

23-4-69

REVISIONS	
NO.	DESCRIPTION/DATE BY

SPARKS, NEVADA
LAS VEGAS, NEVADA
SEATTLE, WASHINGTON

incorporated

SEA

ENGINEERS/PLANNERS
ARCHITECTS

NEVADA


CLARK COUNTY

LAS VEGAS

PLOT & GRADING PLAN
for
Michael Mack
E. Fremont St. & Sahara Ave.

JOB NO. 2-0128-001-77(1)	
DESIGNED G.A.S.	
DRAWN	KEH
COMP.	WDJ
CHECKED	<i>[Signature]</i>
DATE	MARCH, 1977
SHEET NO.	1

1 OF 1 SHEETS

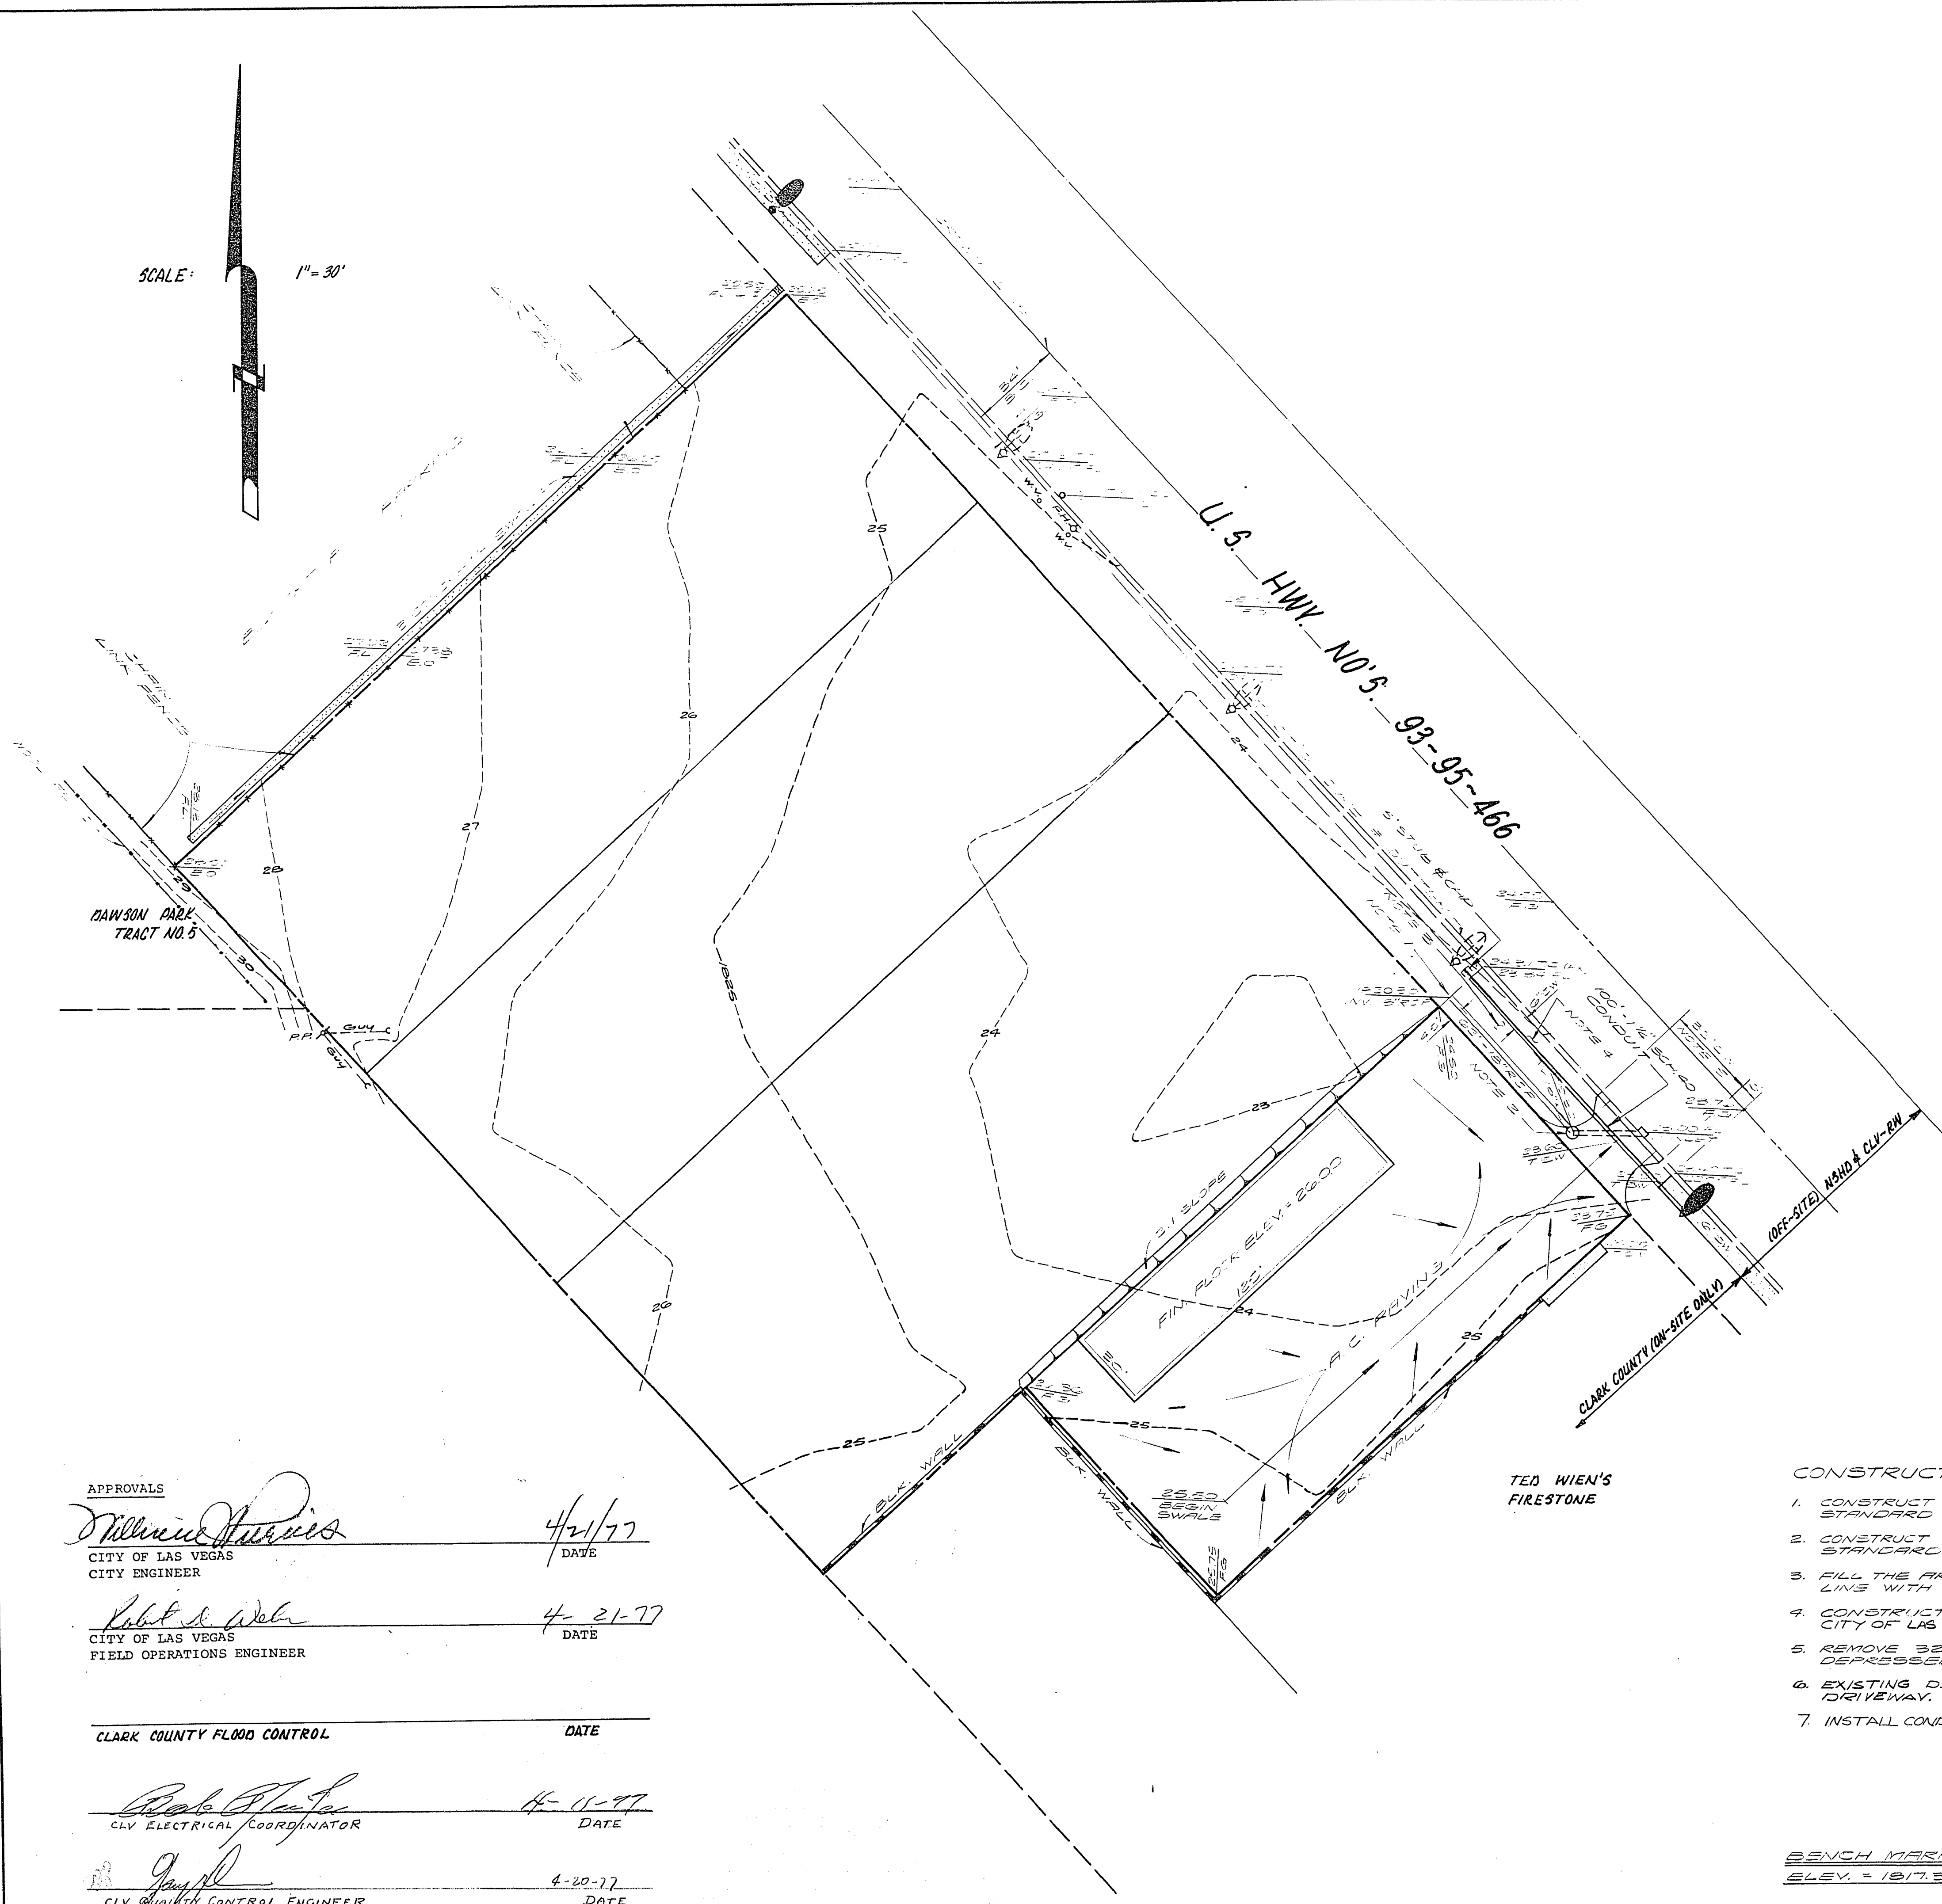

SCALE: 1" = 30'

- EXISTING 400 WATT LUMINAIRE
- FUTURE STREET LIGHT
- FUTURE 3" 4 THW CONDUIT

APPROVALS

[Signature] 4-21-77
CITY OF LAS VEGAS
CITY ENGINEER

[Signature] 4-21-77
CITY OF LAS VEGAS
FIELD OPERATIONS ENGINEER

CLARK COUNTY FLOOD CONTROL DATE

[Signature] 4-11-77
CLV ELECTRICAL COORDINATOR

[Signature] 4-20-77
CLV QUALITY CONTROL ENGINEER

TED WIEN'S
FIRESTONE

- CONSTRUCTION NOTES**
1. CONSTRUCT STATE OF NEVADA DEPARTMENT OF HIGHWAYS STANDARD HEADWALL FOR 18" R.C.P. WITH 0° SKEW.
 2. CONSTRUCT STATE OF NEVADA DEPARTMENT OF HIGHWAYS STANDARD TYPE 2 MANHOLE.
 3. FILL THE AREA FROM BACK OF SIDEWALK TO THE PROPERTY LINE WITH A NON-EXPANSIVE FILL.
 4. CONSTRUCT A 4" THICK SIDEWALK, 6' WIDE PER CITY OF LAS VEGAS STANDARDS.
 5. REMOVE 32' OF EXISTING CURB & GUTTER, REPLACE WITH DEPRESSED CURB AND STANDARD COMMERCIAL DRIVEWAY.
 6. EXISTING DI IN DRIVEWAY MUST BE ALTERED TO CONFORM WITH DRIVEWAY.
 7. INSTALL CONDUIT FOR STREET LIGHTS

BENCH MARK
ELEV. = 1917.35 NW COR. OF GLEN ST. AND BOULDER HIGHWAY

23-4-74 21V 978