
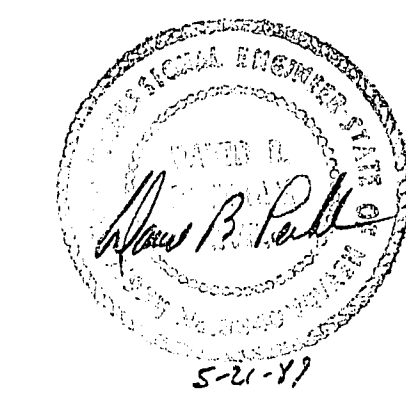
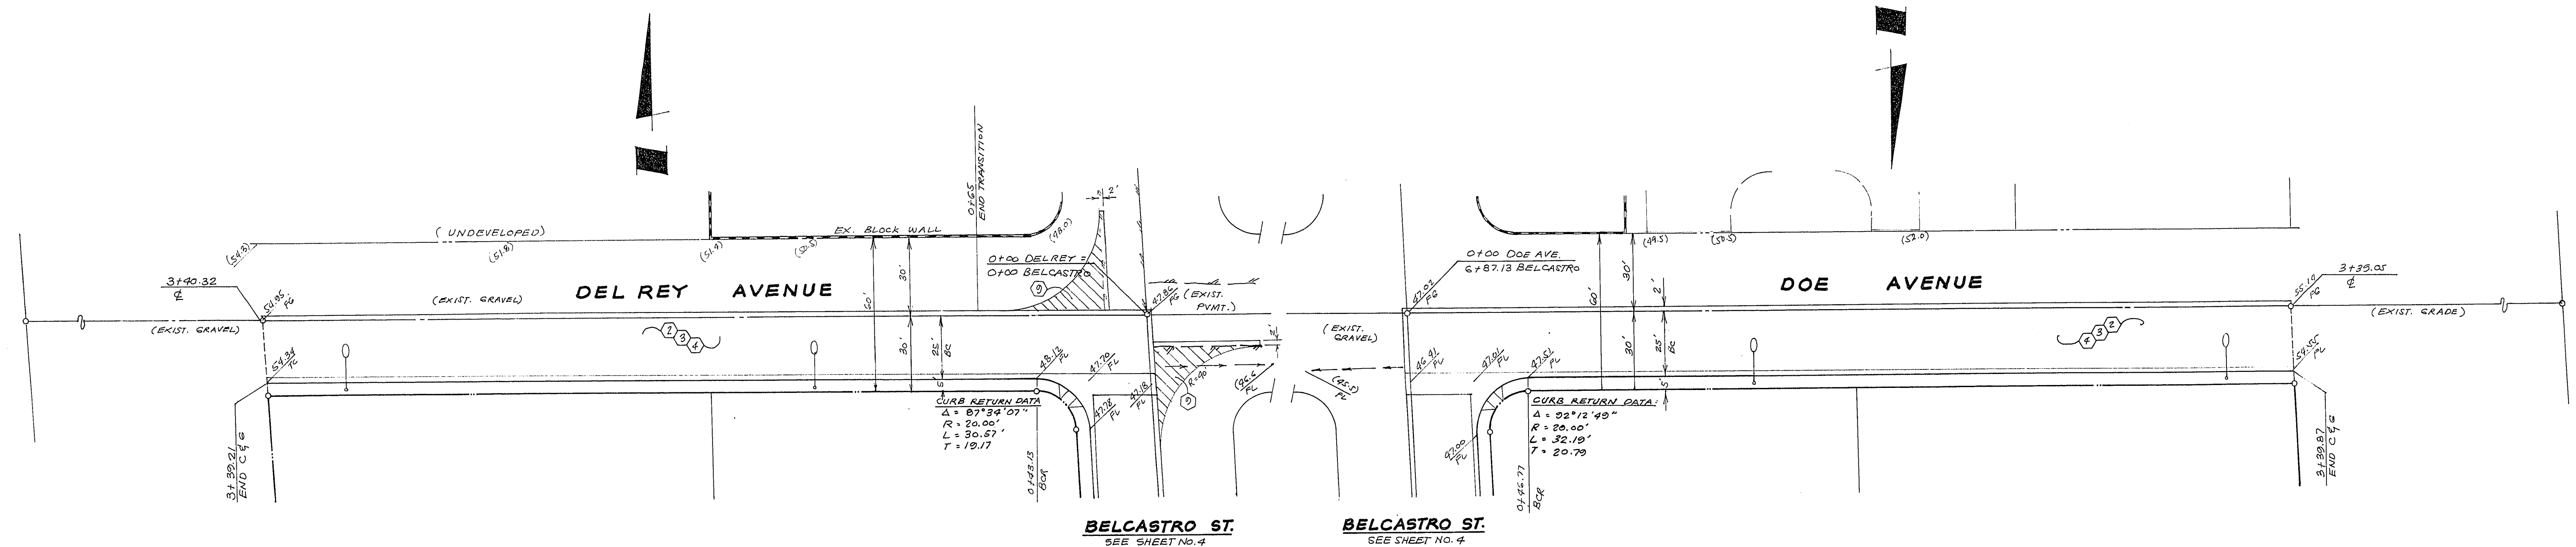


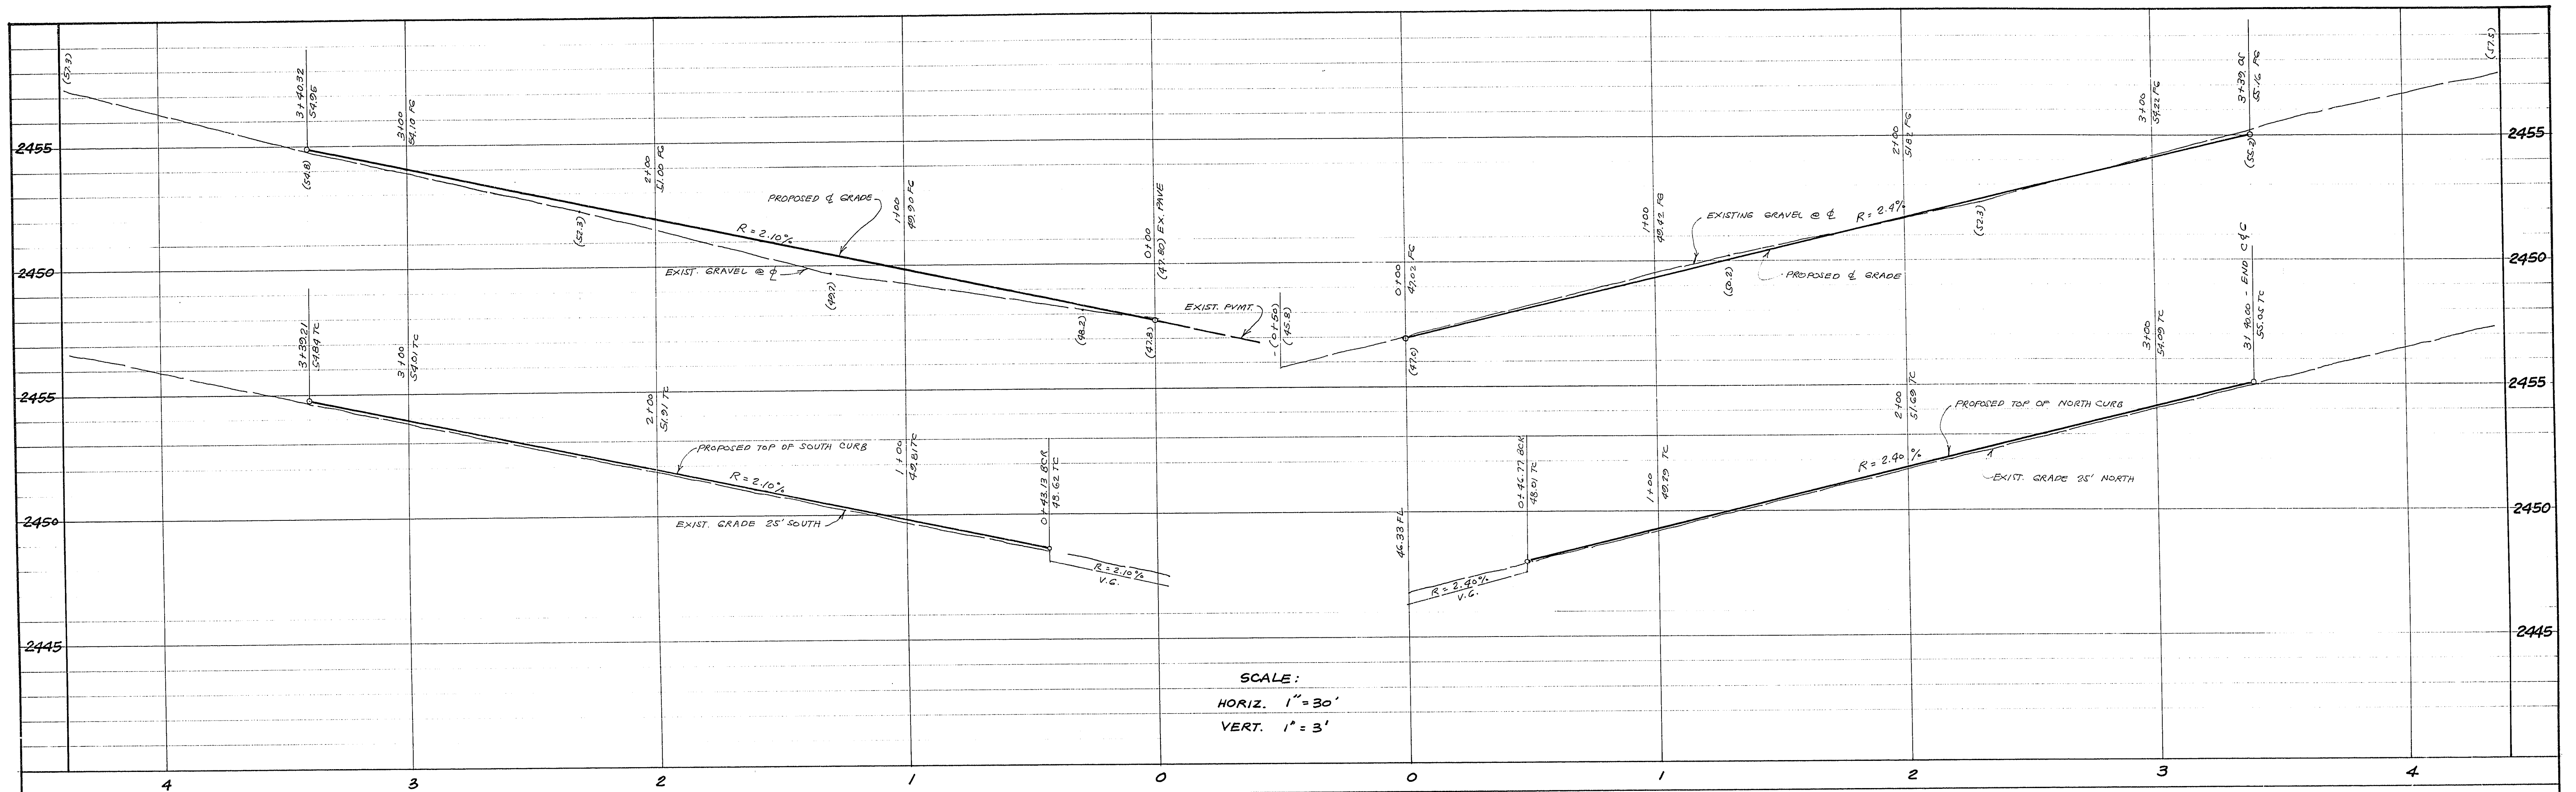

Peckham Engineering 5643 West Charleston Blvd., #10 CONSULTING CIVIL ENGINEERS Las Vegas, Nevada 89102 702-670-4887			
PLAN AND PROFILE DEL REY AVE.: From Belcastro St. to 340'± West DOE AVENUE : From Belcastro St. to 340'± West DESERT WIND SUBDIVISION			
SCALE: 1" = 30'	DATE: MAY 1989	PROJECT NO. 9-0406	SHEET 5 OF 7

107Y-4062