


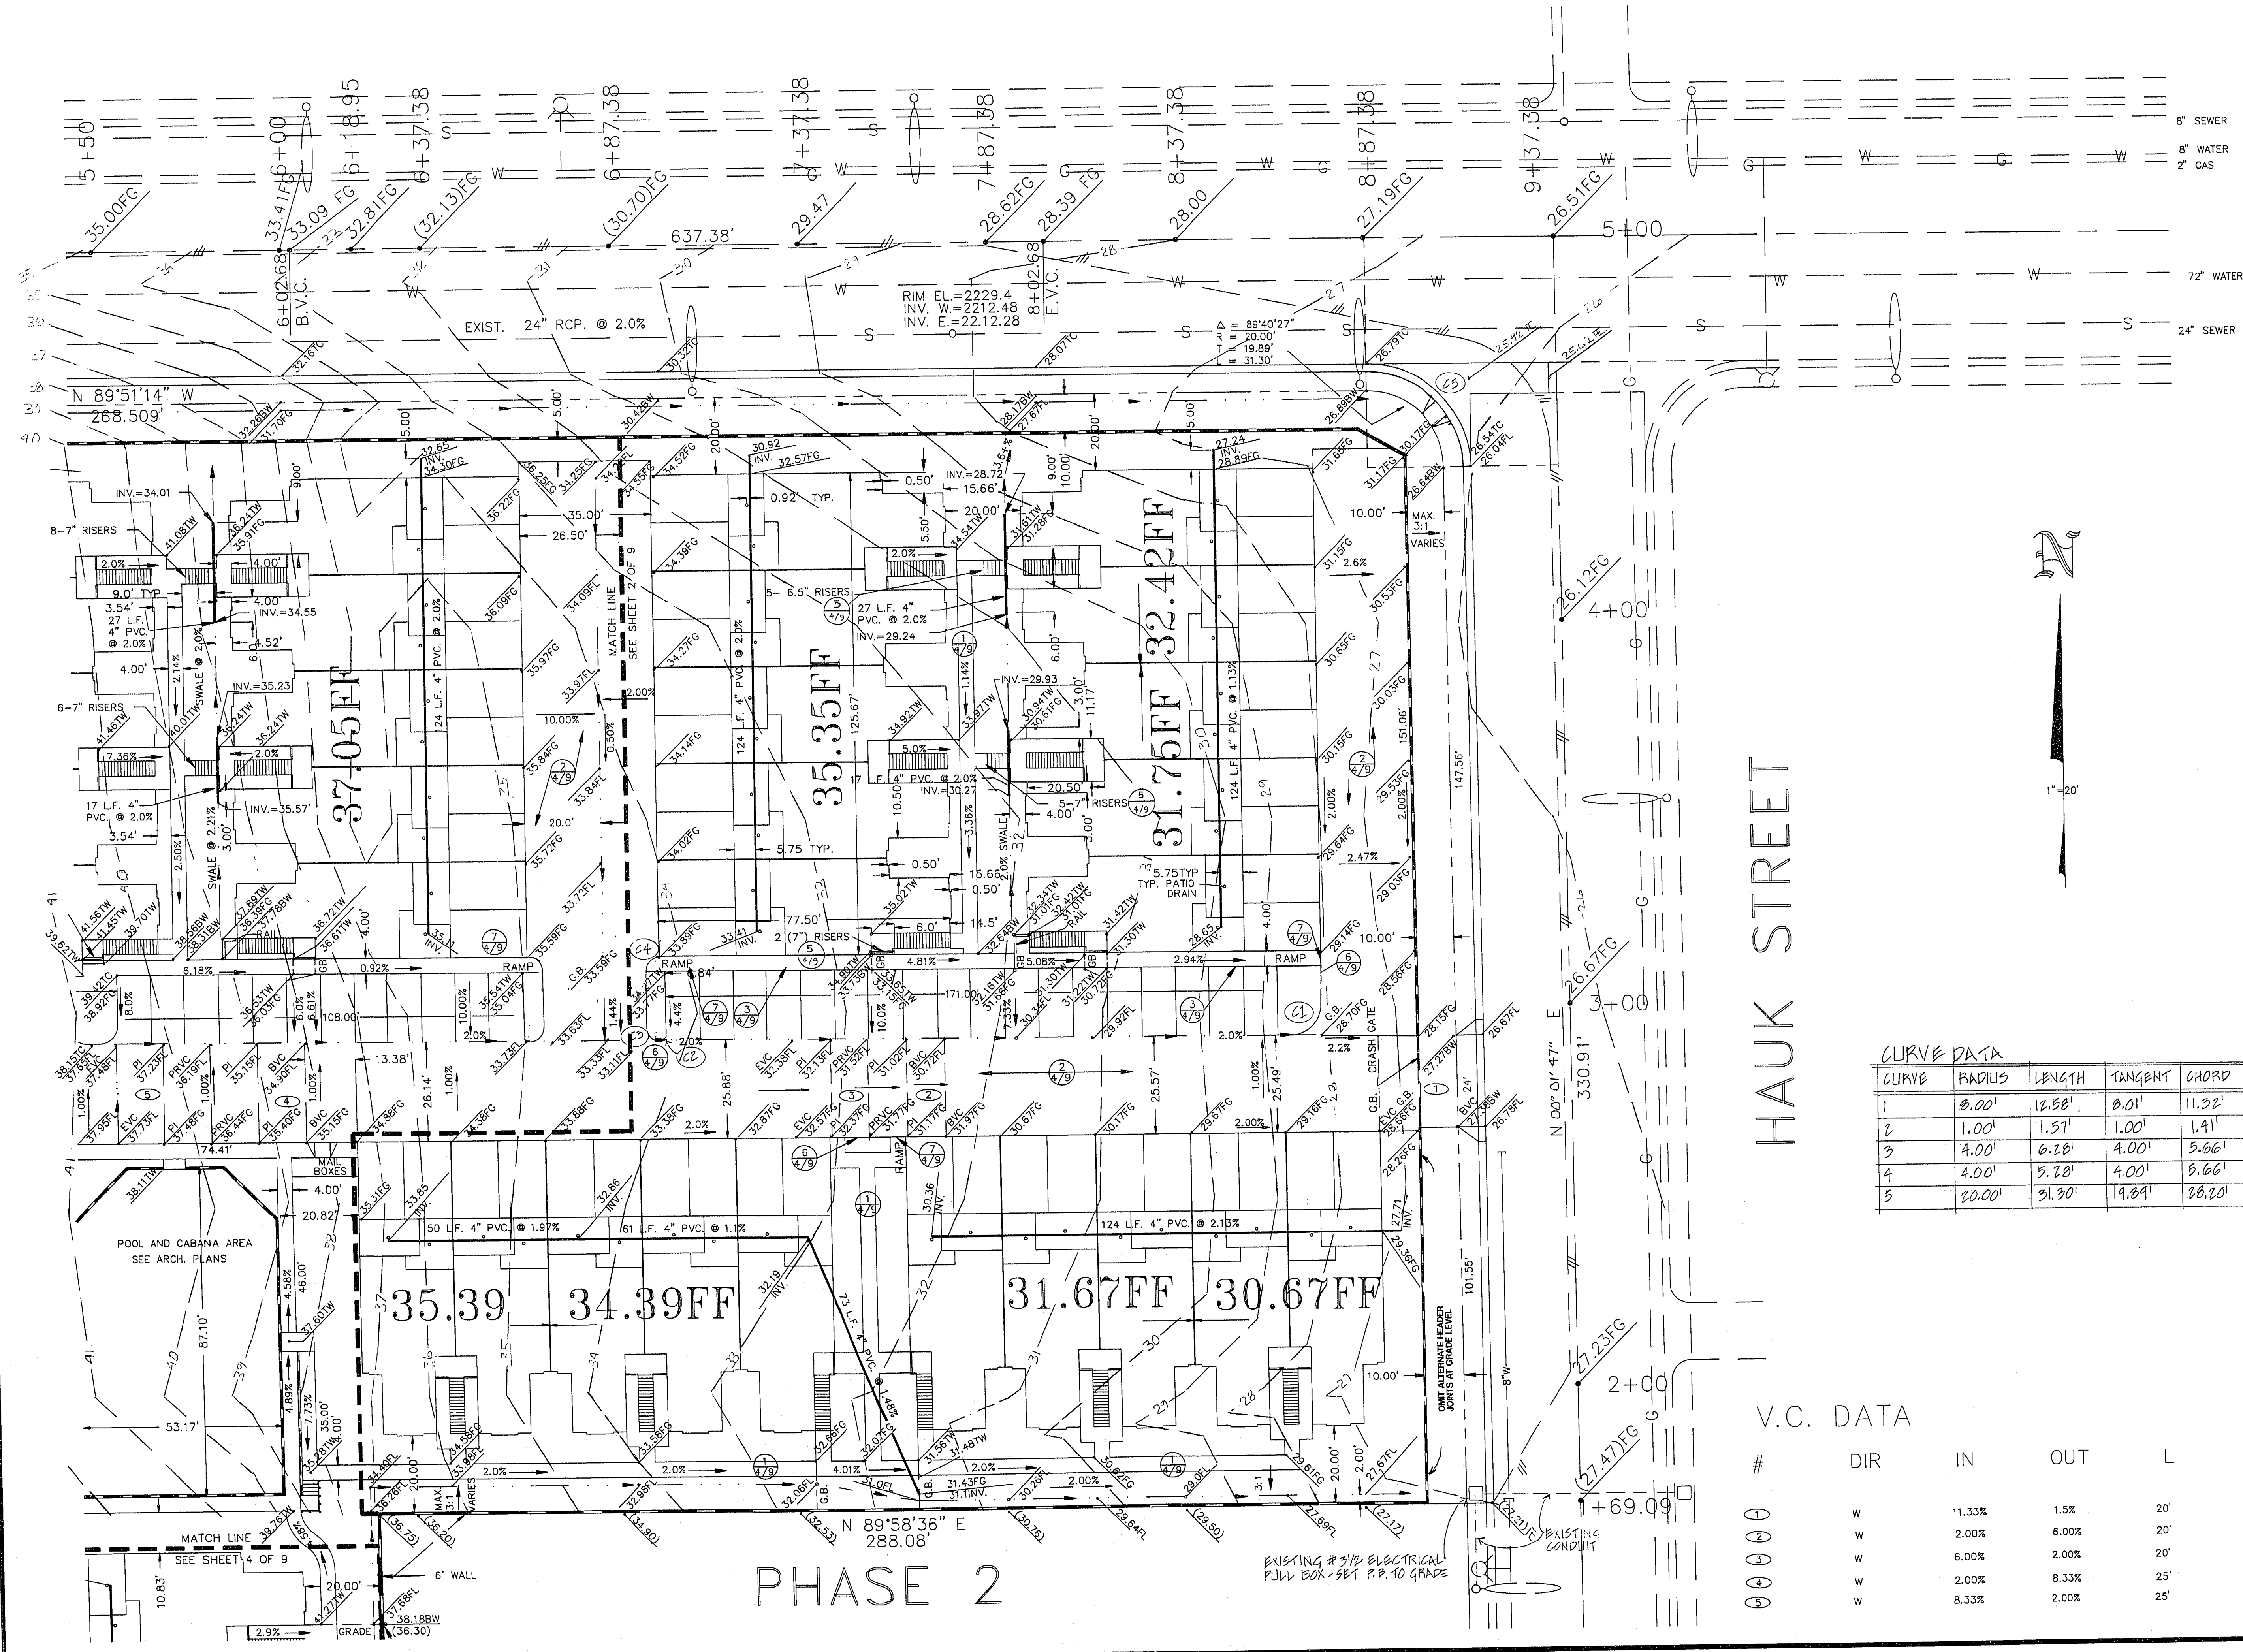

8" SEWER
8" WATER
2" GAS
72" WATER
24" SEWER

CURVE DATA

CURVE	RADIUS	LENGTH	TANGENT	CHORD	Δ
1	8.00'	12.58'	8.01'	11.32'	90°04'09"
2	1.00'	1.51'	1.00'	1.41'	90°02'49"
3	4.00'	6.28'	4.00'	5.66'	90°00'00"
4	4.00'	5.28'	4.00'	5.66'	90°00'00"
5	20.00'	31.90'	19.89'	28.20'	89°40'27"

V.C. DATA

#	DIR	IN	OUT	L	PVI	MO
1	W	11.33%	1.5%	20'	-28.51	-0.25
2	W	2.00%	6.00%	20'	31.18	+0.10
3	W	6.00%	2.00%	20'	32.37	-0.10
4	W	2.00%	8.33%	25'	35.39	+0.20
5	W	8.33%	2.00%	25'	37.48	-0.20

BBCF

BRECHLER & BELL CONSULTING ENGINEERS, INC.
CIVIL ENGINEERING
19 WEST BROOKS AVENUE
SUITE C
NORTH LAS VEGAS, NEVADA
89030
702/642-5362

EL PARQUE CONDOMINIUMS
PLOT AND GRADING PLAN
PHASE 2

JOB TITLE:
SHEET TITLE:
FIELD BOOK
DISK NO.
DATE
DESIGN
DRAWN
CHECKED
SCALE
HORIZ. 1"=20'
VERT.
JOB NO.
90346
SHEET NO.
3 OF 9

10-13-65 1074-4144