



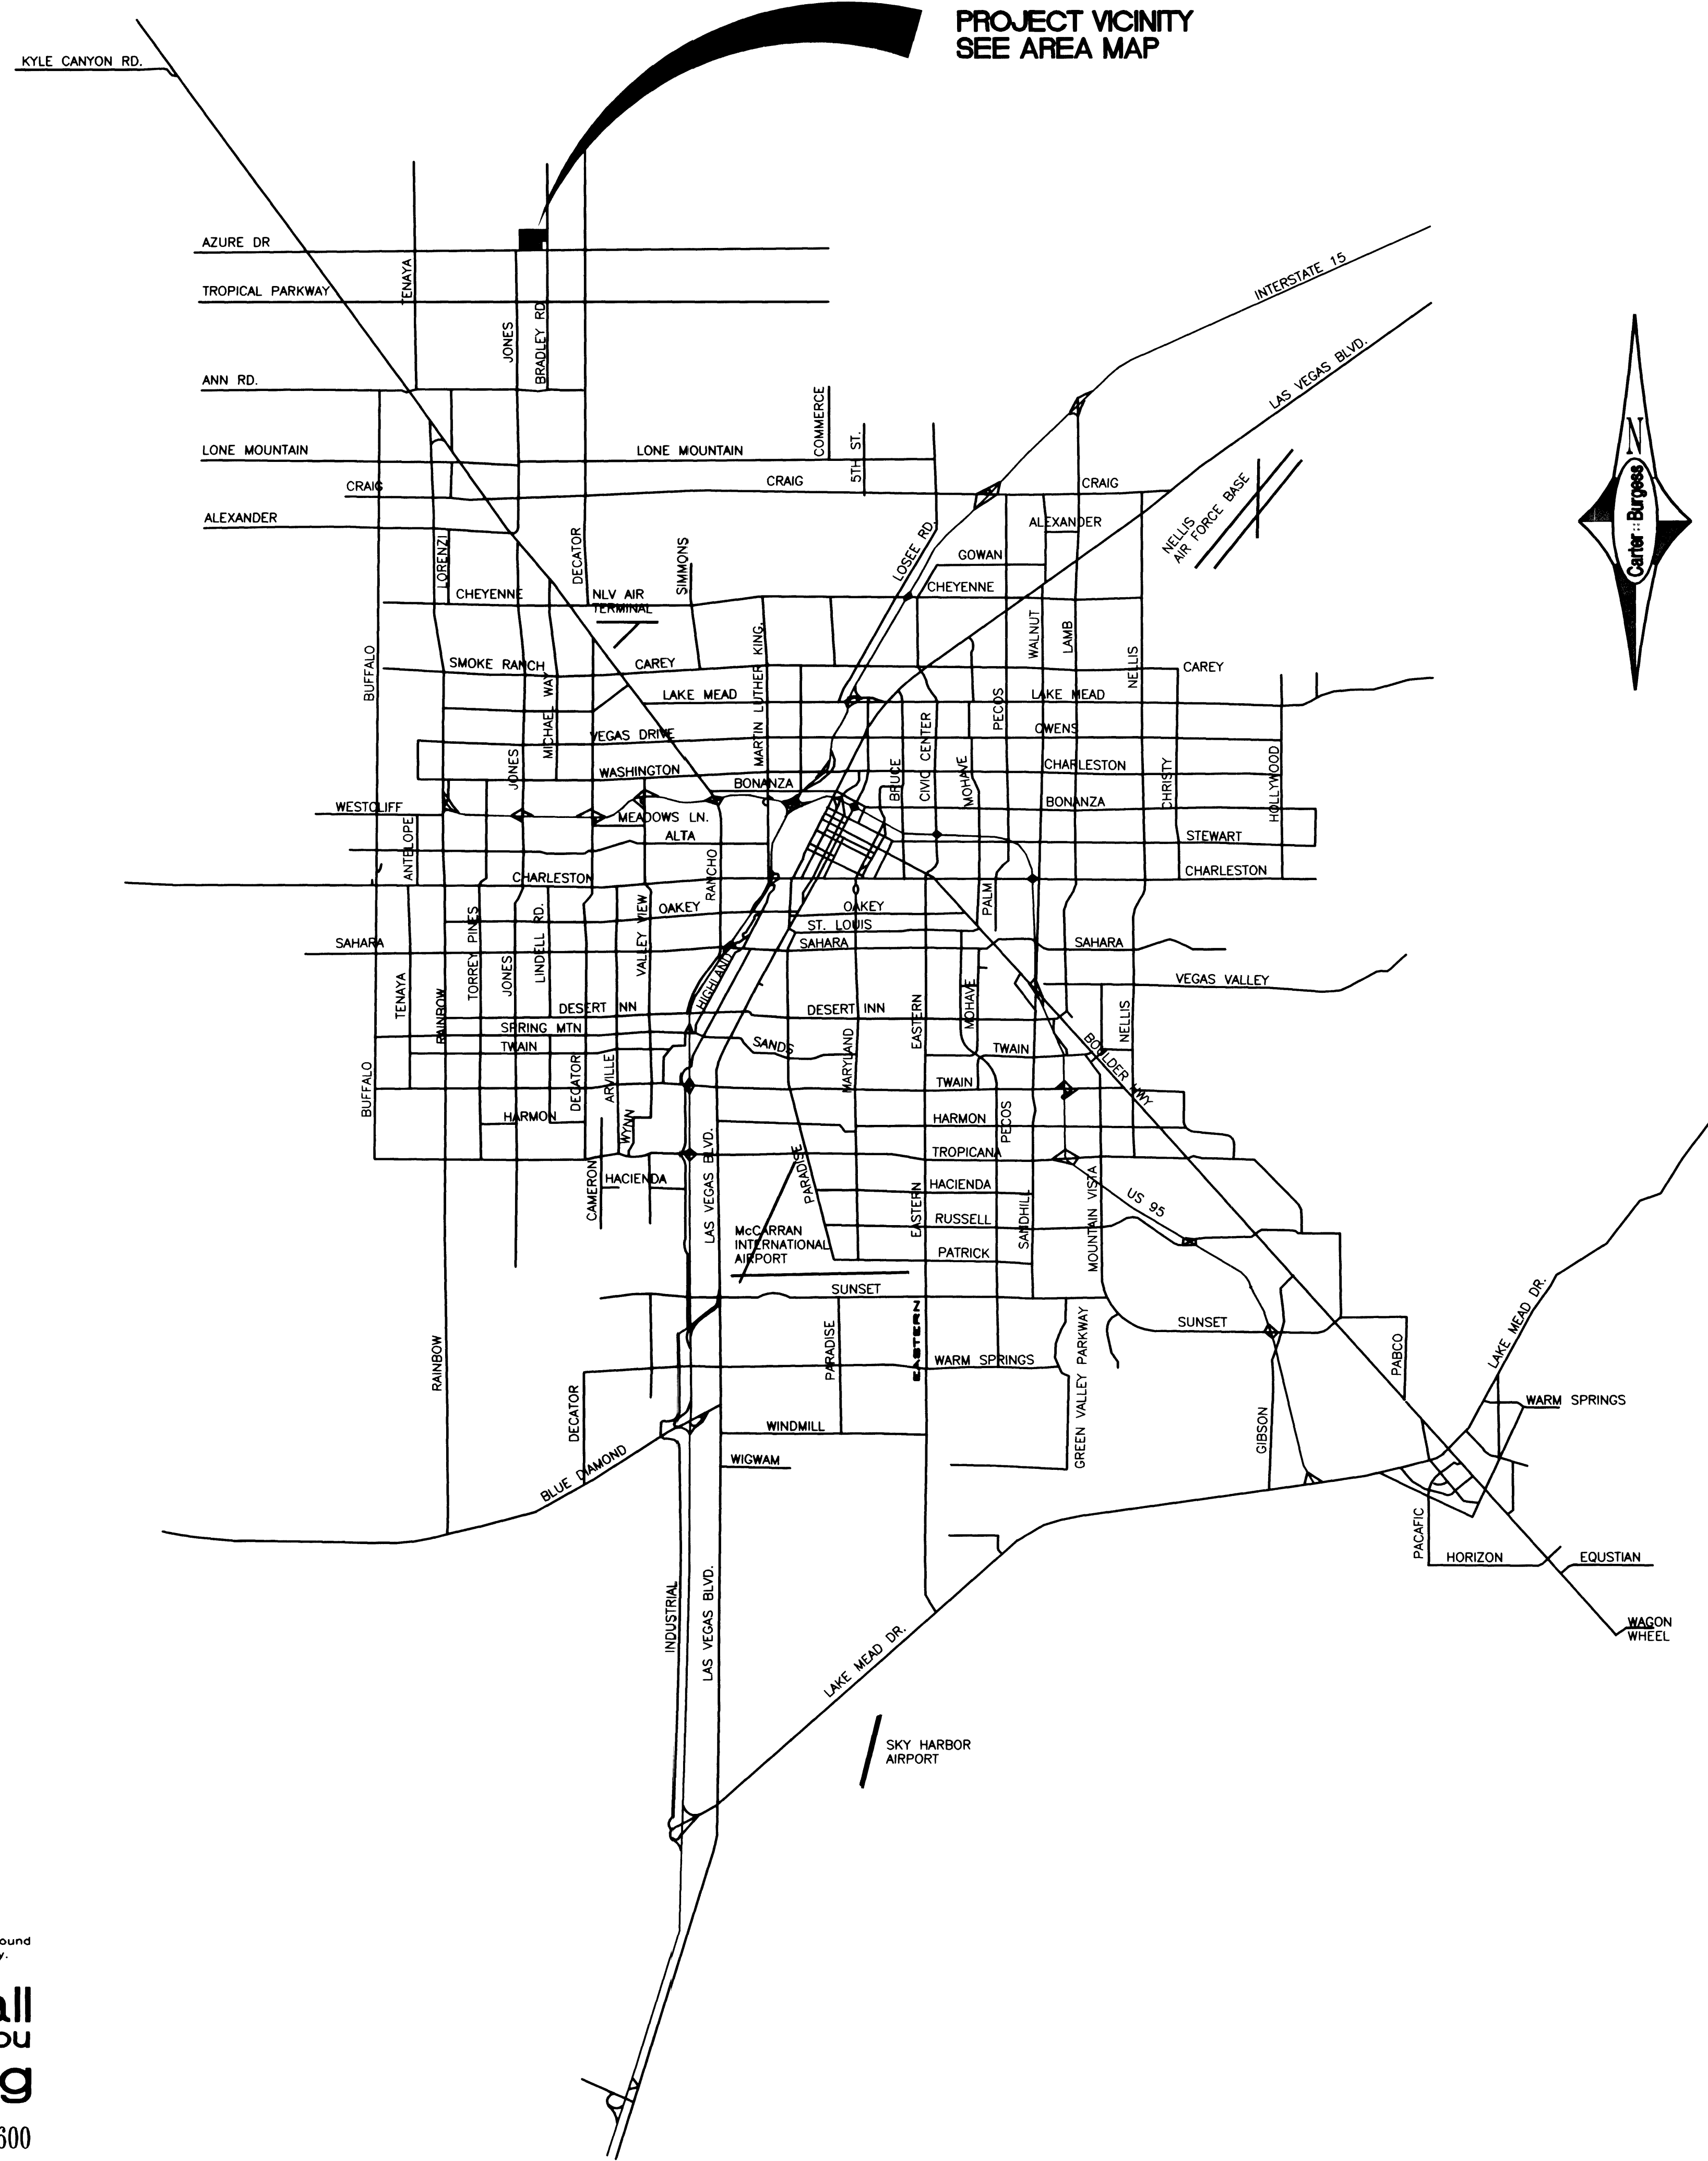

PROJECT VICINITY
SEE AREA MAP

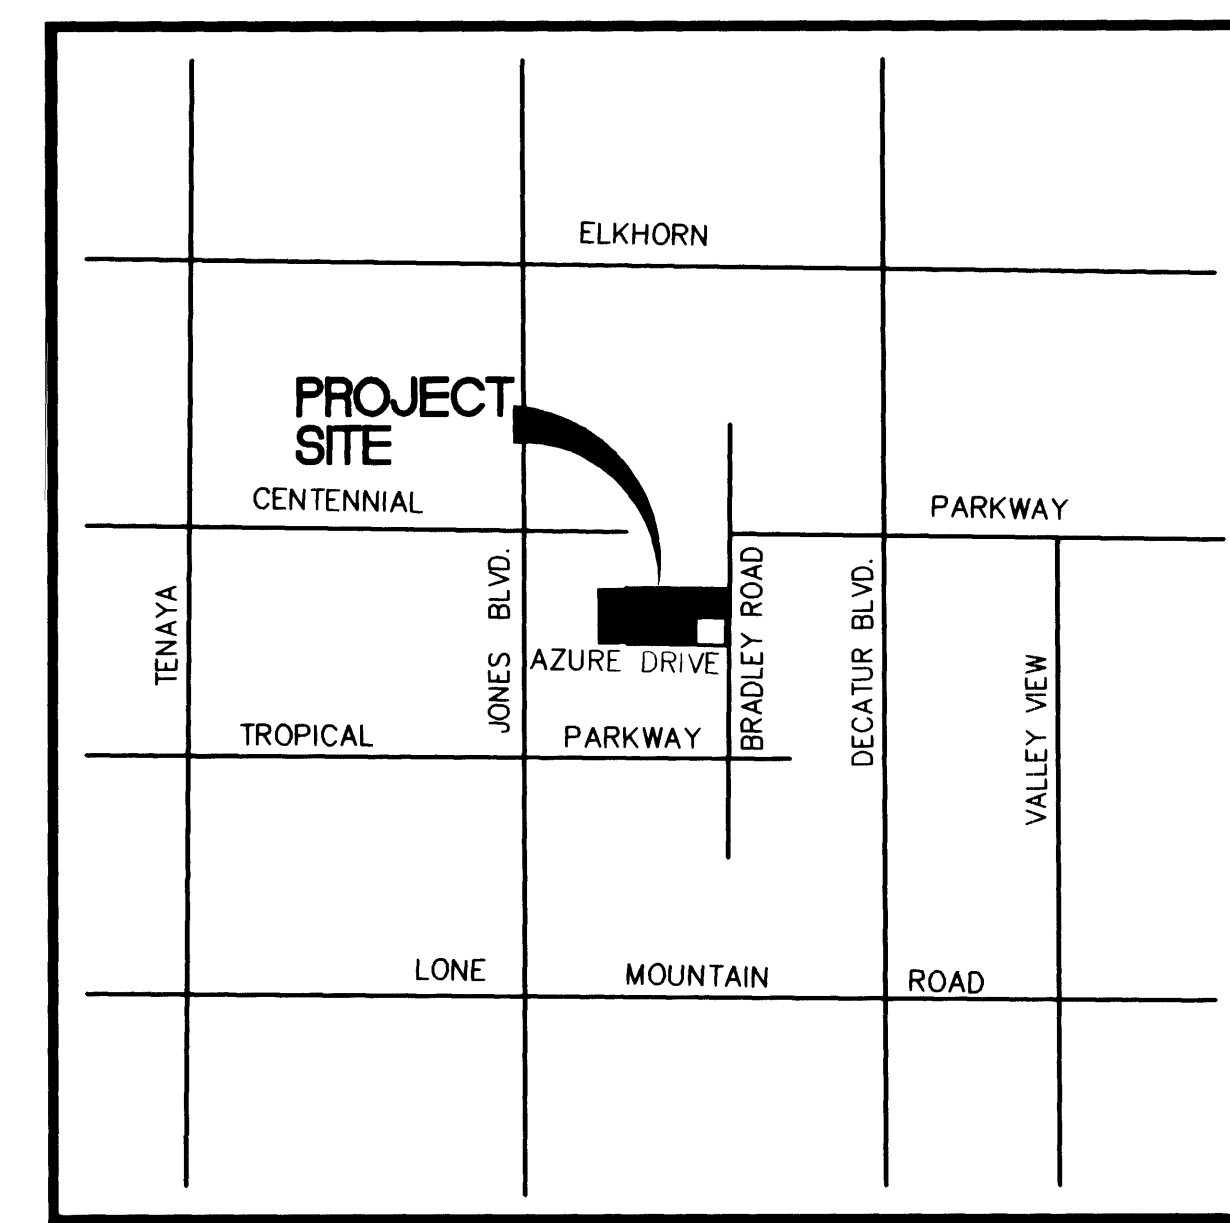

AREA MAP
NOT TO SCALE

- SHEET INDEX - PHASE 3**
1. COVER SHEET
 2. VICINITY MAP
 3. GENERAL NOTES
 4. QUANTITY ESTIMATE AND LEGEND
 5. UTILITY / STREETLIGHT / SIGNAGE PLAN
 6. GRADING PLAN
 7. PLAN AND PROFILE RAVEN CREEK
 8. PLAN AND PROFILE EAGLE CROSSING
 9. PLAN AND PROFILE EAGLE CLAW
 10. DETAIL SHEET

Avoid overhead power line contact. It's costly.

Call before you Overhead

1-702-593-6111
NEVADA POWER ENVIRONMENT AND SAFETY SERVICES DEPARTMENT

Avoid cutting underground utility lines. It's costly.

Call before you Dig

1-800-227-2600

Pulte Homes An American Favorite		Carter Burgess Consultants in Planning, Engineering, Construction Management, and Related Services	
VICINITY MAP INDEX OF DRAWINGS		EAGLE CREEK II PHASE 3	
DRAWN BY: ECN	DESIGNED BY: ECN	CHECKED BY: RWJ	PROJECT NO: 98V189
SCALE: NONE		HORIZ VERT: NONE	
SHEET 2		2 OF 10 SHEETS	
DRAWING NO. 107Y-4681-3		REV DATE BY	
8855 Bermuda road Las Vegas, NV 89119 (702) 938-5400 Fax (702) 938-5454		REVISION	

