




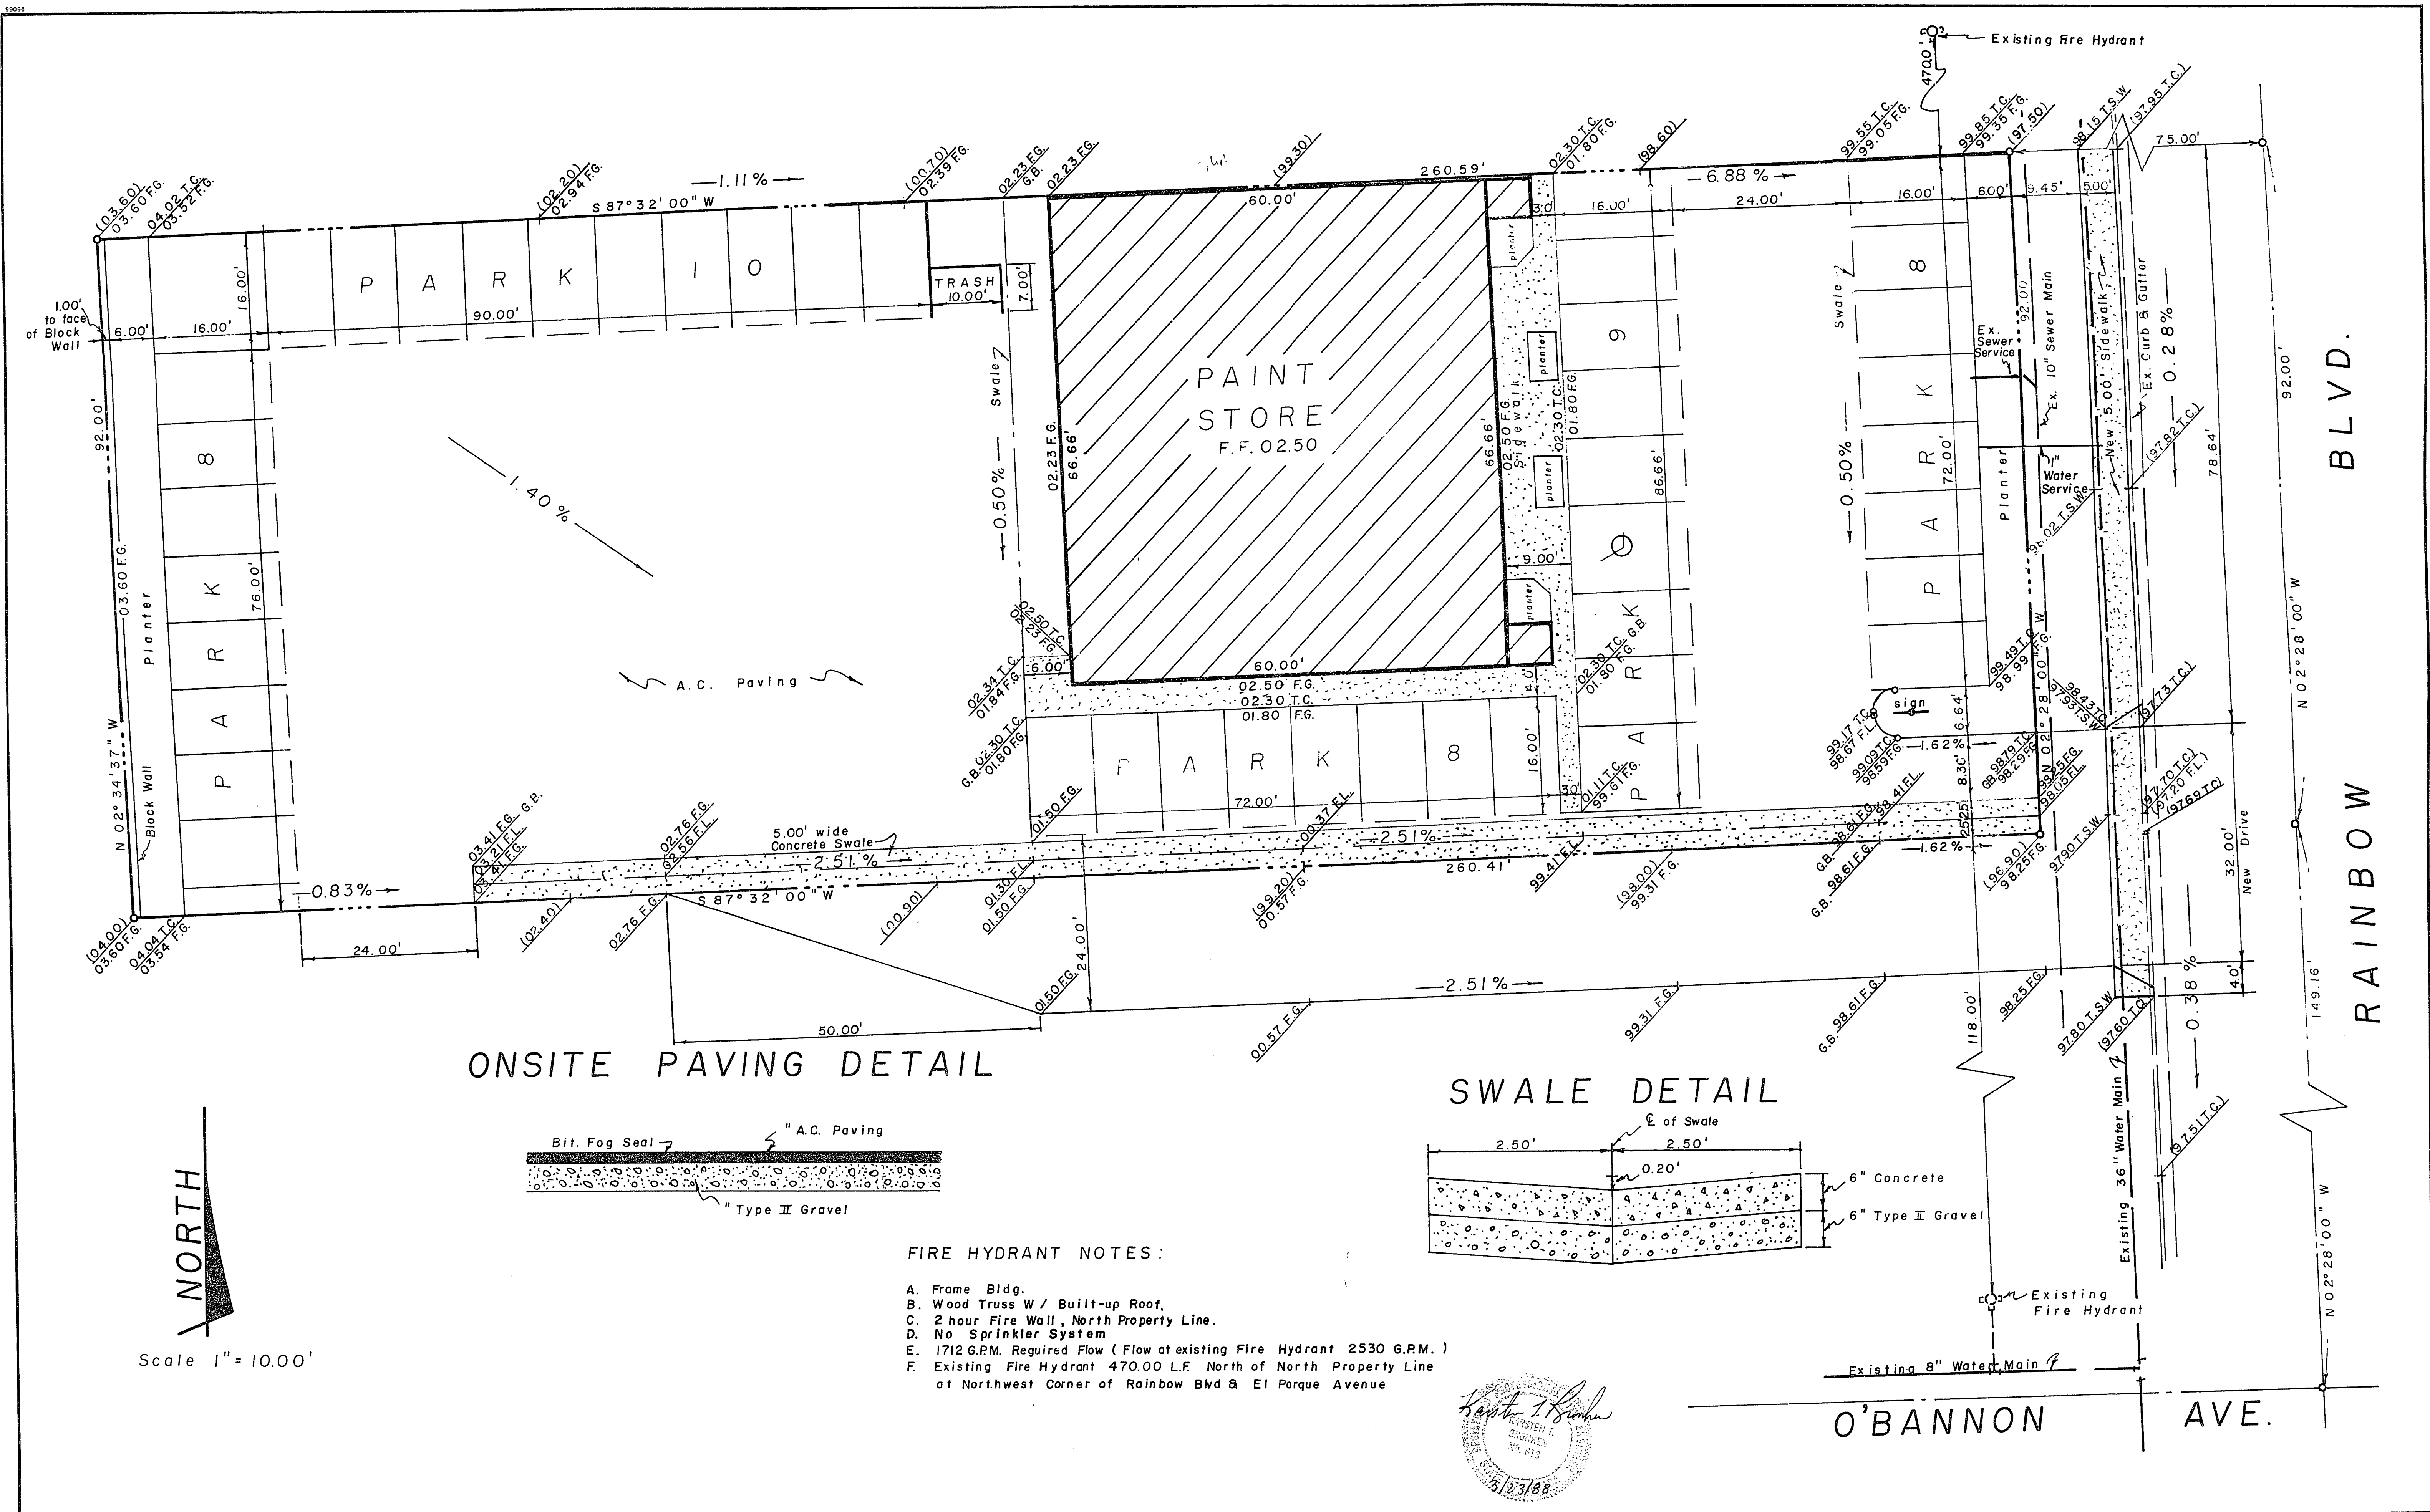

ONSITE PAVING DETAIL

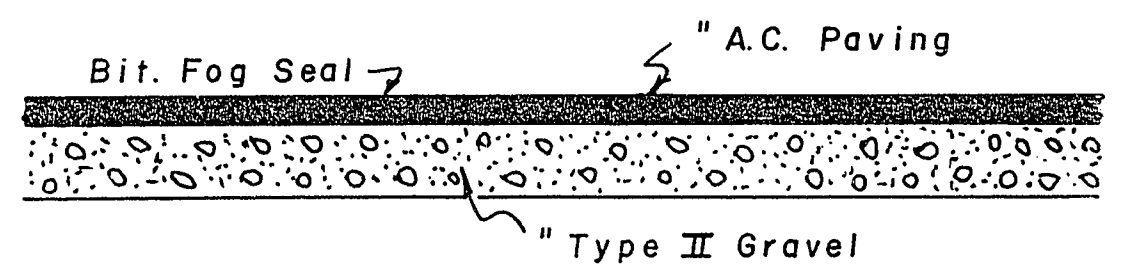

SWALE DETAIL

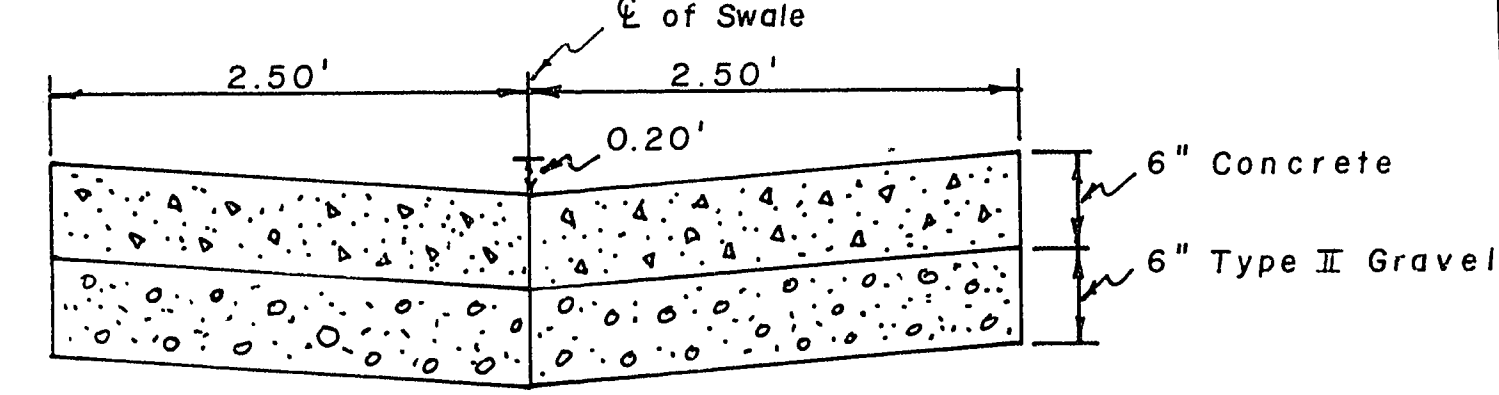

- FIRE HYDRANT NOTES:
- A. Frame Bldg.
 - B. Wood Truss W/ Built-up Roof.
 - C. 2 hour Fire Wall, North Property Line.
 - D. No Sprinkler System
 - E. 1712 G.P.M. Required Flow (Flow at existing Fire Hydrant 2530 G.P.M.)
 - F. Existing Fire Hydrant 470.00 L.F. North of North Property Line at Northwest Corner of Rainbow Blvd & El Parque Avenue

Handwritten signature
 5/23/88

REVISIONS:	SCALE 1"=10.00'	TITLE PLOT AND GRADING PLAN	SHEET NUMBER 3 OF 3
DATE 2/23/88	FOR: Dean O'Bannon	Bronken Engineering Chartered 1818 INDUSTRIAL ROAD, LAS VEGAS, NEVADA 89102 (702) 382-6660	

107-V 1573
 63-50