


LEGEND

ACP ASPHALTIC CEMENT PIPE
 CLV CENTERLINE
 EX. EXISTING
 E.O. EDGE OF OIL
 FG FINISH GRADE
 G.P. GAS PIPE
 HP HIGH PRESSURE
 R=0.43% ROAD GRADIENT
 R/W RIGHT-OF-WAY
 S RATE OF SLOPE

BENCH MARK

CLV BM NO. 7C00-1W4 RIVET IN ALUM. PLATE
 IN TOP OF SW PORTION OF 4'x4.5' GAS
 COMPANY VAULT LOCATED ON THE
 NORTHEAST CORNER OF CRAIG RD. &
 JONES BLVD. 8.5' SOUTHEAST OF POWER
 POLE #SNT. CO 3322.
 ELEVATION: 2258.894

THIS BENCH MARK APPLIES DIRECTLY
 TO SHEETS 3 & 4 ONLY. FOR OTHER
 SHEETS USE NLV BM No. 2-6-109.

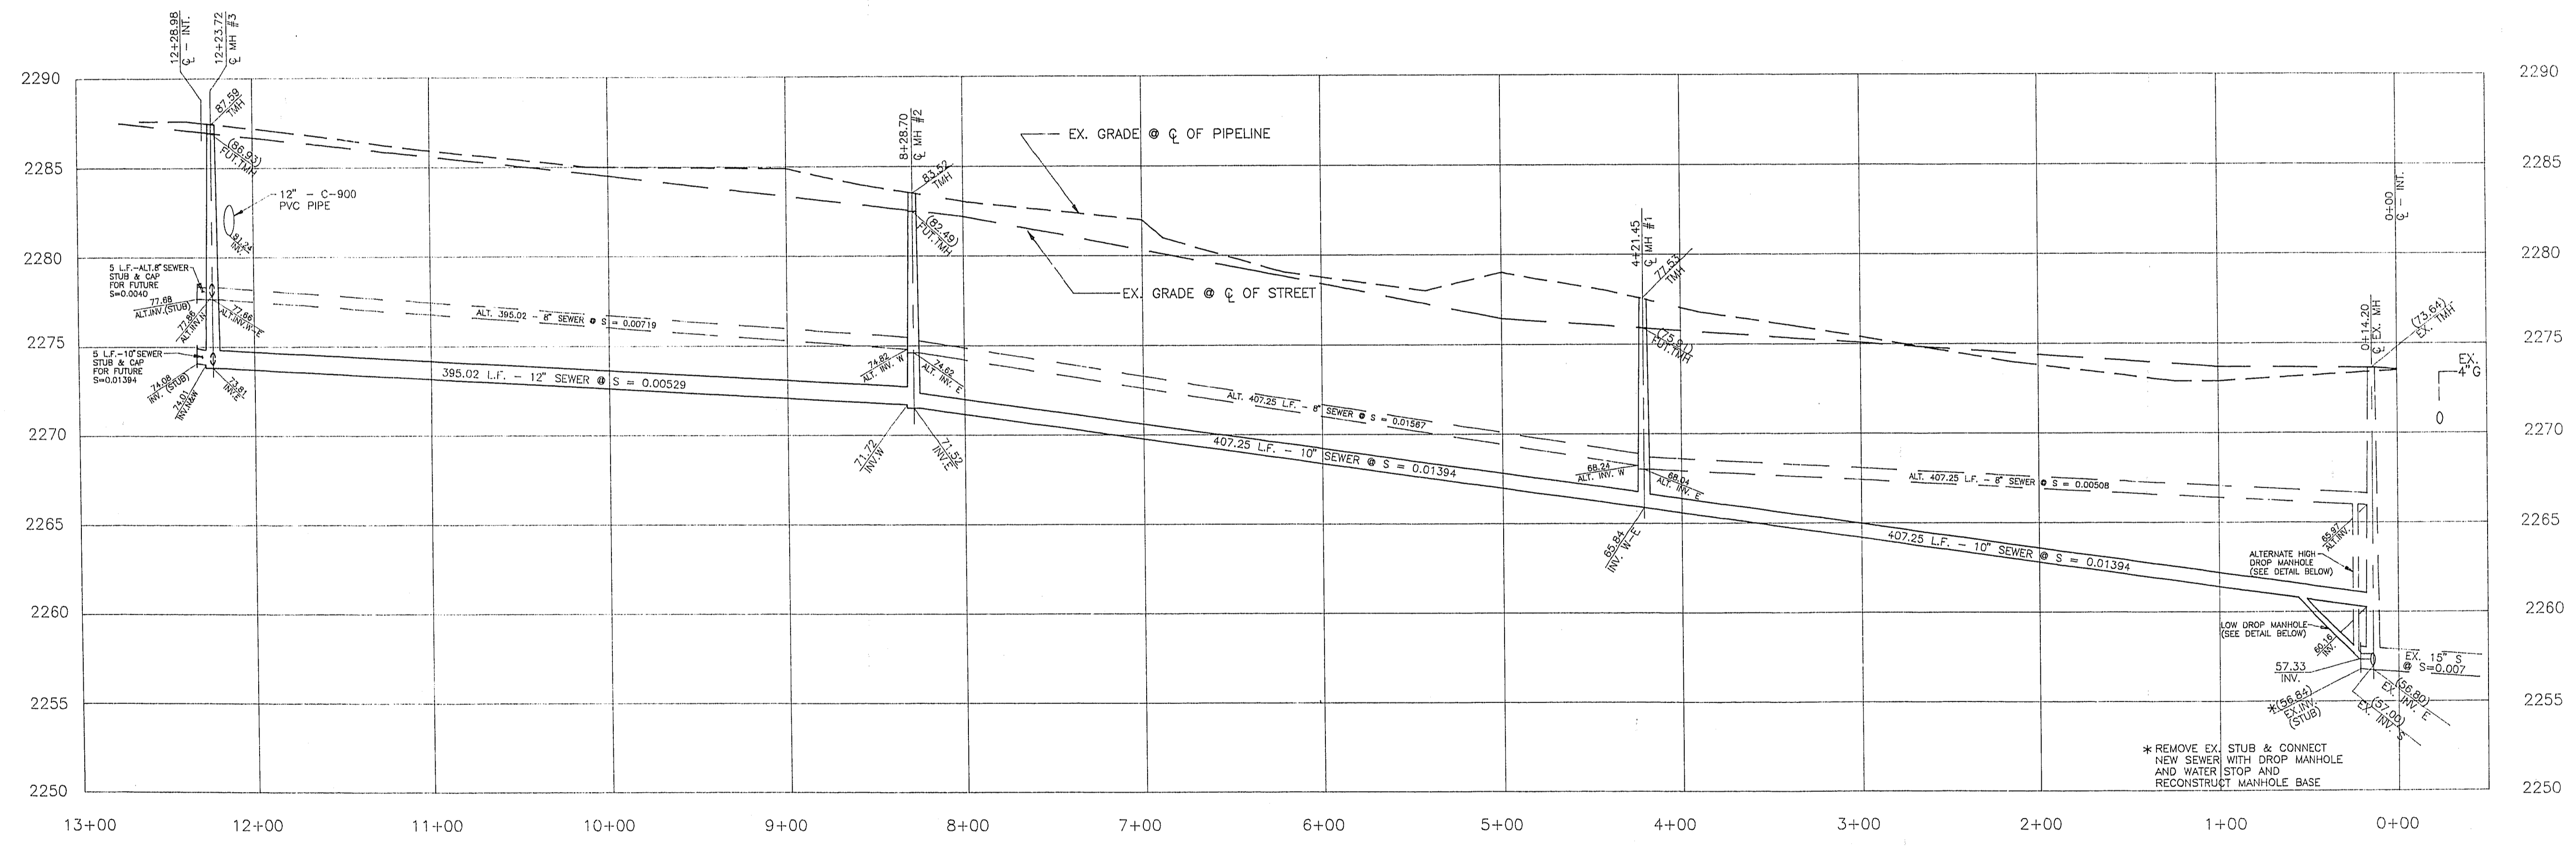


Avoid cutting underground
 utility lines. It's costly.

**Call
 before you
 Dig.**

1-800-227-2600

UNDERGROUND SERVICE ALERT (USA)

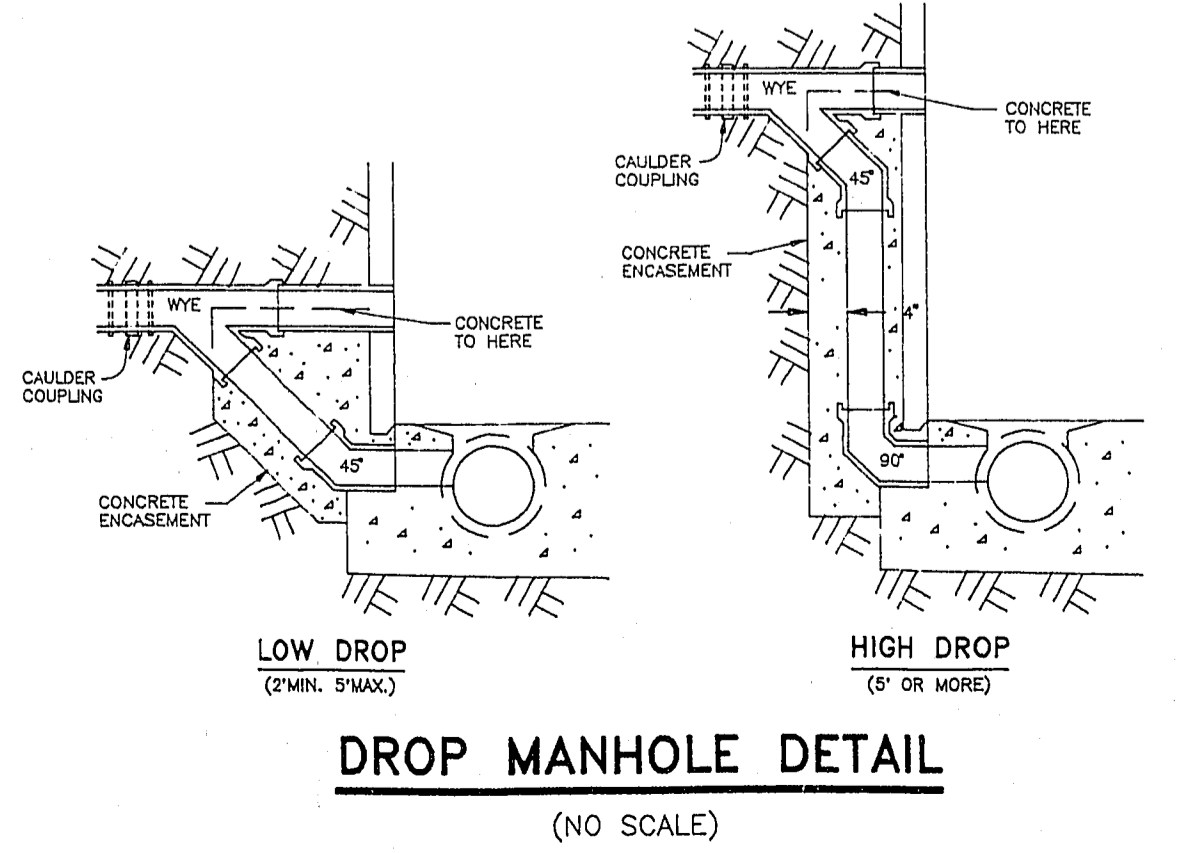


OWNER/DEVELOPER

BIVINS CONSTRUCTION CO., INC.
 620 SOUTH 11TH STREET
 LAS VEGAS, NEVADA 89101
 TELE: (702) 384-7575

APPROVAL

C.L.V. SANITATION ENGINEER DATE

NO.	DATE	DESCRIPTION	APPROVED

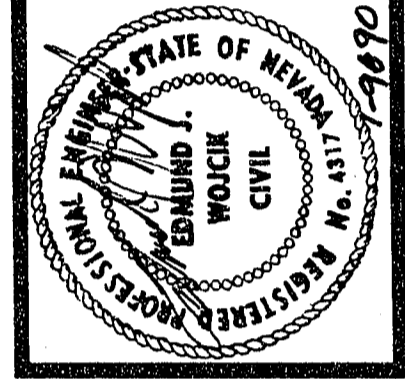

E.J. WOJCIK ENGINEERING
 CIVIL ENGINEERING CONSULTANT
 620 South 11th Street, Suite 7
 Las Vegas, Nevada 89101
 Edmund J. Wojcik, P.E.
 (702) 366-1322

DESERT DREAM ESTATES
 SEWER OUTFALL
 PLAN AND PROFILE

OWNER/DEVELOPER

BIVINS CONSTRUCTION CO., INC.
 620 SOUTH 11TH STREET
 LAS VEGAS, NEVADA 89101
 TELE: (702) 384-7575

(v) SCALE: 1"=5'
 (h) SCALE: 1"=50'

J.N. : 890201
 DRAWN BY: T. CASTER

CHKD BY: E. WOJCIK

SHEET NO. :
3 OF 9

C.L.V. SANITATION ENGINEER DATE