


GENERAL NOTES

1. ALL DRAINAGE PIPING 4" AND SMALLER SHALL BE SLOPED AT 1/4" PER FOOT.
2. ALL DRAINAGE PIPING 5" AND LARGER SHALL BE SLOPED AT 1/8" PER FOOT.
3. ALL CONDENSATE DRAINAGE (CD) PIPING SHALL BE SLOPED AT 1/8" PER FOOT.
4. ALL STORM DRAIN (SD) AND OVERFLOW STORM DRAIN (OSD) PIPING SHALL BE SLOPED AT 1/8" PER FOOT.
5. NO PLUMBING PIPING SHALL BE INSTALL IN CONCRETE OR MASONRY WALLS UNLESS A PIPE CHASE IS PROVIDED.


SHEET NOTES

- 1 1/2" HOT AND COLD WATER TO COUNTER SERVICE STATION.
- 1/2" COLD WATER TO WATER AND ICE STATION.
- 3/4" COLD WATER DOWN IN WALL. TEE 3/4" COLD WATER TO COFFEE BREWER WITH BACKFLOW PREVENTER, TEE 1/2" COLD WATER TO HEADER IN WALL.
- 1/2" HOT AND COLD WATER DOWN IN WALL TO PRE-RINSE ASSEMBLY.
- 1/2" HOT AND COLD WATER DOWN TO HAND SINK W/ RIGHT SPLASH GUARD.
- 1/2" HOT AND COLD WATER DOWN TO THREE COMPARTMENT SINK.
- 1/2" COLD WATER DOWN TO ICE MAKER.
- 3/4" GAS W/ GAS COCK TO RANGE (198 CFH).
- 1/2" GAS W/ GAS COCK TO CHEESEMELTER (30 CFH).
- 1/2" GAS W/ GAS COCK TO FRYER (120 CFH).
- 1/2" HOT AND COLD WATER DOWN TO WORKTABLE W/ SINK AND DRAWER.
- 3/4" GAS W/ GAS COCK TO CONVECTION OVEN AT 1'-8" AND 3/4" GAS W/ GAS COCK TO CONVECTION OVEN AT 4'-4". (54 MBTU EACH)
- 1/2" COLD WATER DOWN TO STEAMER AT 4'-0", TEE 1/4" COLD WATER TO STEAMER AT 1'-4".
- 1/2" HOT AND COLD WATER DOWN IN WALL. TEE 1/2" HOT AND COLD WATER TO HAND SINK W/ RIGHT SPLASH GUARD, TEE 1/2" HOT AND COLD WATER TO HAND SINK W/ LEFT SPLASH GUARD.
- FOR CONTINUATION, SEE SHEET P2.01.
- 1/2" HOT AND COLD WATER DOWN TO SERVICE SINK.
- 1 1/4" HOT AND COLD WATER TO WATER HEATER.
- 3/4" HOT WATER DOWN TO DISHWASHER.
- 1-1/4" GAS SUPPLY FROM ABOVE.
- 1" GAS SUPPLY FROM ABOVE.
- 1/2" HOT AND COLD WATER DOWN TO WASHER BOX.
- 1/2" COLD WATER DOWN TO TRAP PRIMER (TP-1).
- PROVIDE GAS VALVE, UNION, AND GAS SOLENOID VALVE 12" BELOW CEILING.

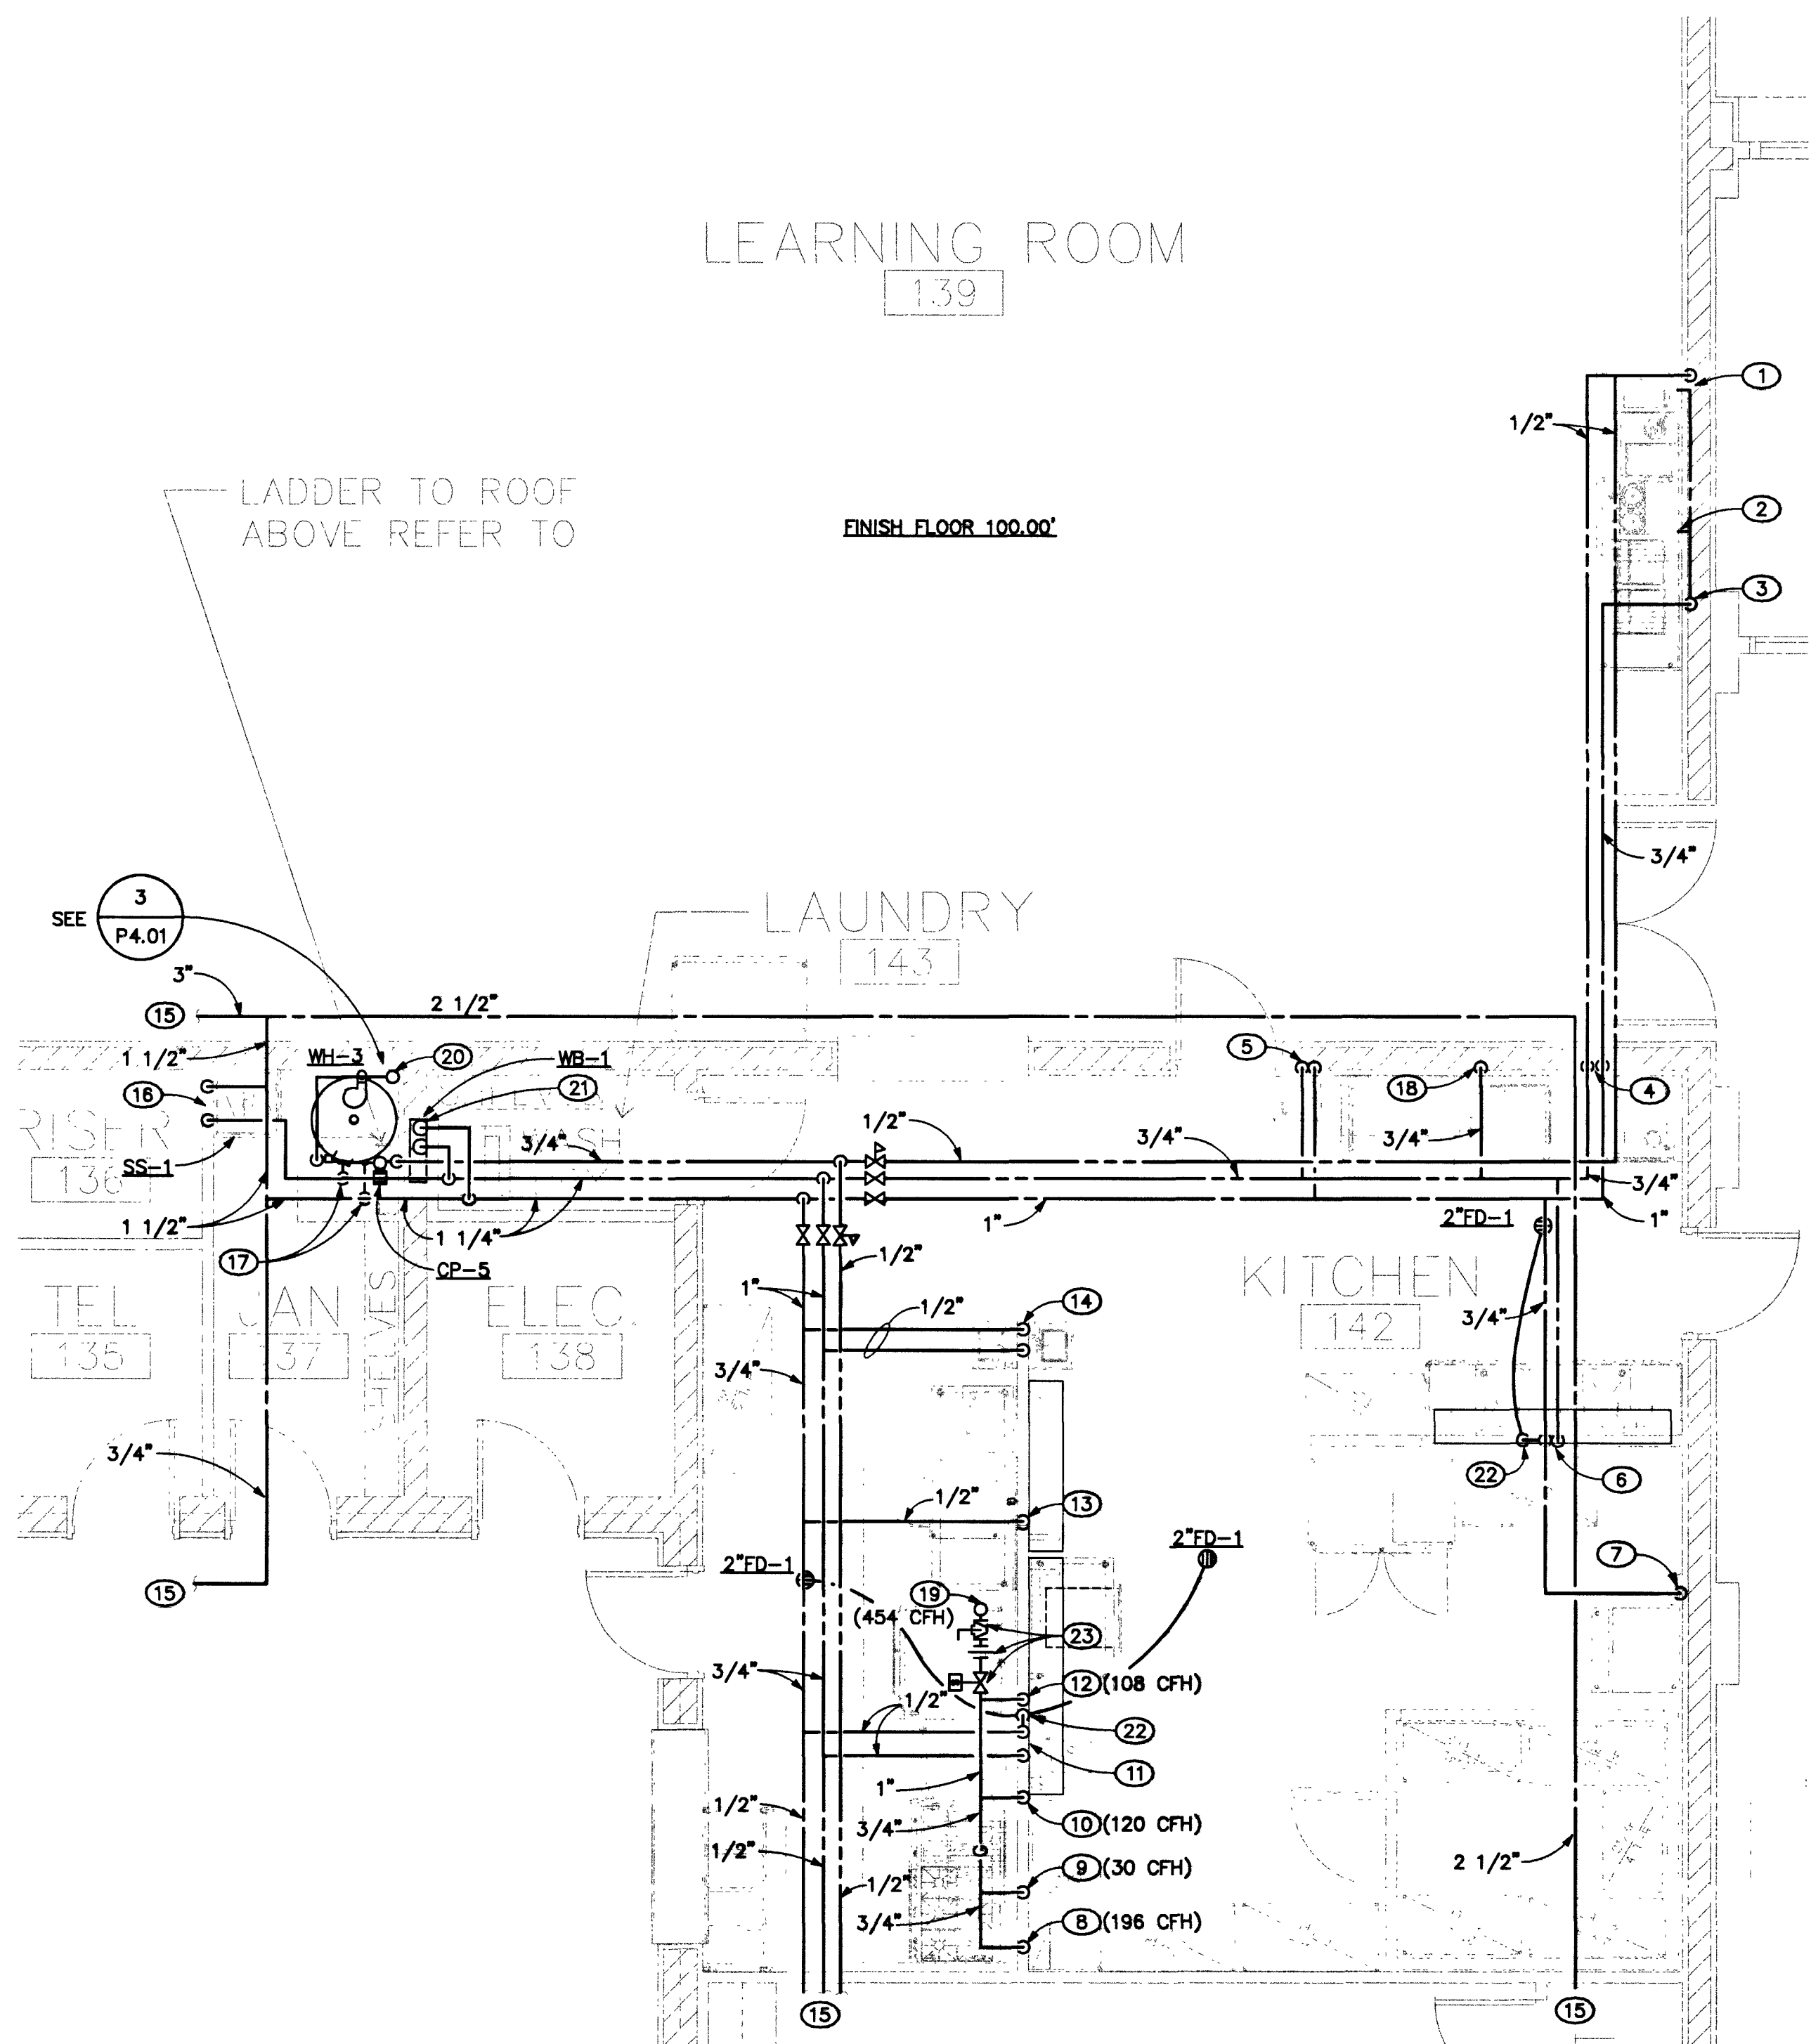

PARTIAL PLUMBING PLAN

SCALE: 1/4" = 1' - 0"

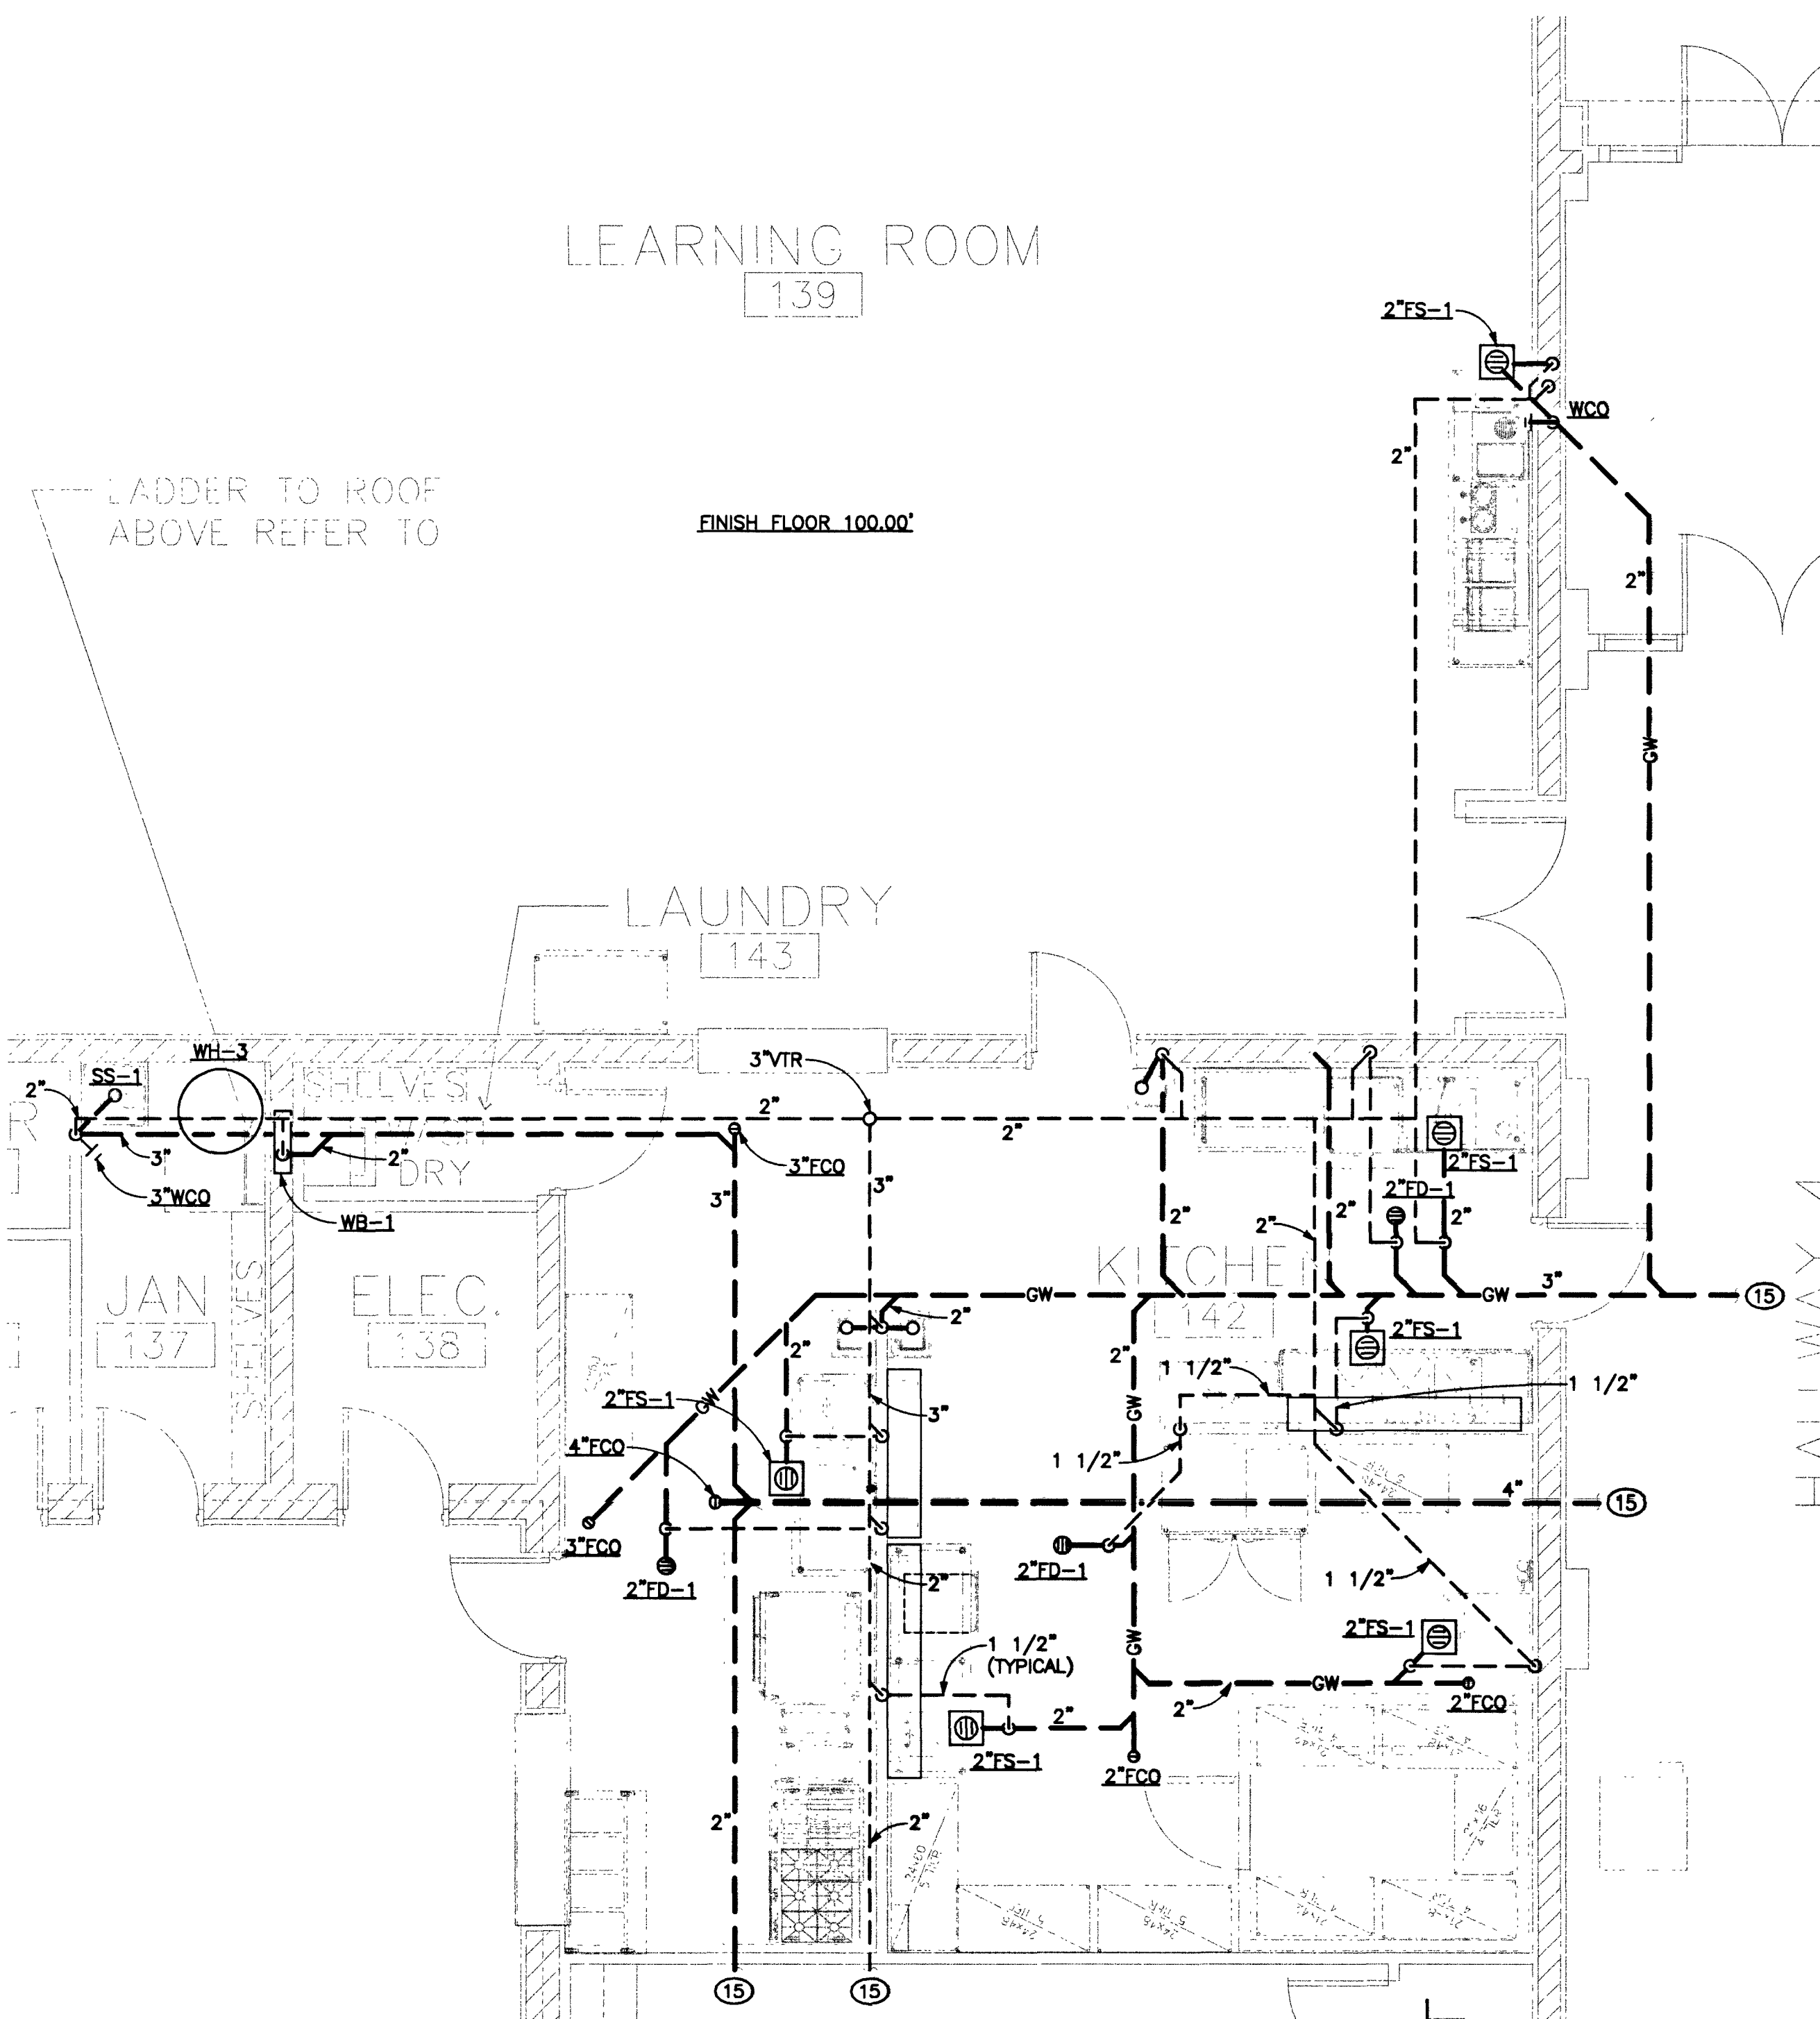

PARTIAL PLUMBING PLAN

SCALE: 1/4" = 1' - 0"

RECORD DRAWINGS
Date: 5/21/13 This record drawing has been prepared in part, based upon information furnished by others. While this information is believed to be reliable, Harris Consulting Engineers P.C. cannot assume its accuracy, and is not responsible for any errors or omissions which may have been incorporated into it as a result. Those relying on this record drawing are advised to obtain independent verification of its accuracy before applying it for any purpose.

OWNER: CITY OF LAS VEGAS
DEPARTMENT OF PUBLIC WORKS
ARCHITECTURAL SERVICES
400 EAST STEWART AVENUE
LAS VEGAS, NEVADA 89101
PHONE: (702) 228-8235
FAX: (702) 262-3232
TDD: (702) 366-9108
DATE: August 2, 2001
SCALE: 1/4"=1'-0"
SHEET NO: 01.15301.22
DRAWING NO: 521-268

P3.01