



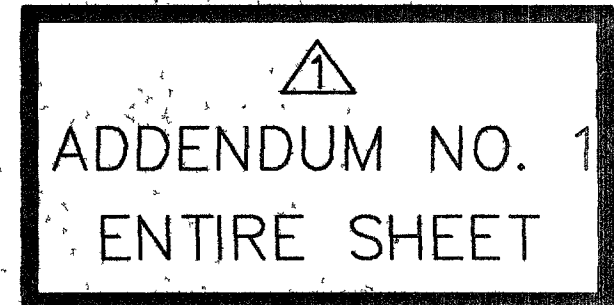

- LEGEND
- ☐ CONSTRUCT TREE PIT (SEE DETAIL SHEET)

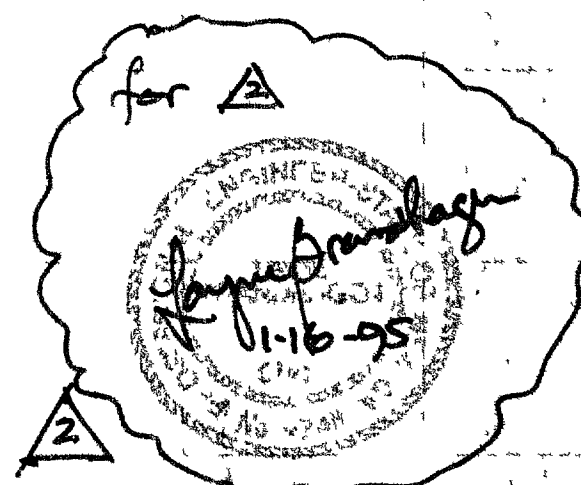

	REVISION NO.1 ISSUED AS ADDENDUM NO.1, ENTIRE SHEET. MODIFICATIONS MADE TO NOTES, CONCRETE ENCASEMENT ADDED TO PROFILE, CL II RCP ADDED TO PROFILE, 0.2' DROP IN INVERTS OF CONNECTOR PIPE.	12-10-94	DBB
	PER L.V.V.W.D. REVIEW	1-13-95	LAB
	REVISION NO 3, ISSUED AS CCO'. REMOVE PIPE BETWEEN STA 56+23.98 TO STA 51 + 43.04. C.B & M.H. @ STA 51 + 43.04.	1-31-95	DBB
NO.	REVISIONS	DATE	BY

PENTACORE

Engineering, Inc.
6763 West Charleston Boulevard
Las Vegas, Nevada 89132
(702) 258-0115

DESIGNED BY	DBB
DRAWN BY	KOZ
CHECKED BY	
NOTE BOOK NO.	

DOWNTOWN CORRIDOR IMPROVEMENTS

CITY OF LAS VEGAS DEPT. OF PUBLIC WORKS
LAS VEGAS, NEVADA

CONFORMED:
1-16-95

DATE 12/05/94

SCALE
HORIZ: 1" = 40'
VERT: 1" = 4'

STORM DRAIN PLAN AND PROFILE

STA.55+90 TO STA.58+00

DWG. NO.
107-V-22
FILE NO.
0135
SHEET
SD