



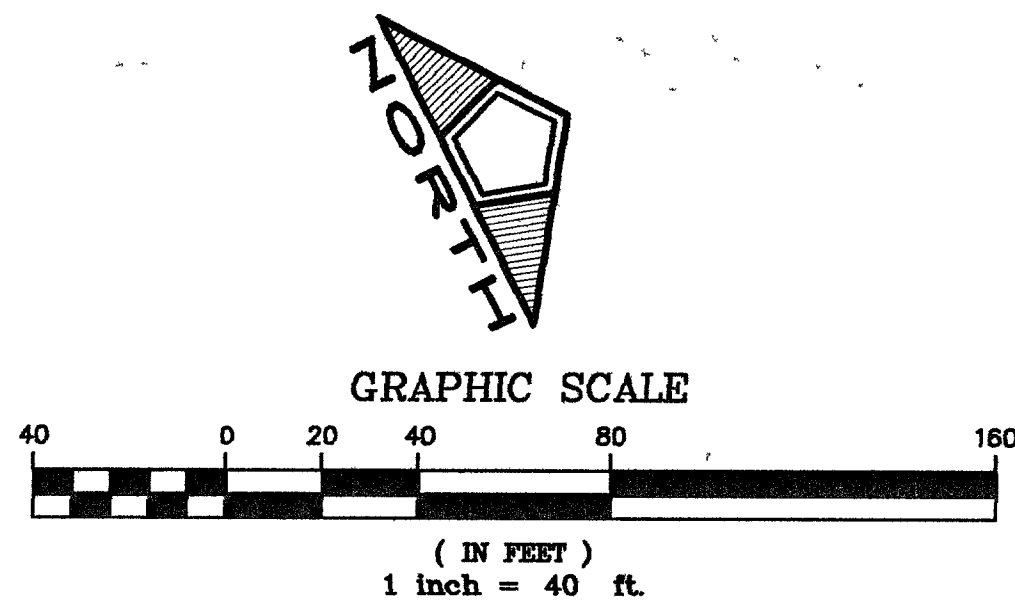

- NOTES**
- 1 REMOVE EXIS. PIPE OPENINGS. OVAL STORM DRAIN AND PLUG REMAINING CRETE.
 - 2 REMOVE EXISTING GRASS BASIN AND PLUG REMAINING CONNECTOR PIPE OPENINGS WITH CONCRETE.
 - 3 REMOVE AND RECONNECT EXISTING BUBBLER CATCH BASINS AND PLUG CONNECTOR PIPE OPENINGS WITH CONCRETE, AS DIRECTED BY ENGINEER.
 - 4 CONSTRUCT STORM DRAIN MANHOLE TYPE 1A PER C.L.V. STD. DWG. No. 404. SIZE - 4'.
 - 5 CONSTRUCT DROP INLET TYPE "A" PER C.L.V. STD. DWG. No. 411. SIZE - 4' TRUNCATE LOCAL DEPRESSION AT HANDICAP RAMP, AS DIRECTED BY ENGINEER.
 - 6 EXISTING UNDERSIDEWALK DRAIN. CLEAR OBSTRUCTIONS TO DRAIN, AS DIRECTED BY THE ENGINEER.
 - 7 SEE SHEETS SD-6 AND SD-7 FOR CONNECTOR PIPE PROFILES.
 - 8 CONSTRUCT NDOT TYPE 3 INLET PER NDOT STD. #R-4.3.1-(609), SIZE - 4'.
 - 9 WATER MAIN RELOCATION, SEE SHEET SD-1 FOR DETAIL.
 - 10 CONCRETE ENCASEMENT, SEE SHEET SD-1 FOR DETAIL.
 - 11 REMOVE EXISTING CONCRETE OR BRICKWORK SEAL; CONNECT 18" STORM DRAIN TO EXISTING 18" STUB.

CAUTION
4TH STREET CONTAINS
TELEPHONE AND TV

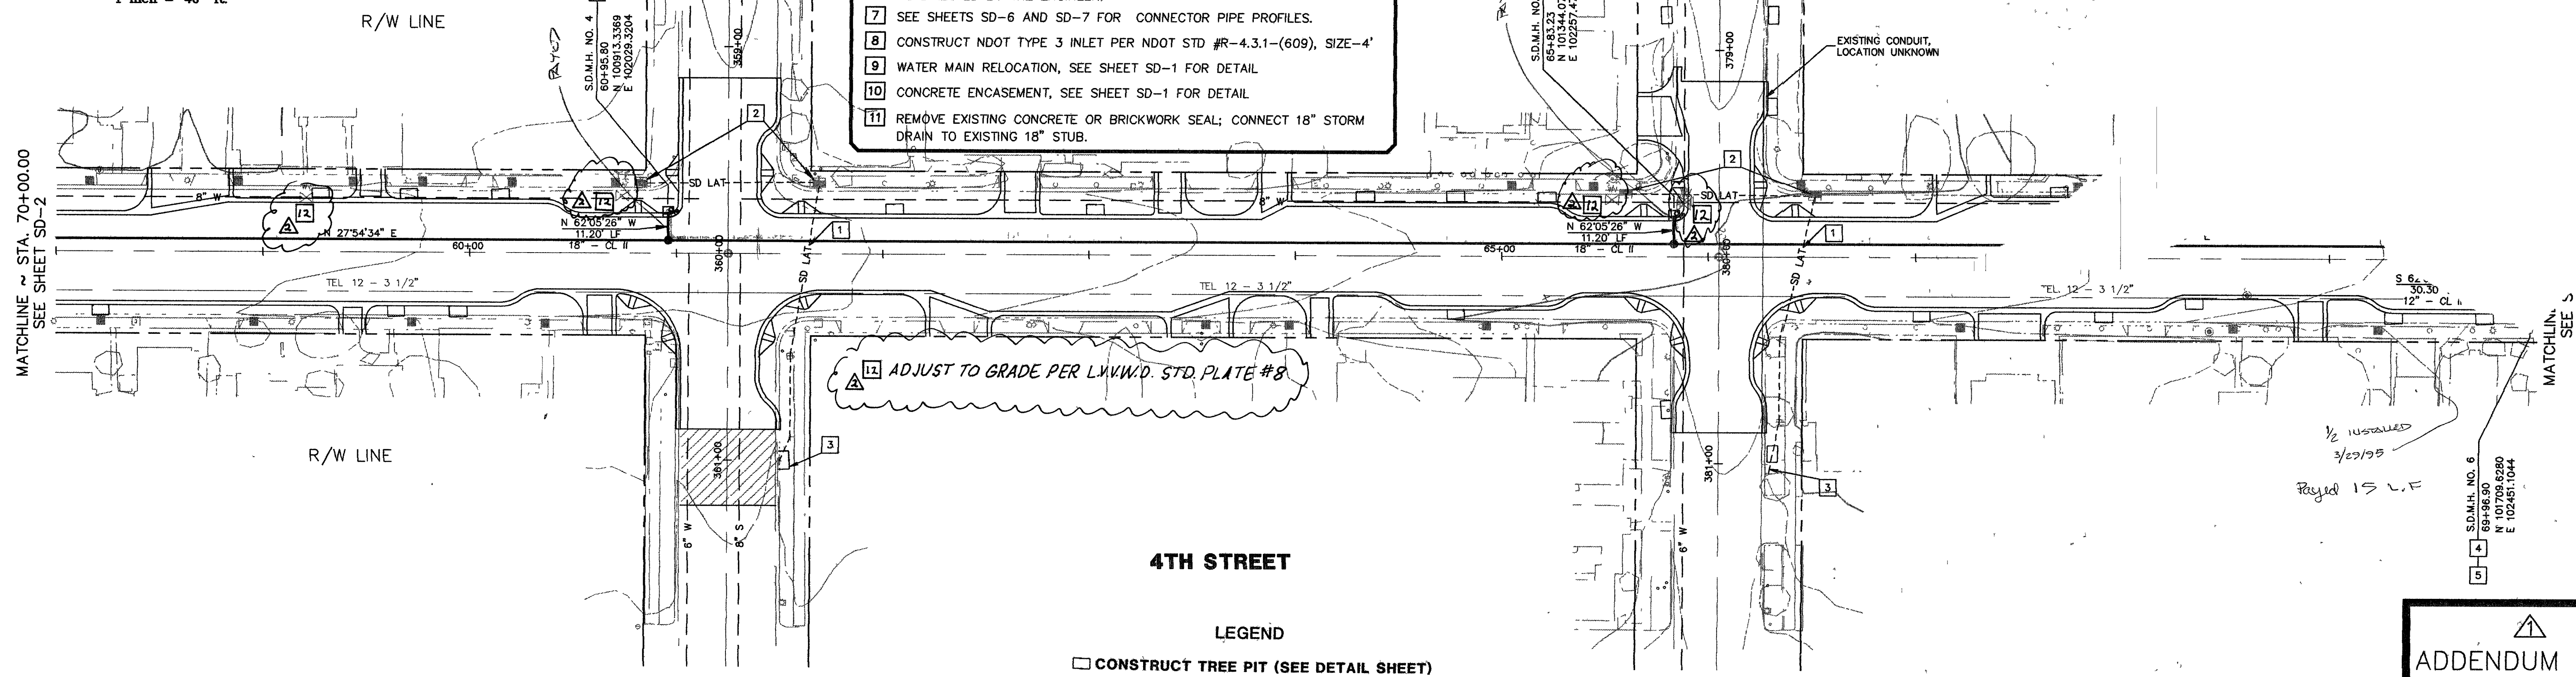


LEGEND
[Symbol] CONSTRUCT TREE PIT (SEE DETAIL SHEET)

ADDENDUM NO. 1
ENTIRE SHEET

LAS VEGAS VALLEY WATER DIST. DATE


58+00 59+00 60+00 61+00 62+00 63+00 64+00 65+00 66+00 67+00 68+00 69+00 70+00

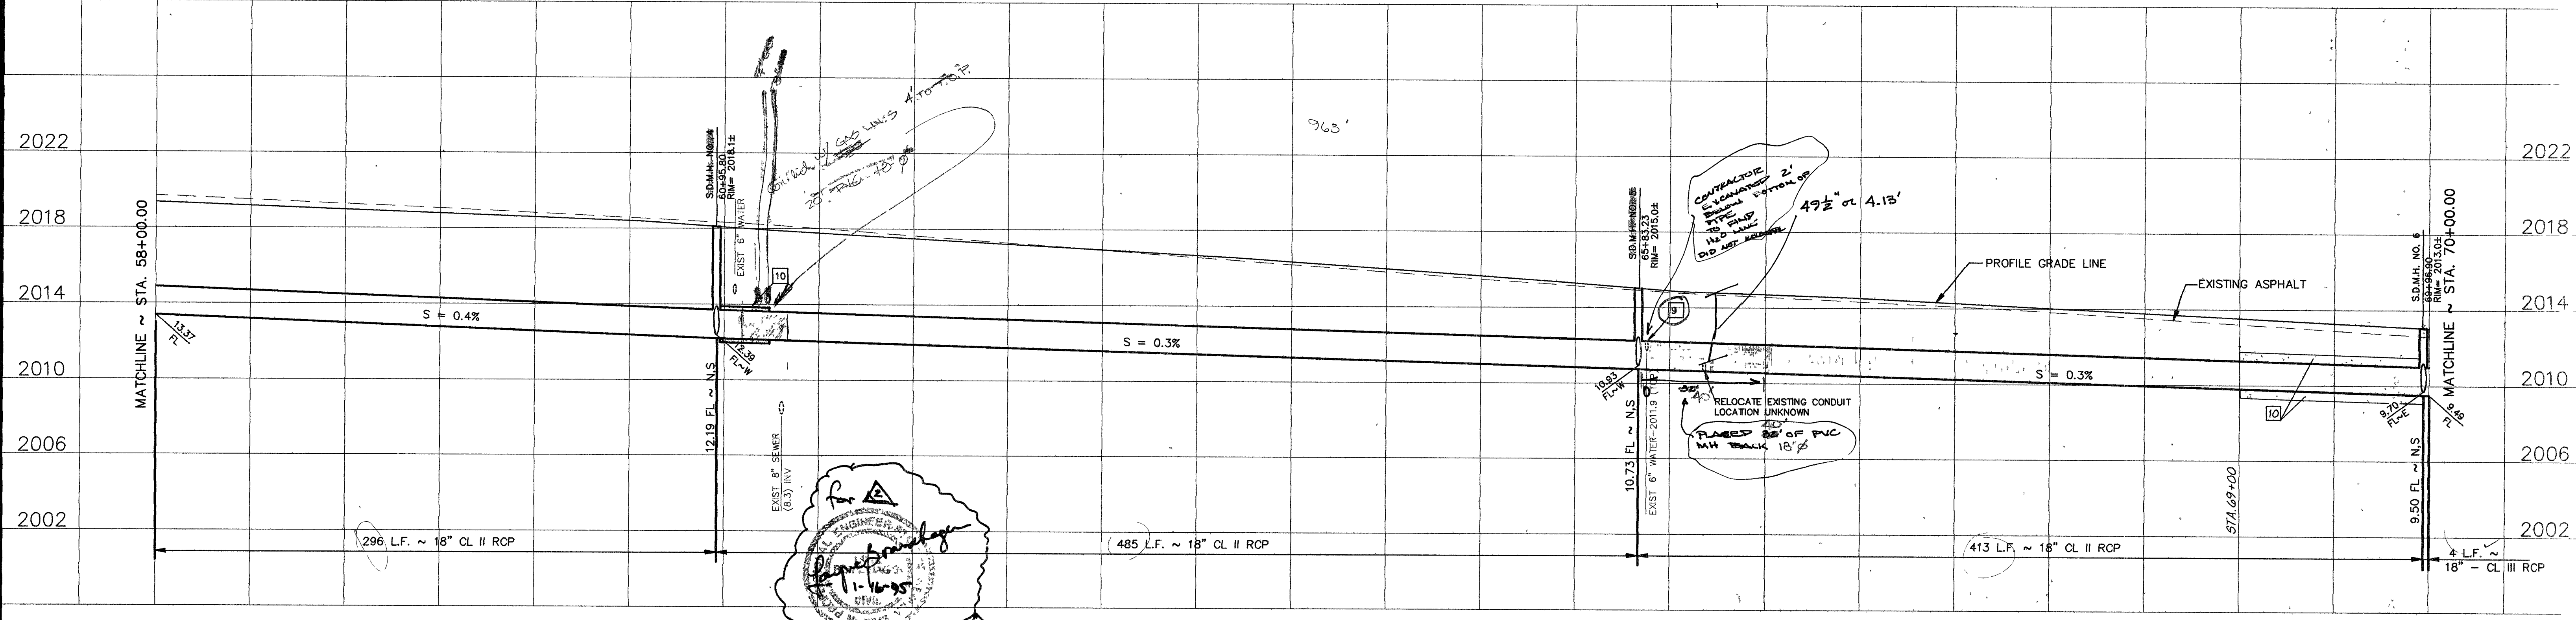

NO.	REVISIONS	DATE	BY
1	REVISION 1, ISSUED AS ADDENDUM NO.1, ENTIRE SHEET, MODIFYING NOTES, MODIFYING CLASS IV RCP IN PROFILE, ADDING CONCRETE ENCASEMENT, RIM ELEVATIONS WATER LINE RELOCATION, LVWD SIGNATURE BLOCK, 0.2' DROP IN CONNECTOR PIPE INVERTS.	12-10-94	DBB
2	PER LVWD REVIEW	1-13-95	DBB

PENTACORE
Engineering, Inc.
6763 West Charleston Boulevard
Las Vegas, Nevada 89102
(702) 258-0115

DESIGNED BY DBB
DRAWN BY KOZ
CHECKED BY
NOTE BOOK NO.

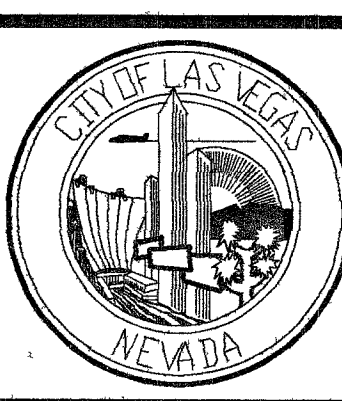

DOWNTOWN CORRIDOR IMPROVEMENTS
CITY OF LAS VEGAS DEPT. OF PUBLIC WORKS
LAS VEGAS, NEVADA

CONFIRMED:
1-16-95
DATE 12/05/94
SCALE
HORIZ: 1" = 40'
VERT: 1" = 4'

STORM DRAIN
PLAN AND PROFILE
STA. 58+00 TO STA. 70+00

DWG. NO. 101-V-2286
FILE NO.
SHEET SD-3