


WASTE AND VENT PIPING PLAN BUILDING III LEVEL 1

SCALE: 3/16"=1'-0" 86229

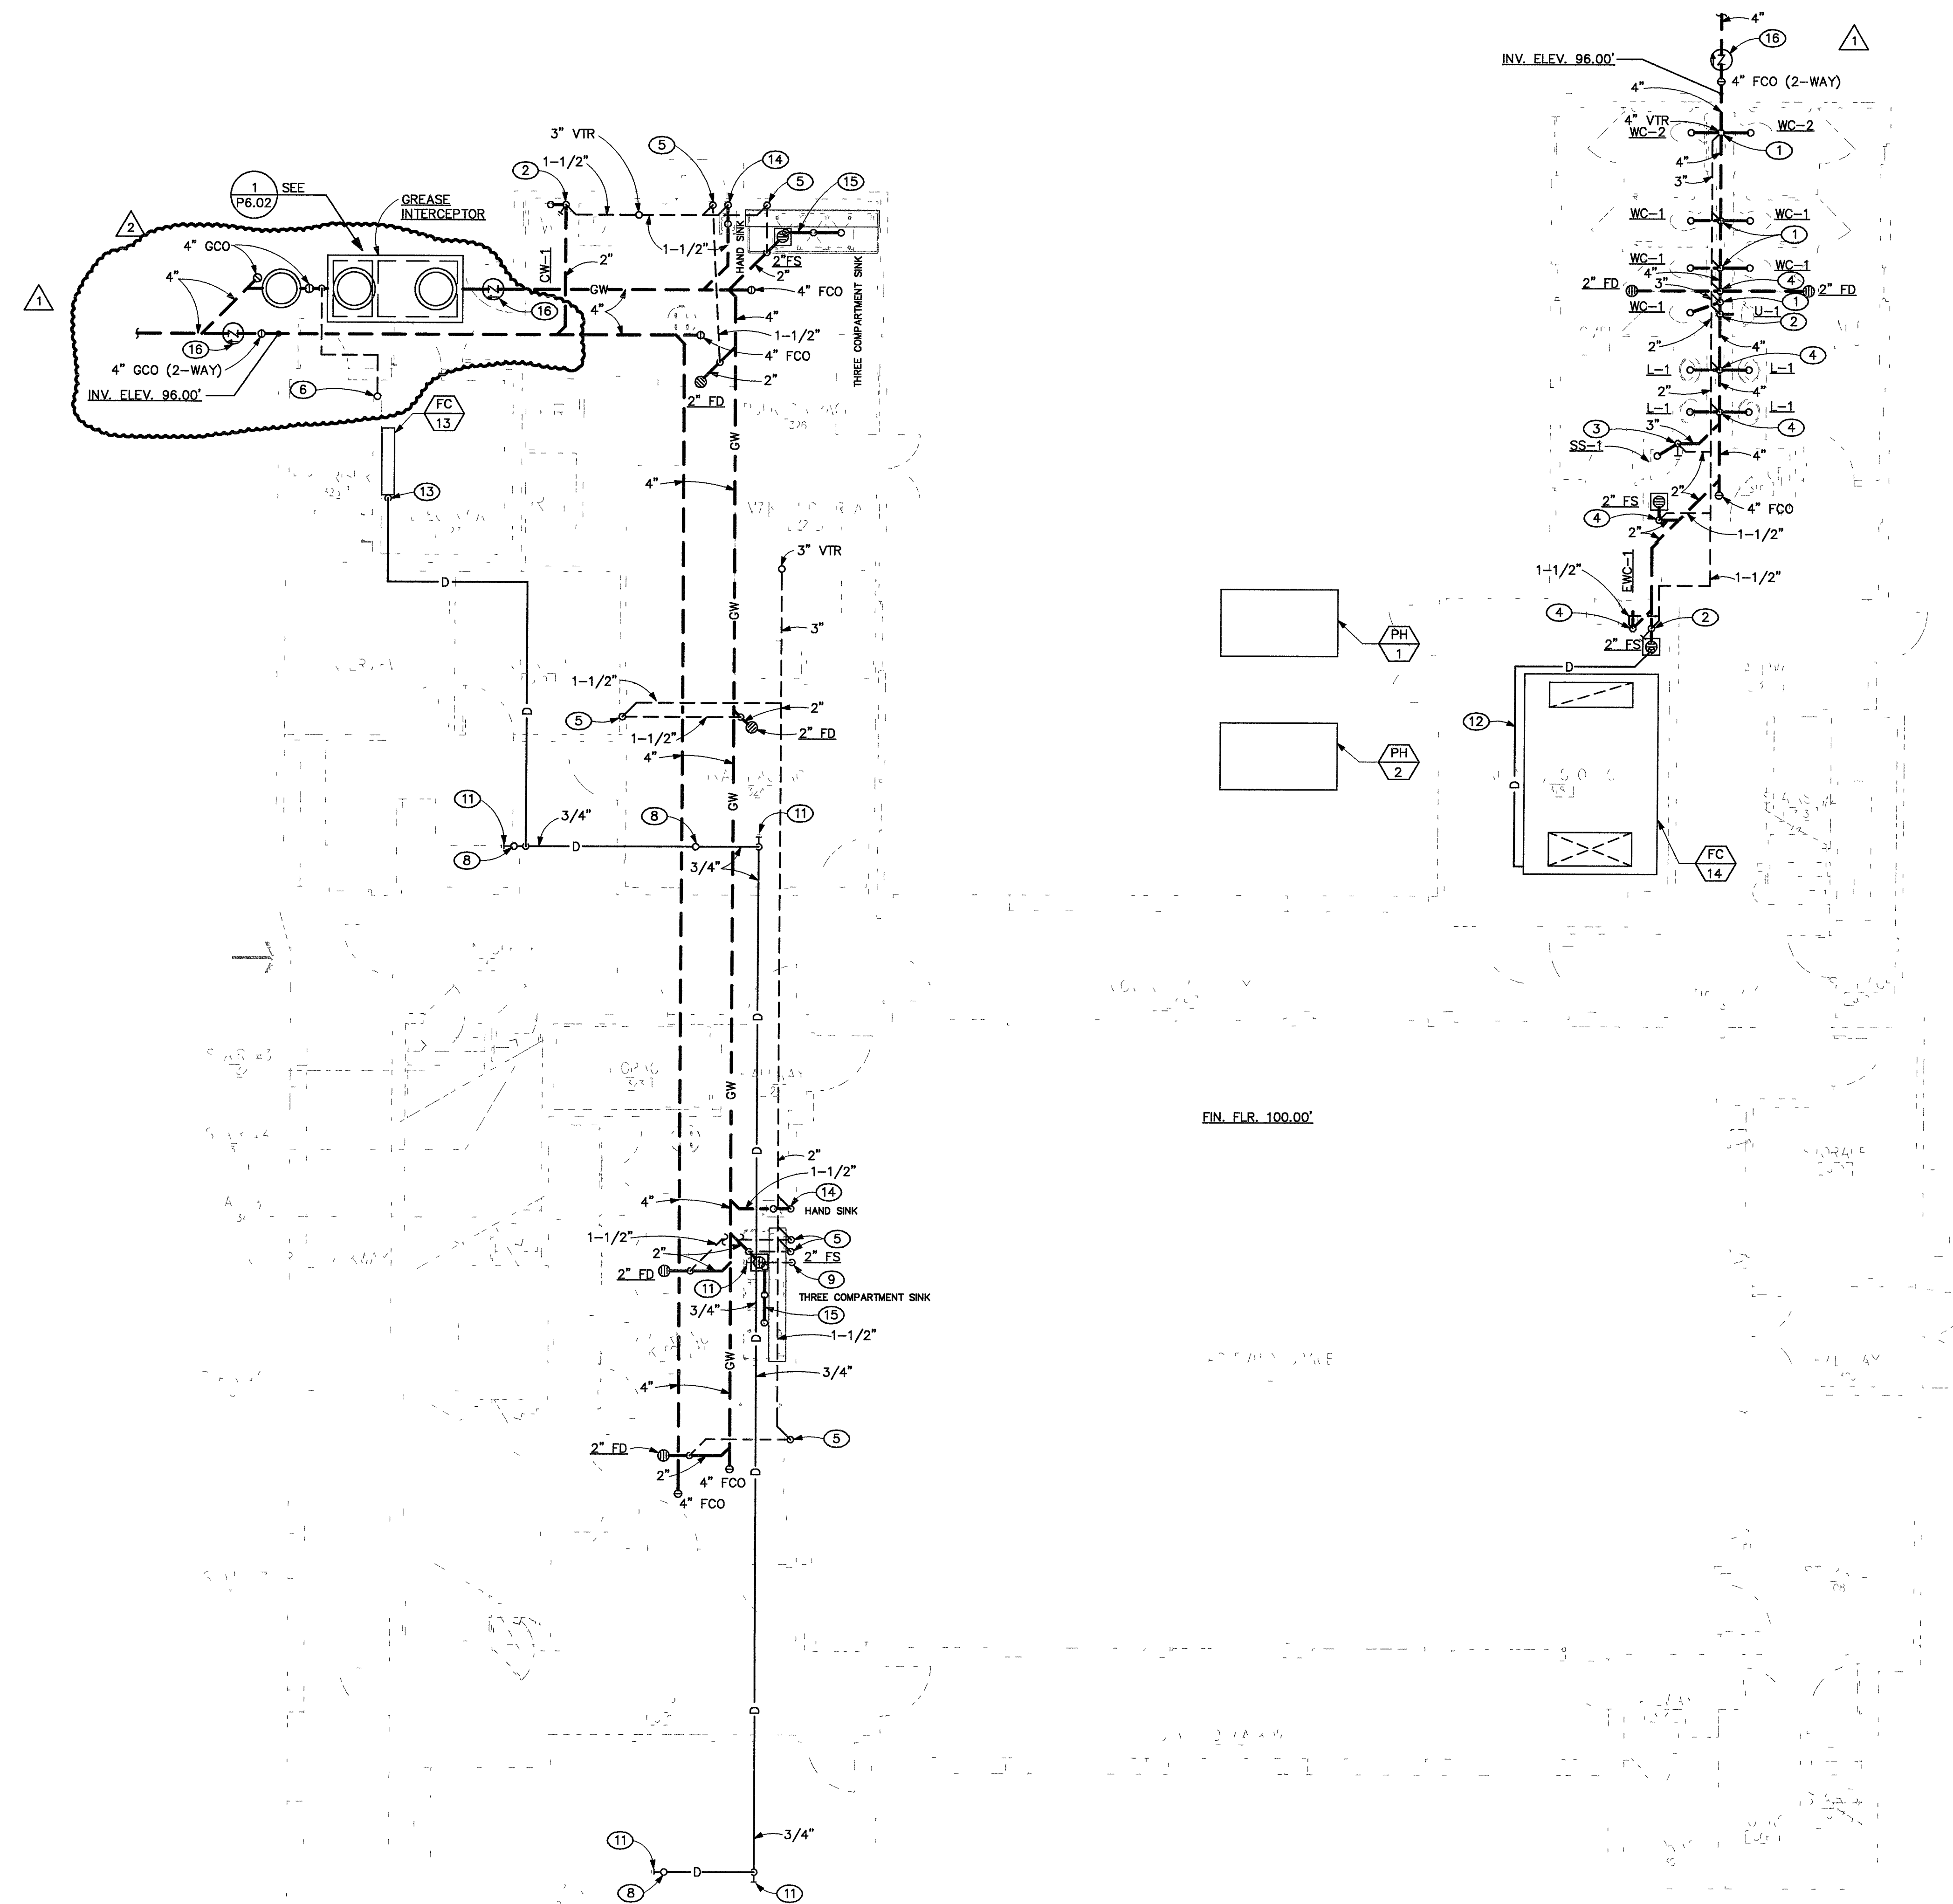

GENERAL NOTES

1. ALL DRAINAGE PIPING 3" AND SMALLER SHALL BE SLOPED AT 1/4" PER FOOT.
2. ALL DRAINAGE PIPING 4" AND LARGER SHALL BE SLOPED AT 1/8" PER FOOT.
3. ALL CONDENSATE DRAINAGE (CD) PIPING SHALL BE SLOPED AT 1/8" PER FOOT.
4. ALL STORM DRAIN (SD) AND OVERFLOW STORM DRAIN (OSD) PIPING SHALL BE SLOPED AT 1/8" PER FOOT.
5. NO PIPING SHALL BE DIRECTLY EMBEDDED IN CONCRETE OR MASONRY WALLS.
6. THE CUTTING, NOTCHING AND BORING OF HOLES IN FLOOR JOISTS AND WALL STUDS SHALL BE IN ACCORDANCE WITH THE UNIFORM BUILDING CODE 1997 EDITION, VOLUME NO. 2, CHAPTER 23, SECTION 2320.

SHEET NOTES

- 1 4" SOIL DOWN 2" VENT UP.
- 2 2" WASTE DOWN, 2" WCO ABOVE FLOOR, 1-1/2" VENT UP.
- 3 3" WASTE DOWN, 3" WCO ABOVE FLOOR, 2" VENT UP.
- 4 2" WASTE DOWN, 1-1/2" VENT UP.
- 5 1-1/2" VENT UP FROM BELOW AND UP.
- 6 2" VENT UP FROM BELOW AND UP THRU ROOF.
- 7 NOT USED.
- 8 3/4" CONDENSATE DRAIN UP THROUGH ROOF TO HEAT PUMP ON ROOF.
- 9 3/4" CONDENSATE DOWN TO SPILL OVER FLOOR SINK.
- 10 NOT USED.
- 11 CLEANOUT CAP.
- 12 3/4" CONDENSATE DRAIN FROM FC-14 TO OVER FLOOR SINK.
- 13 3/4" CONDENSATE DRAIN UP FROM FAN COIL WITH CONDENSATE PUMP, SEE MECHANICAL DRAWINGS FOR LOCATION.
- 14 1-1/2" WASTE DOWN, 1-1/2" WALL CLEANOUT ABOVE FLOOR, 1-1/2" VENT UP, FOR HAND SINK. SEE FOOD SERVICE EQUIPMENT DRAWINGS.
- 15 1-1/2" INDIRECT WASTE FROM THREE COMPARTMENT SINK TO OVER 2" FLOOR SINK. SEE FOOD SERVICE EQUIPMENT DRAWINGS.
- 16 BACKWATER VALVE ZURN MODEL NO. Z1090.

CITY OF LAS VEGAS
DOWNTOWN SENIOR SERVICES CENTER
NEIGHBORHOOD SERVICES

BID
SET

OWNER: CITY OF LAS VEGAS
DEPARTMENT OF PUBLIC WORKS
ARCHITECTURAL SERVICES

400 EAST STEWART AVENUE
LAS VEGAS, NEVADA 89101
PHONE: (702) 228-6535
FAX: (702) 388-3030
TDD: (702) 388-0108

DRAWN: C.A.
FILE: P2.03.DWG
DATE: September 8, 2004
SCALE: 3/16"=1'-0"
BID NO: 04B34101
CLYDUS NO: 01-281

WASTE AND VENT PIPING
LEVEL 1
P2.03

PROJECT NO: 23154.30
DESIGNED BY: A. DABIES
CHECKED BY: R.S. HARRIS
DRAWN BY: C. SADLER
PM: J. SEAL

