


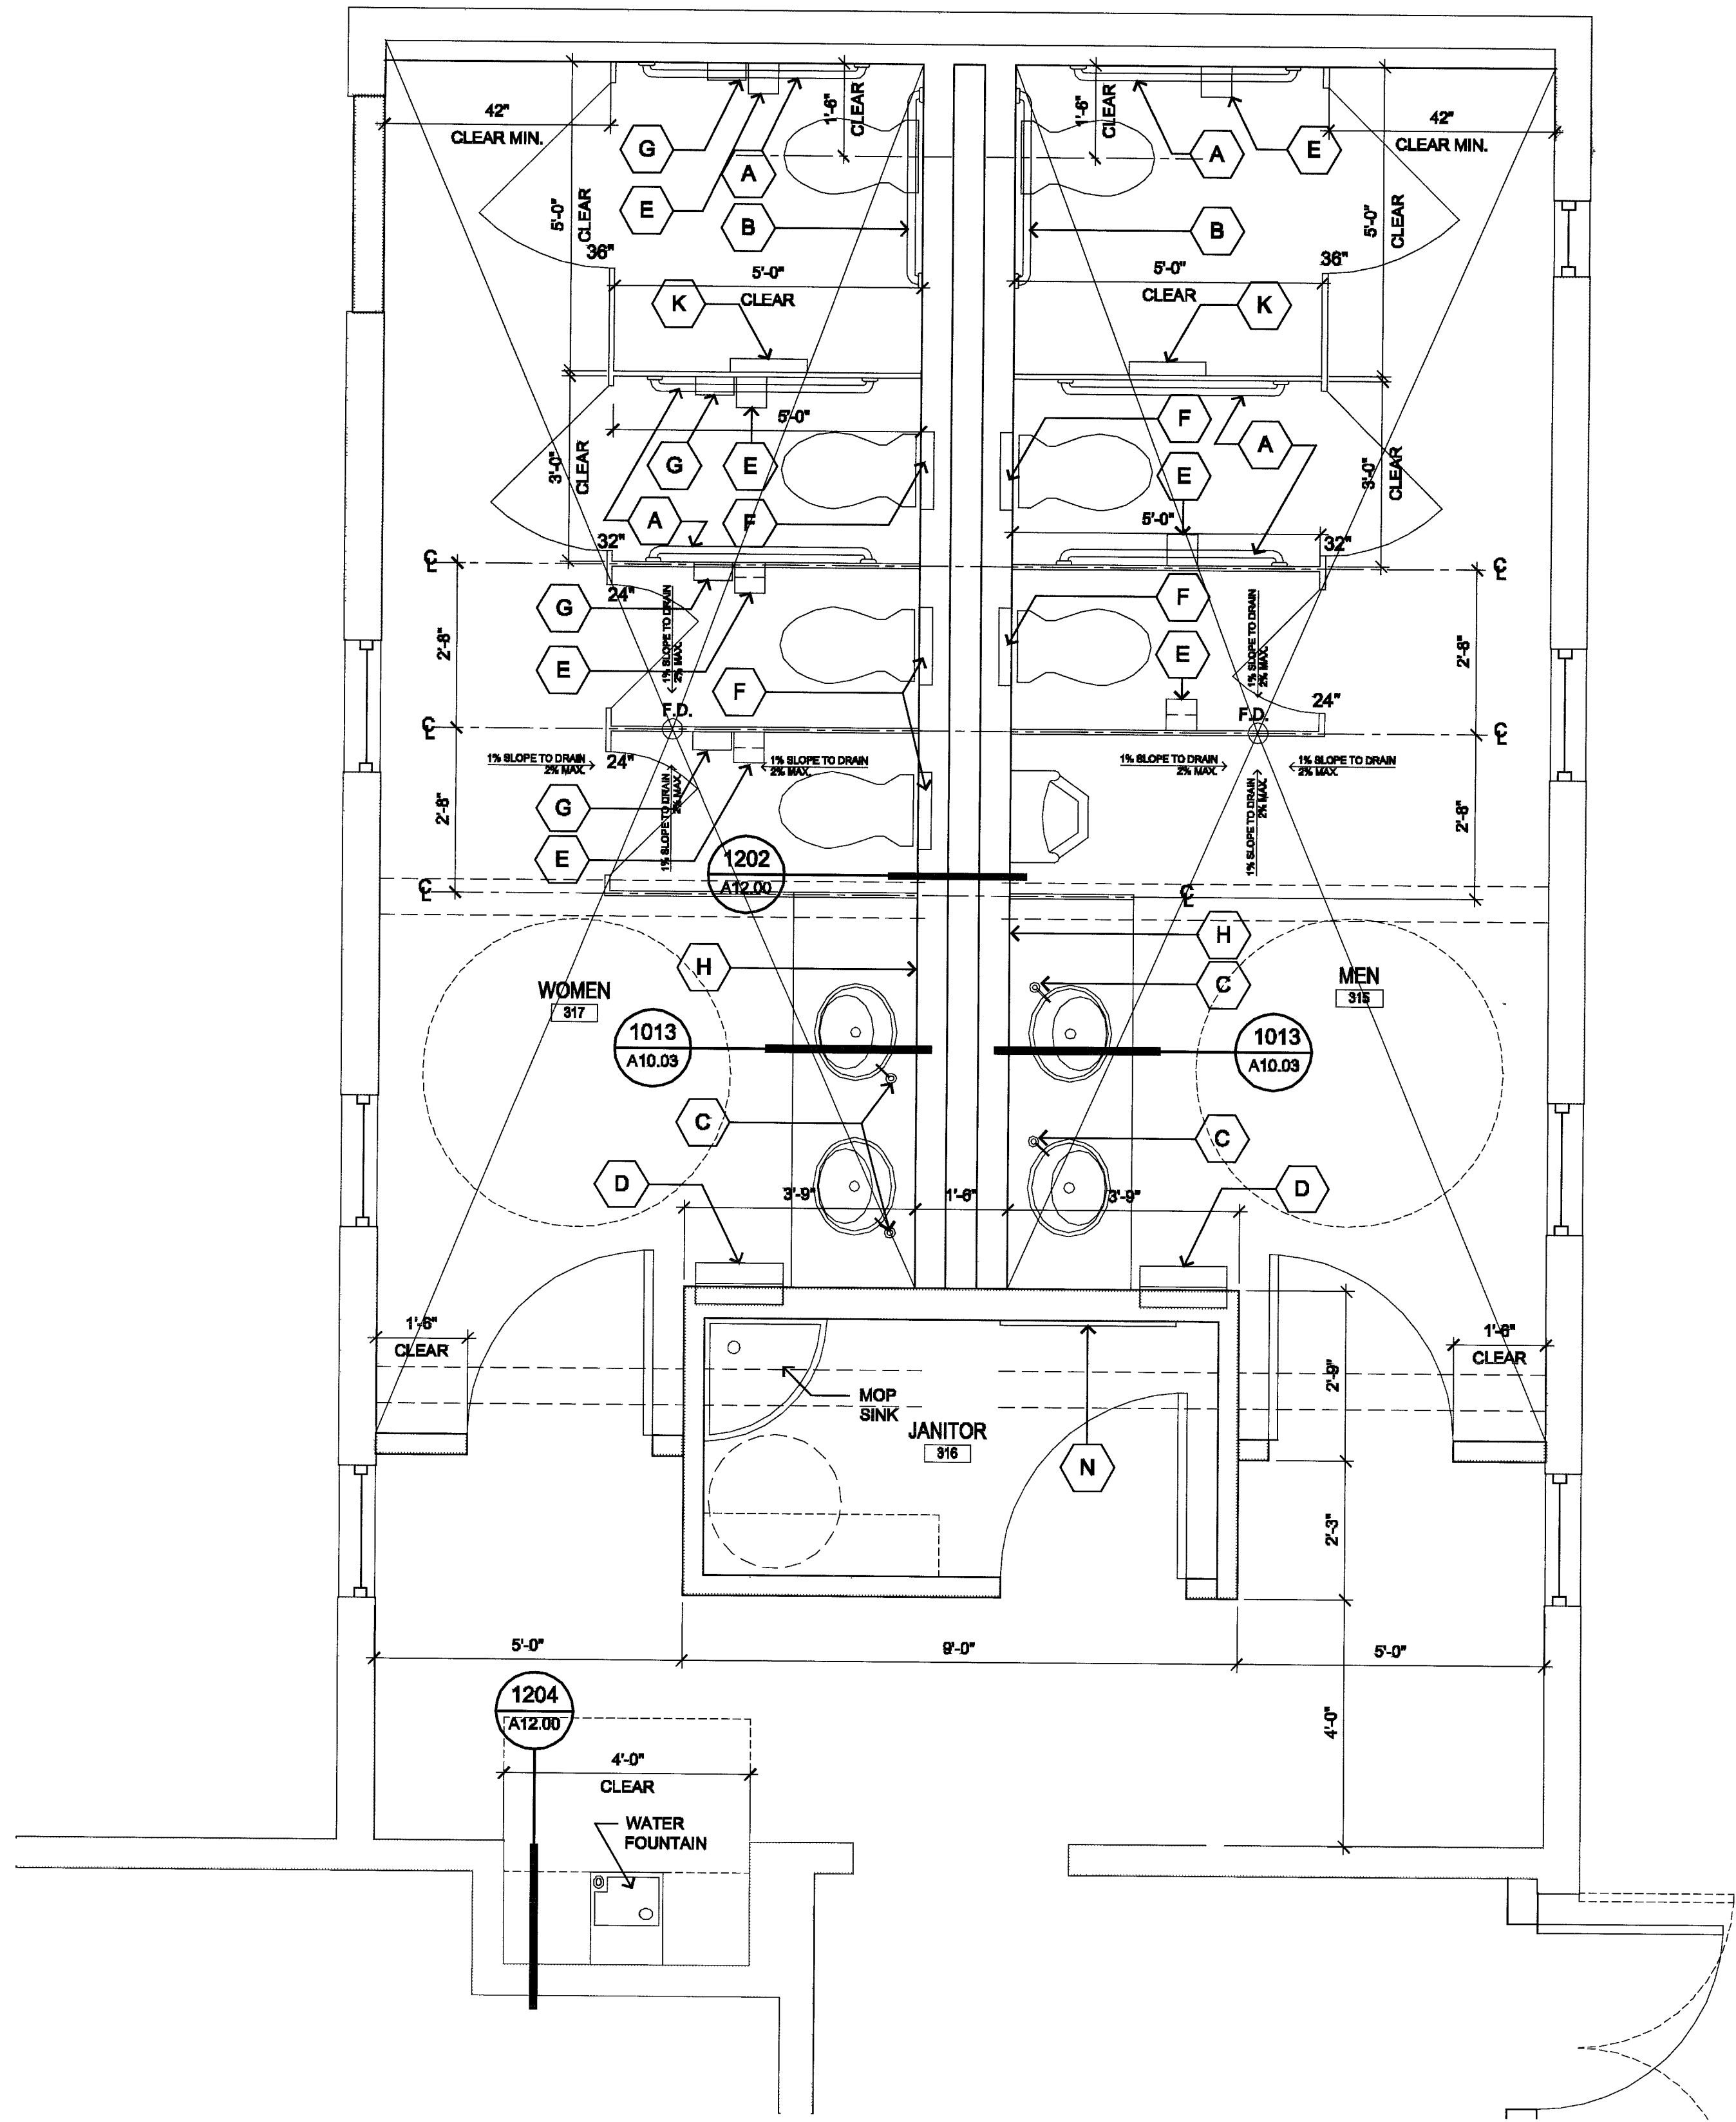

A ENLARGED RESTROOM PLAN
1/2"=1'-0"

TOILET ACCESSORY SCHEDULE

TYPE	DESCRIPTION	MANUFACTURER	MODEL NUMBER	FINISH	MOUNTING HEIGHT A F F
(A)	42" GRAB BAR	BOBRICK	B-6806 x 42	S S (SATIN)	36" TO CENTER
(B)	36" GRAB BAR	BOBRICK	B-6806 x 36	S S (SATIN)	36" TO CENTER
(C)	LIQUID SOAP DISPENSER	BOBRICK	B-622	S S (SATIN)	
(D)	PAPER TOWEL DISP. WASTE RECEPT	BOBRICK	B-3944	S S (SATIN)	60 1/2" TO TOP
(E)	TOILET TISSUE DISPENSER	BOBRICK	B-2888	S S (SATIN)	SEE ELEVATIONS
(F)	SEAT COVER DISPENSER	BOBRICK	B-301	S S (SATIN)	44-1/2" TO TOP
(G)	SANITARY NAPKIN DISPOSAL	BOBRICK	B-270	S S (SATIN)	28" TO TOP
(H)	1/4" PLATE MIRROR FULL WIDTH	BOBRICK	B-290 48" HGT		40" TO BOTTOM
(I)	MIRROR	BOBRICK	B-290 36x48		38" TO BOTTOM
(J)	SEAT COVER DISPENSER	BOBRICK	B-221	S S (SATIN)	44-1/2" TO TOP
(K)	PAPER TOWEL DISPENSER	BOBRICK	B-2621	S S (SATIN)	4'-0" TO DISPENSER
(L)	UTILITY HOOK	BOBRICK	B-6707	S S (SATIN)	3'-0" TO TOP
(M)	MOP / BROOM HOLDER	BOBRICK	B-239	S S (SATIN)	48" TO CENTER
(N)	LIQUID SOAP DISPENSER	BOBRICK	B-2111	S S (SATIN)	40" TO PUSH BUTTON
NOTE CONCEALED ANCHOR PLATES PROVIDE AT ALL GRAB BAR LOCATIONS		BOBRICK	2562		

FIXTURE HEIGHTS and NOTES

VERIFY ALL PLUMBING FIXTURE MOUNTING HEIGHTS WITH PLUMBING DRAWINGS

STANDARD LAV 2'-10" TO TOP
STANDARD W.C. 1'-6" TO 1'-7"

ALL TOILET ACCESSORIES HEIGHT AND CLEARANCES MUST CONFORM TO ALL ADA/ACCESSIBILITY GUIDELINE REQUIREMENTS - REFER TO ADA GUIDELINES

PROVIDE BLOCKING FOR TOILET ACCESSORY ANCHORAGE AS REQUIRED - CONCEALED ANCHOR PLATES (BOBRICK - 2562 SERIES) TO BE PROVIDED AT ALL GRAB BAR LOCATIONS

FULLY INSULATE ALL PLUMBING PIPES IN ALL PERIMETER WALLS OF ALL TOILET ROOMS (TO HELP REDUCE NOISE CAUSED BY THE PIPES)

BOBRICK MODEL NUMBERS LISTED ARE FOR COLOR, PATTERN AND QUALITY IDENTIFICATION ONLY - CONTRACTOR MAY PROVIDE APPROVED EQUAL TOILET ACCESSORIES WITH PRIOR APPROVAL

FULLY INSULATE ALL EXPOSED LAVATORY PIPES AS REQUIRED IN THE AMERICANS WITH DISABILITIES ACT (ADA) REQUIREMENTS

ALL TOILET ROOMS ARE TO BE ACCESSIBLE WITH ACCESSIBLE FIXTURES AND CONTROLS PER ADA REQUIREMENTS EXCEPTION TOILET ROOMS DEDICATED AS STRICTLY PRIVATE

REFER TO ADA SHEETS 1-8 FOR STANDARD ADA REQUIREMENTS

DETAIL WINDOW SILLS AND SIDES WITH TILE TO MATCH REQUIRED HEIGHT

SEE DETAIL E/A2 20 FOR TYPICAL TILE LAYOUT (TYPICAL FOR ALL RESTROOMS AND UNISEX IN BUILDING 2 AND 3)

IMPORTANT NOTE!!!
ALL TOILET FLUSH VALVES MUST BE LOCATED ON THE ACCESSIBLE SIDE OF THE TOILET - NOT THE SIDE OF THE TANK CLOSEST TO THE WALL.

95865

INSIDE
3/04/05 - Arch. W.F.

CONSULT

JMA ARCHITECTURE STUDIOS

10158 60188108 C0055 8 6111

RECORD DRAWING
This record drawing, dated September 20, 2004, has been prepared in part based upon information furnished by others.

While this information is believed to be reliable, JMA Architecture Studios cannot assume its accuracy and does not accept responsibility for the accuracy of the record drawing or for any errors or omissions which may have been incorporated into it as a result.

These drawings and the record documents are accepted upon independent verification of its accuracy before applying for any purpose.

CITY OF LAS VEGAS
DOWNTOWN SENIOR SERVICES CENTER
NEIGHBORHOOD SERVICES

BID SET

OWNER: CITY OF LAS VEGAS
DEPARTMENT OF PUBLIC WORKS
ARCHITECTURAL SERVICES

400 EAST STEWART AVENUE
LAS VEGAS, NEVADA 89101
PHONE: (702) 226-6939
FAX: (702) 382-3212
TDD: (702) 386-9106

DRAWN: B. Bullock

DATE: September 8, 2004

SCALE: 1/2" = 1'-0"

DESIGN NO: 04.10341.01

CITY DRAW NO: 521-287

Enlarged Plans

95865

A2.21