



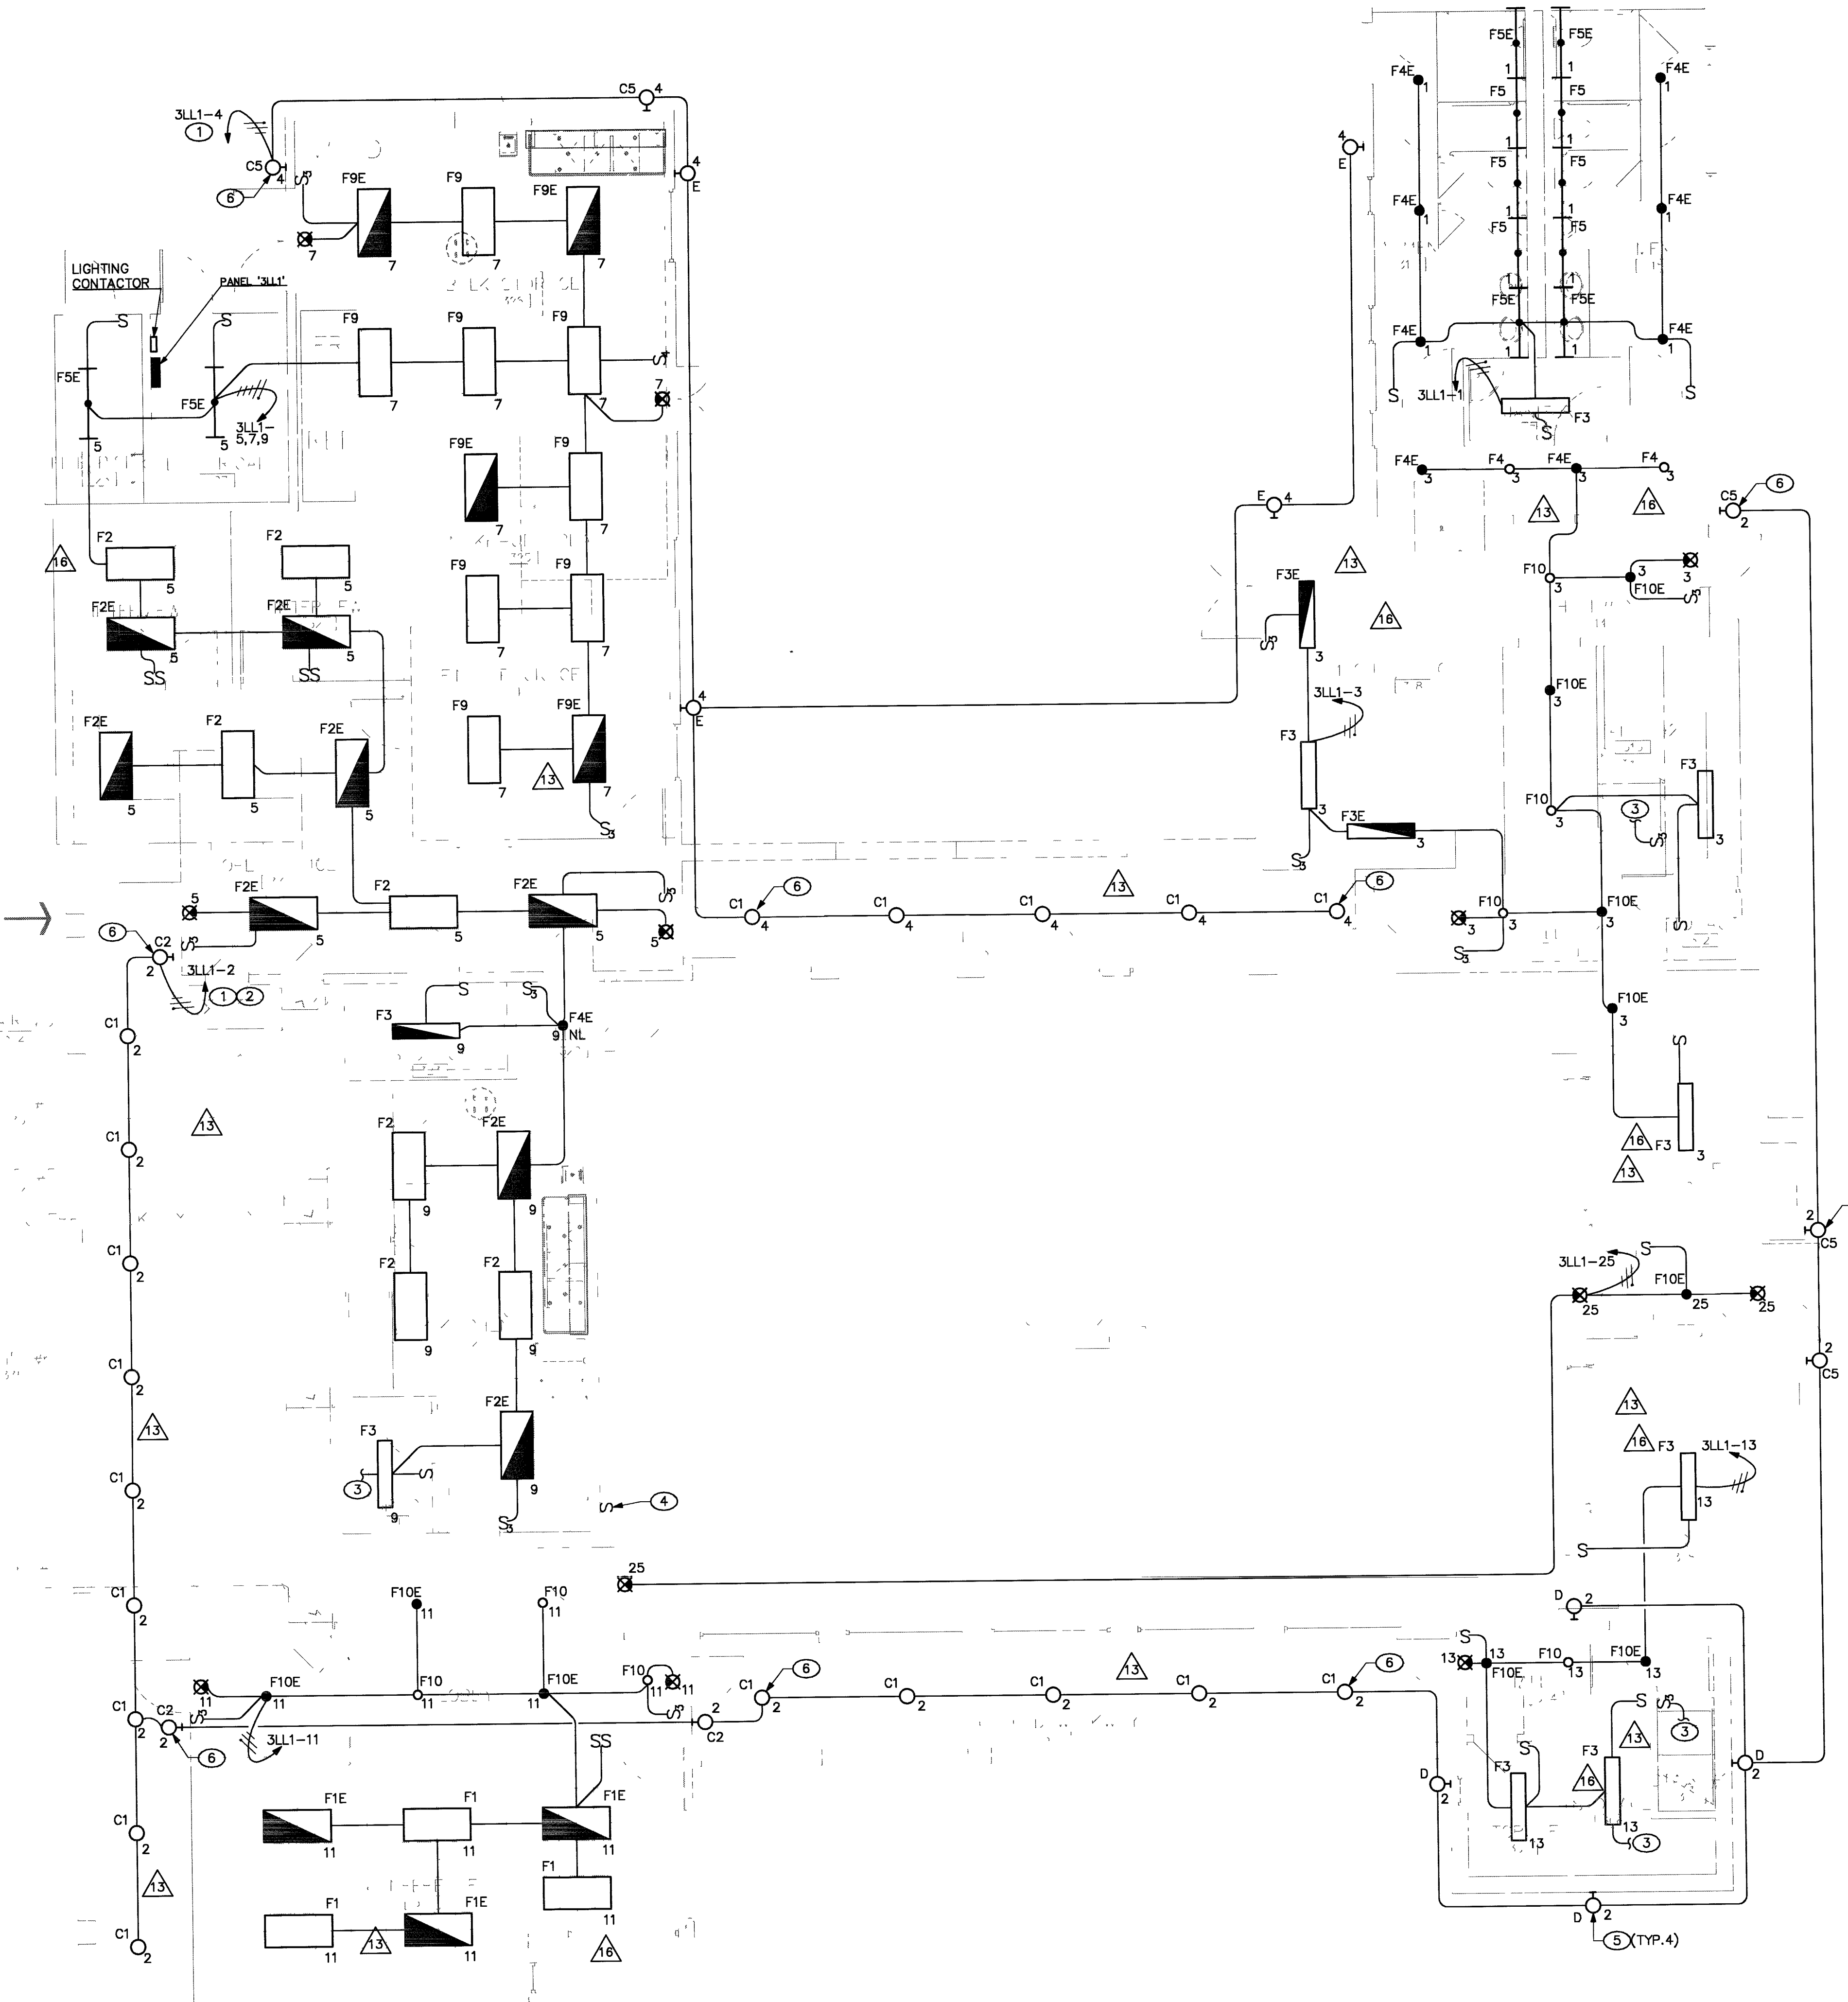

LIGHTING PLAN FLOOR 1 BUILDING III
SCALE: 3/16"=1'-0"

- GENERAL NOTES**
- SEE POWER PLANS FOR LOCATIONS OF PANELBOARDS.
 - SEE ARCHITECTURAL DRAWINGS FOR ADDITIONAL INFORMATION AND EXACT FIXTURE LOCATIONS.
 - COORDINATE LOCATIONS OF REQUIRED LIGHTING TRANSFORMERS WITH ARCHITECT PRIOR TO ROUGH-IN. PROVIDE ACCESS PANEL OR CONNECTION ABOVE ACCESSIBLE CEILING AND OVERCURRENT PROTECTION PER NEC REQUIREMENTS IF NOT INTEGRAL WITH FIXTURE.
 - VERIFY EGRESS PATHS WITH FINAL ARCHITECTURAL EXITING PLANS. PROVIDE ANY ADDITIONAL EXIT SIGNS REQUIRED BY THE AUTHORITY HAVING JURISDICTION FOR APPROVAL. RECORD LOCATION OF ANY ADDITIONAL EXIT SIGNS ON RECORD DRAWINGS.
 - PROVIDE AN UNSWITCHED CONDUCTOR TO ALL EXIT SIGNS AND EMERGENCY LIGHTING FIXTURES.
 - ALL 20A, 120V BRANCH CIRCUITS IN EXCESS OF 75 FT SHALL HAVE #10 AWG CONDUCTORS AND CONDUIT UPSIZED ACCORDINGLY.
 - MULTIPLE SWITCHES LOCATED IN ONE LOCATION SHALL BE MOUNTED UNDER COMMON GANGED FACEPLATE. MULTIPLE SINGLE GANG FACEPLATES ARE NOT ACCEPTABLE.

- SHEET NOTES**
- ROUTE CIRCUITS TO PANEL '3LL1' THROUGH LIGHTING CONTACTOR. REFER TO DETAIL 1/E2.03 FOR ADDITIONAL INFORMATION.
 - CIRCUIT USING #10AWG THROUGHOUT.
 - REFER TO LIGHTING PLAN ON SHEET E2.04 FOR CONTINUATION OF CIRCUIT.
 - PROVIDE (11) ELEVEN SWITCHES FOR CONTROL OF ASSEMBLY SPACE LIGHTS AND (1) DIMMER FOR CONTROL OF TRACK LIGHTING. REFER TO LIGHTING PLAN ON E2.04 FOR ADDITIONAL SWITCHING INFORMATION.
 - FLOODLIGHT FOR BELL TOWER. FIELD COORDINATE LOCATION WITH ARCHITECT AND OWNER'S REPRESENTATIVE PRIOR TO ROUGH-IN.
 - PROVIDE FULL LUMEN EMERGENCY BATTERY BACK-UP. BATTERY TO BE REMOTE MOUNTED. LOCATE PER MANUFACTURER'S RECOMMENDATIONS.

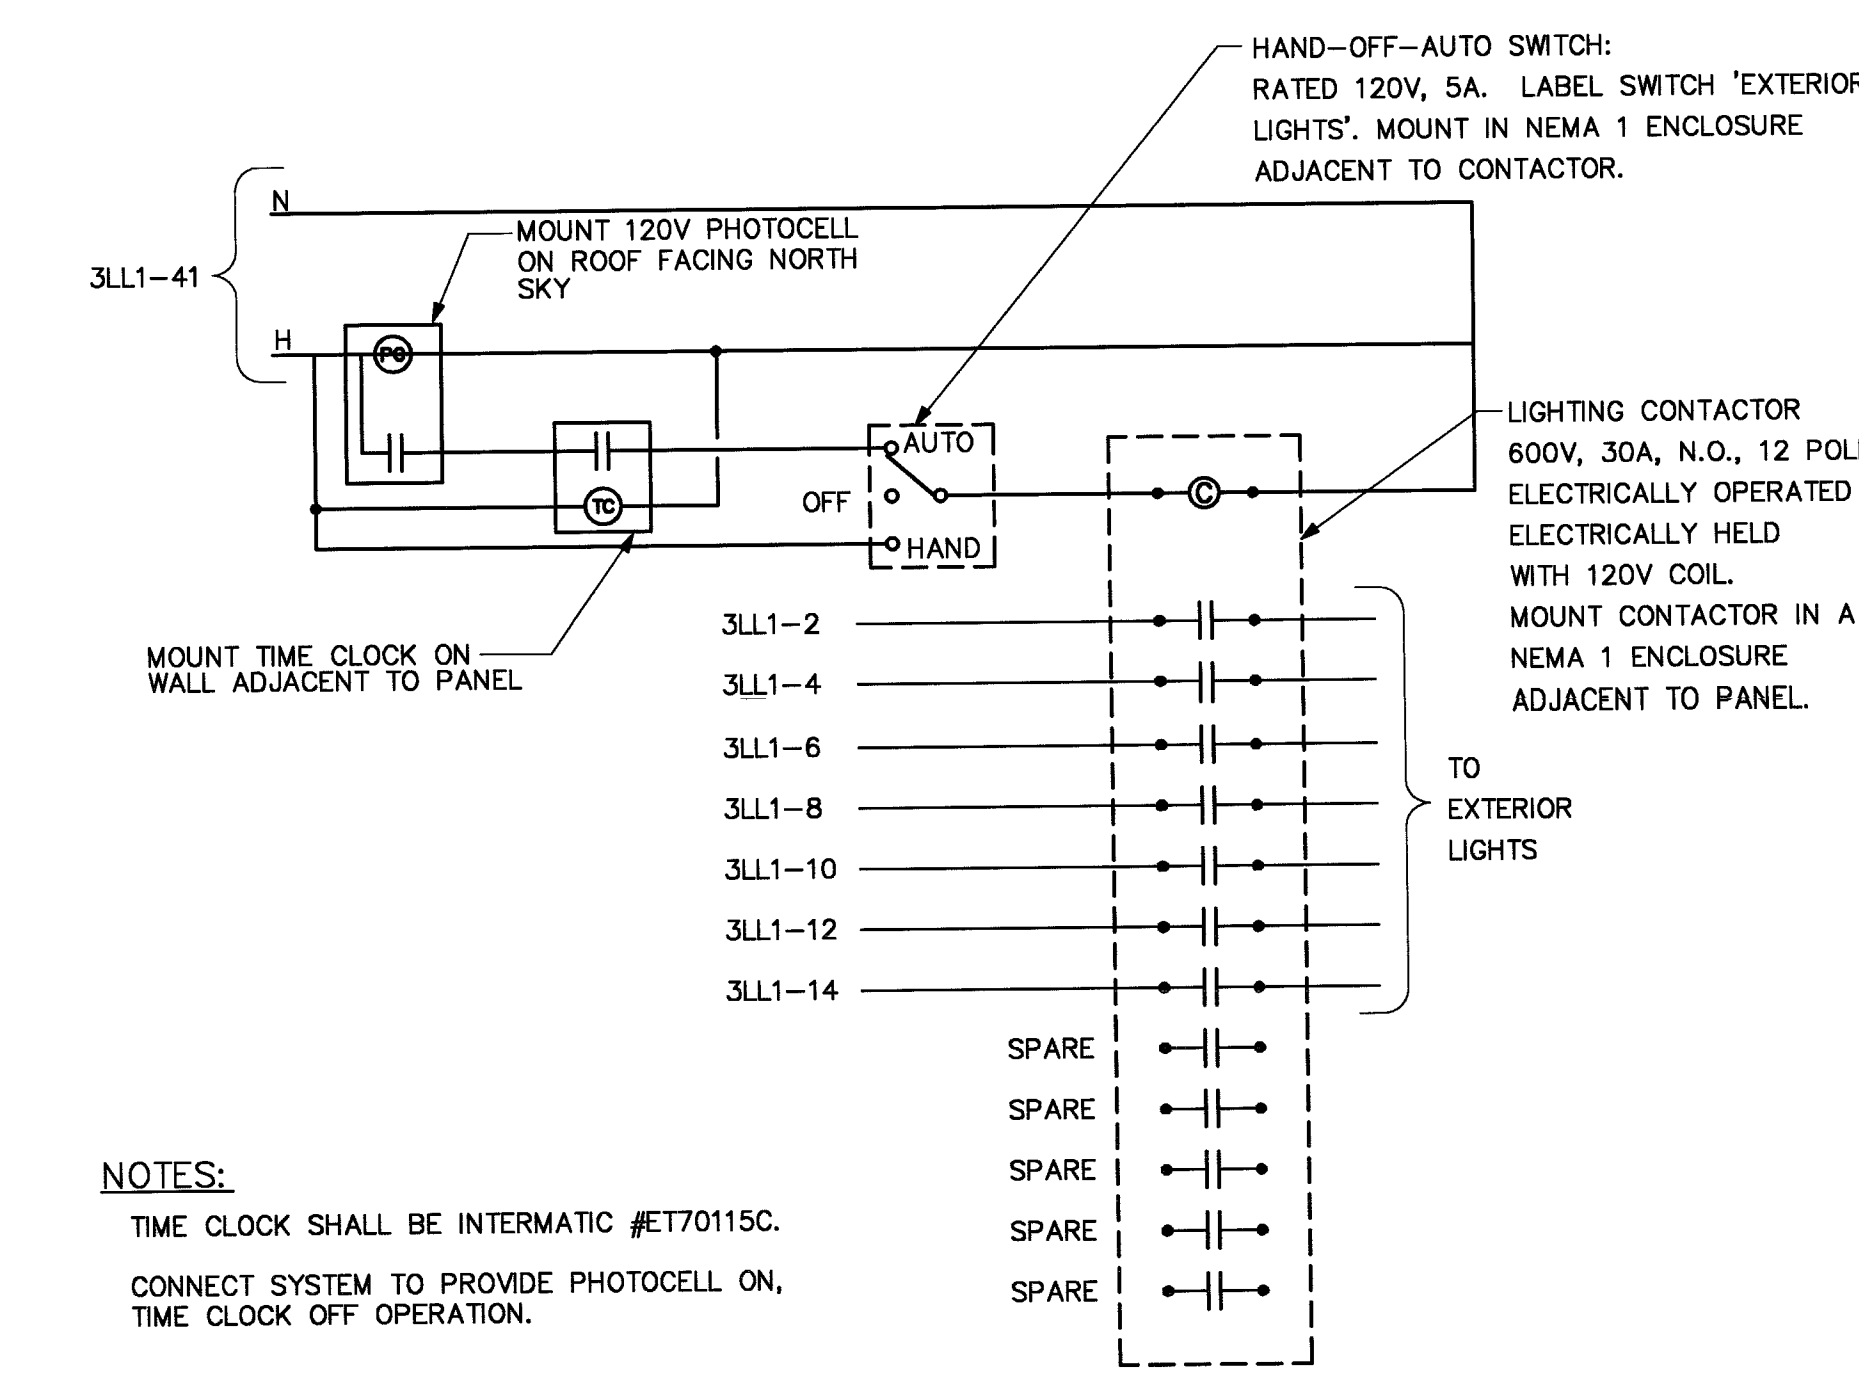

EXTERIOR WIRING SCHEMATIC
NO SCALE

RECORD DRAWINGS
Date: 01/26/08 The record drawing has been prepared in part, based upon information furnished by others. While this information is believed to be reliable, Harris Consulting Engineers LLC cannot assure its accuracy, and is not responsible for the accuracy of this record drawing or for any errors or omissions which may have been incorporated into it as a result. Those relying on this record drawing are advised to obtain independent verification of its accuracy before applying it for any purpose.

HARRIS CONSULTING ENGINEERS, LLC
1700 West Sahara, Suite 400, Las Vegas, Nevada 89103
Tel: 702/229-1000 Fax: 702/229-1004

PROJECT NO: 23154.30
DESIGNED BY: S. PAY
CHECKED BY: R. WHISENHUNT
DRAWN BY: R. PUERNER
PM: G. GOINS

JMA ARCHITECTURE STUDIOS
10155 CONVENT CROSS DRIVE LAS VEGAS, NEVADA 89123 (702) 731-0003

**CITY OF LAS VEGAS
DOWNTOWN SENIOR SERVICES CENTER
NEIGHBORHOOD SERVICES**

RECORD SET

**OWNER: CITY OF LAS VEGAS
DEPARTMENT OF PUBLIC WORKS
ARCHITECTURAL SERVICES**

400 EAST STEWART AVENUE
LAS VEGAS, NEVADA 89101
PHONE (702) 229-0535
FAX (702) 229-3035
TELE (702) 490-5100

**DRAWN: R. PUERNER
FILE: E2.03.DWG
DATE: September 8, 2004
SCALE: 3/16"=1'-0"
SHEET NO: 04.03.01
CLV Dwg NO: 001-281**

LIGHTING PLAN FLOOR 1
E2.03