



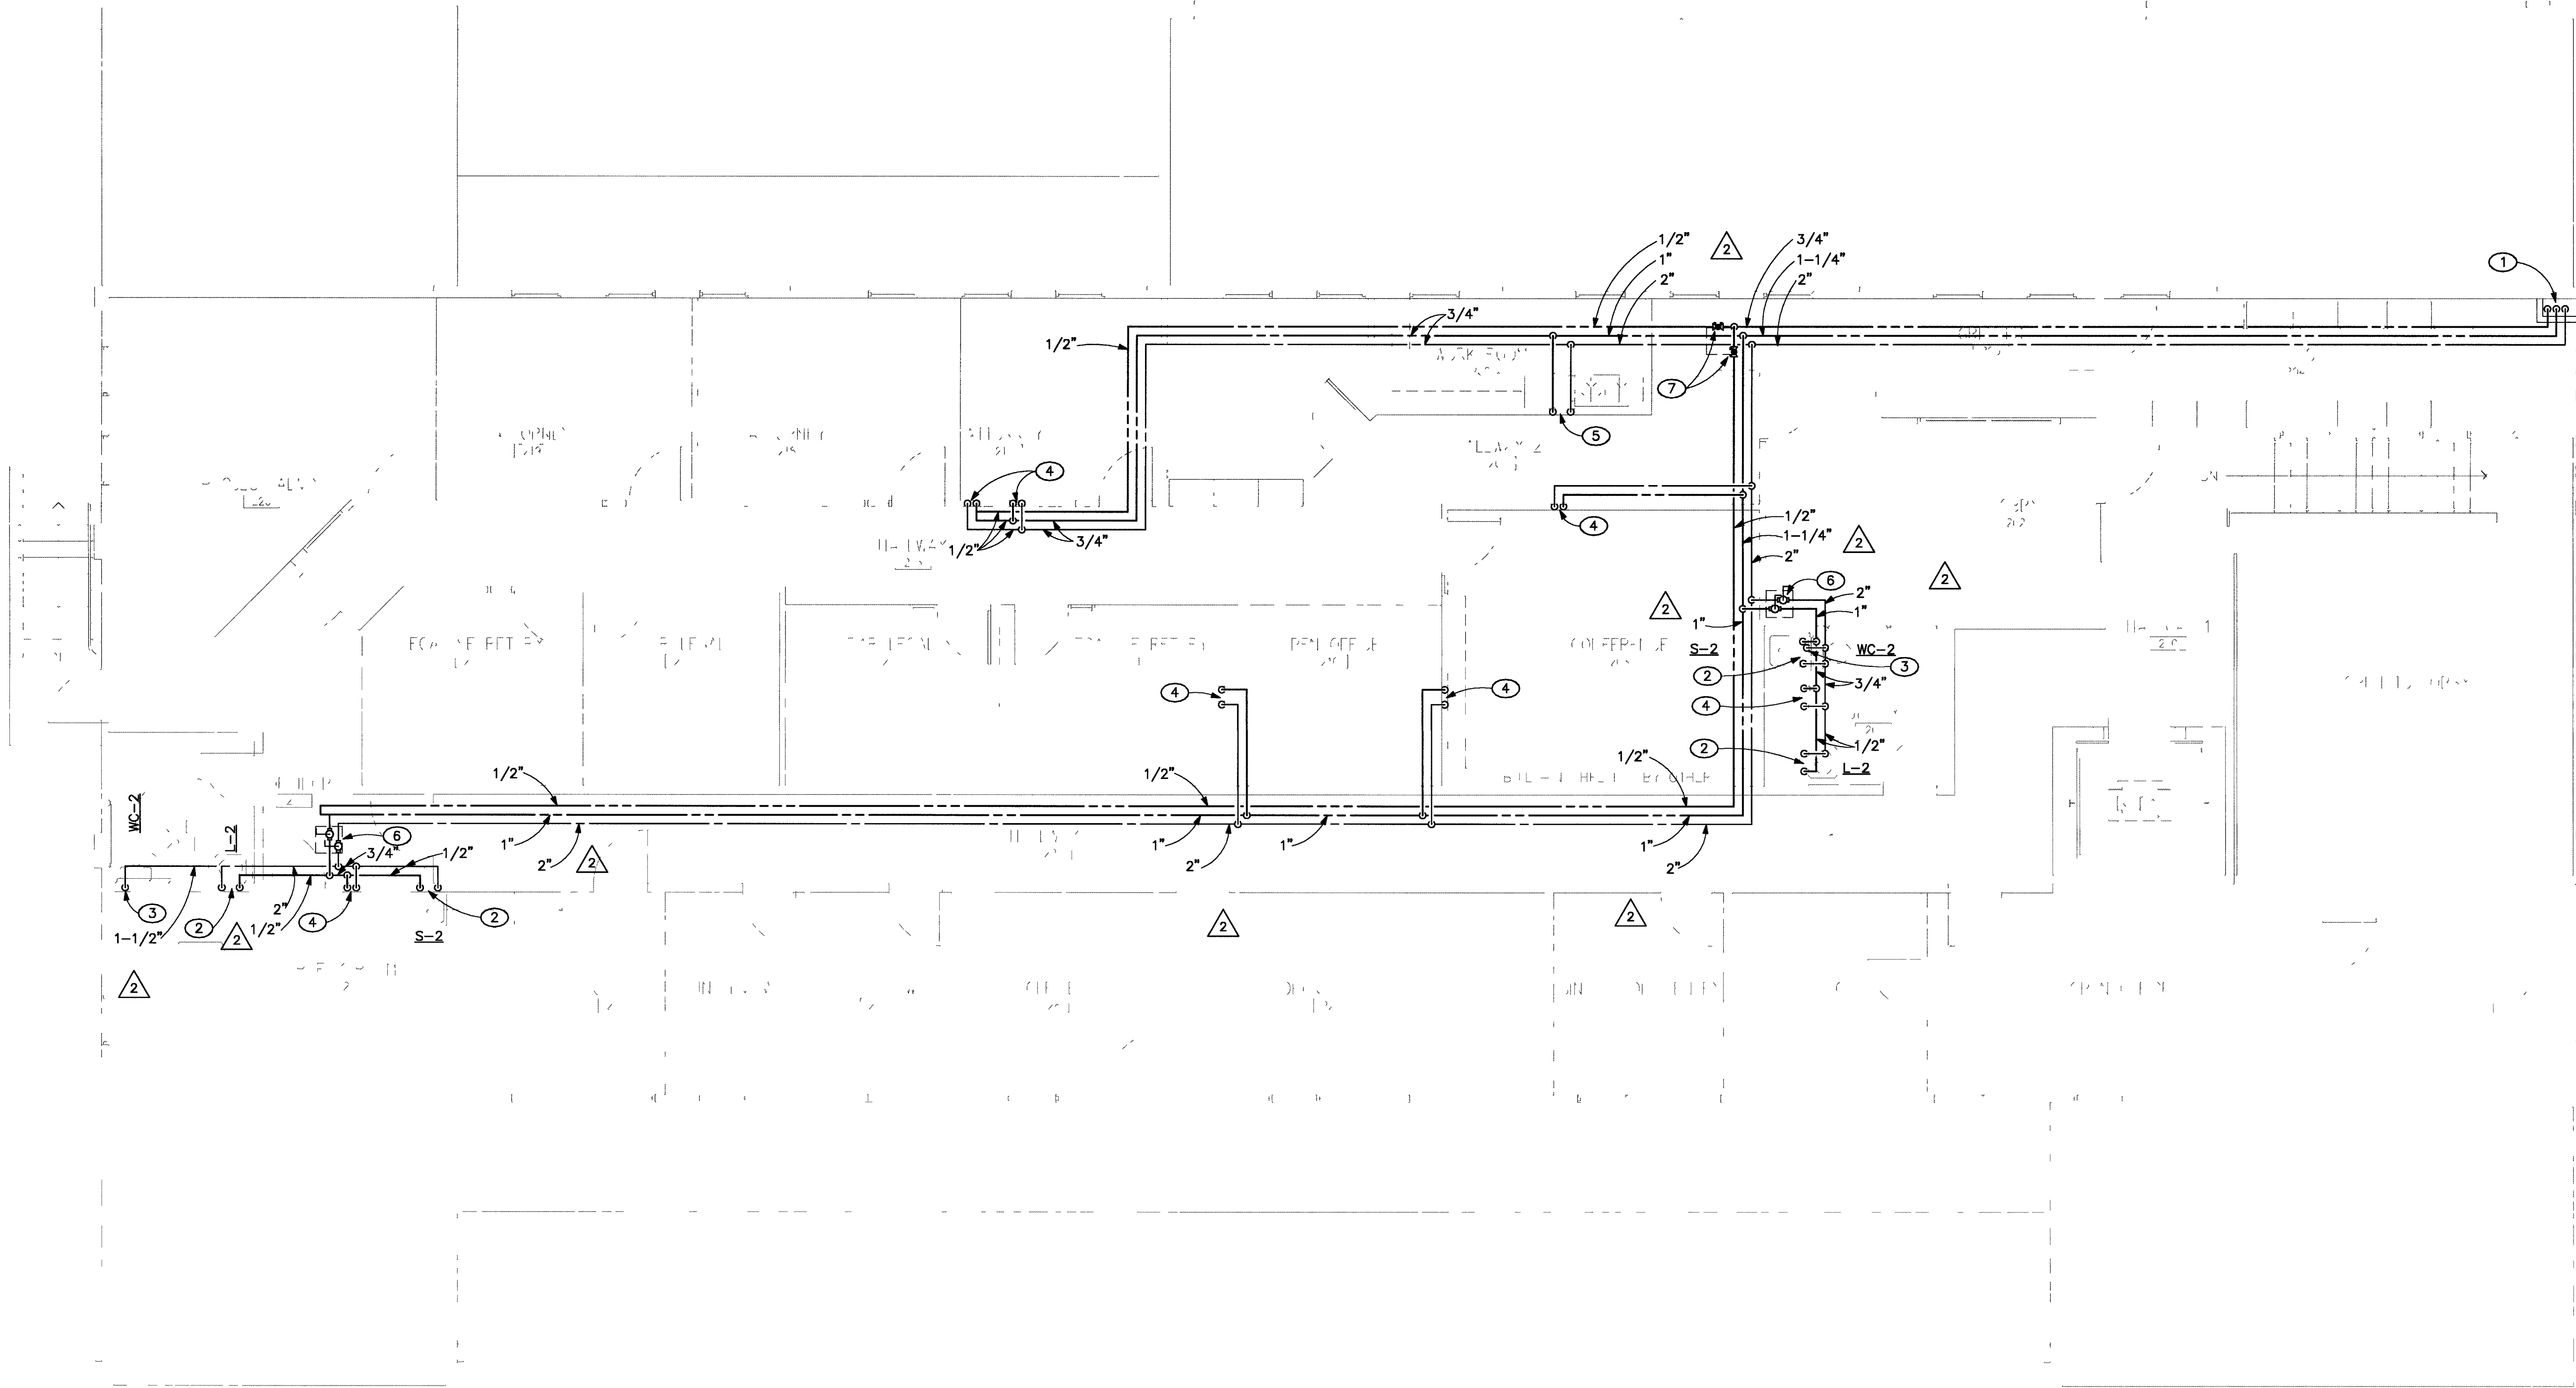

WATER SUPPLY PIPING PLAN BUILDING II LEVEL 2

SCALE: 3/16"=1'-0"

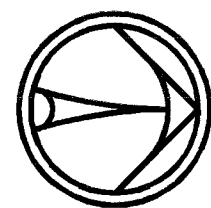

GENERAL NOTES

1. ALL DRAINAGE PIPING 3" AND SMALLER SHALL BE SLOPED AT 1/4" PER FOOT.
2. ALL DRAINAGE PIPING 4" AND LARGER SHALL BE SLOPED AT 1/8" PER FOOT.
3. ALL CONDENSATE DRAINAGE (CD) PIPING SHALL BE SLOPED AT 1/8" PER FOOT.
4. ALL STORM DRAIN (SD) AND OVERFLOW STORM DRAIN (OSD) PIPING SHALL BE SLOPED AT 1/8" PER FOOT.
5. NO PIPING SHALL BE DIRECTLY EMBEDDED IN CONCRET OR MASONRY WALLS.
6. THE CUTTING, NOTCHING AND BORING OF HOLES IN FLOOR JOISTS AND WALL STUDS SHALL BE IN ACCORDANCE WITH THE UNIFORM BUILDING CODE 1997 EDITION, VOLUME NO. 2, CHAPTER 23, SECTION 2320.

SHEET NOTES

1. 2" COLD WATER, 1-1/4" HOT WATER, AND 3/4" HOT WATER RETURN UP FROM LEVEL 1.
2. 1/2" HOT AND COLD WATER DOWN.
3. 1-1/2" COLD WATER DOWN.
4. 1/2" HOT AND COLD WATER DOWN TO LEVEL 1.
5. 2" COLD WATER AND 3/4" HOT WATER DOWN TO LEVEL 1.
6. SHUT OFF VALVES ABOVE CEILING WITH ACCESS PANEL TO MATCH CEILING CONSTRUCTION.
7. NIBICO GLOBE STYLE BALANCING VALVE MODEL NO. S1710-1/2", SET FOR 0.5 GPM ABOVE CEILING WITH ACCESS PANEL TO MATCH CEILING CONSTRUCTION.

RECORD DRAWINGS
Date: 01/25/08 This record drawing has been prepared in part, based upon information furnished by others. While this information is believed to be reliable, Harris Consulting Engineers LLC cannot assure its accuracy, and is not responsible for the accuracy of this record drawing or for any errors or omissions which may have been incorporated into it as a result. Those relying on this record drawing are advised to obtain independent verification of its accuracy before applying it for any purpose.

PROJECT NO: 23154.30
DESIGNED BY: A. DeBUES
CHECKED BY: D.S. HARRIS
DRAWN BY: C. SADLER
PM: J. HEAL

REVISIONS
2 6-23-04 PLAN CHECK
20 01-25-08 RECORD DRAWING

CONSULTANT
JMA ARCHITECTURE STUDIOS
LAS VEGAS, NEVADA 89144 (702) 732-1233
10155 CONINGTON CROSS DRIVE

CITY OF LAS VEGAS
DOWNTOWN SENIOR SERVICES CENTER
NEIGHBORHOOD SERVICES

RECORD SET

OWNER: CITY OF LAS VEGAS
DEPARTMENT OF PUBLIC WORKS
ARCHITECTURAL SERVICES
480 EAST STEWART AVENUE
LAS VEGAS, NEVADA 89101
PHONE: (702) 228-1636
FAX: (702) 382-0332
TDD: (702) 388-6100

DESIGN
FILE C&S
DATE September 8, 2004
SCALE NO SCALE
SHEET NO 04B3421
PROJECT NO 501-281
WATER SUPPLY PIPING
PLAN LEVEL 2

P3.02

95967