


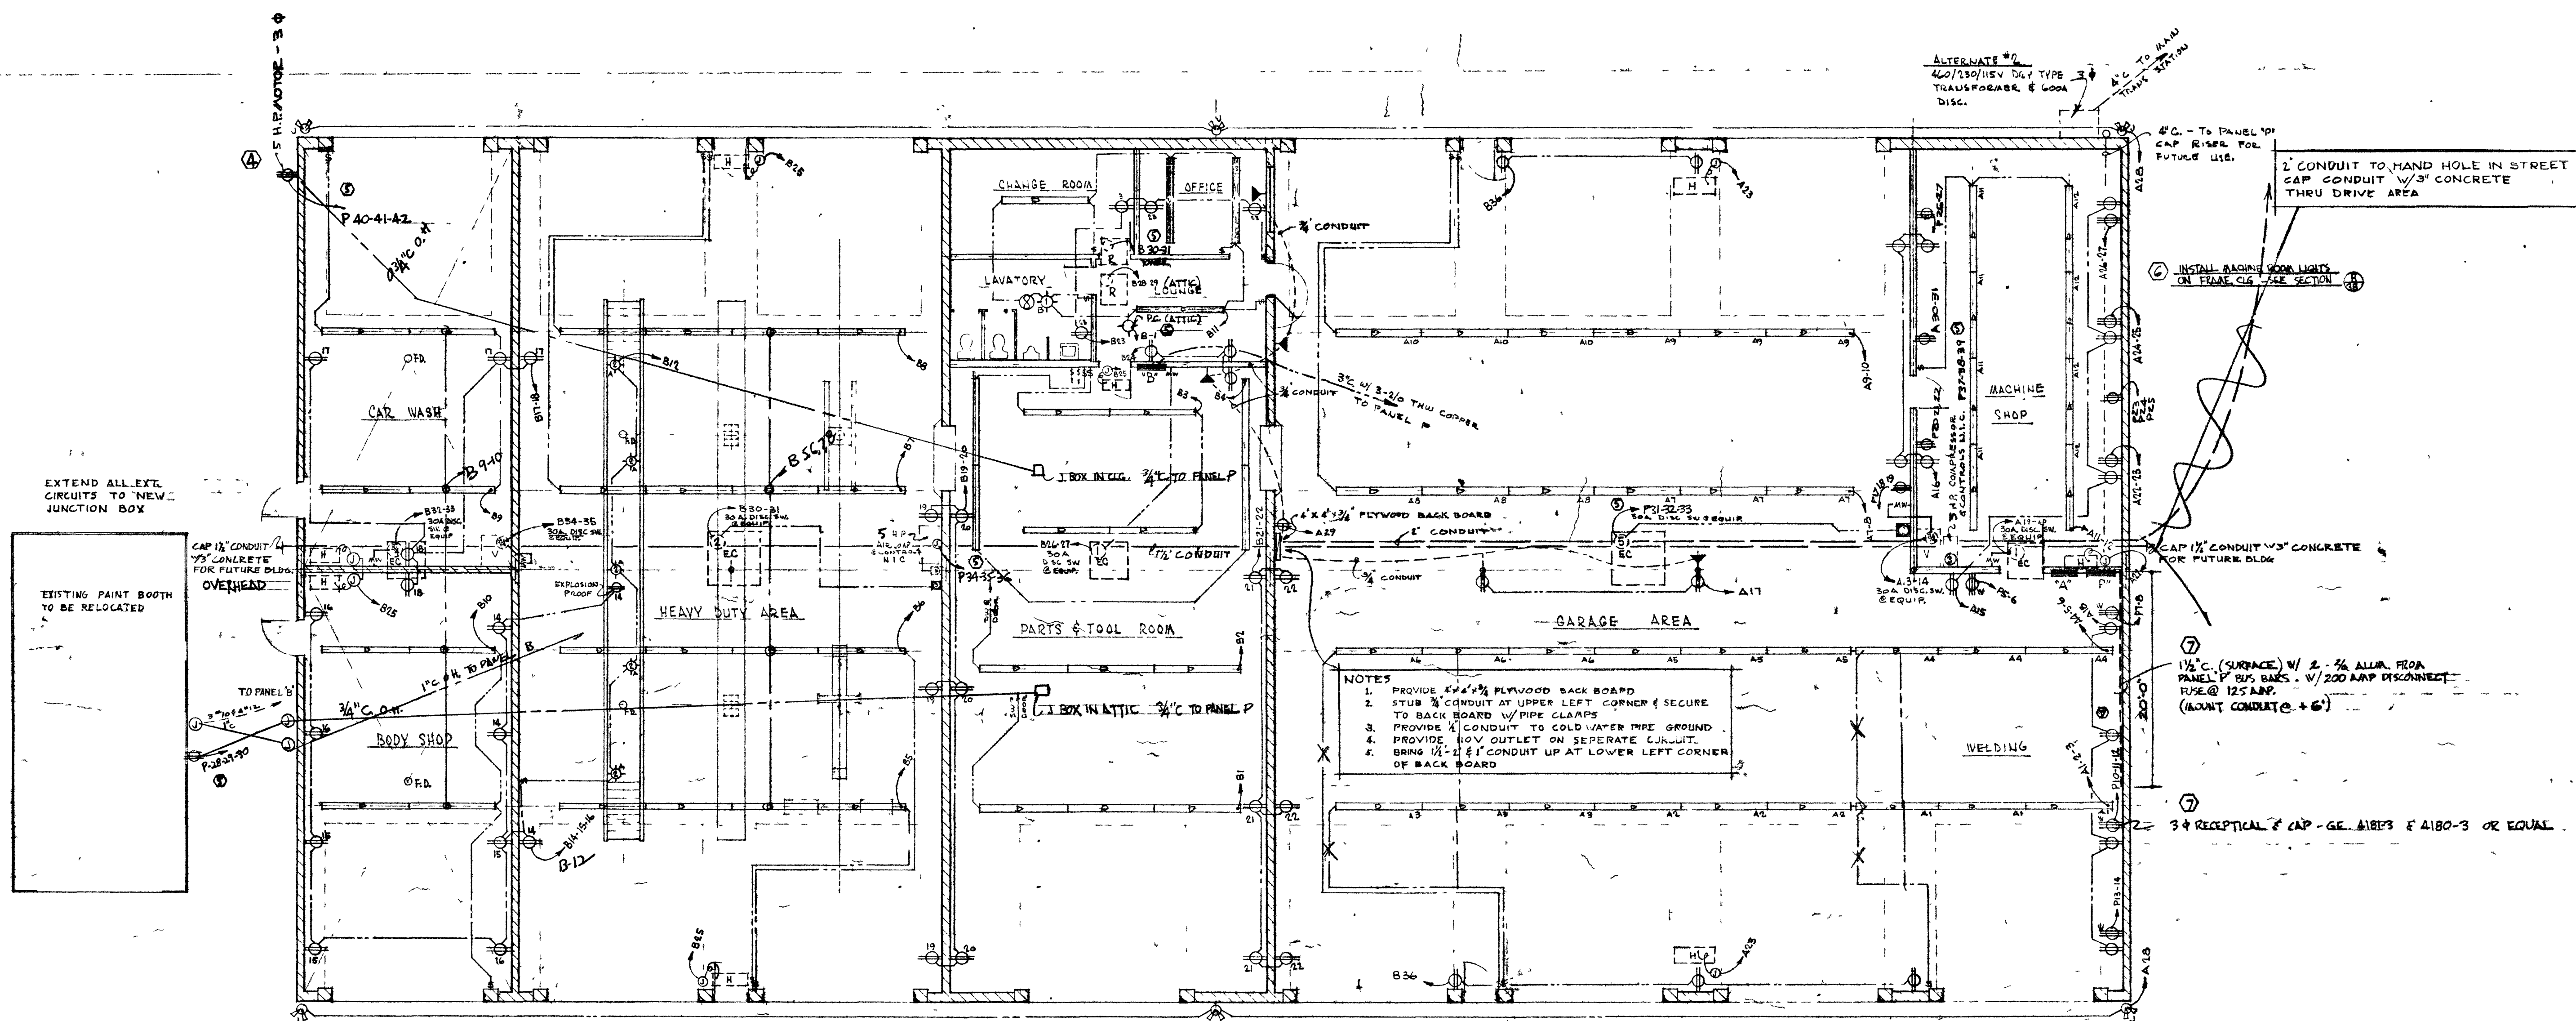

NOTES
 1. PROVIDE 4" X 4" PLYWOOD BACK BOARD
 2. STUB 3/4" CONDUIT AT UPPER LEFT CORNER & SECURE TO BACK BOARD W/ PIPE CLAMPS
 3. PROVIDE 1/2" CONDUIT TO COLD WATER PIPE GROUND
 4. PROVIDE 10V OUTLET ON SEPARATE CIRCUIT
 5. BRING 1/2" X 1/2" CONDUIT UP AT LOWER LEFT CORNER OF BACK BOARD


LEGEND

- ⊕ DUPLEX CONVENIENCE OUTLET - 5A. - 115V. - 1φ
- ⊕ POWER OUTLET A - 230V. - 1φ
- ⊕ WELDER OUTLET A - 230V. - 1φ
- ⊕ SURFACE MOUNT CEILING FIXTURE - 100W. - 115V. - 1φ
- ⊕ RECESSED HWY. DUTY FIXTURE - 100W. - 115V. - 1φ - EXPLOSION PROOF
- ⊕ EXHAUST FAN - 115V. - 1φ
- ⊕ TELEPHONE OUTLET
- 4 LAMP 36" SLIA LINE, SURFACE MOUNT, FLUORESCENT FIXTURE.
- 4 LAMP 36" SLIA LINE, FLUORESCENT FIXTURE 7' PLASTIC PIPES
- ⊕ GAS FIRED SPACE HTR. SUSP FROM CLG. - 1/4 HP FAN MOTOR.
- ⊕ TENTHOUSE VENTILATOR - H.P. AS INDICATED
- ⊕ ROOF MOUNTED EVAPORATIVE COOLER - H.P. AS INDICATED
- ⊕ ROOF MOUNTED REFRIGERATION A/C UNIT - H.P. AS INDICATED
- MOTOR WATCHMAN MOTOR CONTROL
- ⊕ MOTOR STARTER

REVISIONS	
1	11 APRIL 66
2	ADDED A-10
3	26 MAY 66
4	ADD 30 OUTLETS
5	REVISE PANELS
6	REVISE CIRCUITS
7	REVISE WELDER OUTLETS - 110V
8	
DATE 3-15-66	
DRAWN BY A K D	
CHECKED BY	
SHEET TITLE ELECTRICAL PLAN	
BUILDING "B"	
JOB TITLE CITY YARD FACILITIES	
FOR THE CITY OF LAS VEGAS, NEVADA	
217 GARCES AVE. 305-1464	
JOB NO. 6510	
SHEET 12 B	
OF 30 TOTAL	
522-29	

AS BUILT DRAWING AS SUBMITTED BY CONTRACTOR

9405

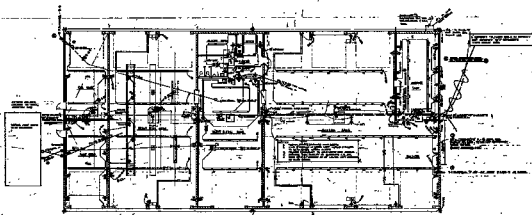

1. 1st Floor Plan
2. 2nd Floor Plan
3. 3rd Floor Plan
4. 4th Floor Plan
5. 5th Floor Plan
6. 6th Floor Plan
7. 7th Floor Plan
8. 8th Floor Plan
9. 9th Floor Plan
10. 10th Floor Plan

- LEGEND**
- 1. 1st Floor Plan
 - 2. 2nd Floor Plan
 - 3. 3rd Floor Plan
 - 4. 4th Floor Plan
 - 5. 5th Floor Plan
 - 6. 6th Floor Plan
 - 7. 7th Floor Plan
 - 8. 8th Floor Plan
 - 9. 9th Floor Plan
 - 10. 10th Floor Plan

AS BUILT