



REVISIONS	
1	11 APRIL 66
2	5/6/66
3	18 MAY 66
4	20 MAY 66
5	2 JUNE 66
6	9-28-66
7	11-28-66
8	12-16-66
9	3-15-66
DRAWN BY AKP	
CHECKED BY	

JACK T. Belcher
 217 GARCES AVE.
 LAS VEGAS, NEVADA
 ELECTRICAL PLAN
 BUILDING "A"
 CITY YARD FACILITIES FOR THE CITY OF LAS VEGAS, NEVADA

JOB
6510
 SHEET
12A
 OF 30 TOTAL

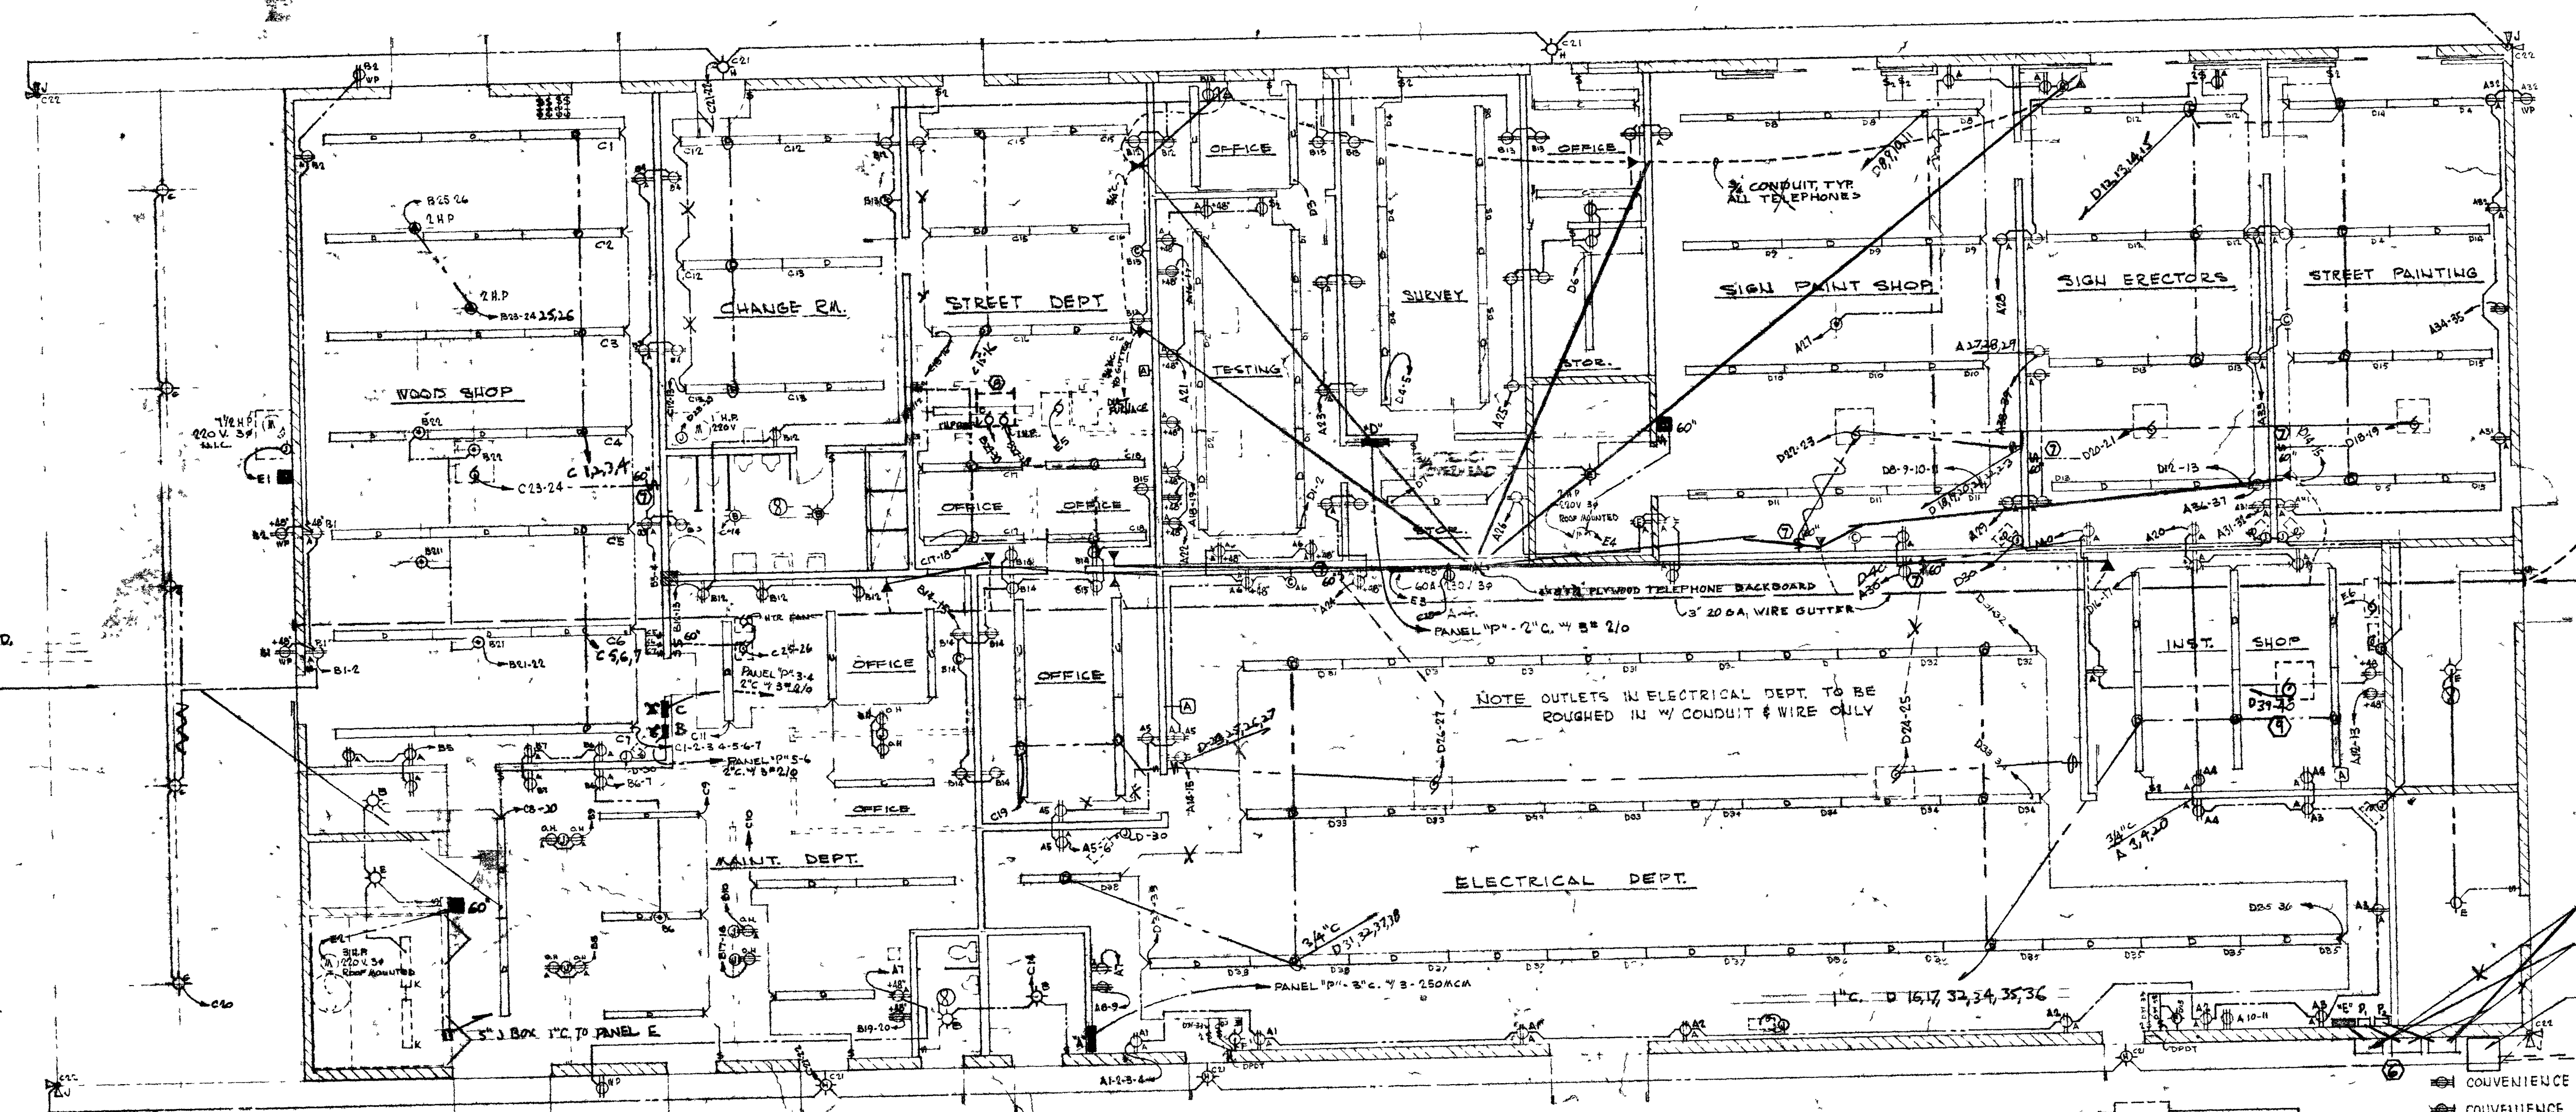


1" HANDHOLE
 1" STREET
 1/2" CONDUIT
 1/4" CONCRETE

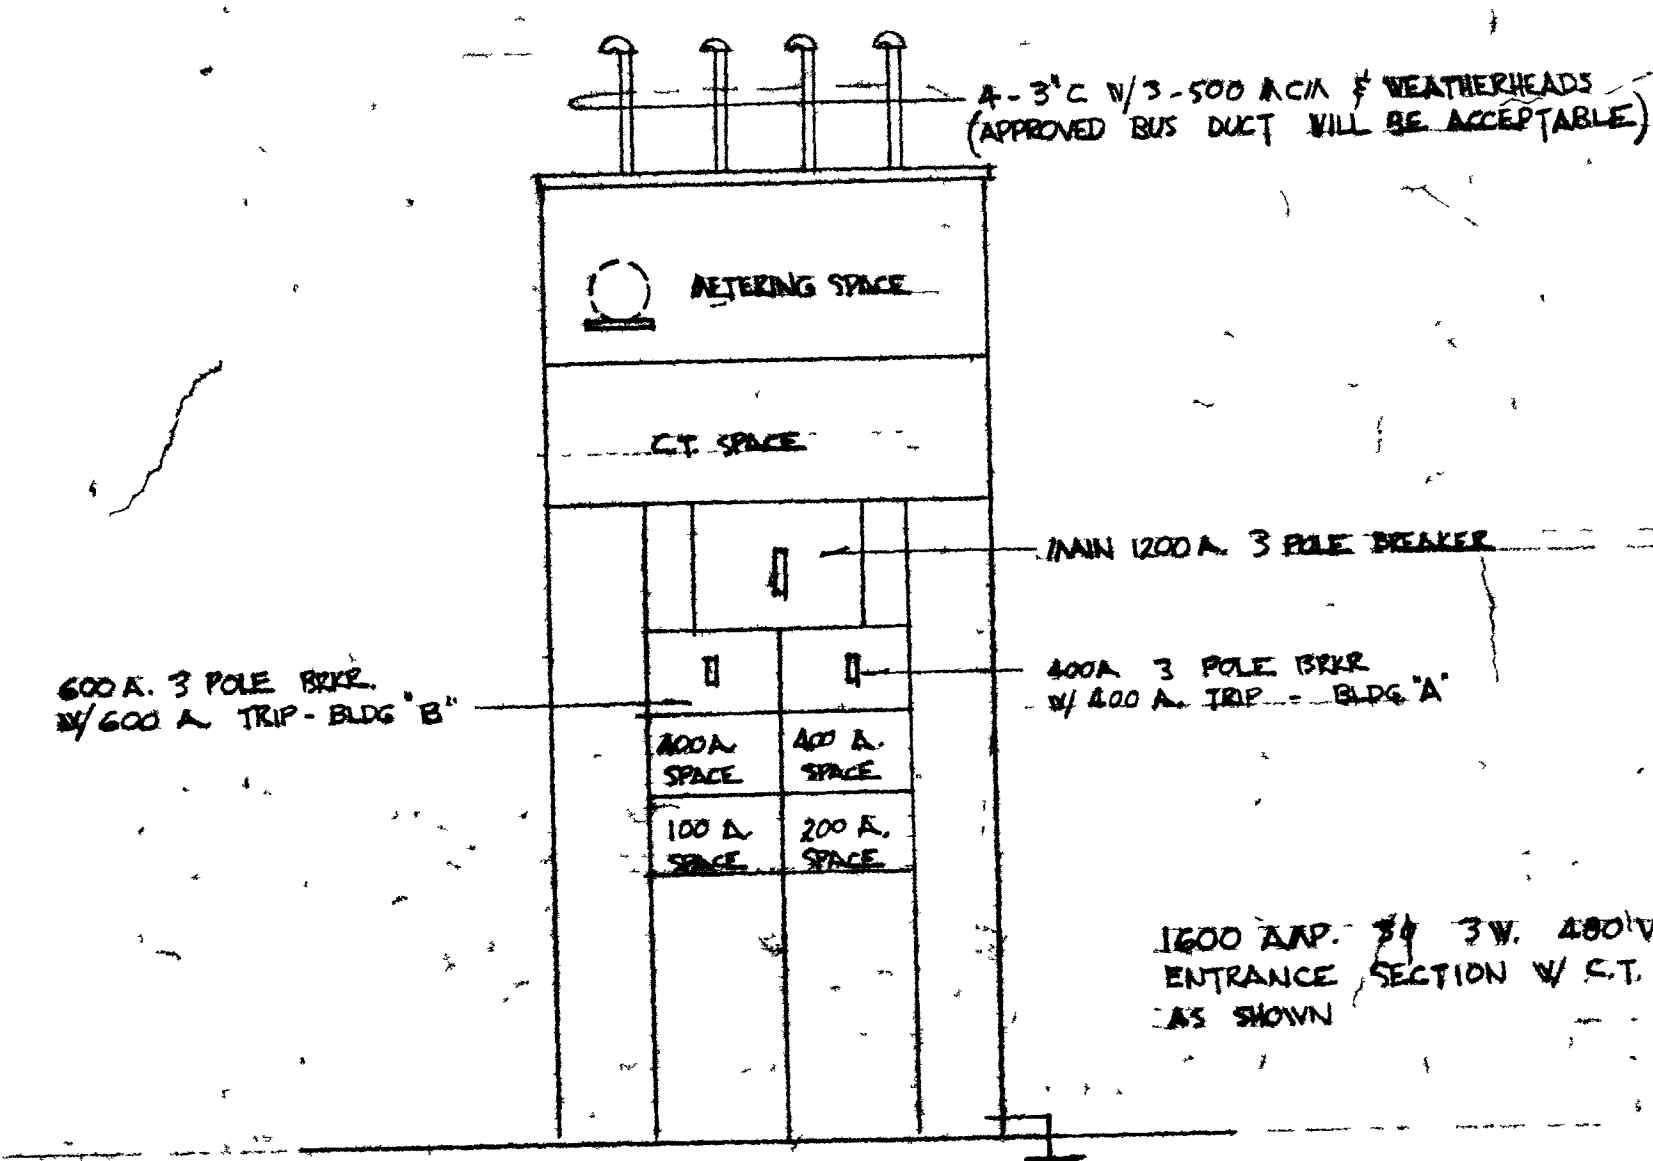


METERING SECTION

NOTE: ALL LIGHT BULBS & FLUORESCENT TUBES TO BE FURNISHED & INSTALLED BY OWNER.
 SEE HEATING, VENTILATING, & AIR COND. DRAWINGS FOR EQUIP. LOCATIONS & LOADS.
 ALL RUNS FROM GUTTER TO INDIVIDUAL PHONE OUTLETS TO BE 1/2" EMT CONDUIT

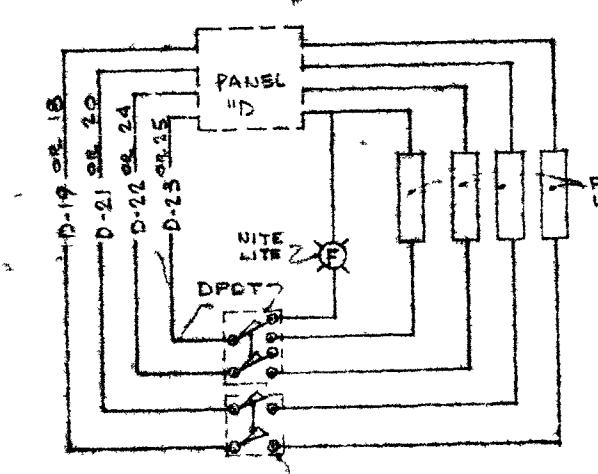

TYPICAL SWITCH SCHEMATIC
ELECT. DEPT. (W/ NITE LITE)

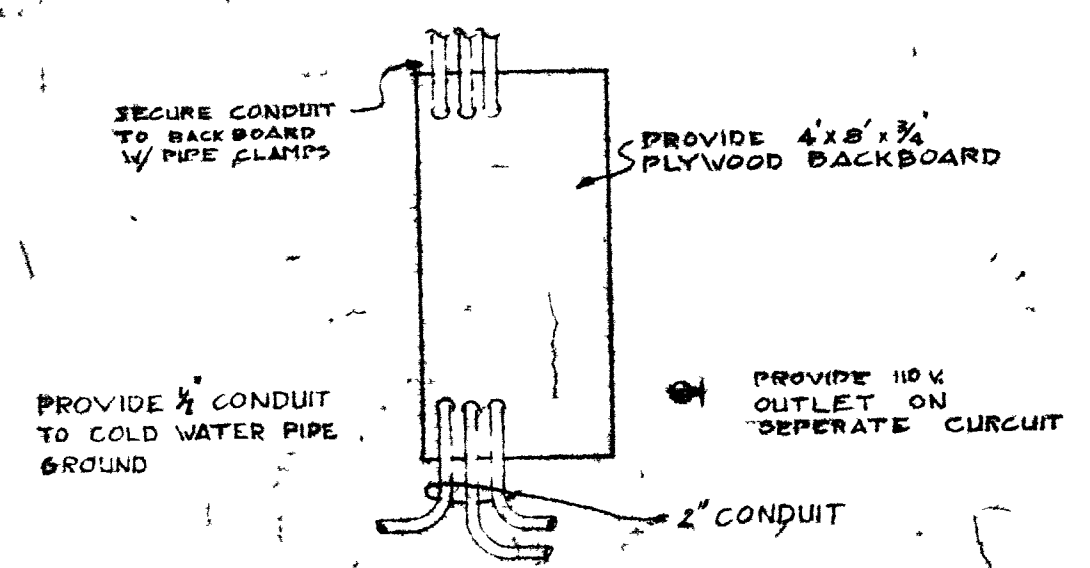

- ① CONVENIENCE OUTLET - H.D. 60A - 230V. 1φ (UNLESS NOTED)
- ② CONVENIENCE OUTLET - STD. 15A MIN. 115V. 1φ
- ③ " - H.D. - 5A MIN. 115V. 1φ
- ④ " - H.D. - 5A MIN. 115V. 1φ WEATHER TIGHT
- ⑤ " (H.D. OR STD.) (115V. OR 230V. 1φ) OVER HEAD MOUNTED.
- ⑥ JUNCTION BOX
- ⑦ CLOCK OUTLET - 115V. 1φ
- ⑧ TIME CLOCK OUTLET - 115V. 1φ
- ⑨ EXHAUST FAN - FRACTIONAL H.P. - 115V. 1φ
- ⑩ MOTOR LOAD - H.P. & VOLTAGE AS INDICATED - SEE MECHANICAL (1A-A)
- ⑪ TELEPHONE OUTLET
- ⑫ RADIO ANTENNA (1/4" CONDUIT FROM OUTLET TO ANTENNA LOCATION)
- ⑬ INCANDESCENT FIXTURE - 115V. 1φ - SURFACE MOUNT (SEE FIXTURE SCHED.)
- ⑭ " - 115V. 1φ - WALL MOUNT
- ⑮ AREA LIGHTING FLOOD - 115V. 1φ - ROOF MOUNTED 2 LAMP PAR. 30.
- ⑯ FLUORESCENT FIXTURE - 115V. 1φ - (SEE FIXTURE SCHED.)
- ⑰ SWITCH SPST
- ⑱ SWITCH DPST (FOR SWITCHING 2 CIRCUITS)
- ⑲ FLOOR OUTLET - H.D. - 5A MIN. - 115V. 1φ
- ⑳ FLOOR OUTLET - H.D. 60A - 230V. 1φ (MOTOR LOADS AS INDICATED)
- ㉑ SERVICE OUTLET - NP - 7A MIN. 115V. 1φ EXPLOSION PROOF
- ㉒ MOTOR STARTER 1/2 START-STOP SWITCH

AS BUILT

AS BUILT

522-29

