
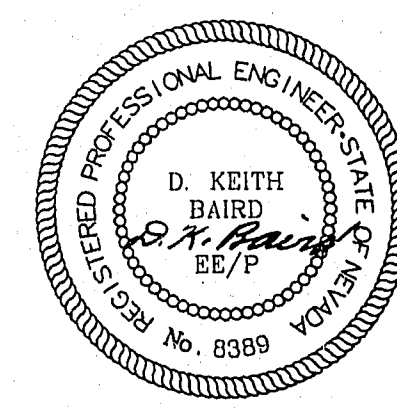


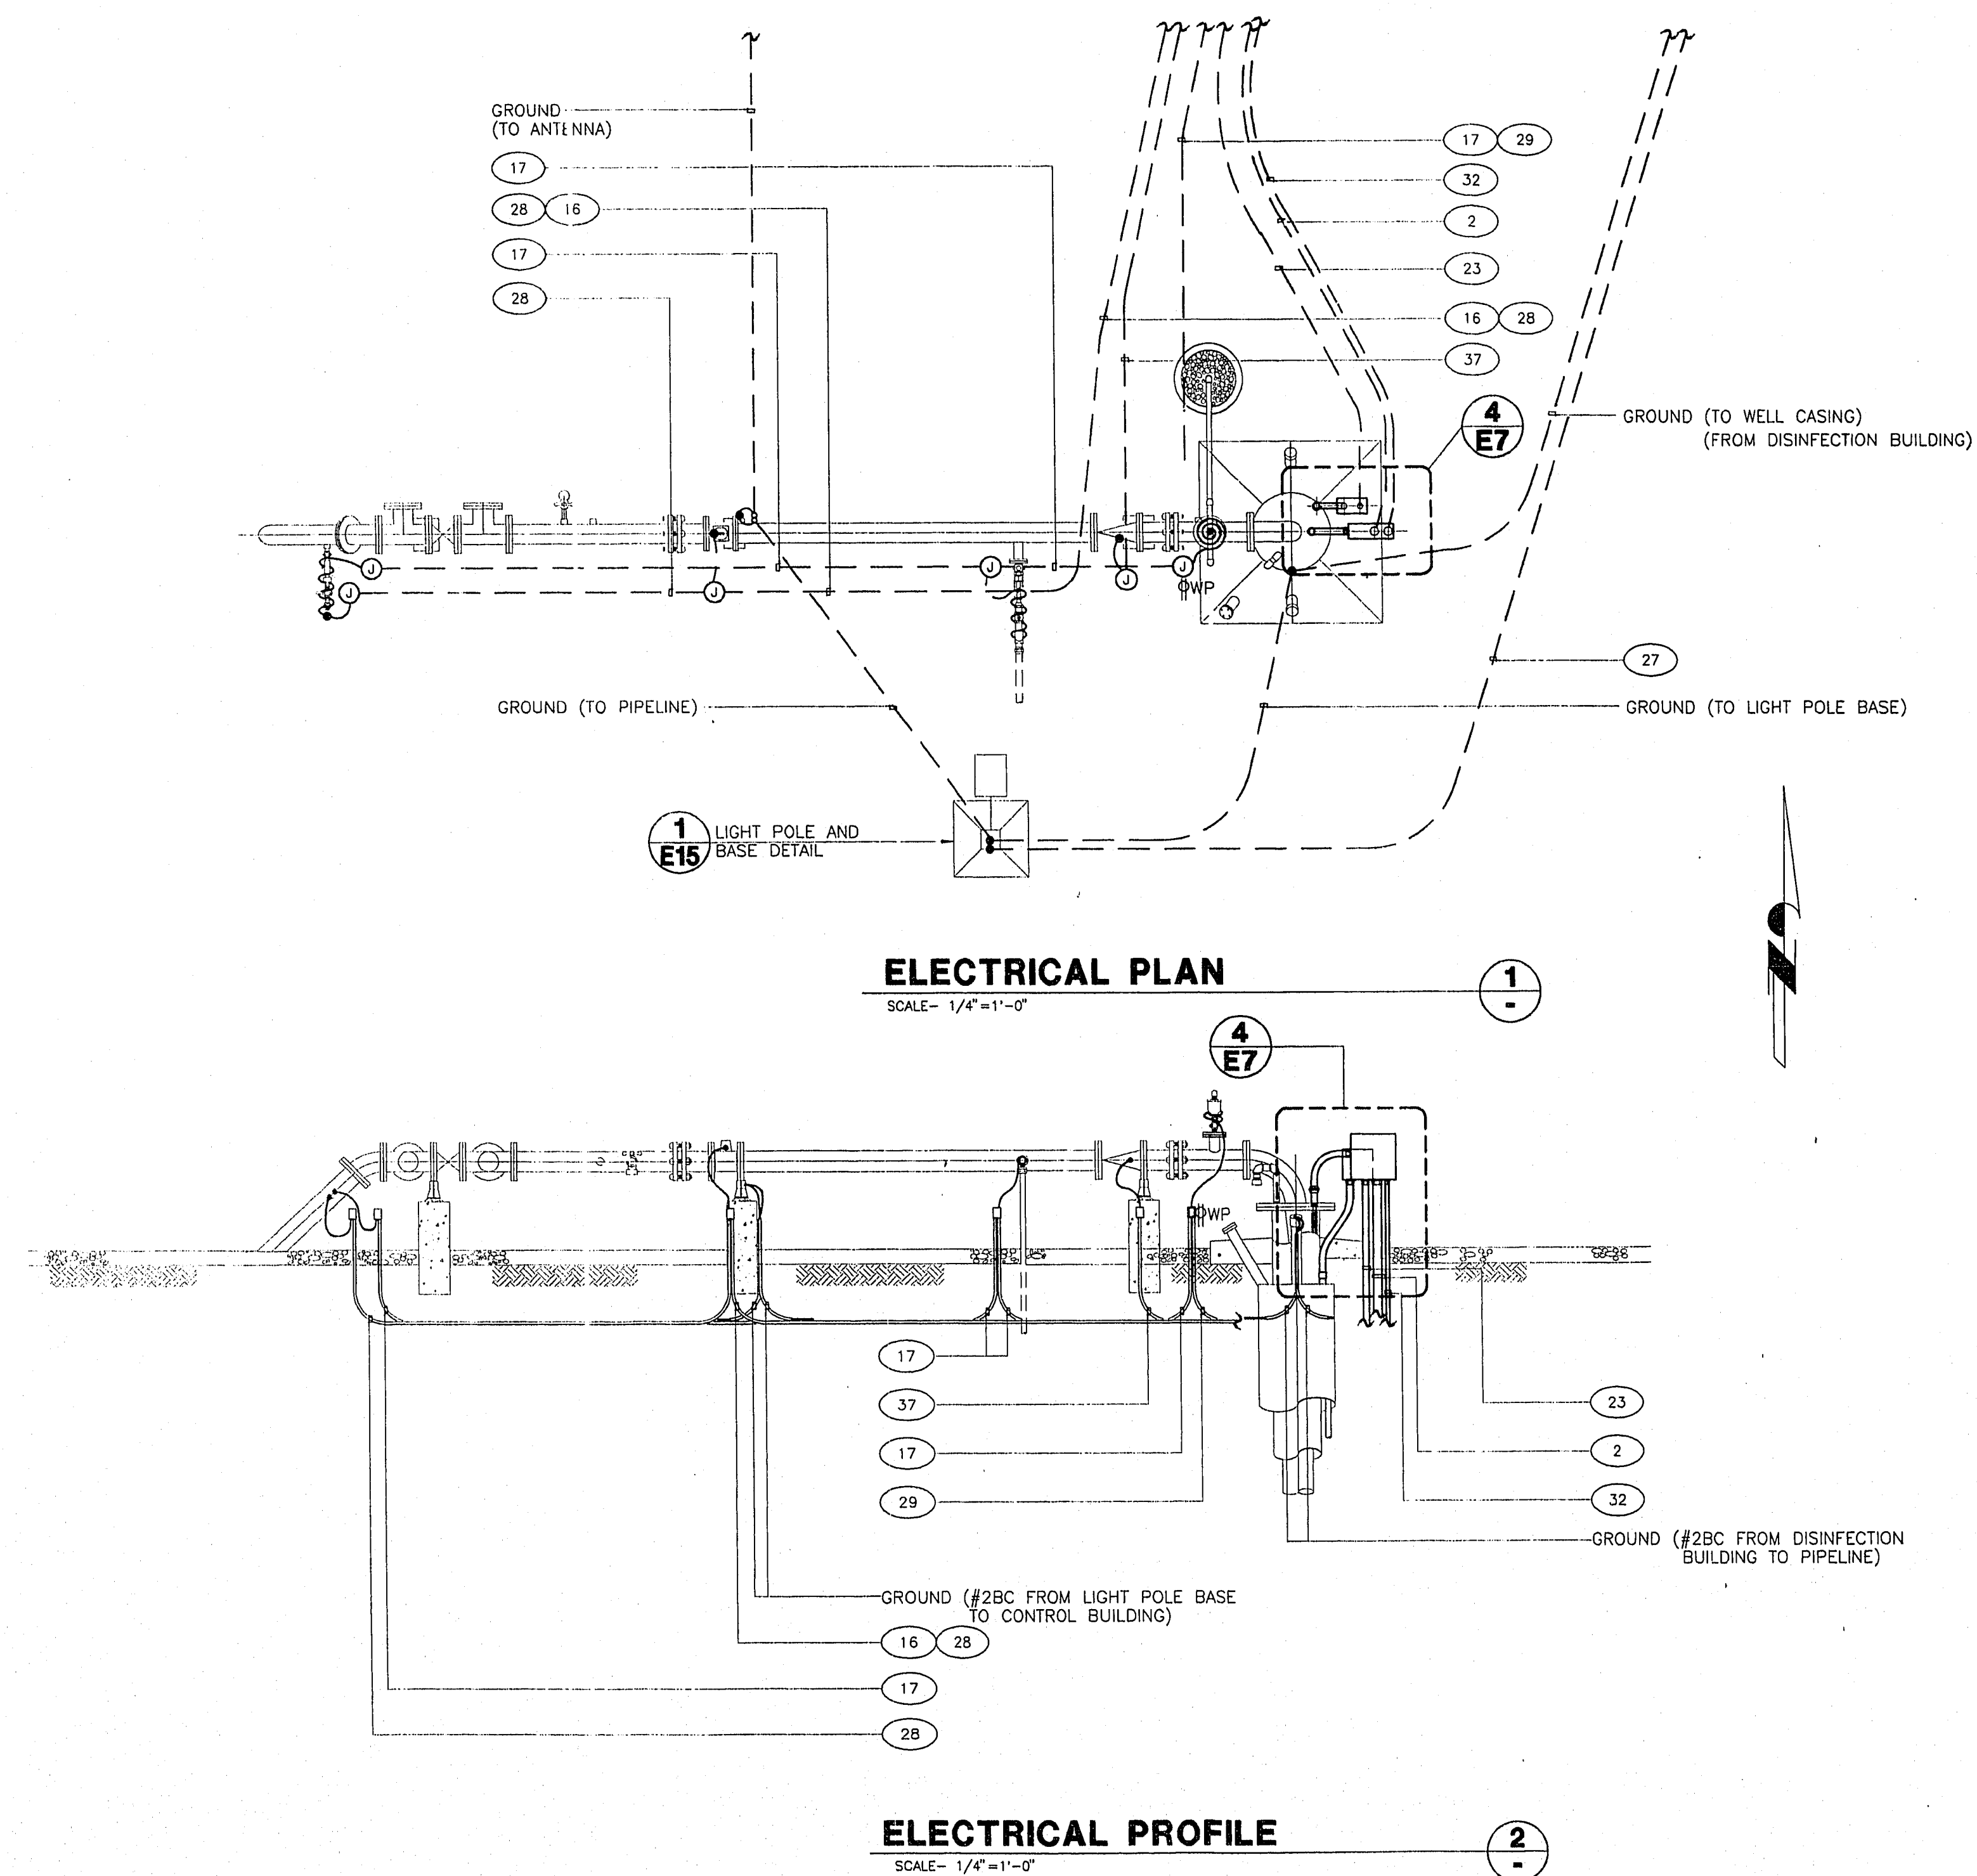

12-13-94

SCALE: HORIZ. 1" = 4' VERT. NONE	FILE NAME: C0717E12.DWG DATE: 08/01/94 DRAWN: J. E. SALDANA DATE: 08/01/94 CHECKED: D.K.B. DATE: 08/01/94	RECOMMENDED JAVIER O. ARCEO APPROVED D. Keith Baird D. KEITH BAIRD R.P.E. NO. 8389 DATE: 12-13-94
--	---	---

LAS VEGAS VALLEY WATER DISTRICT
3700 WEST CHARLESTON BOULEVARD
LAS VEGAS, NEVADA

EQUIP WELL No.s 96 AND 97
WELL No. 97 ELECTRICAL PLAN,
PROFILE AT WELL SITE

DRAWING NUMBER
717
REF. SHEET NO. E12
SHEET 28 OF 32

716-716