
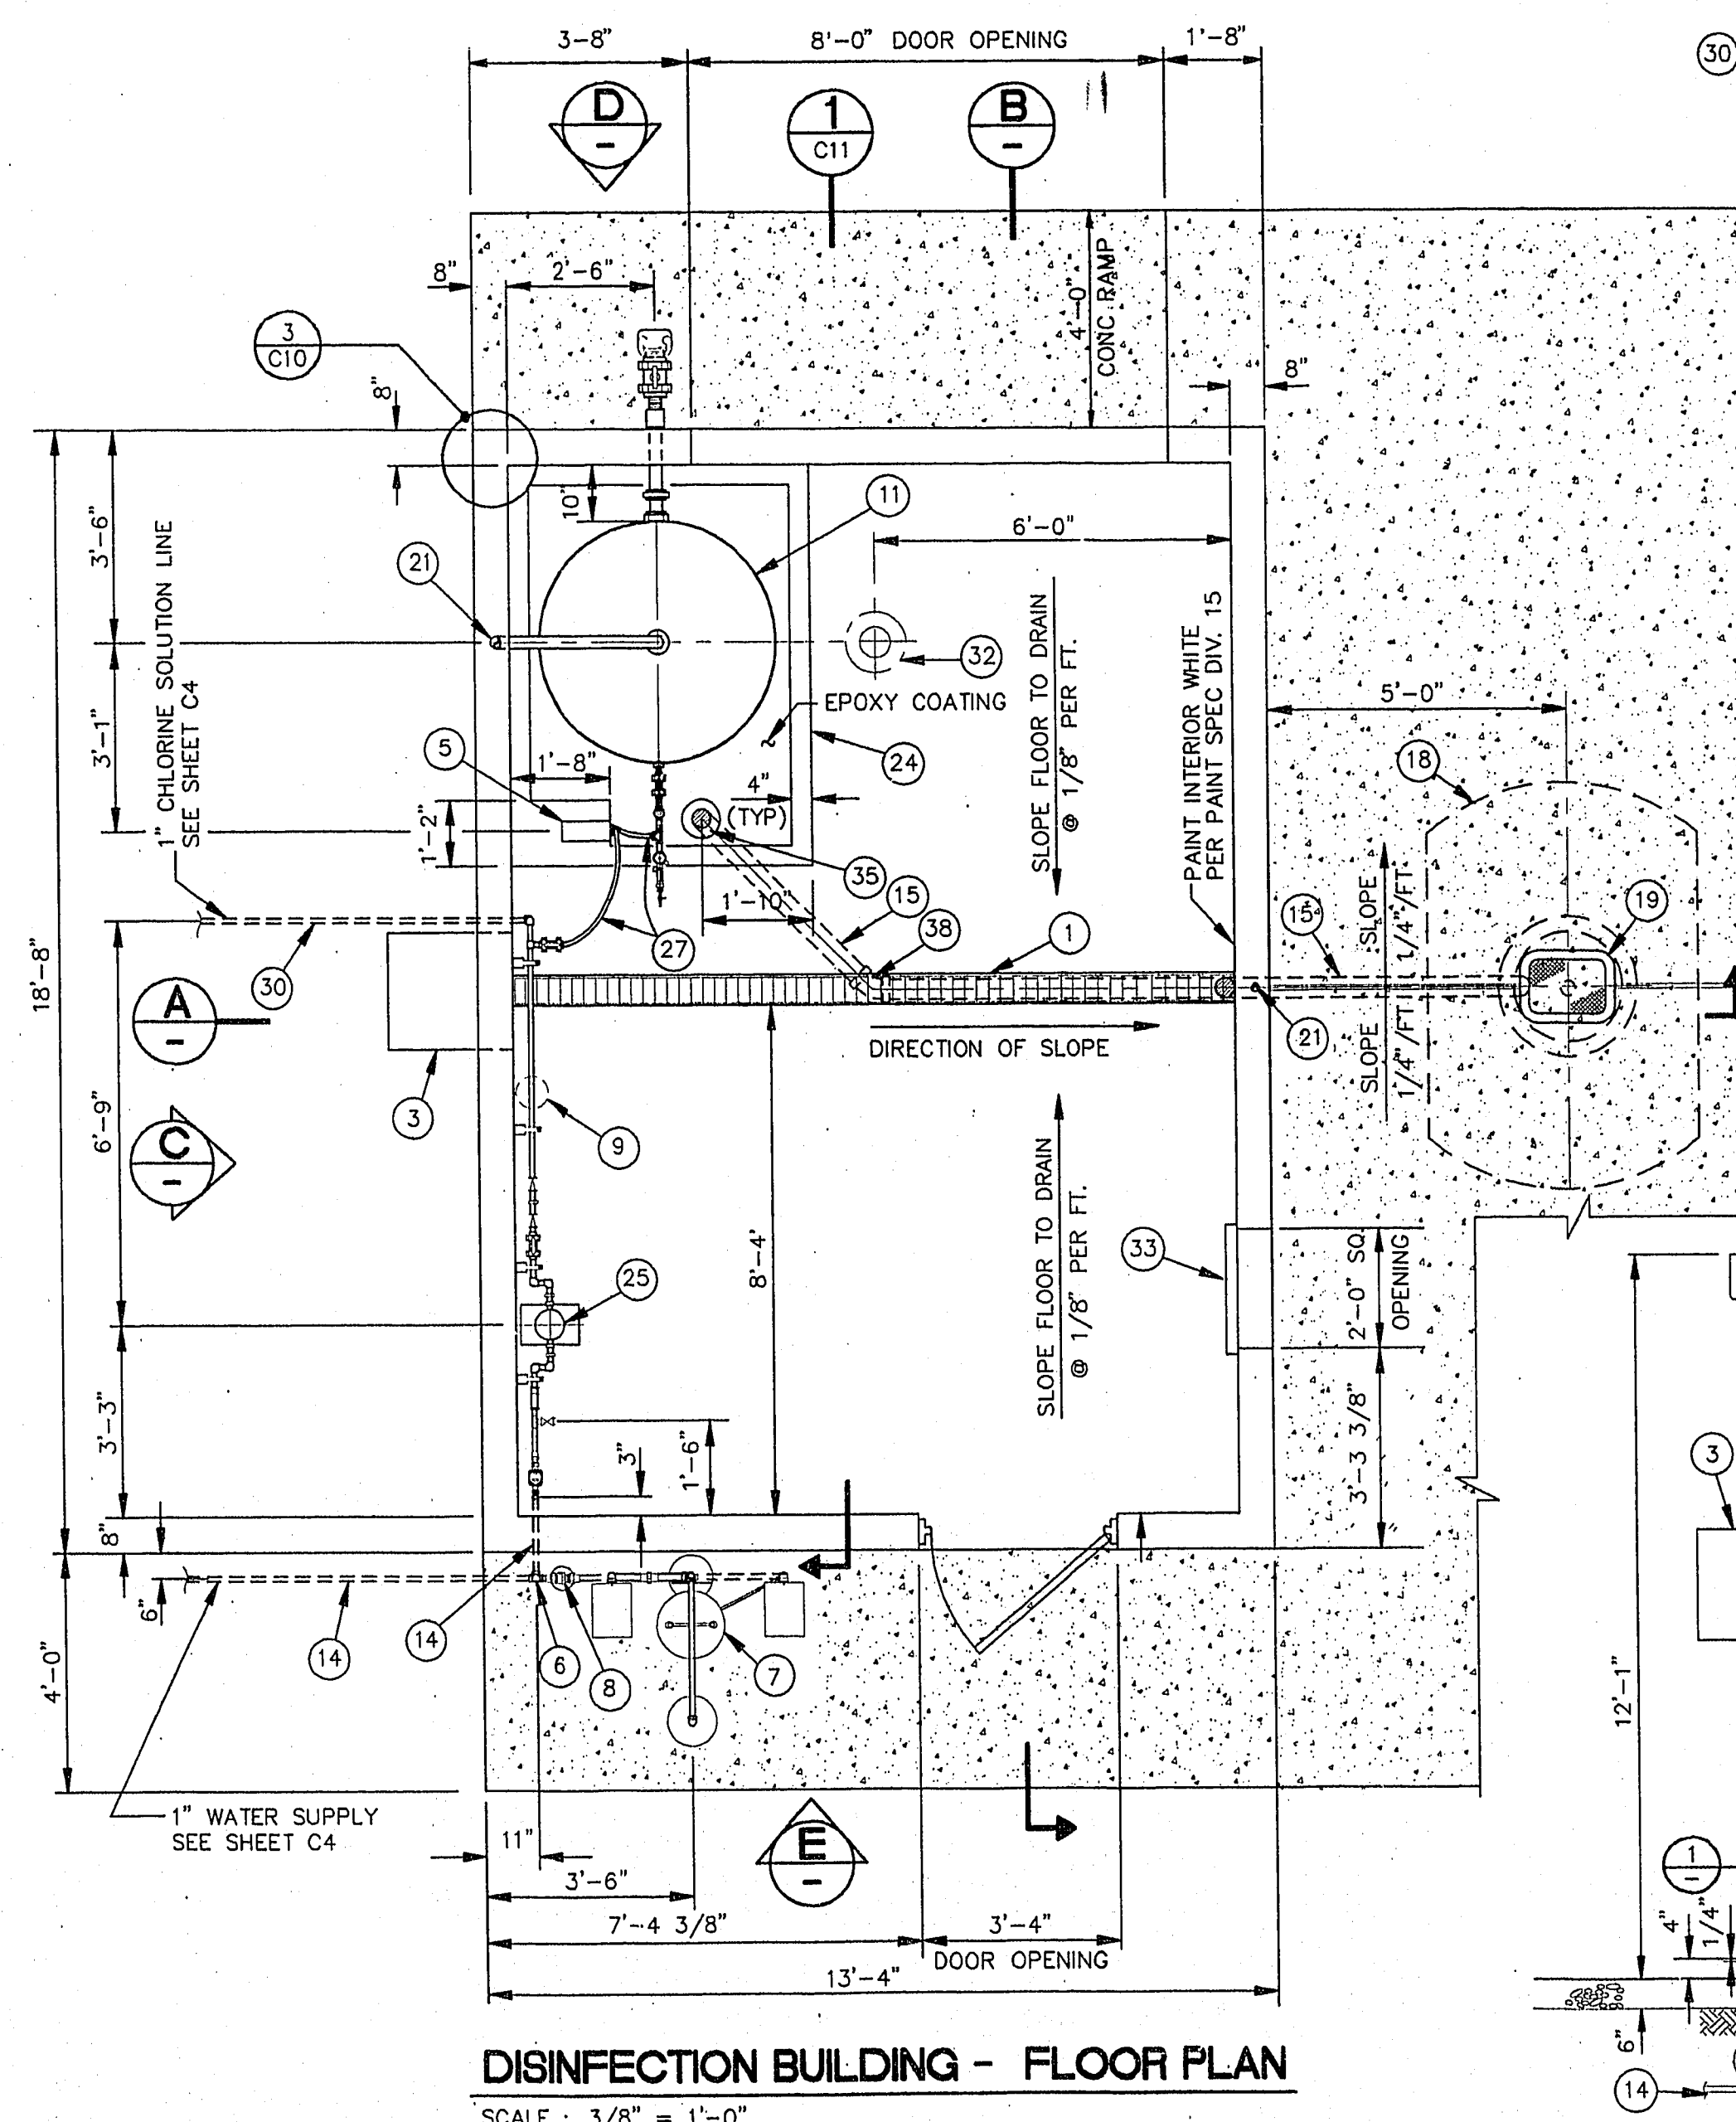
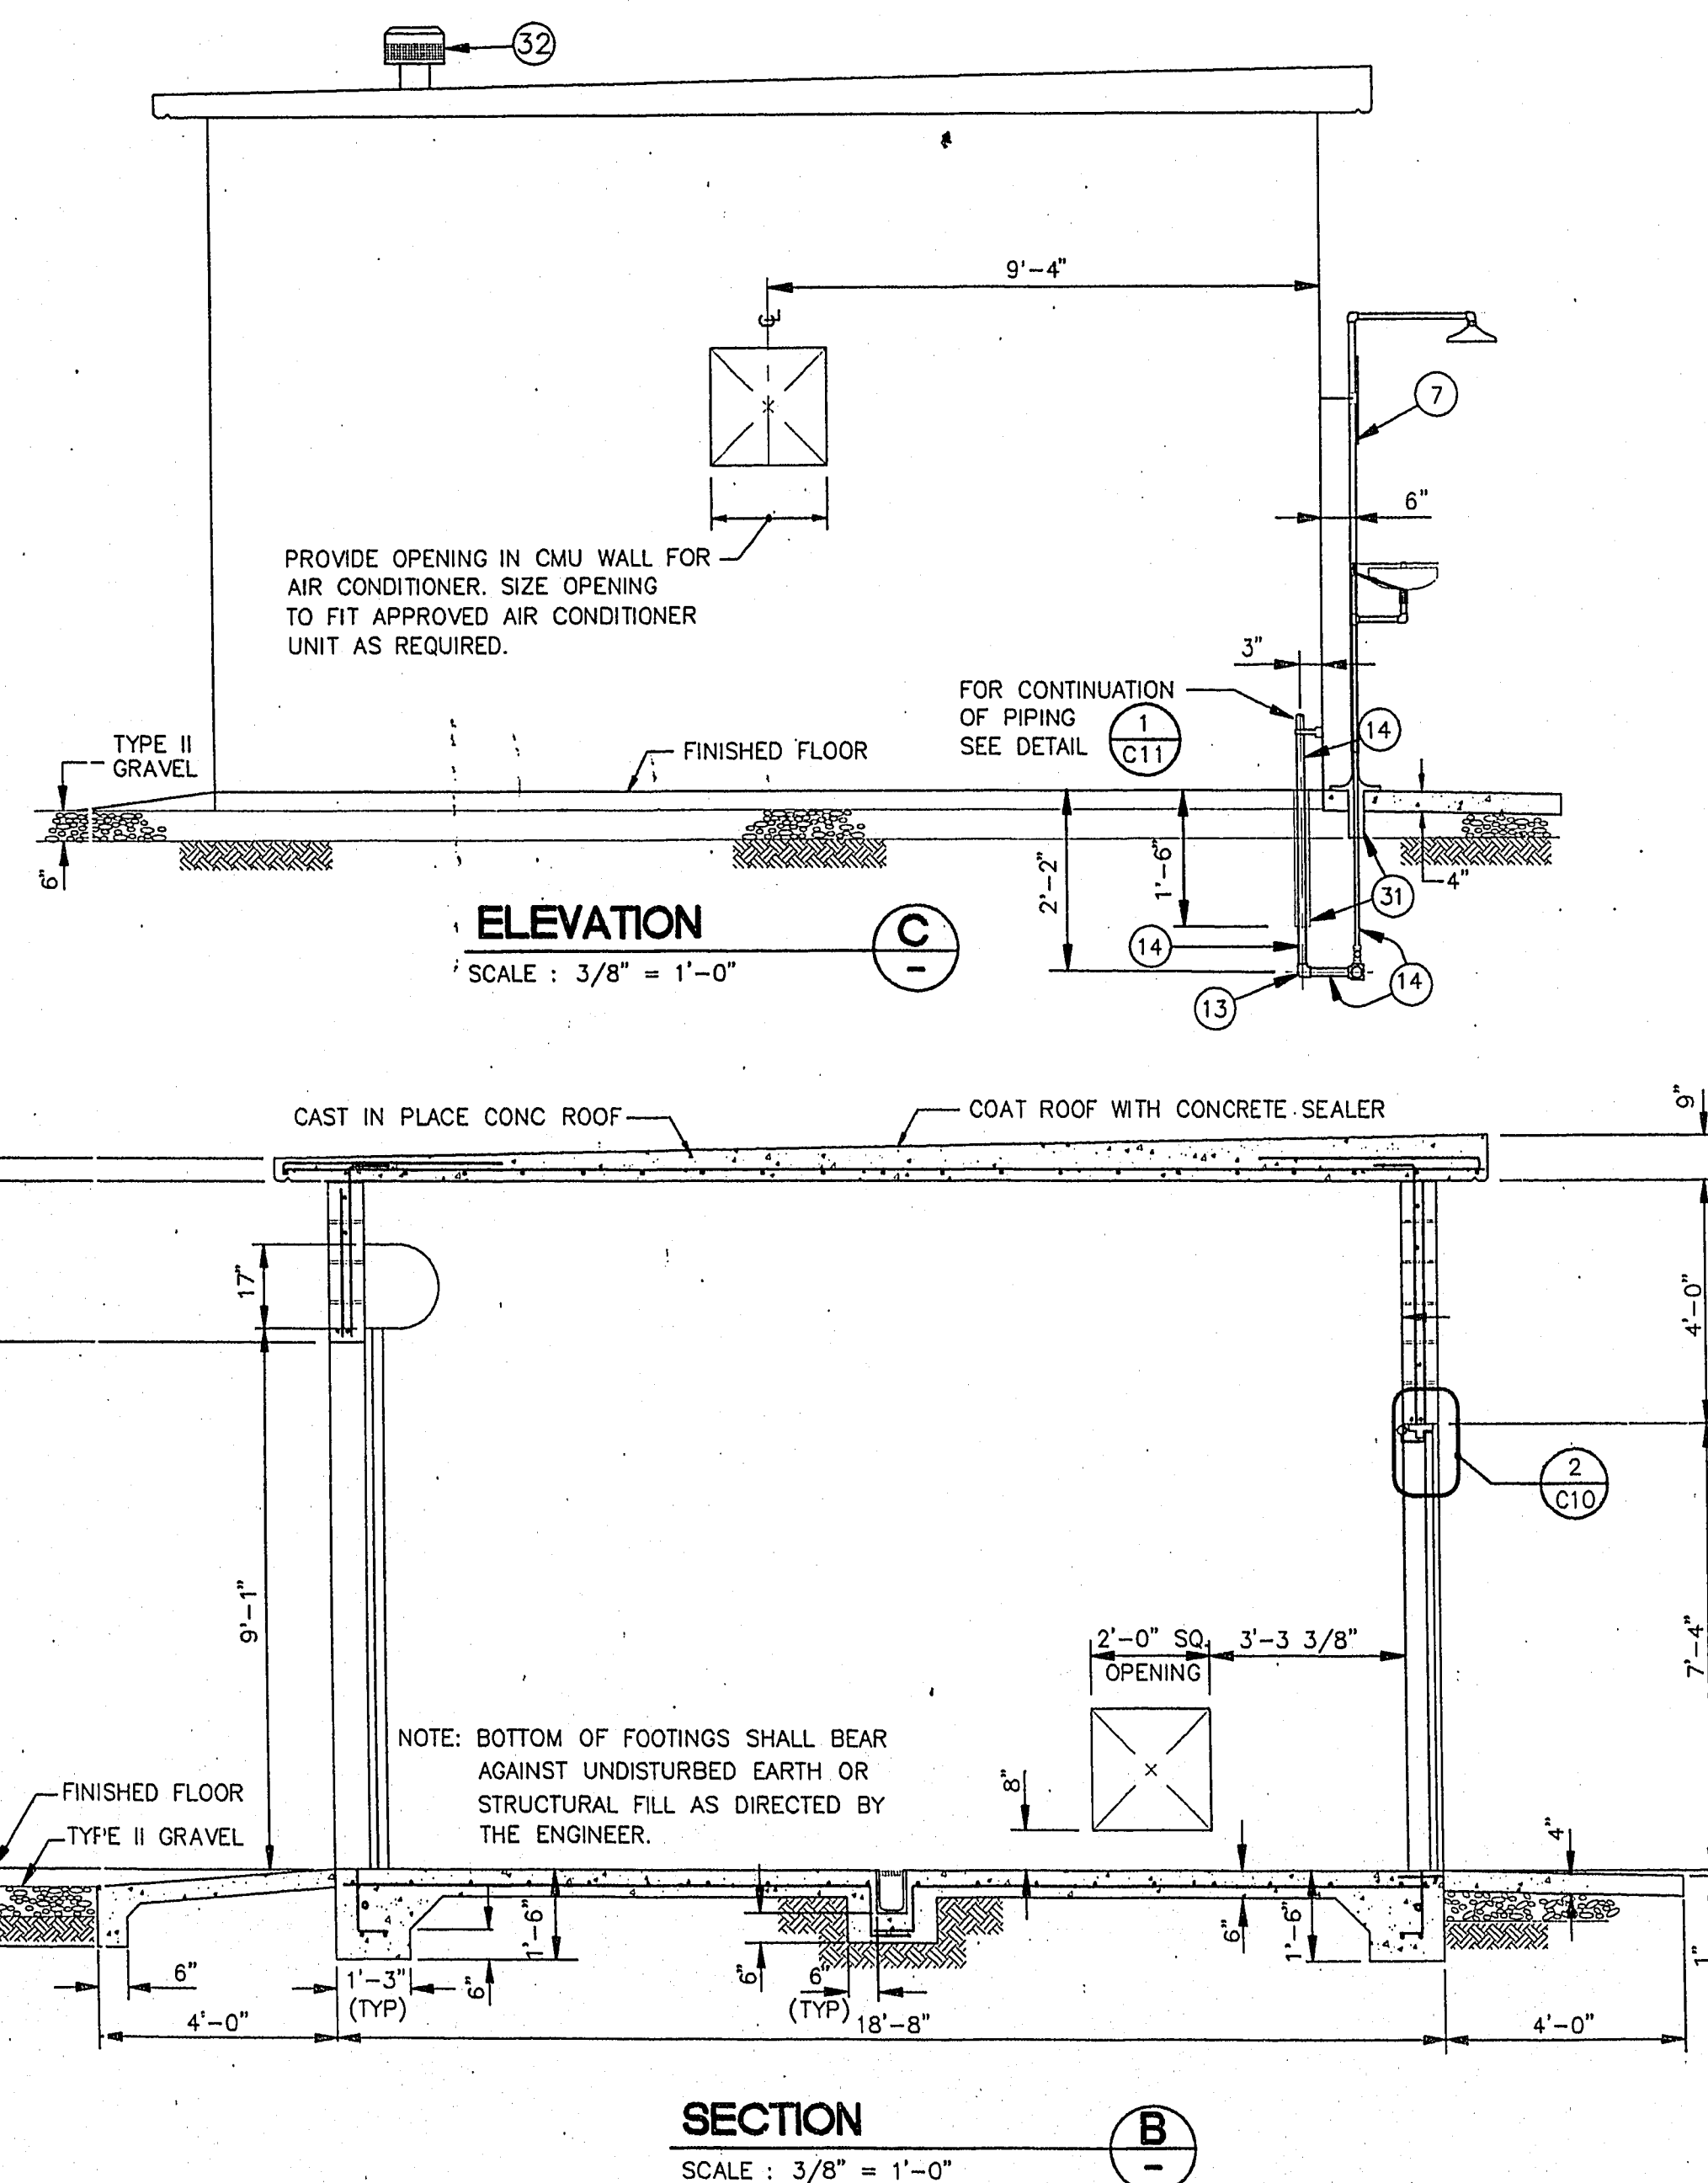
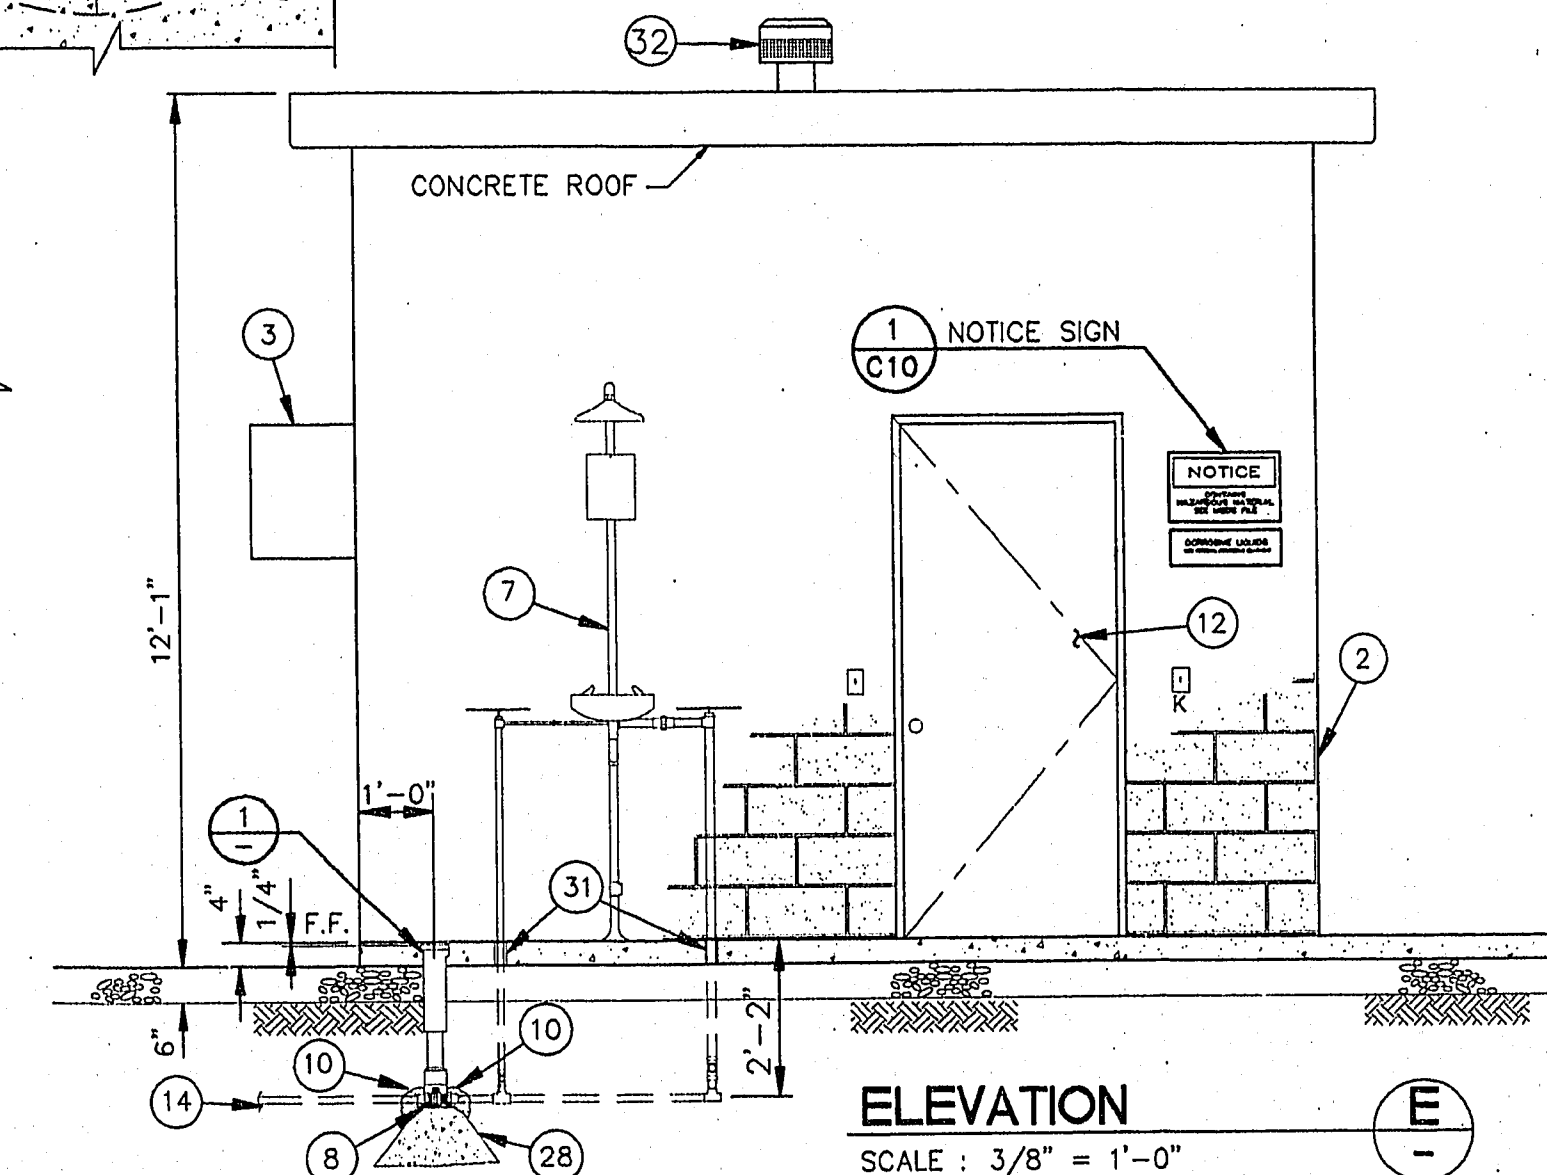
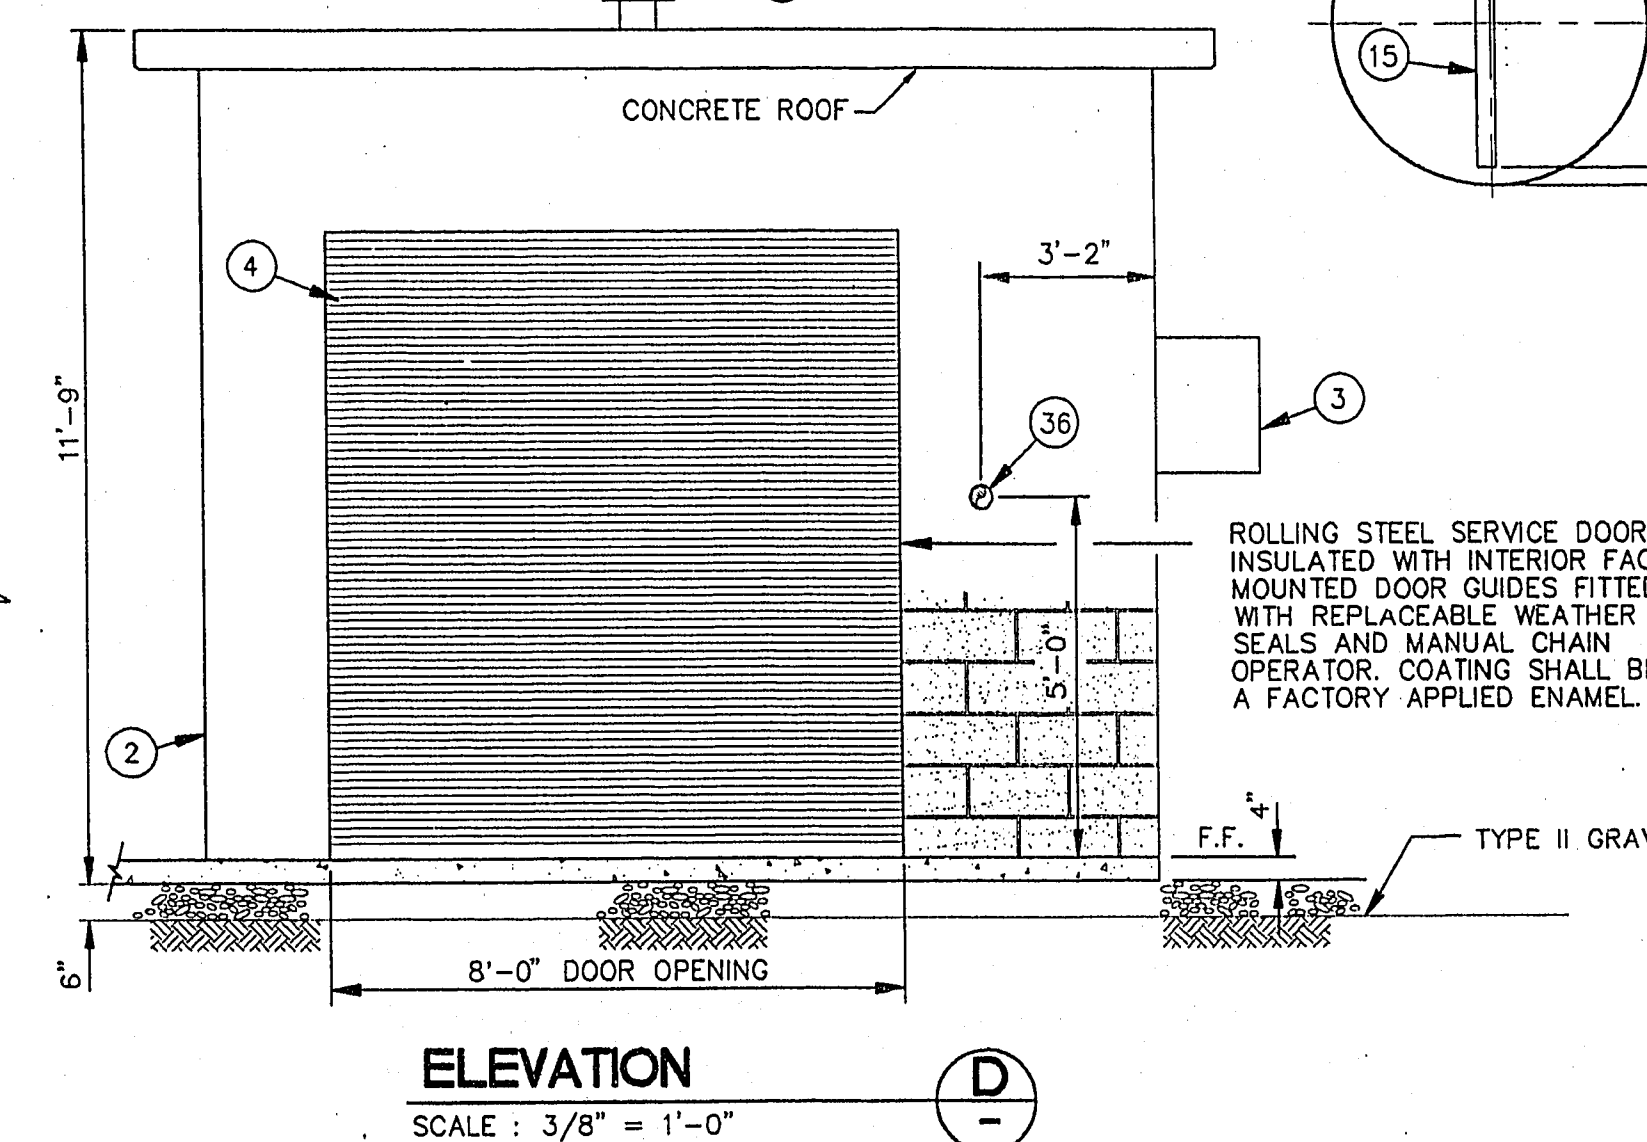
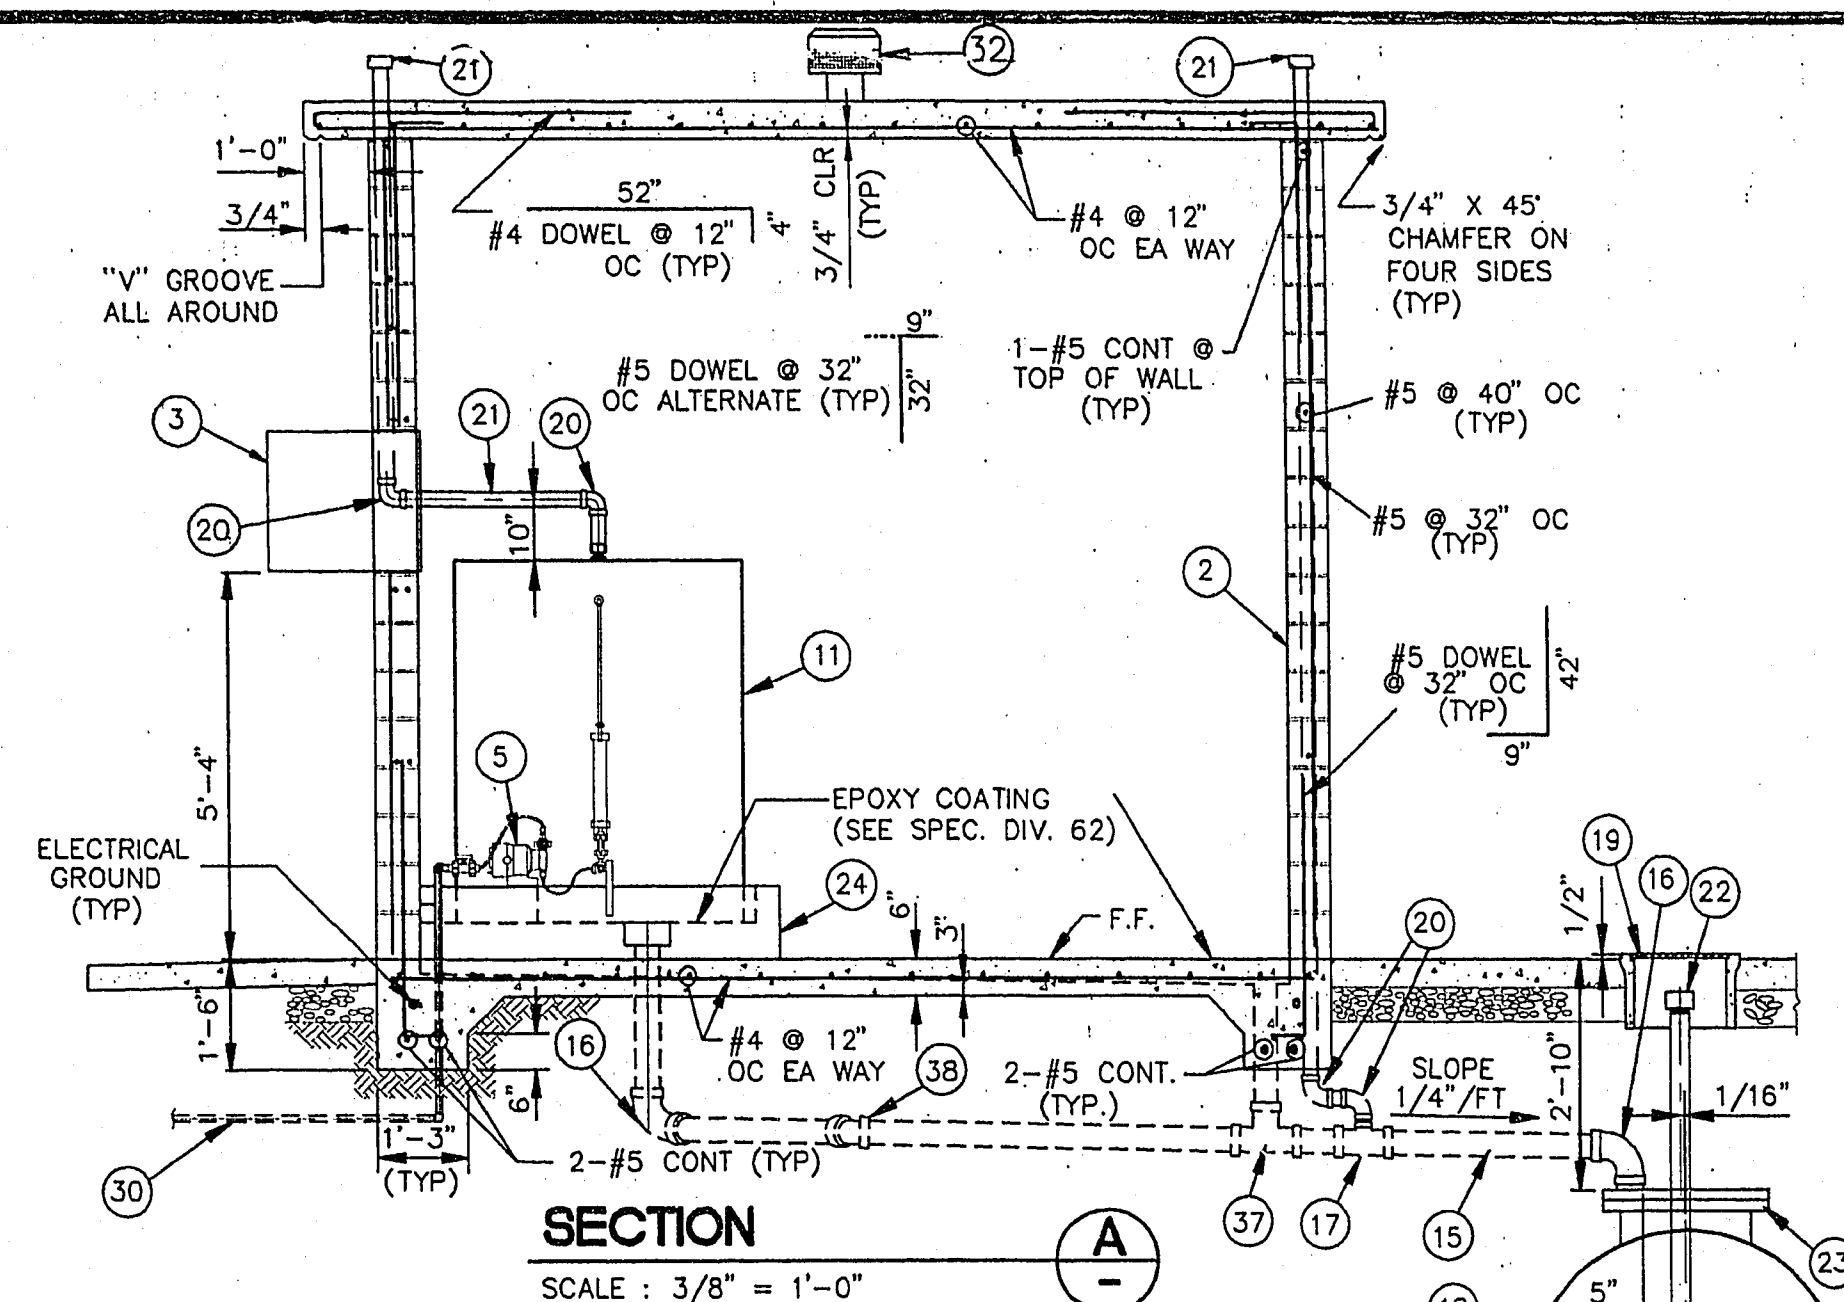



ITEM	DESCRIPTION	SPEC DIV/SEC	ITEM	DESCRIPTION	SPEC DIV/SEC
1	ACO PRECAST VINYLESTER RESIN CONCRETE CHEM SAFE DOUBLE TRENCH DRAIN	6209	20	2" CPVC 90° ELBOW	4204B
2	SPLIT FACED 8" x 8" x 16" PIGMENTED CMU WALLS, SOLID GROUT ALL CELLS	AS NOTED	21	2" CPVC PIPE	4204B
3	CONTRACTOR TO SUBMIT COLOR SAMPLES		22	4" PVC CAP	6214
4	AIR CONDITIONER / HEAT PUMP	4302	23	22" Ø MANWAY	
5	INSULATED STEEL ROLLING SERVICE DOOR WITH WEATHER SEALS AND MANUAL CHAIN OPERATOR	6209	24	5'-0" x 6'-8" x 6" THICK CONCRETE PAD	DIV. 16
6	LMI METERING PUMP	4202C	25	WATER SUPPLY BOOSTER PUMP, WITH CONCRETE PAD	4203B
7	1" PVC TEE	4203C	26	UNISTRUT CHANNEL NO. P1000 AND CLAMP NO. P1113, FOR 3/8" FLEXIBLE POLYETHYLENE TUBING (PROVIDED W/LMI PUMP)	AS NOTED
8	COMBINATION EYEWASH AND SHOWER ASSEMBLY	4206	27	CONCRETE THRUST BLOCK, SEE L.V.V.W.D. STD. PLATE NO. 5	AS NOTED
9	1" TEE HEAD, CURB STOP, FORD B11-444 OR APPROVED EQUAL	AS NOTED	28	CAST IRON SERVICE BOX, ADJUSTABLE, TYLER NO. 90-C OR APPROVED EQUAL	
10	TEMPERATURE TRANSMITTER	5117	29	1" SCH 80 CPVC CHLORINE SOLUTION LINE	4204B
11	SAND BAG BOTH OPENINGS OF THE C.I. SERVICE BOX	AS NOTED	30	2" SCH 80 PVC PIPE SLEEVE	4203C
12	48" x 60" TALL SODIUM HYPOCHLORITE TANK	4202D	31	ROOF VENT: AIRFOIL VENT ALUMINUM CAP WITH BIRDPROOF SCREEN	6213
13	FLUSH STEEL DOOR WITH INSULATED HONEY-COMB CORE	6208	32	FAN EXHAUSTER ELECTRICALLY OPERATED AND CONNECTED TO THE FAN, 2 FT. X 2 FT. FREE AREA LOUVERED VENT W/INSECT SCREEN, BLADE AND JAMB SEALS, FACTORY MOUNTED 120V ELECTRIC OPERATOR	4303 & 4304
14	1" PVC 90° ELBOW	4203C	33	4" FLOOR DRAIN, McMASTER-CARR CATALOG NO. 2411K44	AS NOTED
15	1" SCH. 80 PVC WATER SUPPLY	4203C	34	2" CAM QUICK DISCONNECT W/ 2" BALL VALVE	
16	4" PVC PIPE, SCH. 80	6214	35	4" SCH. 80 PVC, SOCKET TEE	6214
17	4" PVC SCH. 80, SOCKET 90° ELBOW	6214	36	4" SCH. 80 PVC, SOCKET 45° ELBOW	6214
18	4" x 2" PVC SCH 80, SOCKET TEE	6214			
19	DOUBLE WALL FIBERGLASS REINFORCED PLASTIC UNDERGROUND TANK WITH 22" MANWAY COVER, 550 GAL	4207			
20	9 1/2" x 16" METER BOX WITH NO. 3-T TRAFFIC COVER, BROOKS	AS NOTED			
21	3-SERIES OR APPROVED EQUAL				

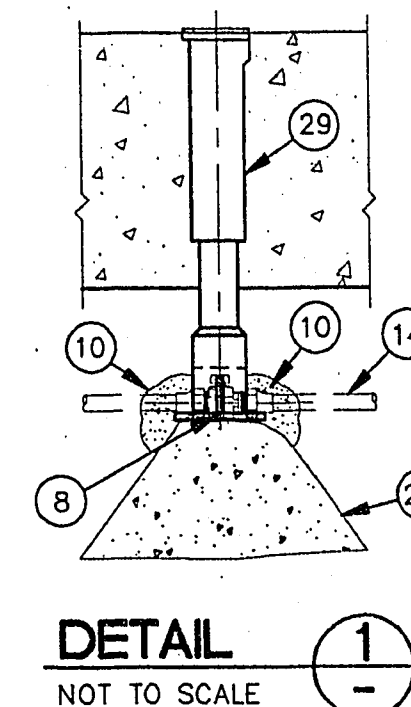

DISINFECTION BUILDING - FLOOR PLAN
SCALE: 3/8" = 1'-0"

LAS VEGAS VALLEY WATER DISTRICT
3700 WEST CHARLESTON BOULEVARD
LAS VEGAS, NEVADA

EQUIP WELL NOS. 96 AND 97
WELL NO. 97
DISINFECTION BUILDING

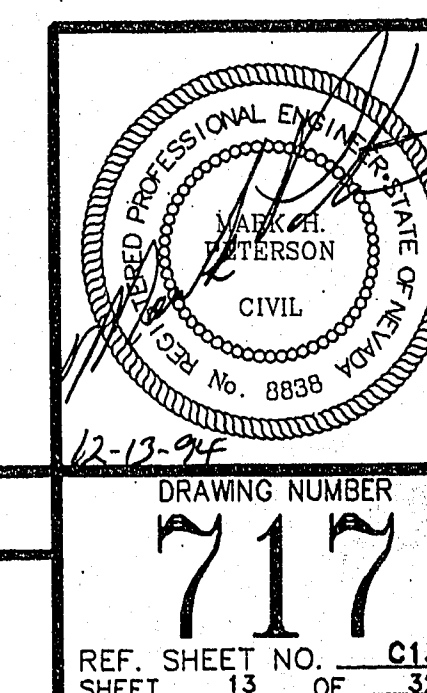

DRAWING NUMBER
717
REF. SHEET NO. **C13**
SHEET 13 OF 32

E-3 QS-396 139-27-SE 565-245