



ITEM	DESCRIPTION	SPEC SEC/DIV
1	AIR CONDITIONER / HEATER UNIT	DIV 43
2	SPLIT FACED 8"x 8"x 16" PIGMENTED CMU WALLS	AS NOTED
	SOLID GROUT ALL CELLS. CONTRACTOR TO SUBMIT COLOR SAMPLES.	
3	ROLLING SERVICE DOOR	DIV 62
4	FLOOD LIGHT	


NOTE: FOR ELECTRICAL EQUIPMENT LAYOUT SEE SHEET E11

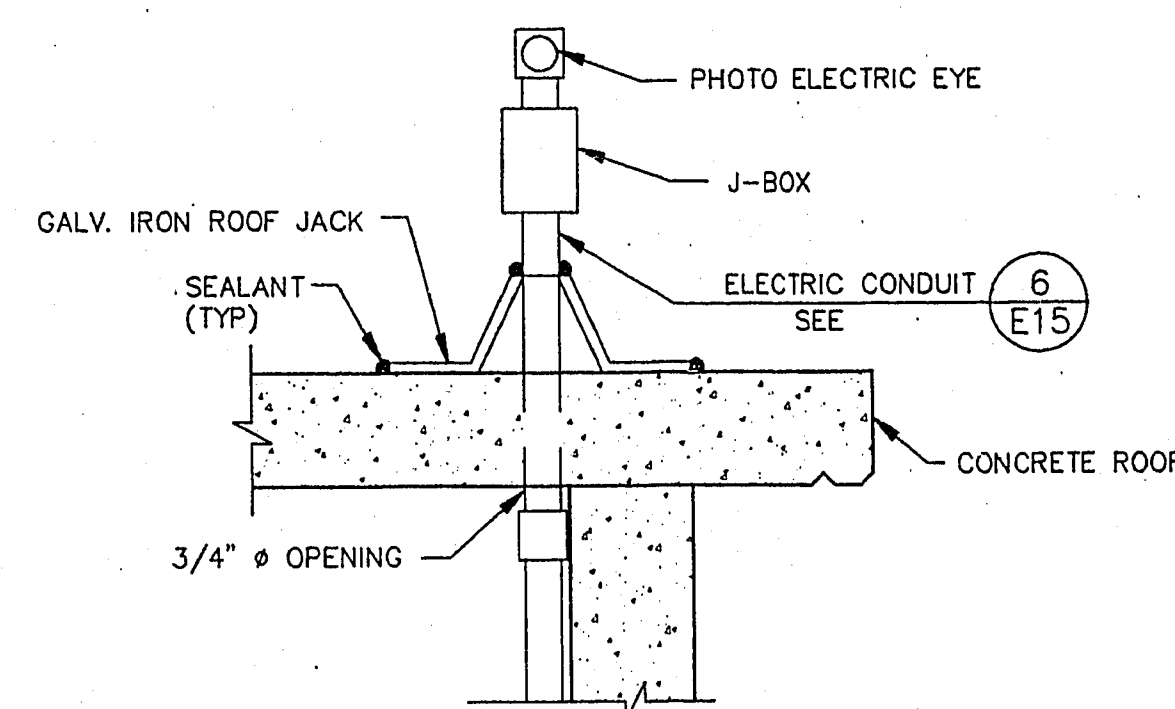


DETAIL
NOT TO SCALE

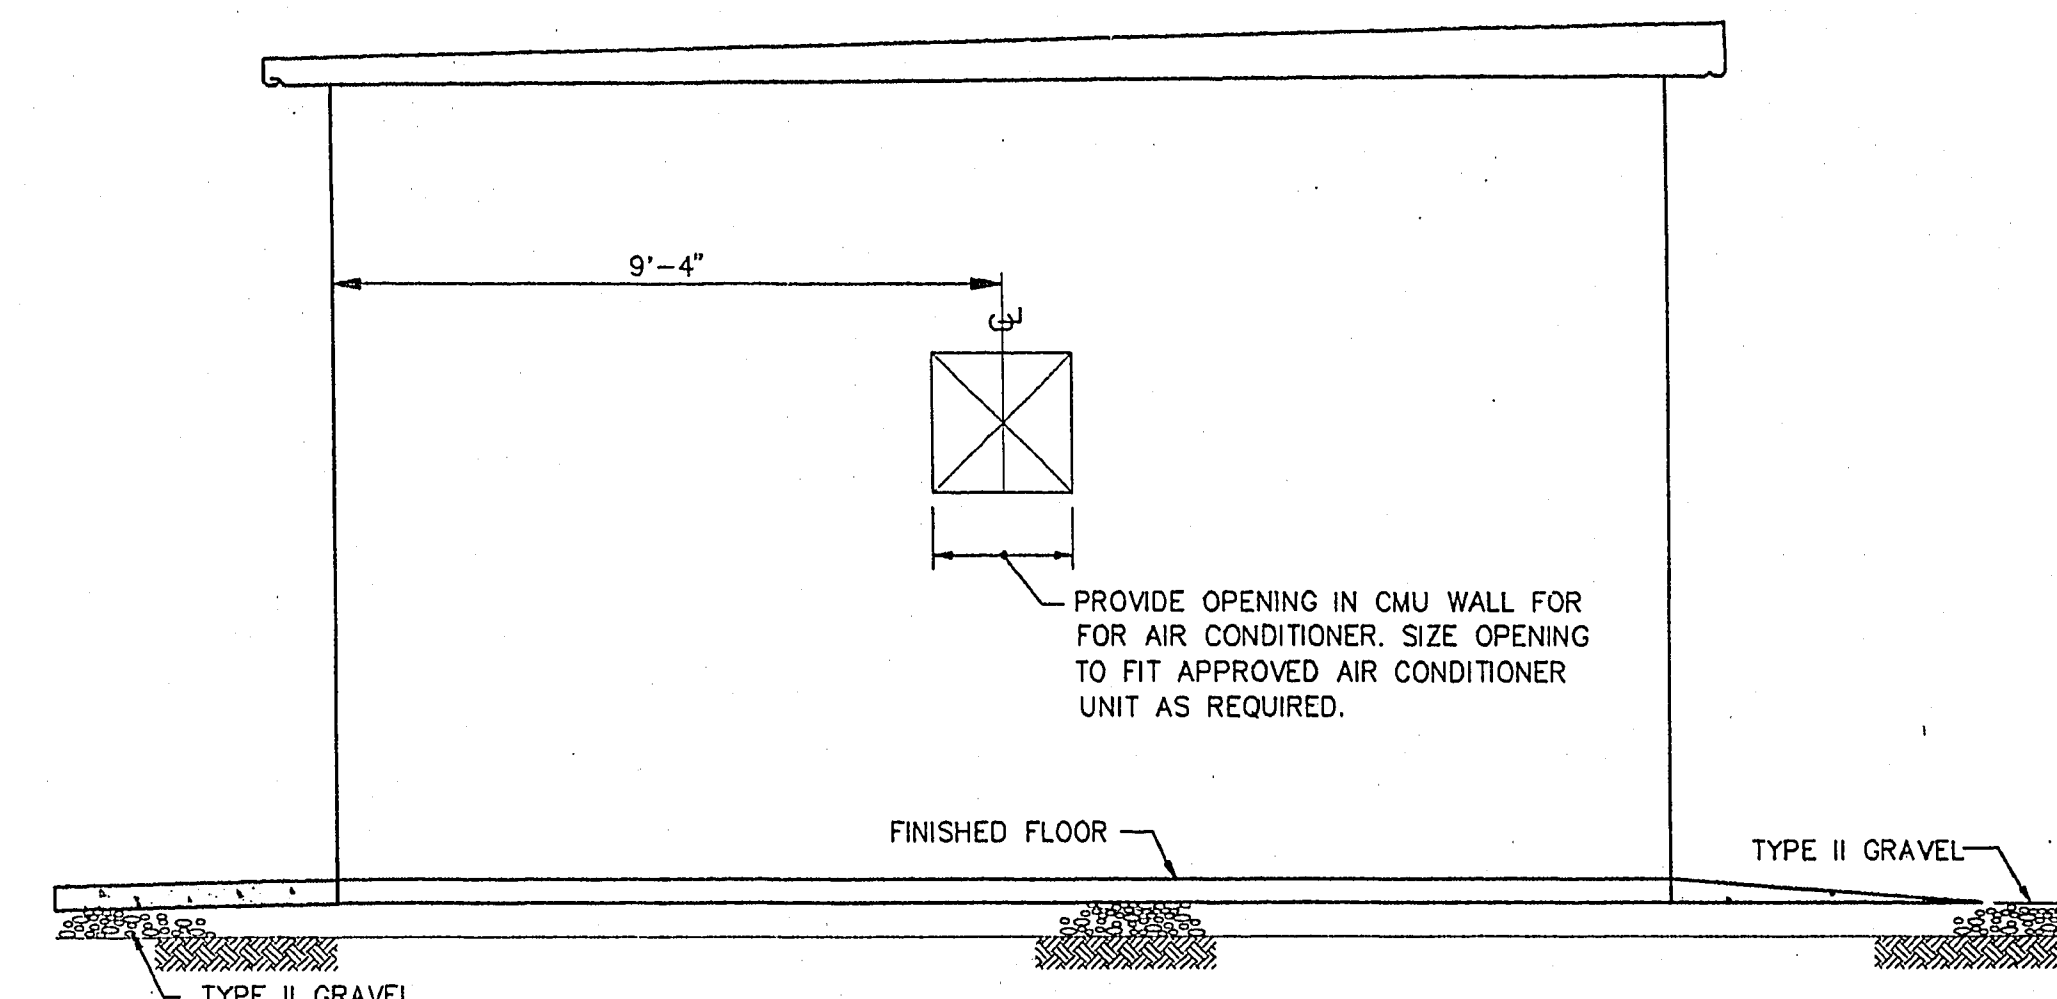


ELEVATION
SCALE: 3/8" = 1'-0"

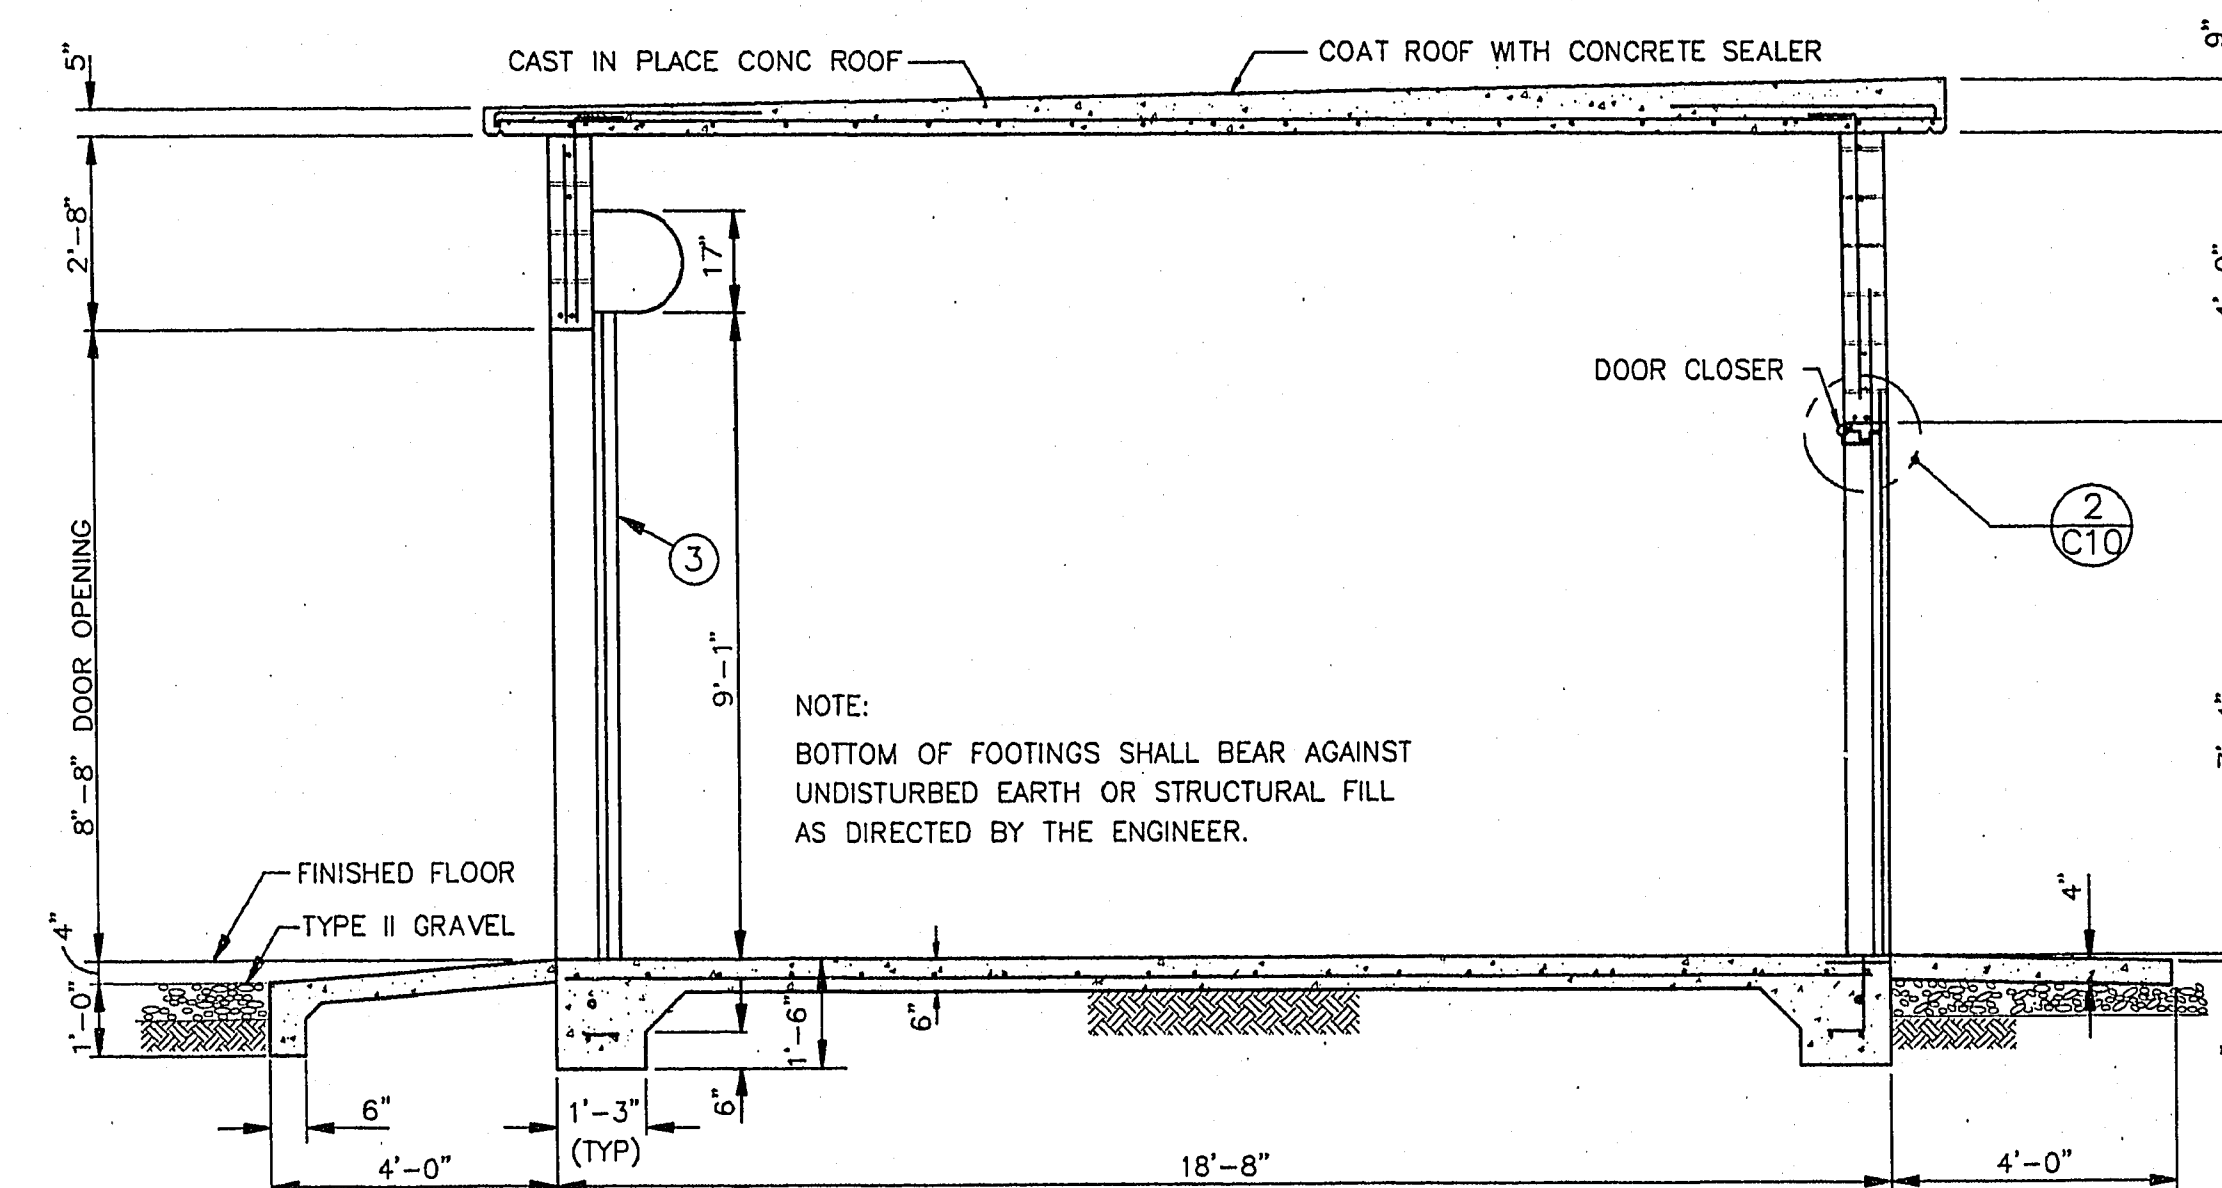


SECTION
SCALE: 3/8" = 1'-0"

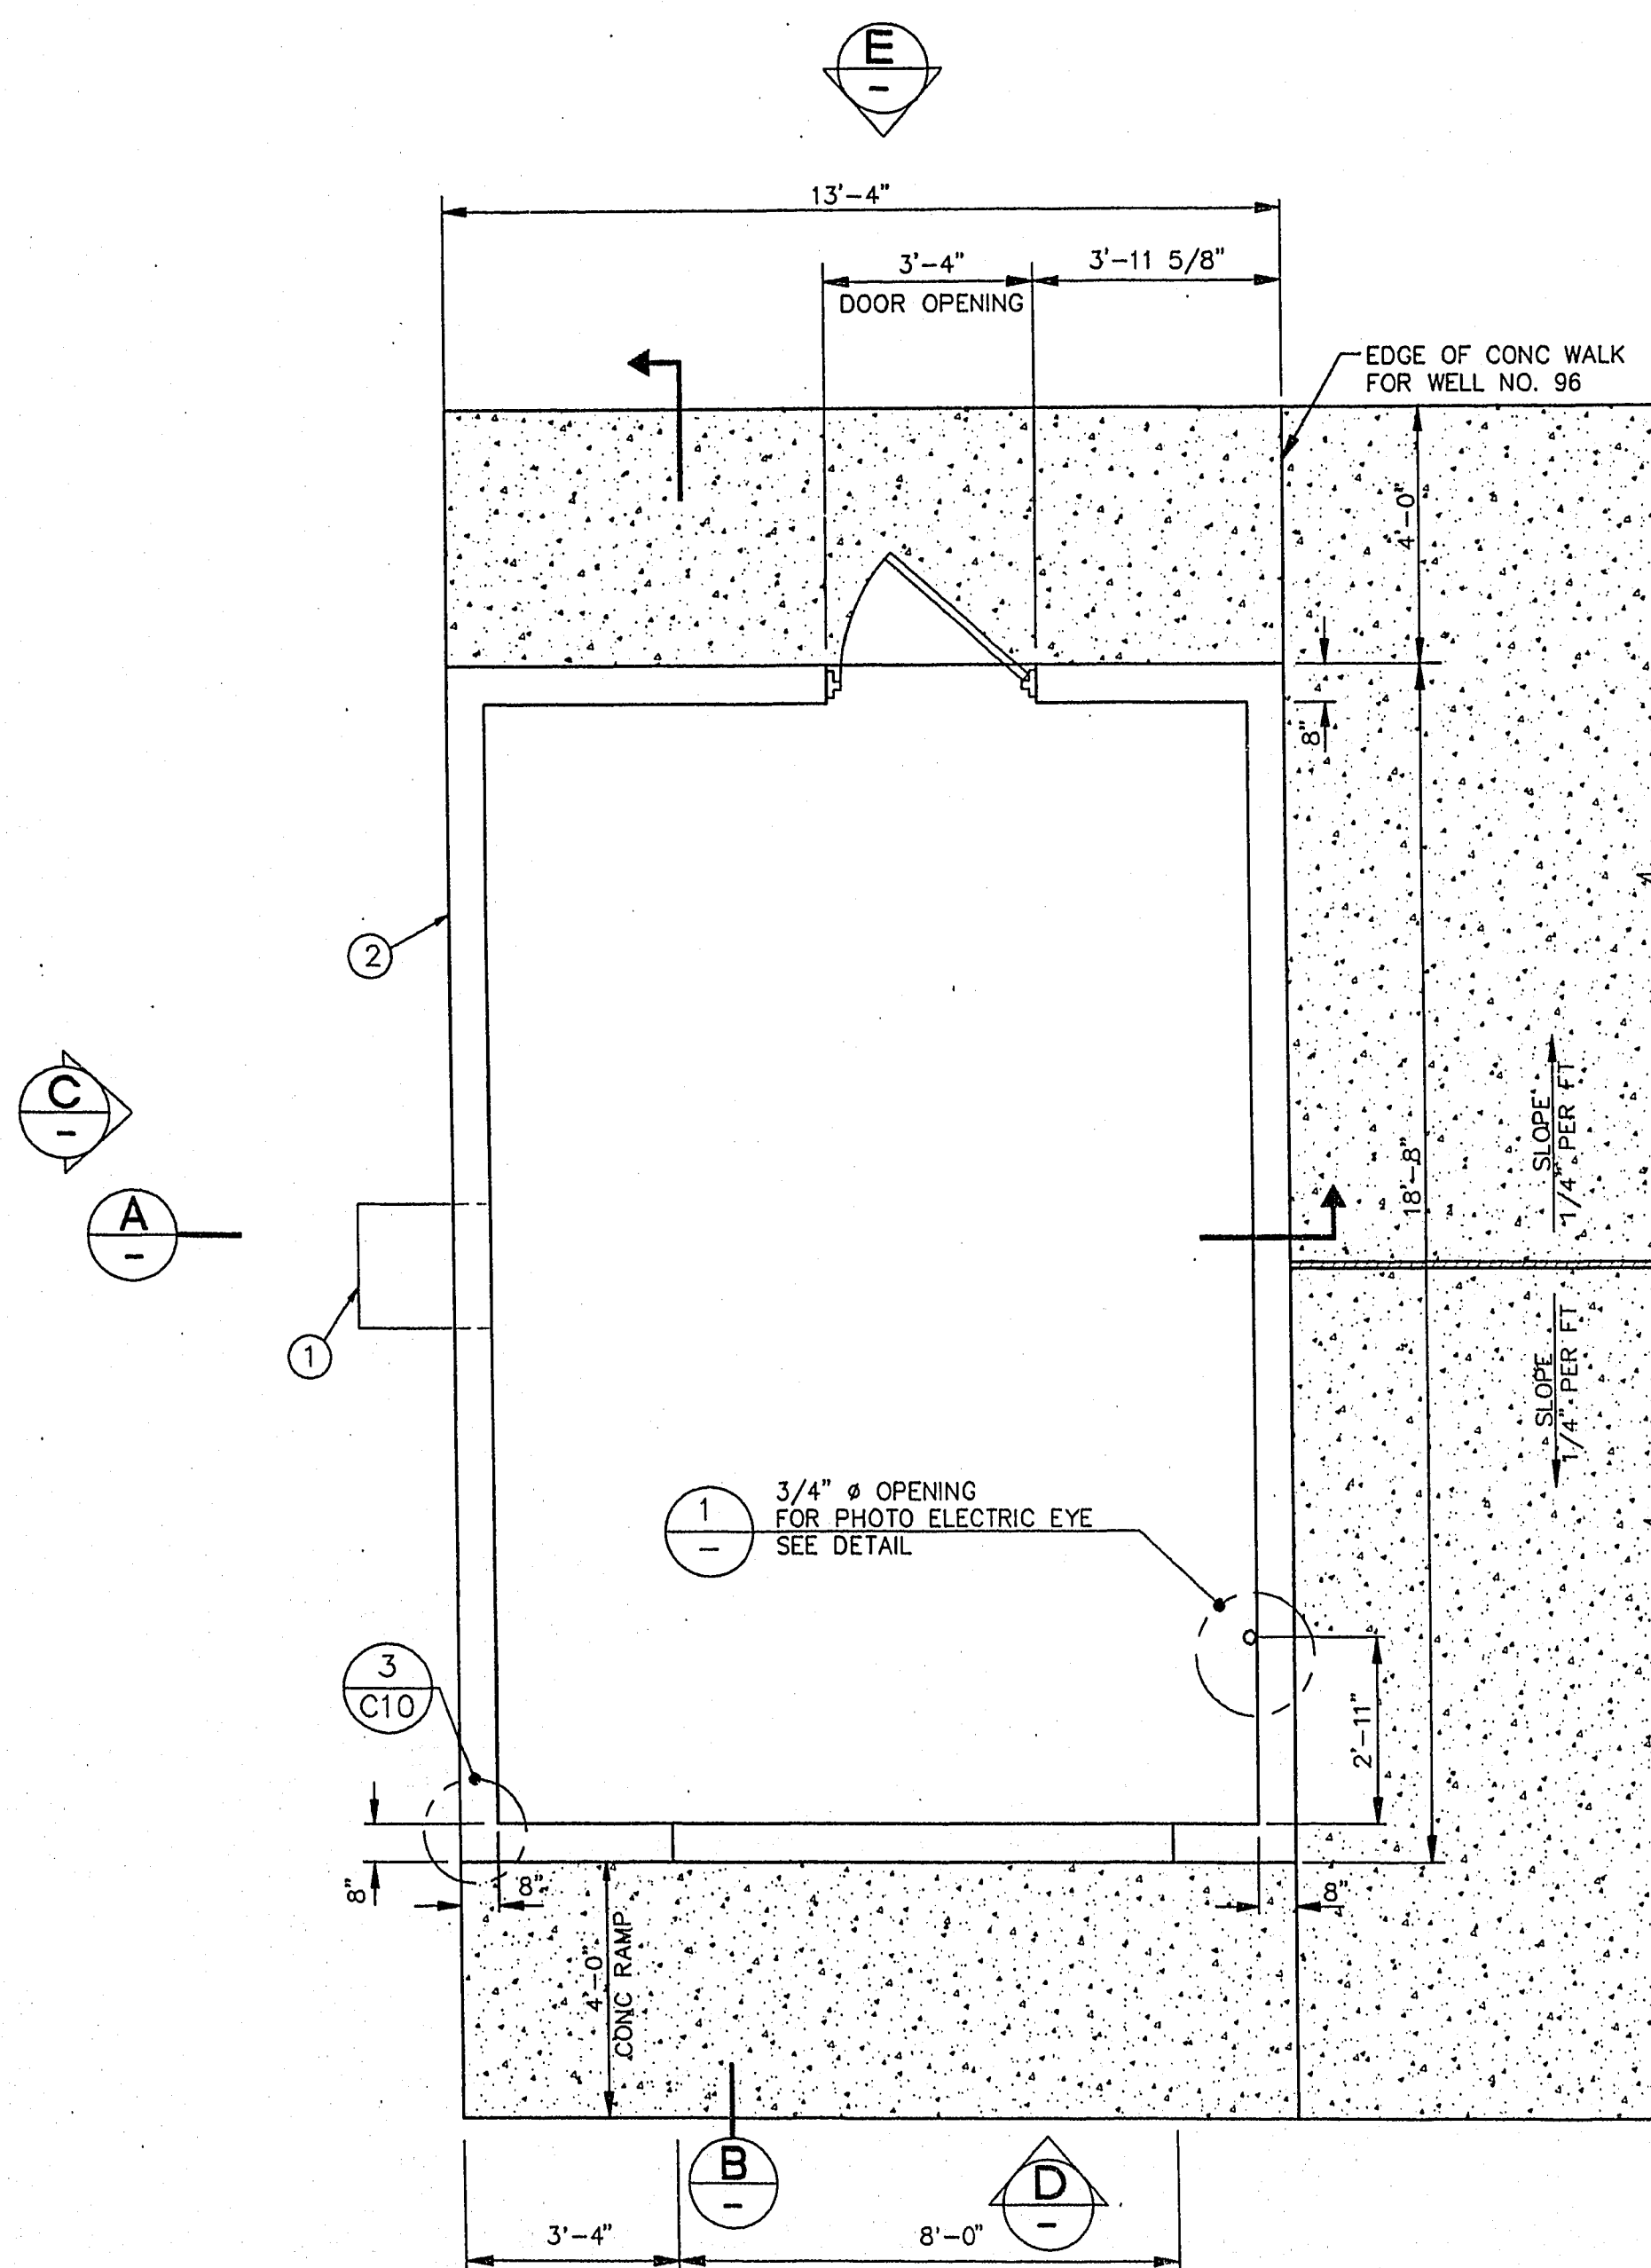


CONTROL BUILDING - FLOOR PLAN
SCALE: 3/8" = 1'-0"

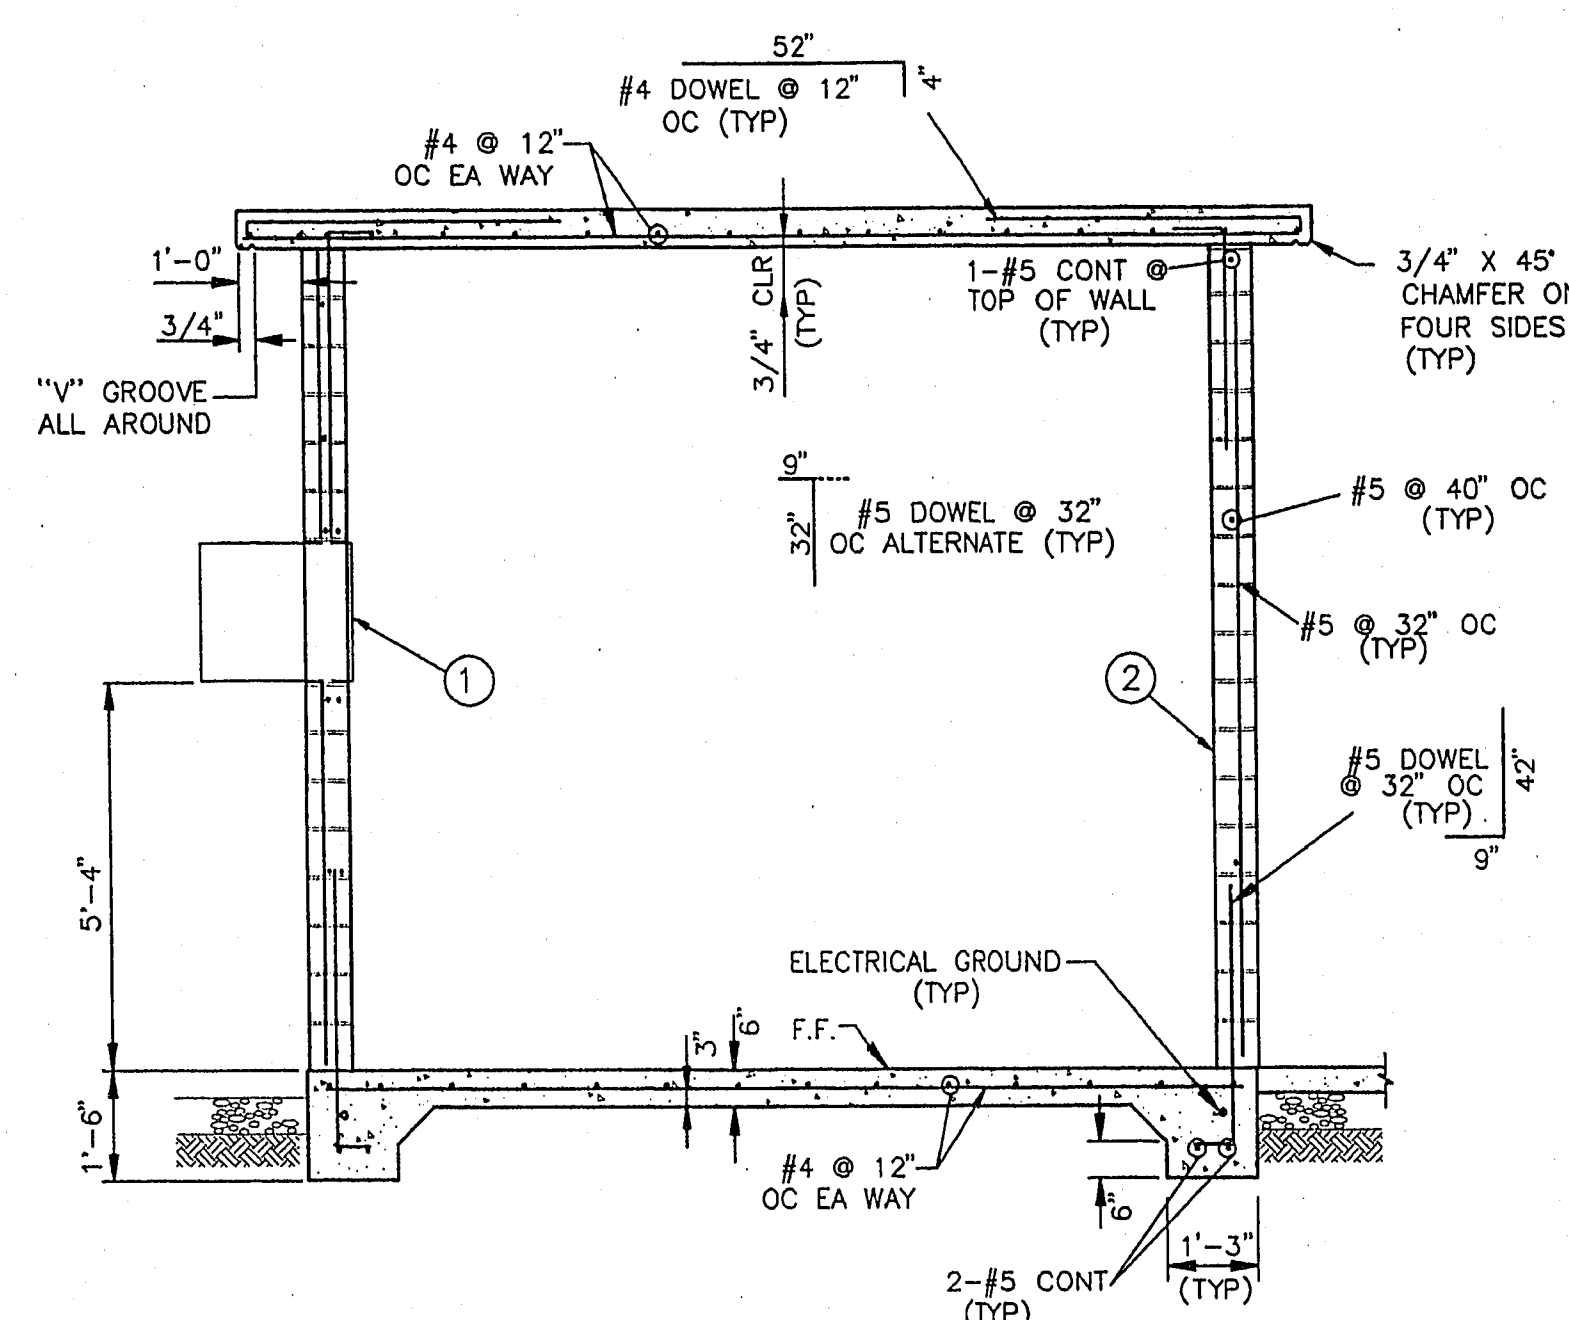

SECTION
SCALE: 3/8" = 1'-0"

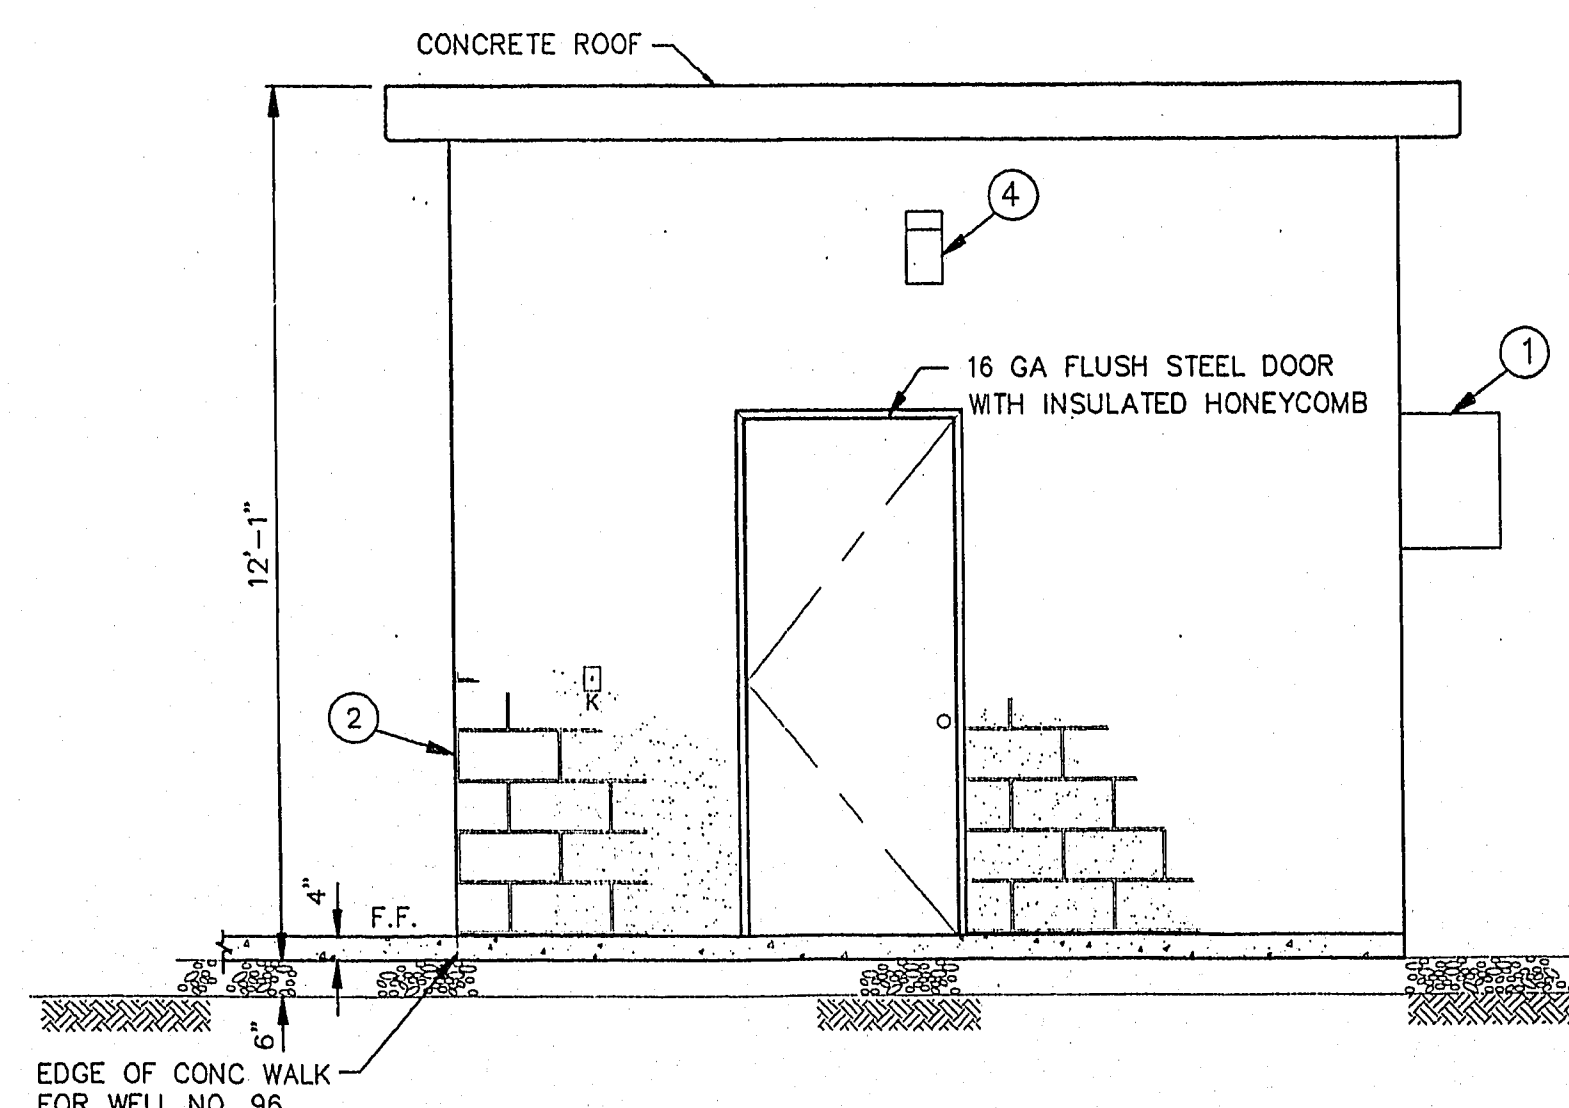


ELEVATION
SCALE: 3/8" = 1'-0"

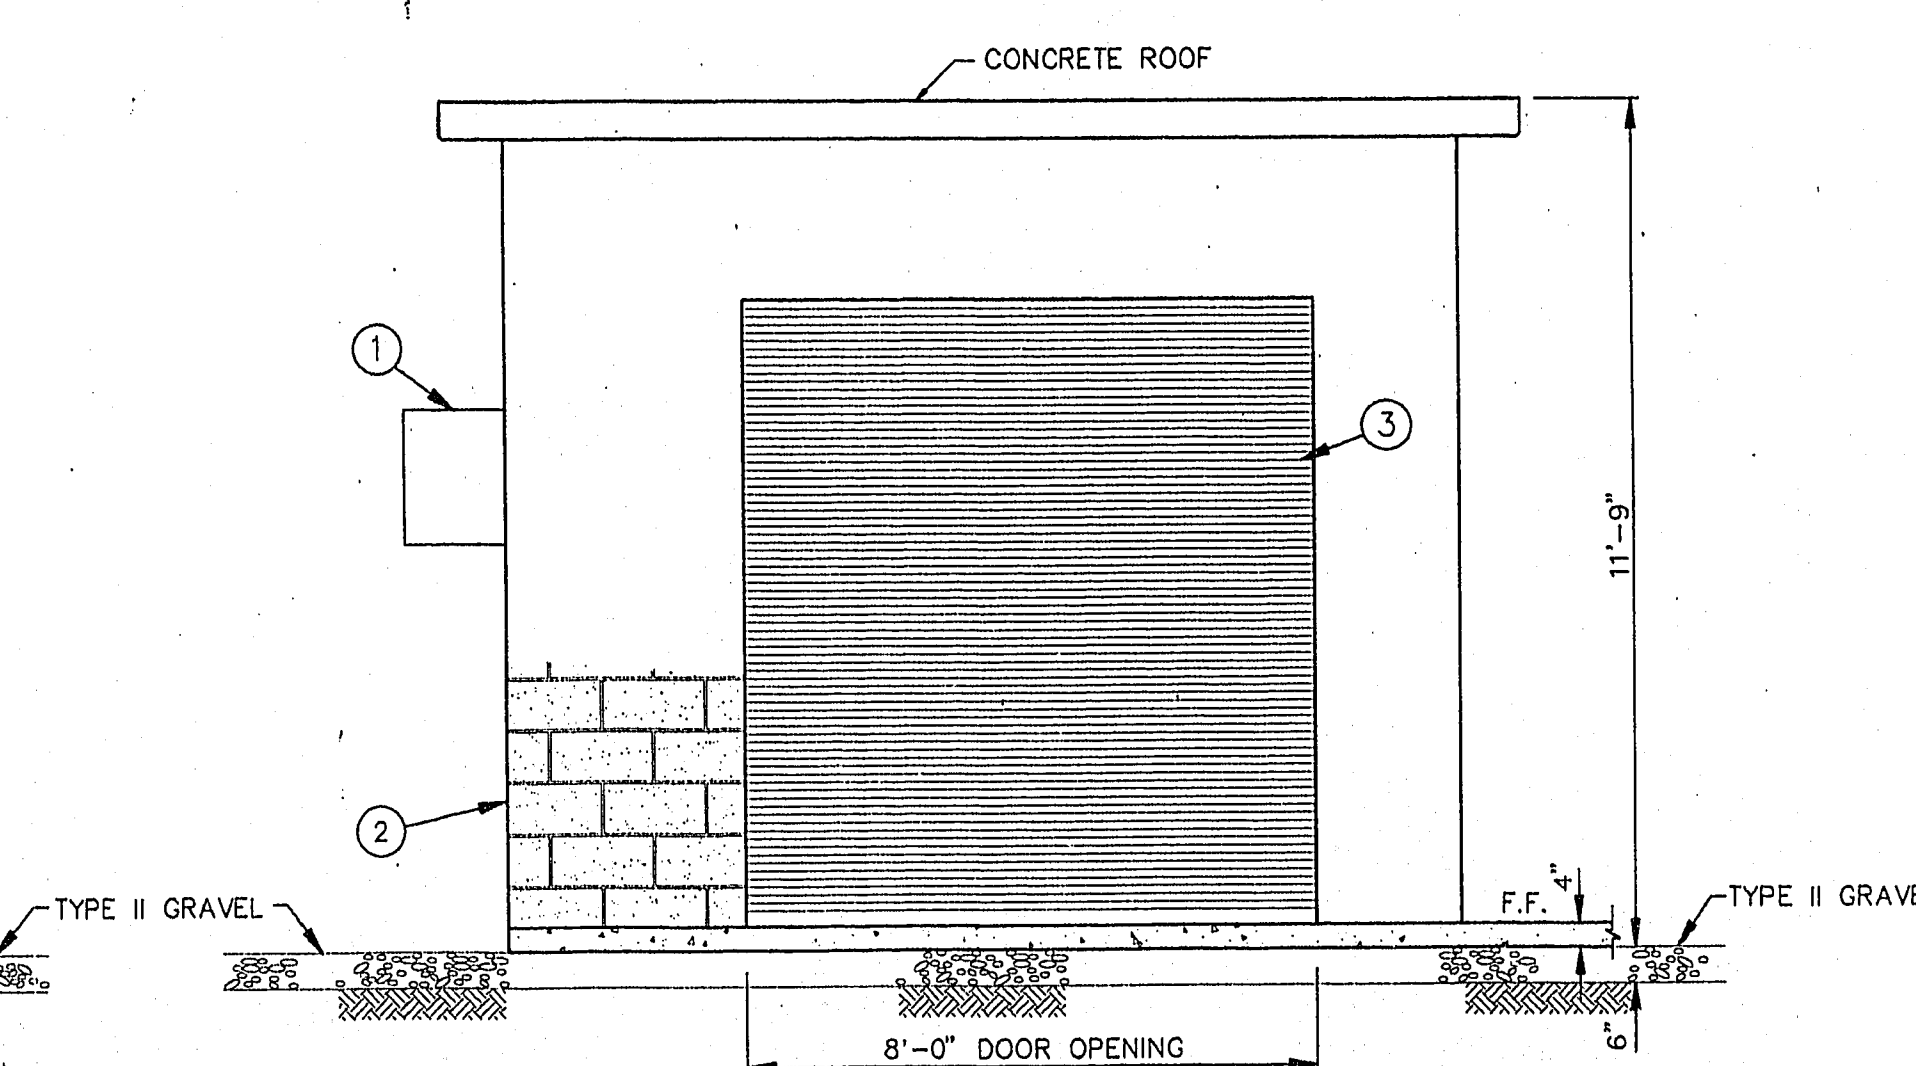

ELEVATION
SCALE: 3/8" = 1'-0"

LAS VEGAS VALLEY WATER DISTRICT
3700 WEST CHARLESTON BOULEVARD
LAS VEGAS, NEVADA

EQUIP WELL NOS. 96 AND 97
WELL NOS. 96 AND 97
CONTROL BUILDING

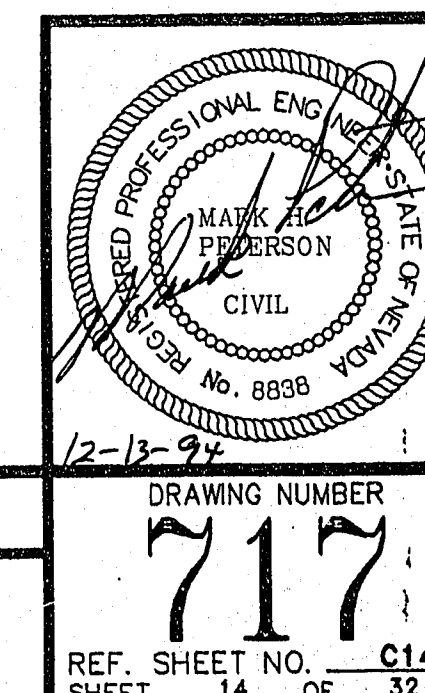

E-3 QS-396 138-27-SE