




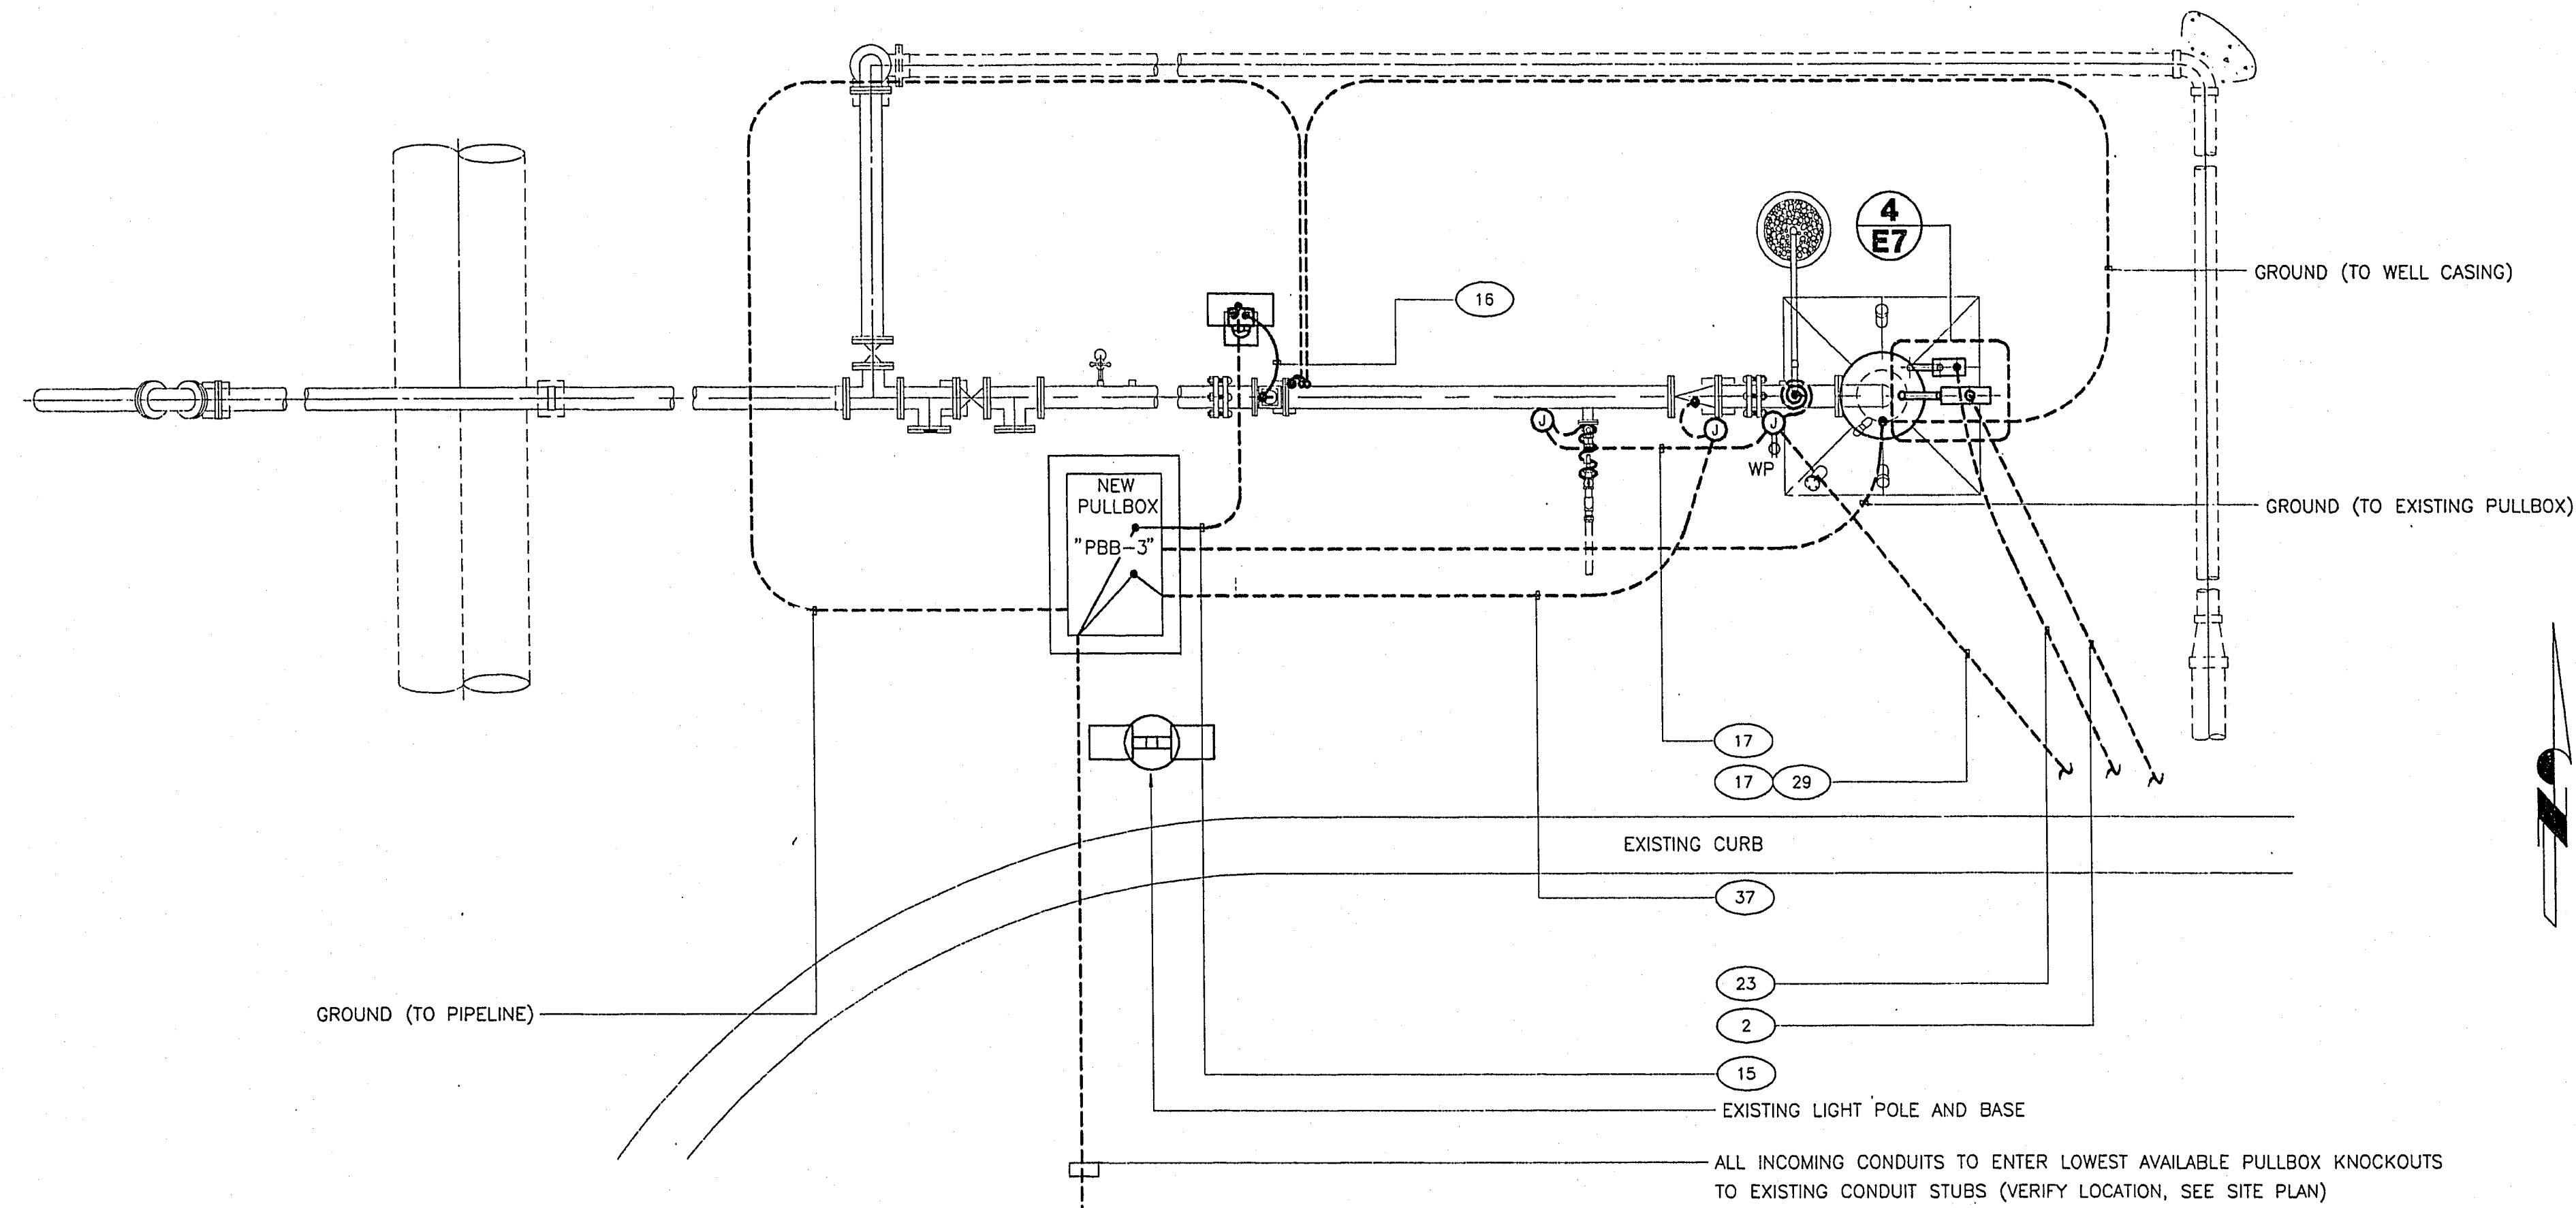

ELECTRICAL PLAN
SCALE - 1/4" = 1'-0"

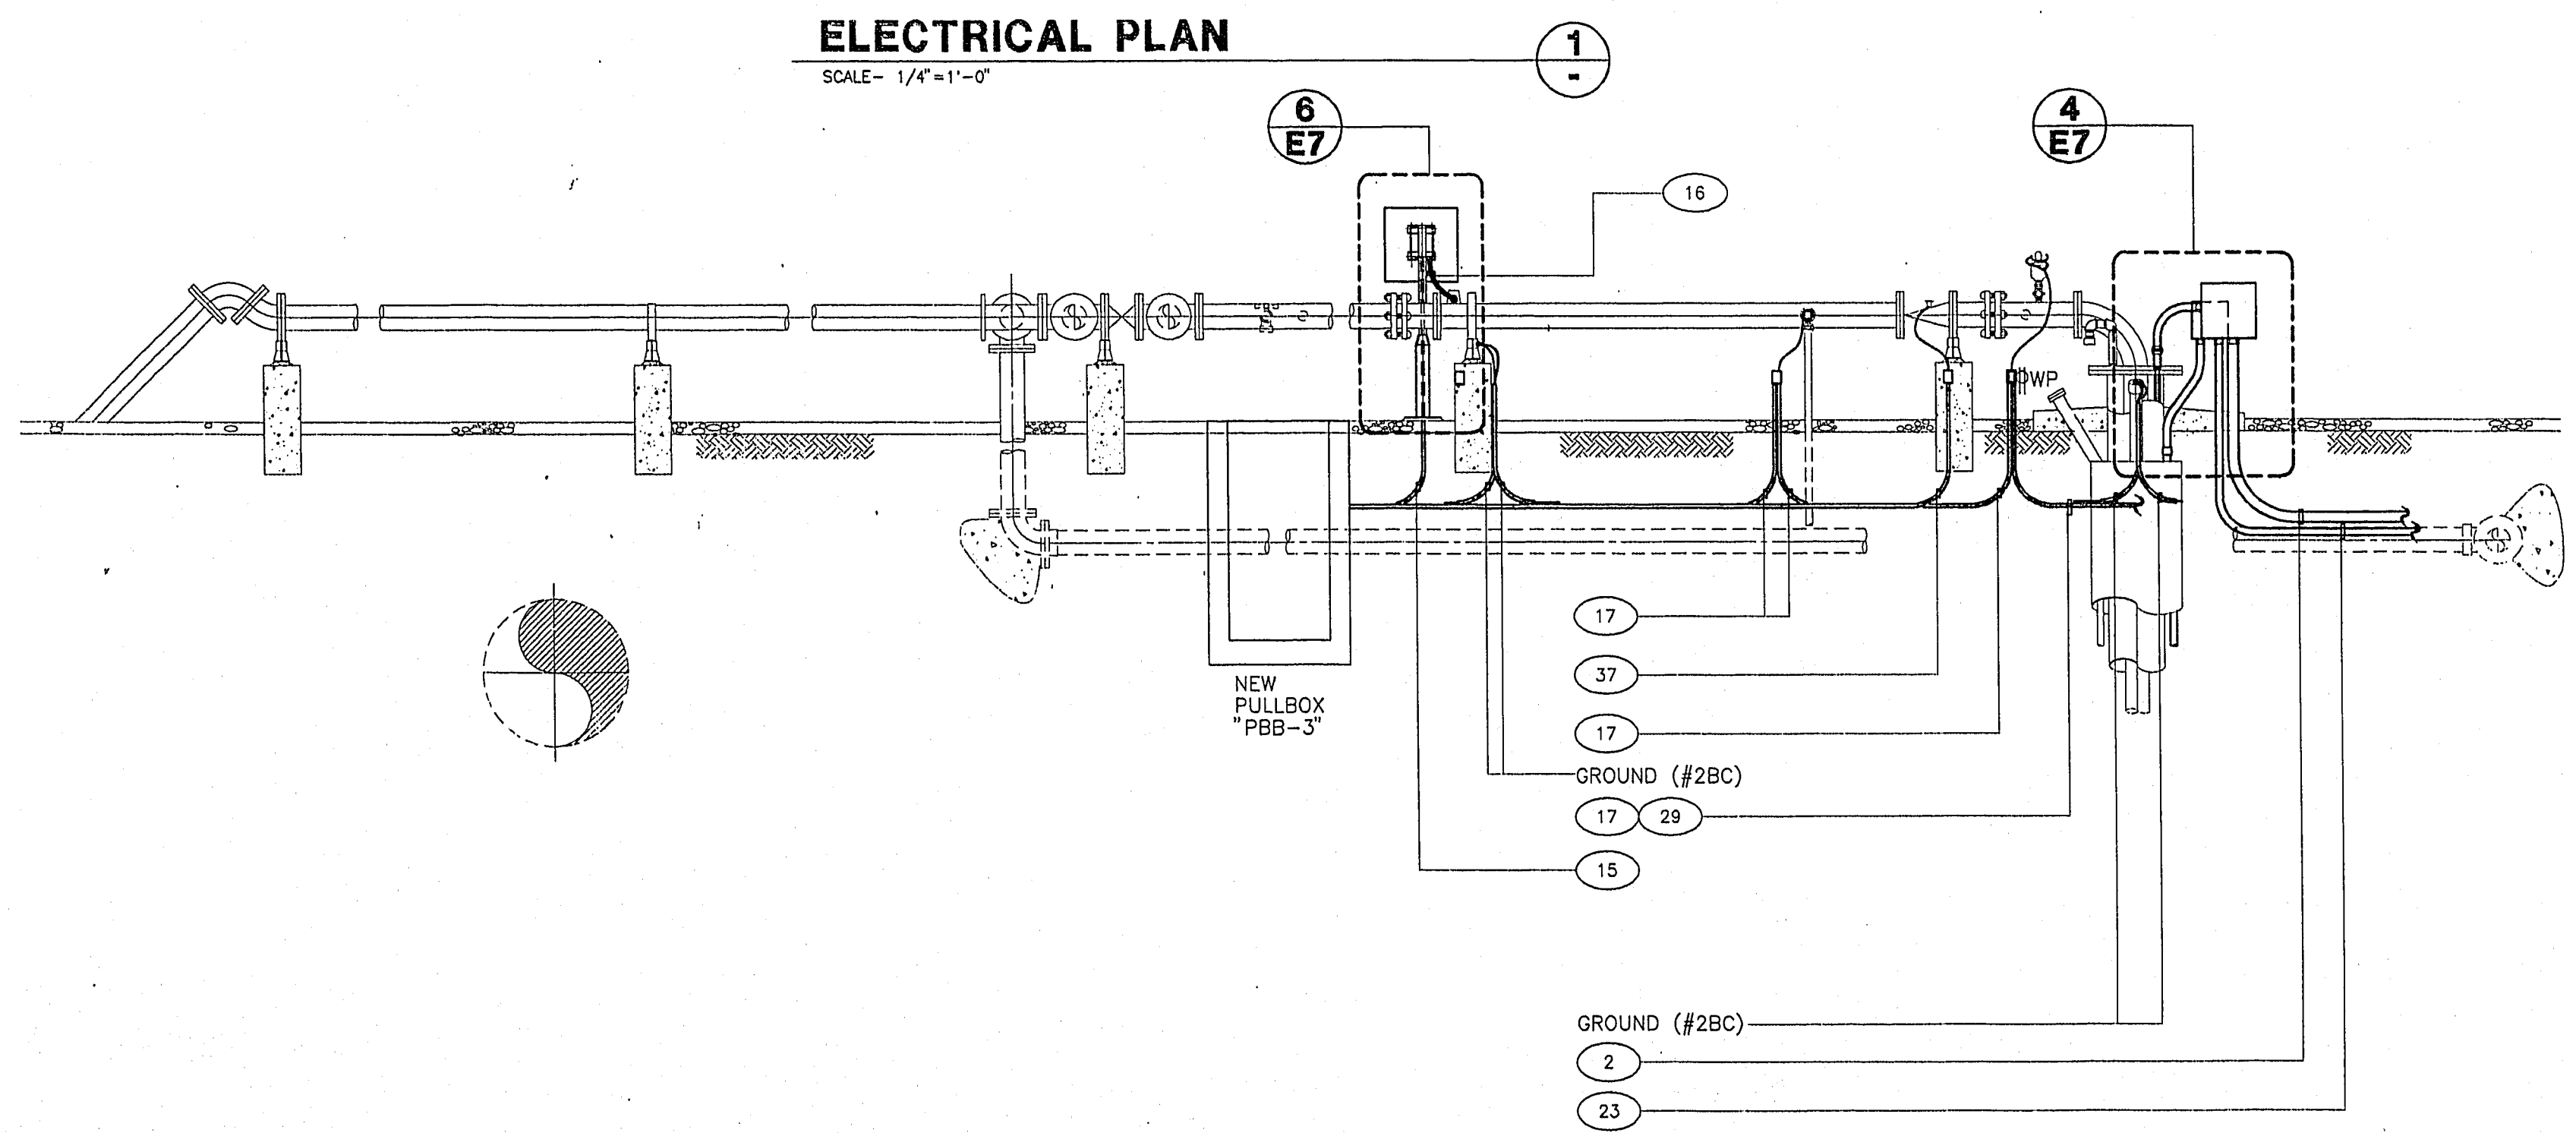

ELECTRICAL PROFILE
SCALE - 1/4" = 1'-0"

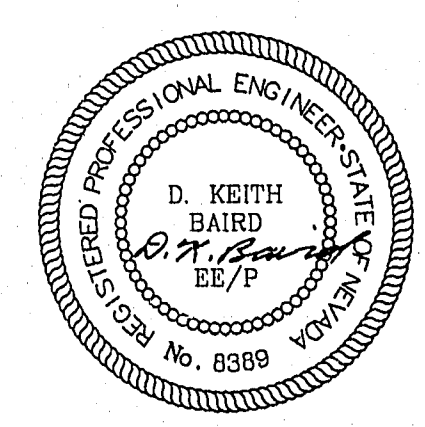

REV.	DESCRIPTION	BY	DATE	CHKD.

SCALE:
HORIZ.
NOTED
VERT.
NONE

FILE NAME: C0717E05.DWG DATE: 08/01/94

DRAWN: J. E. SALDANA DATE: 08/01/94

CHECKED: D.K.B. DATE: 08/01/94

RECOMMENDED
JAVIER O. ARCEO
APPROVED
D. Keith Baird
D. KEITH BAIRD
8389
R.P.E. NO. 12-13-94
DATE

LAS VEGAS VALLEY WATER DISTRICT
3700 WEST CHARLESTON BOULEVARD
LAS VEGAS, NEVADA

EQUIP WELL No.s 96 AND 97
WELL No. 96 ELECTRICAL PLAN,
PROFILE AT WELL SITE

DRAWING NUMBER
717
REF. SHEET NO. 15
SHEET 18 OF 32