
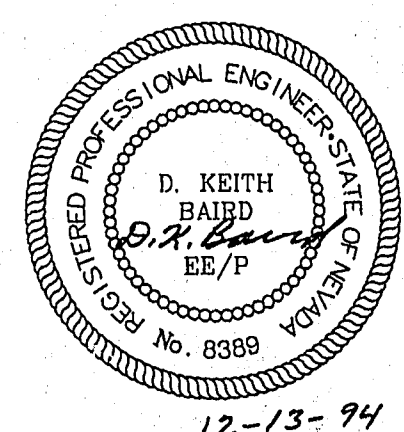
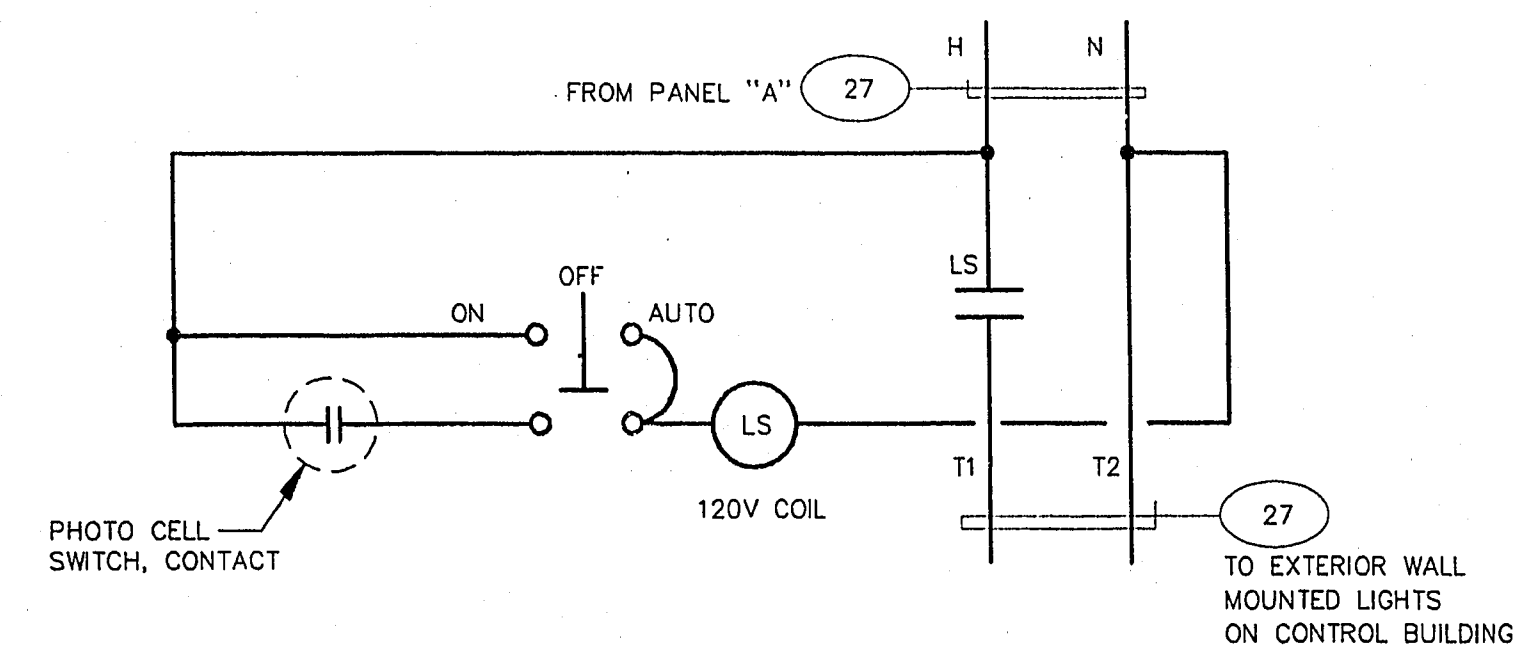


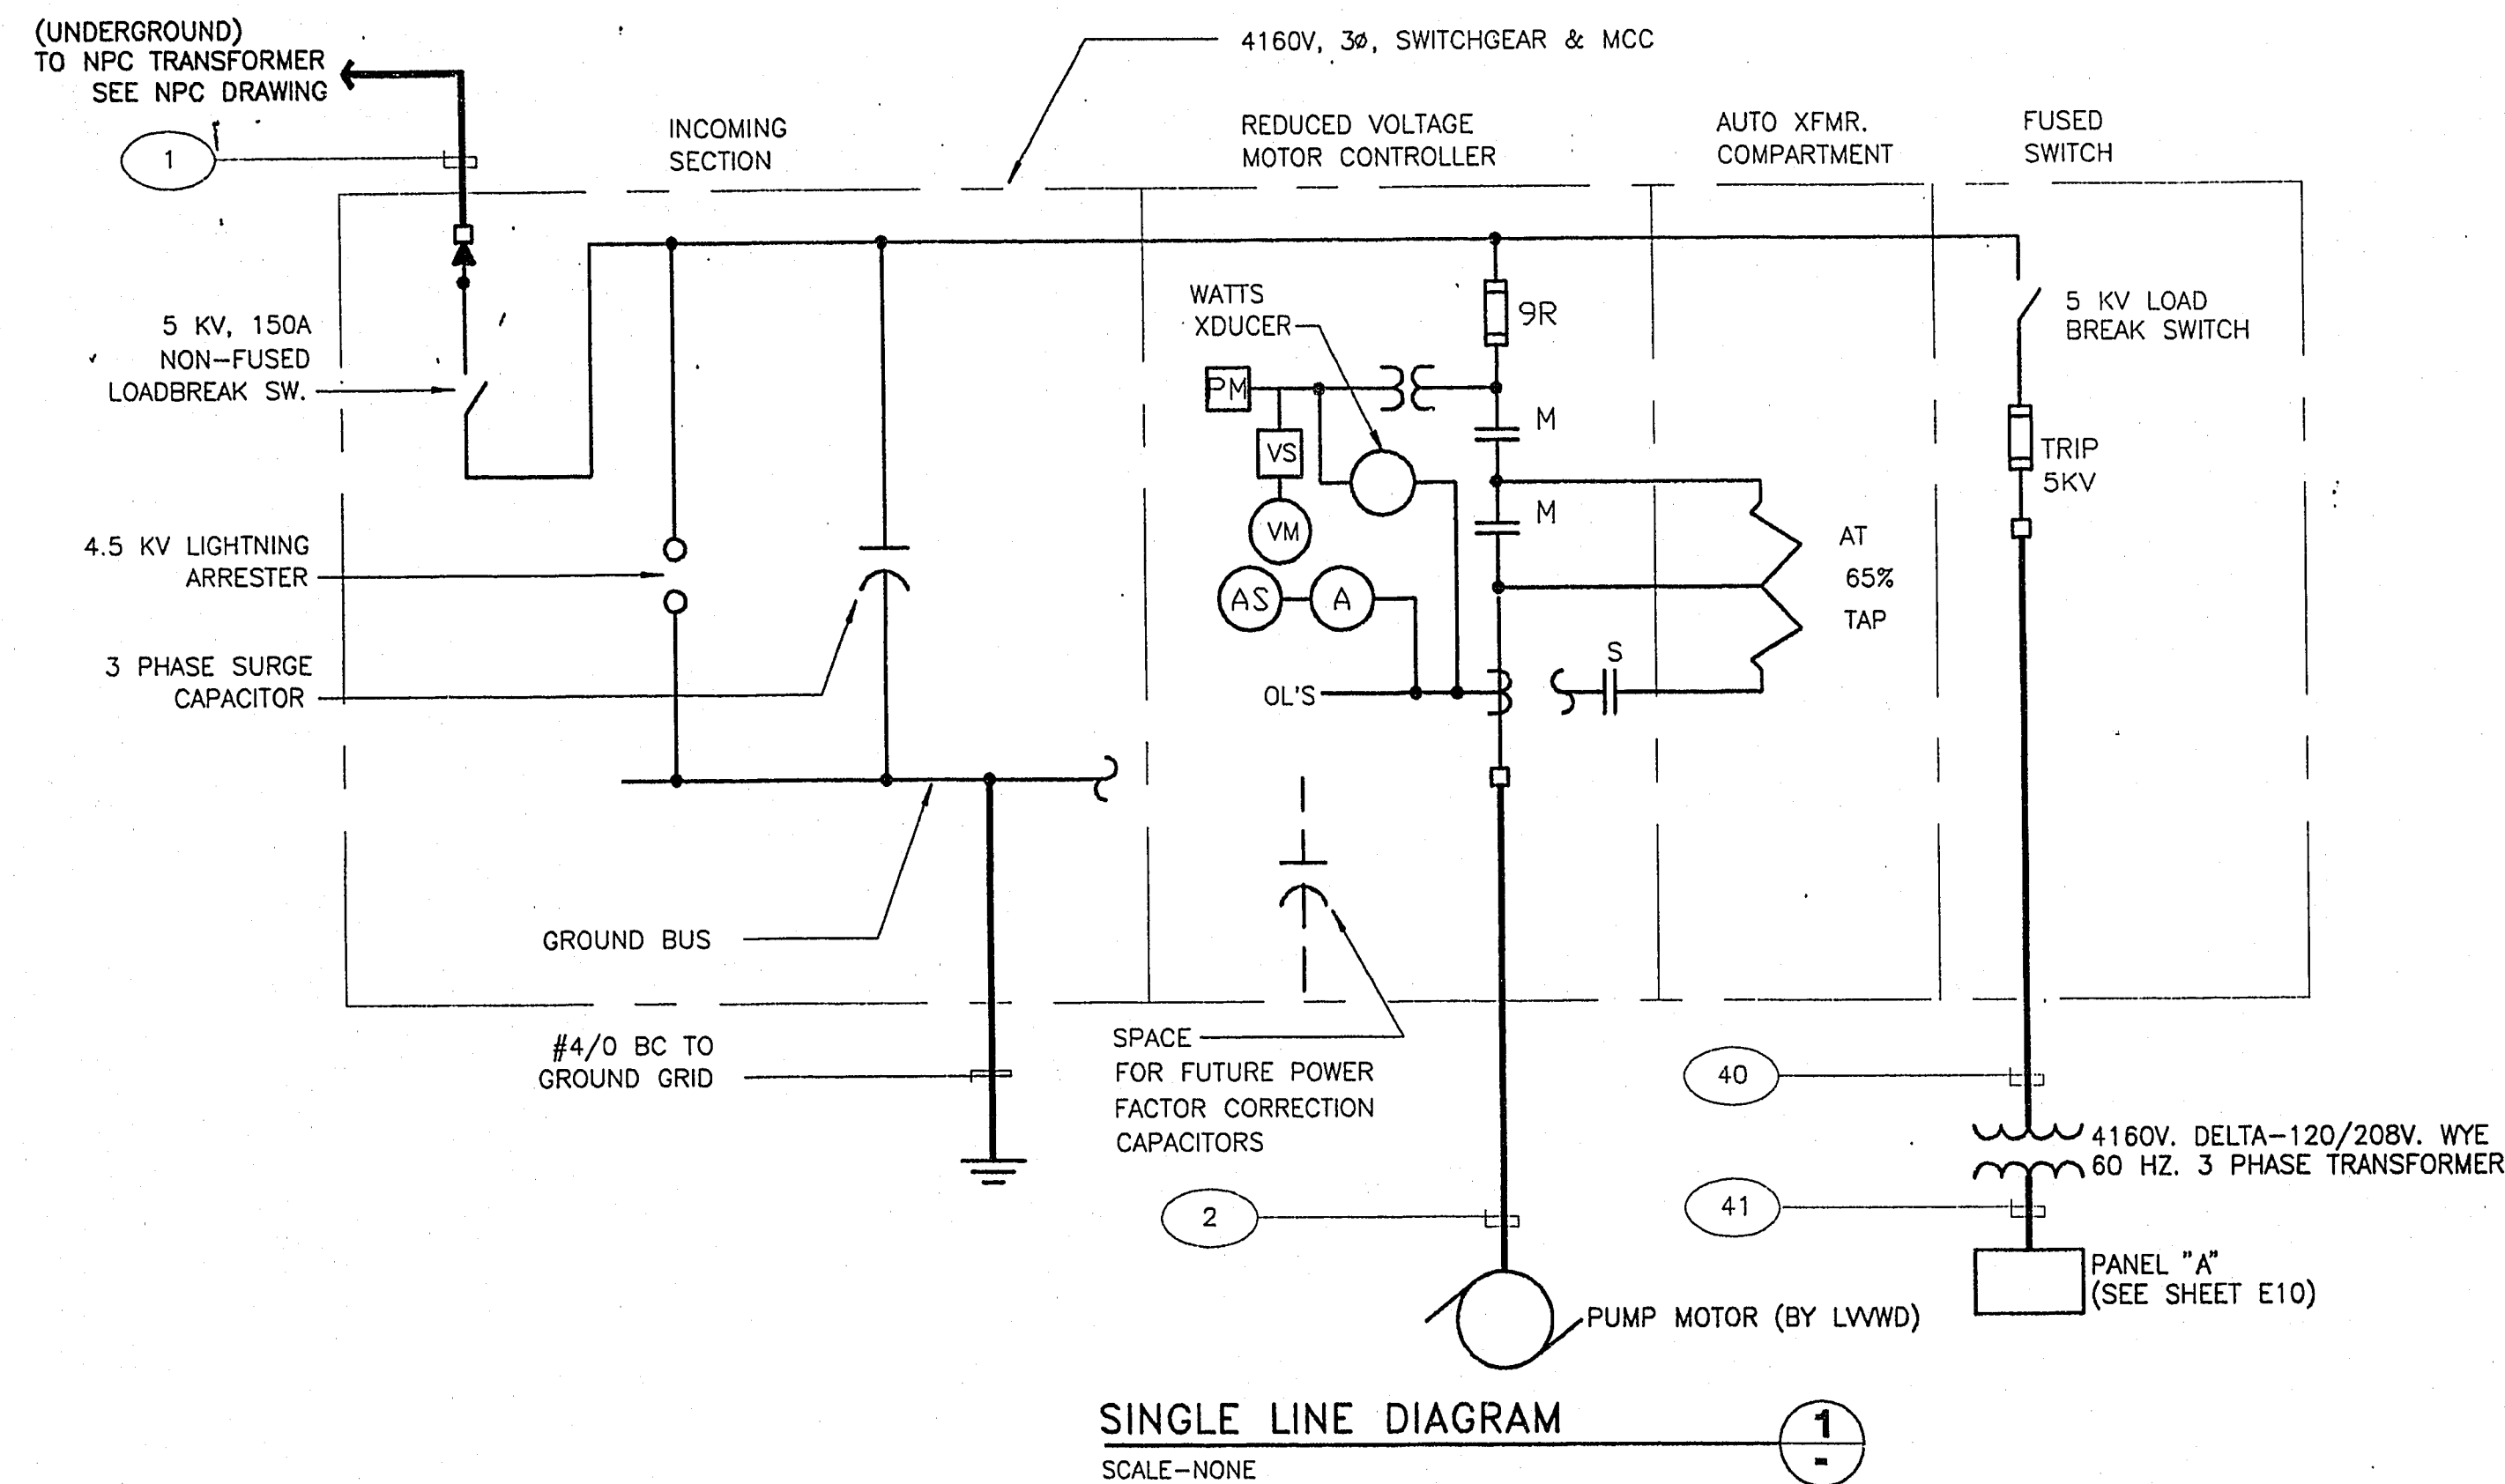

12-13-94

SCALE: HORIZ. NONE VERT. NONE	FILE NAME: C0717E06.DWG DATE: 08/14/94	RECOMMENDED JAVIER O. ARCEO R.P.F. NO. DATE
DRAWN: J. E. SALDANA DATE: 08/14/94	CHECKED: D.K.B. DATE: 08/15/94	APPROVED D. Keith Baird 8389 12-13-94 D. Keith Baird R.P.F. NO. DATE

LAS VEGAS VALLEY WATER DISTRICT
3700 WEST CHARLESTON BOULEVARD
LAS VEGAS, NEVADA

EQUIP WELL No.s 96 AND 97
WELL No.s 96 AND 97 SCHEMATIC DIAGRAMS,
SINGLE LINE DIAGRAM

DRAWING NUMBER
717
REF. SHEET NO. 66
SHEET 20 OF 32