


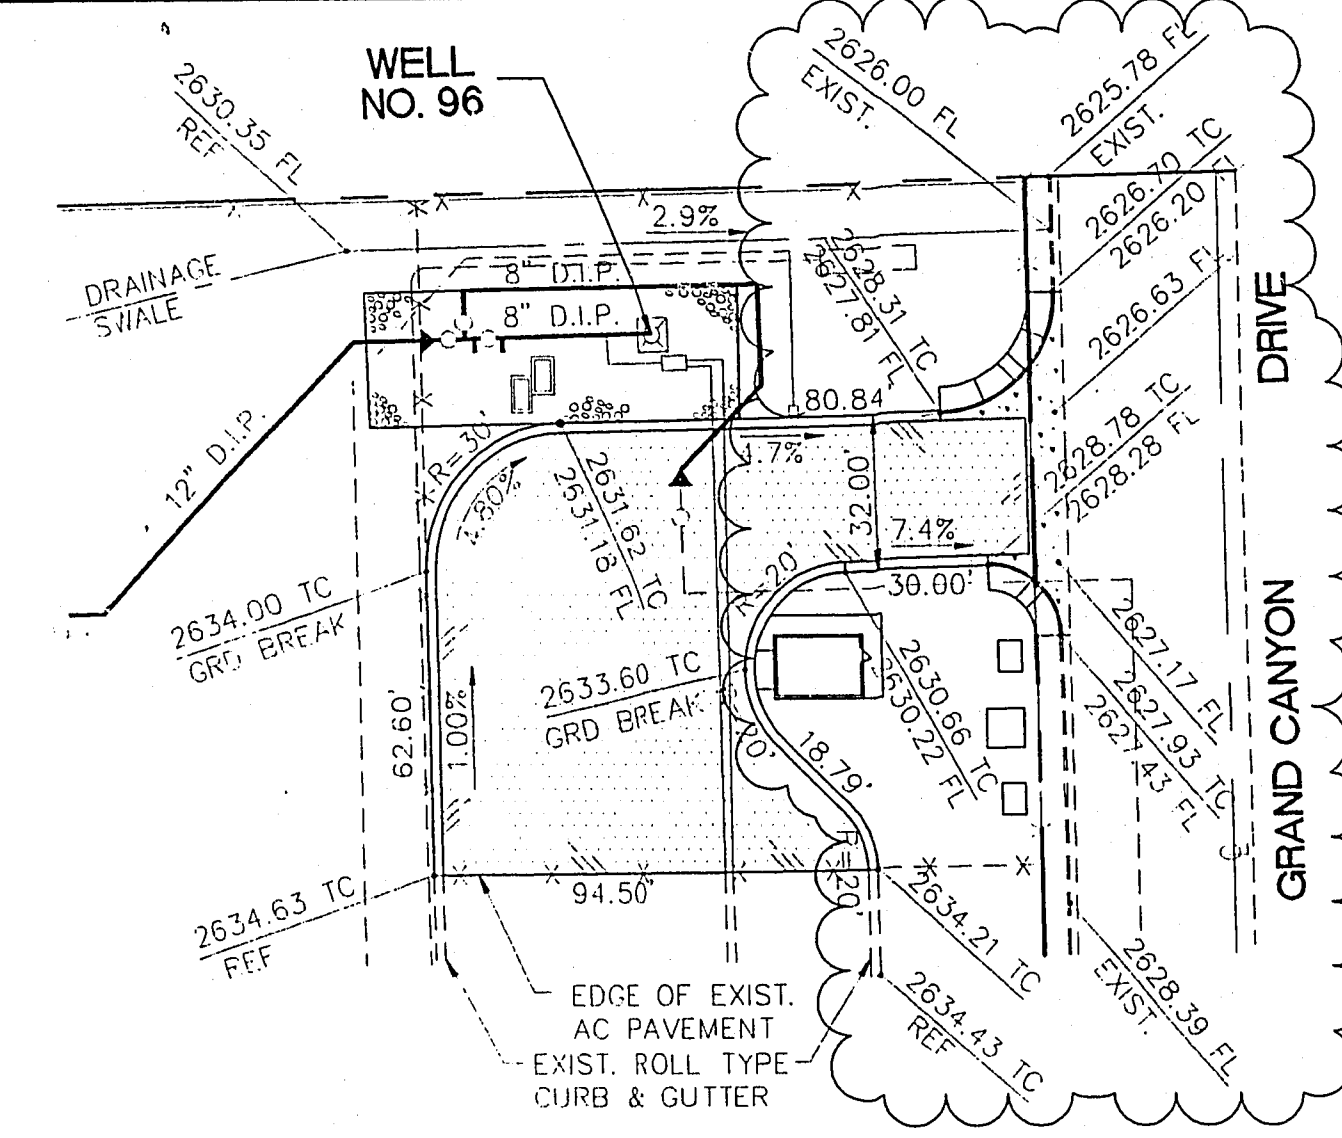

2'-0" TYP.

SLOPE

SUMP DRAIN PIPE

4" THICK CONCRETE TRANSITION

SLOPE

ROLL TYPE CURB AND GUTTER

1

5"

2'-0"

5"

NO. 2424 W/ ARMOR FRAME, BROOKS NO. 2424-105, AND GALV. STEEL TRAFFIC GRATE, BROOKS NO. 2424 OR APPROVED EQUAL

3'-6"

4"


3'-0"

ROLL TYPE CURB AND GUTTER

SECTION 1

B.M. CO015DI, LOCATED ON THE POWER POLE #55 @ THE SOUTHEAST CORNER OF THE INTERSECTION OF CHEYENNE AVE & BUFFALO DRIVE, ELEV. 2364.05 C.C.E.D. DATUM

NOTE: THE CONTRACTOR SHALL REMOVE AND DISPOSE OF THE EARTHEN PAD IN THE VICINITY OF WELL NO. 96, WHICH WAS CONSTRUCTED BY THE WELL DRILLING CONTRACTOR, AND PERFORM NECESSARY GRADING TO ACHIEVE THE FINAL GRADES AS SHOWN ON THE DRAWINGS.

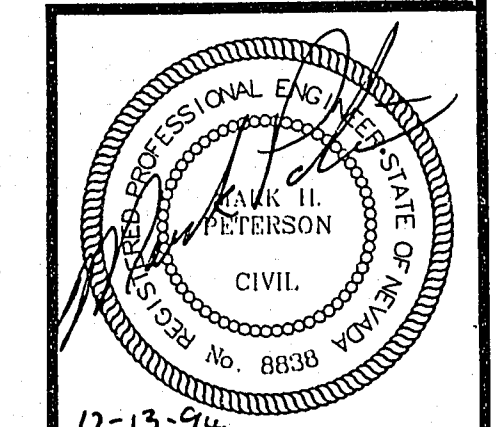

DRAWING NUMBER
717
REF. SHEET NO. C3
SHEET 3 OF 32

A	CHANGED PER CITY OF LAS VEGAS	MJD	1/95	SCALE: 1"=40'	FILE NWE: C0717C03.DWG	DATE: 07/21/94	RECOMMENDED
					DRAWN: F.P.A./P.J./S.M.	DATE: 07/21/94	JOSEPH Y. LIN R.P.E. NO. DATE
REV.	DESCRIPTION	BY	DATE	CHK'D	CHECKED: J.Y.L.	DATE: 07/21/94	APPROVED  MARK H. PETERSON 8838 R.P.E. NO. 12-13-94 DATE

LAS VEGAS VALLEY WATER DISTRICT
3700 WEST CHARLESTON BOULEVARD
LAS VEGAS, NEVADA

*EQUIP WELL NOS. 96 AND 97
WELL NO. 96 SITE PLAN
AND WELL NO. 96 GRADING PLAN*