



ITEM	DESCRIPTION	SPEC DIV/SEC	ITEM	DESCRIPTION	SPEC DIV/SEC
1	ACO PRECAST VINYLESTER RESIN CONCRETE CHEM SAFE DOUBLE TRENCH DRAIN	6209	20	2" CPVC 90° ELBOW	4204B
2	SPLIT FACED 8" x 8" x 16" PIGMENTED CMU WALLS, SOLID GROUT ALL CELLS	AS NOTED	21	2" CPVC PIPE	4204B
3	CONTRACTOR TO SUBMIT COLOR SAMPLES		22	4" CPVC CAP	4204B
4	AIR CONDITIONER / HEAT PUMP	4302	23	22" Ø MANWAY	
5	INSULATED STEEL ROLLING SERVICE DOOR WITH WEATHER SEALS AND MANUAL CHAIN OPERATOR	6209	24	5'-0" x 8'-8" CONCRETE PAD, SEE SHT. C26	DIV. 16
6	LMI METERING PUMP	4202C	25	WATER SUPPLY BOOSTER PUMP, WITH CONCRETE PAD	4203B
7	1" CPVC TEE	4203C	26	UNISTRUT CHANNEL NO. P1000 AND CLAMP NO. P1113	AS NOTED
8	COMBINATION EYEWASH AND SHOWER ASSEMBLY	4206	27	3/8" FLEXIBLE POLYETHYLENE TUBING (PROVIDED W/LMI PUMP)	AS NOTED
9	1" TEE HEAD, CURB STOP, FORD B11-444 OR APPROVED EQUAL	AS NOTED	28	CONCRETE THRUST BLOCK, SEE LVMWD STD. PLATE #5	
10	TEMPERATURE TRANSMITTER	5117	29	CAST IRON SERVICE BOX, ADJUSTABLE, TYLER NO. 90-C OR APPVD. EQUAL	
11	SAND BAG BOTH OPENINGS OF THE C.I. SERVICE BOX	AS NOTED	30	1" SCH 80 CPVC CHLORINE SOLUTION LINE, SEE SHT. C4	4204B
12	48" x 60" TALL SODIUM HYPOCHLORITE TANK	4202D	31	2" SCH 80 PVC PIPE SLEEVE	4203C
13	1" BRONZE 90° ELBOW	620B	32	ROOF VENT: AIRFOIL VENT ALUMINIUM CAP WITH BIRDPROOF SCREEN	6213
14	1" COPPER WATER SUPPLY, SEE SHT. C3	4203C	33	FAN EXHAUSTER ELECTRICALLY OPERATED AND CONNECTED TO THE FAN, 2 FT. X 2 FT. FREE AREA LOUVERED VENT W/INSECT SCREEN, BLADE AND JAMB SEALS, FACTORY MOUNTED 120V	4303 & 4304
15	4" CPVC PIPE, SCH. 80	4203C	34	2" CPVC CAP W/8-1/8" HOLES	4204B
16	4" CPVC SCH. 80 SOCKET TEE	4204B	35	4" FLOOR DRAIN, McMASTER-CARR CATALOG NO. 2411K44, SEE DETAIL 6	AS NOTED
17	4" x 2" CPVC SCH. 80, SOCKET TEE	4204B	36	SHT. C20	
18	DOUBLE WALL FIBERGLASS REINFORCED PLASTIC UNDERGROUND TANK WITH 22" MANWAY COVER, 550 GAL	4207	37	2" CAM QUICK DISCONNECT W/ 2" BALL VALVE	4204B
19	9 1/2" x 16" METER BOX WITH NO. 3-T TRAFFIC COVER, BROOKS	AS NOTED	38	4" SCH. 80 CPVC, SOCKET 45° ELBOW	4204B
20	3-SERIES OR APPROVED EQUAL				

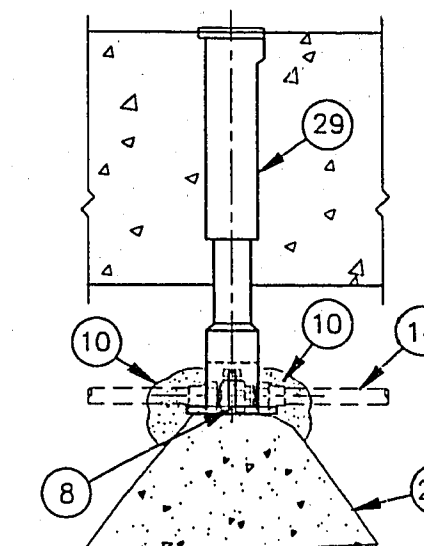


DETAIL 1
NOT TO SCALE

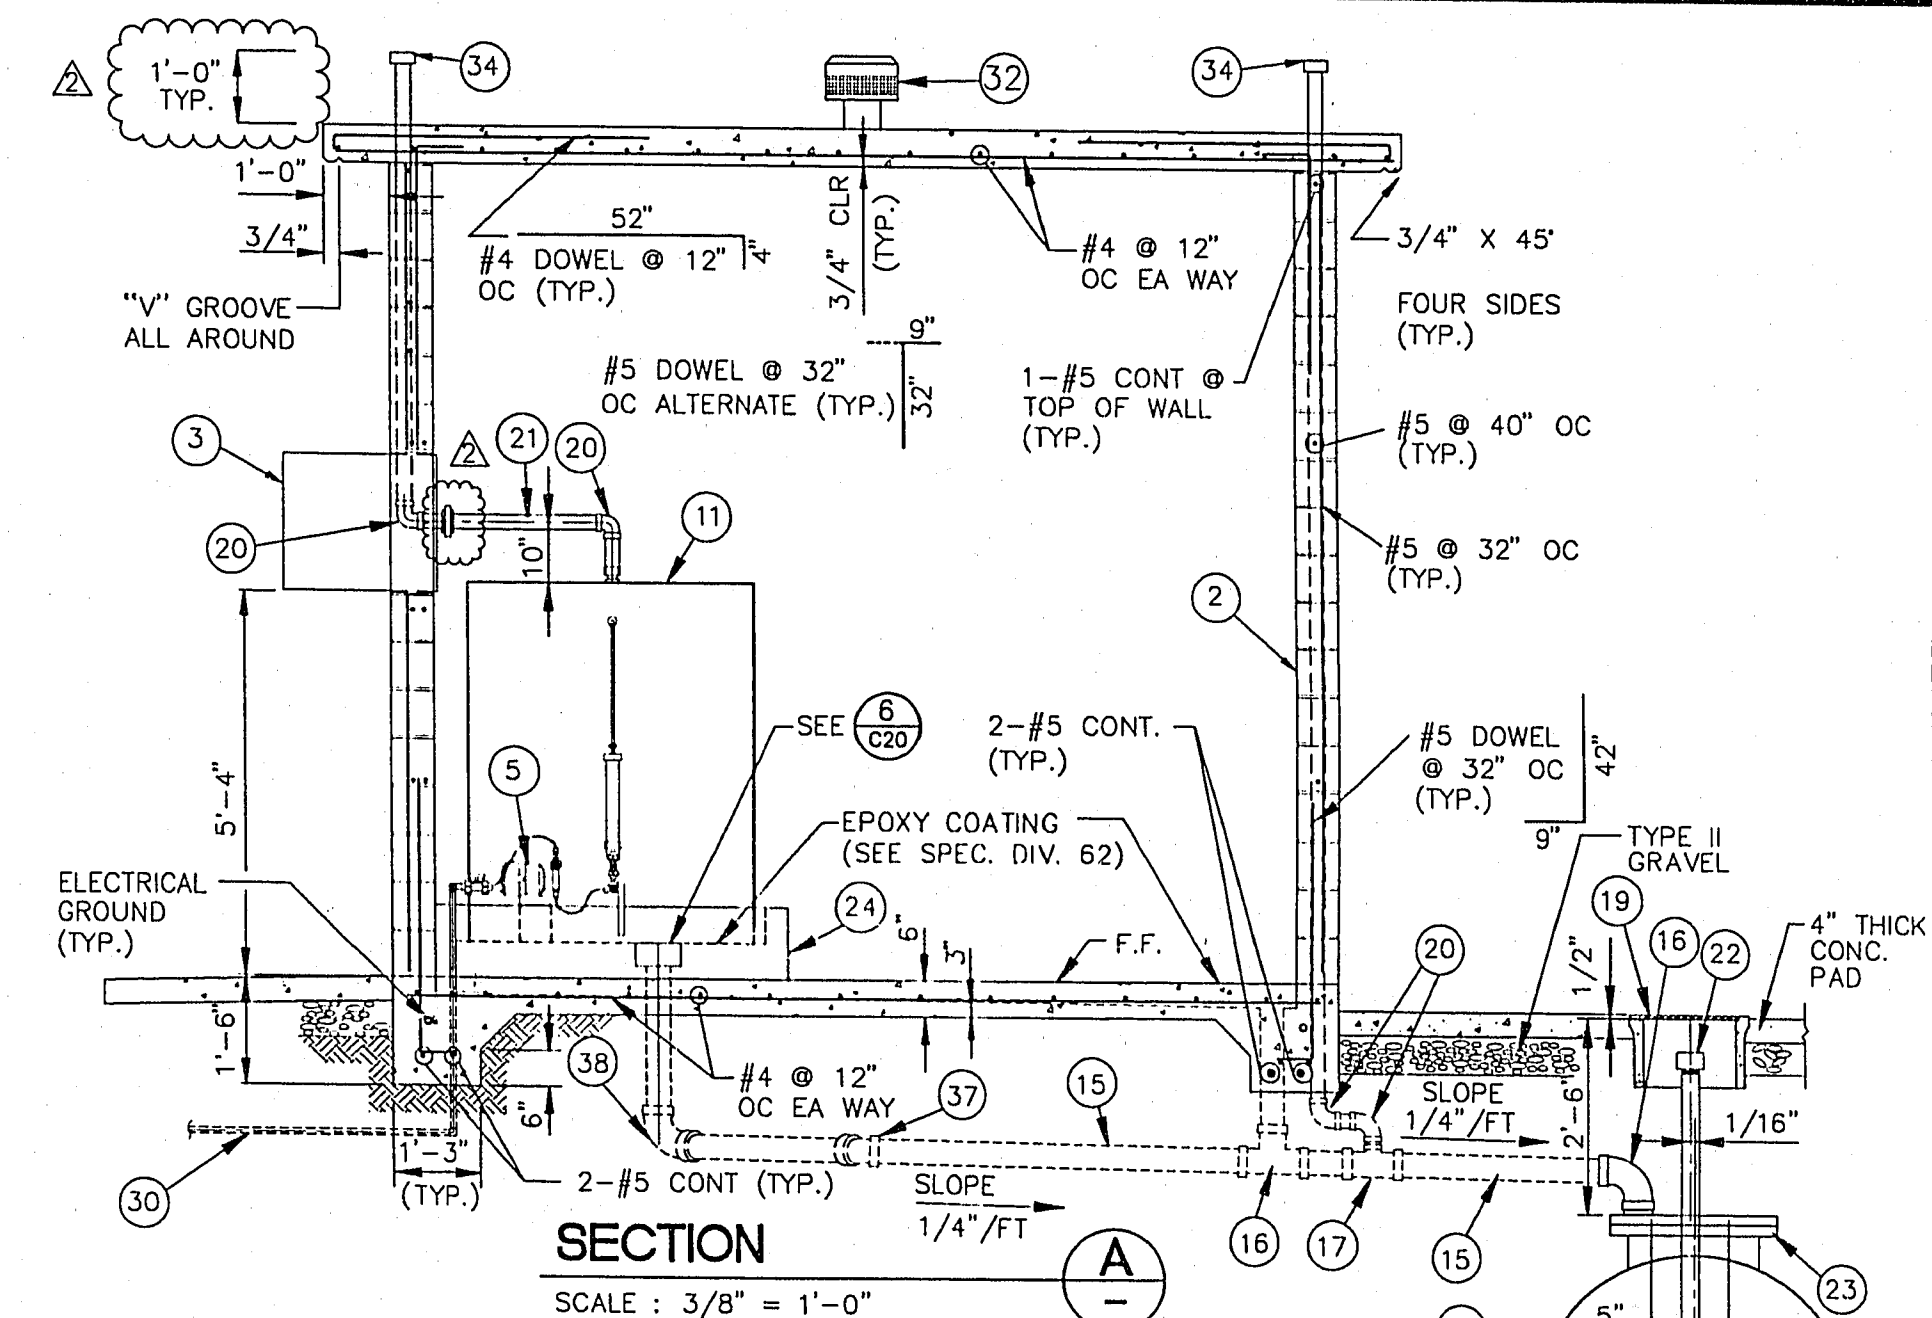


SECTION

SCALE: 3/8" = 1'-0"

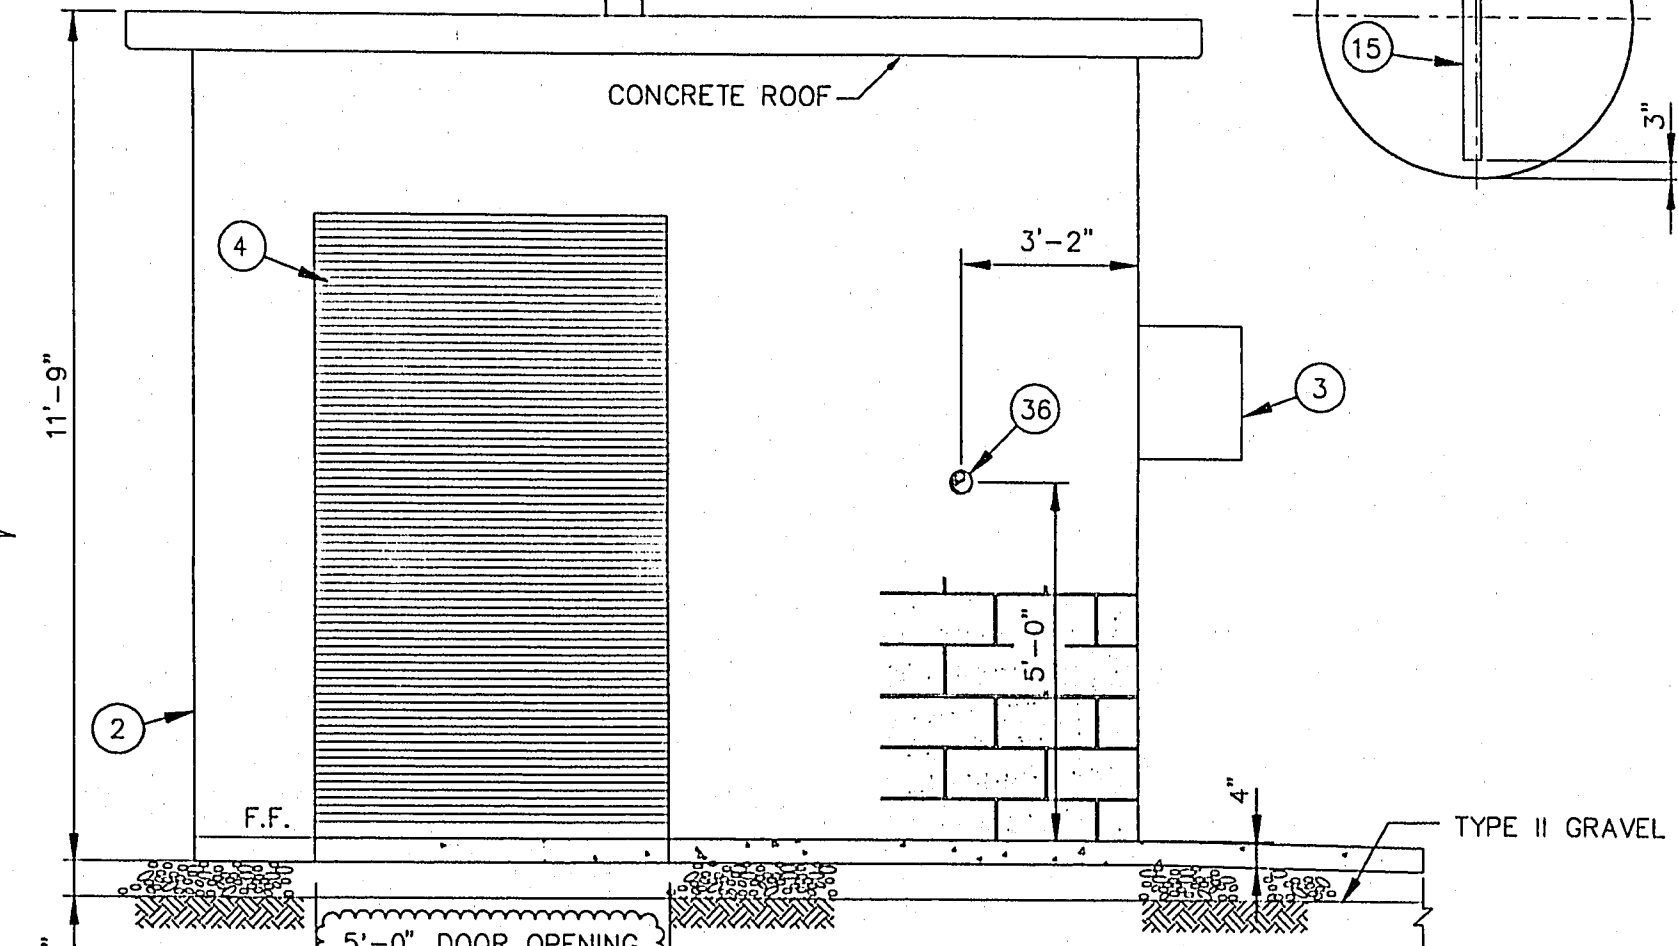


ELEVATION

SCALE: 3/8" = 1'-0"

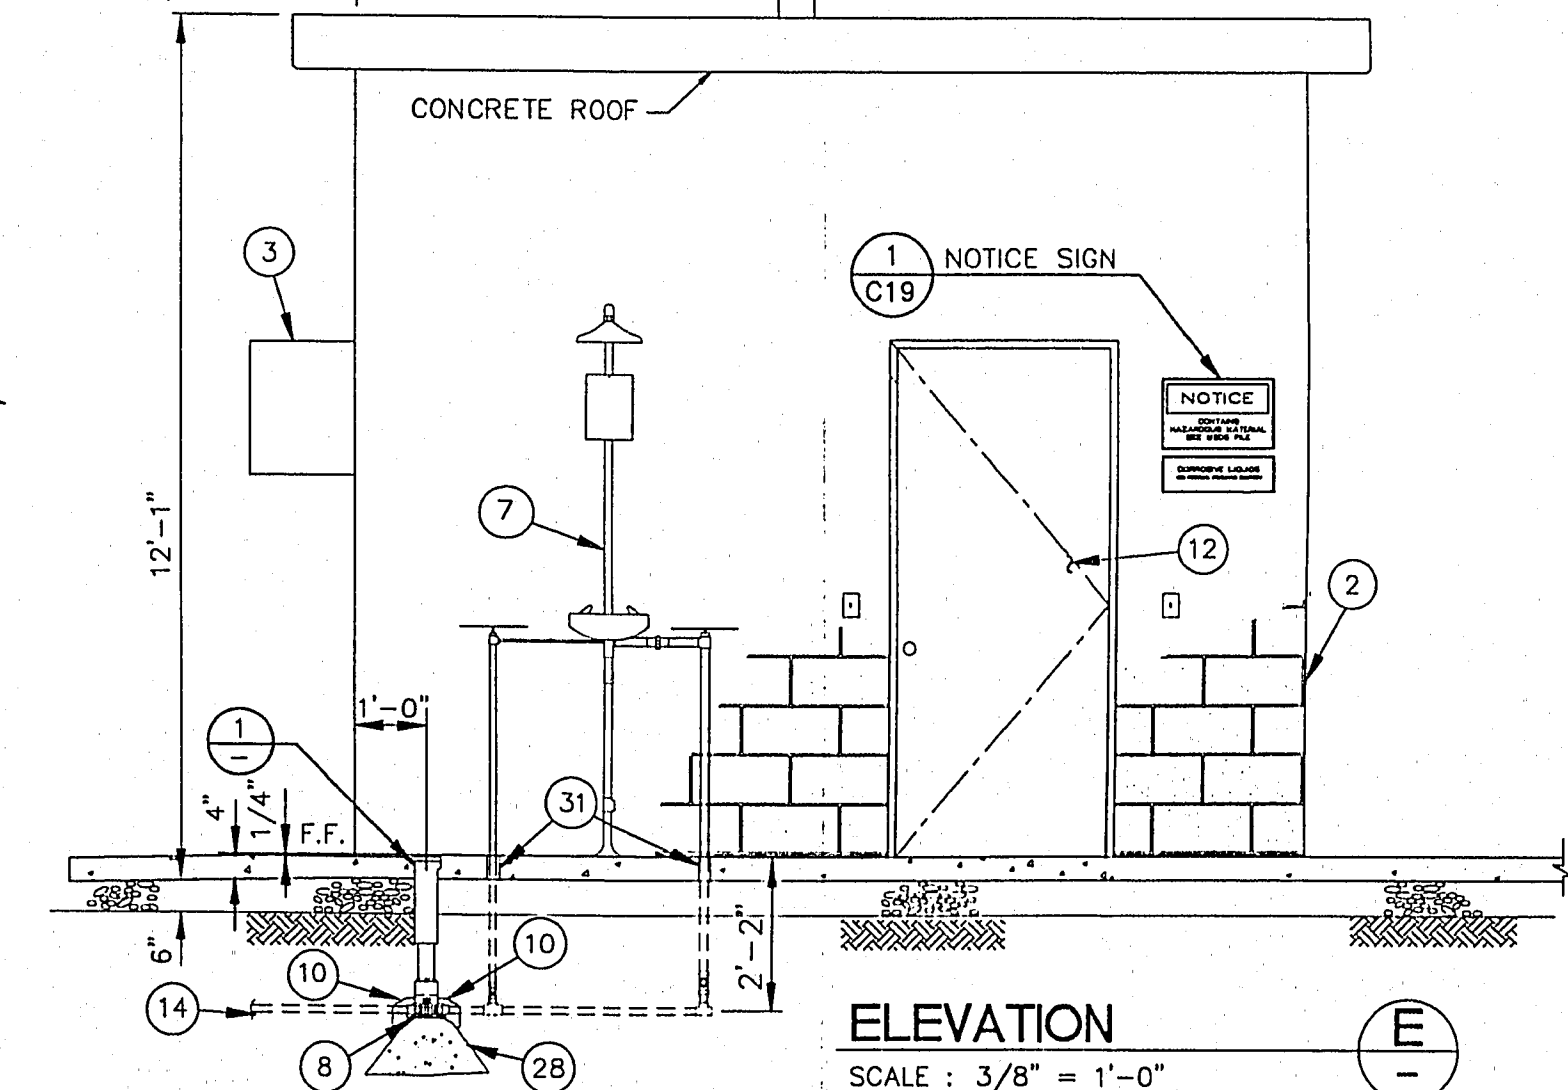


ELEVATION

SCALE: 3/8" = 1'-0"

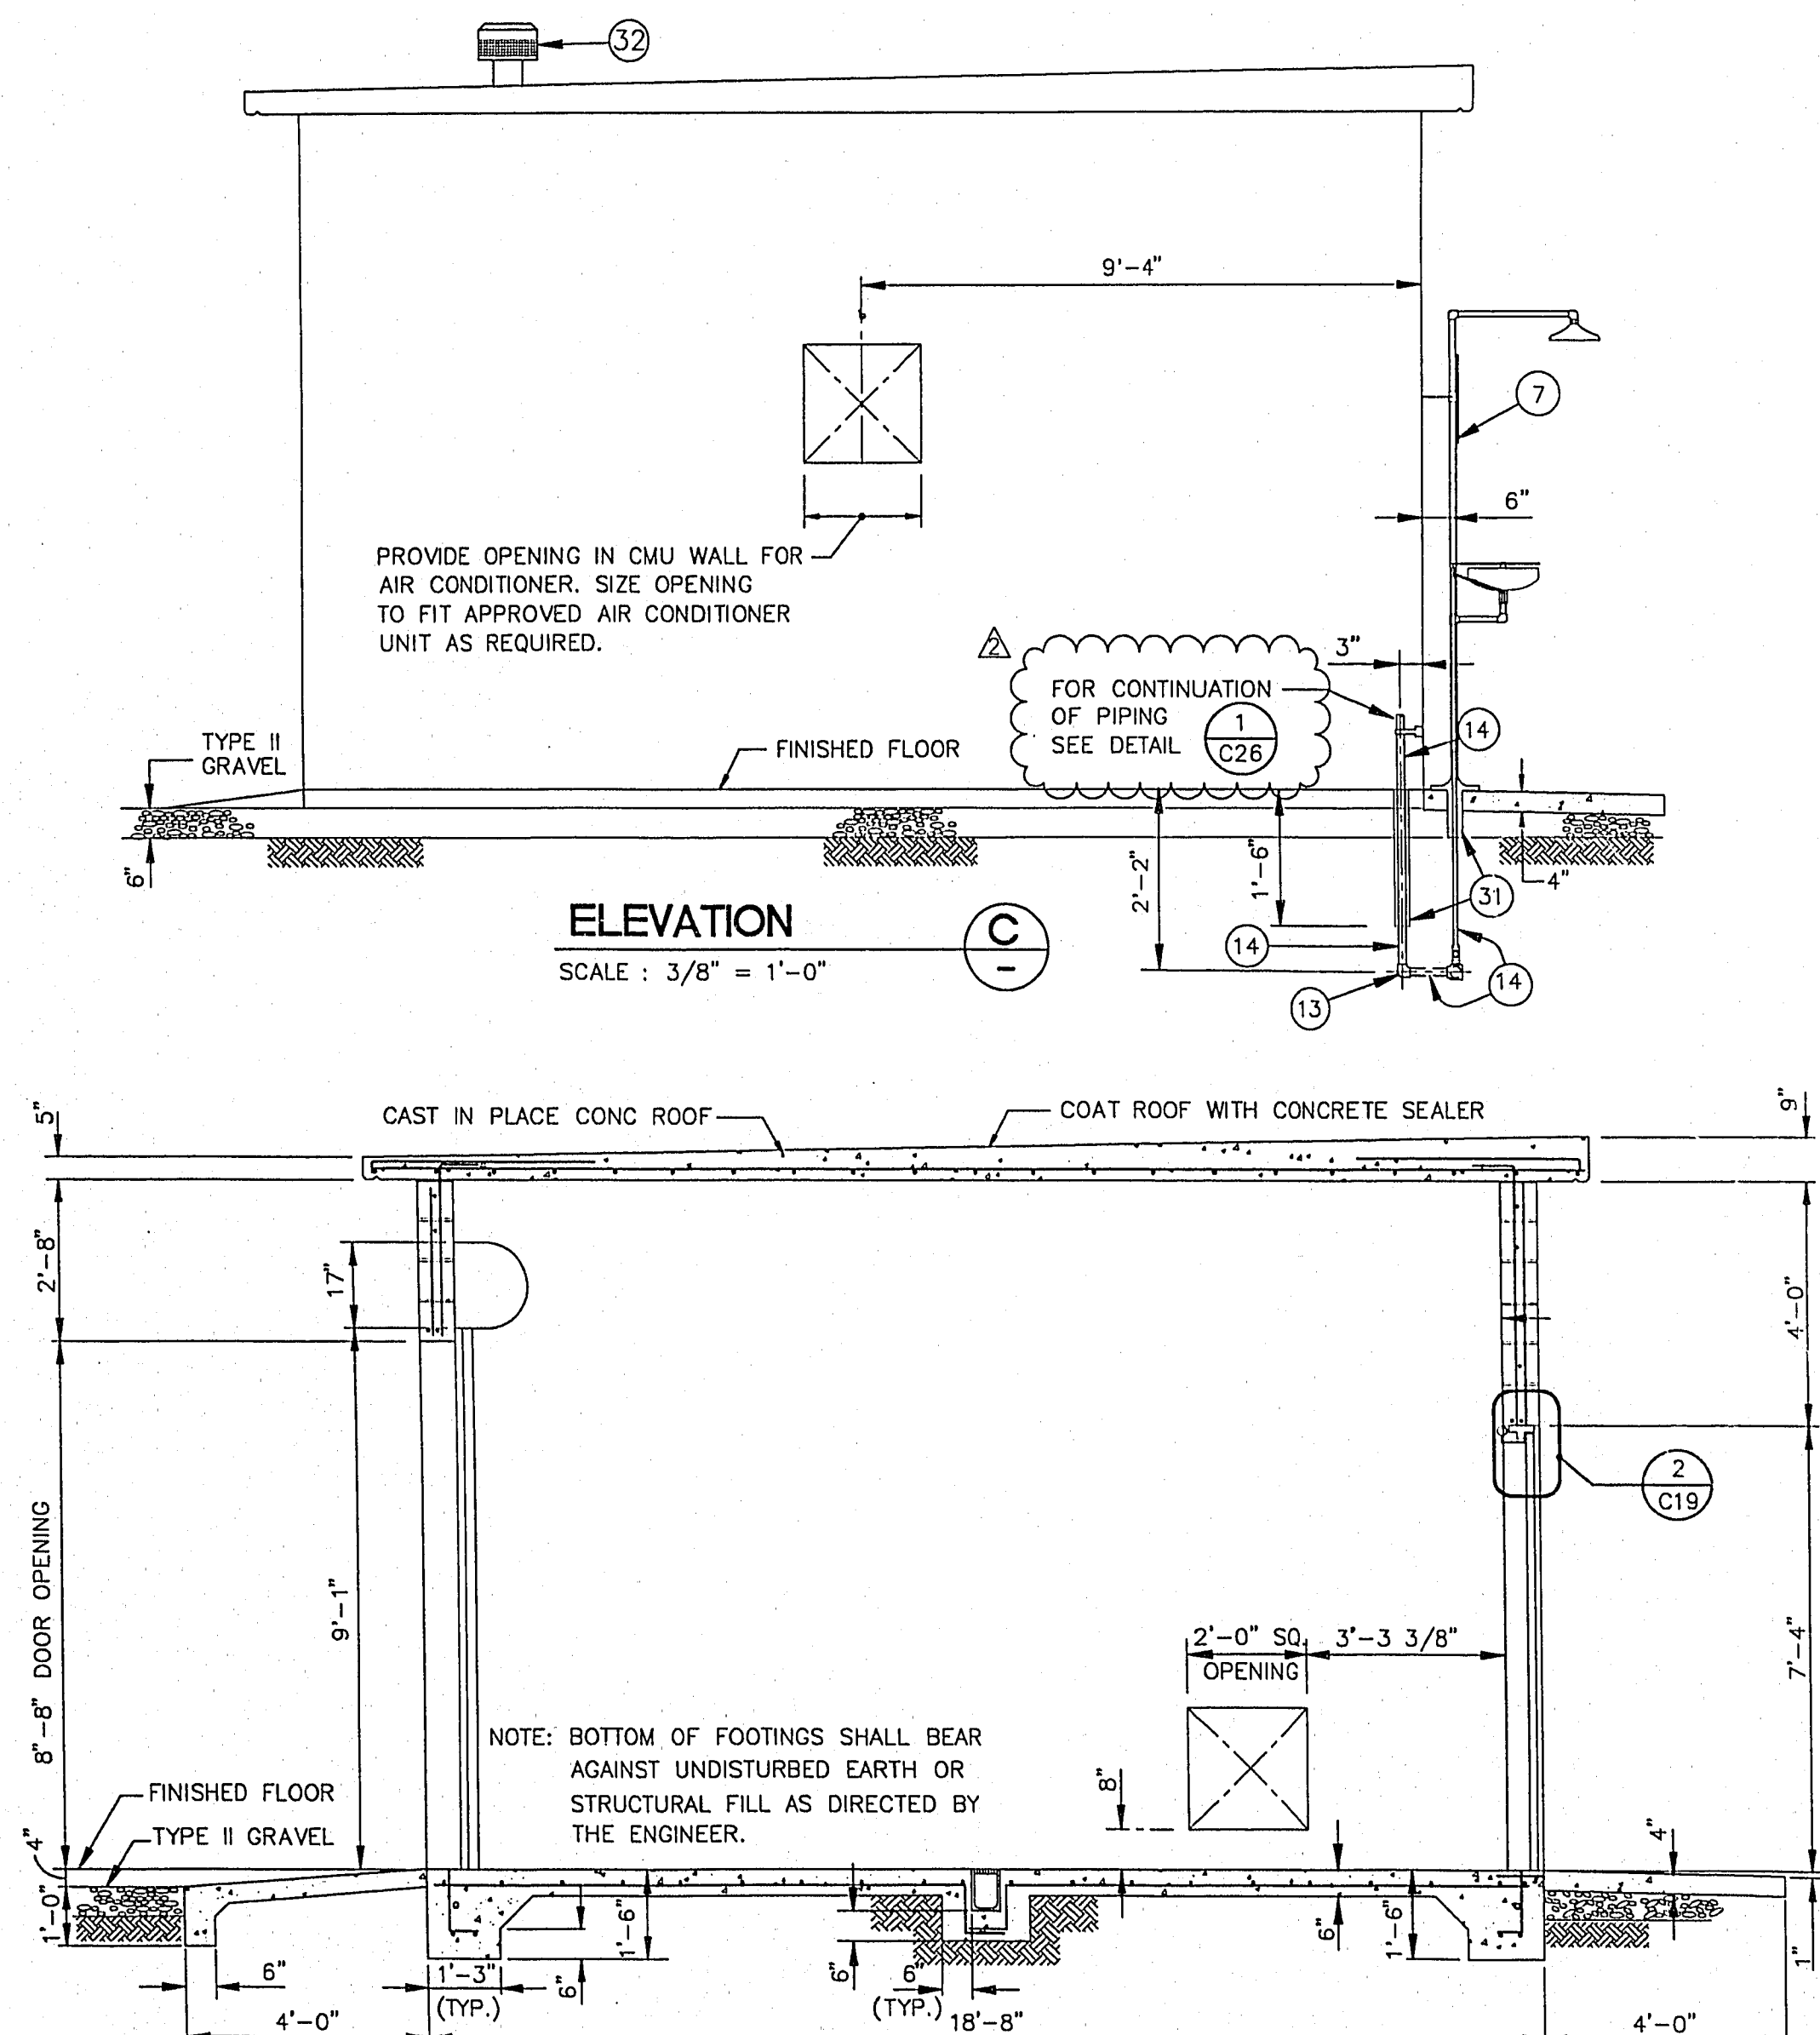


ELEVATION

SCALE: 3/8" = 1'-0"

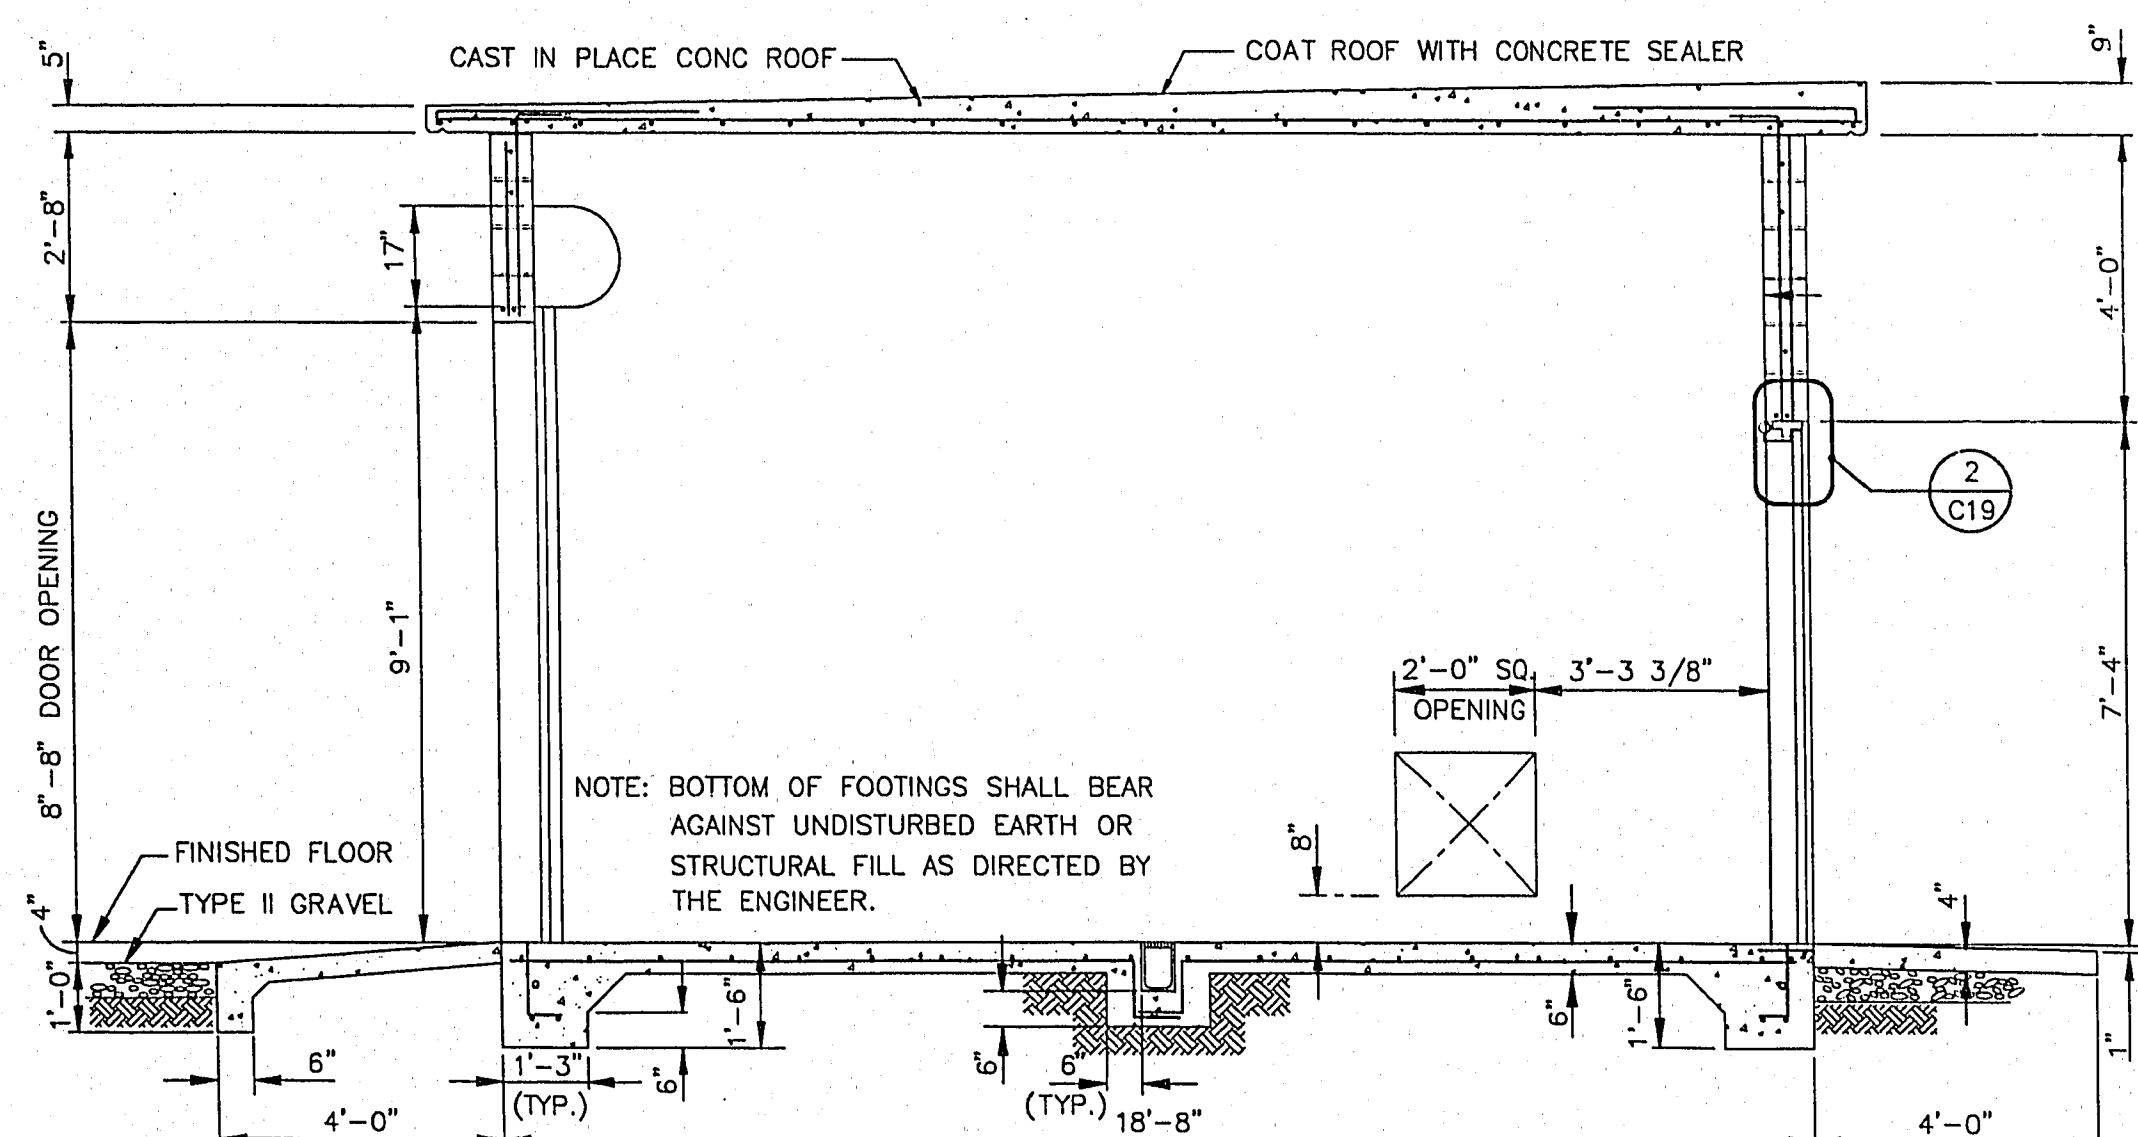

SECTION

SCALE: 3/8" = 1'-0"

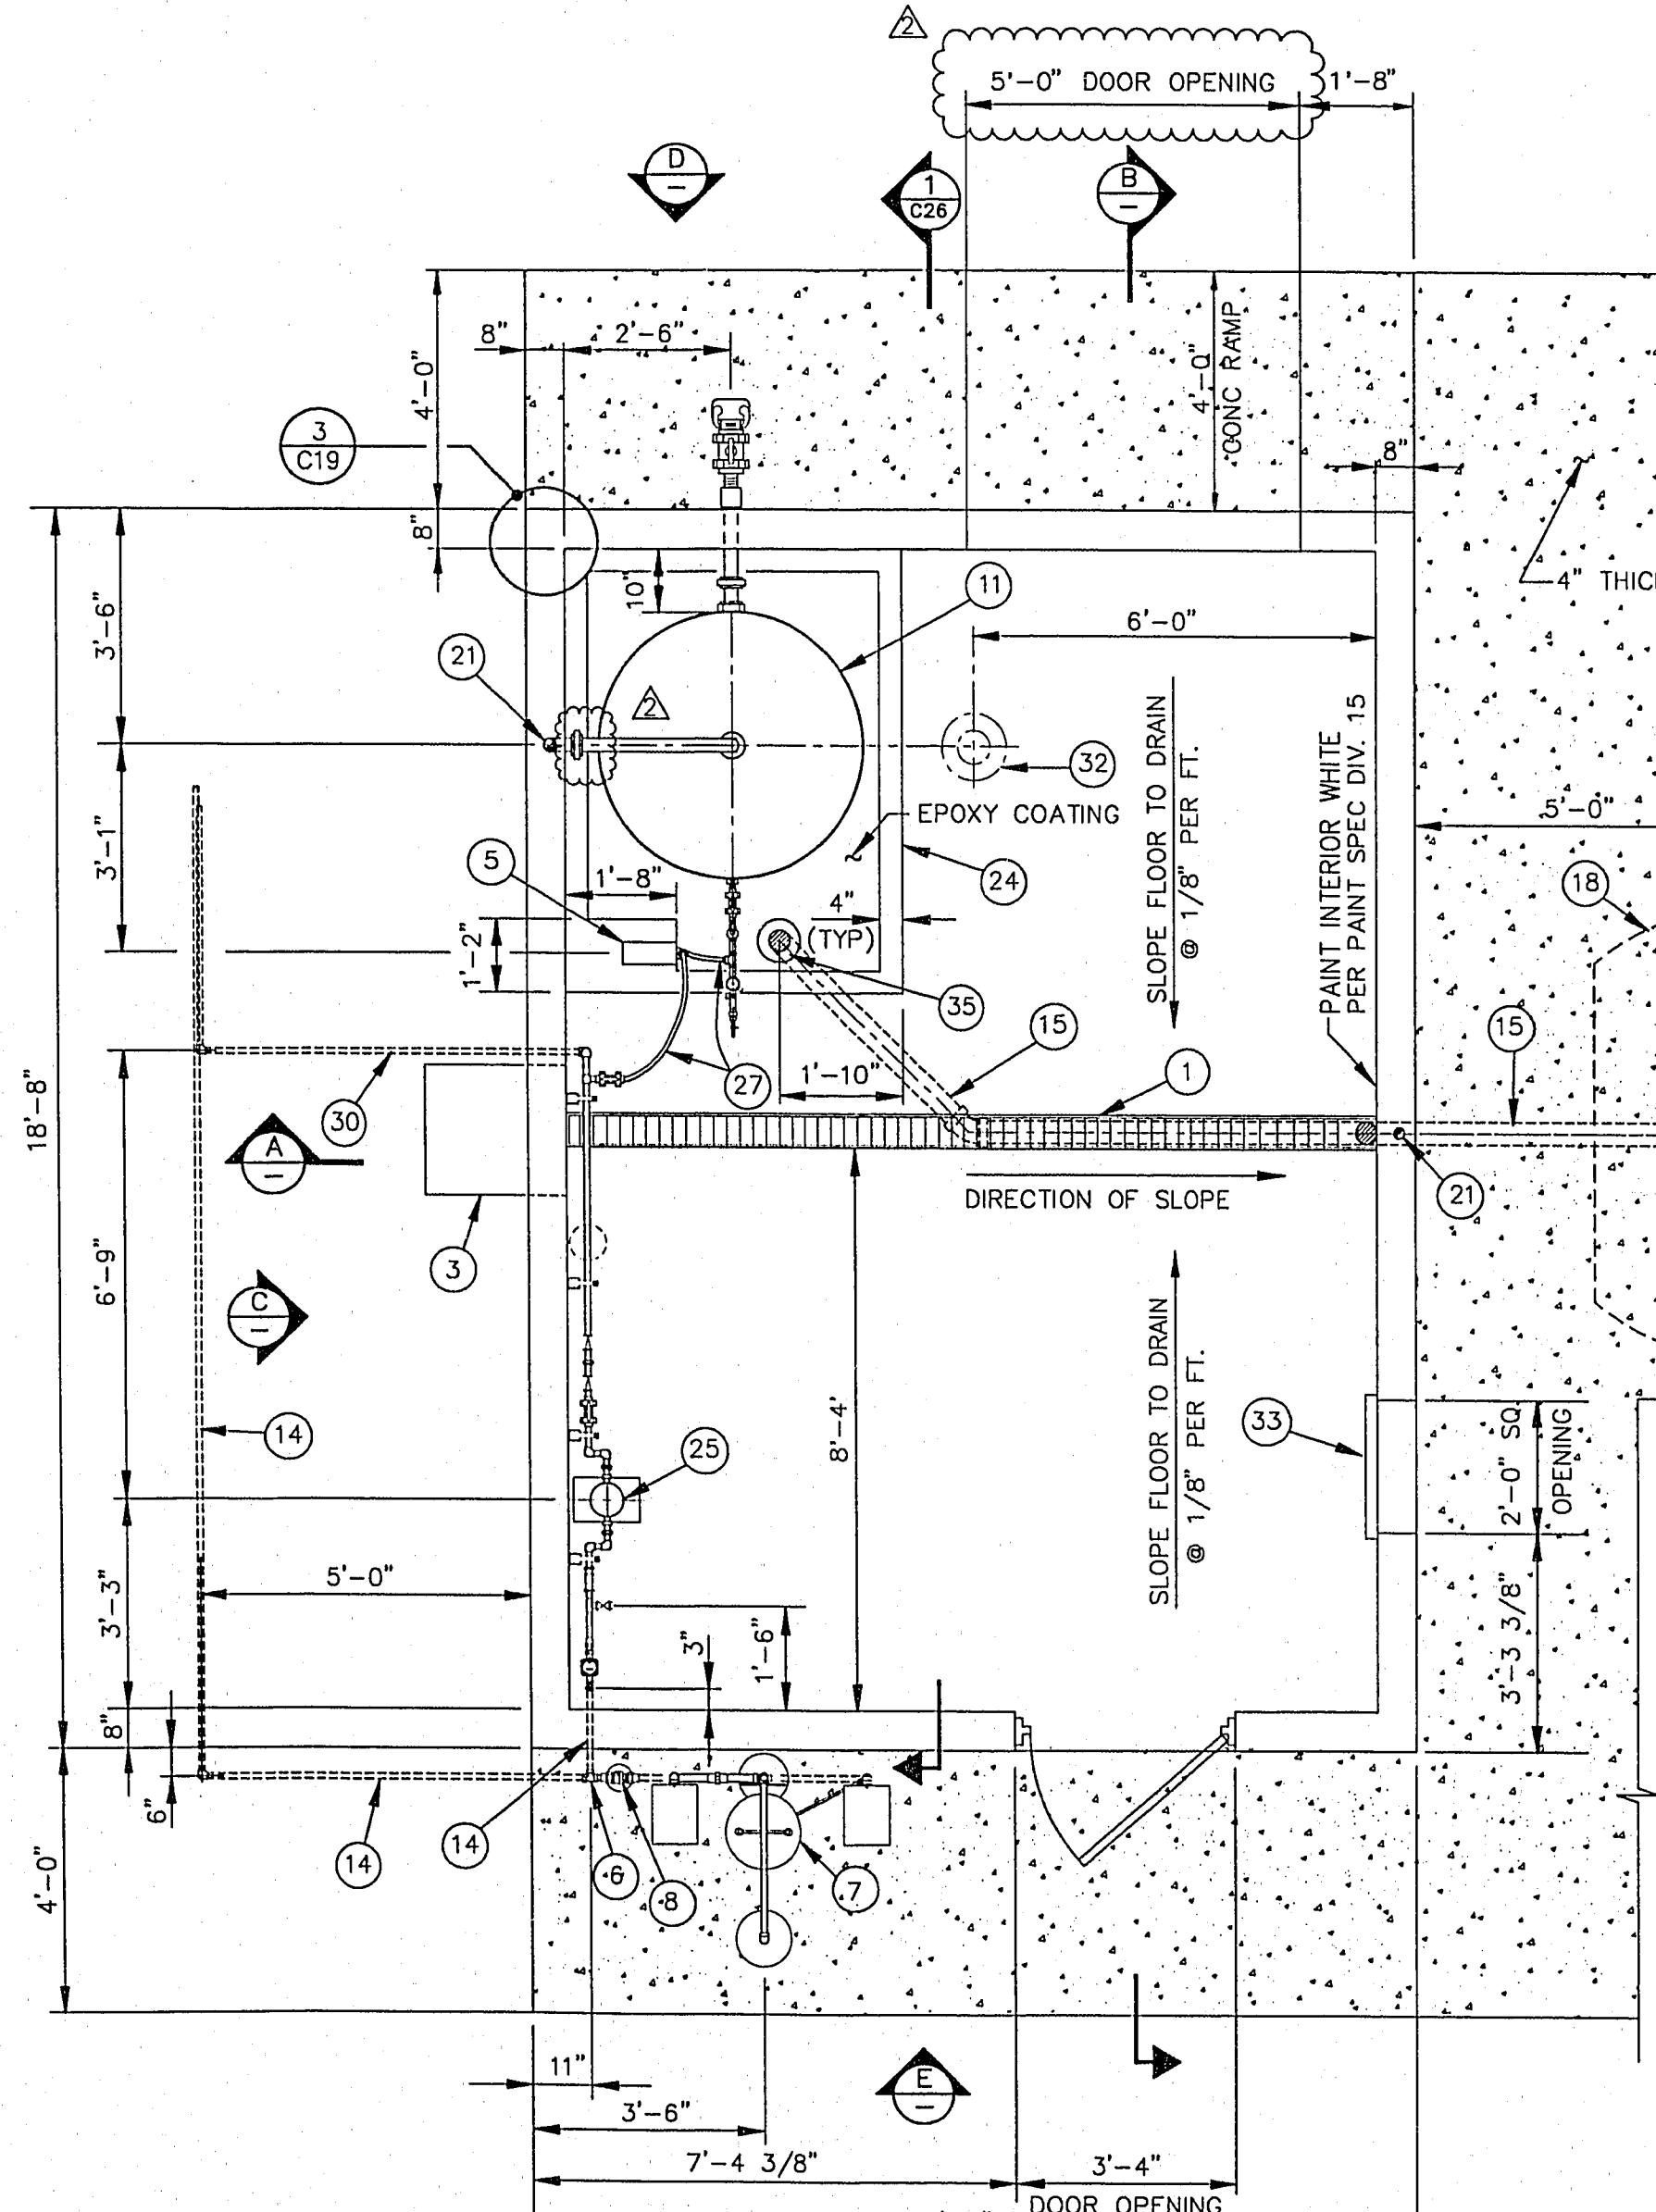


DISINFECTION BUILDING - FLOOR PLAN

SCALE: 3/8" = 1'-0"

LAS VEGAS VALLEY WATER DISTRICT
1001 SOUTH VALLEY VIEW BOULEVARD
LAS VEGAS, NEVADA 89153

EQUIP WELL NO. 93 AND WELL NO. 94

DISINFECTION BUILDING, WELL NO. 94

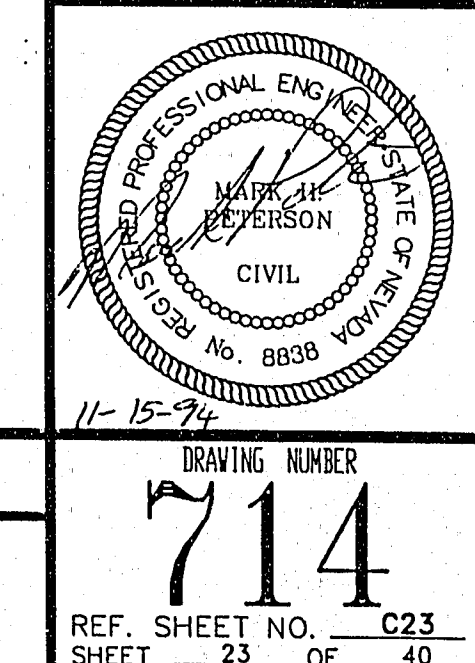

DRAWING NUMBER
714

REF. SHEET NO. C23
SHEET 23 OF 40

PER PLAN CHECK	MJD	1/95	hsp	SCALE:	FILE NO.: 71494C23	DATE: 06/21/94	RECOMMENDED	BARTON T. SMITH	2652	E.I.T. NO.	DATE
				AS SHOWN	DRAWN: BJM	DATE: 06/21/94	APPROVED	MARK H. PETERSON	8838	R.P.E. NO.	DATE
					CHECKED: MHP	DATE: 06/21/94					