


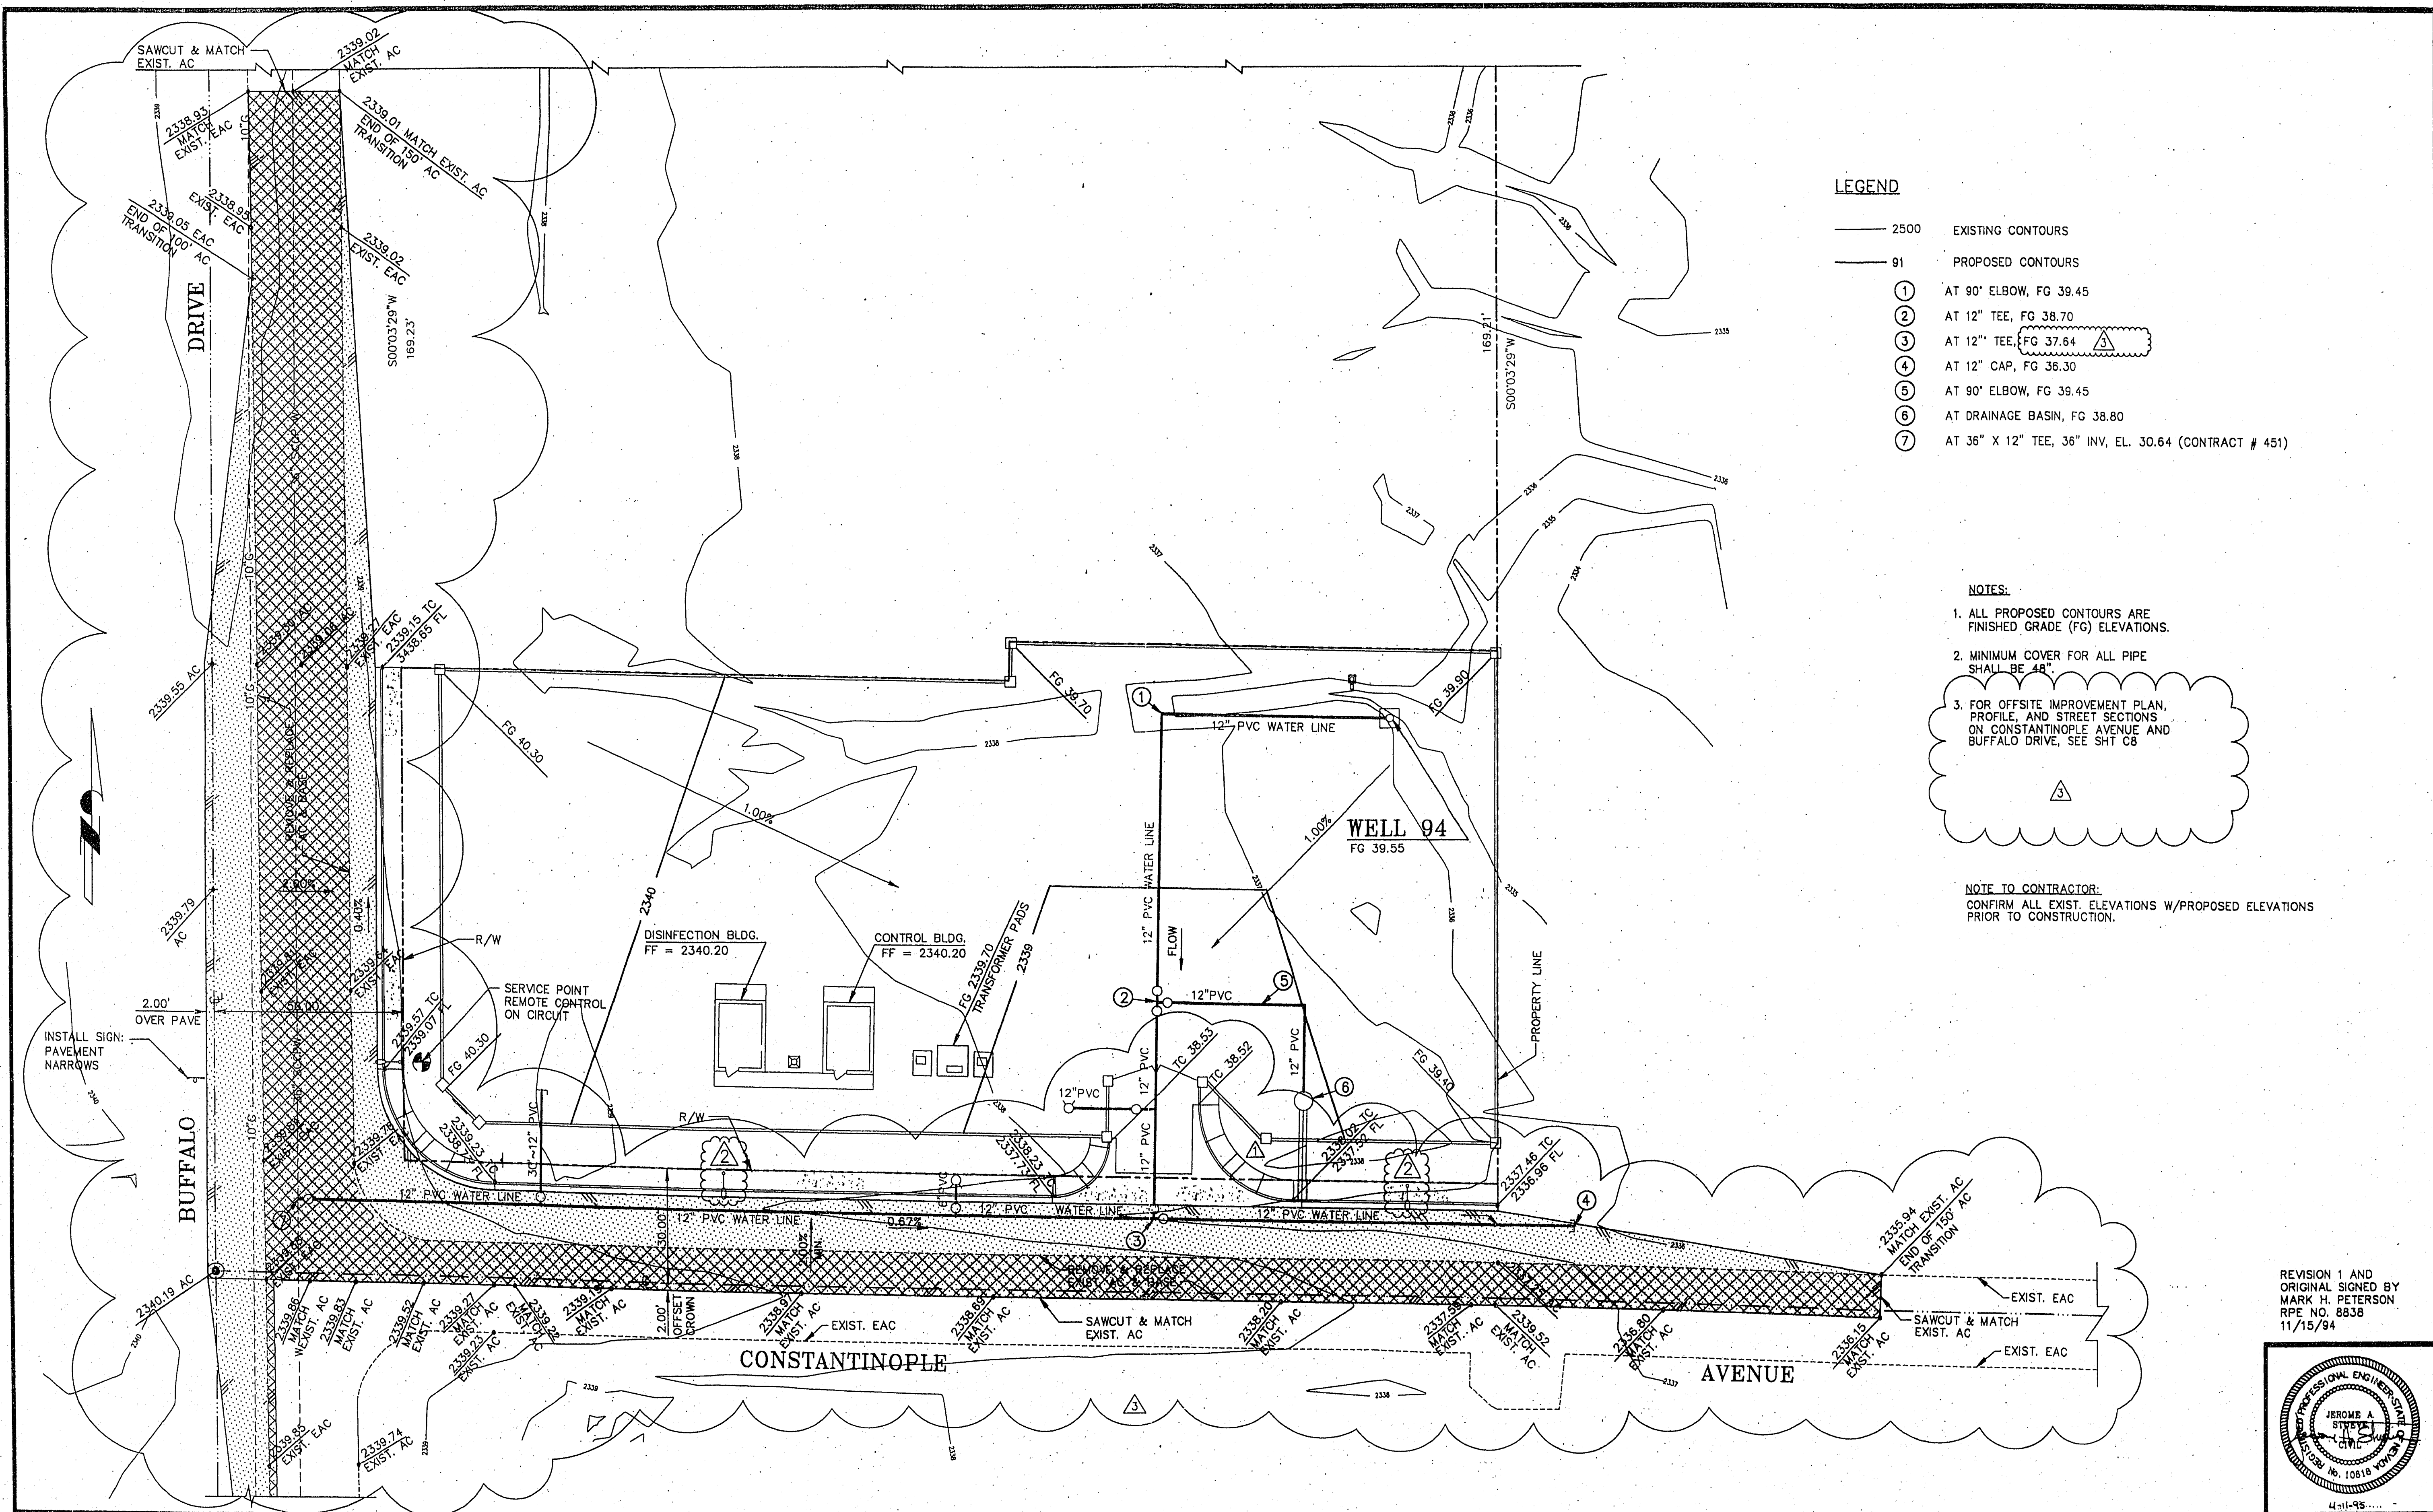

LEGEND

- 2500 EXISTING CONTOURS
- 91 PROPOSED CONTOURS
- ① AT 90° ELBOW, FG 39.45
- ② AT 12" TEE, FG 38.70
- ③ AT 12" TEE, FG 37.64
- ④ AT 12" CAP, FG 36.30
- ⑤ AT 90° ELBOW, FG 39.45
- ⑥ AT DRAINAGE BASIN, FG 38.80
- ⑦ AT 36" X 12" TEE, 36" INV, EL. 30.64 (CONTRACT # 451)


NOTES:

1. ALL PROPOSED CONTOURS ARE FINISHED GRADE (FG) ELEVATIONS.
2. MINIMUM COVER FOR ALL PIPE SHALL BE 48"
3. FOR OFFSITE IMPROVEMENT PLAN, PROFILE, AND STREET SECTIONS ON CONSTANTINOPLE AVENUE AND BUFFALO DRIVE, SEE SHT C8

NOTE TO CONTRACTOR:

CONFIRM ALL EXIST. ELEVATIONS W/PROPOSED ELEVATIONS PRIOR TO CONSTRUCTION.

REVISION 1 AND ORIGINAL SIGNED BY
MARK H. PETERSON
RPE NO. 8838
11/15/94

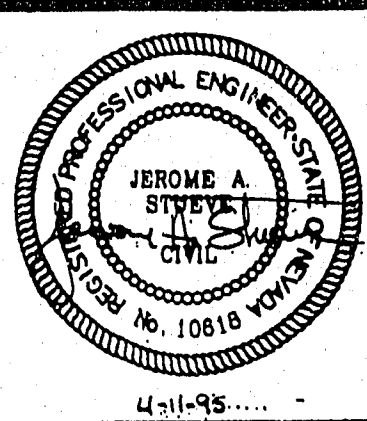

1	CHANGED PER CITY OF LAS VEGAS	GB	1/85	
2	CHANGED PER CITY OF LAS VEGAS	GB	3/95	
3	CHANGED PER CLARK COUNTY COMMENTS	PJ	4/4/95	

SCALE:	FILE NO. 71494C08	DATE: 06/21/94
1" = 20'	DRAWN: BJM	DATE: 06/21/94
	CHECKED: GEW	DATE: 06/21/94

RECOMMENDED	10818	4/95
JEROME A. STUEVE	R.P.E. NO.	DATE
APPROVED	8851	4-1-95
SHAWN P. HOLMUS	R.P.E. NO.	DATE

LAS VEGAS VALLEY WATER DISTRICT
1001 SOUTH VALLEY VIEW BOULEVARD
LAS VEGAS, NEVADA

EQUIP WELL NO. 93 & WELL NO. 94
GRADING AND DRAINAGE PLAN,
WELL NO. 94

DRAWING NUMBER
714
REF. SHEET NO. C8
SHEET 1 OF 39

27-133 E-3, F-3 QS-397, QS-326 138-28-NE, 138-10-NW