


LAS VEGAS VALLEY WATER DISTRICT

CONTRACT NO. 714

EQUIP WELL NO. 93 AND WELL NO. 94

LIST OF DRAWINGS:

REF. SHEET NO.	DESCRIPTION
C1	TITLE SHEET
C2	SYMBOLS, ABBREVIATIONS AND GENERAL NOTES
C3	SITE PLAN, WELL NO. 93
C4	SITE PLAN, WELL NO. 94
C5	GRADING AND DRAINAGE PLAN, WELL NO. 93
C6	GRADING AND DRAINAGE PLAN, WELL NO. 94
C7	OFFSITE IMPROVEMENT PLAN, WELL NO. 93
C8	OFFSITE IMPROVEMENT PLAN, WELL NO. 94
C9	LANDSCAPE AND IRRIGATION PLAN, WELL NO. 93
C10	LANDSCAPE AND IRRIGATION PLAN, WELL NO. 94
C11	PUMP PIPING PLAN, WELL NO. 93
C12	PUMP PIPING PROFILES, WELL NO. 93
C13	PUMP PIPING PROFILES, WELL NO. 93
C14	PUMP PIPING PLAN, WELL NO. 94
C15	PUMP PIPING PROFILES, WELL NO. 94
C16	PUMP PIPING PROFILES, WELL NO. 94
C17	DRAINAGE DISCHARGE PLAN, PROFILE AND SECTIONS, WELL NO. 93
C18	ACCESS ROAD PLAN, PROFILE AND SECTIONS, WELL NO. 93
C19	MISCELLANEOUS DETAILS
C20	MISCELLANEOUS DETAILS
C21	BOOSTER PUMP & WATER SUPPLY PIPING AND MISCELLANEOUS DETAILS
C22	DISINFECTION BUILDING, WELL NO. 93
C23	DISINFECTION BUILDING, WELL NO. 94
C24	CONTROL BUILDING, WELL NO. 93
C25	CONTROL BUILDING, WELL NO. 94
C26	CHLORINE SOLUTION AND WATER SUPPLY PIPING PROFILE
E1	SYMBOL LEGEND AND GENERAL NOTES
E2	WELL NO. 93 ELECTRICAL SITE PLAN, ELECTRICAL GROUNDING PLAN
E3	WELL NO. 94 ELECTRICAL SITE PLAN, ELECTRICAL GROUNDING PLAN
E4	WELL NO. 93 AND 94 CONTROL BUILDING, DISINFECTION BUILDING ELECTRICAL PLAN
E5	WELL NO. 93 AND 94 CONTROL BUILDING, DISINFECTION LIGHTING AND INTRUSION PLAN
E6	WELL NO. 93 ELECTRICAL PLAN, PROFILE AT WELL SITE
E7	WELL NO. 93 / WELL NO. 94 DETAILS
E8	WELL NO. 93 / WELL NO. 94 DETAILS
E9	WELL NO. 93 / WELL NO. 94 SCHEMATIC DIAGRAMS
E10	WELL NO. 93 / 94 SCHEMATIC DIAGRAM, SINGLE LINE DIAGRAM
E11	WELL NO. 93 / WELL NO. 94 CABLE AND PANEL SCHEDULE
E12	NEVADA POWER COMPANY PLAN, WELL NO. 93
E13	NEVADA POWER COMPANY PLAN, WELL NO. 94

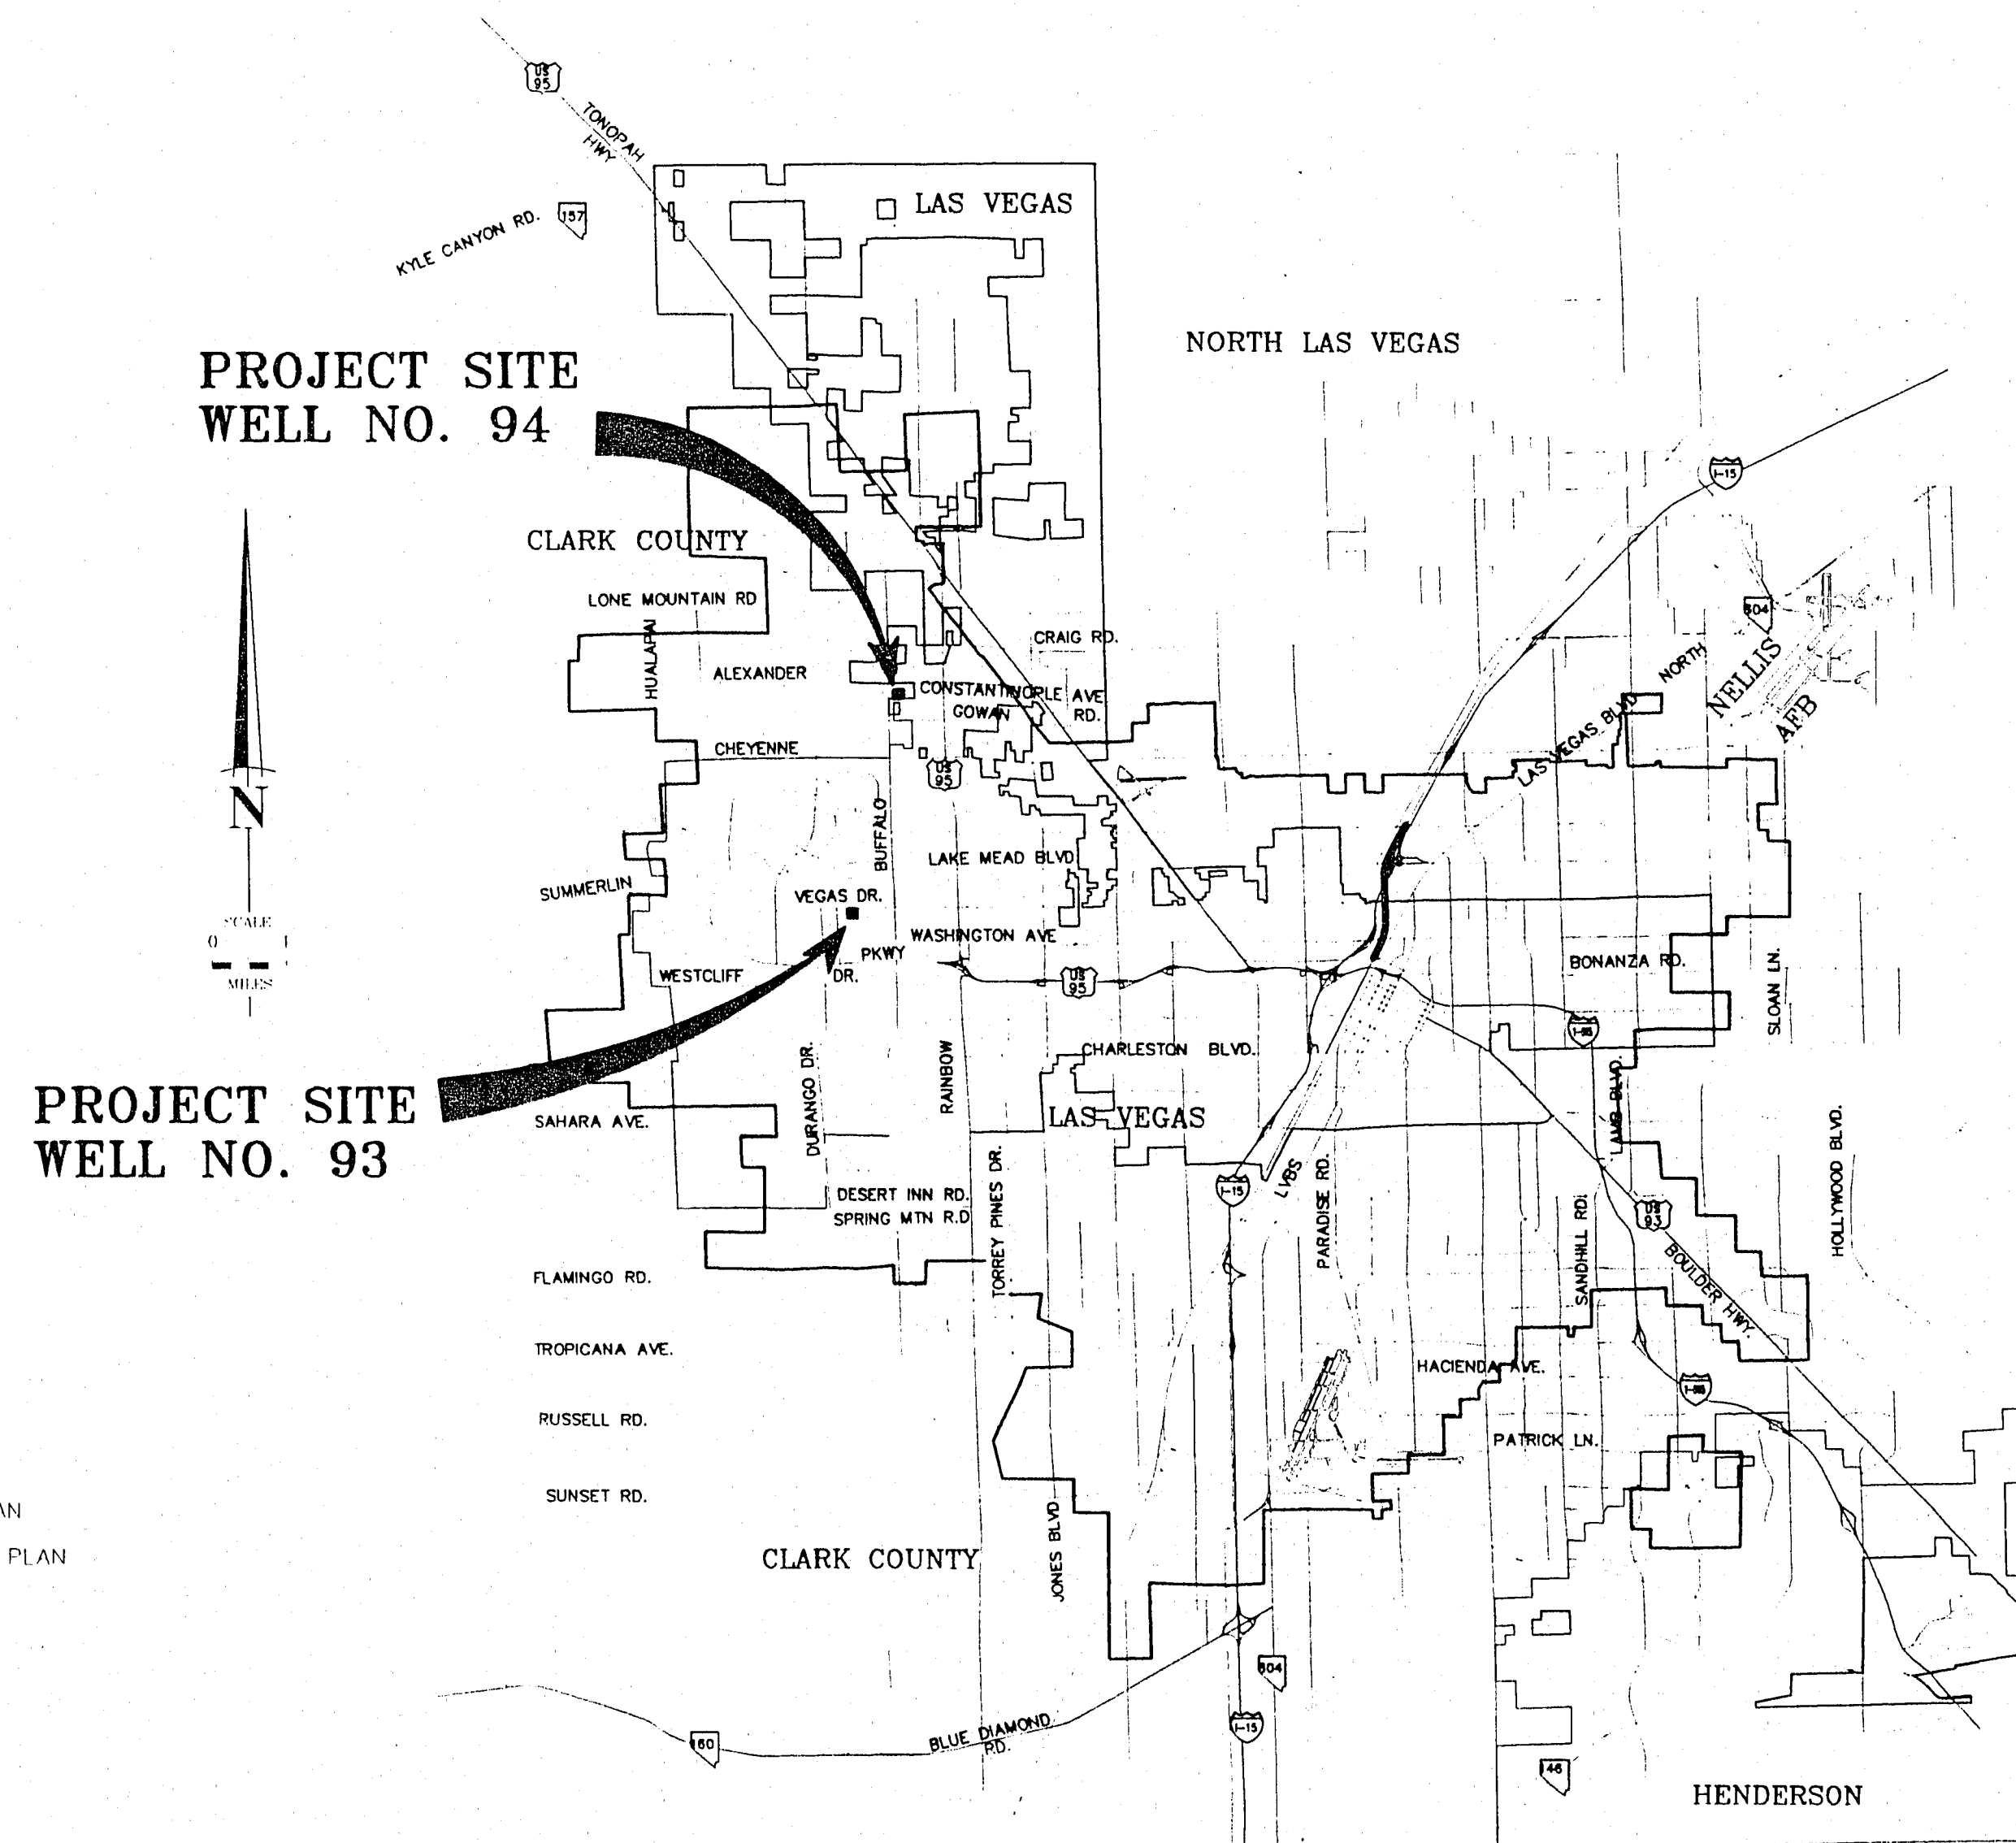


VICINITY MAP

L.V.V.W.D. STANDARD PLATES:


THE L.V.V.W.D. STANDARD PLATES THAT ARE MADE A PART OF THESE DRAWINGS ARE INCLUDED IN THE CONTRACT VOLUME FOR THE WORK AND ARE A PART OF THESE DRAWINGS AS IF ATTACHED HERETO.

CAUTION TO CONTRACTOR:

THE CONTRACTOR SHALL BE RESPONSIBLE TO INVESTIGATE AND VERIFY THE ACTUAL LOCATION AND DEPTH OF ALL EXISTING UNDERGROUND FACILITIES AT LEAST 48 HOURS IN ADVANCE OF THE PERFORMANCE OF ANY WORK.

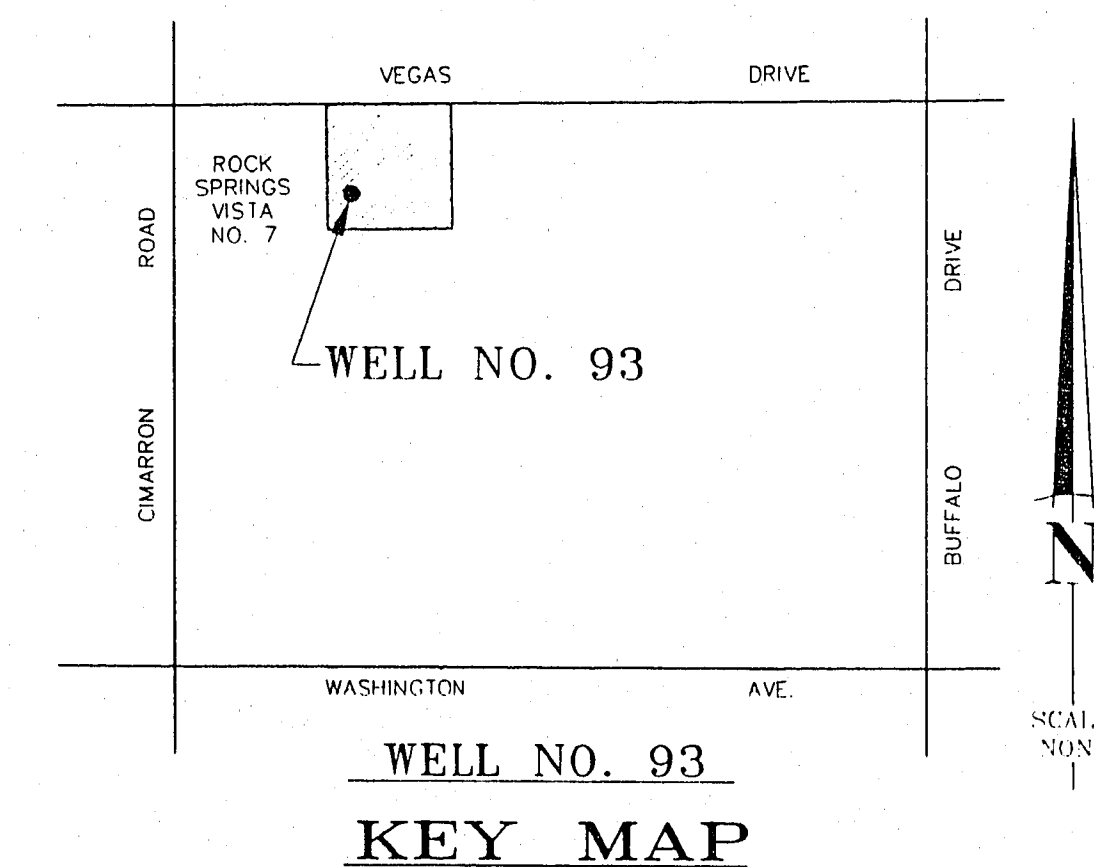


WELL NO. 93
KEY MAP

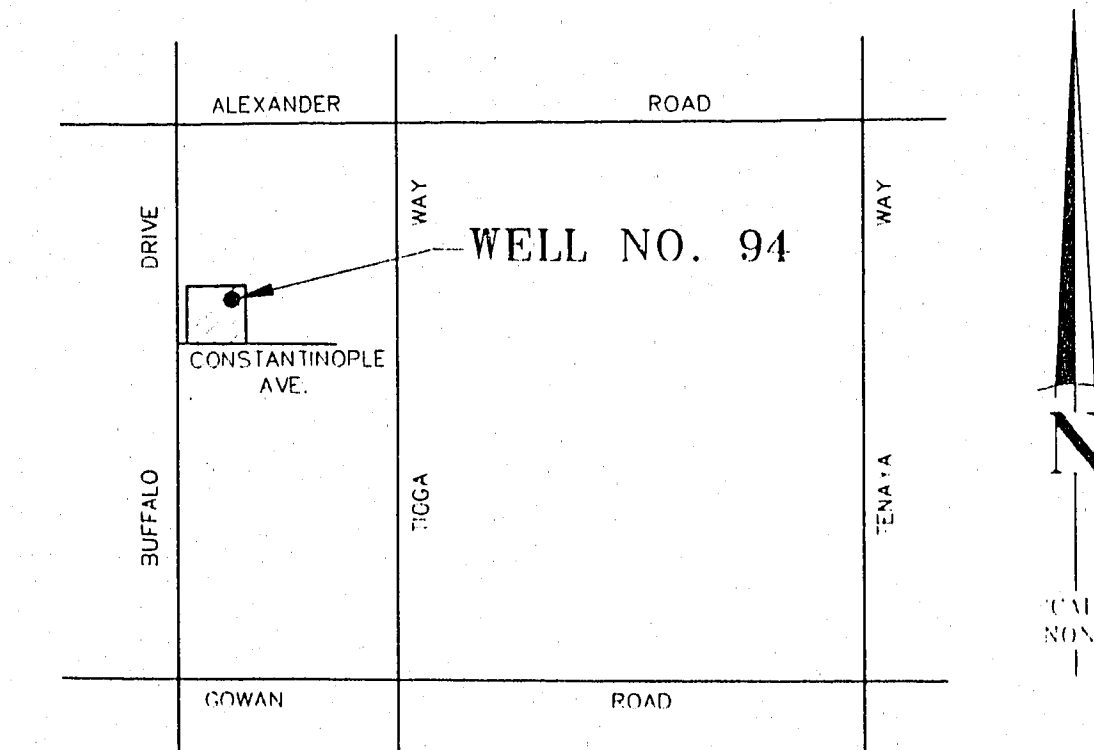

WELL NO. 94
KEY MAP

APPROVALS FOR WELL #93 OFFSITE ONLY	
	2-6-95
CITY OF LAS VEGAS ENGINEER	DATE
	1-18-95
FIRE DEPARTMENT	DATE
	12-29-94
NEVADA POWER COMPANY	DATE

APPROVALS FOR WELL #94

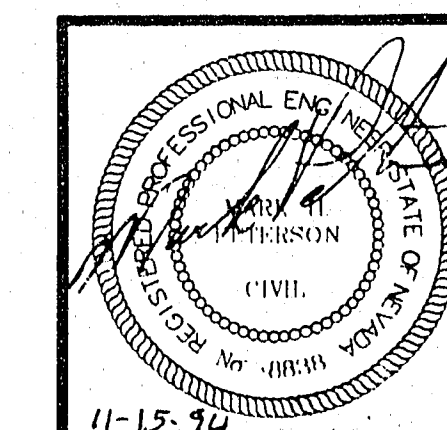

ADDED APPROVAL BLOCKS	GB 1/95	SCALE:	FILE NAME: 71493C01	DATE: 06/21/94	REVISION NO. 2652	11-15-94
			DRAWN: BJM	DATE: 06/21/94	APPROVED: MARK H. PETERSON	11-15-94
			CHECKED: MHP	DATE: 06/21/94		

LAS VEGAS VALLEY WATER DISTRICT
1001 SOUTH VALLEY VIEW BOULEVARD
LAS VEGAS, NEVADA 89153

EQUIP WELL NO. 93 AND WELL NO. 94

TITLE SHEET

DRAWING NUMBER
714
REF. SHEET NO. C1 OF 39

27-128