



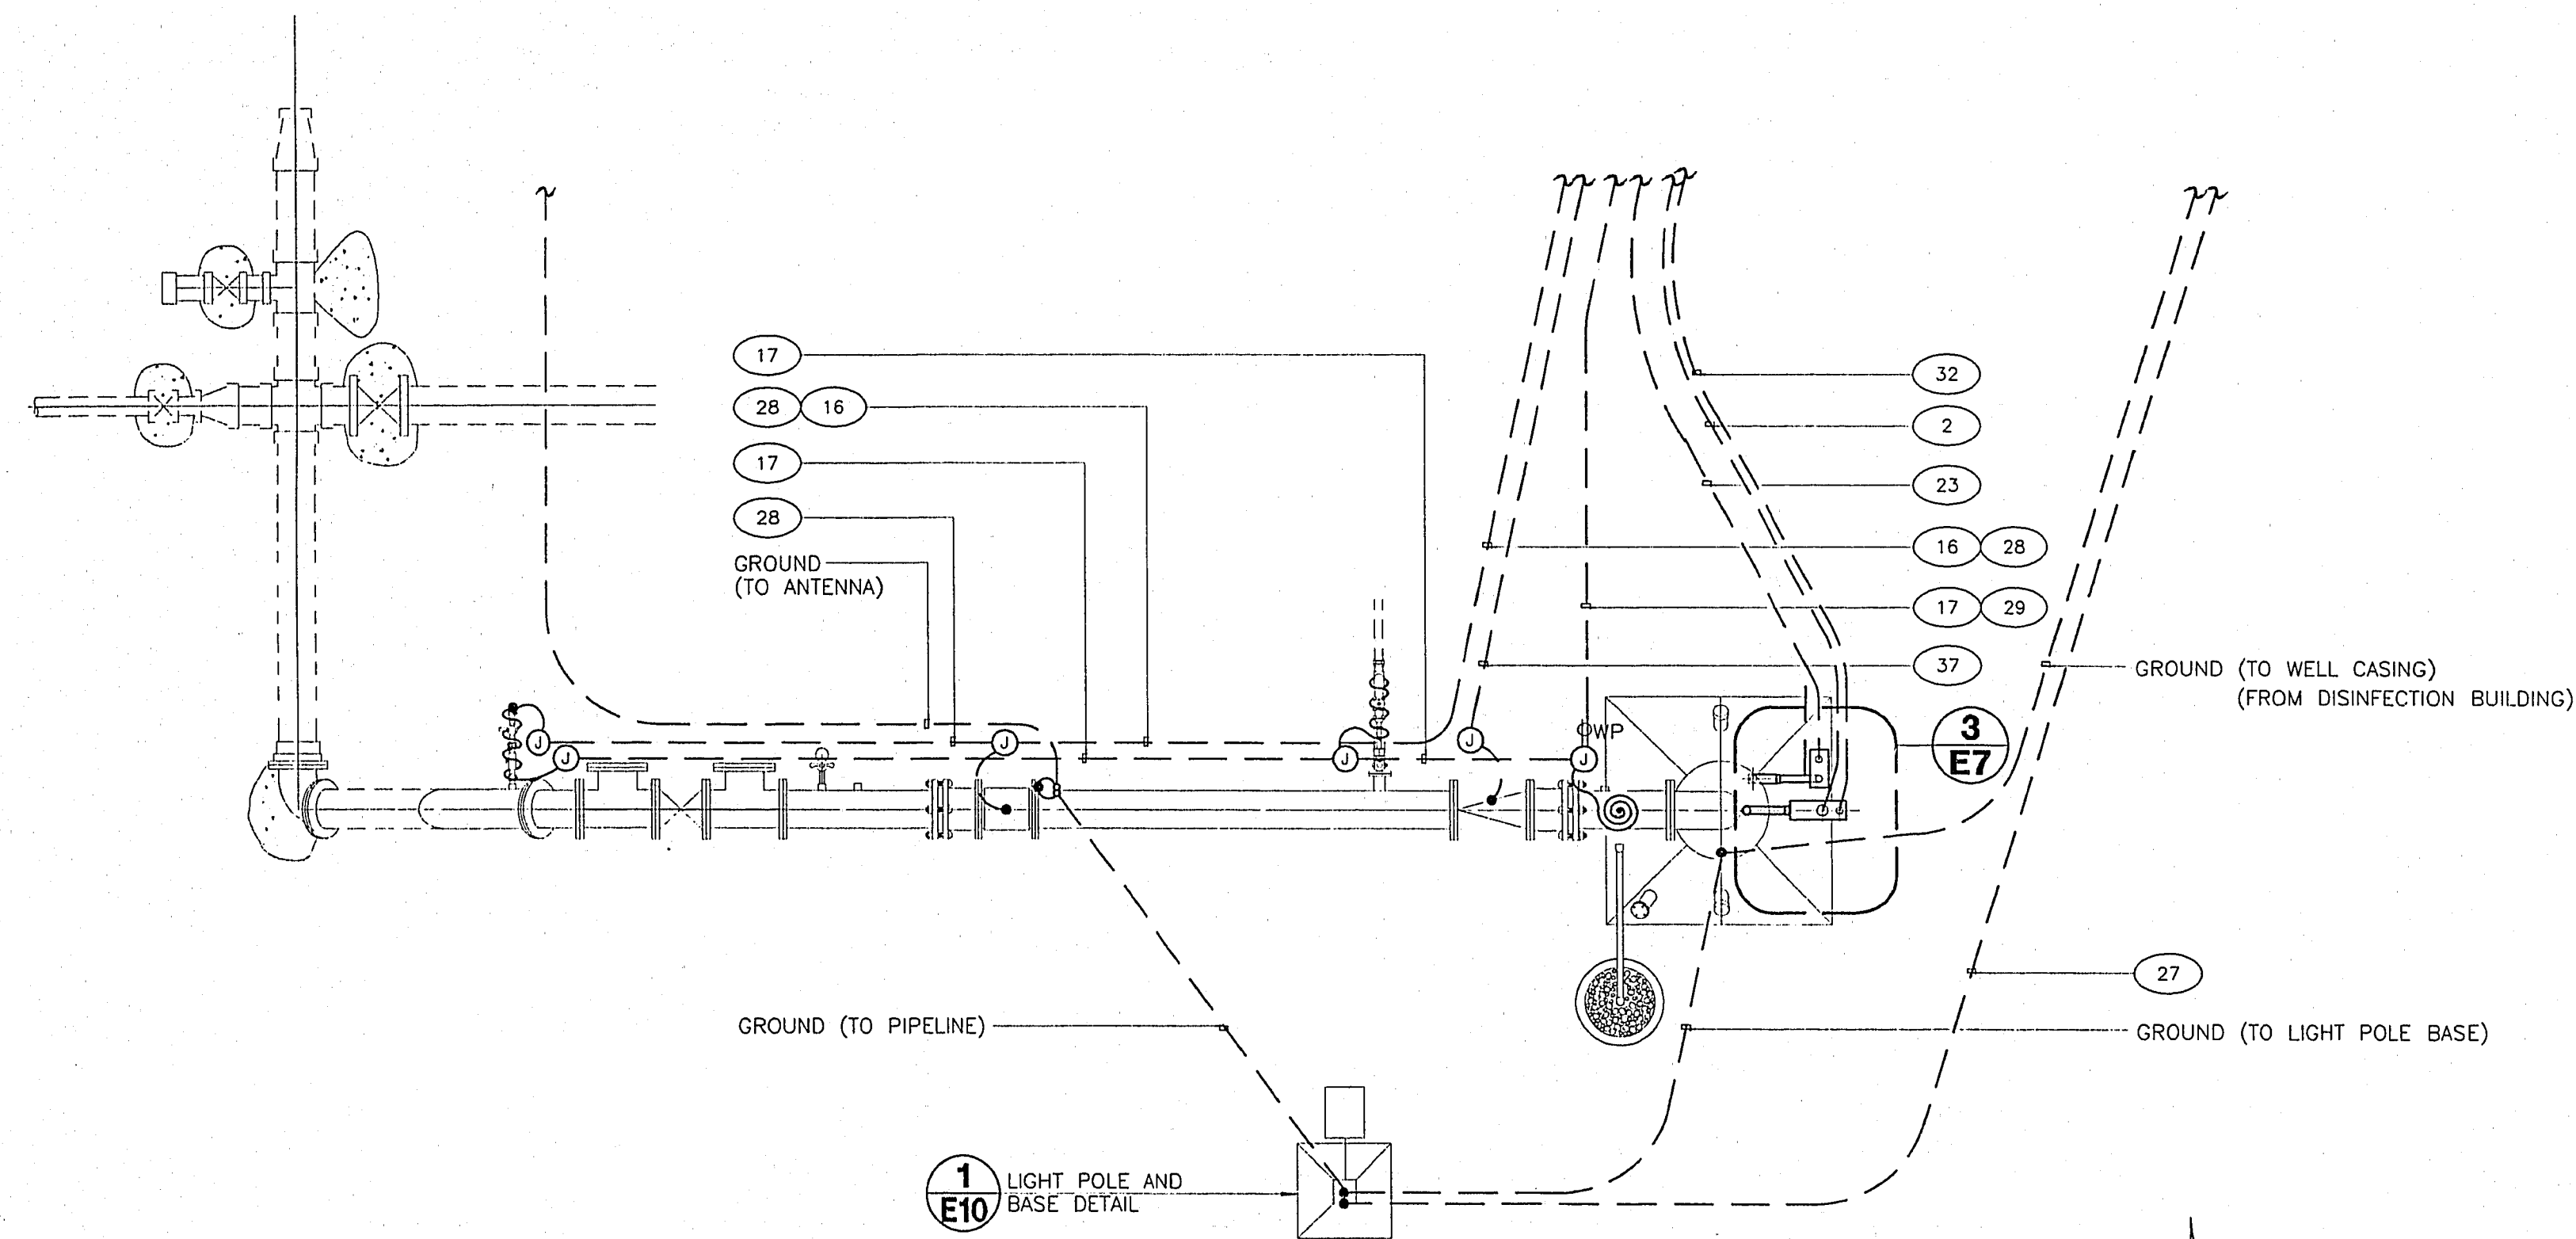


WELL No. 90 ELECTRICAL PLAN 1
SCALE - 1/4" = 1'-0"

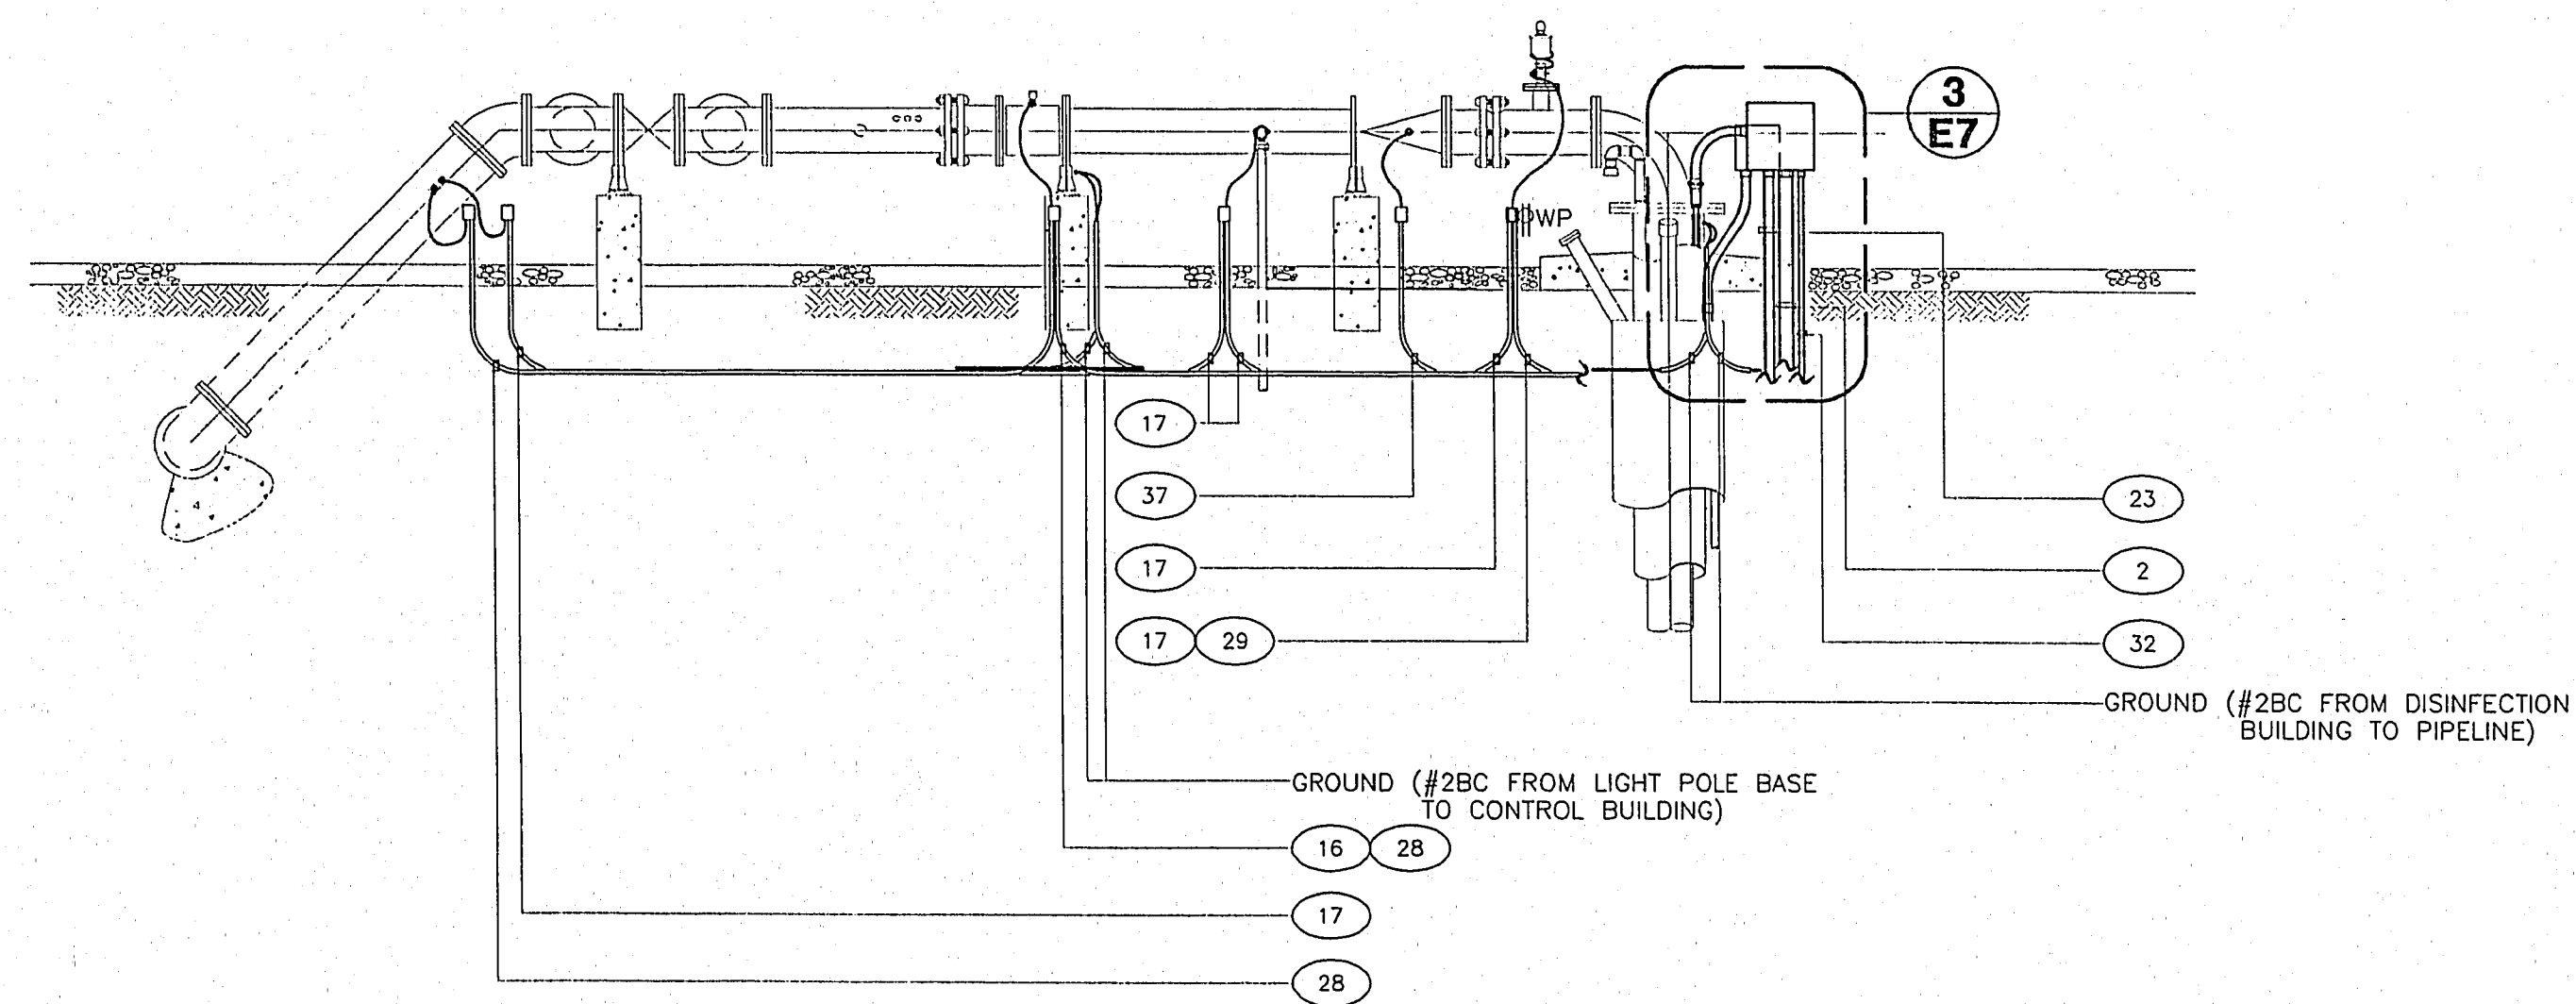

WELL No. 90 ELECTRICAL PROFILE 2
SCALE - 1/4" = 1'-0"

ORIGINAL ISSUED
DRAWING SIGNED BY: D. K. BAIRD
ON: 10/05/94

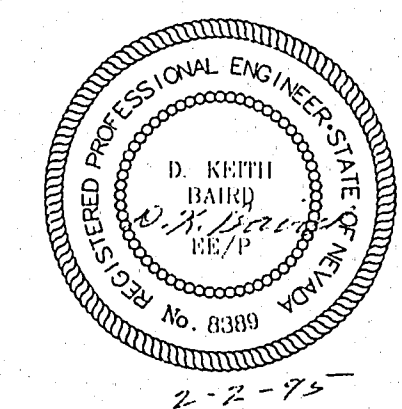

REV	DESCRIPTION	BY	DATE	CHECKED
1	REPLOTTED ORIGINAL	JES	02/95	JQA

SCALE: HORIZ. 1" = 4' VERT. NONE	FILE NAME: C0713E06.DWG DATE: 07/12/94 DRAWN: J.E. SILDANA DATE: 07/12/94 CHECKED: D.K.B. DATE: 07/14/94	RECOMMENDED D. Keith Baird 8389 2-2-95 APPROVED Shawn P. Molzys 9651 2-2-95
--	--	--

LAS VEGAS VALLEY WATER DISTRICT
3700 WEST CHARLESTON BOULEVARD
LAS VEGAS, NEVADA

EQUIP WELL No.s 90 AND 95
WELL No. 90 ELECTRICAL PLAN AND PROFILE

DRAWING NUMBER
713
REF. SHEET NO. 16
SHEET 22 OF 29