


24-15-107

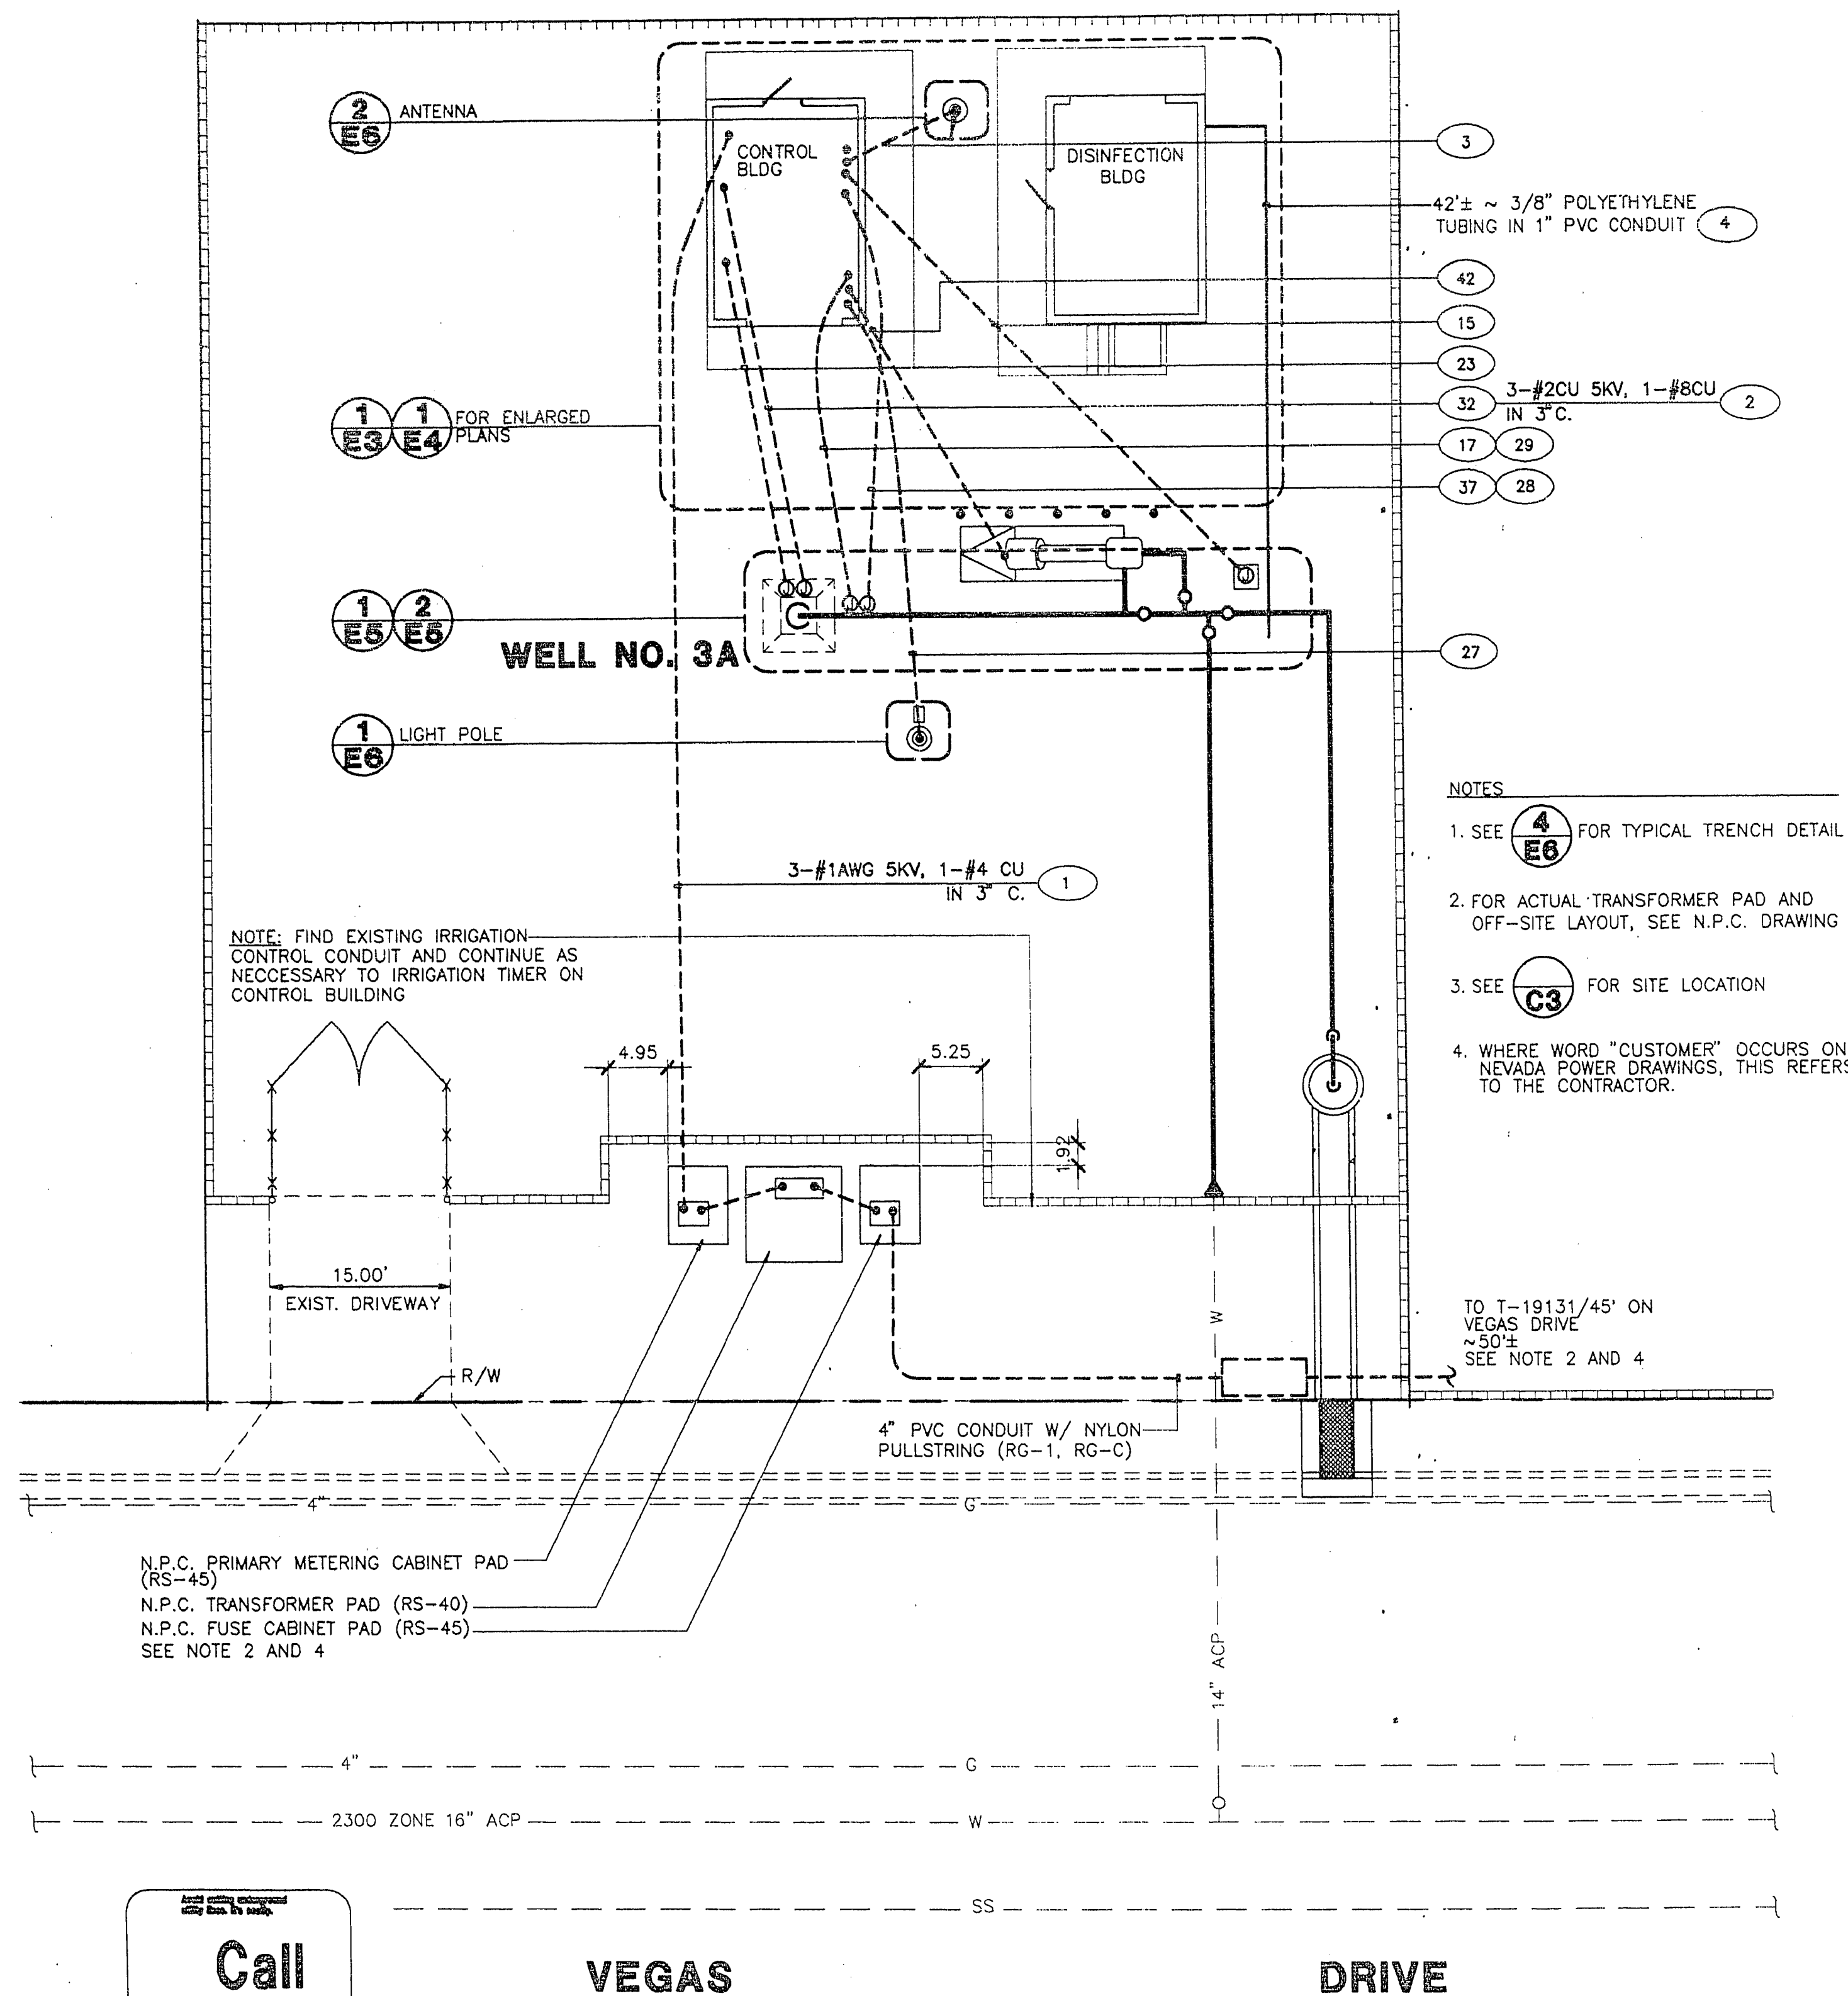

- NOTES
1. SEE **E6** FOR TYPICAL TRENCH DETAIL
 2. FOR ACTUAL TRANSFORMER PAD AND OFF-SITE LAYOUT, SEE N.P.C. DRAWING
 3. SEE **C3** FOR SITE LOCATION
 4. WHERE WORD "CUSTOMER" OCCURS ON NEVADA POWER DRAWINGS, THIS REFERS TO THE CONTRACTOR.

TO T-19131/45' ON VEGAS DRIVE
~50'±
SEE NOTE 2 AND 4

Call before you Dig.
1-800-227-2800


ELECTRICAL SITE PLAN **1**
SCALE - NOTED

REV	DESCRIPTION	BY	DATE	CHKD

SCALE:	FILE NAME: C0746E02.DWG	DATE: 5/5/95
1" = 10'	DRAWN: J. E. SALDANA	DATE: 5/5/95
NONE	CHECKED: J. Q. ARCEO	DATE: 05/9/95

APPROVED:	DATE: 6-8-95
D. KEITH BAIRD	R.P.F. NO. 8389
SHAWN P. MOLLUS	R.P.F. NO. 8661


LAS VEGAS VALLEY WATER DISTRICT
1001 SOUTH VALLEY VIEW BOULEVARD
LAS VEGAS, NEVADA 89153

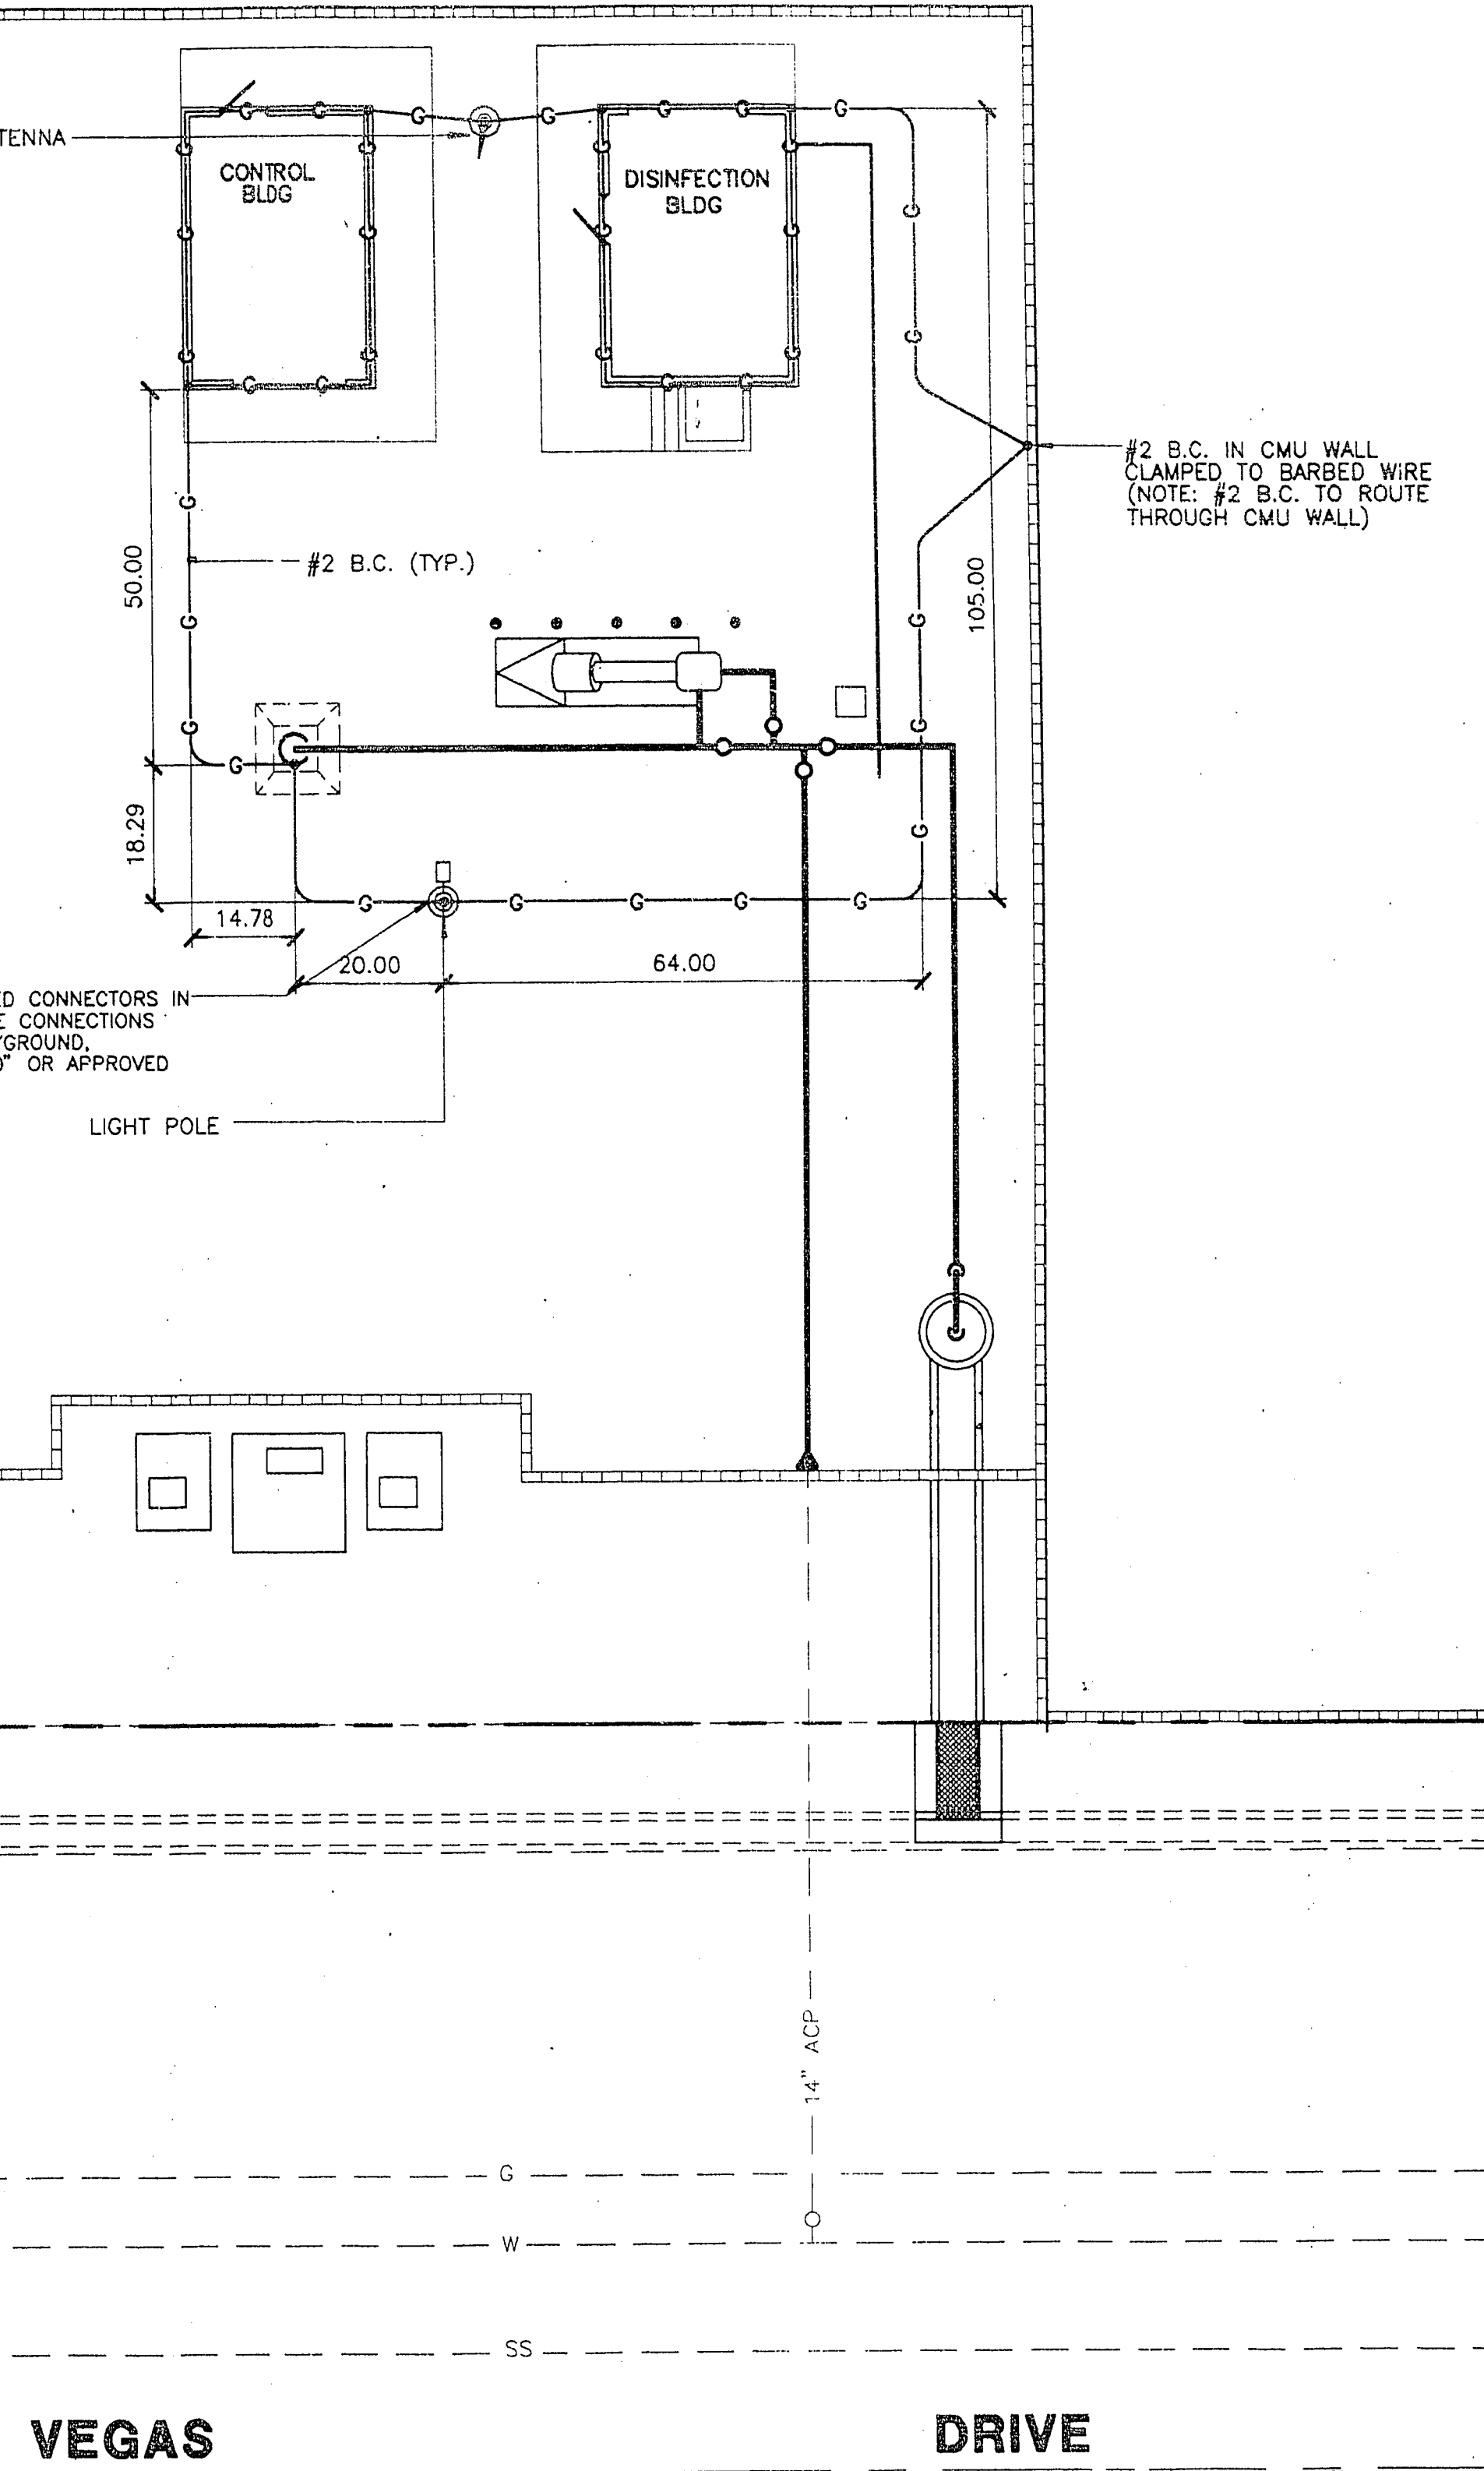

GROUNDING PLAN **2**
SCALE - NOTED

EQUIP WELL NO. 3A
ELECTRICAL SITE PLAN,
ELECTRICAL GROUNDING PLAN

DRAWING NUMBER
746
REF. SHEET NO. 12
SHEET 15 OF 25

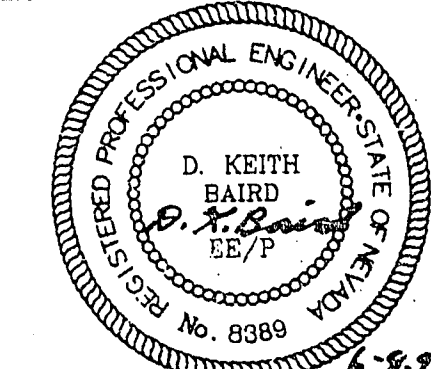

NO746015.TIF
13:10
06/08/95
Plot of C0746E02.dwg