



29-15-108

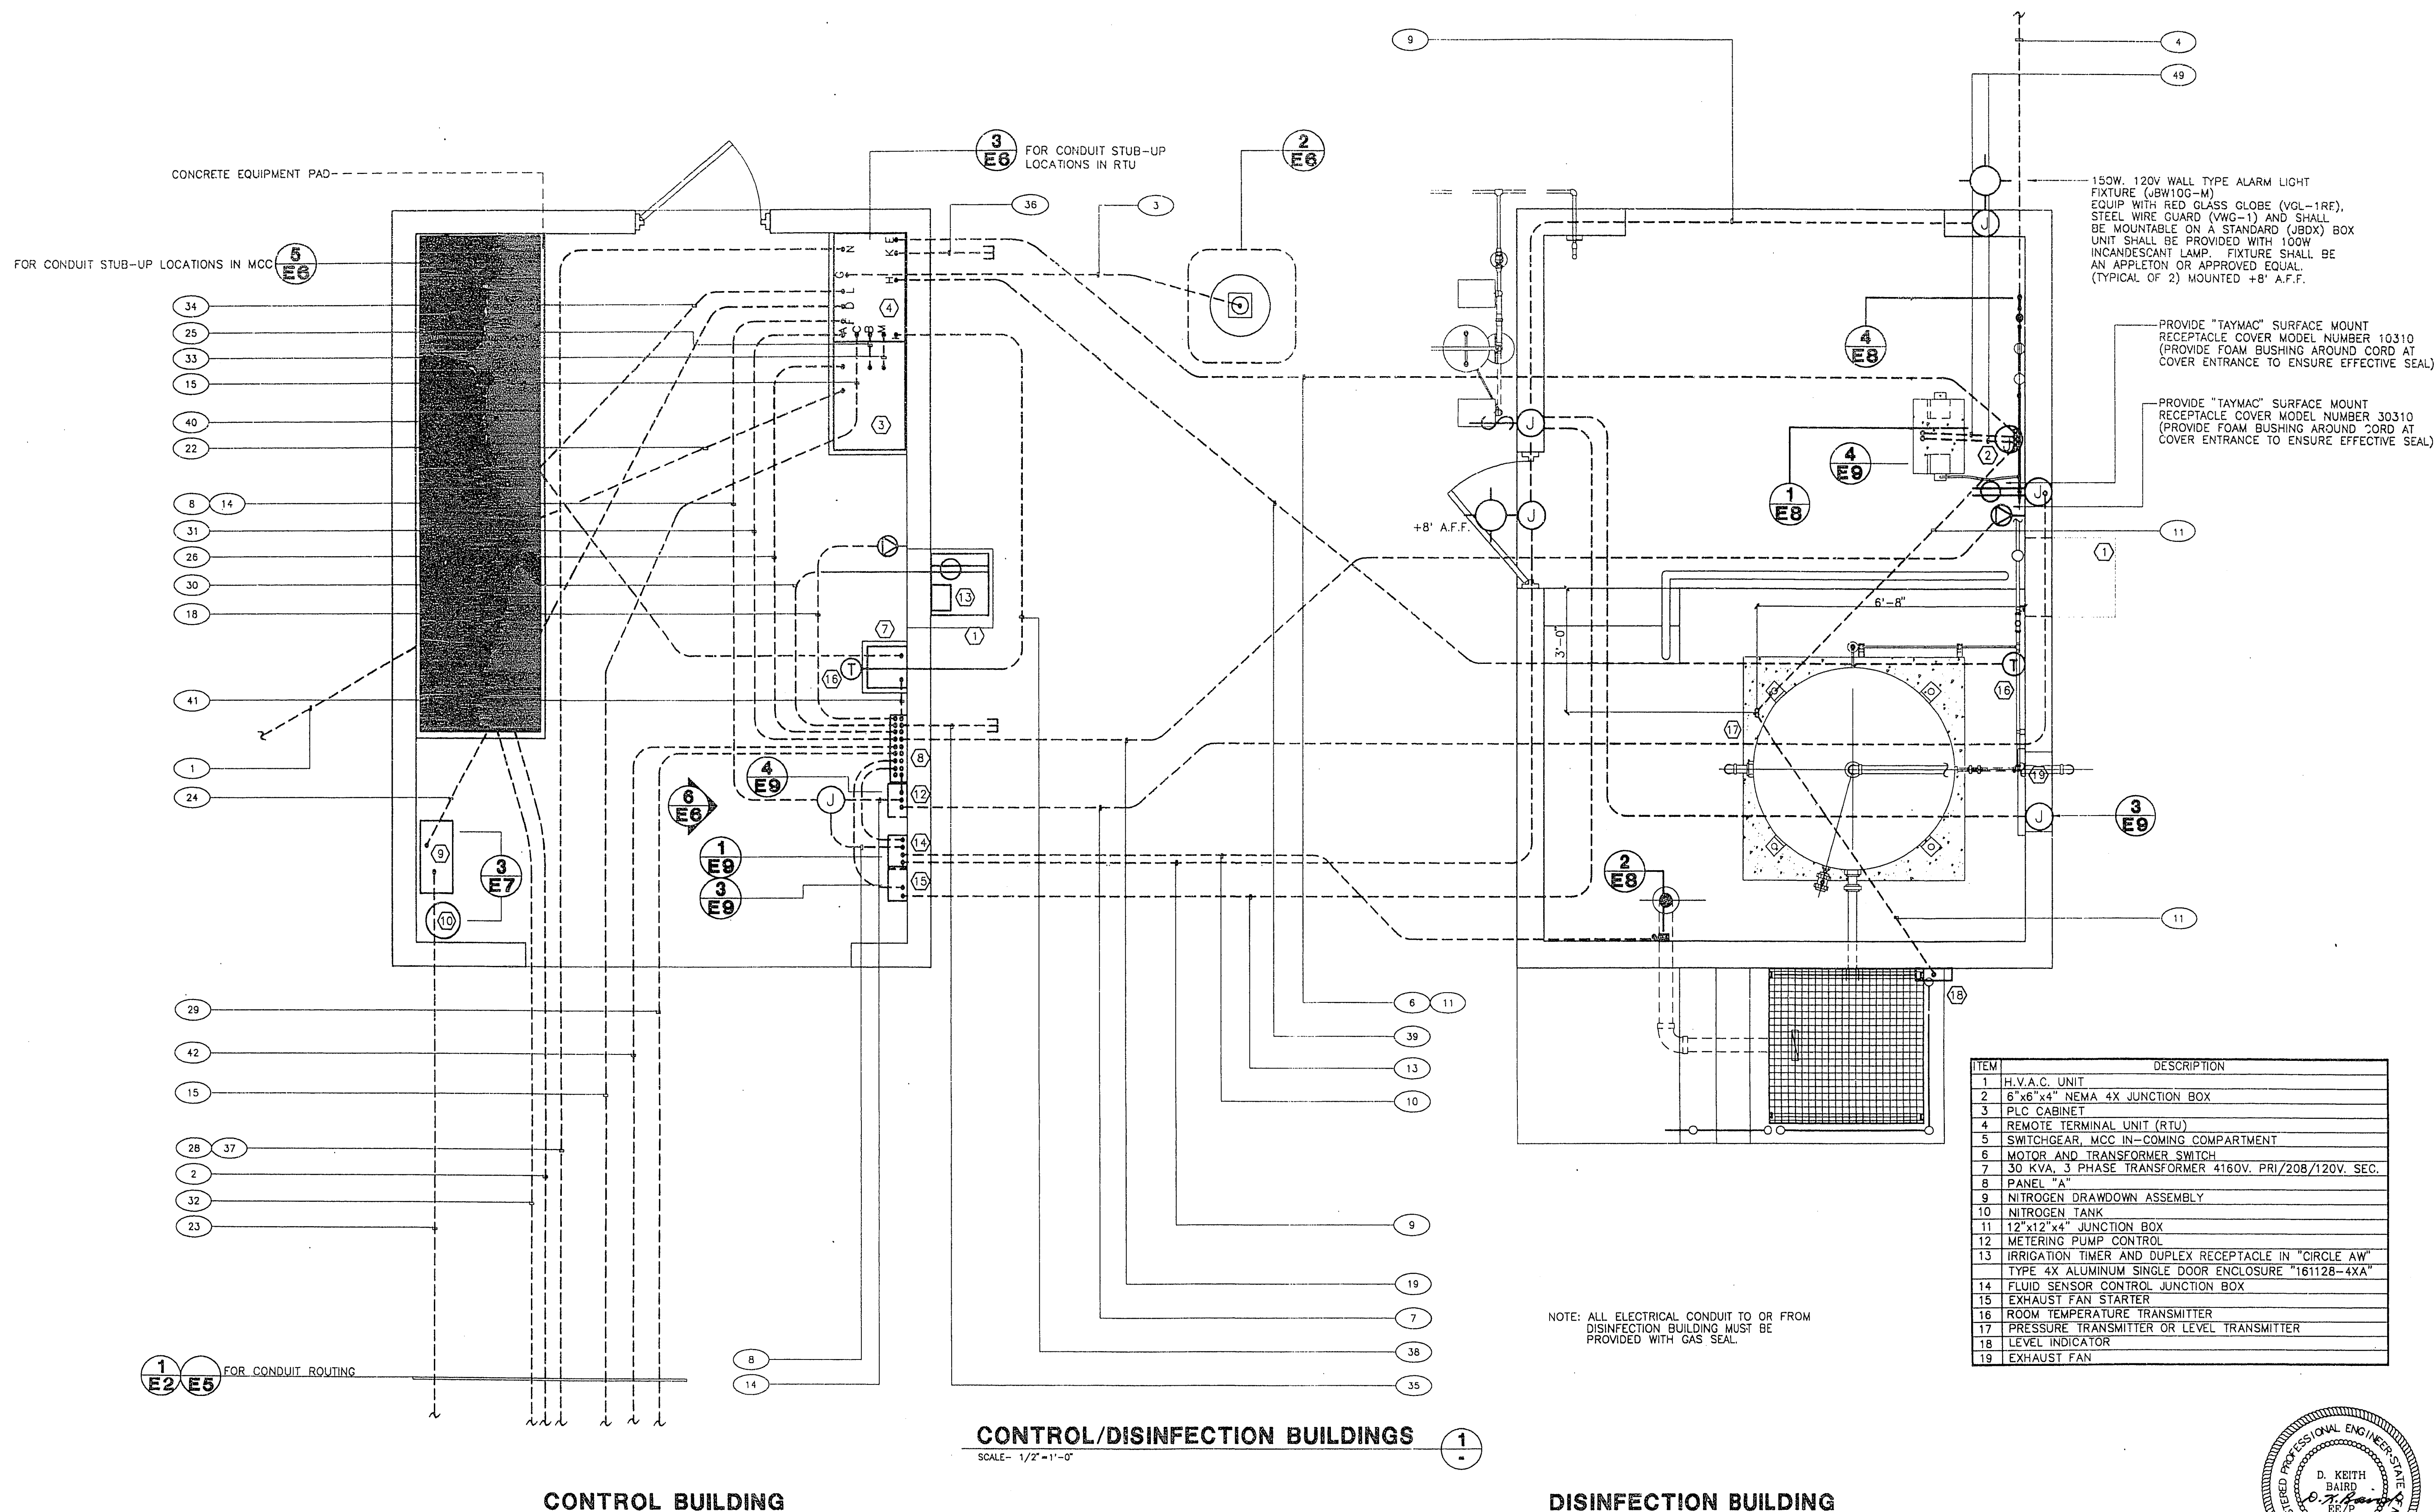

ITEM	DESCRIPTION
1	H.V.A.C. UNIT
2	6"x6"x4" NEMA 4X JUNCTION BOX
3	PLC CABINET
4	REMOTE TERMINAL UNIT (RTU)
5	SWITCHGEAR, MCC IN-COMING COMPARTMENT
6	MOTOR AND TRANSFORMER SWITCH
7	30 KVA, 3 PHASE TRANSFORMER 4160V, PRI/208/120V, SEC.
8	PANEL "A"
9	NITROGEN DRAWDOWN ASSEMBLY
10	NITROGEN TANK
11	12"x12"x4" JUNCTION BOX
12	METERING PUMP CONTROL
13	IRRIGATION TIMER AND DUPLEX RECEPTACLE IN "CIRCLE AW"
14	TYPE 4X ALUMINUM SINGLE DOOR ENCLOSURE "161128-4XA"
15	FLUID SENSOR CONTROL JUNCTION BOX
16	EXHAUST FAN STARTER
17	ROOM TEMPERATURE TRANSMITTER
18	PRESSURE TRANSMITTER OR LEVEL TRANSMITTER
19	LEVEL INDICATOR
20	EXHAUST FAN

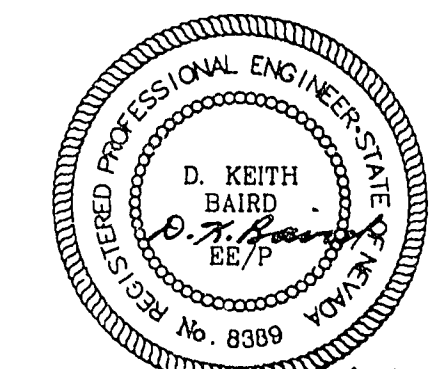

CONTROL/DISINFECTION BUILDINGS
SCALE: 1/2" = 1'-0"

CONTROL BUILDING

DISINFECTION BUILDING

REV

DESCRIPTION

BY

DATE

CHKD

SCALE:

1" = 2'

FILE NAME:

CO746E03.DWG

DATE:

04/28/95

DRAWN:

J. E. SALDANA

DATE:

04/28/95

CHECKED:

J. Q. ARCEO

DATE:

05/9/95

RECOMMENDED

D. Keith Baird

6-8-95

APPROVED

Shawn P. Mollus

6-22-95

LAS VEGAS VALLEY WATER DISTRICT

1001 SOUTH VALLEY VIEW BOULEVARD

LAS VEGAS, NEVADA 89153

EQUIP WELL NO. 3A

CONTROL BUILDING,

DISINFECTION BUILDING ELECTRICAL PLAN

DRAWING NUMBER

746

REF. SHEET NO.

13

SHEET

16

OF

25

NO746016.TIF
13:29
Plot 06/08/95
C:\VAD\DRAWINGS\CONTRACT\CO746\CO746E03.dwg