


24-15-93

LAS VEGAS VALLEY WATER DISTRICT


CONTRACT NO. 746
EQUIP WELL NO. 3A

LIST OF DRAWINGS:

REF. SHEET NO.	DESCRIPTION
C1	TITLE SHEET
C2	SYMBOLS, ABBREVIATIONS AND GENERAL NOTES
C3	SITE PLAN
C4	DEMOLITION PLAN
C5	GRADING AND DRAINAGE PLAN
C6	PUMP PIPING PLAN AND PROFILE
C7	DRAINAGE DISCHARGE PLAN, PROFILE AND SECTIONS
C8	MISCELLANEOUS DETAILS
C9	STANDARD DETAILS
B1	DISINFECTION BUILDING
B2	CONTROL BUILDING
B3	DISINFECTION SOLUTION PIPING PLAN AND SECTIONS
B4	BUILDING, FENCE AND GATE DETAILS
E1	SYMBOLS, LEGEND AND GENERAL NOTES
E2	ELECTRICAL SITE PLAN, ELECTRICAL GROUNDING PLAN
E3	CONTROL BUILDING, DISINFECTION BUILDING ELECTRICAL PLAN
E4	CONTROL BUILDING, DISINFECTION BUILDING LIGHTING AND INTRUSION PLAN
E5	ELECTRICAL PLAN AND PROFILE AT WELL SITE
E6	DETAILS
E7	DETAILS
E8	DETAILS
E9	SINGLE LINE DIAGRAM, SCHEMATIC DIAGRAMS
E10	SCHEMATIC DIAGRAMS
E11	CABLE AND PANEL SCHEDULE
E12	NEVADA POWER DRAWING

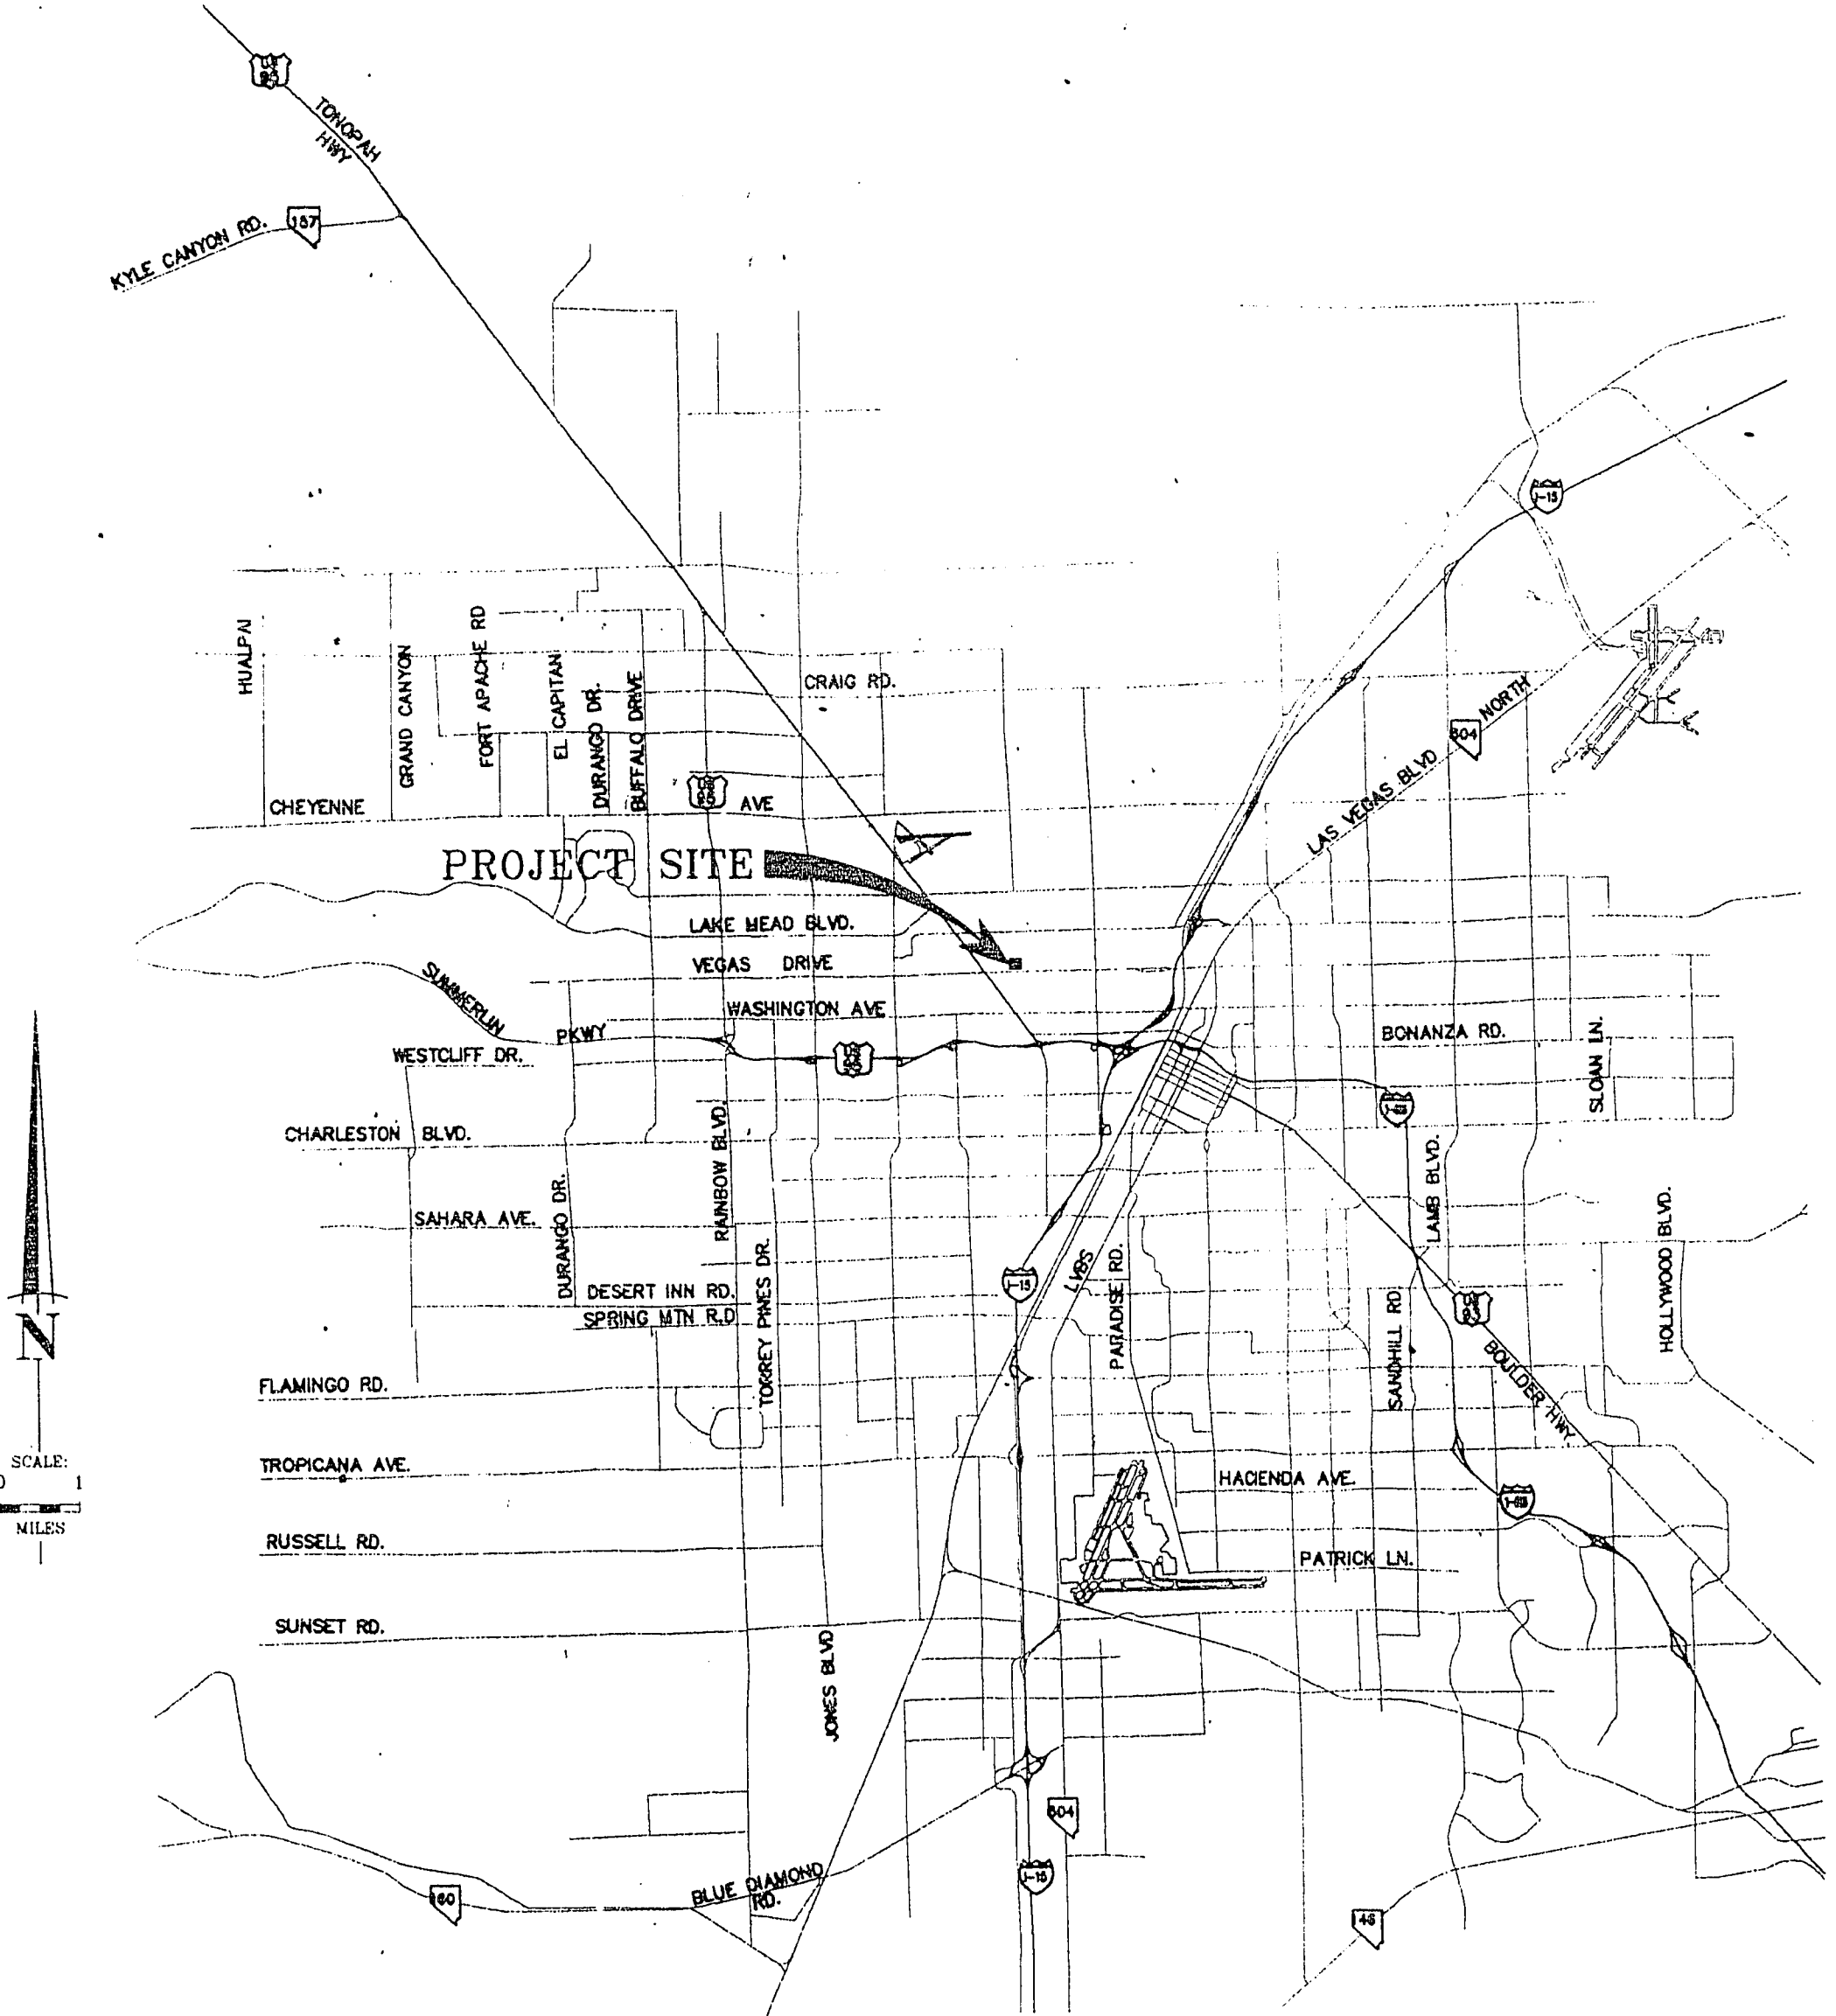

VICINITY MAP

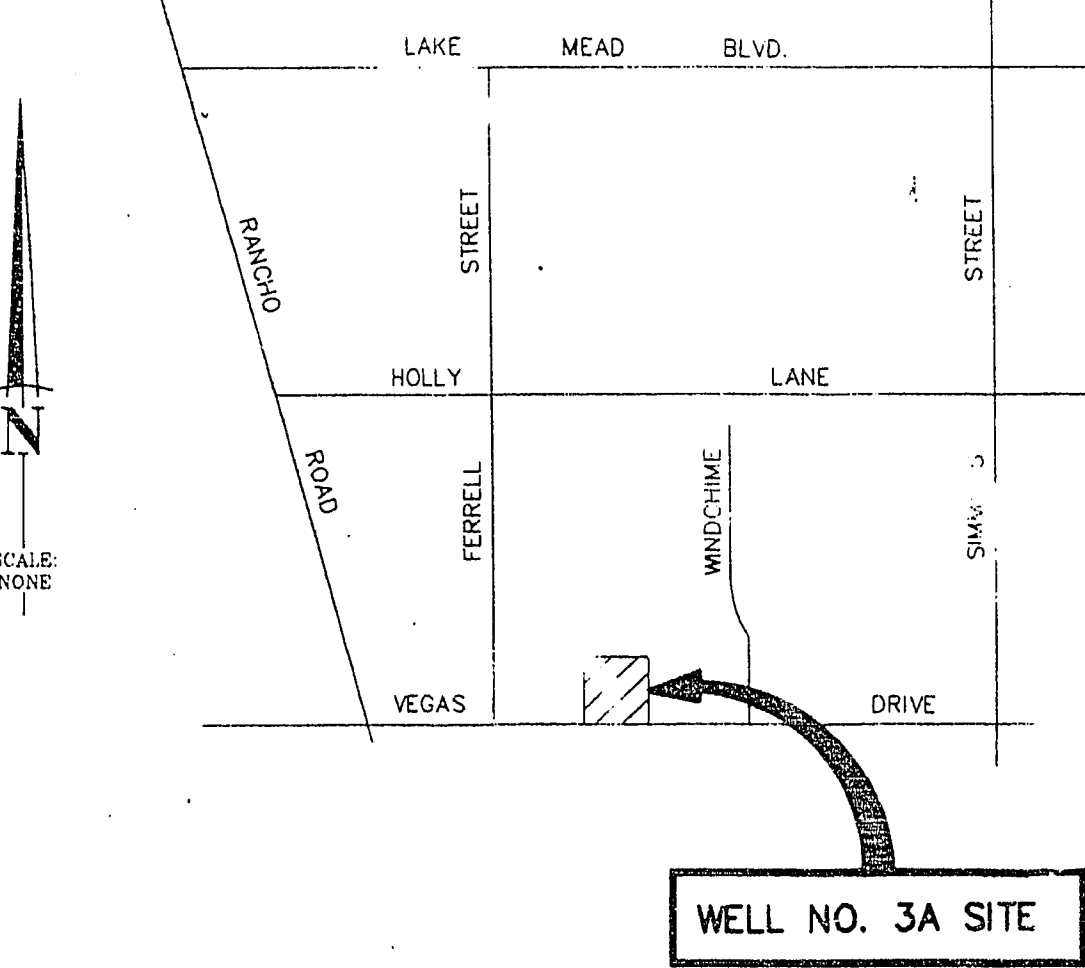

KEY MAP

CAUTION TO CONTRACTOR:
THE CONTRACTOR SHALL BE RESPONSIBLE TO INVESTIGATE AND VERIFY THE ACTUAL LOCATION AND DEPTH OF ALL EXISTING UNDERGROUND FACILITIES AT LEAST 48 HOURS IN ADVANCE OF THE PERFORMANCE OF ANY WORK.

SCALE: AS SHOWN	FILE NAME: C0746C01 DATE: 12/8/94	RECOMMENDED: JEROME A. STOEVE DATE: 6-8-95
	DRAWN: G.B./P.J. DATE: 4/26/95	APPROVED: P. M. DATE: 6-22-95
	CHECKED: G. E. WALLACE DATE: 5/9/95	SHAWN A. MOLLUS DATE: 6-22-95

LAS VEGAS VALLEY WATER DISTRICT
1001 SOUTH VALLEY VIEW BOULEVARD
LAS VEGAS, NEVADA 89153

EQUIP WELL NO. 3A
TITLE SHEET

SHEETS E1 THROUGH E12
SHEETS C2 THROUGH C9 AND B1 THROUGH B4

D. KEITH BAIRD
JEROME A. STOEVE

746
REF. SHEET NO. 11
SHEET 1 OF 25

NO746001.TIF