

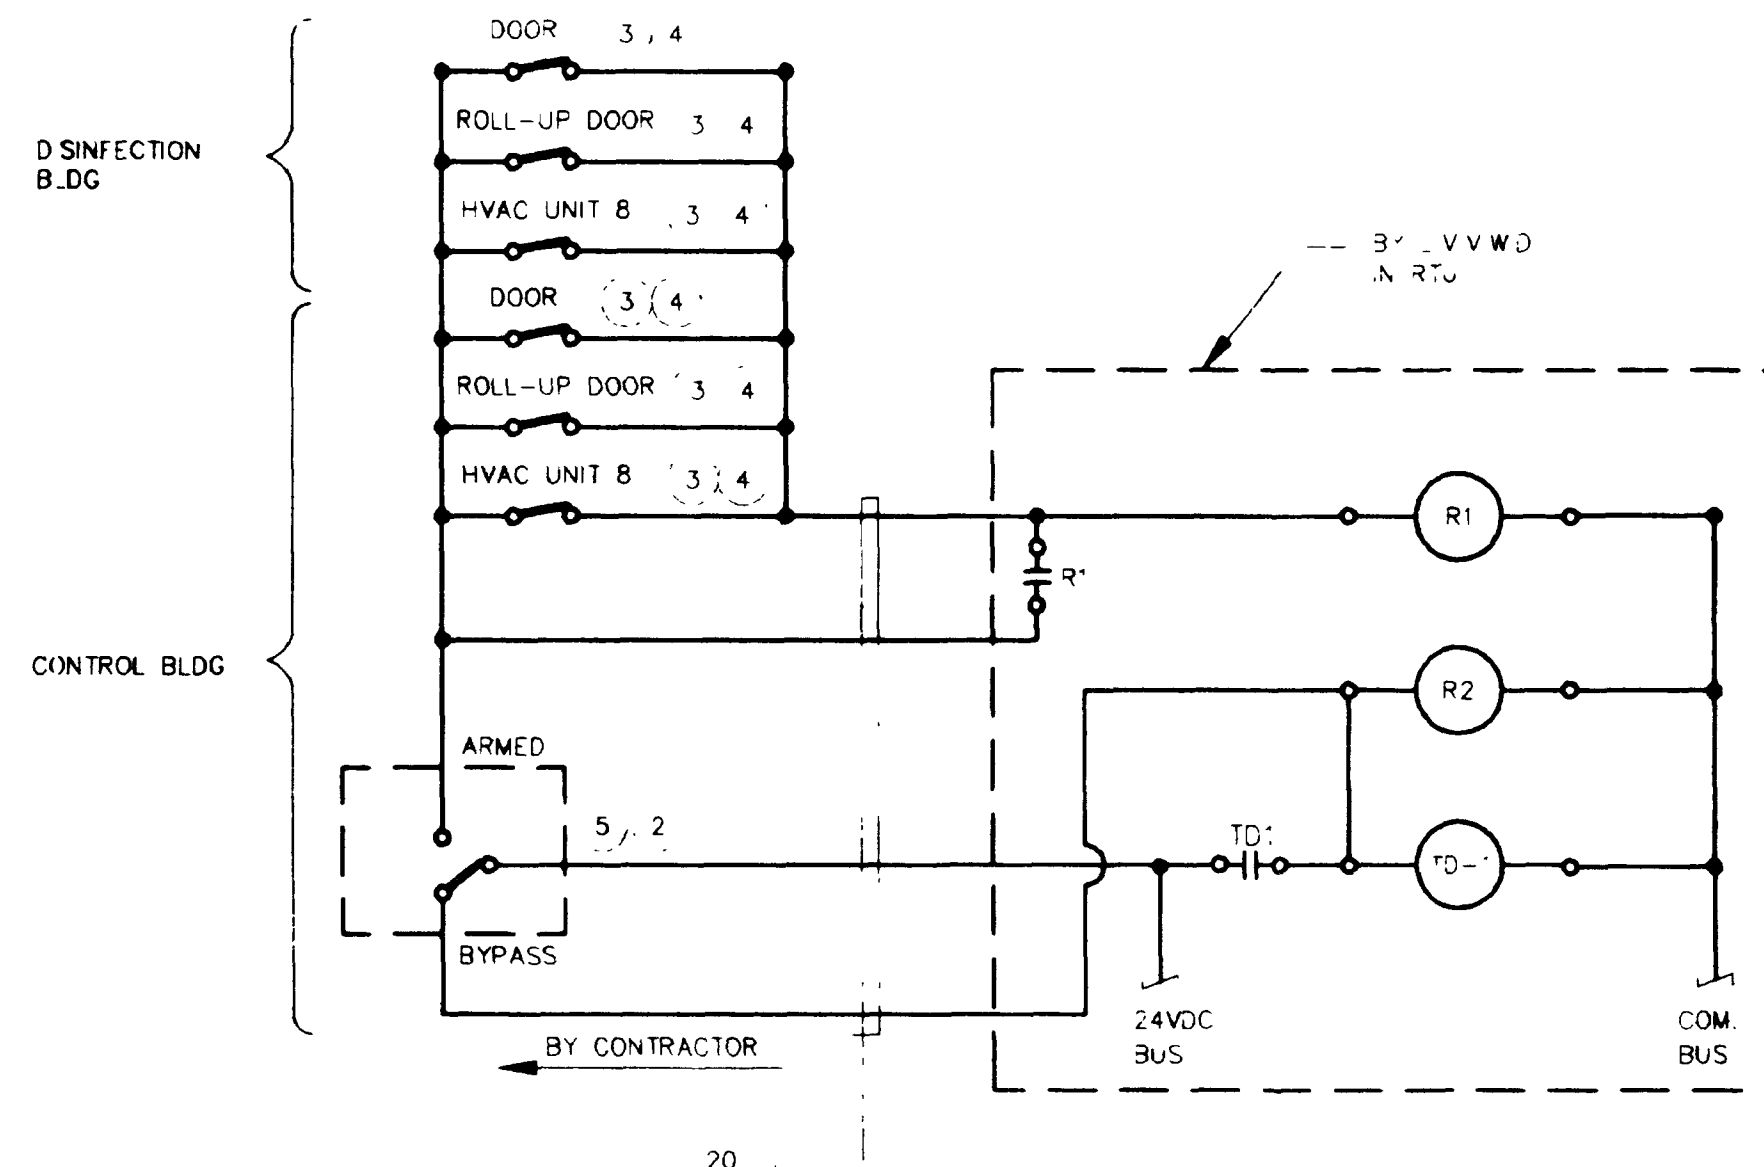
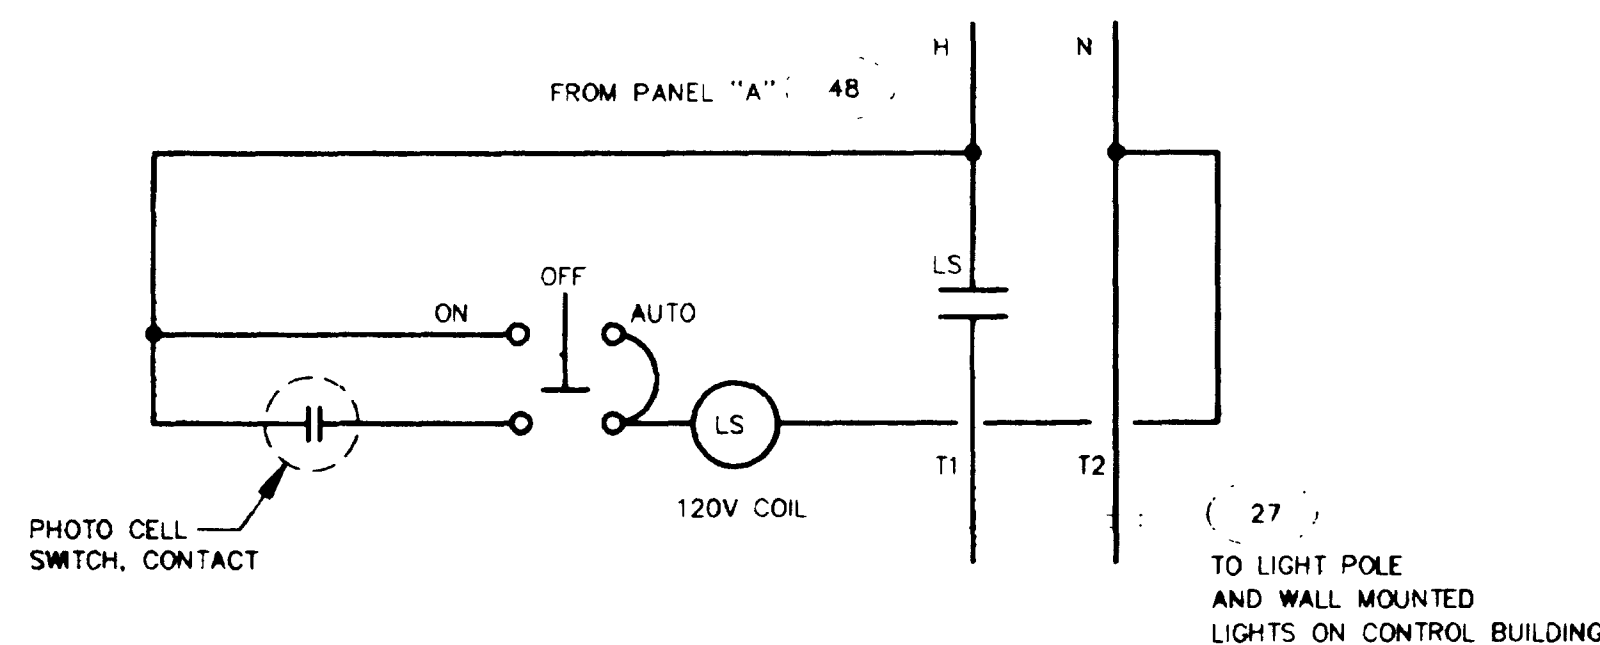
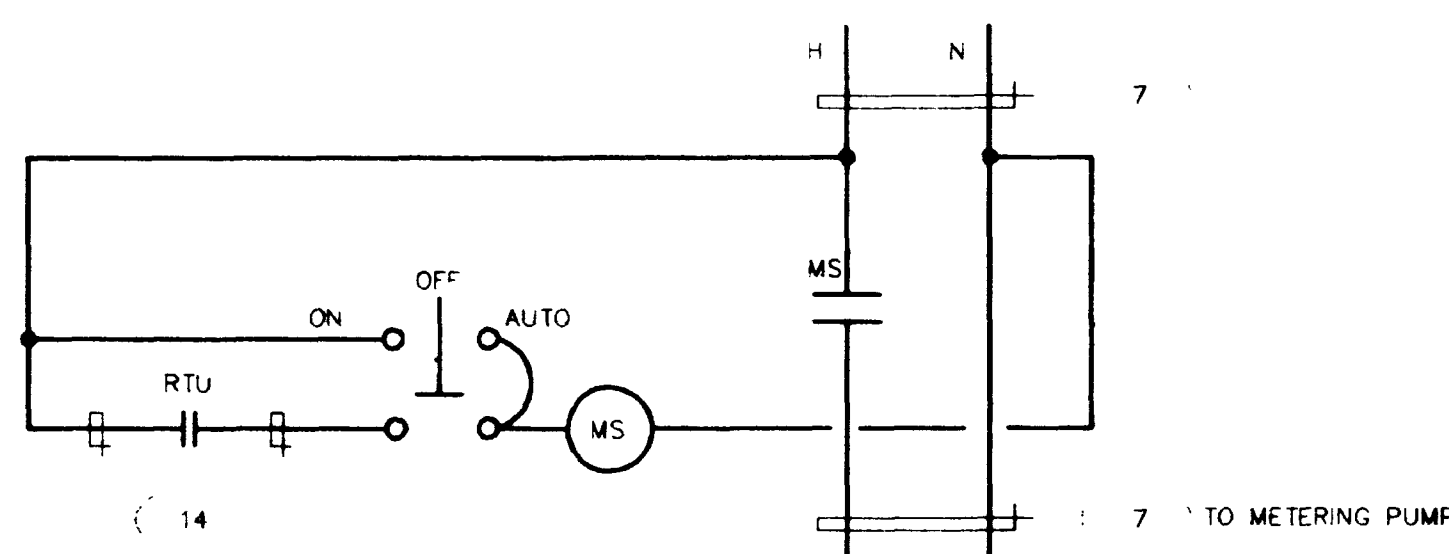


29-15-88

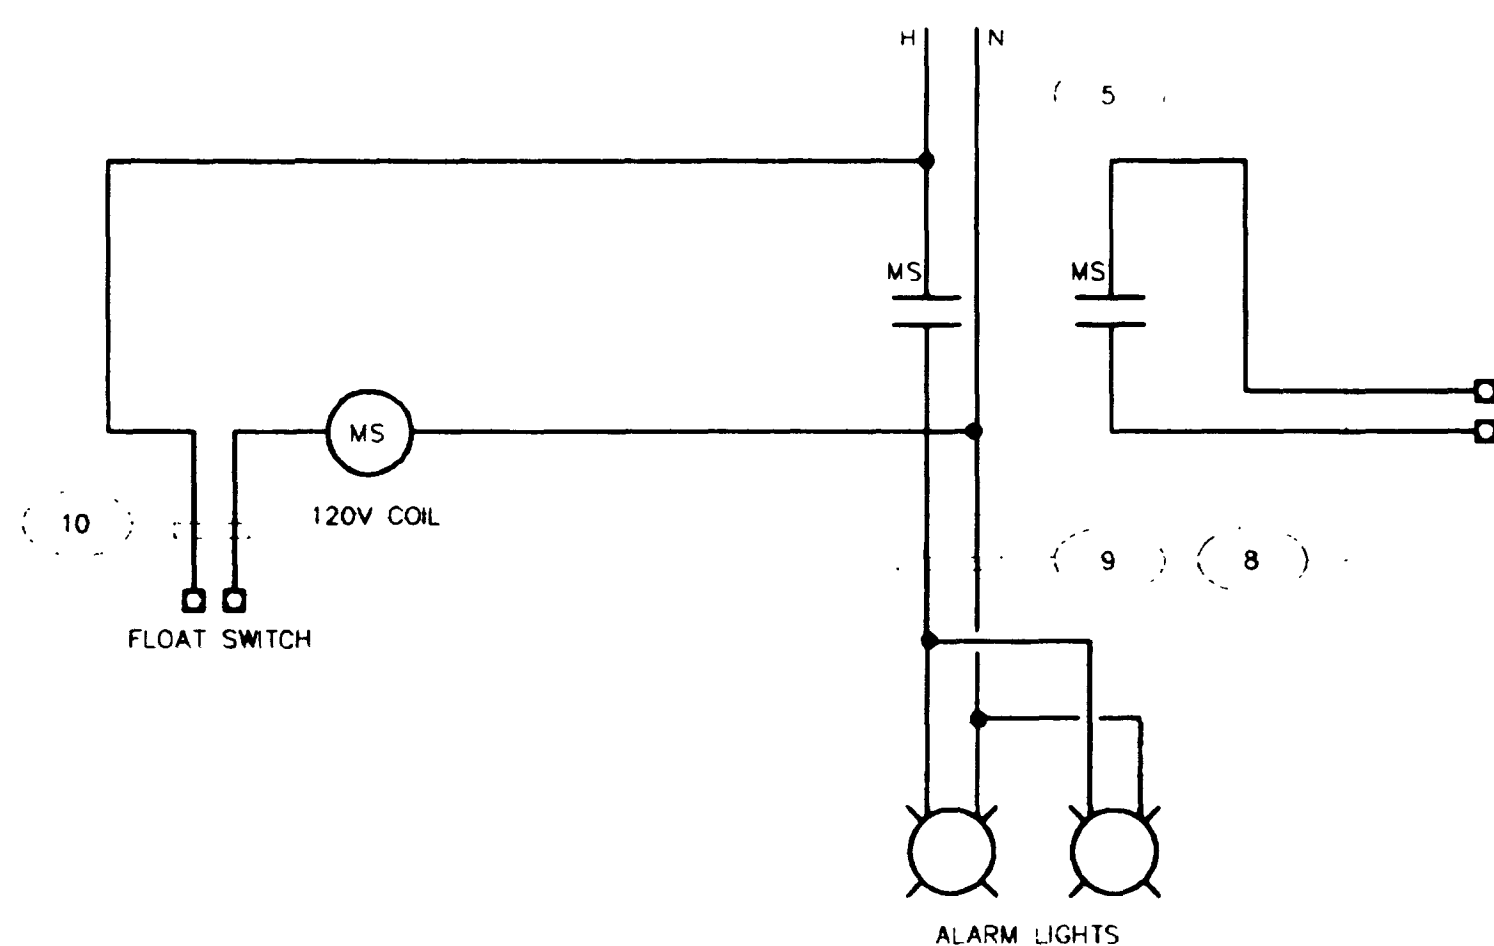


- NOTES
- FROM RTU
 - EXTERNAL KEY SWITCH
 - REPRESENTS ALARM SWITCH
 - CLOSES WHEN DOOR OPENS
 - VENDOR, NEVADA LOCK SUPPLY, P/N 3535.
NOTE: KEY TO WYE 2387

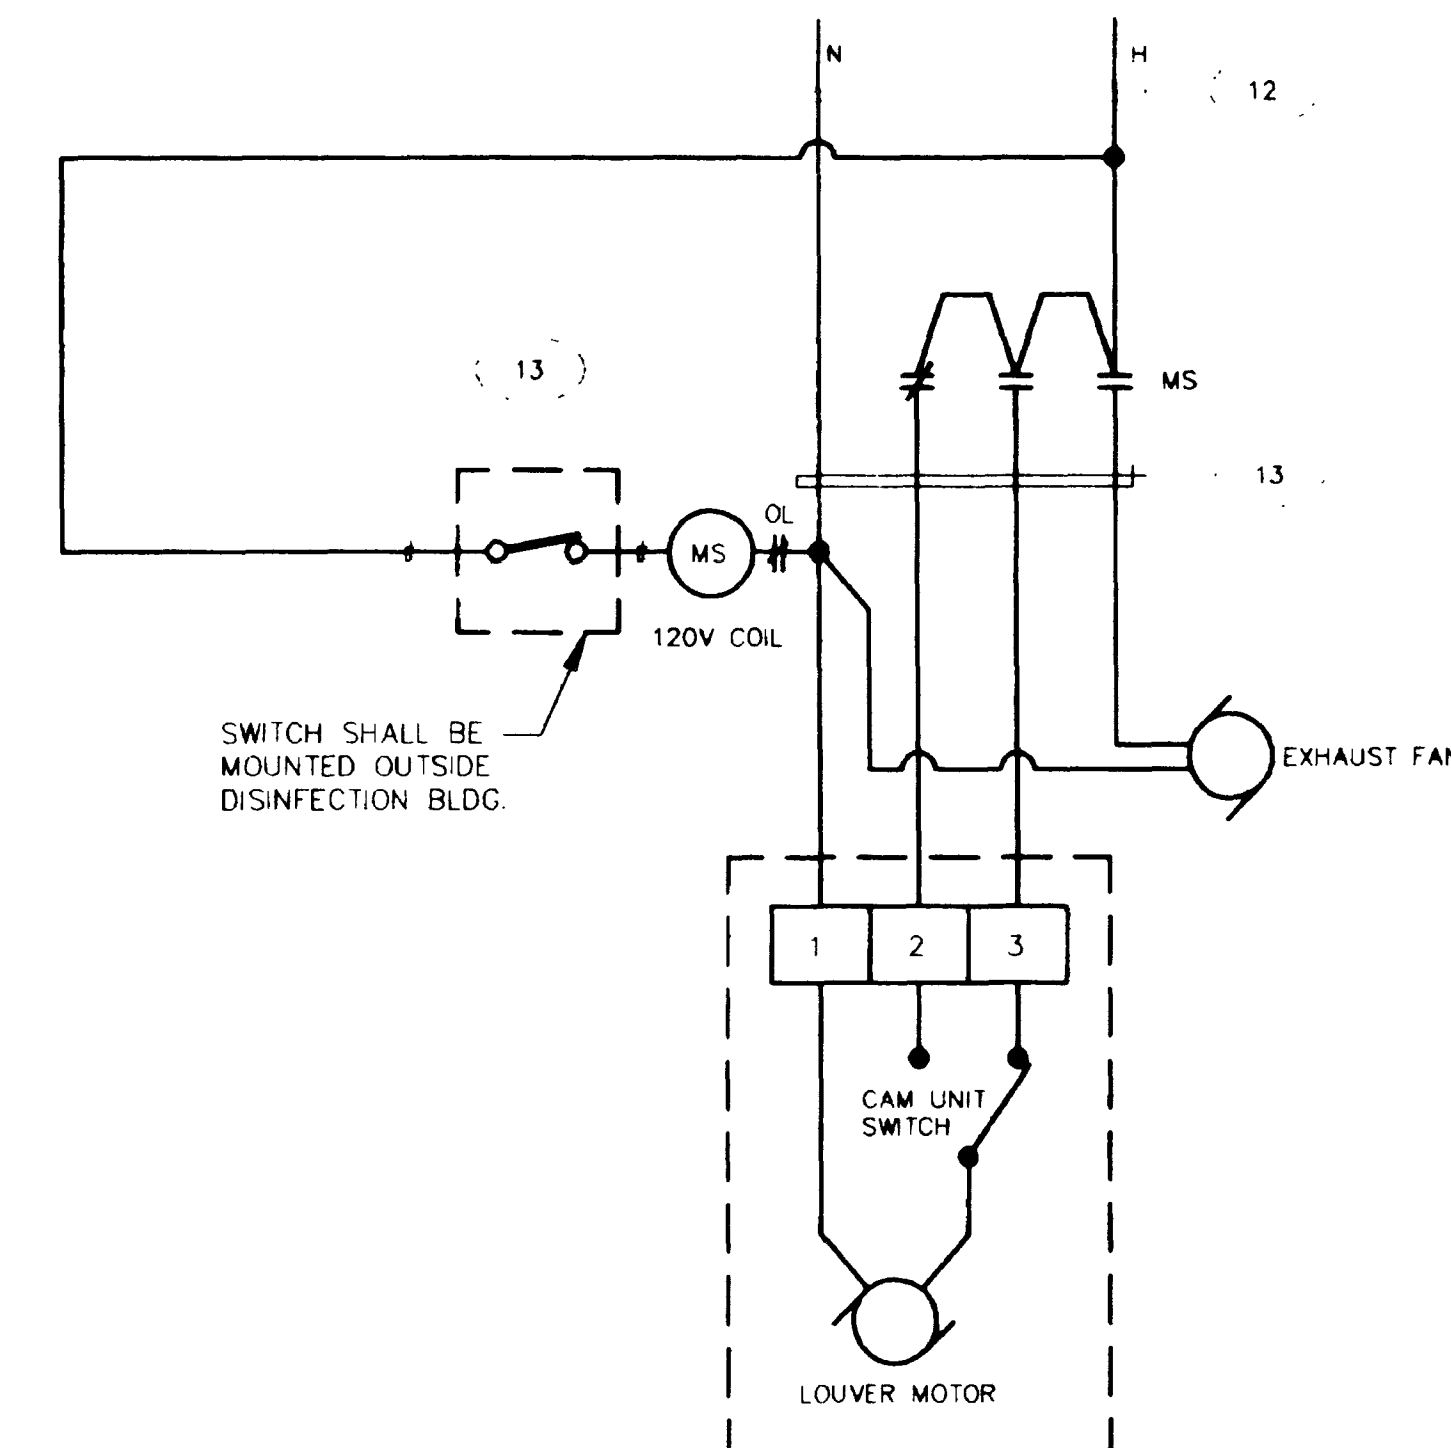

INTRUSION ALARM SYSTEM

EXHAUST FAN/LOUVERS DIAGRAM

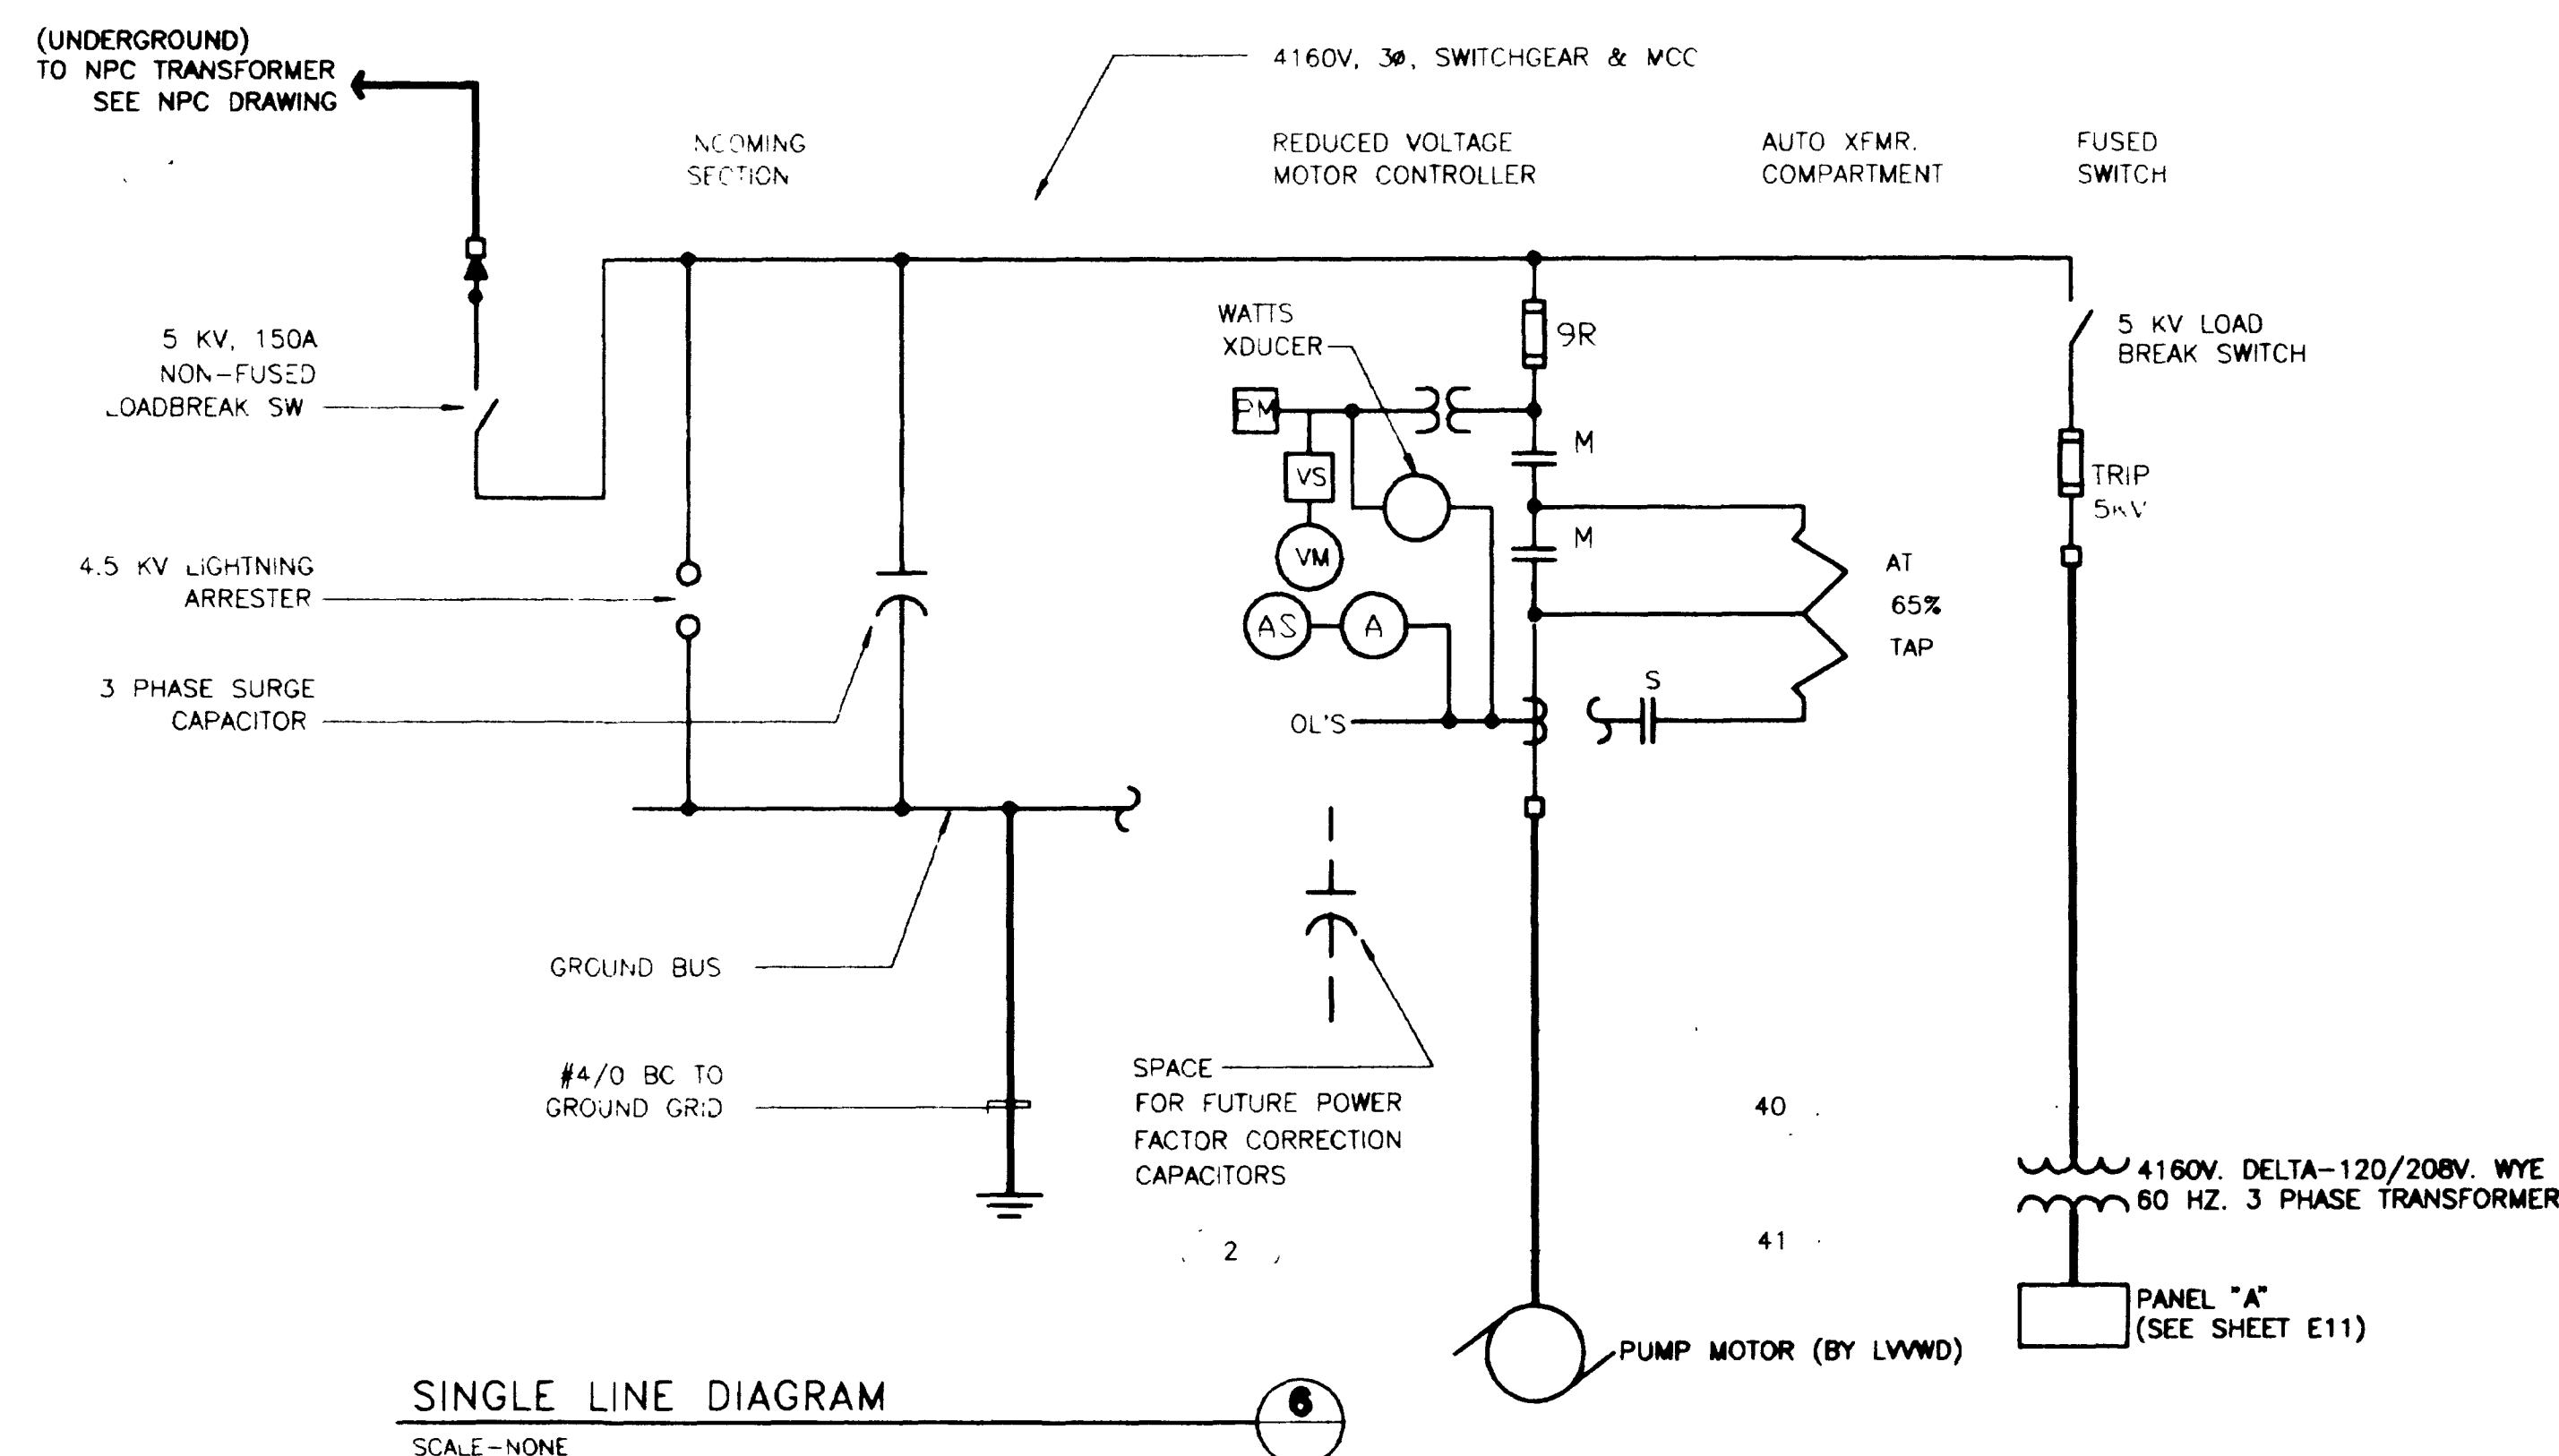

REV	DESCRIPTION	BY	DATE	CHKD

SCALE:	FILE NAME: C0737E10.DWG	DATE: 12/19/94	RECOMMENDED	DATE: 4-25-95
NONE	DRAWN: J. E. SALDANA	DATE: 012/19/94	D. KEITH BAIRD	RPE NO. DATE
NONE	CHECKED: JQA	DATE: 04/17/95	APPROVED	DATE: 5/5/95
			SHAWN P. MOLLUS	RPE NO. DATE

LAS VEGAS VALLEY WATER DISTRICT
1001 SOUTH VALLEY VIEW BOULEVARD
LAS VEGAS, NEVADA 89153

EQUIP WELL NOS. 102 AND 105
SINGLE LINE DIAGRAM,
SCHEMATIC DIAGRAMS



DRAWING NUMBER
737
REF. SHEET NO. 10
SHEET 27 OF 31

9528 3 QS 374 565-267

NOT37027.TIF

