



04-15-87

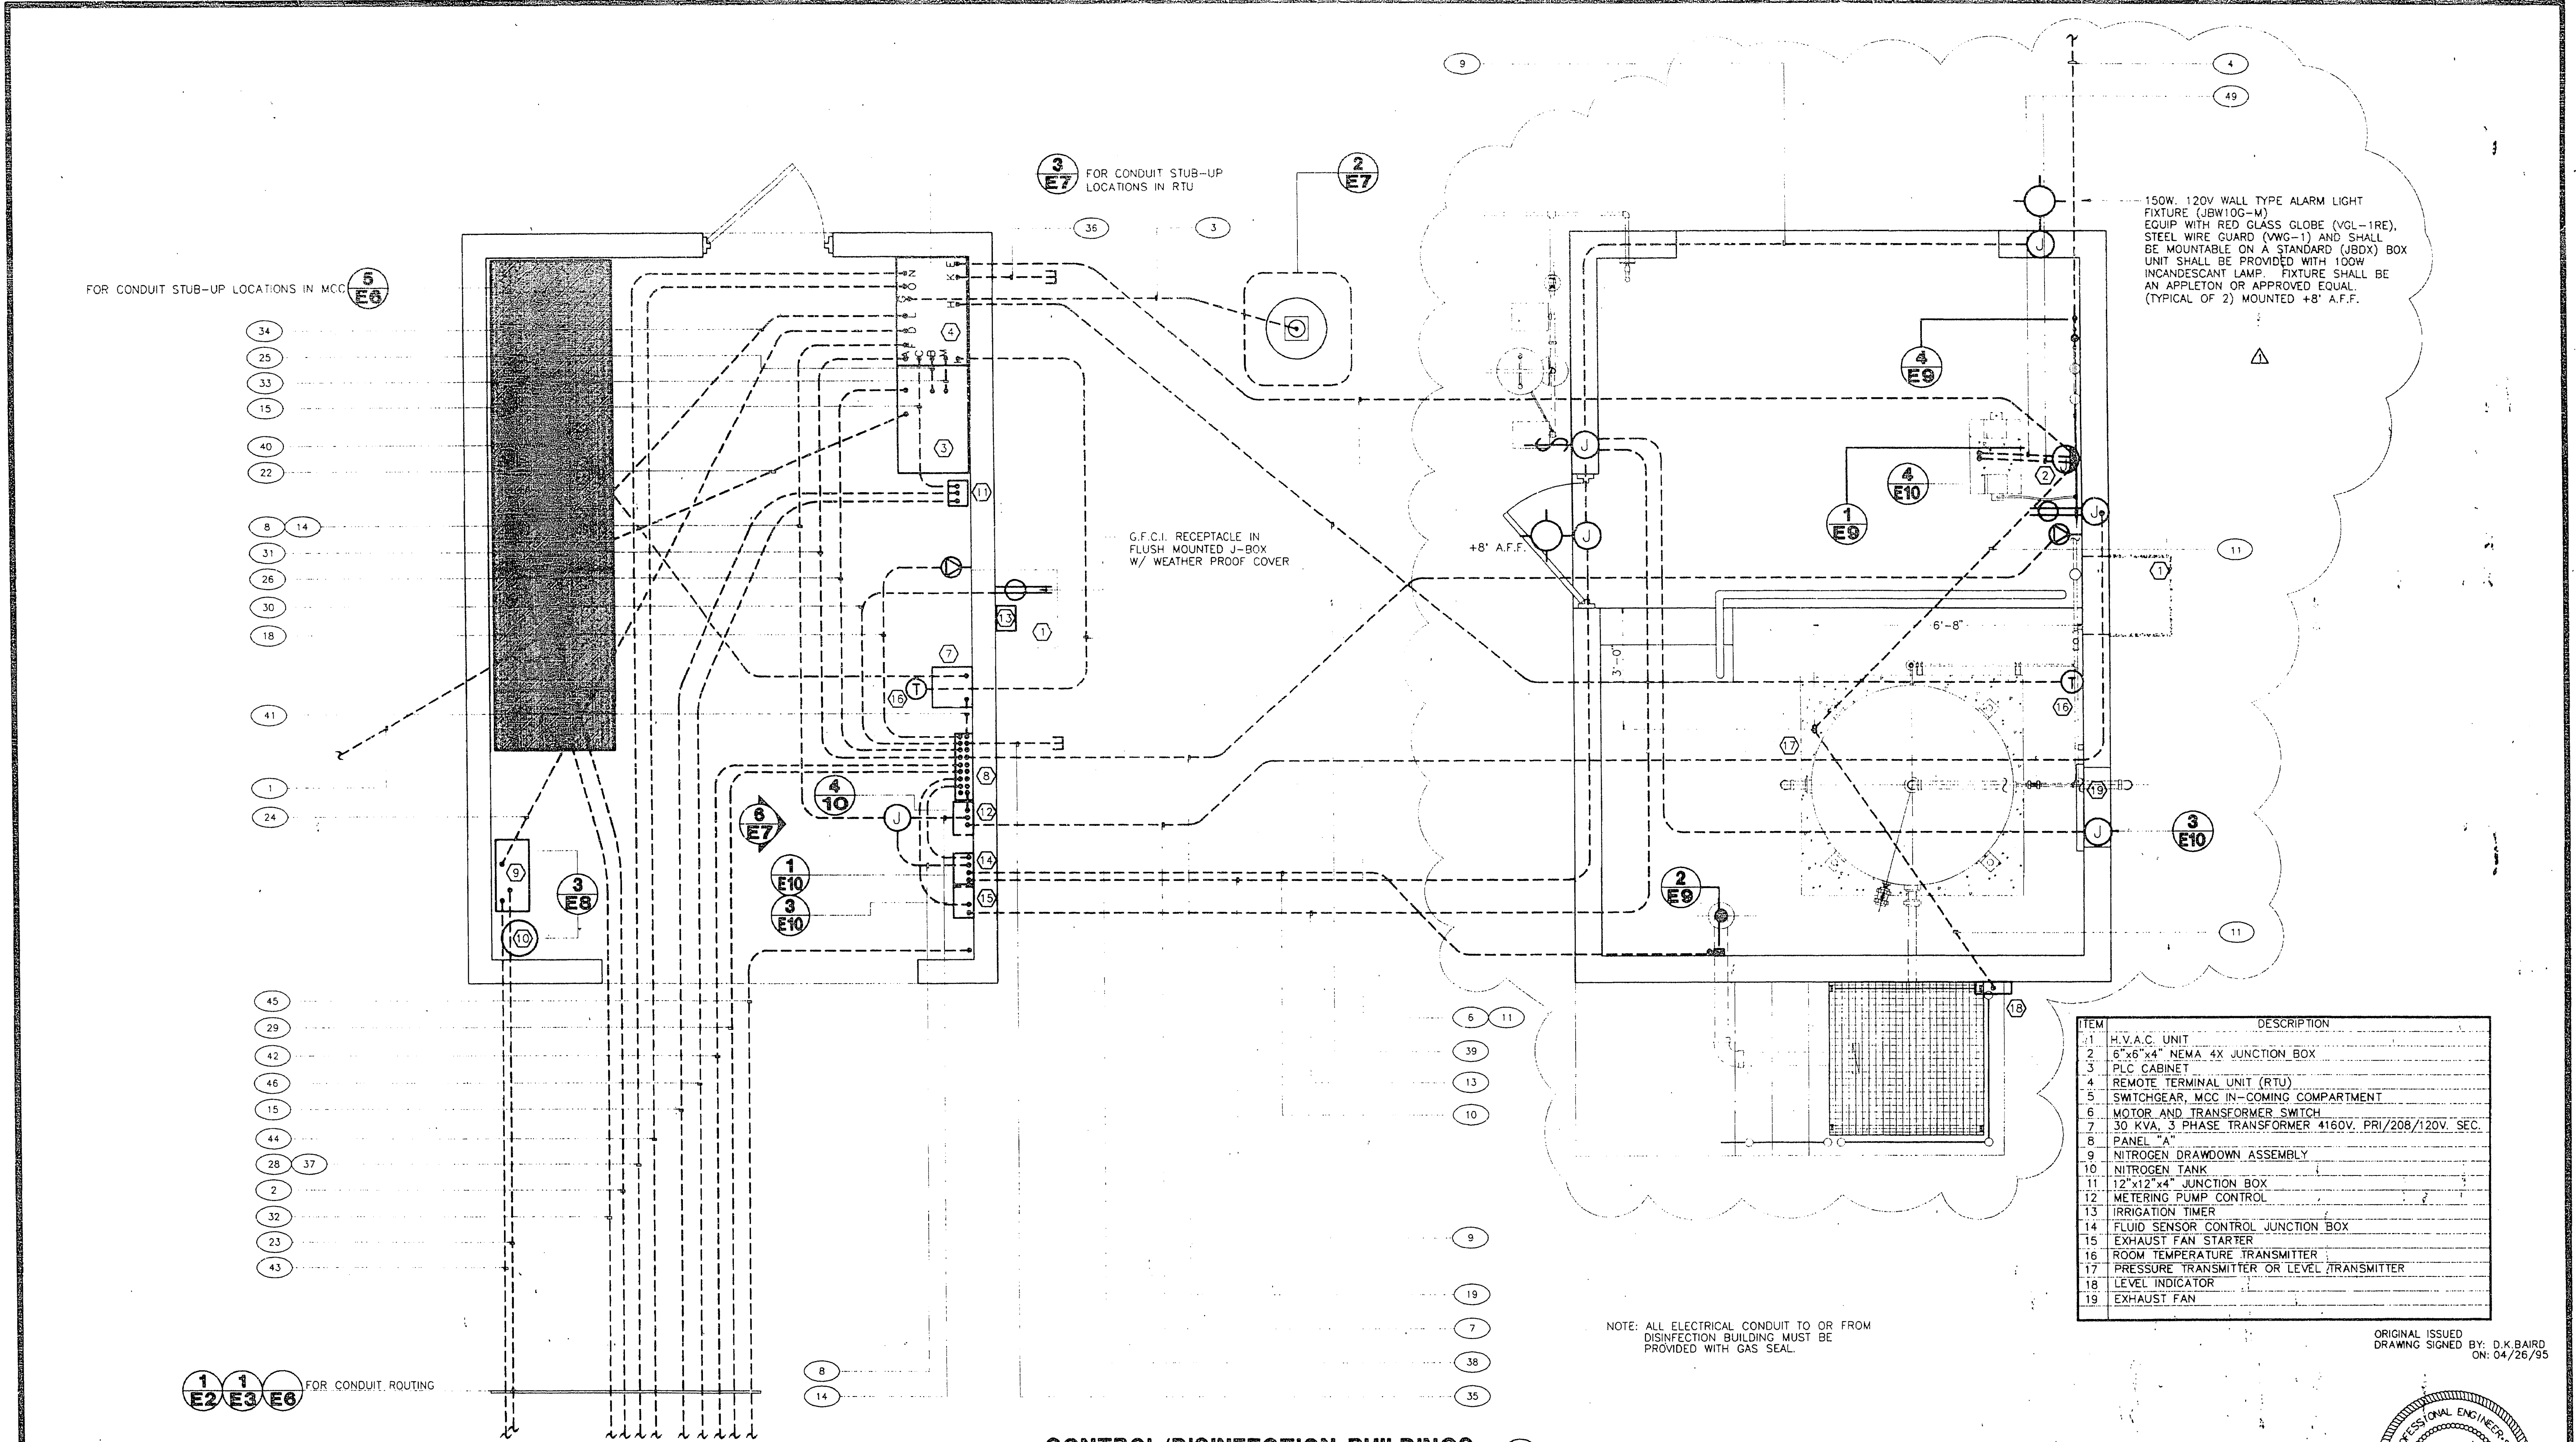

ITEM	DESCRIPTION
1	H.V.A.C. UNIT
2	6"x6"x4" NEMA 4X JUNCTION BOX
3	PLC CABINET
4	REMOTE TERMINAL UNIT (RTU)
5	SWITCHGEAR, MCC IN-COMING COMPARTMENT
6	MOTOR AND TRANSFORMER SWITCH
7	30 KVA, 3 PHASE TRANSFORMER 4160V, PRI/208/120V, SEC.
8	PANEL "A"
9	NITROGEN DRAWDOWN ASSEMBLY
10	NITROGEN TANK
11	12"x12"x4" JUNCTION BOX
12	METERING PUMP CONTROL
13	IRRIGATION TIMER
14	FLUID SENSOR CONTROL JUNCTION BOX
15	EXHAUST FAN STARTER
16	ROOM TEMPERATURE TRANSMITTER
17	PRESSURE TRANSMITTER OR LEVEL TRANSMITTER
18	LEVEL INDICATOR
19	EXHAUST FAN

ORIGINAL ISSUED
DRAWING SIGNED BY: D.K. BAIRD
ON: 04/26/95

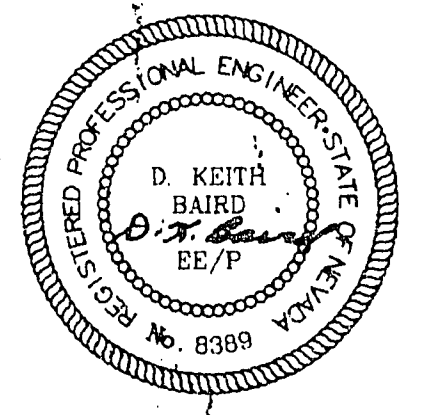

CONTROL/DISINFECTION BUILDINGS
SCALE: 1/2" = 1'-0"

CONTROL BUILDING

DISINFECTION BUILDING

SCALE: 1" = 2'	FILE NAME: C0737E04.DWG DATE: 12/14/94	RECOMMENDED BY: D. Keith Baird 8389 5-30-95
DRAWN: J. E. SALDANA DATE: 12/14/94	CHECKED: JDA DATE: 04/17/95	APPROVED: Shawn P. Mollus 9651 5-30-95
DATE: 5/24/95	DATE: 5/24/95	DATE: 5/24/95

LAS VEGAS VALLEY WATER DISTRICT
1001 SOUTH VALLEY VIEW BOULEVARD
LAS VEGAS, NEVADA 89153

EQUIP WELL NOS. 102 AND 105
CONTROL BUILDING,
DISINFECTION BUILDING ELECTRICAL PLAN

DRAWING NUMBER
737
REF. SHEET NO. 21 OF 31

NO737021.TIF 09:17 05/30/95