



2A-5-76

ITEM	DESCRIPTION	SPEC SEC/DIV
1	AIR CONDITIONER / HEATER UNIT	DIV 43
2	SPLIT FACED 8"x 8"x 16" PIGMENTED CMU WALLS	DIV 17
	SOLID GROUT ALL CELLS.	
3	ROLLING SERVICE DOOR	DIV 62
4	STEEL SERVICE DOOR	DIV 62
5	PAINT INTERIOR WHITE	DIV 15


NOTE: FOR ELECTRICAL EQUIPMENT AND CONDUIT LAYOUT SEE SHEET E4.

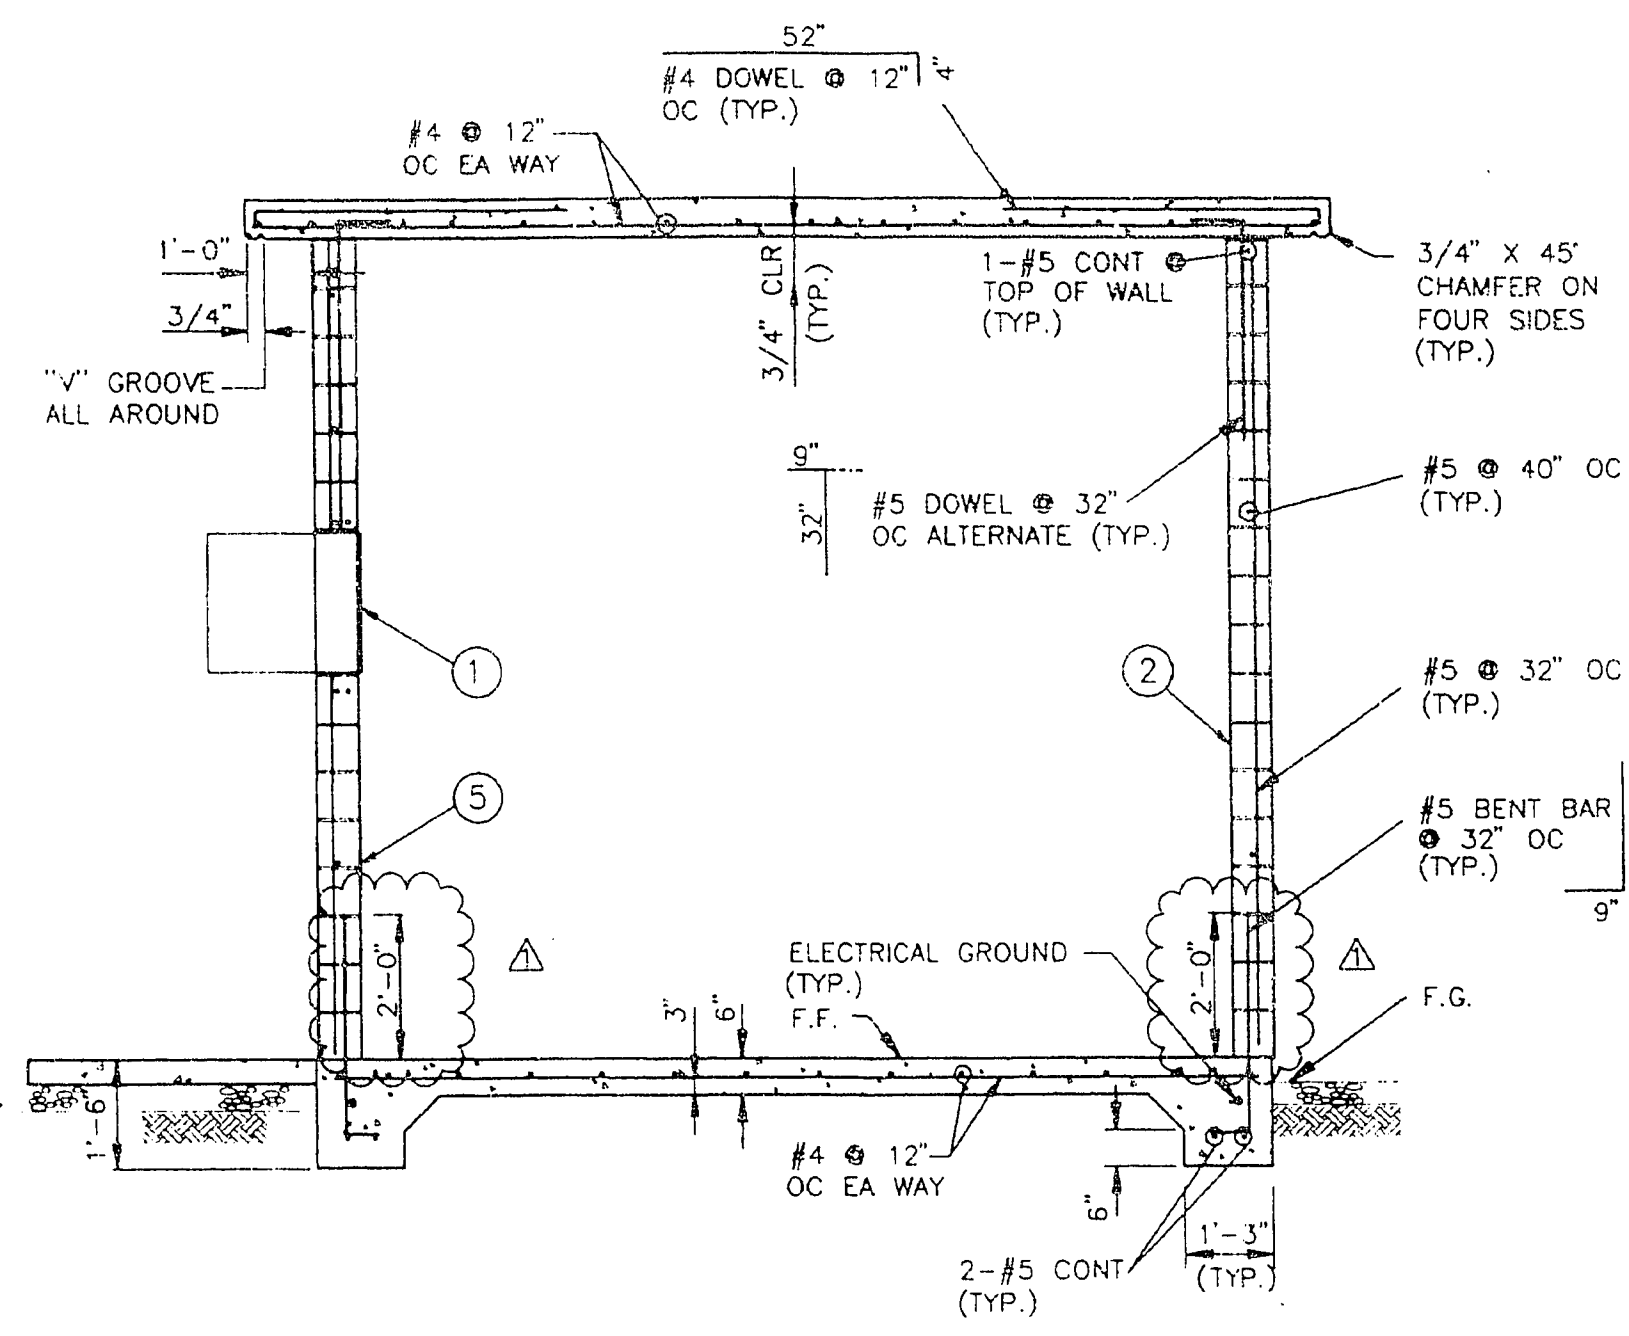


SECTION A-A
SCALE: 3/8" = 1'-0"

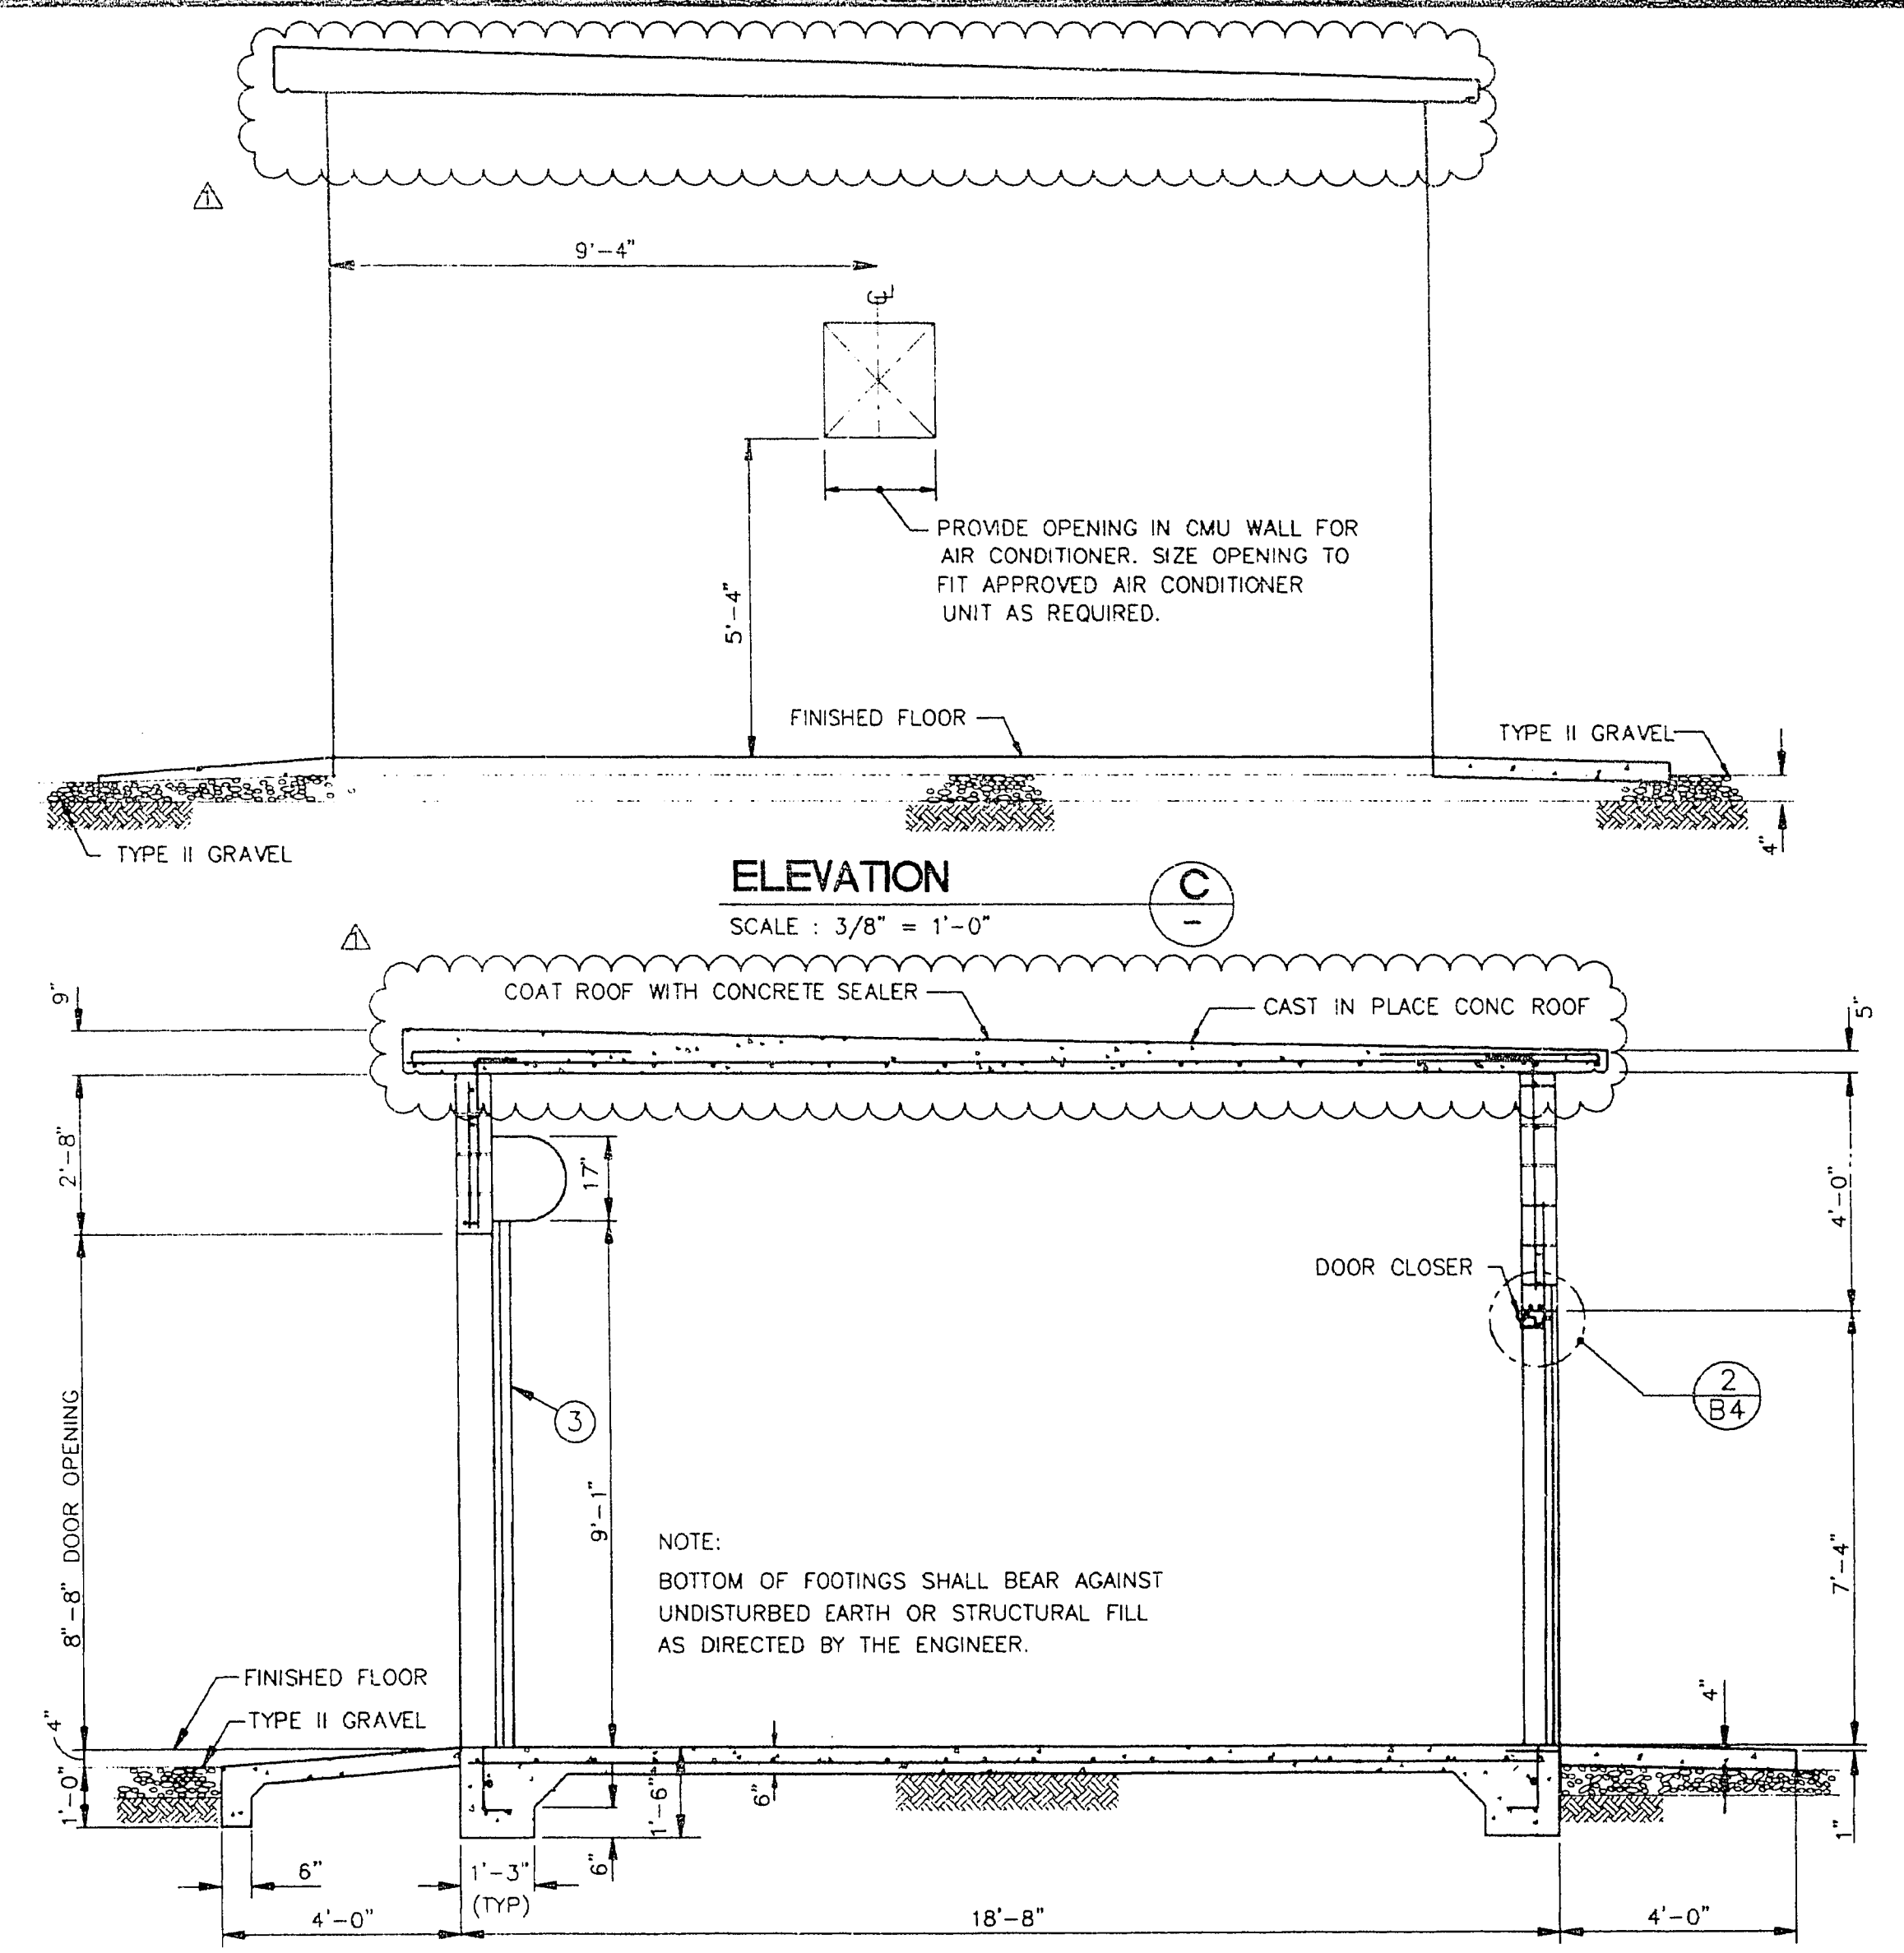


ELEVATION C-C
SCALE: 3/8" = 1'-0"

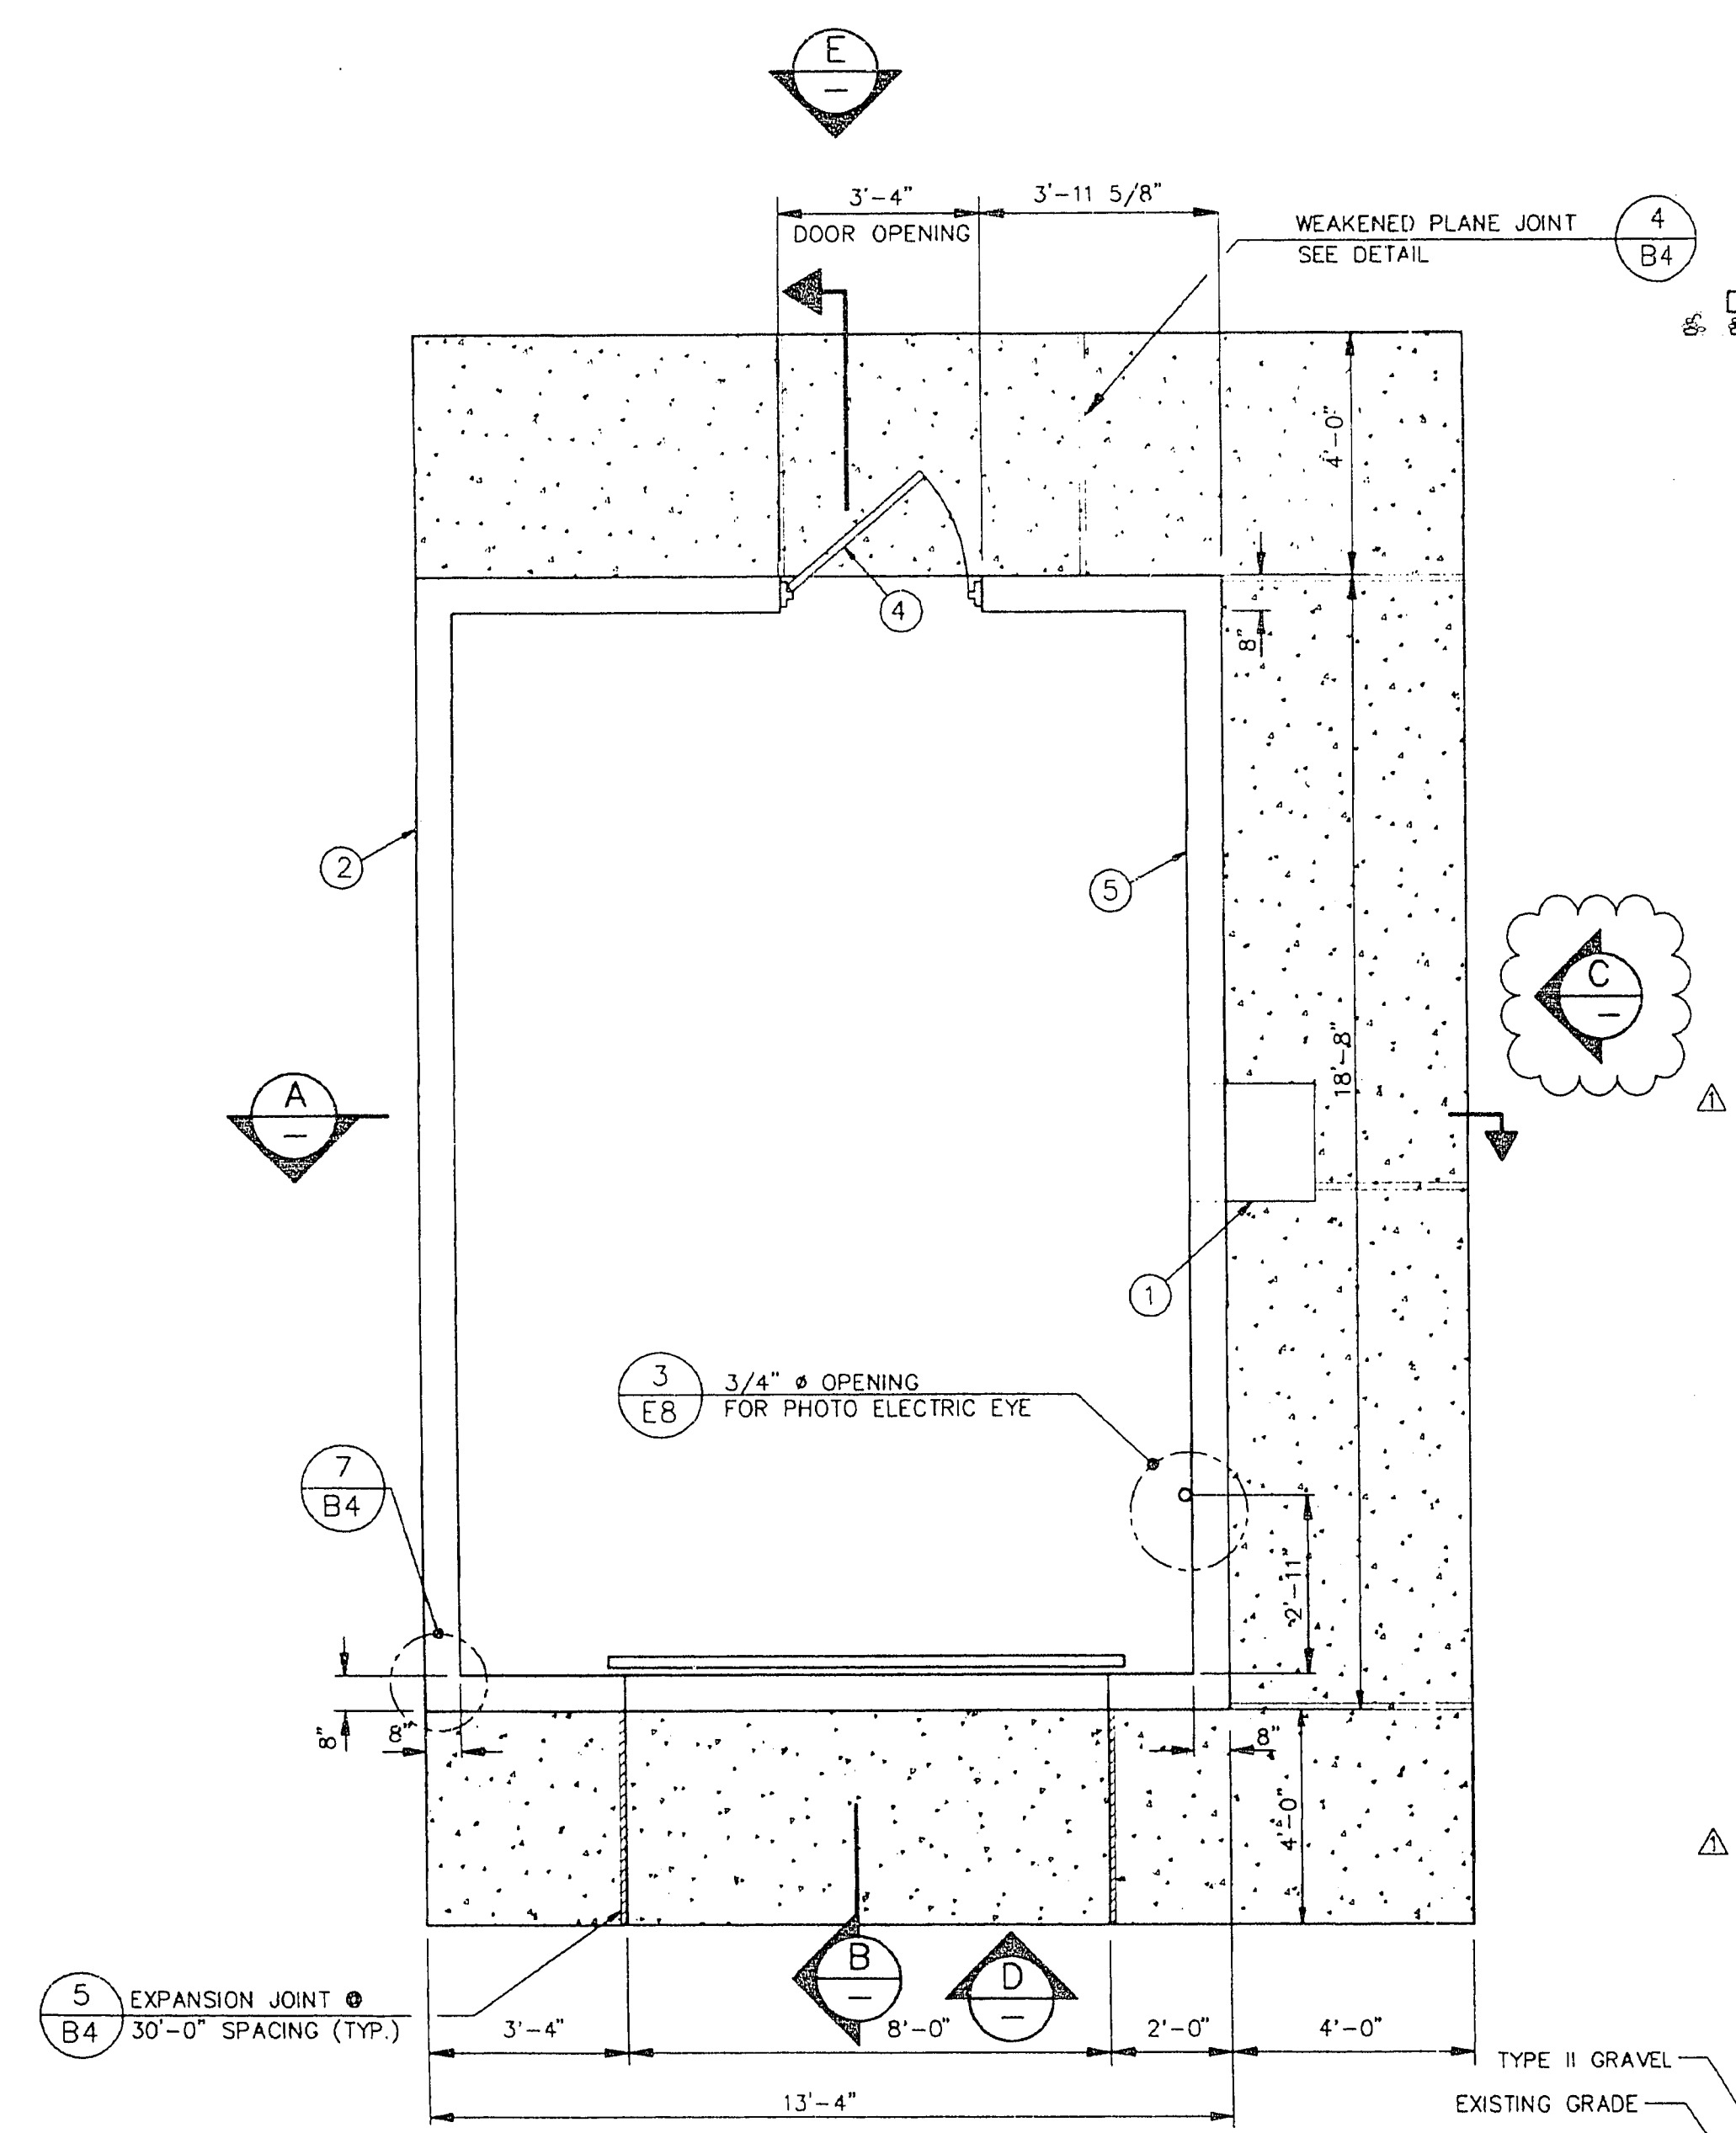

CONTROL BUILDING - FLOOR PLAN
SCALE: 3/8" = 1'-0"

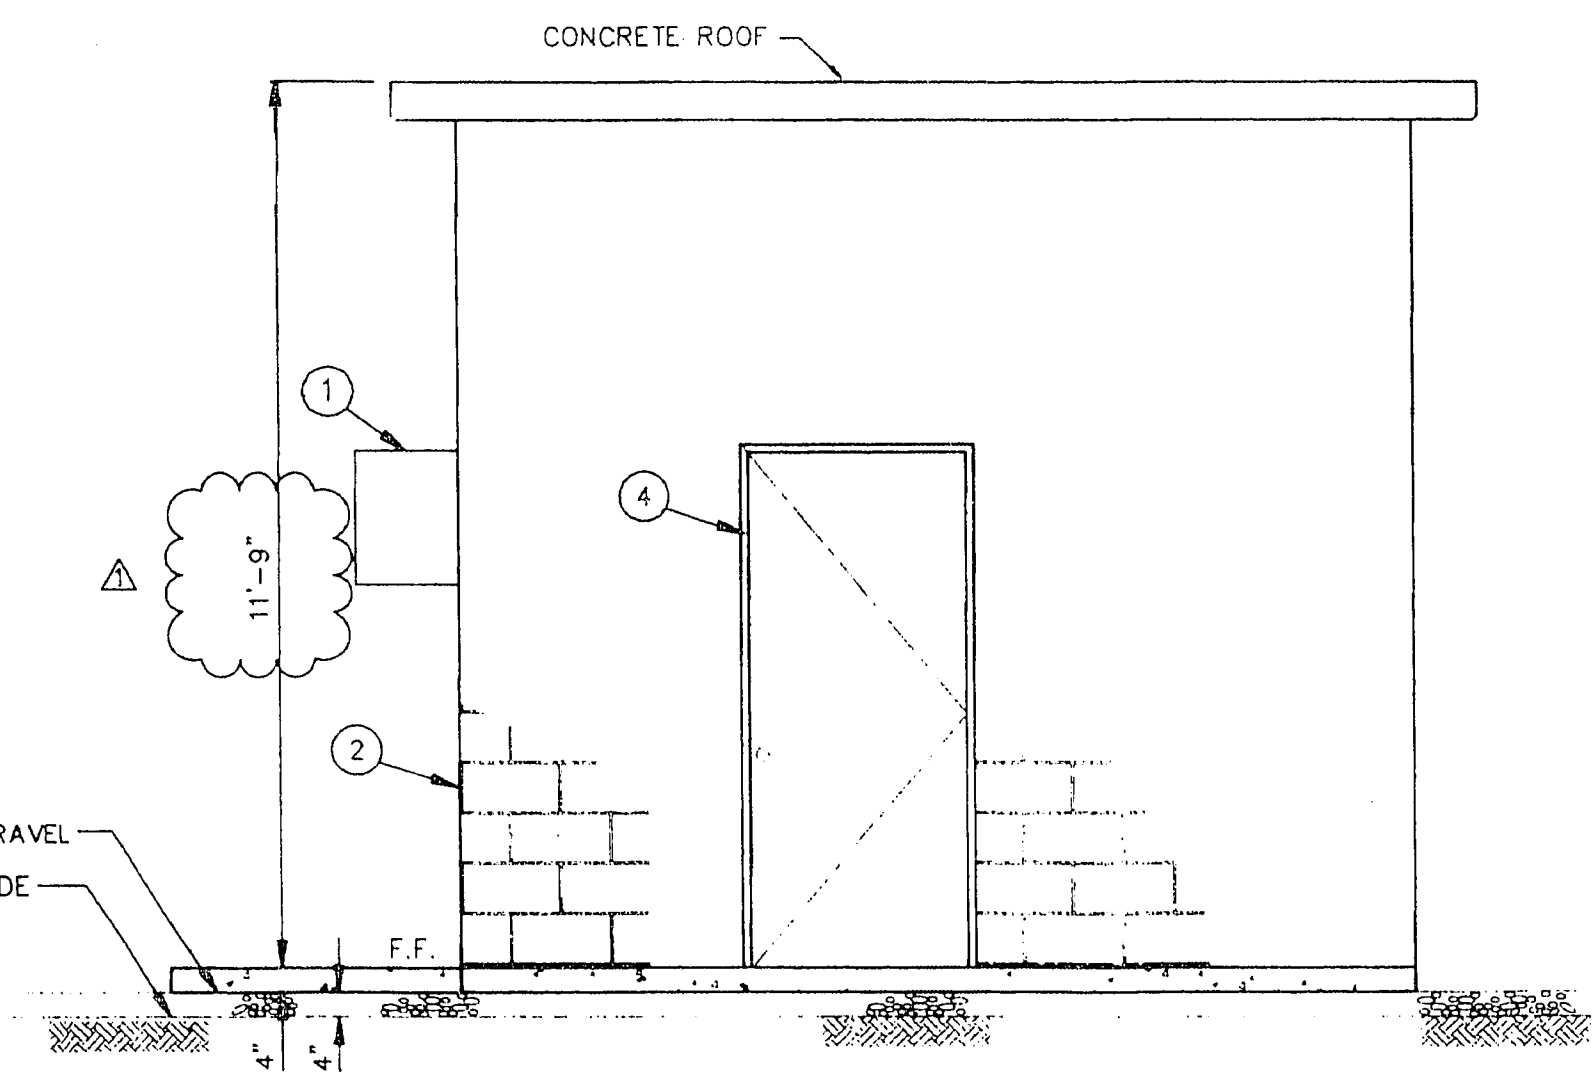


ELEVATION E-E
SCALE: 3/8" = 1'-0"

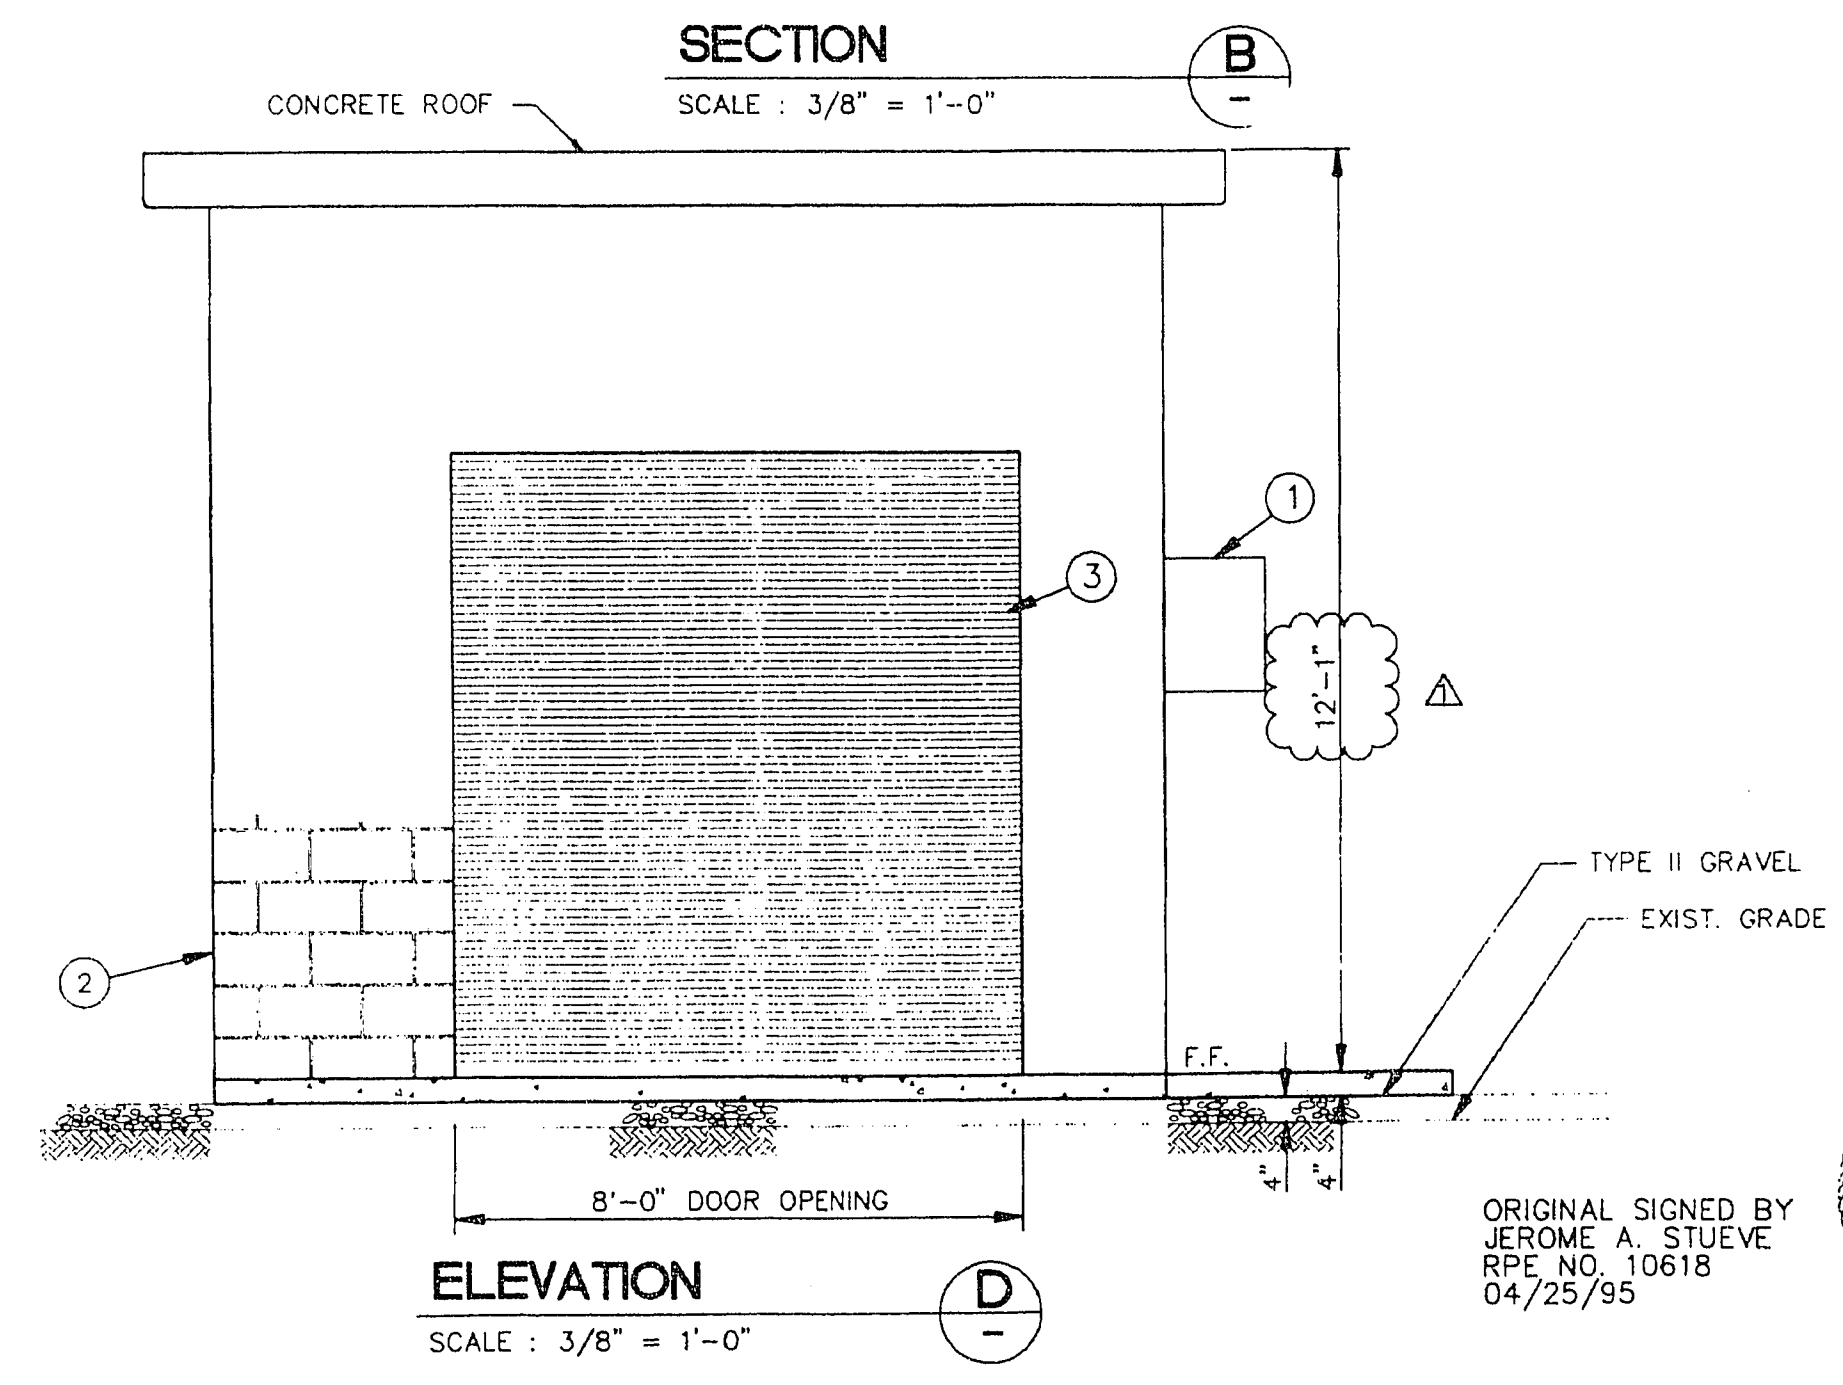

ELEVATION D-D
SCALE: 3/8" = 1'-0"

ORIGINAL SIGNED BY
JEROME A. STUEVE
RPE NO. 10618
04/25/95

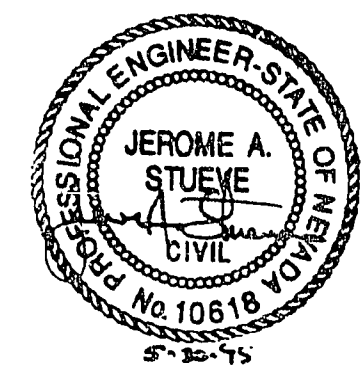

LAS VEGAS VALLEY WATER DISTRICT
1001 SOUTH VALLEY VIEW BOULEVARD
LAS VEGAS, NEVADA 89153

EQUIP WELL NOS. 102 AND 105
CONTROL BUILDING

DRAWING NUMBER
737
SHEET 15 OF 31

NO737015.TIF

SCALE:	FILE NAME: CO237B2.DWG	DATE: 11/11/94	REVISION:	10618	5-30-95
NOTED	DRAWN: P.J./G.B.	DATE: 11/11/94	APPROVED:	JEROME A. STUEVE	RPE NO.
	CHECKED: G.E.W.	DATE: 4/17/95	APPROVED:	SHAWN P. WOLLOS	RPE NO.