


29-15-48

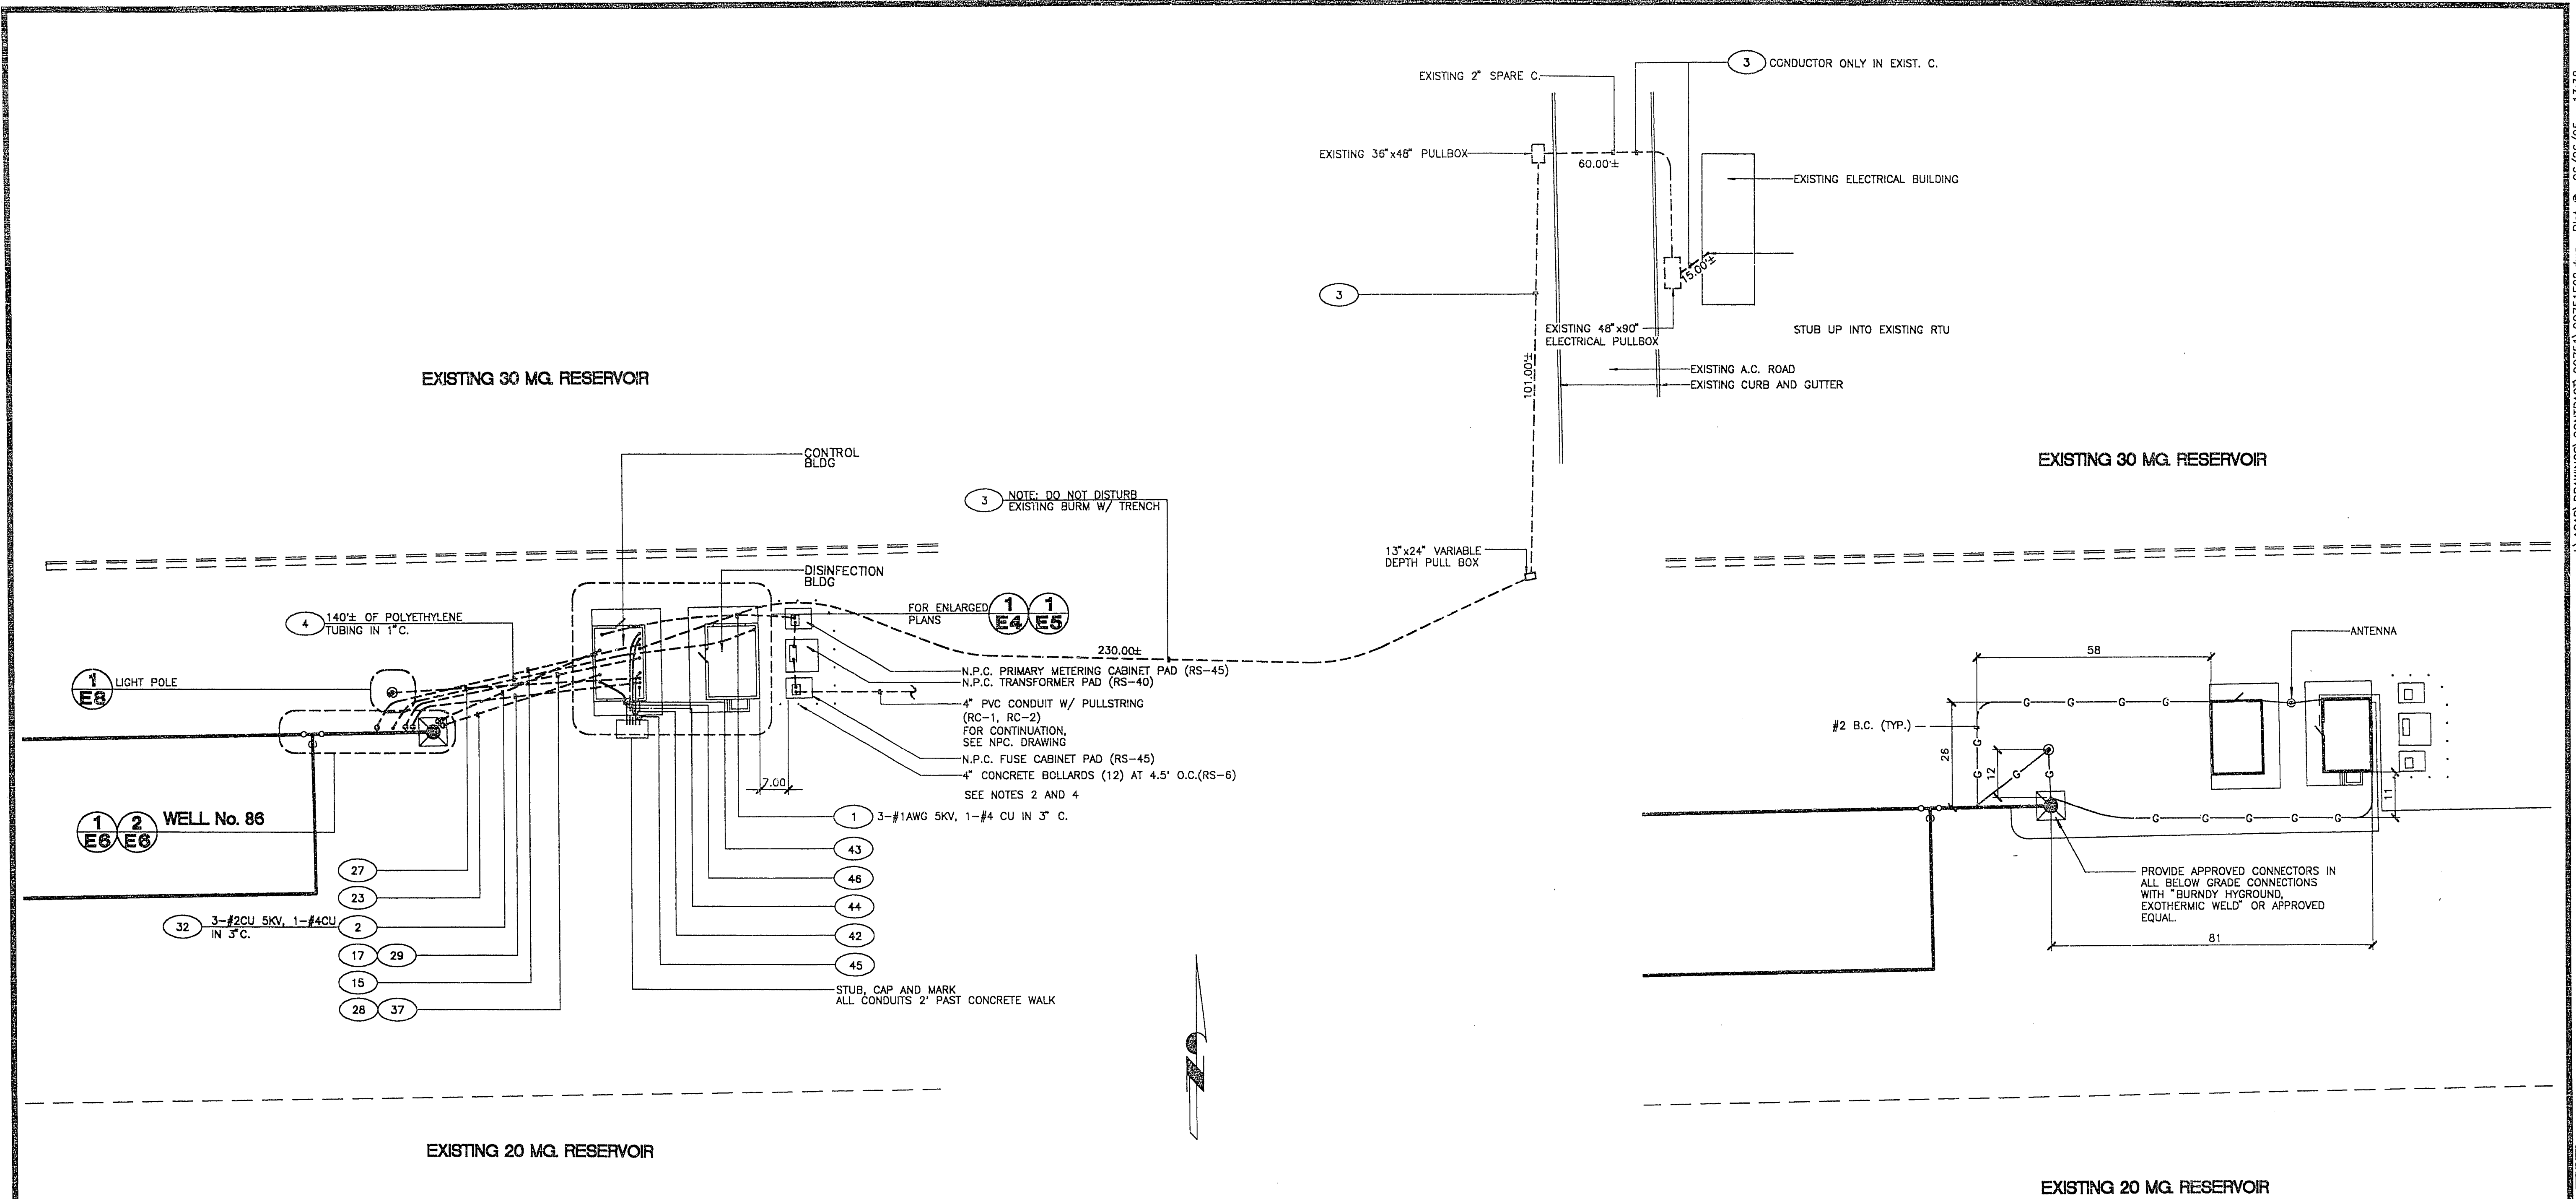


- NOTES
1. SEE **4** FOR TYPICAL TRENCH DETAIL
 2. FOR ACTUAL TRANSFORMER PAD AND OFFSITE LAYOUT, SEE N.P.C. DRAWING
 3. SEE **C7** FOR SITE LOCATION
 4. WHERE WORD "CUSTOMER" OCCURS ON NEVADA POWER DRAWINGS, THIS REFERS TO THE CONTRACTOR.
 5. CONDUIT LAYOUT SHOWN IS SCHEMATIC AND DOES NOT REFLECT ACTUAL INSTALLATION REQUIREMENTS

Call
before you
Dig.
1-800-227-2800

ELECTRICAL SITE PLAN **1**
SCALE- NOTED

GROUNDING PLAN **2**
SCALE- NOTED

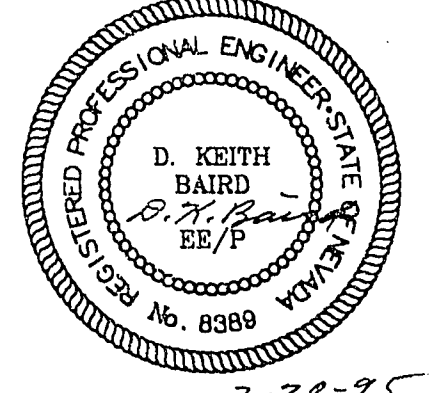

SCALE: 1" = 20'	FILE NAME: C0751E02.DWG DATE: 06/07/95	RECOMMENDED BY: D. KEITH BAIRD DATE: 7-20-95	LAS VEGAS VALLEY WATER DISTRICT 1001 SOUTH VALLEY VIEW BOULEVARD LAS VEGAS, NEVADA 89153	EQUIP WELL NOS. 86 AND 104 WELL NO. 86 ELECTRICAL SITE PLAN, ELECTRICAL GROUNDING PLAN	DRAWING NUMBER 751 REF. SHEET NO. 12 SHEET 18 OF 31
	DRAWN: J. E. SALDANA DATE: 06/07/95	APPROVED BY: P. M. MOLLUS DATE: 7-25-95			
	CHECKED: J. Q. ARCEO DATE: 06/12/95				

N075118.TIF