




LAS VEGAS VALLEY WATER DISTRICT


DURANGO DRIVE / IRON MOUNTAIN ROAD 2745 ZONE RECIRCULATION PIPELINE

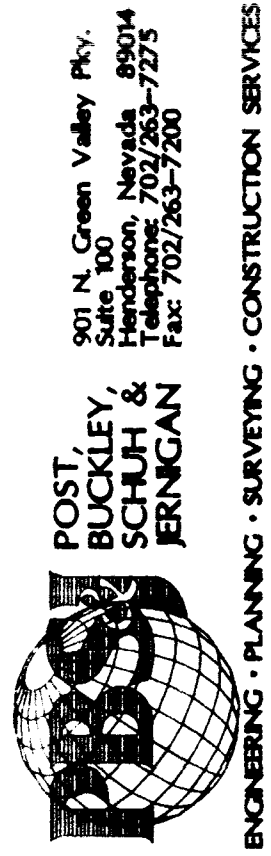


LIST OF DRAWINGS

SHEET NO	DRAWING NO	DESCRIPTION
1	G1	LVVWD TITLE, LOCATION MAP AND LIST OF DRAWINGS
2	G2	CLARK COUNTY GENERAL NOTES
3	G3	CITY OF LAS VEGAS GENERAL NOTES
4	G4	ABBREVIATION LIST
5	G5	LEGEND
6	G6	SURVEY CONTROL PLAN AND KEY MAP
7	G7	SURVEY CONTROL PLAN AND KEY MAP
8	C1	PLAN AND PROFILE STA 50+00.00 TO STA 60+00.00
9	C2	PLAN AND PROFILE STA 60+00.00 TO STA 69+00.00
10	C3	PLAN AND PROFILE STA 69+00.00 TO STA 80+00.00
11	C4	PLAN AND PROFILE STA 80+00.00 TO STA 91+00.00
12	C5	PLAN AND PROFILE STA 91+00.00 TO STA 102+00.00
13	C6	PLAN AND PROFILE STA 102+00.00 TO STA 112+00.00
14	C7	PLAN AND PROFILE STA 112+00.00 TO STA 121+00.00
15	C8	PLAN AND PROFILE STA 121+00.00 TO STA 130+00.00
16	C9	PLAN AND PROFILE STA 130+00.00 TO STA 141+00.00
17	C10	PLAN AND PROFILE STA 141+00.00 TO STA 152+00.00
18	C11	PLAN AND PROFILE STA 152+00.00 TO STA 163+00.00
19	C12	PLAN AND PROFILE STA 163+00.00 TO STA 174+00.00
20	C13	PLAN AND PROFILE STA 174+00.00 TO STA 183+00.00
21	C14	PLAN AND PROFILE STA 183+00.00 TO STA 190+29.27
22	C15	PLAN AND PROFILE STA 10+00.00 TO STA 18+00.00
23	C16	PLAN AND PROFILE STA 18+00.00 TO STA 24+87.81
24	C17	TANK SITE
25	D1	TRENCH AND ENCASEMENT DETAILS AND CHLORINATION REQUIREMENTS
26	D2	APPURTENANCES DETAILS AND THRUST BLOCK AND ANCHOR BLOCK DETAILS
27	D3	PUMP STATION EQUIPMENT LAYOUT PLAN
28	D4	PUMP STATION EQUIPMENT LAYOUT SECTIONS
29	D5	PRV VAULT PIPING PLAN AND EQUIPMENT AND MATERIAL SCHEDULE
30	D6	PRV VAULT STRUCTURAL PLAN AND SECTIONS AND PIPE SUPPORT DETAIL
31	D7	PRV VAULT CONNECTION DETAIL AND COMPONENT DETAILS
32	D8	TANK DETAIL

PROJECT LOCATION

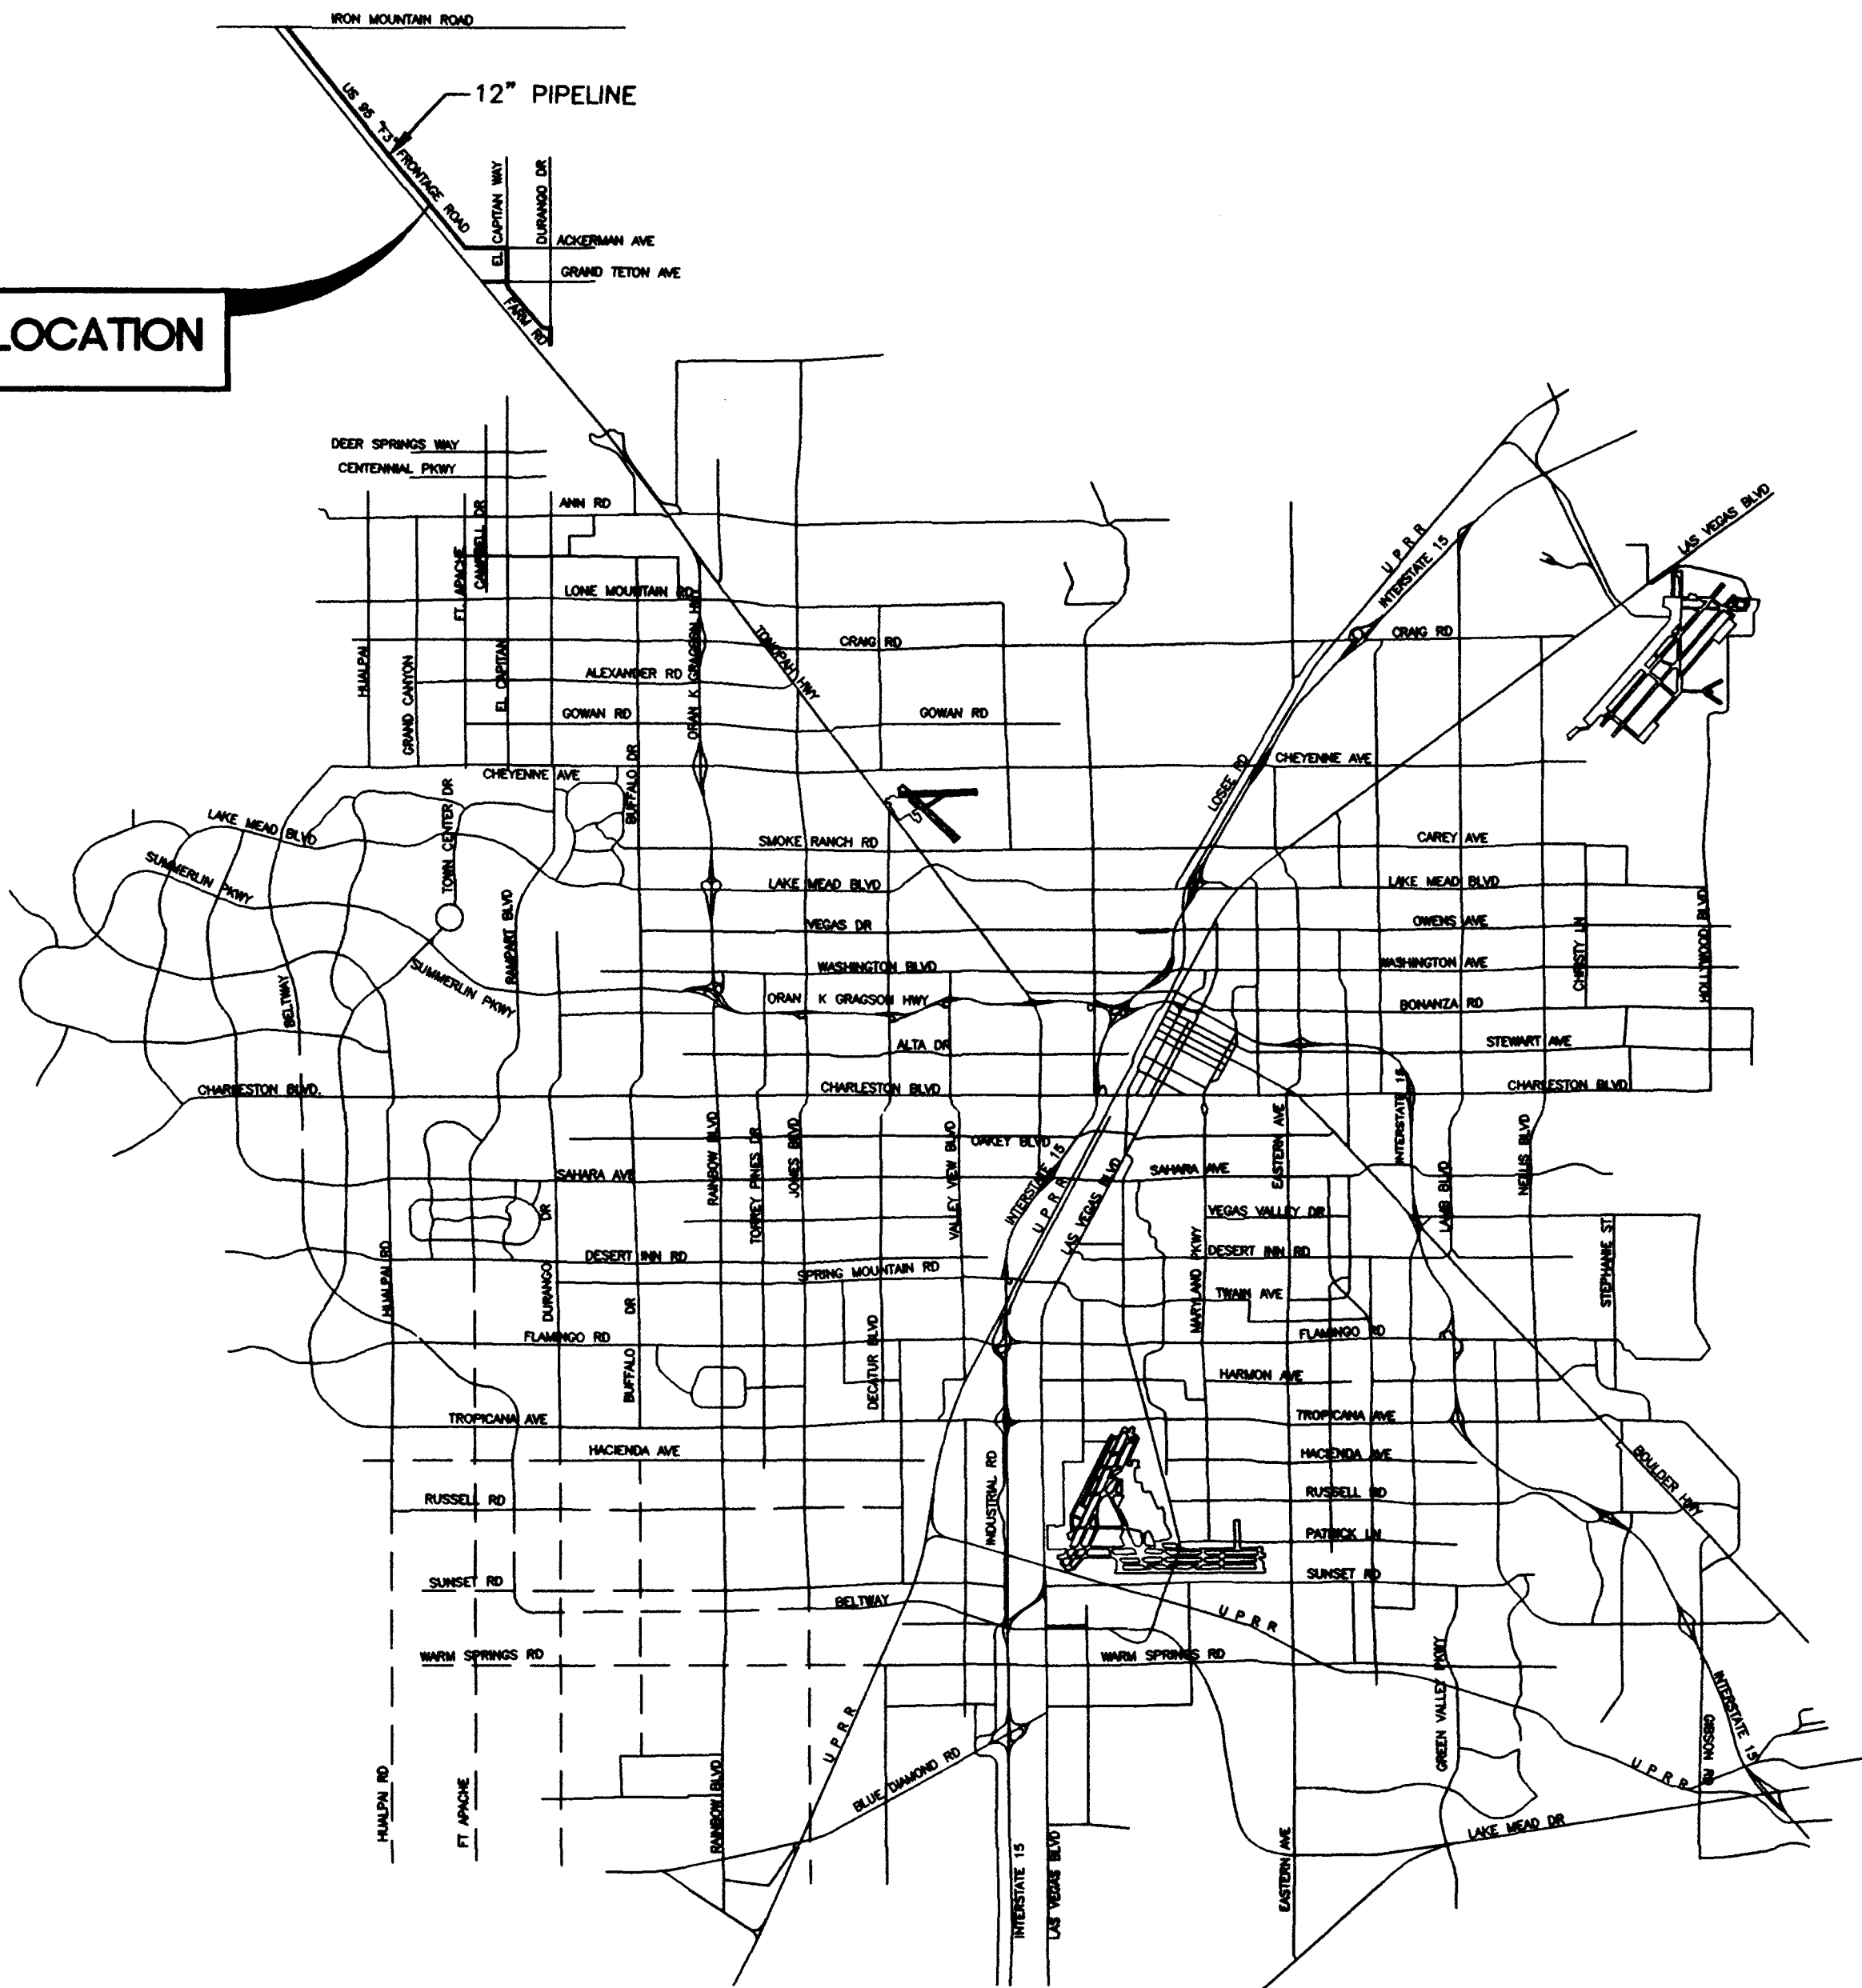

LOCATION MAP
NOT TO SCALE

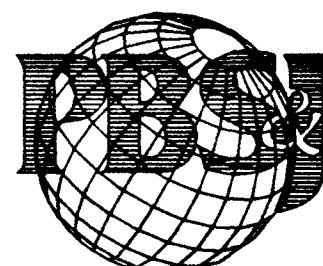

POST, BUCKLEY, SCHUH & JERNIGAN
901 N. Green Valley Pkwy.
Suite 100
Henderson, Nevada 89014
Telephone: 702/263-7275
Fax: 702/263-7200

ENGINEERING • PLANNING • SURVEYING • CONSTRUCTION SERVICES

ACCEPTED BY:

LAS VEGAS VALLEY WATER DISTRICT DATE

CAUTION TO CONTRACTOR:

THE CONTRACTOR SHALL BE RESPONSIBLE TO INVESTIGATE AND VERIFY THE ACTUAL LOCATION AND DEPTH OF ALL EXISTING UNDERGROUND FACILITIES AT LEAST 48 HOURS IN ADVANCE OF THE PERFORMANCE OF ANY WORK.

Call before you Dig

1-800-227-2600

PACIFIC COMMUNITIES DEVELOPMENT CORPORATION	
POST, BUCKLEY, SCHUH & JERNIGAN 901 N. Green Valley Pkwy. Suite 100 Henderson, Nevada 89014 Telephone: 702/263-7275 Fax: 702/263-7200	
VERIFICATION SCALE 1/2" = 0' 1/2"	
DRAWING NUMBER G-1 SHEET 1 OF 32	
CONTRACT NUMBER	
DRAWING NUMBER G-1 SHEET 1 OF 32	




LAS VEGAS VALLEY WATER DISTRICT

**DURANGO DRIVE / IRON MOUNTAIN ROAD
2745 ZONE RECIRCULATION PIPELINE**



LIST OF CHARGES		
SHEET NO	CHARGES NO	DESCRIPTION
1	31	RENT TRUCK DURING JOB AND LAB OF MATERIAL
2	40	PAID POLICE TRAFFIC STOP
3	41	PAID POLICE TRAFFIC STOP
4	42	PAID POLICE TRAFFIC STOP
62	100	PAID POLICE TRAFFIC STOP

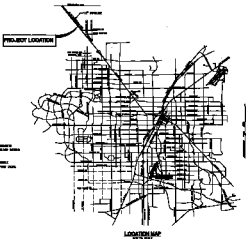

100-100-100

3 4 5 6 7

CAUTION TO CONTRACTOR
 PLASTER SHALL BE APPLIED TO ALL INTERIORS
 (SEE ALL NOTES ON DRAWING AND THE SPECIFICATIONS OF THE WORK)

REVIEW

Call before you dig.

1-800-451-4511

