



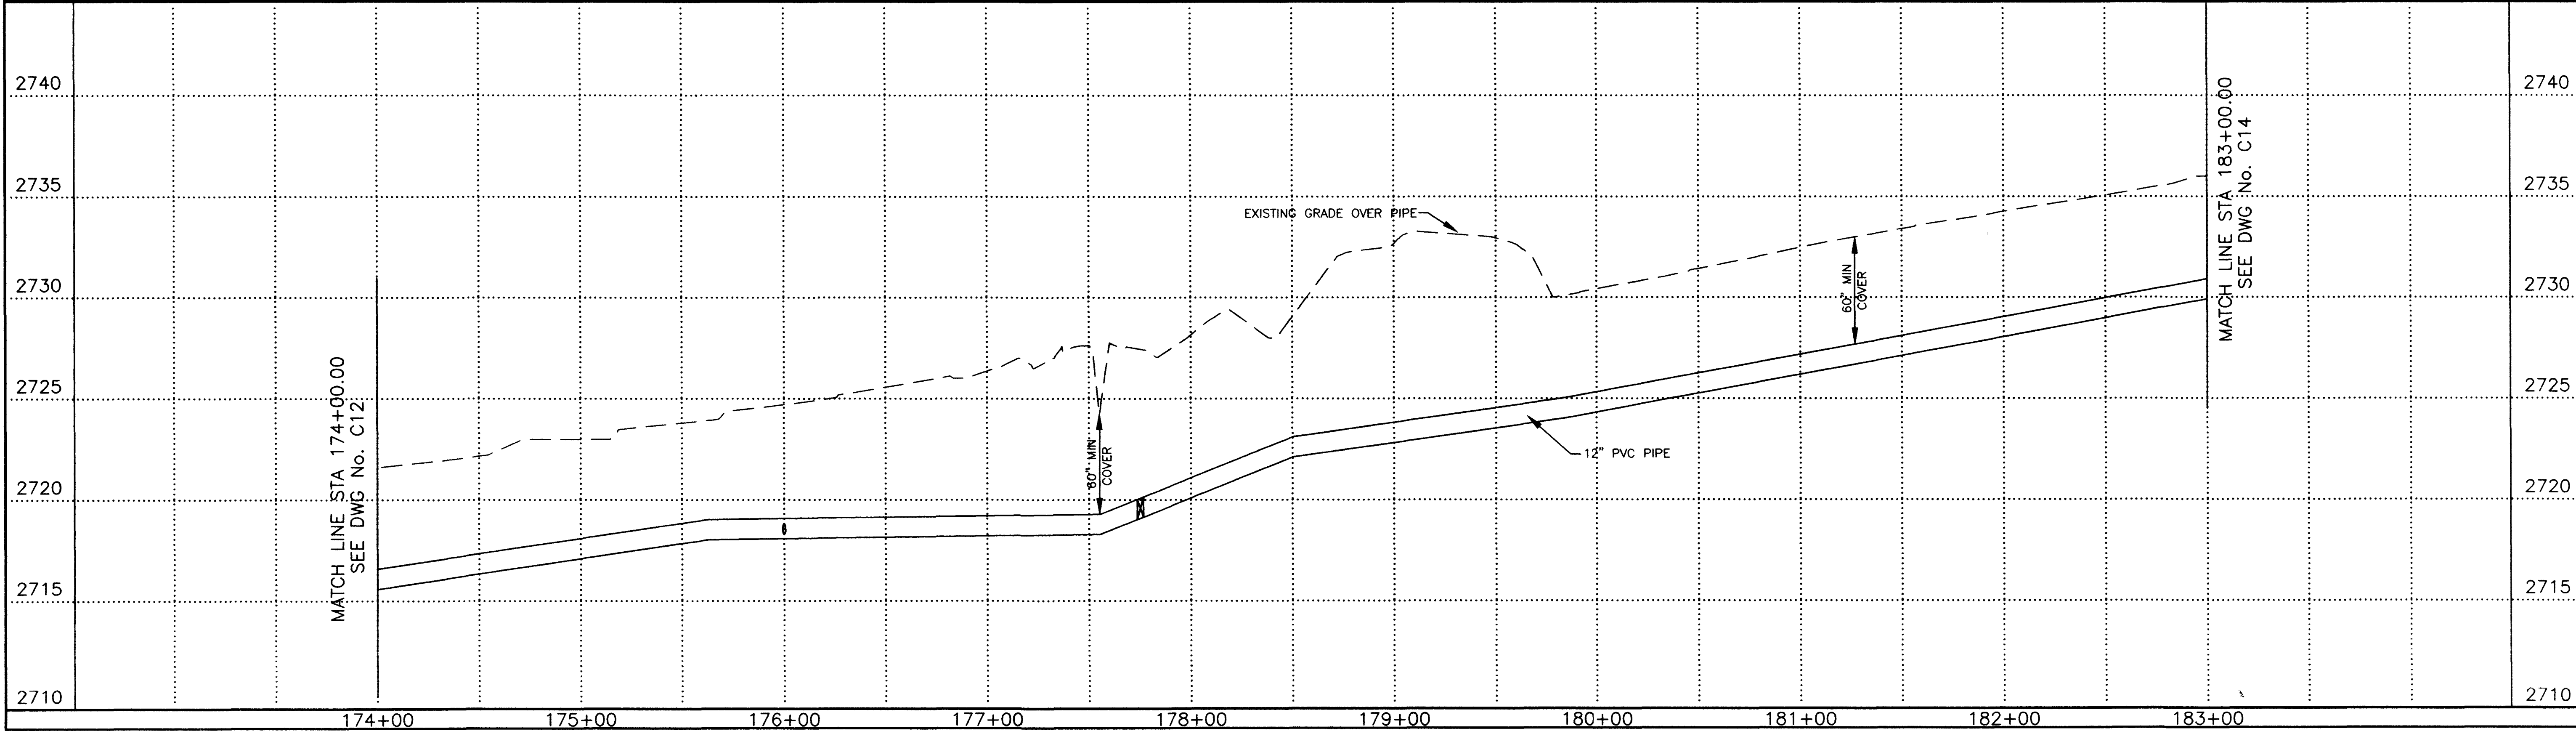

MATCH LINE STA 174+00.00
SEE DWG No. C12

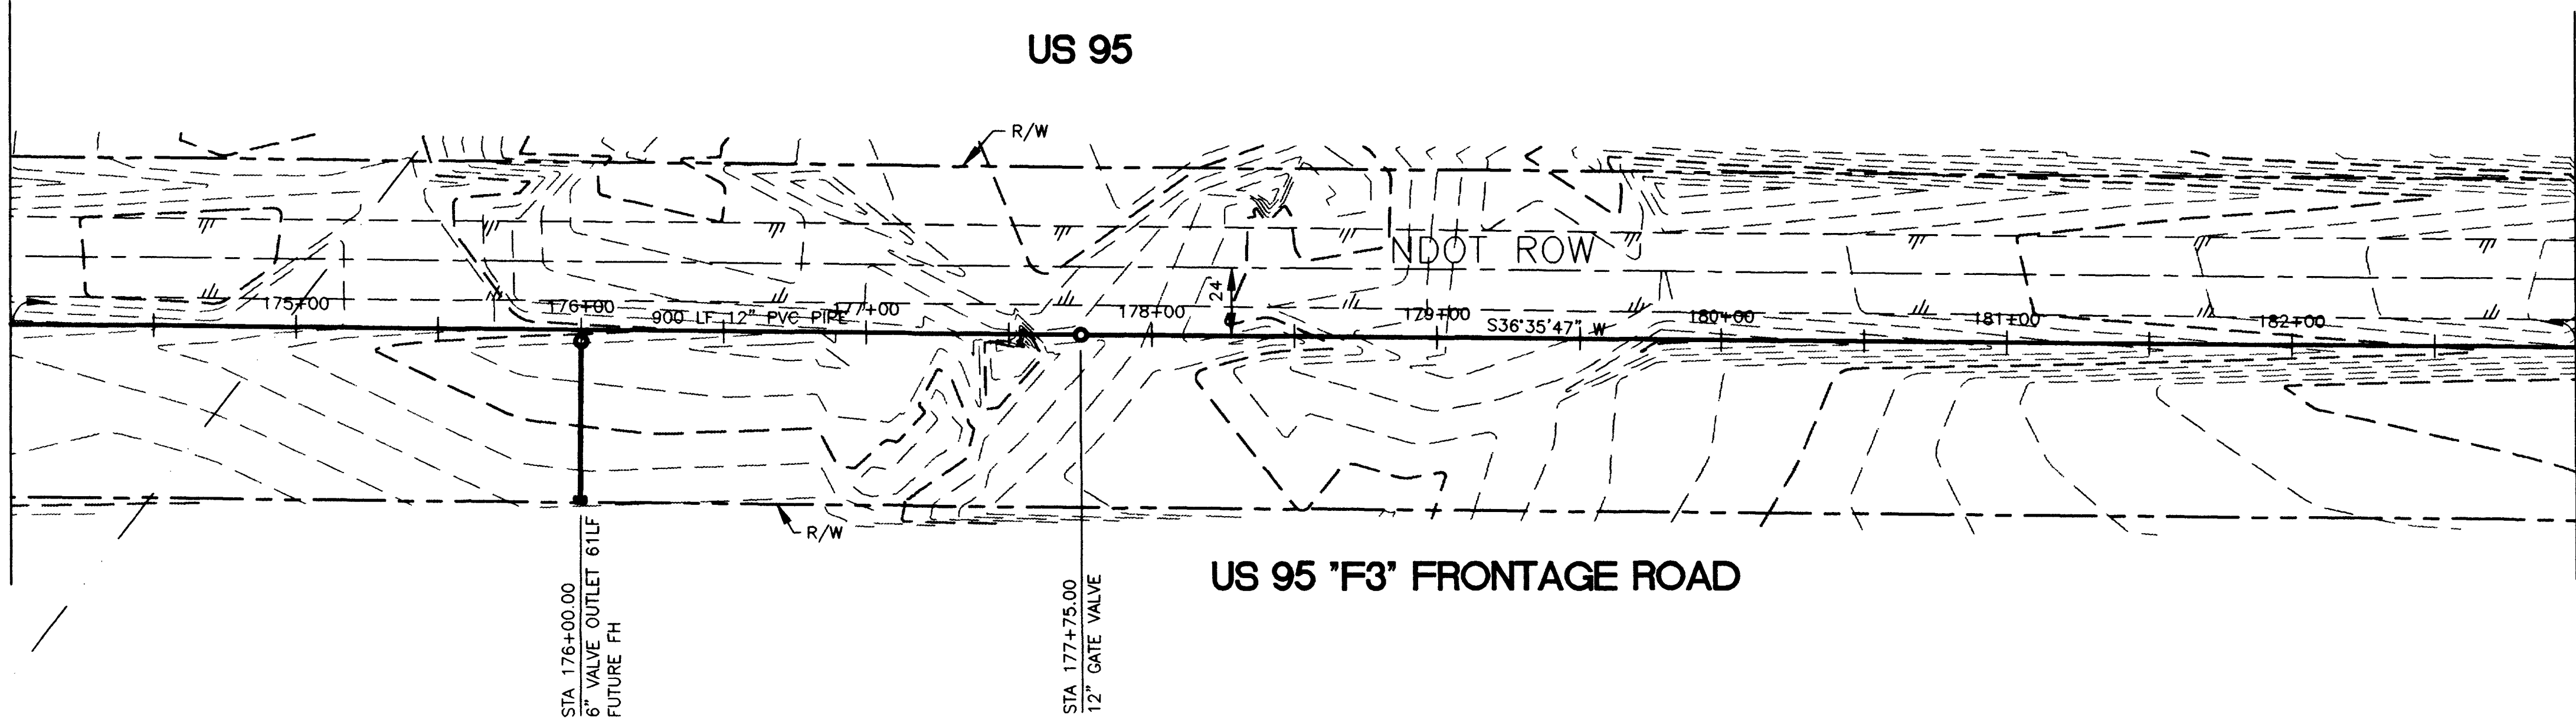

MATCH LINE STA 183+00.00
SEE DWG No. C14

NEVADA DEPARTMENT OF TRANSPORTATION (NDOT) PERMIT REQUIRED
AN APPROVED NDOT OCCUPANCY PERMIT SHALL BE OBTAINED THROUGH THE
DISTRICT PRIOR TO ANY CONSTRUCTION WITHIN THE NDOT RIGHT-OF-WAY.



LAS VEGAS VALLEY WATER DISTRICT

DATE

SCALE: HORIZ. 1"=40'

Call before you Dig
1-800-227-2800

	DRAWN BY: _____		09/04/97
	CHECKED BY: _____		09/04/97
CONTRACT NUMBER	RECOMMENDED BY: _____		12/12
	ACCEPTED BY: _____		10/83
DURANGO DRIVE / IRON MOUNTAIN ROAD 2745 ZONE RECIRCULATION PIPELINE		PLAN AND PROFILE	
STA 174+00.00 TO STA 183+00.00		STA 174+00.00 TO STA 183+00.00	
PACIFIC COMMUNITIES DEVELOPMENT CORPORATION		POST, BUCKLEY, SCHULTZ & JENNAN	
VERIFICATION SCALE		901 N. Green Valley Pk. Suite 100 Nevada 89114 Telephone 702/263-7275 Fax 702/263-7280	
1/2 0 1/2		BAR REPRESENTS ONE AND ONE-HALF INCHES ON ORIGINAL	
1/2 0 1/2		SCALE HORIZ. 1"=40' VERT. 1"=4'	
1/2 0 1/2		D:\DWG\996\996-C13 9-04-97 12:00 pm	

 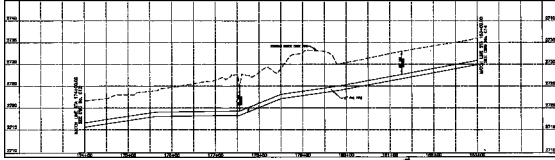

PROJECT: US 85 7th FRONTAGE ROAD DRAWING: 174+00 TO 184+00 DATE: 10-10-68	
SCALE: 1" = 40' SHEET: 174+00 TO 184+00	
DESIGNED BY: 174+00 TO 184+00 CHECKED BY: 174+00 TO 184+00 APPROVED BY: 174+00 TO 184+00	