



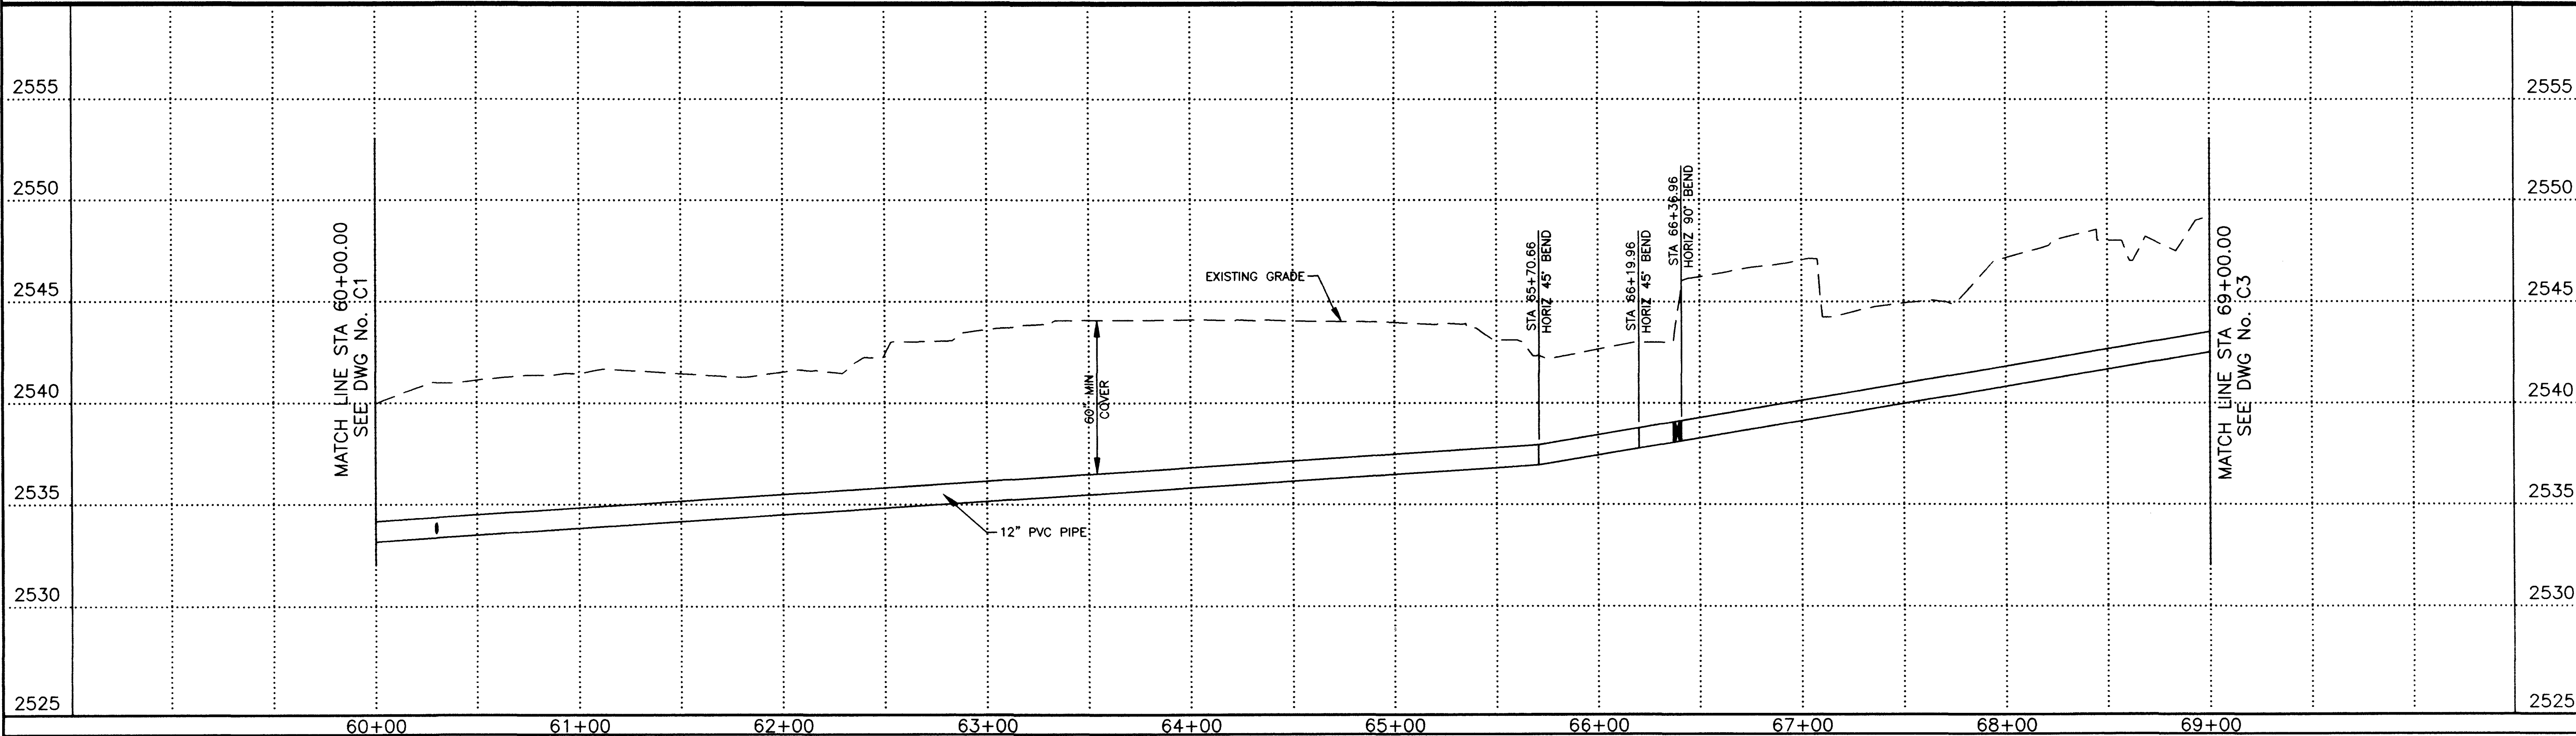

PACIFIC COMMUNITIES DEVELOPMENT CORPORATION 901 N. Green Valley Pkwy. Suite 100 Henderson, NV 89015 Tel: 702/363-7700 Fax: 702/363-7700	
POST, BUCKLEY, SCHUE & ERNGAN ENGINEERING • PLANNING • SURVEYING • CONSTRUCTION SERVICES	
DURANGO DRIVE / IRON MOUNTAIN ROAD 2745 ZONE RECIRCULATION PIPELINE PLAN AND PROFILE STA 60+00.00 TO STA 69+00.00	VERIFY SCALE 1/2" = 0' 1/2" 0' = 0" 1/2" = 1'
SCALE HORIZ. SCALE VERT. SCALE 1" = 40' 1" = 4'	BAR REPRESENTS ONE AND ONE-HALF INCHES ON ORIGINAL
DRAWN BY: JMA CHECKED BY: SB RECOMMENDED BY: LOUIS A. ATWELL ACCEPTED BY: STEVE BRIDMAN R.F.E. NO. DATE: 12112 12/12/97 R.F.E. NO. DATE: 10583 12/12/97	PROFESSIONAL ENGINEER-STATE OF NEVADA LOUIS A. ATWELL No. 12112 12/12/97
CONTRACT NUMBER	
DRAWING NUMBER C2 SHEET 9 OF 32	

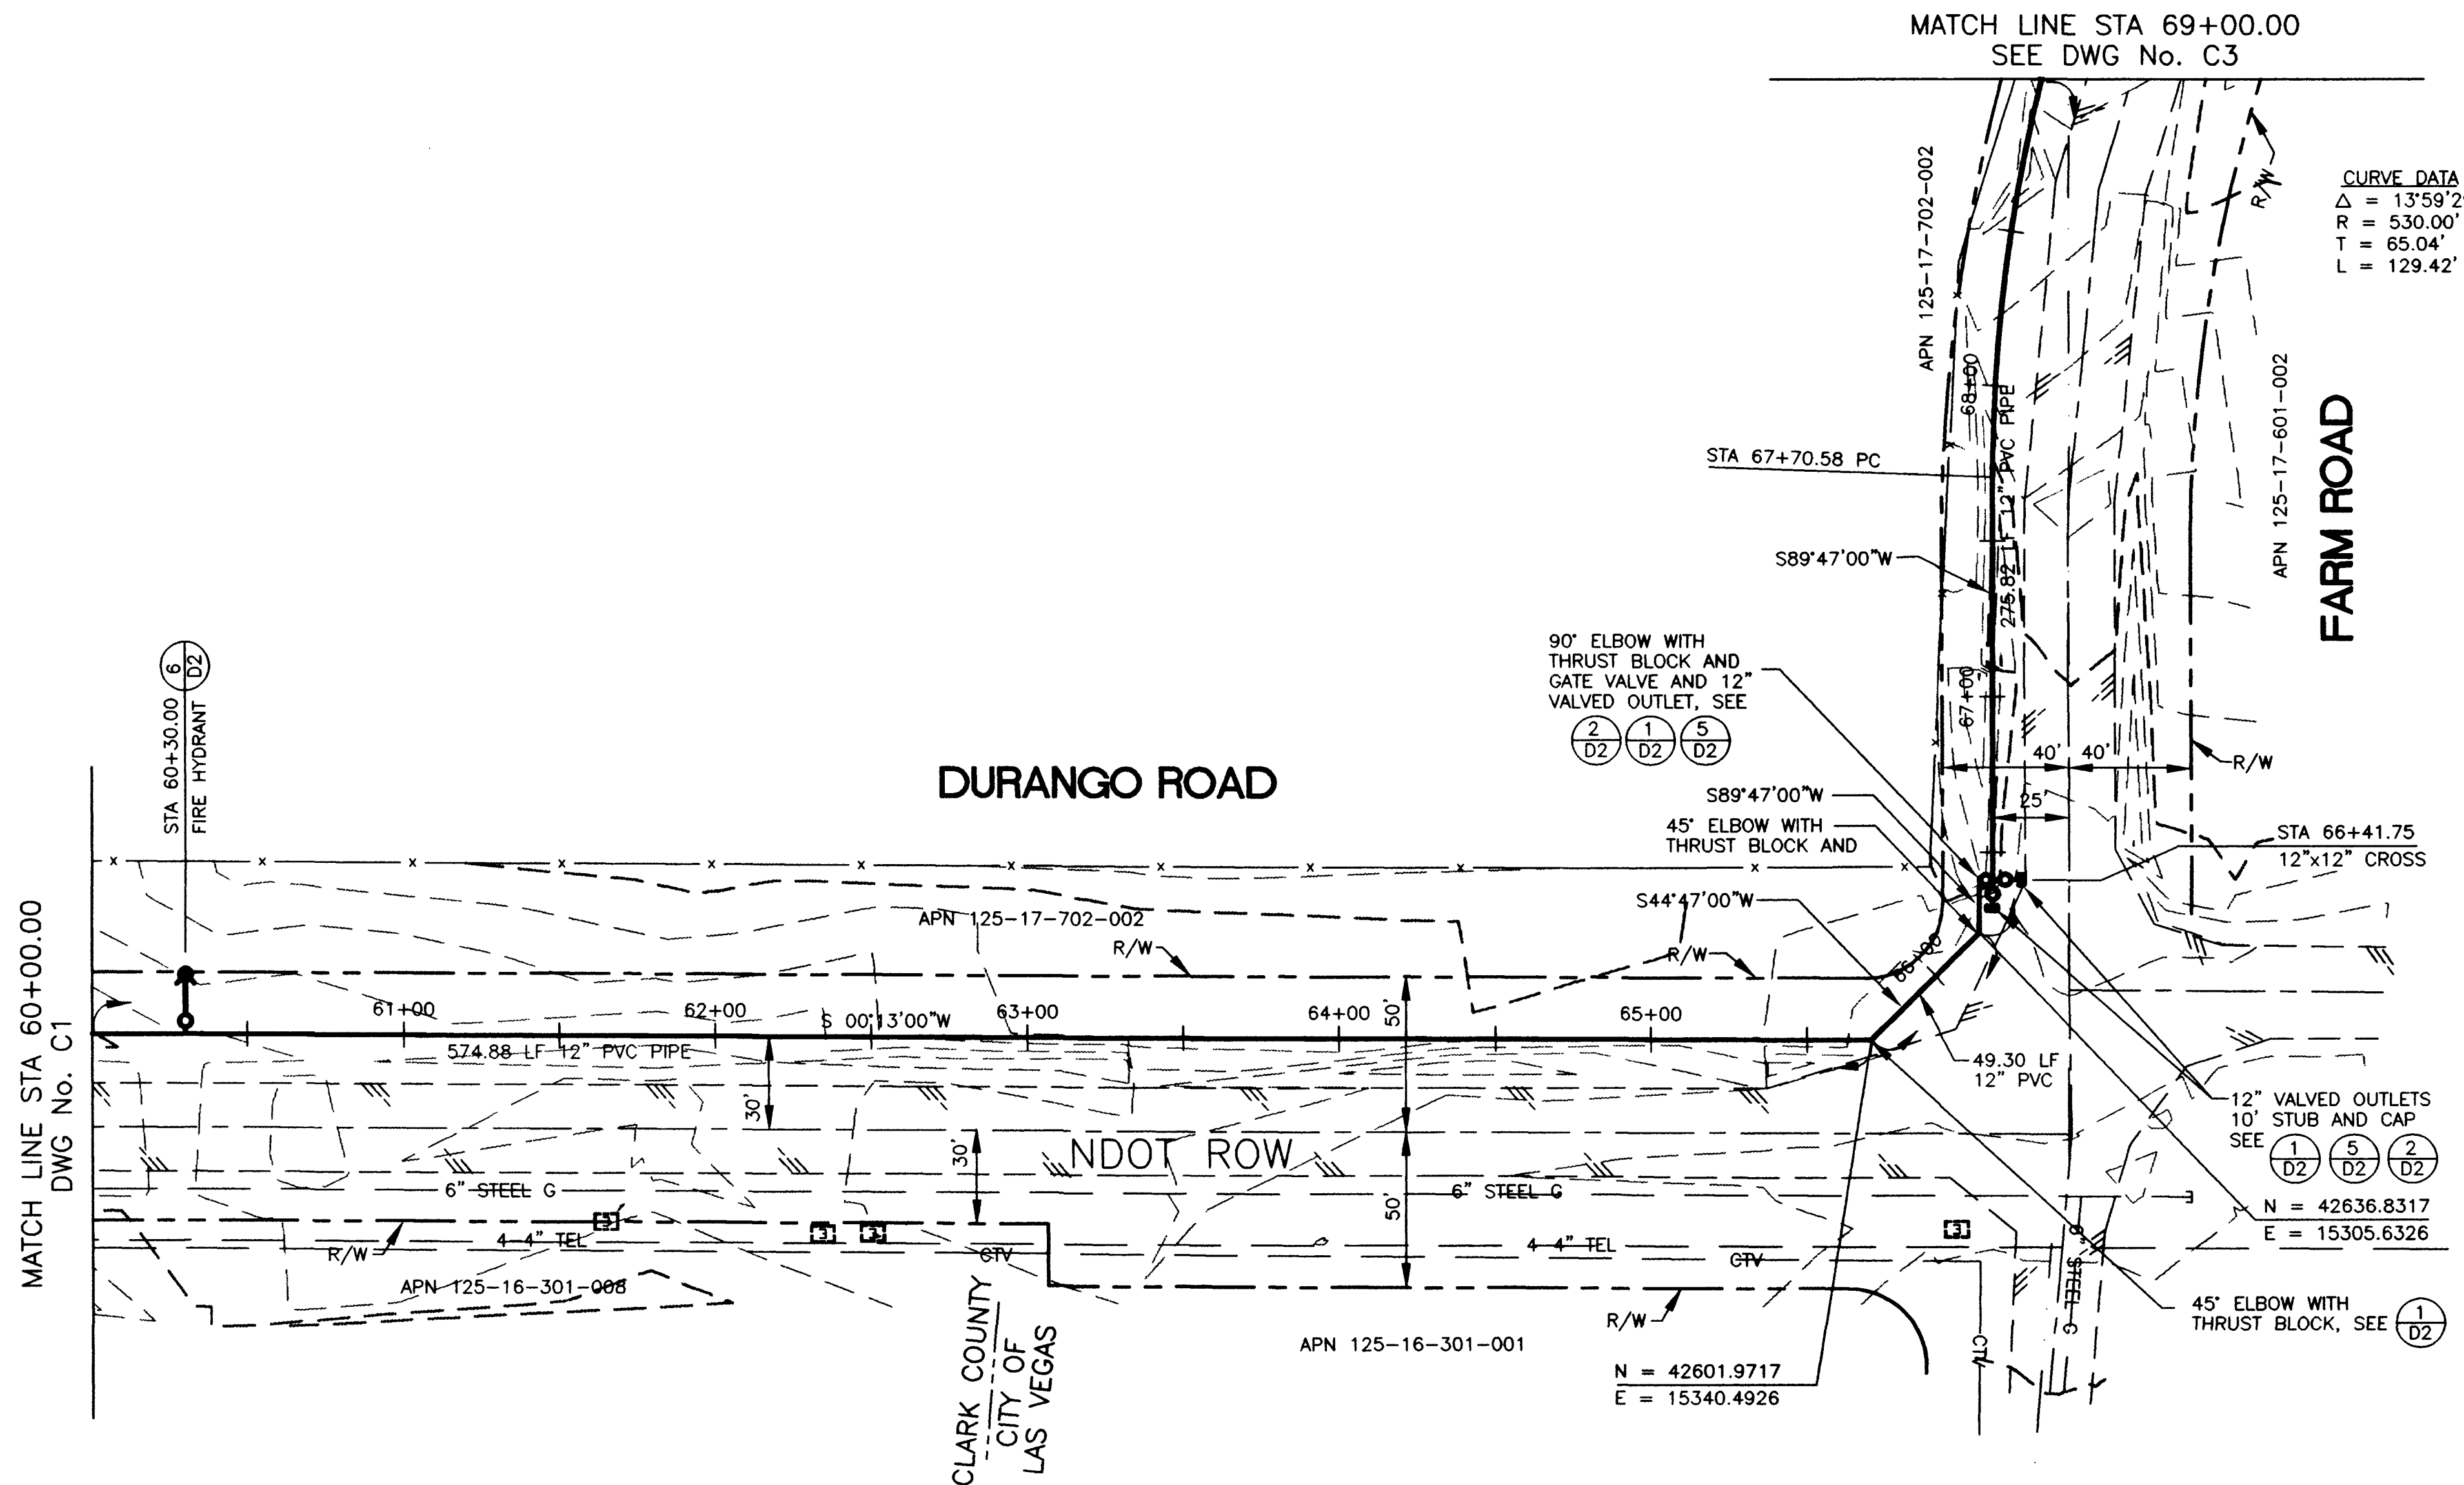