

MATCH LINE AREA A

MATCH LINE AREA B

MATCH LINE AREA A

MATCH LINE AREA B

MATCH LINE AREA A


MATCH LINE AREA B

MATCH LINE AREA A

MATCH LINE AREA B

MATCH LINE AREA A

MATCH LINE AREA B

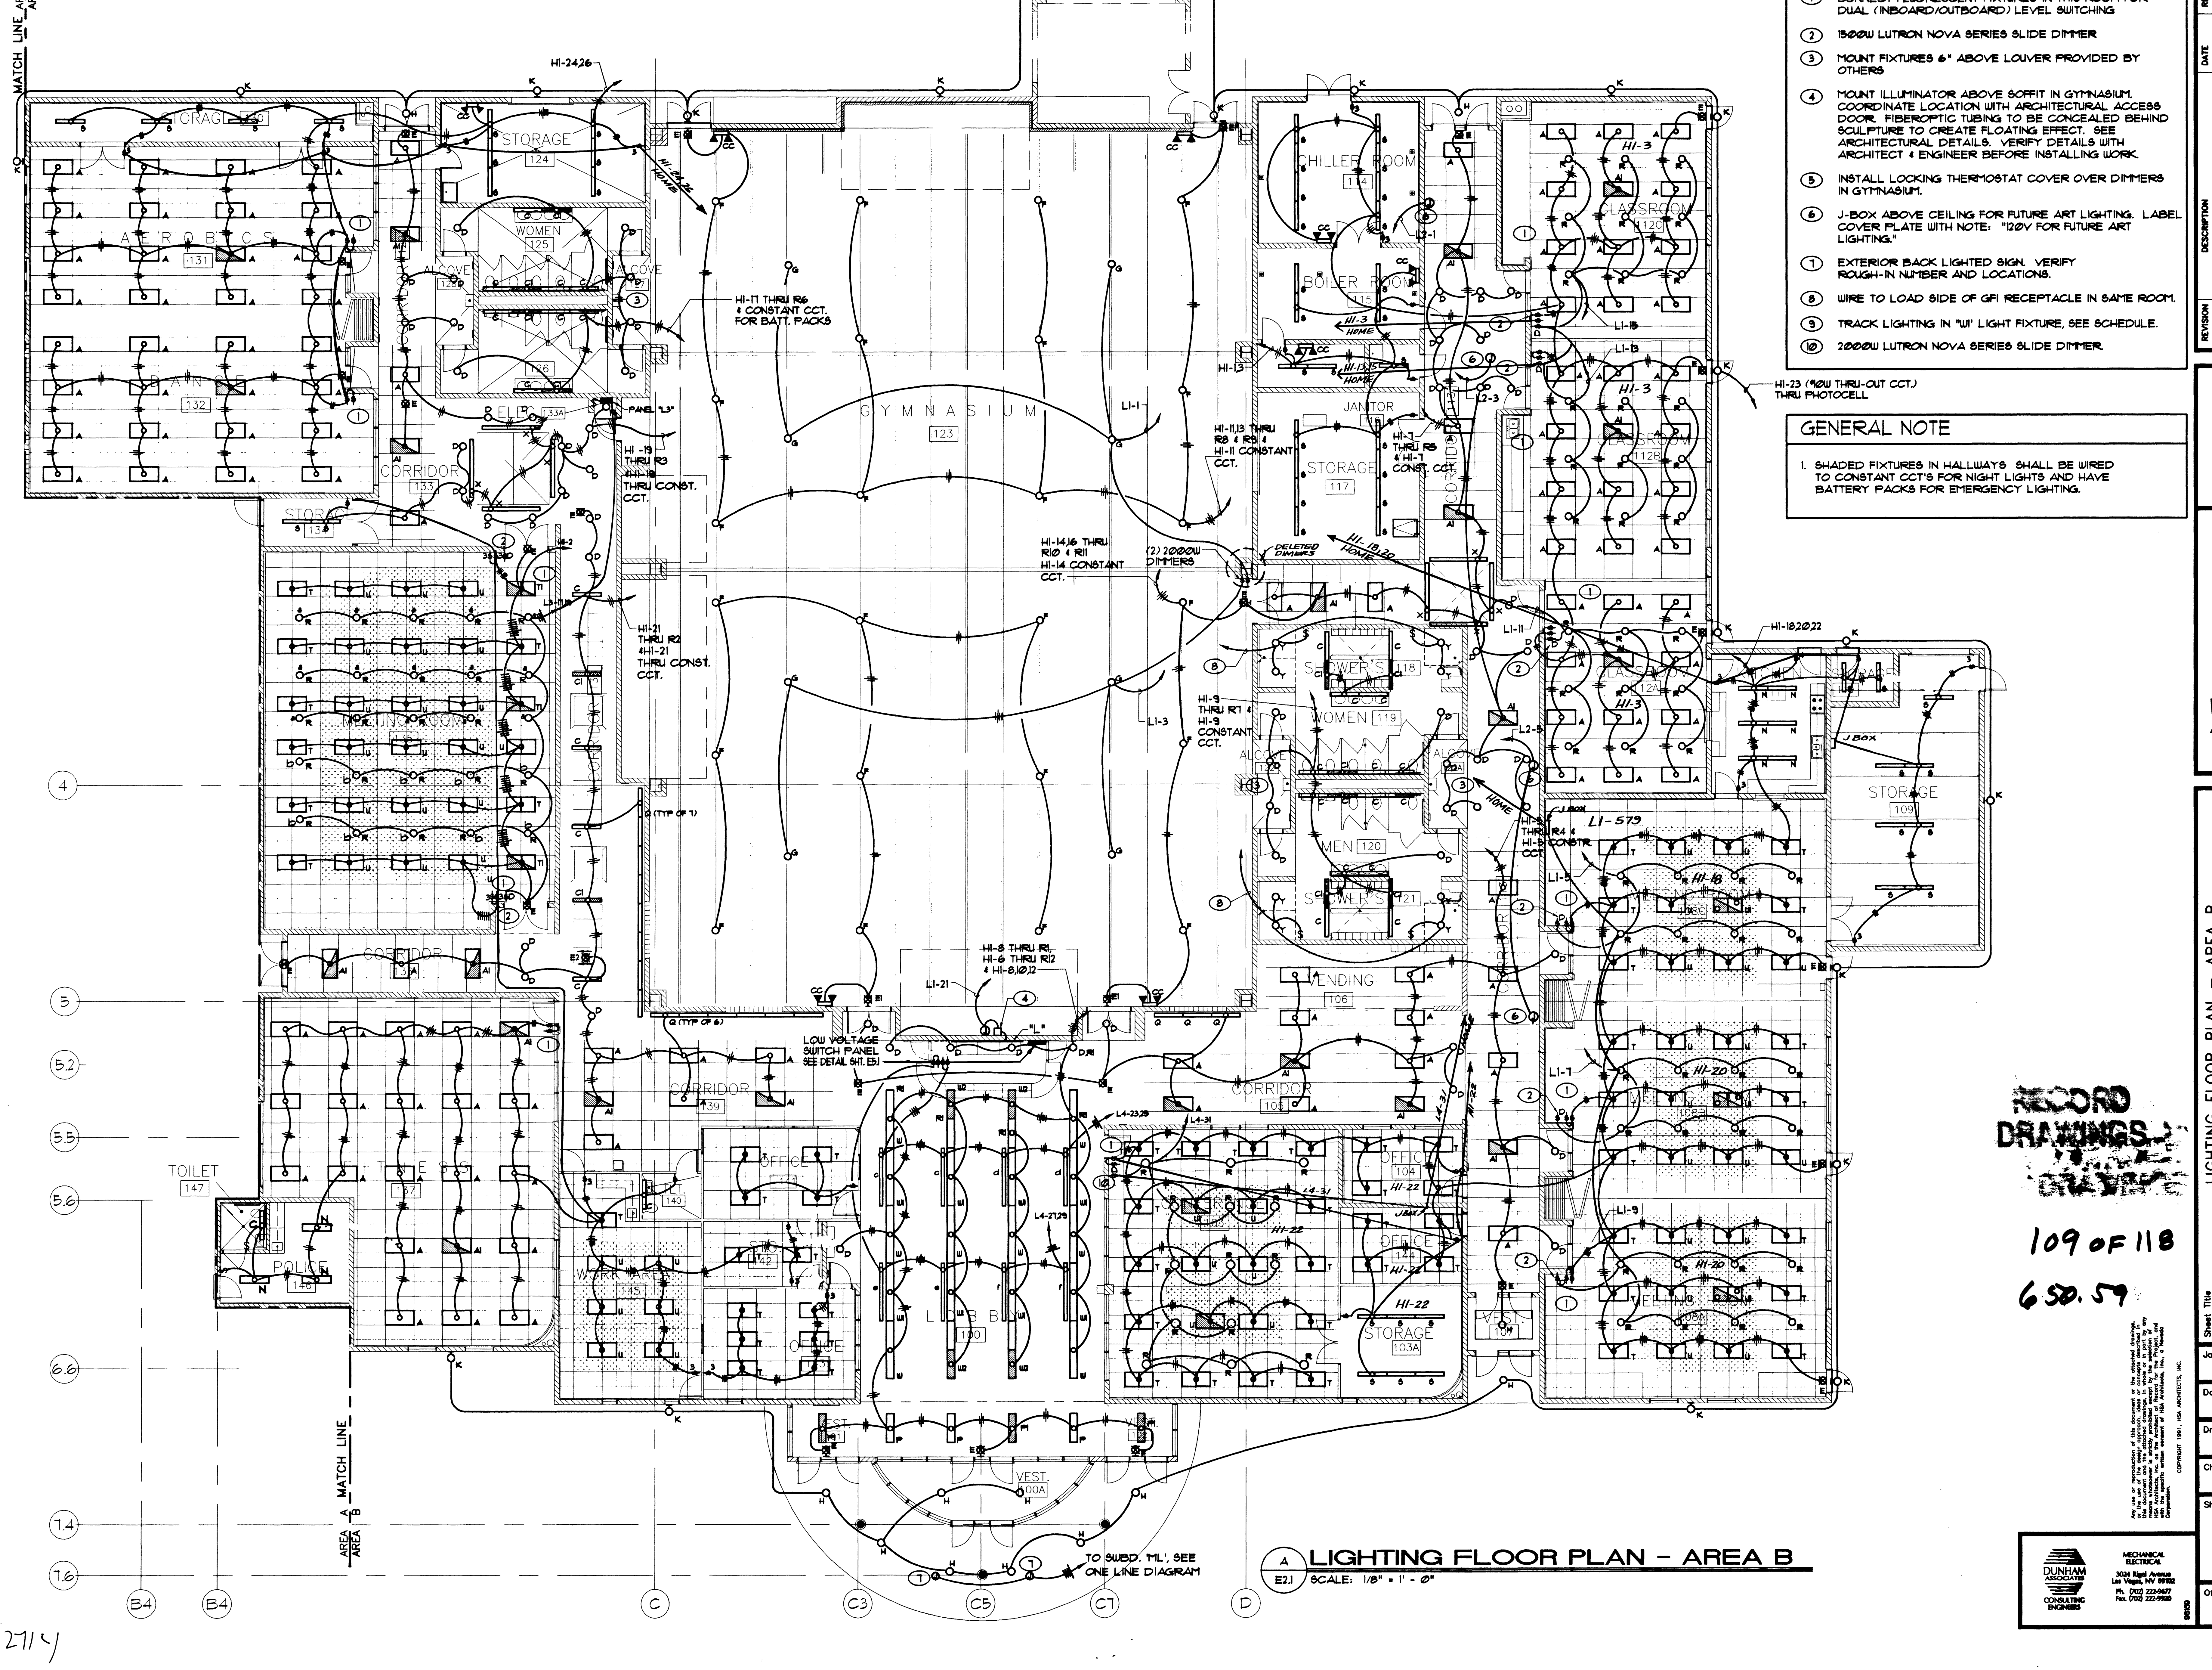

SHEET NOTES

- ① CONNECT FLUORESCENT FIXTURES IN THIS ROOM FOR DUAL (INBOARD/OUTBOARD) LEVEL SWITCHING
- ② 1500W LUTRON NOVA SERIES SLIDE DIMMER
- ③ MOUNT FIXTURES 6" ABOVE LOUVER PROVIDED BY OTHERS
- ④ MOUNT ILLUMINATOR ABOVE SOFFIT IN GYMNASIUM. COORDINATE LOCATION WITH ARCHITECTURAL ACCESS DOOR. FIBEROPTIC TUBING TO BE CONCEALED BEHIND SCULPTURE TO CREATE FLOATING EFFECT. SEE ARCHITECTURAL DETAILS. VERIFY DETAILS WITH ARCHITECT & ENGINEER BEFORE INSTALLING WORK.
- ⑤ INSTALL LOCKING THERMOSTAT COVER OVER DIMMERS IN GYMNASIUM.
- ⑥ J-BOX ABOVE CEILING FOR FUTURE ART LIGHTING. LABEL COVER PLATE WITH NOTE: "120V FOR FUTURE ART LIGHTING."
- ⑦ EXTERIOR BACK LIGHTED SIGN. VERIFY ROUGH-IN NUMBER AND LOCATIONS.
- ⑧ WIRE TO LOAD SIDE OF GFI RECEPTACLE IN SAME ROOM.
- ⑨ TRACK LIGHTING IN "W" LIGHT FIXTURE, SEE SCHEDULE.
- ⑩ 2000W LUTRON NOVA SERIES SLIDE DIMMER

GENERAL NOTE

1. SHADED FIXTURES IN HALLWAYS SHALL BE WIRED TO CONSTANT CCT'S FOR NIGHT LIGHTS AND HAVE BATTERY PACKS FOR EMERGENCY LIGHTING.

REVISION	DESCRIPTION	DATE	REV. BY

WAYNE SCHREIBER AIA
THOMAS M. SILVA AIA

1525 WEST OAKLEY BLVD
LAS VEGAS, NV 89102
(702) 383-0077
FAX 383-0057

Lighting Floor Plan - Area B
Job Title: CITY OF LAS VEGAS DEPARTMENT OF PARK AND LEISURE ACTIVITIES
DURANGO RECREATION FACILITY
Verify all Dimensions and Conditions at the Site

RECORD DRAWINGS

109 OF 118
650.59

Sheet Title	960901
Date	2-20-98
Drawn By	MDV
Check	RGK
Sheet	E21

DUNHAM ASSOCIATES
3034 Regal Avenue
Las Vegas, NV 89128
Ph. (702) 222-9677
Fax. (702) 222-9950

LIGHTING FLOOR PLAN - AREA B
E21 SCALE: 1/8" = 1' - 0"

P: 18/05/98 E21.dwg Wed Feb 20 07:50:20 1998 MAC

2714

109 1/6
3 OF 11
650.59