


- SHEET NOTES**
- ① J-BOX FOR SECURITY SYSTEM. VERIFY EXACT LOCATION WITH SECURITY CONTRACTOR.
 - ② SMOKE/FIRE DAMPERS, SEE MECHANICAL PLANS. PROVIDE DUCT DETECTOR, INTERFACE RELAY & POWER TO DAMPER. UPON ACTIVATION OF A DETECTOR ALL DAMPERS ARE TO SHUT & ASSOCIATED UNITS TO SHUTDOWN. ALL DUCT DETECTORS SHALL HAVE REMOTE INDICATING LIGHTS. MOUNT FLUSH IN CEILING BELOW DETECTOR.

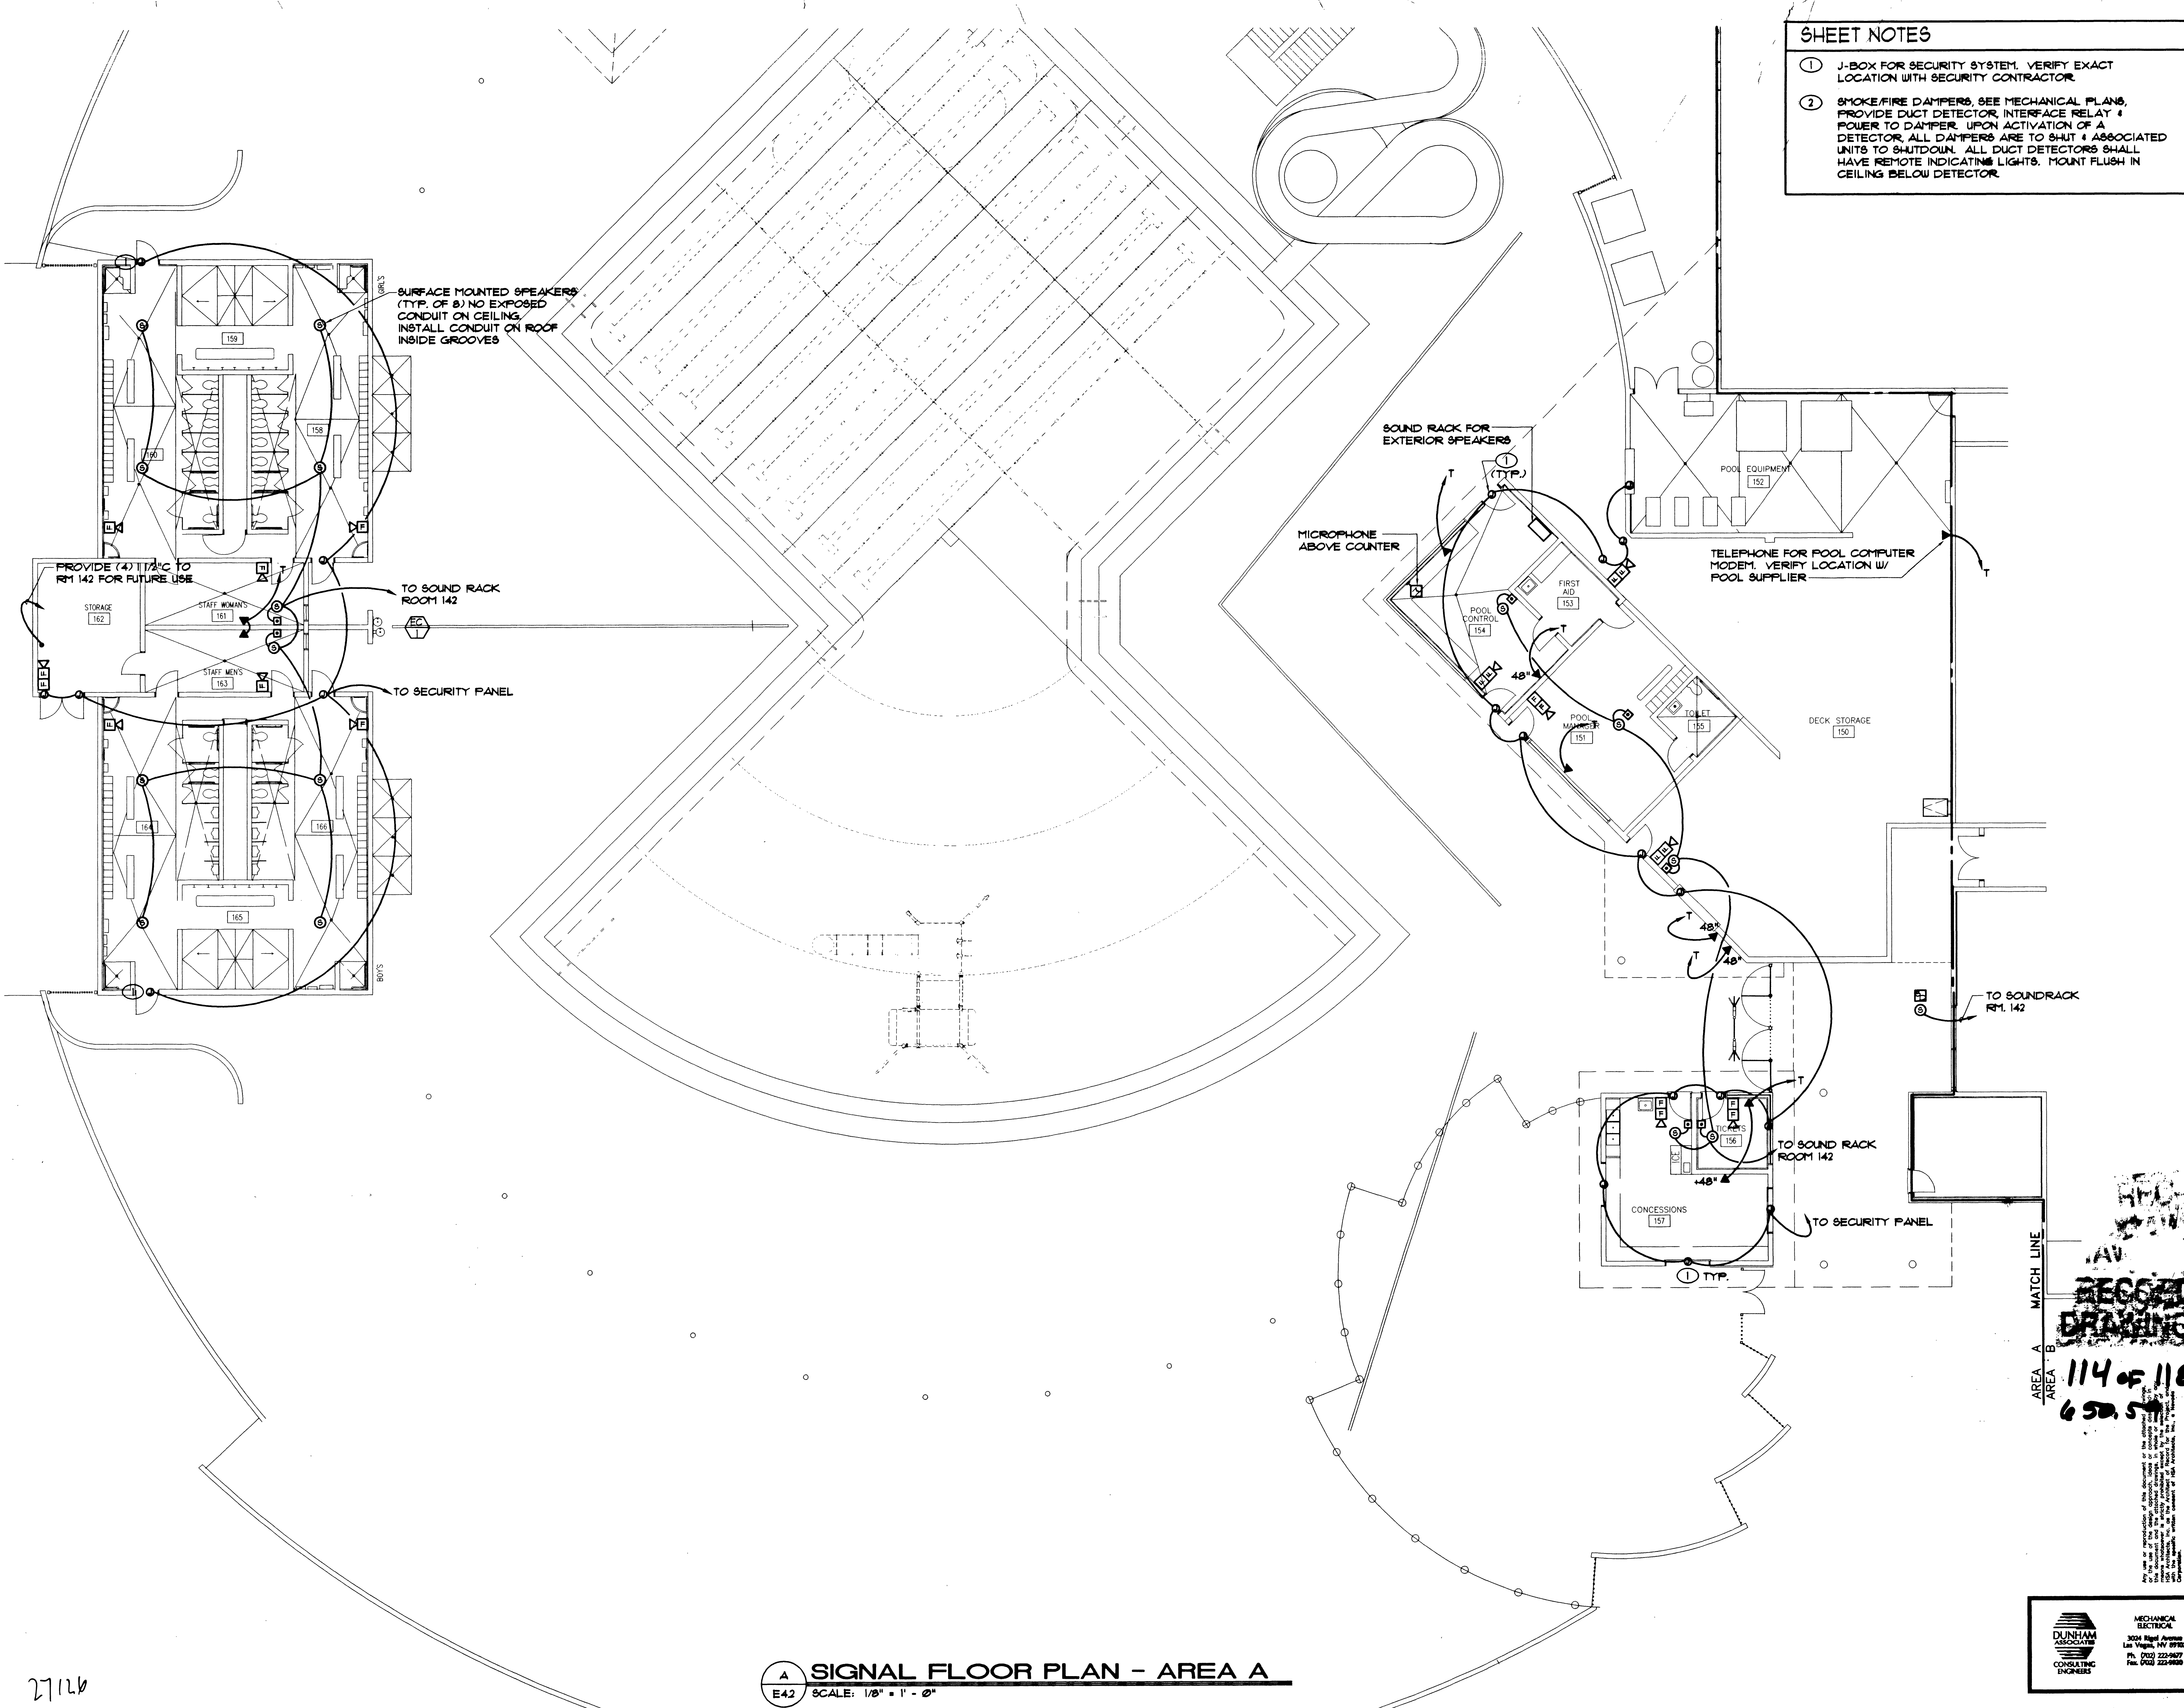

REVISION	DESCRIPTION	DATE	REV. BY

1525 WEST OAKLEY BLVD
LAS VEGAS, NV 89102
(702) 341-8077
FAX 341-8077

WHS
ARCHITECTS

WAYNE SCHREIBER AIA
THOMAS M. SILVA AIA

SIGNAL FLOOR PLAN - AREA A

CITY OF LAS VEGAS DEPARTMENT OF PARK AND LEISURE ACTIVITIES
DURANGO RECREATION FACILITY

Verify all Dimensions and Conditions at the Site

RECORD DRAWINGS

114 of 118
650.59

Job No.	960901
Date	2-20-98
Drawn By	MDV
Check	RGK
Sheet	E4.2
Of	114 of 118 8 OF 11

DUNHAM
CONSULTING
ENGINEERS

MECHANICAL
ELECTRICAL

3024 Regal Avenue
Las Vegas, NV 89128
Ph: (702) 222-9977
Fax: (702) 222-9999

A SIGNAL FLOOR PLAN - AREA A
E4.2 SCALE: 1/8" = 1' - 0"

P:\080501\E4-2.dwg Plot File: 26 08:17:58 03/06 MDC

27126

650.59