




A PARTIAL PLUMBING FLOOR PLAN
P31 SCALE: 1/4" = 1'-0"

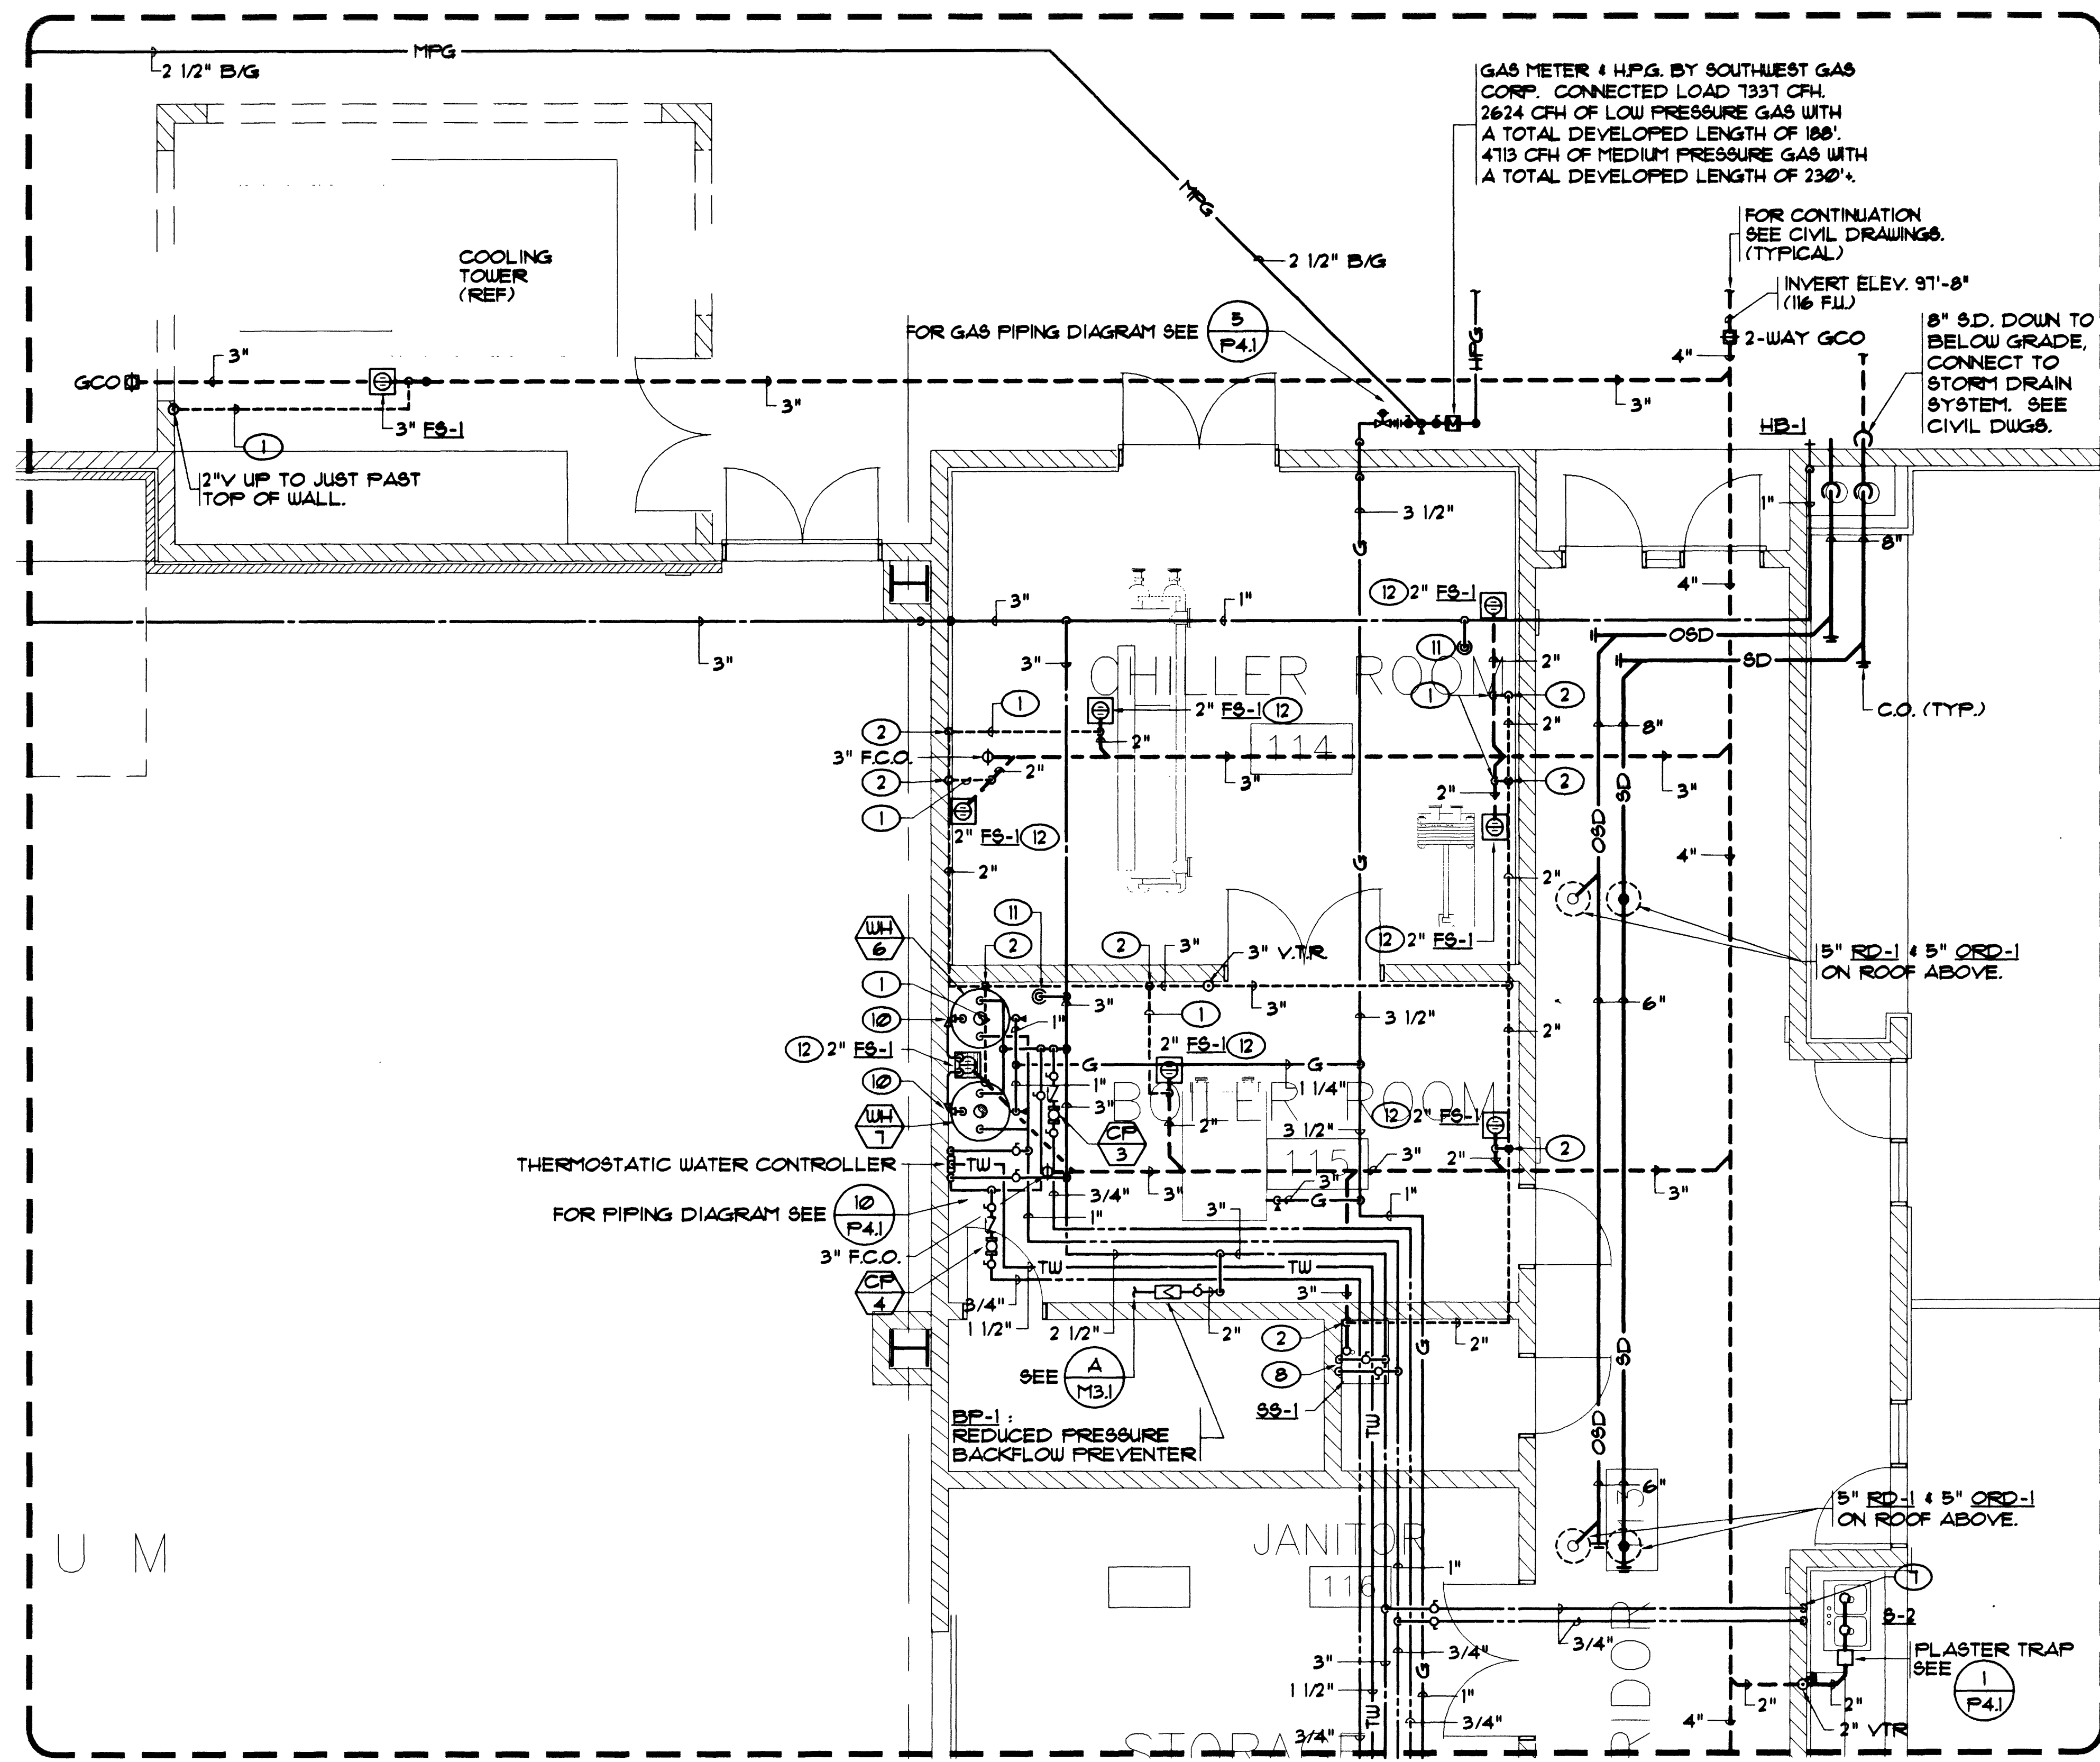

B PARTIAL PLUMBING FLOOR PLAN
P31 SCALE: 1/4" = 1'-0"

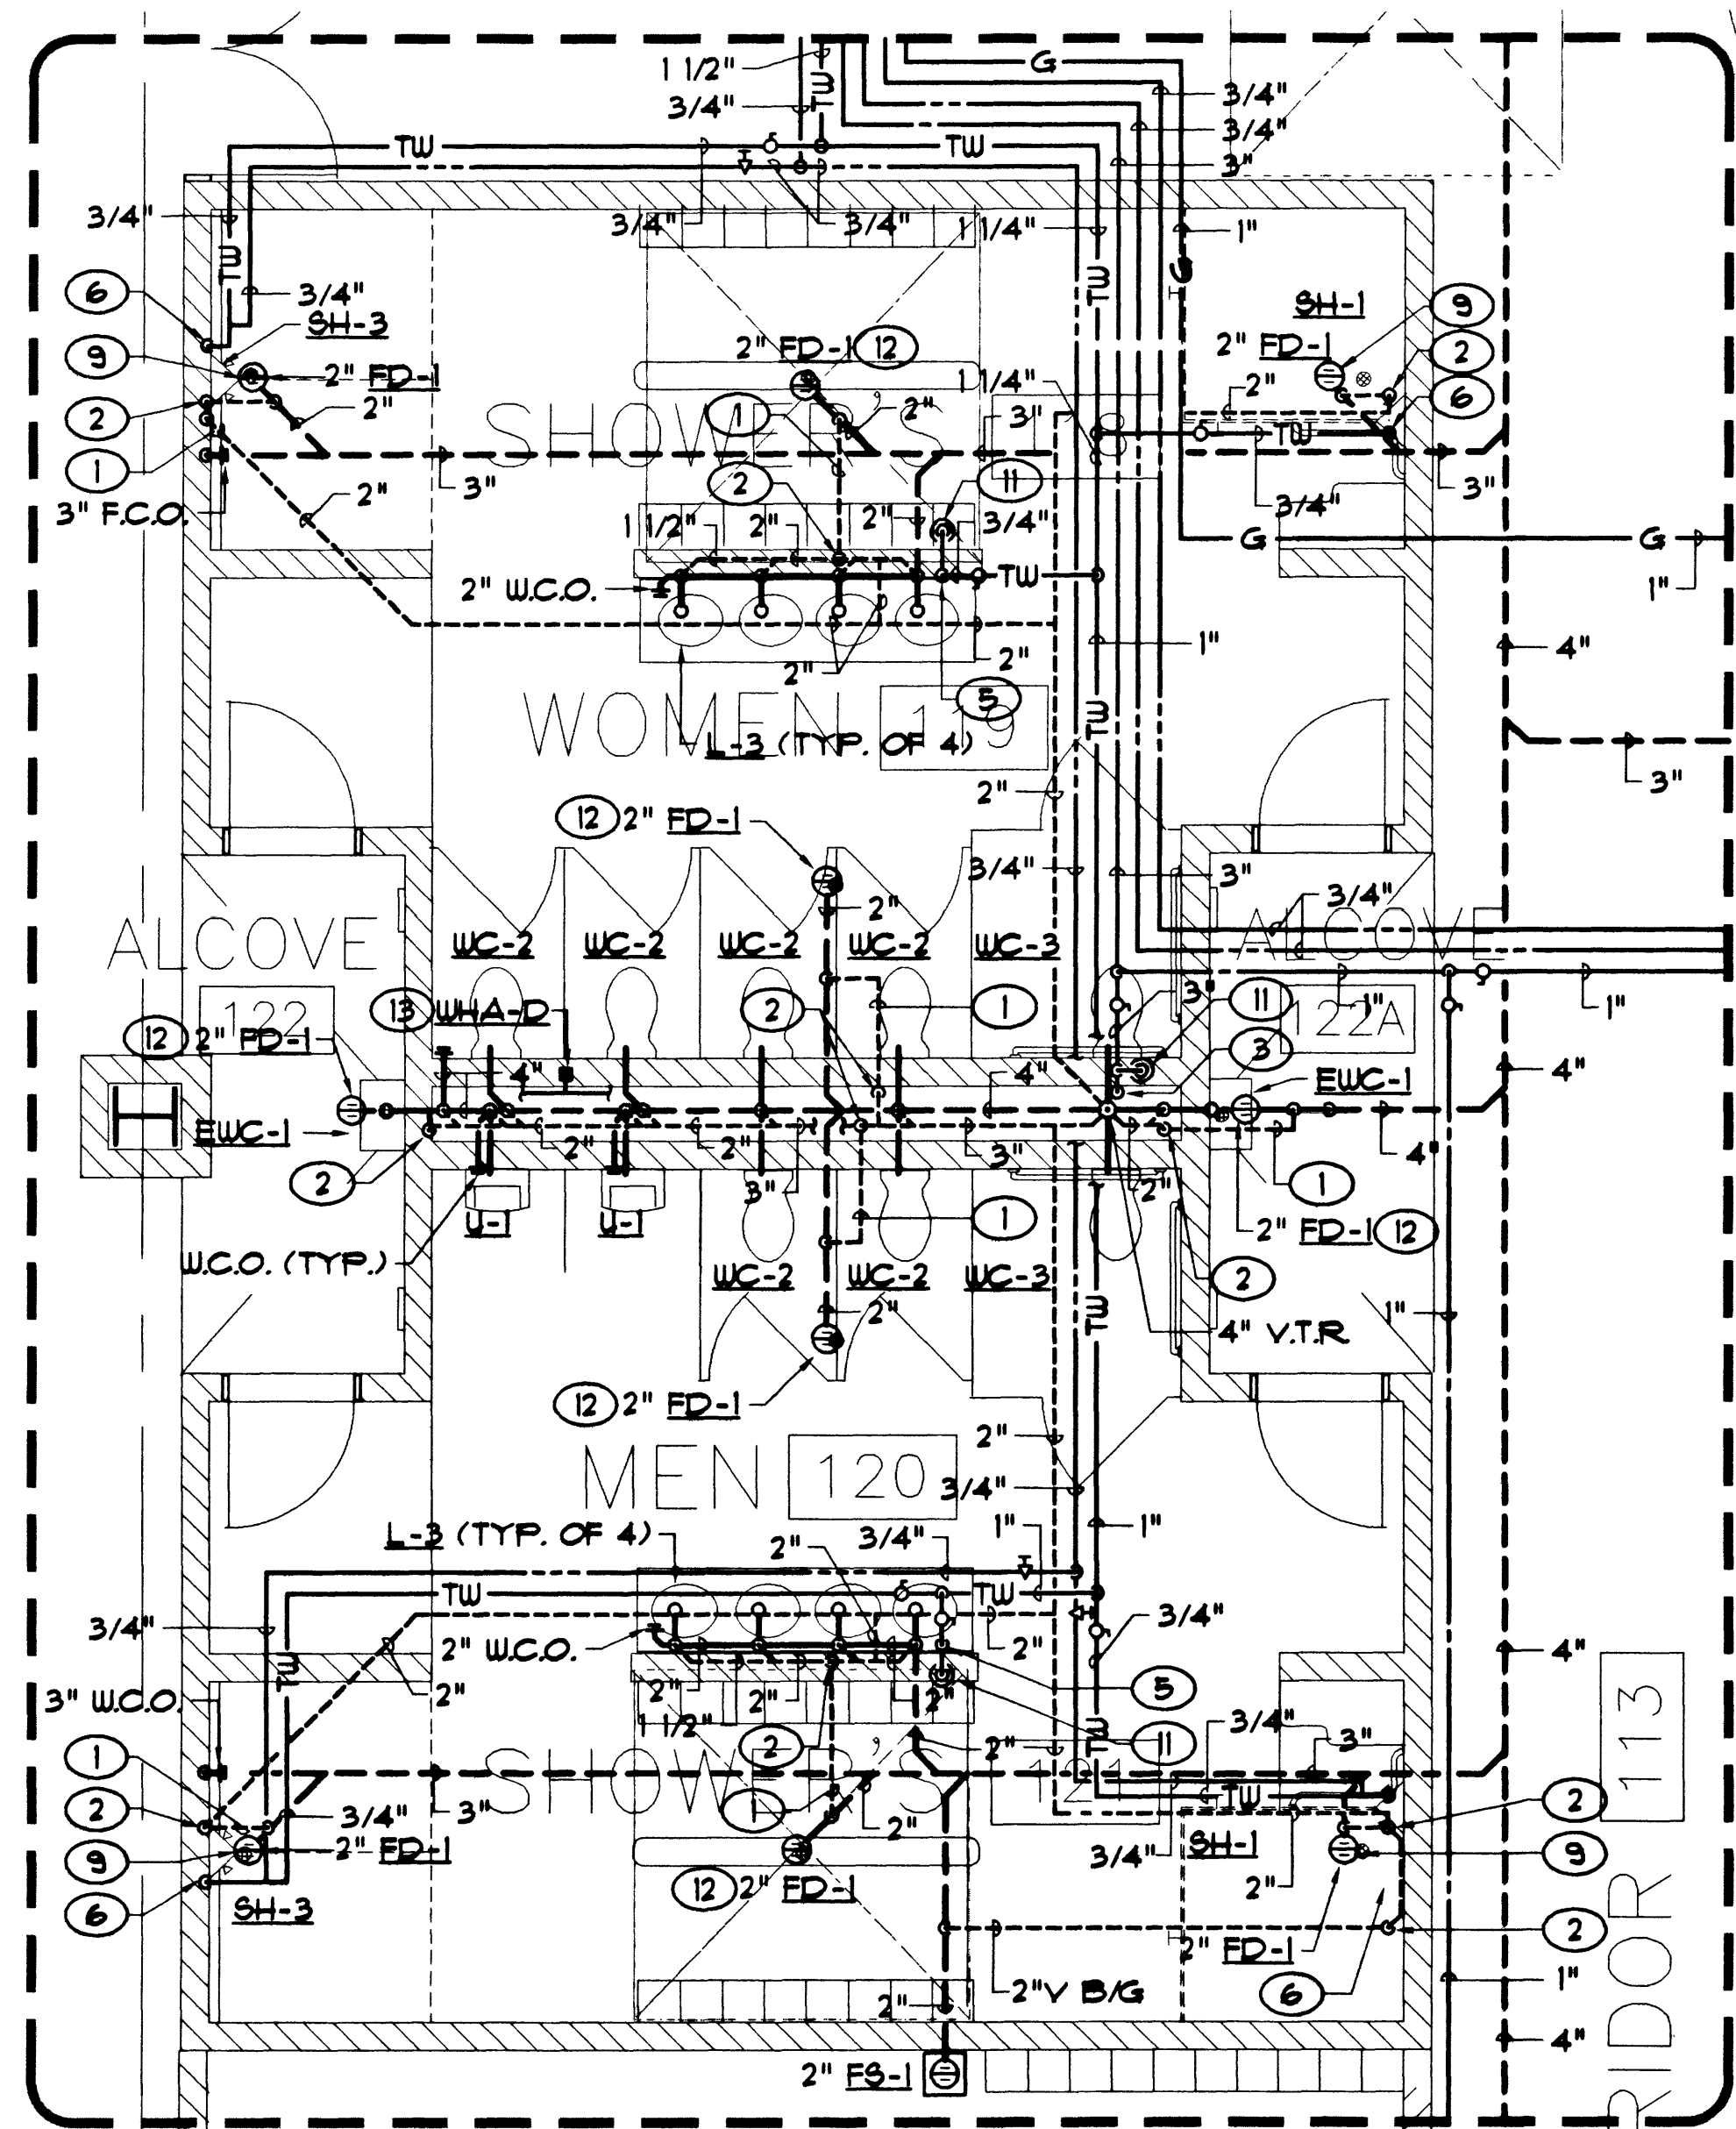

C PARTIAL PLUMBING FLOOR PLAN
P31 SCALE: 1/4" = 1'-0"

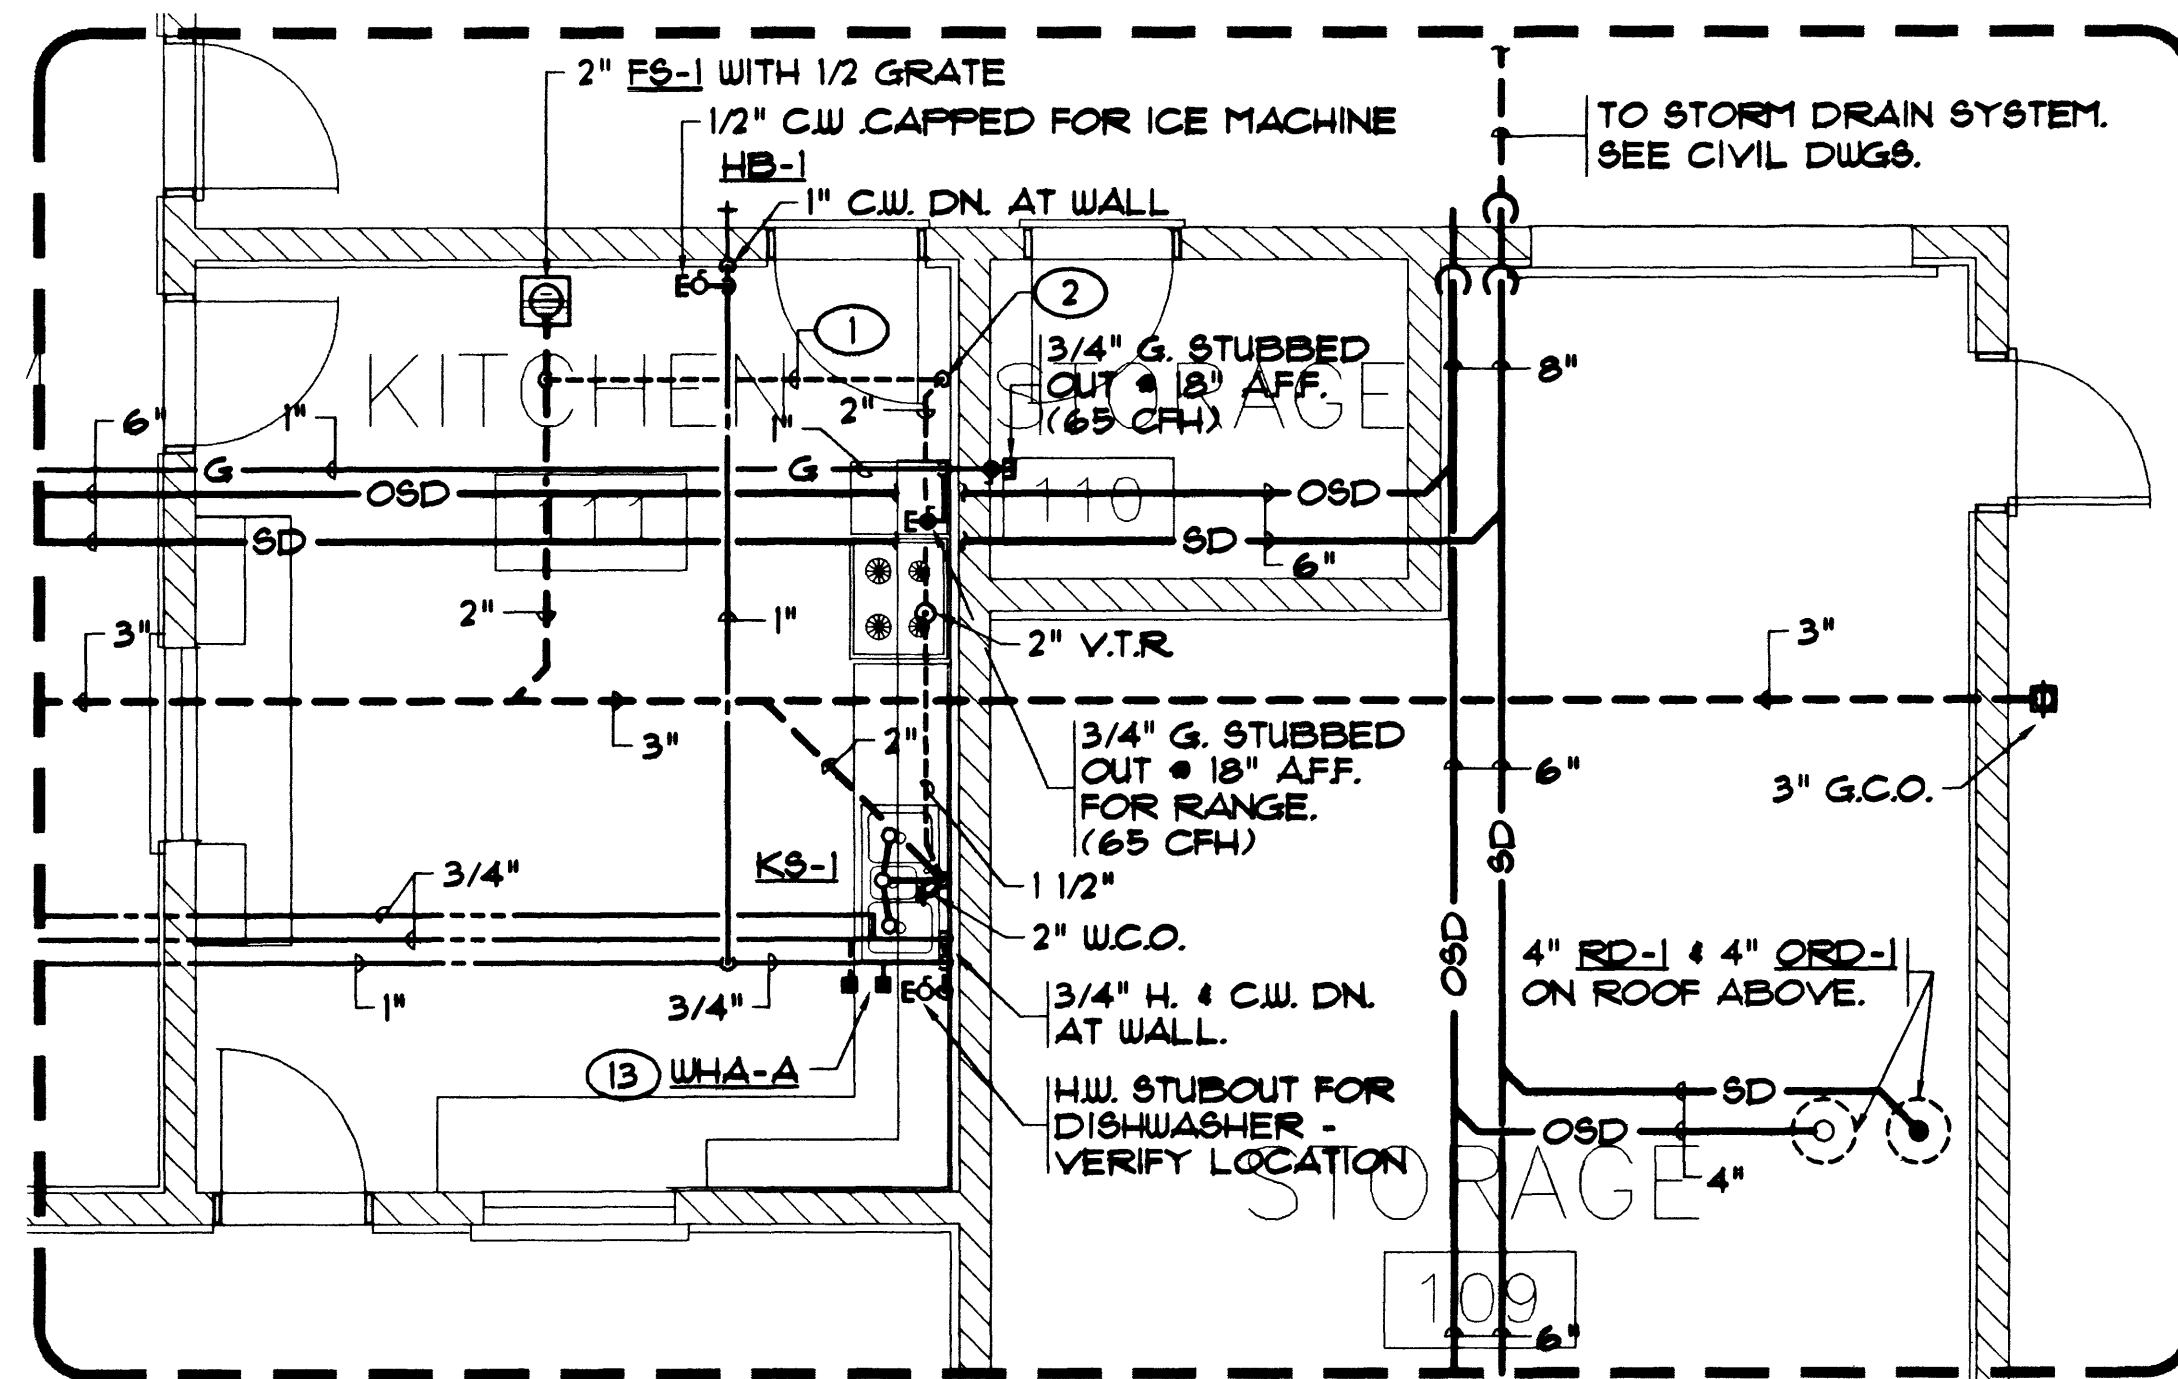

D PARTIAL PLUMBING FLOOR PLAN
P31 SCALE: 1/4" = 1'-0"

SHEET NOTES

- ① 2" VENT UP FROM BELOW FLOOR.
- ② 2" VENT UP FROM BELOW FLOOR.
- ③ 3" C.W. DOWN IN CHASE TO 3" HEADER.
- ④ 3/4" H. & C.W. DOWN AT WALL TO LAVS.
- ⑤ 3/4" T.W. DOWN AT WALL TO LAVS.
- ⑥ 3/4" H. & C.W. DOWN IN WALL TO 2-2.
- ⑦ 1/2" H. & C.W. DOWN IN WALL TO 2-2.
- ⑧ 2" DRAIN NEAR BASE OF SHOWER COLUMN.
- ⑨ TP4R VALVE WITH FULL SIZE DRAIN PIPING TO OVER FLOOR SINK.
- ⑩ TRAP PRIMER WITH DISTRIBUTION UNIT. PROVIDE ACCESS PANEL IN WALL OR CEILING AS NECESSARY.
- ⑪ CONNECT FLOOR DRAIN TO TRAP PRIMER.
- ⑫ PROVIDE WATER HAMMER ARRESTOR WITH PROPERLY SIZED ACCESS PANEL.

RECORD DRAWINGS RECORD DRAWING
104 OF 110
650.59

DUNHAM ASSOCIATES
MECHANICAL ELECTRICAL
3024 Regal Avenue
Las Vegas, NV 89102
PH: (702) 222-9677
FAX: (702) 222-9650

REVISION	DESCRIPTION	DATE	REV. BY

1525 WEST OAKLEY BLVD
LAS VEGAS, NV 89102
(702) 363-8077
FAX 363-0657

HSA ARCHITECTS

WAYNE SCHEIDT, AIA
THOMAS M. SILVA, AIA

Sheet Title: **PARTIAL PLUMBING FLOOR PLANS**
Job Title: **CITY OF LAS VEGAS DEPARTMENT OF PARK AND LEISURE ACTIVITIES DURANGO RECREATION FACILITY**
Job No: 960901
Date: 2-20-98
Drawn By: DGD
Check: KJK
Sheet: P31

Verify all Dimensions and Conditions at the Site

or 104 of 110
4 of 6
650.59

P:\06150\03-1.dwg P31.MPT 06.15.98 40.1598 LLS:MD

27116