


MATCH LINE AREA A
SEE A72.3 AREA B

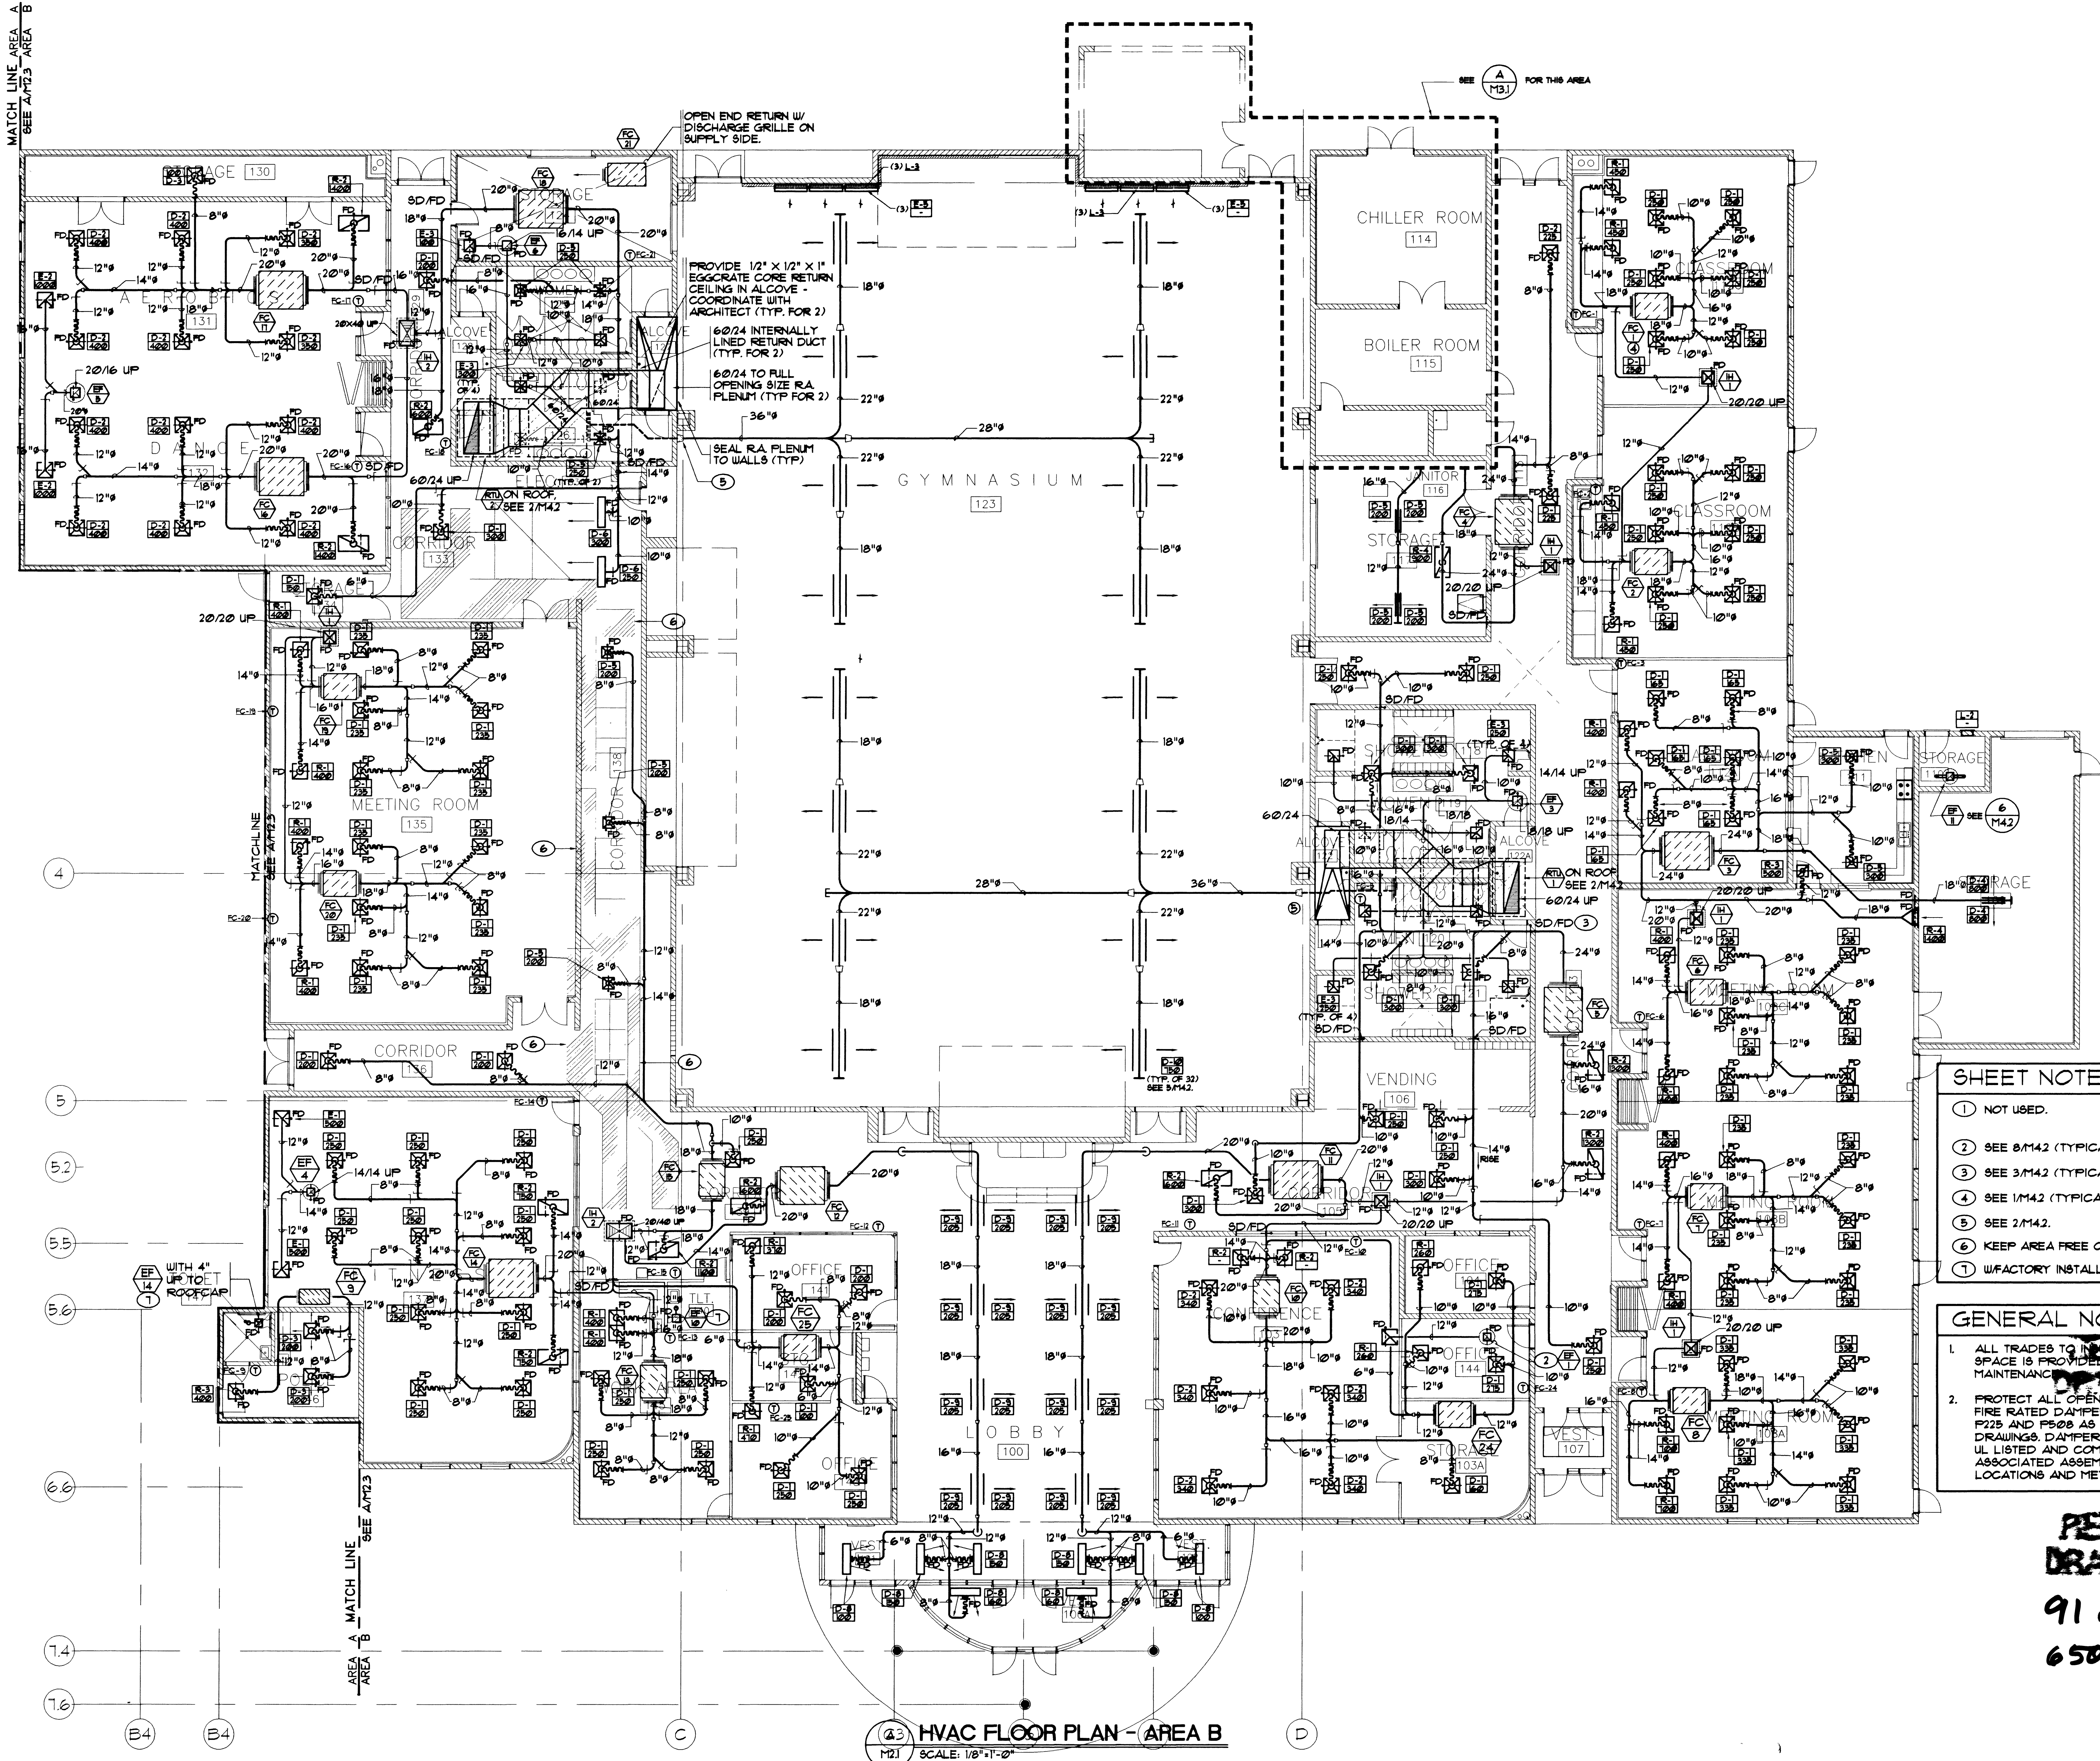

- SHEET NOTES**
- 1 NOT USED.
 - 2 SEE 8/M42 (TYPICAL).
 - 3 SEE 3/M42 (TYPICAL).
 - 4 SEE 1/M42 (TYPICAL).
 - 5 SEE 2/M42.
 - 6 KEEP AREA FREE OF DUCTWORK AND PIPING.
 - 7 W/FACORY INSTALLED CEILING FIRE DAMPER.
- GENERAL NOTES**
1. ALL TRADES TO MAKE SURE SUFFICIENT SPACE IS PROVIDED FOR FILTER AND UNIT MAINTENANCE.
 2. PROTECT ALL OPENINGS THRU CEILING WITH FIRE RATED DAMPERS PER UL DESIGN NO. P228 AND P228 AS INDICATED ON THE ARCH. DRAWINGS. DAMPER ASSEMBLY SHALL BE UL LISTED AND COMPATIBLE WITH ITS ASSOCIATED ASSEMBLY. FIELD VERIFY ALL LOCATIONS AND METHODS.

**RECORD
DRAWINGS**
91 OF 118
650.59

DUNHAM ASSOCIATES
CONSULTING ENGINEERS
304 N. 3RD STREET
LAS VEGAS, NV 89101
PH. (702) 222-9677
FAX. (702) 222-9698

M2.1

of 91 / 118
3 of 12

REVISION	DESCRIPTION	DATE	REV. BY

1525 WEST OAKLEY BLVD
LAS VEGAS, NV 89102
(702) 383-0077
FAX 383-0057

WAYNE SCHREINER AIA
THOMAS M. SILVA AIA

Sheet Title **HVAC PLAN - AREA B**

Job Title **CITY OF LAS VEGAS DEPARTMENT OF PARK AND LEISURE ACTIVITIES
DURANGO RECREATION FACILITY**

Job **960901**

Date **2-20-98**

Drawn By **DGD**

Check **KJK**

Sheet **M2.1**

Verify all Dimensions and Conditions at the Site

960901