


MATCH LINE AREA A
AREA B

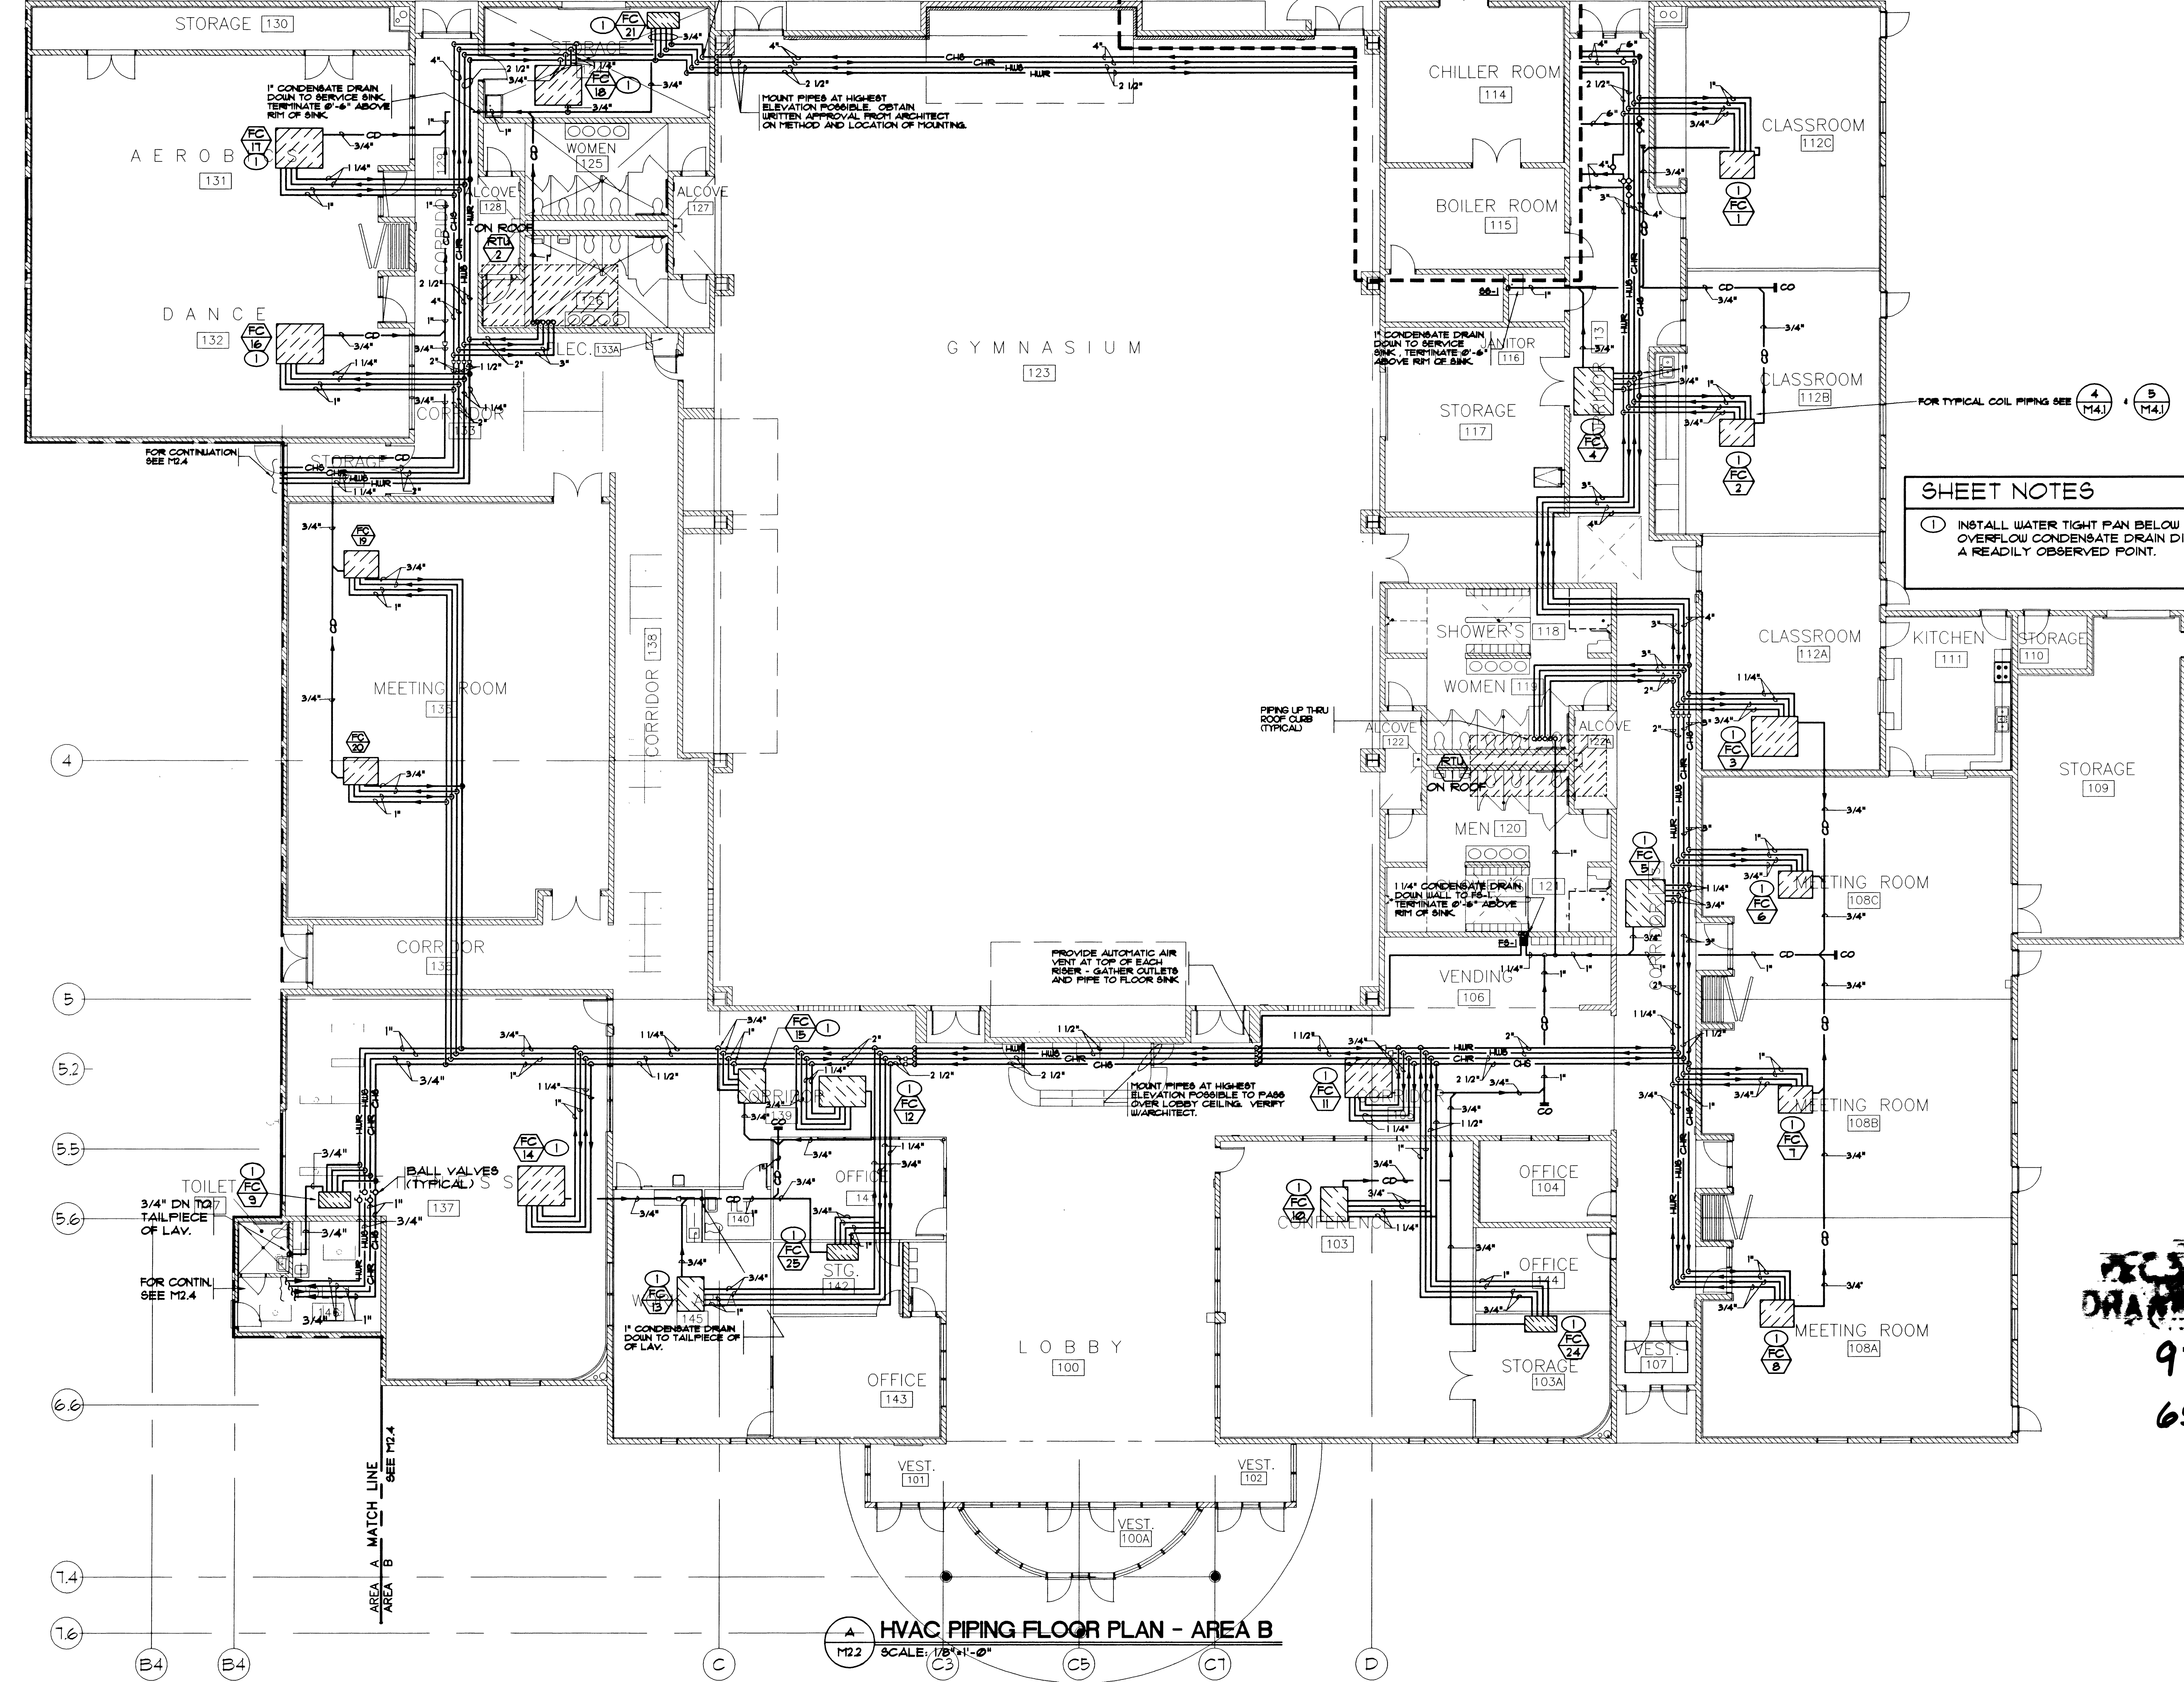

SHEET NOTES

① INSTALL WATER TIGHT PAN BELOW UNIT WITH 3/4" OVERFLOW CONDENSATE DRAIN DISCHARGING TO A READILY OBSERVED POINT.

REC RECORDED
DRAWINGS
92 OF 118
650.59

HVAC PIPING FLOOR PLAN - AREA B
SCALE: 1/8" = 1'-0"

P:\36105\36105-2.dwg F:\1 MAY 06 15:02:44 1998 LISAUD

27104

REVISION	DESCRIPTION	DATE	REV. BY

1525 WEST OAKLEY BLVD
LAS VEGAS, NV 89102
(703) 583-0077
FAX 363-0857

HSA ARCHITECTS

WAYNE SCHREINER, AIA
THOMAS M. SILVA, AIA

Sheet Title	HVAC PIPING PLAN - AREA B
Job Title	CITY OF LAS VEGAS DEPARTMENT OF PARK AND LEISURE ACTIVITIES DURANGO RECREATION FACILITY
Job	960901
Date	2-20-98
Drawn By	DGD
Check	KJK
Sheet	M2.2
or	92 of 118
	4 of 12
	650.59



MECHANICAL ELECTRICAL
3024 Regal Avenue
Las Vegas, NV 89102
PH (703) 222-8877
FAX (703) 222-9950

Verify all Dimensions and Conditions at the Site