


P:\86150\M2-3.dwg F:\M2 06 15 08 16 1998 LISJAO

27109

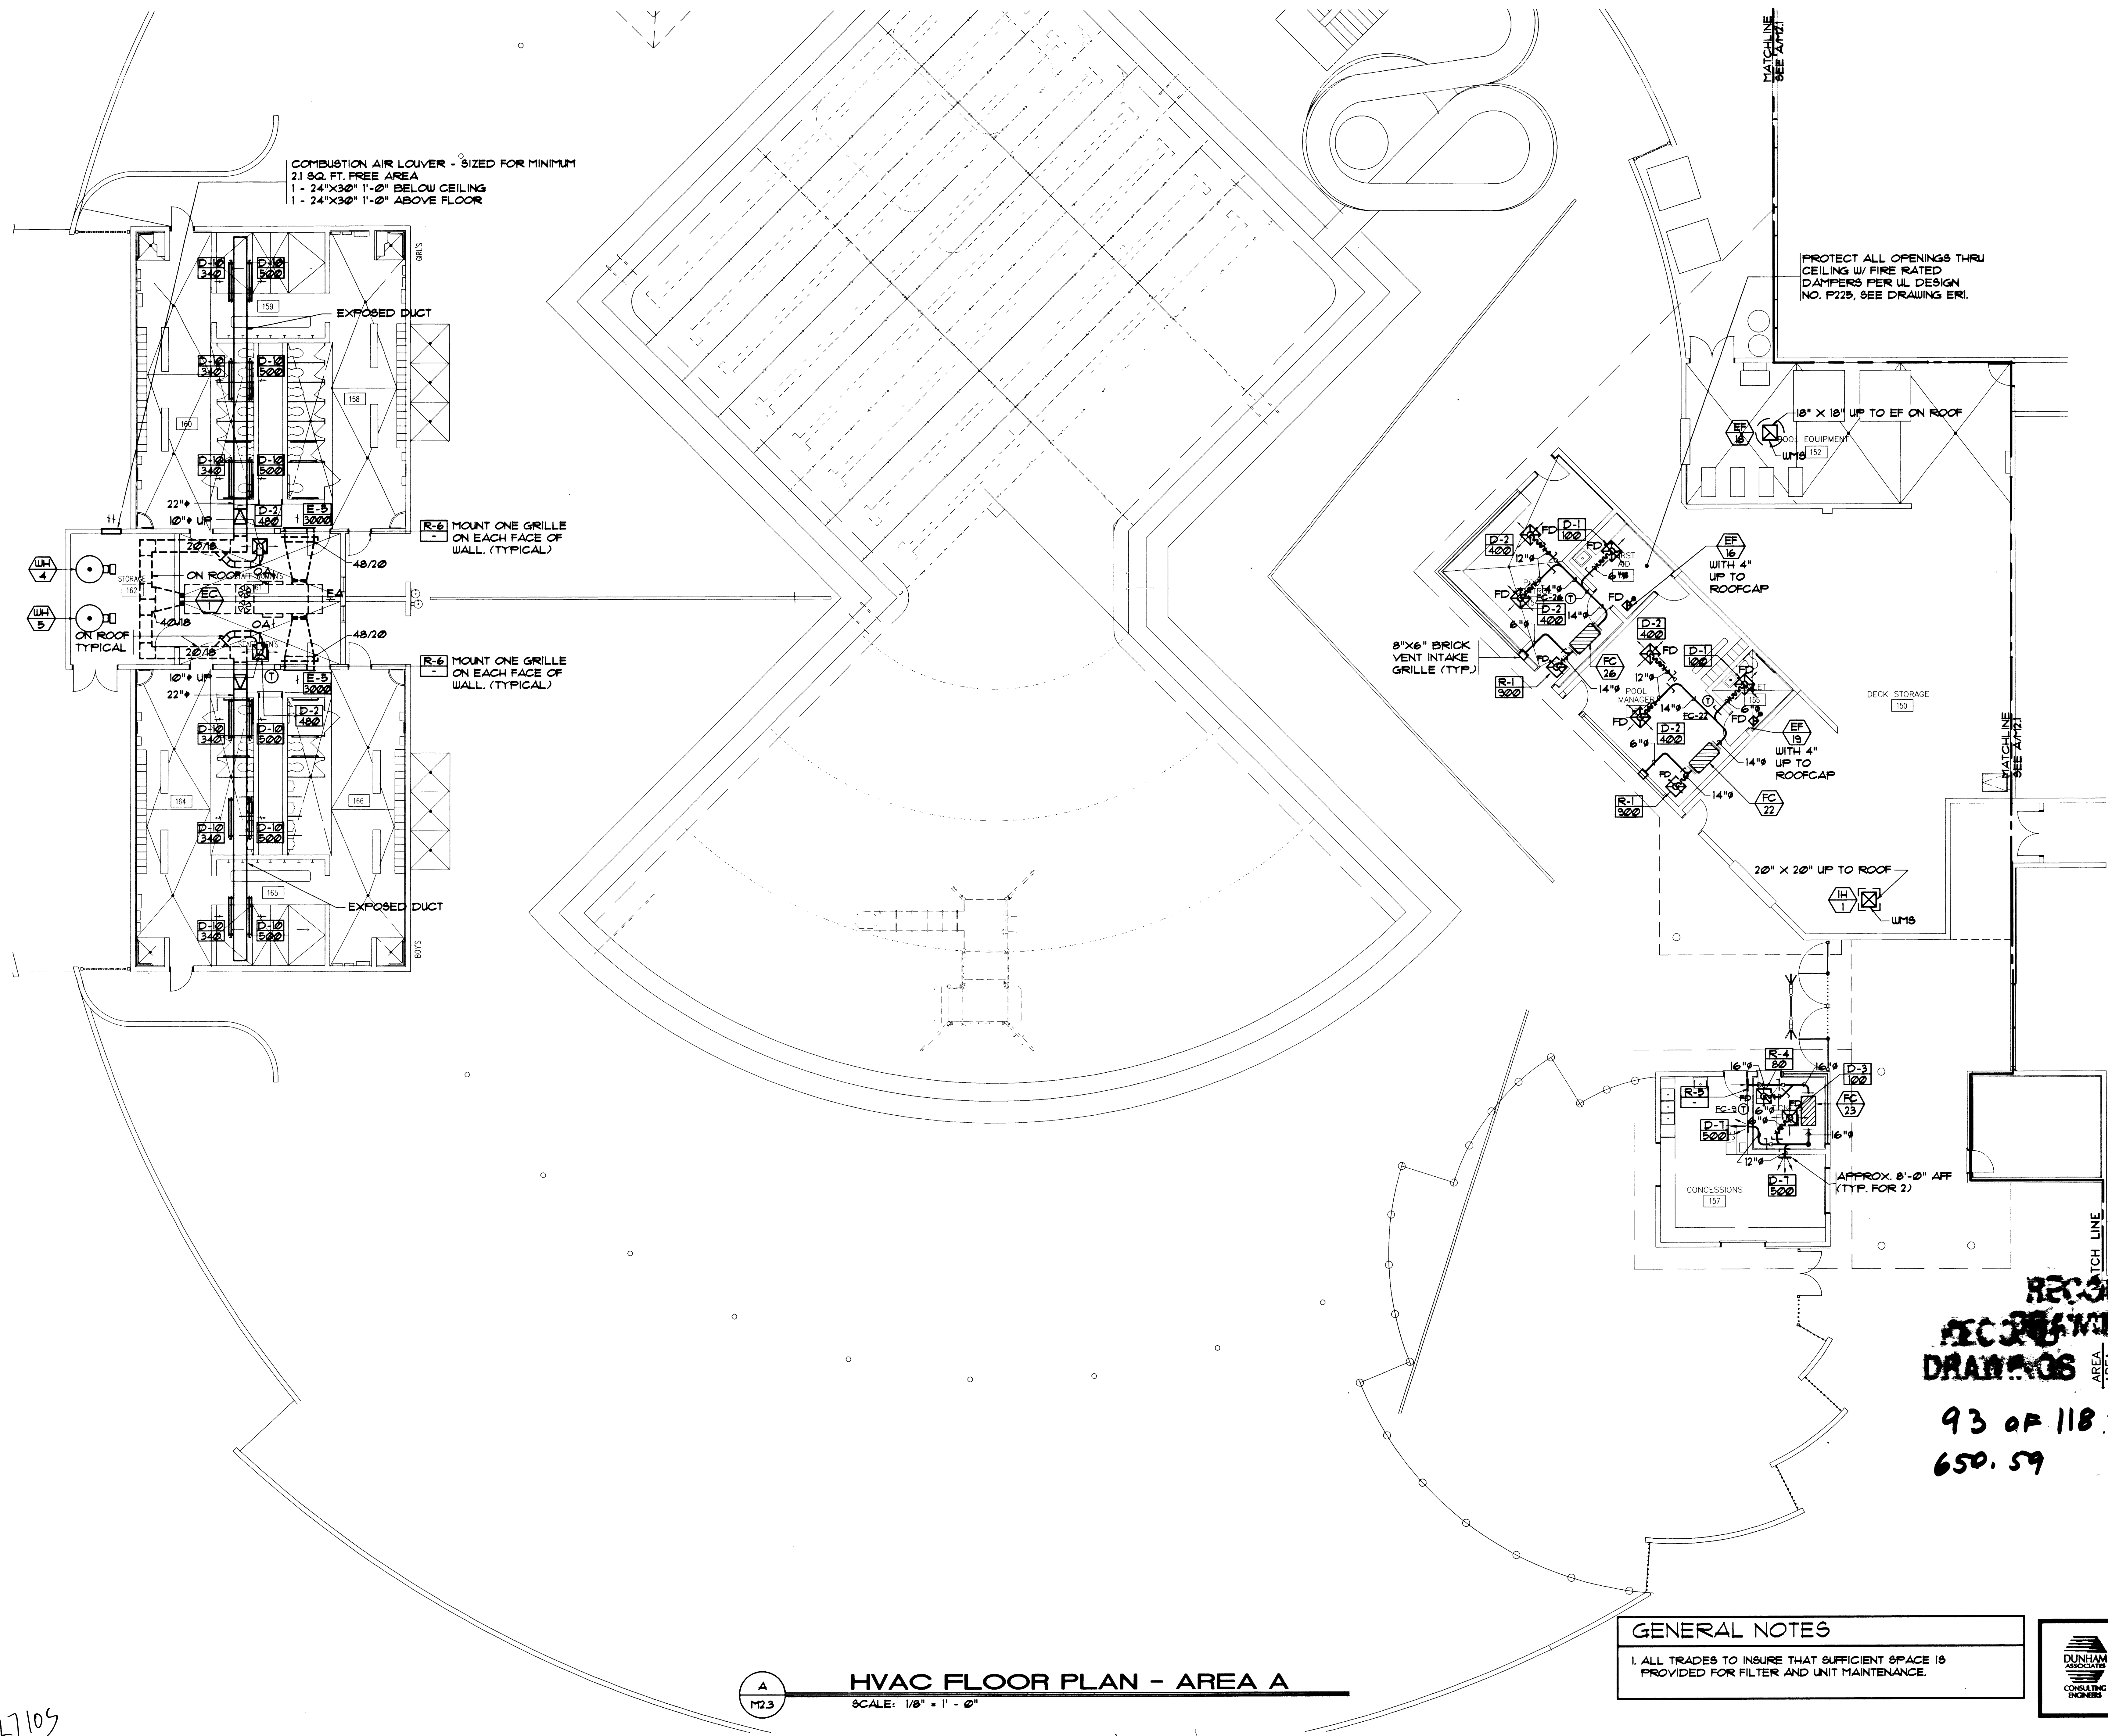

COMBUSTION AIR LOUVER - SIZED FOR MINIMUM
 2.1 SQ. FT. FREE AREA
 1 - 24"x30" 1'-0" BELOW CEILING
 1 - 24"x30" 1'-0" ABOVE FLOOR

R-6 MOUNT ONE GRILLE
 ON EACH FACE OF
 WALL. (TYPICAL)

R-6 MOUNT ONE GRILLE
 ON EACH FACE OF
 WALL. (TYPICAL)

PROTECT ALL OPENINGS THRU
 CEILING W/ FIRE RATED
 DAMPERS PER UL DESIGN
 NO. P225, SEE DRAWING ERI.

8"x6" BRICK
 VENT INTAKE
 GRILLE (TYP.)

DECK STORAGE


20' X 20' UP TO ROOF

APPROX. 8'-0" AFF
 (TYP. FOR 2)

**RECORD
 RECORDS
 DRAWINGS**

93 OF 118
 650.59

GENERAL NOTES
 1. ALL TRADES TO INSURE THAT SUFFICIENT SPACE IS
 PROVIDED FOR FILTER AND UNIT MAINTENANCE.

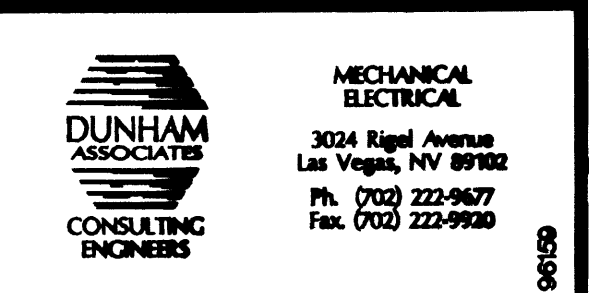

HVAC FLOOR PLAN - AREA A
 SCALE: 1/8" = 1' - 0"

REVISION	DESCRIPTION	DATE	REV. BY
1	BUILDING DEPARTMENT COMMENTS	7/26/97	RJK
2	OWNER CHANGES	8/19/97	RJK
3	BUILDING DEPARTMENT COMMENTS	7/28/98	RJK

WAYNE SCHREINER AA
 THOMAS M. SILVA AA
 1525 WEST OAKLEY BLVD
 LAS VEGAS, NV 89102
 (702) 382-0877
 FAX 382-0857
WISA ARCHITECTS

Sheet Title HVAC PLAN - AREA A
 Job Title CITY OF LAS VEGAS DEPARTMENT OF PARK AND LEISURE ACTIVITIES
 DURANGO RECREATION FACILITY
 Verify all Dimensions and Conditions at the Site

Job	960901
Date	2-20-98
Drawn By	DGD
Check	KJK
Sheet	M2.3

Of 93 118
 5 of 12
 6 2 9