

GOWAN ROAD

NOTES:

- ① CIRCUIT TO EXISTING PANELS AND BREAKERS PROVIDED UNDER BUILDING CONTRACT.
- ② ALL WALKWAY LIGHTING CIRCUITING IS 2#0, 1#0 GND, 3/4" UNLESS NOTED OTHERWISE.
- ③ ALL PARKING LOT LIGHTING CIRCUITING IS 3#0, 1#0 GND, 1" UNLESS NOTED OTHERWISE.
- ④ ROUTE THRU CONTACTOR.
- ⑤ PROVIDE TIMING CONTROL CENTER EQUAL TO INTERMATIC TS1B1BC COMPLETE WITH PHOTOCONTROL, MOUNT CONTACTOR AND TIMING CONTROL CENTER ON WALL ADJACENT TO PANEL. PROGRAM TO CONTROL LIGHTING PER OWNERS INSTRUCTIONS.

DESIGNWORKSHOP
 LANDSCAPE ARCHITECTURE
 LAND PLANNING
 URBAN DESIGN
 TOURISM PLANNING
 510 South Mill Ave., Suite 201
 Tempe, Arizona 85281
 (602) 466-5666
 Albuquerque • Aspen • Denver
 San Francisco • Santa Fe • Tampa • Vail
 Jackson Hole

CONSULTANT
TJKROB CONSULTING
 ENGINEERS, INC.
 1919 S. JONES BLVD., SUITE B
 LAS VEGAS, NEVADA 89102
 (702) 871-3621
 ELECTRICAL ENGINEERING

**NORTHWEST
 FAMILY
 RECREATIONAL
 COMPLEX**
 CITY OF
 LAS VEGAS, NEVADA

**ELECTRICAL
SITE PLAN**

CONSTRUCTION DOCUMENT

ISSUE DATE: 10/24/97


DRAWN: JTK/AM JOB NO: 763/SITE

REVIEWED: TOM KROB

REVISIONS/DESCRIPTION:

1. 01/30/98 ADDENDUM #2

PROJECT KEY MAP: NTE

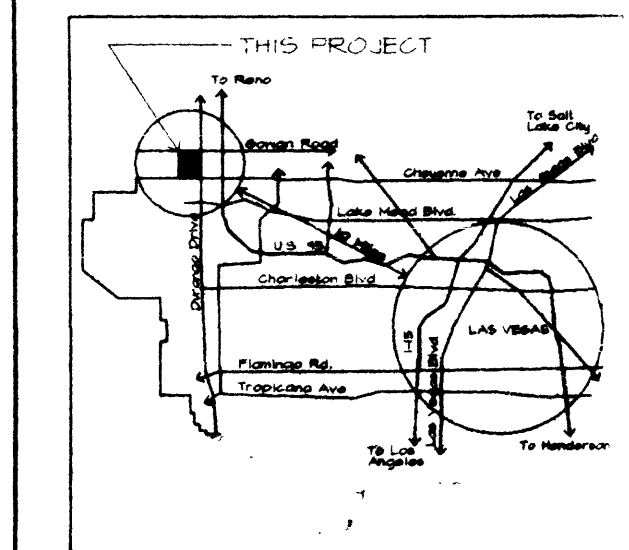

Scale: 1" = 30'-0"
 North arrow pointing up.

SHEET NUMBER
E-2.1

Design Workshop, Inc. Oc
34 OF 37
 8/20/99

LIMIT OF THIS PROJECT

MATCH LINE

MATCH LINE

MATCH LINE

Community Center

NOT IN CONTRACT

N.I.C.

N.I.C.

3=F3
2=F2
9=F7

35

**RECORD
DRAWINGS**
37 OF 118
650.59

ELECTRICAL SITE 1 PLAN

SCALE: 1" = 30'-0"

27089
27088