

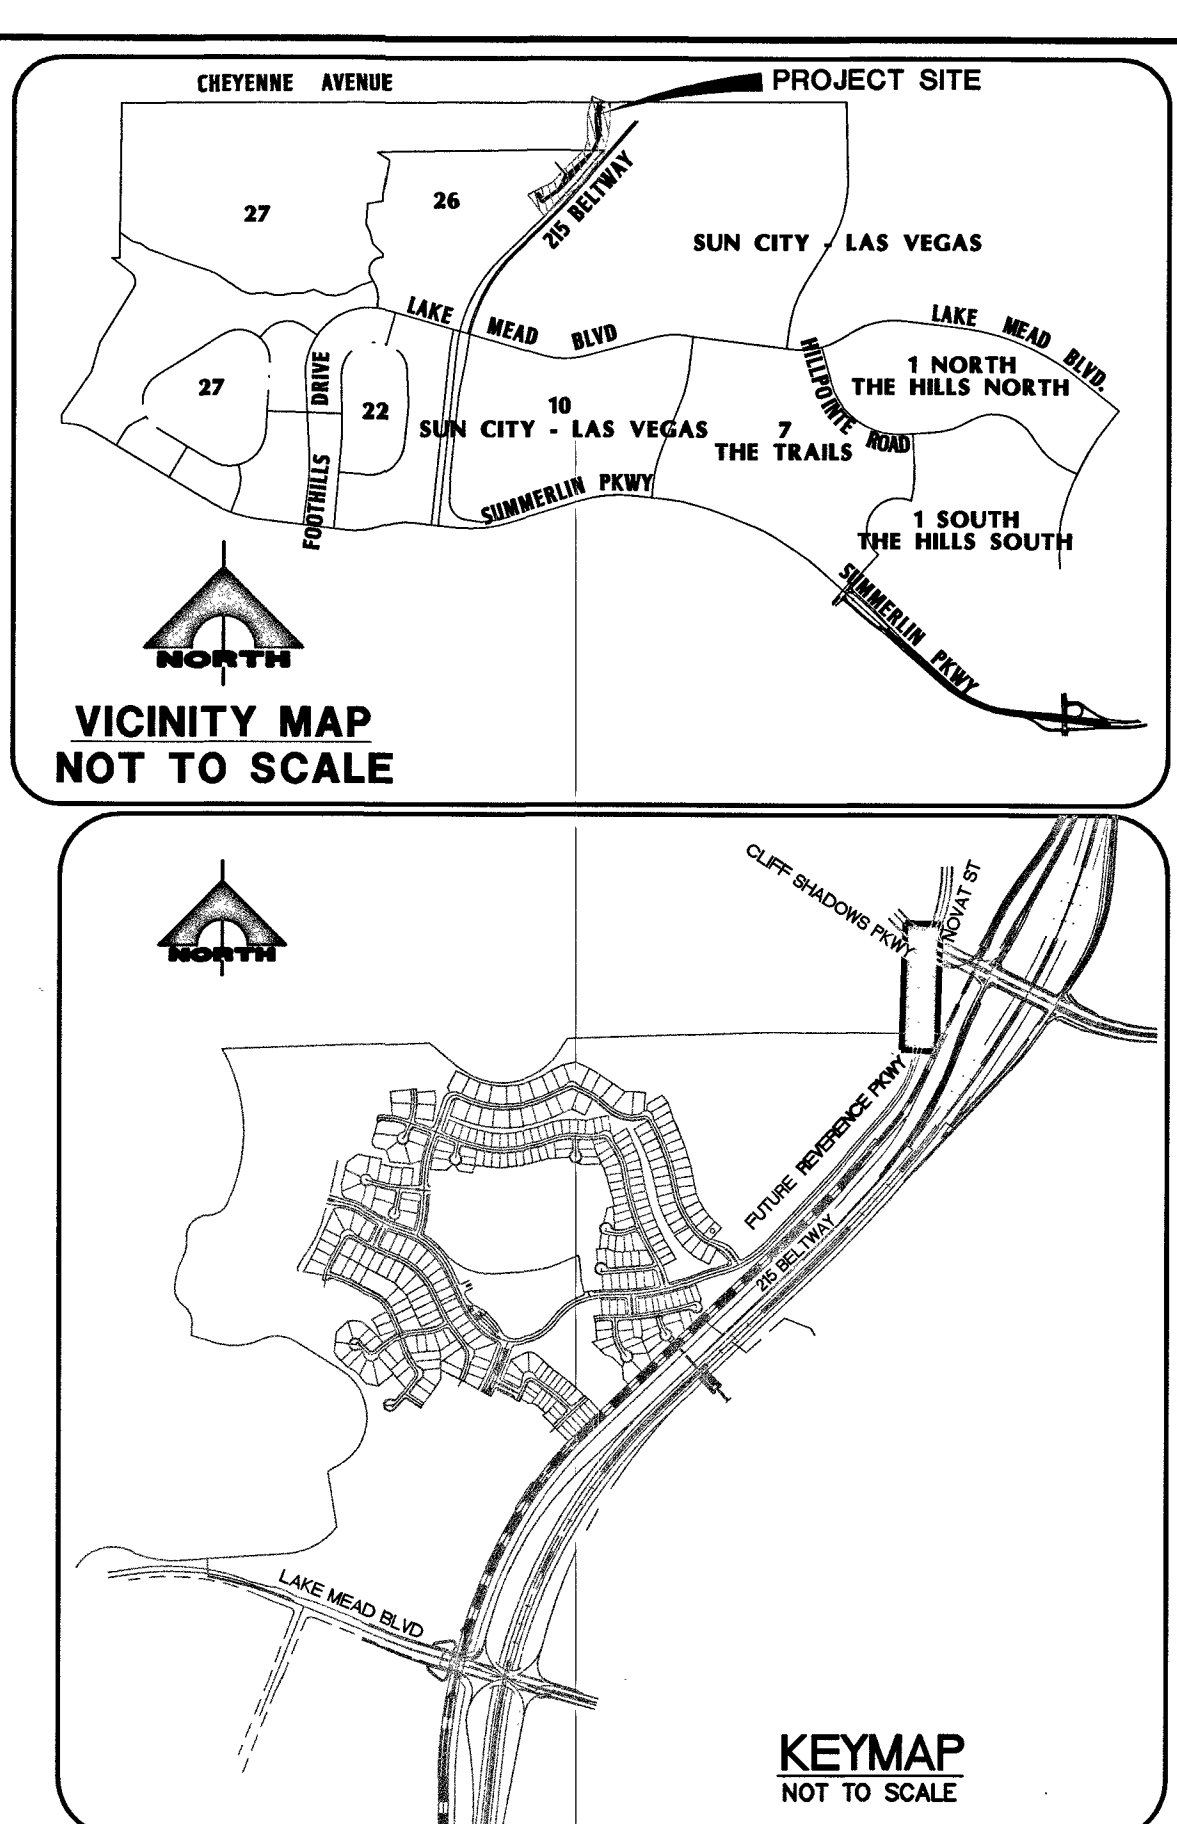


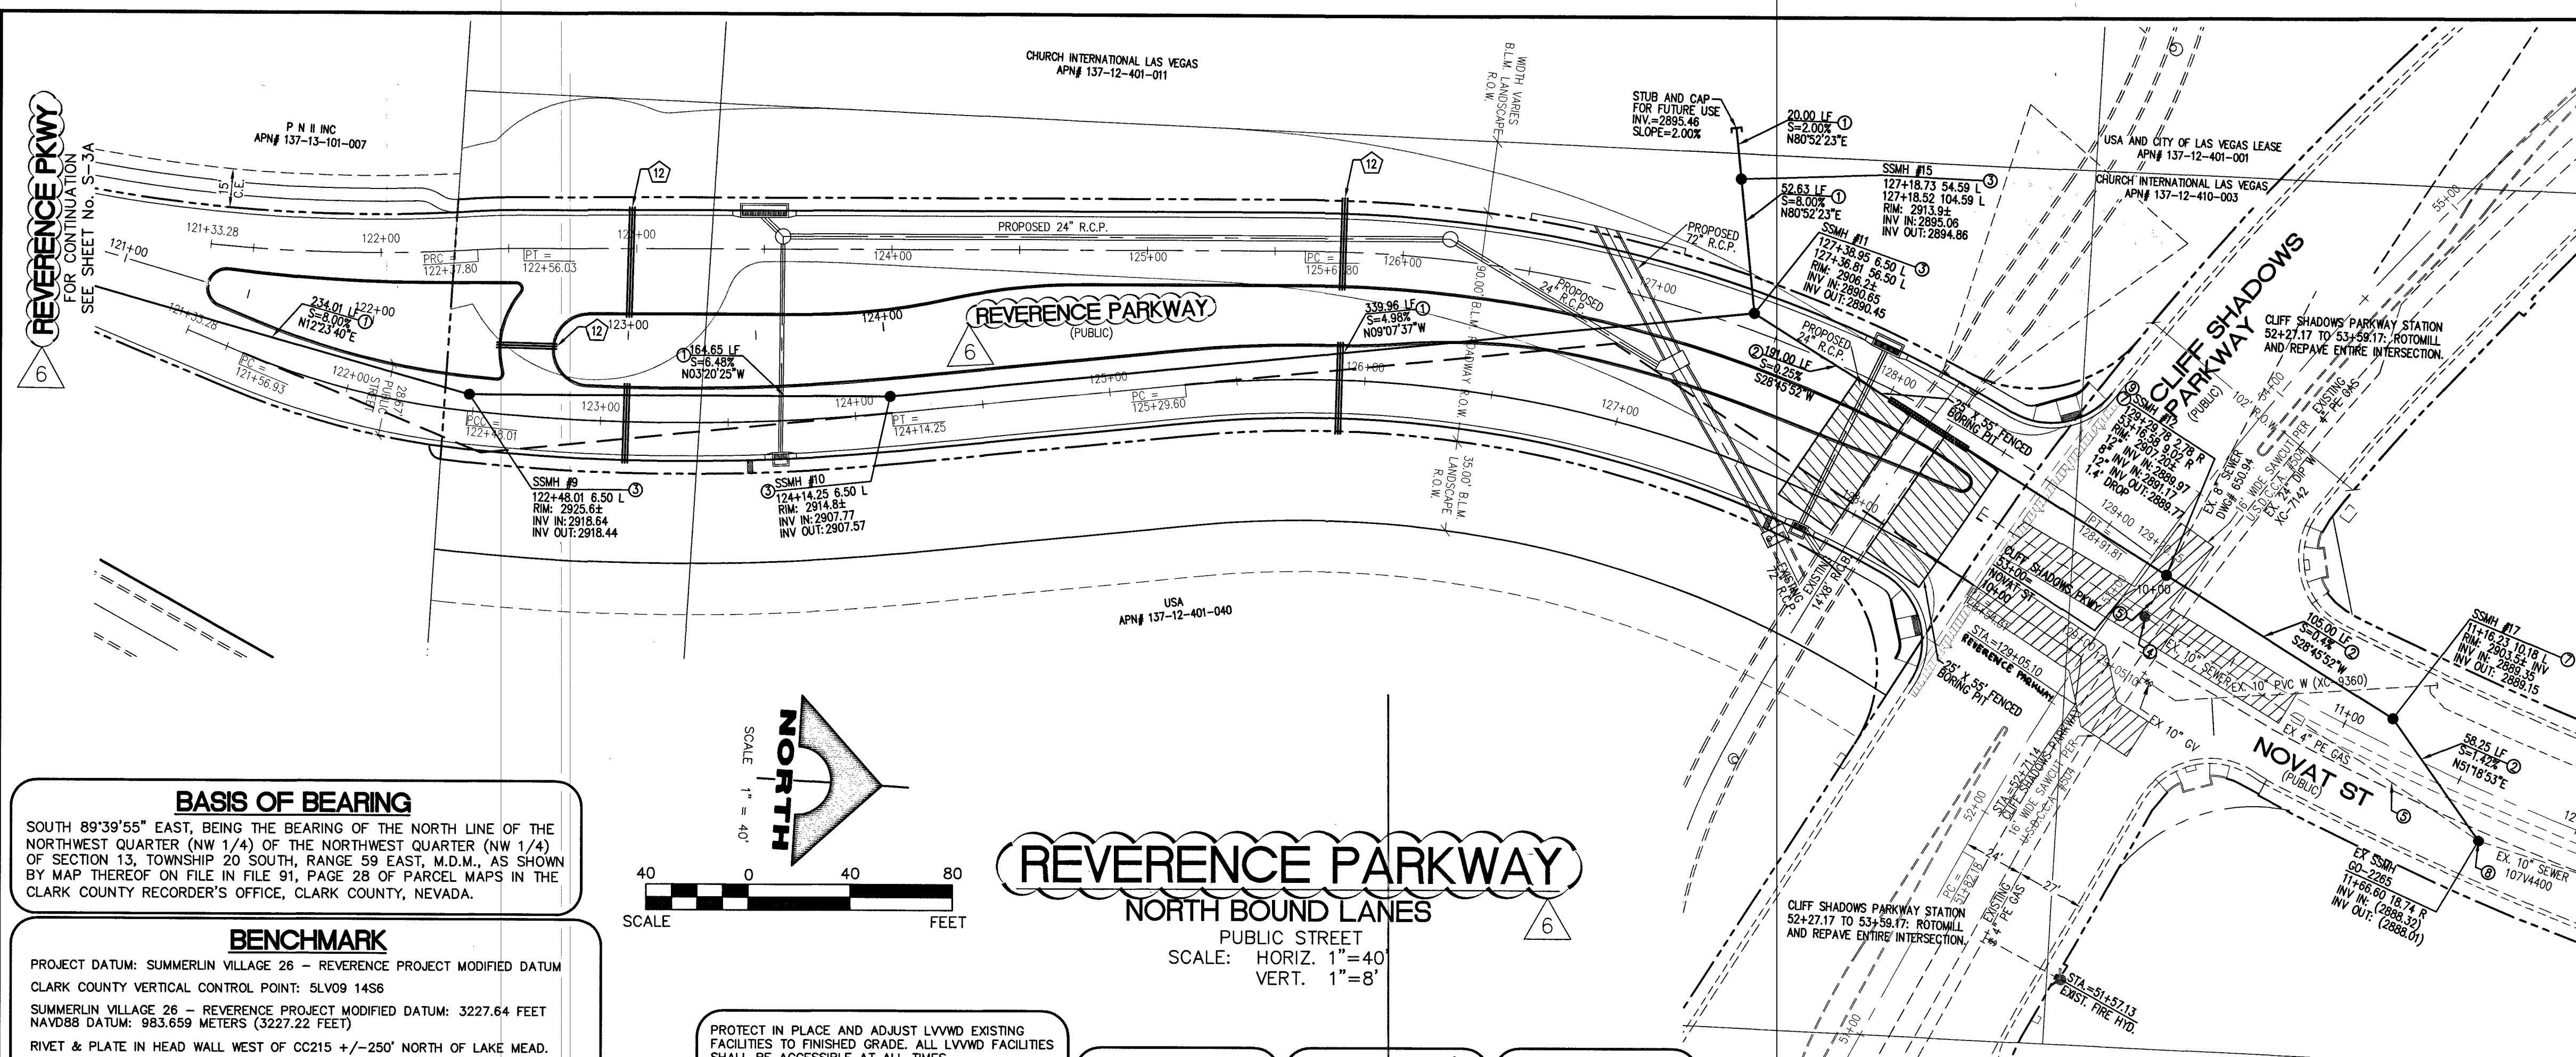

BASIS OF BEARING
SOUTH 89°39'55" EAST, BEING THE BEARING OF THE NORTH LINE OF THE NORTHWEST QUARTER (NW 1/4) OF THE NORTHWEST QUARTER (NW 1/4) OF SECTION 13, TOWNSHIP 20 SOUTH, RANGE 59 EAST, M.D.M., AS SHOWN BY MAP THEREOF ON FILE IN FILE 91, PAGE 28 OF PARCEL MAPS IN THE CLARK COUNTY RECORDER'S OFFICE, CLARK COUNTY, NEVADA.

BENCHMARK
PROJECT DATUM: SUMMERLIN VILLAGE 26 - REVERENCE PROJECT MODIFIED DATUM
CLARK COUNTY VERTICAL CONTROL POINT: 5LV09 1456
SUMMERLIN VILLAGE 26 - REVERENCE PROJECT MODIFIED DATUM: 3227.64 FEET
NAVOD88 DATUM: 983.659 METERS (3227.22 FEET)
RIVET & PLATE IN HEAD WALL WEST OF CC215 +/-250' NORTH OF LAKE MEAD.
TO OBTAIN SUMMERLIN VILLAGE 26 - REVERENCE PROJECT MODIFIED DATUM ADD 0.42 FEET TO NAVOD88 DATUM.

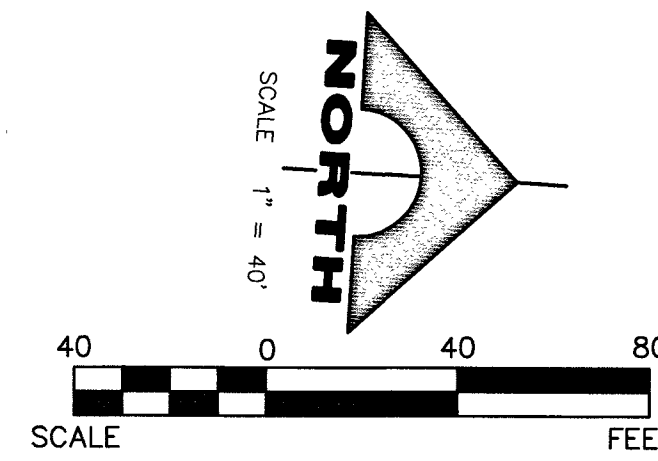

REVERENCE PARKWAY
NORTH BOUND LANES
PUBLIC STREET
SCALE: HORIZ. 1"=40'
VERT. 1"=8'

APPROVED FOR CONSTRUCTION
Signature on File (sheet S-3A)
LAS VEGAS FIRE AND RESCUE
FIRE FLOW 1,500 GPM AT 20 PSI RESIDUAL
DATE

APPROVED FOR CONSTRUCTION
Signature of Engineer
LAS VEGAS VALLEY WATER DISTRICT
PROJECT #124656
LVWMD APPROVED FIRE FLOW 1,500 GPM AT 20 PSI RESIDUAL
DATE: 11/01/16

Call before you Dig
Avoid cutting underground utility lines. It's costly.

FAST
Call before you UnderGround
1-702-432-5300
FREEWAY AND ARTERIAL SYSTEM OF TRANSPORTATION

CALL BEFORE YOU DO OVERHEAD
1-702-227-2929

LEGEND


EXISTING FIRE HYDRANT	W/6" G.V. & F.H. LOCATOR	EXISTING WATER LINE	EXISTING GATE VALVE	EXISTING GATE VALVE	EXISTING WATER LINE
W/6" G.V. & F.H. LOCATOR	EXISTING WATER LINE	EXISTING GATE VALVE	EXISTING WATER LINE	EXISTING GATE VALVE	EXISTING WATER LINE
W/6" G.V. & F.H. LOCATOR	EXISTING WATER LINE	EXISTING GATE VALVE	EXISTING WATER LINE	EXISTING GATE VALVE	EXISTING WATER LINE
W/6" G.V. & F.H. LOCATOR	EXISTING WATER LINE	EXISTING GATE VALVE	EXISTING WATER LINE	EXISTING GATE VALVE	EXISTING WATER LINE
W/6" G.V. & F.H. LOCATOR	EXISTING WATER LINE	EXISTING GATE VALVE	EXISTING WATER LINE	EXISTING GATE VALVE	EXISTING WATER LINE

SEWER CONSTRUCTION NOTES

KEY	ITEM
1	INSTALL 8" PUBLIC PVC SEWER LINE.
2	INSTALL 12" PUBLIC C900 SEWER LINE.
3	INSTALL 48" SANITARY SEWER MANHOLE PER SD-1A AND SD-1B.
4	REMOVE MANHOLE PER DCSWCS 3.16.2a.
5	ABANDON SEWER LINE PER DCSWCS 3.16.1c.
6	INSTALL 12" PUBLIC PVC SEWER LINE.
7	INSTALL 60" SANITARY SEWER MANHOLE PER SD-1A AND SD-1B.
8	ADJUST TO GRADE
9	INSTALL CORROSION PROTECTION PER DCSWCS 3.16.18.

WATER CONSTRUCTION NOTES

KEY	ITEM
1	INSTALL 8" PVC PUBLIC WATER MAIN
2	INSTALL 8" DIP PUBLIC WATER MAIN
3	INSTALL 8" GATE VALVE. VALVES SHALL NOT BE LOCATED IN STREET VALLEY GUTTERS OR WITHIN THE PROPOSED CURB & GUTTER LOCATIONS. UDACS PLATE 30 & 39
4	INSTALL 8" - 5' BEND UDACS PLATE 31
5	INSTALL 8" - 45' BEND UDACS PLATE 31
6	INSTALL 8" - 90' BEND UDACS PLATE 31
7	INSTALL 8" TEE UDACS PLATE 31
8	8" CAP W/ 2" BLOW-OFF PER (UDACS) PLATE No. 36
9	1 1/2" IRRIGATION SERVICE LAT. W/ 1 1/2" METER AND 1 1/2" R.P.A. PER UDACS PLATE 4 & 8
10	INSTALL FIRE HYDRANT ASSEMBLY PER UNIFORM DESIGN AND CONSTRUCTION STANDARDS FOR WATER DISTRIBUTION SYSTEMS (UDACS) PLATE No. 40
11	8" CAP W/ 2" BLOW-OFF PER (UDACS) PLATE No. 36
12	INSTALL IRRIGATION SLEEVES 1-6" AND 2-4" SCH. 40 PVC (SEE DETAIL 25 ON SHEET D-1)
13	INSTALL STEEL CASING PER UDACS PLATE 22 & 23
14	* ALL WATER MAIN IN CASING TO BE DIP
15	INSTALL 16" C905 PUBLIC WATER MAIN
16	INSTALL 16" DIP PUBLIC WATER MAIN
17	INSTALL 16" CLASS 53 DIP PUBLIC WATER MAIN
18	INSTALL 16" - 5' BEND W/ RESTRAINED JOINTS ON EACH END
19	INSTALL 16" - 11.25' BEND
20	INSTALL 16" - 22.5' BEND
21	INSTALL 16" - 45' BEND
22	INSTALL 16" - 90' BEND
23	INSTALL 16" X 8" REDUCER
24	CONSTRUCT CLASS 1 CLSM TRENCH BACKFILL PER UDACS PLATE 16 AND 19
25	INSTALL 16" GATE VALVE. VALVES SHALL NOT BE LOCATED IN STREET VALLEY GUTTERS OR WITHIN THE PROPOSED CURB & GUTTER LOCATIONS. UDACS PLATE 30 & 39
26	INSTALL TYPE "C" TEST STATION WITHOUT ANODE PER DETAIL 1 ON SHEET D-2A
27	INSTALL 4" COMBINATION AIR VALVE PER UDACS PLATE 38
28	INSTALL 6" PVC PUBLIC WATER MAIN
29	INSTALL 8" X 6" REDUCER UDACS PLATE 30
30	INSTALL 16" X 8" TEE
31	INSTALL 8" - 90' BEND UDACS PLATE 31
32	16" CAP W/ 2" BLOW-OFF PER (UDACS) PLATE No. 36
33	INSTALL 8"x6" TEE
34	INSTALL 16"x6" TEE
35	INSTALL 6" MANUAL BLOW-OFF ASSEMBLY PER UDACS PLATE No. 37

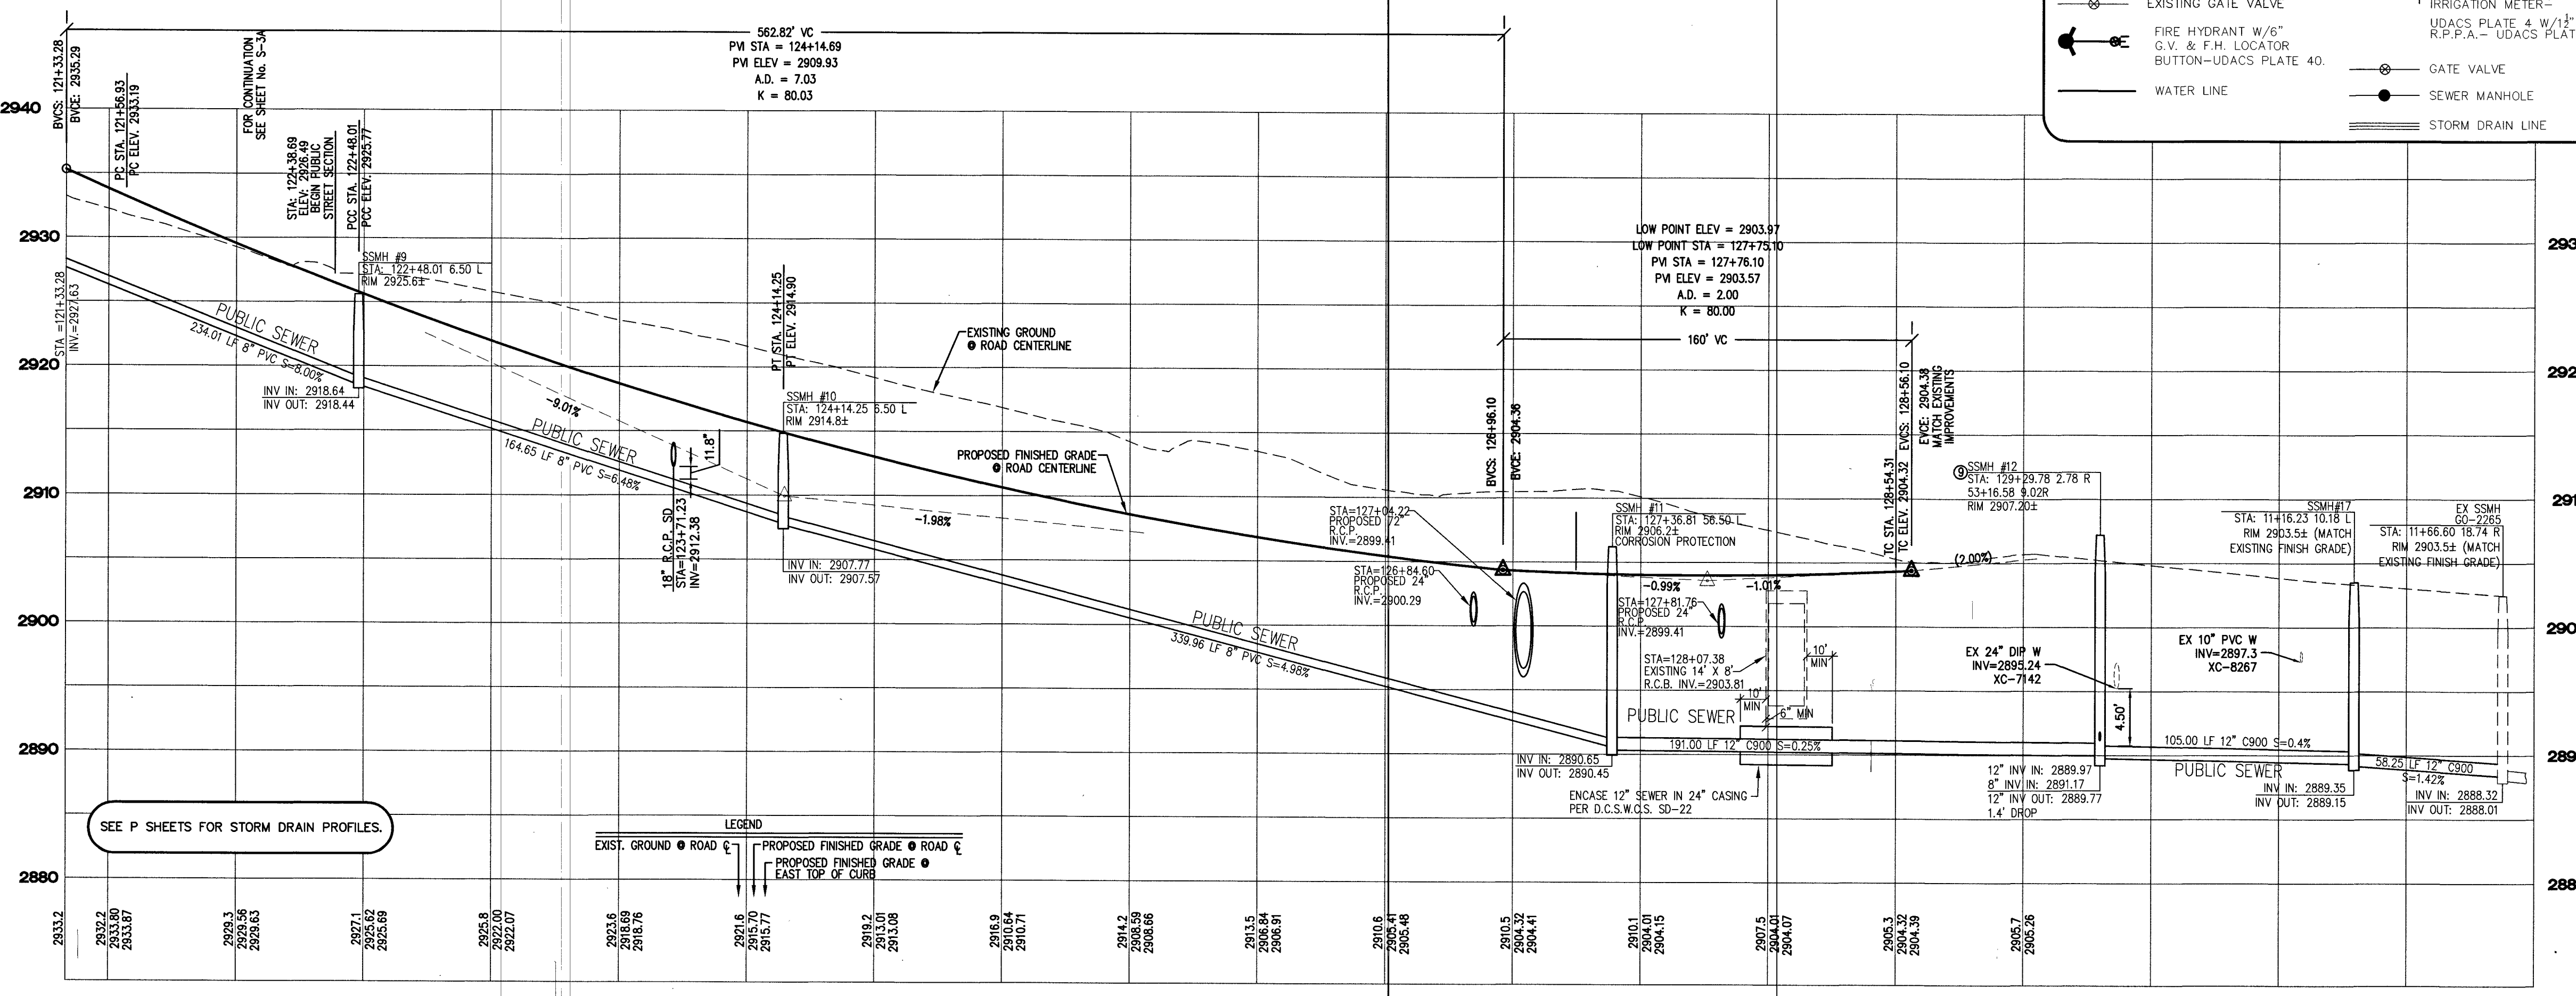

H# 18839 CLV DWG# 1074 4950-AR

PROJECT NO. 764-204-013
DESIGNER GCV
DRAWN HN
CHECK WP
PLOT DATE 10-31-16
PLOT TIME 13:49:09
DESCRIPTION

1555 S. RAINBOW BLVD.
LAS VEGAS, NV 89146
T: 702.804.2000
F: 702.804.2299
gcvengineering.com

ENGINEERS & SURVEYORS

DESERT HOPE DRIVE - ACCESS ROAD - (AKA REVERENCE PARKWAY)
REVERENCE VILLAGE 26

PULTE HOMES

WATER PLAN/SEWER PLAN AND PROFILE

REVERENCE PARKWAY

DRAWING
S-4A
17A OF 26 SHTS