



IMPROVEMENT PLANS FOR SUMMERLIN VILLAGE 24 DORAL ACADEMY SUMMERLIN CAMPUS

581 SKY VISTA DRIVE
STONEBRIDGE UNIT 2

APN: 137-34-219-001
LAS VEGAS, NEVADA 89138

DRAWING INDEX

NO.	DWG	DESCRIPTION
1	C1.1	COVER SHEET
2	C1.2	PROJECT DATA
3	C1.3	GENERAL NOTES
4	C3.1	HORIZONTAL CONTROL PLAN I
5	C3.2	HORIZONTAL CONTROL PLAN II
6	C3.3	HORIZONTAL CONTROL PLAN III
7	C3.4	HORIZONTAL CONTROL PLAN IV
8	C3.5	HORIZONTAL CONTROL PLAN V
9	C3.6	HORIZONTAL CONTROL CURB TABLES
10	C3.7	FIRE ACCESS PLAN
11	C4.1	GRADING PLAN I
12	C4.2	GRADING PLAN II
13	C4.3	GRADING PLAN III
14	C4.4	GRADING PLAN IV
15	C4.5	GRADING PLAN V
16	C4.6	GRADING PROFILE - STORMDRAIN 1
17	C4.7	GRADING PROFILE - STORMDRAIN 2
18	C5.1	UTILITY PLAN I
19	C5.2	UTILITY PLAN II
20	C5.3	UTILITY PLAN III
21	C5.4	UTILITY PLAN IV
22	C5.5	UTILITY PLAN V
23	C5.6	UTILITY PLAN VI
24	C5.7	UTILITY PLAN VII
25	C6.1	WALL PLAN I
26	C6.2	WALL PLAN II
27	C6.3	WALL PLAN III
28	C7.1	SIGNAGE PLAN I
29	C7.2	SIGNAGE PLAN II
30	C7.3	SIGNAGE PLAN III
31	C7.4	SIGNAGE PLAN IV
32	C7.5	SIGNAGE PLAN V
33	C8.1	DETAIL SHEET I
34	C8.2	DETAIL SHEET II
35	C8.3	DETAIL SHEET III

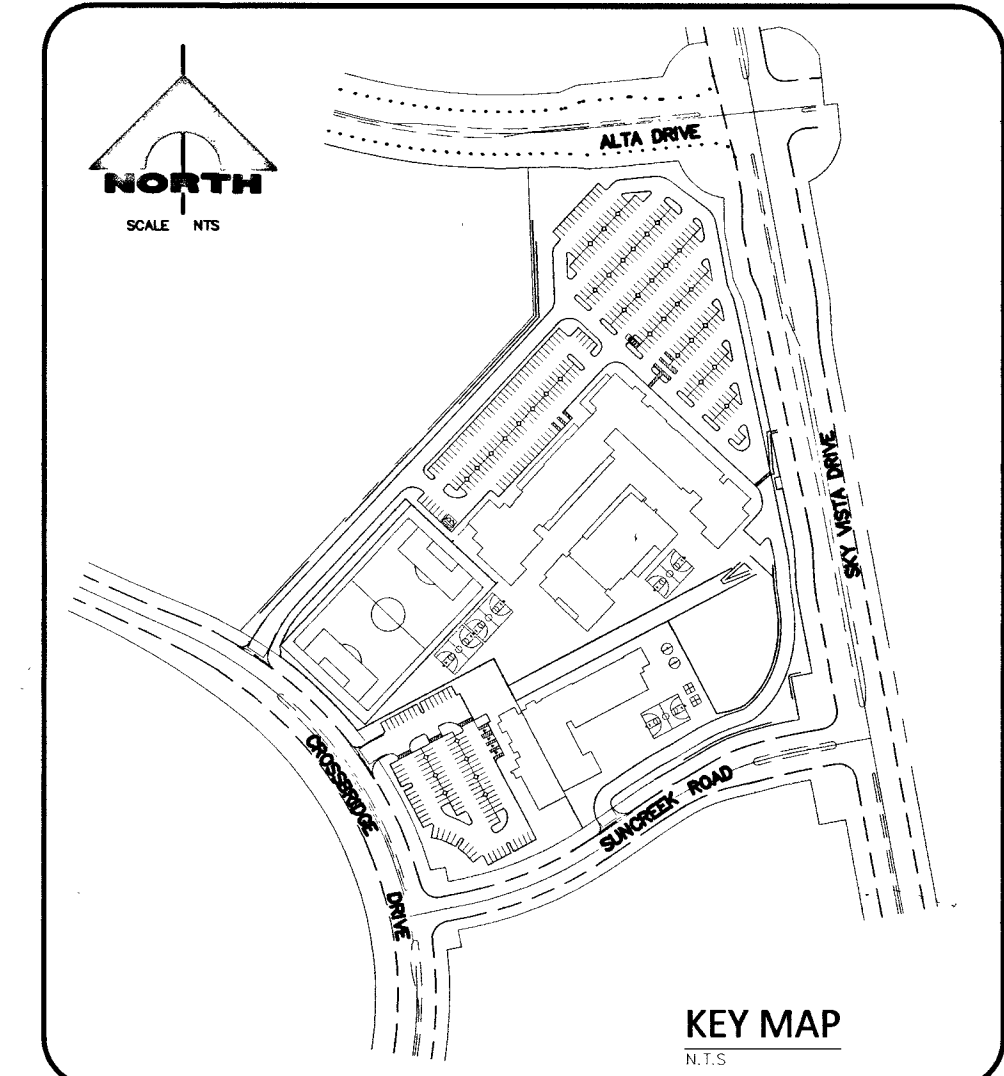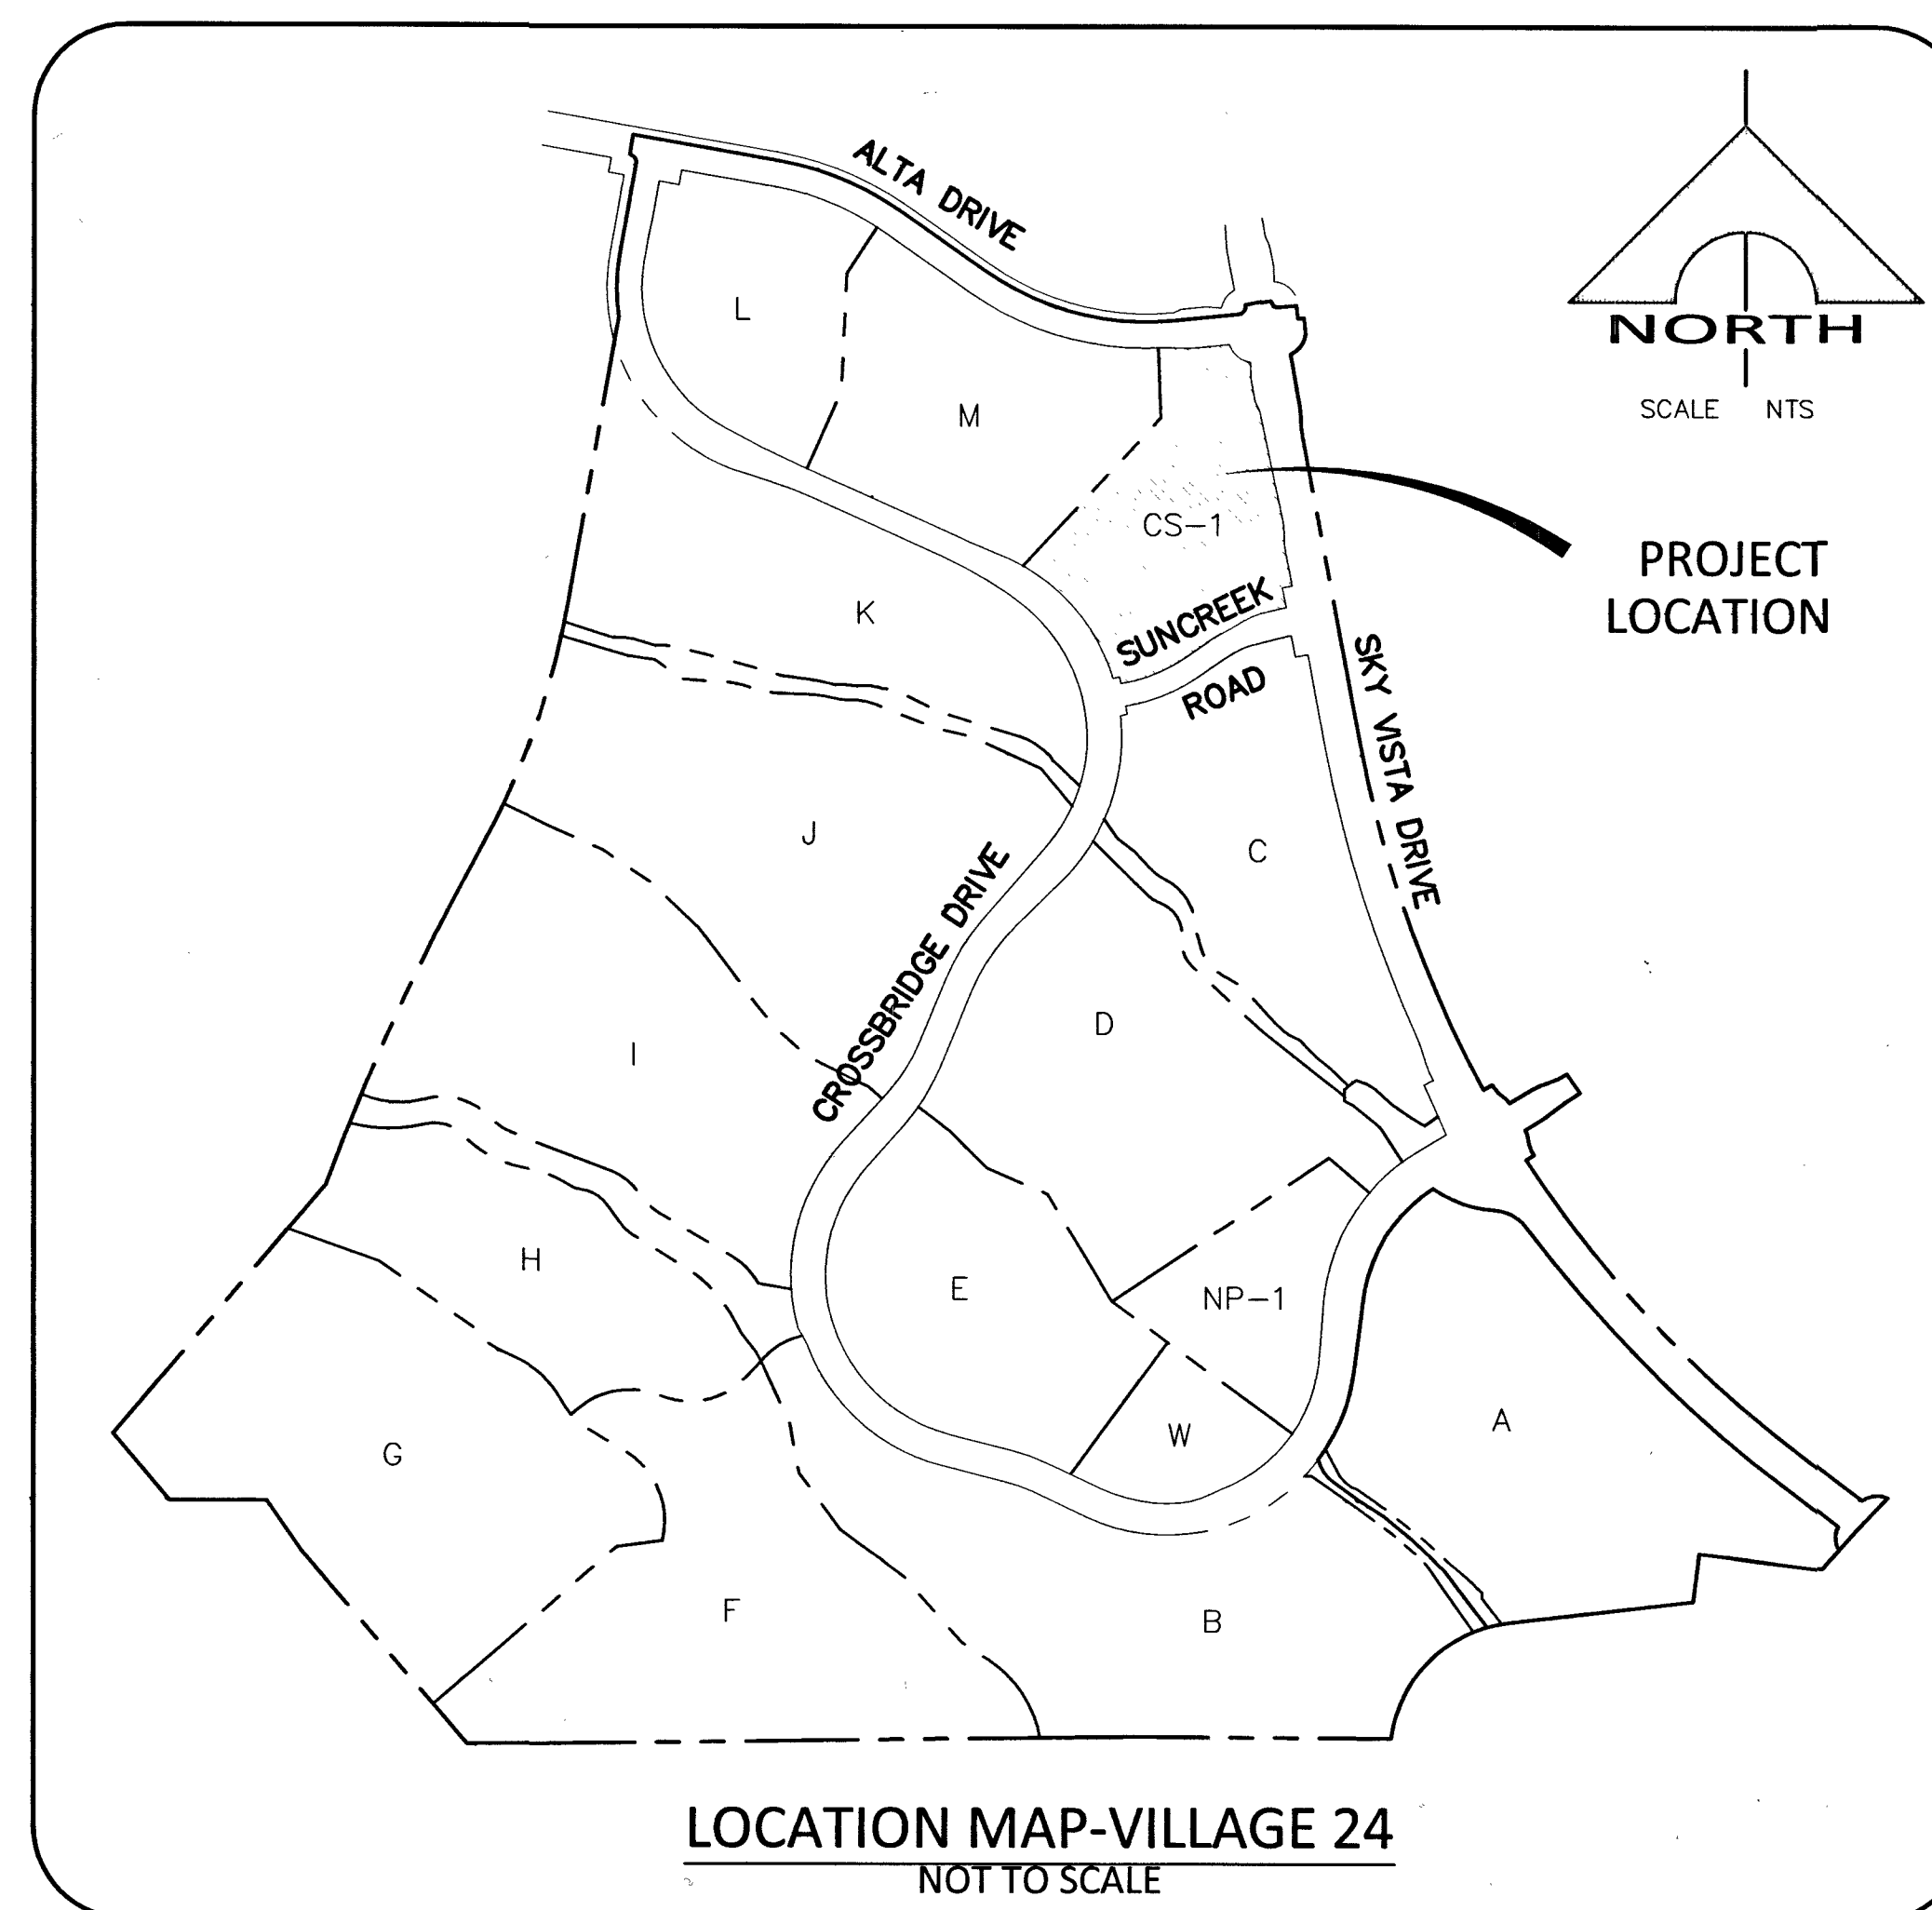

REV#	REV. DESCRIPTION	SHEET(S) APPD BY	DATE

APPROVALS

APPROVAL OF THESE PLANS IS LIMITED TO THOSE IMPROVEMENTS CONSTRUCTED IN THE DEDICATED RIGHTS-OF-WAY AND/OR DEDICATED EASEMENTS. THIS APPROVAL DOES NOT AUTHORIZE THE CONSTRUCTION OF ANY IMPROVEMENTS THAT DEVIATE FROM ADOPTED STANDARDS AND/OR SPECIFICATIONS, EXCEPT THOSE SPECIFICALLY LISTED UNDER "DEVIATIONS FROM STANDARDS". THE ENGINEER SHALL RESOLVE ANY DEVIATION OTHER THAN THOSE LISTED IN "DEVIATIONS FROM STANDARDS" IN FAVOR OF THE UNIFORM STANDARD DRAWINGS AND SPECIFICATIONS CLARK COUNTY AREA NEVADA.

Kristina Summala 1/27/16
ALLEN PAVELKA: PE # 9029 KRISTINA SUMMALA DATE
CITY ENGINEER

R. Gill 12/21/15
LAS VEGAS FIRE & RESCUE DATE

Chris Knight 1-27-15
CHRIS KNIGHT, DIRECTOR, BUILDING AND SAFETY DATE
THIS PLAN CONFORMS TO THE APPLICABLE STANDARDS OF THE PLANNING DEPARTMENT.

UTILITY/AGENCY APPROVALS

Angie B... 12/15/15
COK COMMUNICATIONS LAS VEGAS, INC. DATE

THE AFFIXED CENTURYLINK APPROVAL DOES NOT ASSUME OR GUARANTEE LIABILITY FOR KNOWN OR UNKNOWN CONFLICTS WITH EXISTING OR PROPOSED IMPROVEMENTS. RESOLUTION OF ANY CONFLICT WILL BE ACCOMPLISHED PURSUANT TO LOCAL ORDINANCES, NEVADA REVISED STATUTES AND/OR PUBLIC UTILITY COMMISSION RULES AND REGULATIONS.

Michael Summa 12/15/15
CENTRAL TELEPHONE CO., DBA CENTURYLINK DATE

NV ENERGY ACKNOWLEDGES THAT WE HAVE RECEIVED YOUR PLANS AND WILL PROVIDE SERVICE TO ALL ELECTRICAL NEEDS ASSOCIATED WITH THIS PROJECT. NV ENERGY RESERVES THE RIGHT TO ADDRESS ANY EXISTING OR FUTURE CONFLICTS ONCE THE FINAL DESIGN IS COMPLETED. THE NEW SERVICE AND THE RESOLUTION OF ANY CONFLICTS WILL BE ACCOMPLISHED PURSUANT TO THE NEVADA PUBLIC UTILITY COMMISSION'S RULES AND REGULATIONS.

Patricia Gray 12/15/15
NV ENERGY DATE
Carla... 01-04-16
SOUTHWEST GAS CORP. DATE

BASIS OF BEARINGS

NORTH 05°38'32" WEST BEING THE BEARING OF THE WEST LINE OF THE NORTHWEST QUARTER (NW 1/4) OF SECTION 33, TOWNSHIP 20 SOUTH, RANGE 59 EAST, M.D.M. AS SHOWN IN BOOK 149, PAGE 46 PLATS ON FILE AT THE CLARK COUNTY, NEVADA RECORDER'S OFFICE.

BENCHMARK

DESCRIPTION	NAVD 88 DATUM	NAVD 88 DATUM
CITY OF LAS VEGAS VERTICAL CONTROL POINT "D368", BEING A US&GS DISC SET IN ROCK SOUTH OF CHARLESTON BLVD & WEST OF DEENTON BASIN.	3246.63 (FEET)	989.574 (METERS)
CITY OF LAS VEGAS VERTICAL CONTROL 2008 AND ADJUSTMENT (UPDATED 05/24/2010) BASED ON NORTH AMERICAN VERTICAL DATUM OF 1988 (NAVD'88).		

NOTE: THIS PROJECT PLAN APPROVAL CONTINGENT ON 123547 VILLAGE 24 CROSSBRIDGE DRIVE UNIT 2 IMPROVEMENT PLAN APPROVAL

LEGAL DESCRIPTION

LOT CS-1 PER BK 149, PAGE 46 OF PLATS ON FILE AT CLARK COUNTY NEVADA RECORDS OFFICE.

APPROVED FOR CONSTRUCTION

Y. J. SHARIF 12/16/16
LAS VEGAS VALLEY WATER DISTRICT ENGINEERING SERVICES MANAGER
PROJECT NO. 124110 DATE: 12/16/16
LVVWD APPROVED FIRE FLOW 4000 GPM AT 20 PSI RESIDUAL
SHEETS: C1.1, C1.2, C1.3, & C5.1 THRU C5.7

LVVWD NOTE:

LVVWD PROJECT: 124110
HGL REQUEST: OCTOBER 1, 2015
HGL RESPONSE: OCTOBER 12, 2015
WATER NETWORK ANALYSIS APPROVED: DECEMBER 1, 2014

DRAINAGE CERTIFICATION

I CERTIFY THAT THE GRADING PLANS ARE IN CONFORMANCE WITH THE APPROVED DRAINAGE STUDY DS-4755A ON FILE AT THE CITY OF LAS VEGAS FOR THIS PROJECT.


Paul Fritz 12-21-15
PAUL F. FRITZ P.E. 16825 DATE

OWNER/DEVELOPER

CA LV SVD LLC
3000 OLYMPIC BLVD, BLDG. 1 STE 2120
SANTA MONICA, CA. 90404
CONTACT: BARI COOPER SHERMAN
OFFICE PHONE NO. 310-752-9634

SUMMERLIN DESIGN REVIEW COMMITTEE

Julie Cleave 12-21-15
JULIE CLEAVE
VICE PRESIDENT PLANNING & DESIGN DATE

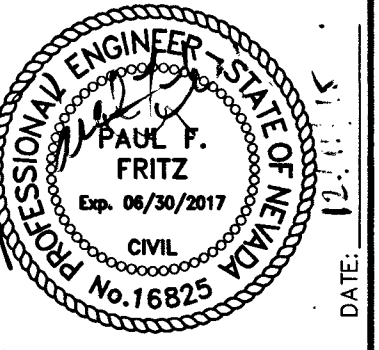

DATE	REV	DESCRIPTION
12/15/15	1	
12/15/15	2	
12/15/15	3	
12/15/15	4	
12/15/15	5	
12/15/15	6	
12/15/15	7	
12/15/15	8	
12/15/15	9	
12/15/15	10	
12/15/15	11	
12/15/15	12	
12/15/15	13	
12/15/15	14	
12/15/15	15	
12/15/15	16	
12/15/15	17	
12/15/15	18	
12/15/15	19	
12/15/15	20	
12/15/15	21	
12/15/15	22	
12/15/15	23	
12/15/15	24	
12/15/15	25	
12/15/15	26	
12/15/15	27	
12/15/15	28	
12/15/15	29	
12/15/15	30	
12/15/15	31	
12/15/15	32	
12/15/15	33	
12/15/15	34	
12/15/15	35	

PROJECT NO. 889-002
DESIGN: 889-002
DRAWN: 889-002
CHECK: 889-002
PLOT DATE: 12-10-15
PLOT TIME: 11:02:39

1555 S. RAINBOW BLVD.
LAS VEGAS, NV 89146
T: 702.804.2000
F: 702.804.2299
gocv.com
ENGINEERS & SURVEYORS

CA LAS VEGAS SVD, LLC
DORAL ACADEMY SUMMERLIN CAMPUS
COVER SHEET

DRAWING
C1.1
1 OF 35 SHTS

H# 62408 715-186

H: 62408

CLV: 00-00000