


DESERT GYMCA TS

PROPOSED GYMNASTICS FACILITY

8200 W. SAHARA AVENUE, LAS VEGAS, NEVADA 89117
APN: 163-04-418-002 PROJECT 402-15-001

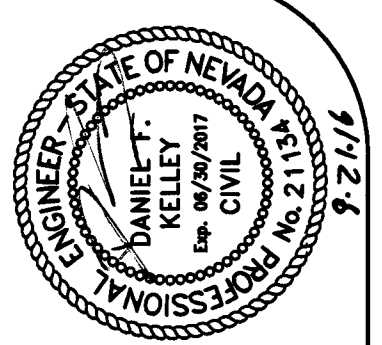

2/16/16	2 - ADDED SWG PLANS	9/27/16	DATE
DATE	REVISIONS AND RECORD OF ISSUE	NO.	BY
DATE	AGENCY DESIGNATION:	NO.	BY



S&B CHRIST CONSULTING, LLC
OFFICE: 1002 200-0004
LAS VEGAS, NV 89103
S&B CHRIST CONSULTING, LLC

DESERT GYMCA TS
PROJECT NO: 402-15-001
COVER SHEET

DESIGNED: HF
DETAILED: HF
CHECKED: DK
APPROVED: DK
DATE: September 2016
IF THIS BAR DOES NOT MEASURE 1" THEN DRAWING IS NOT TO FULL SCALE
HANSSEN NO. 65920
107 ✓ 6746
SHEET 1 OF 17
G1

PROJ: 124537 AGRI: 116031 QS: 163-04-SW

NO. SHEET	SHEET TITLE
1	G1 COVER SHEET
2	G2 ABBREVIATIONS AND LEGEND
3	G3 GENERAL NOTES 1
4	G4 GENERAL NOTES 2
5	G5 SITE PLAN
6	SP1 GEOMETRIC CONTROL I
7	SP2 GEOMETRIC CONTROL II
8	C1 GRADING PLAN
9	C2 RETAINING WALL DETAILS
10	C3 DEMOLITION PLAN
11	C4 STRIPING PLAN
12	C5 ADA ACCESSIBLE PATH
13	C6 UTILITY PLAN
14	CD1 CIVIL DETAILS 1
15	CD2 CIVIL DETAILS 2
16	CD3 CIVIL DETAILS 3
17	CD4 CIVIL DETAILS 4
18	SWG PLANS

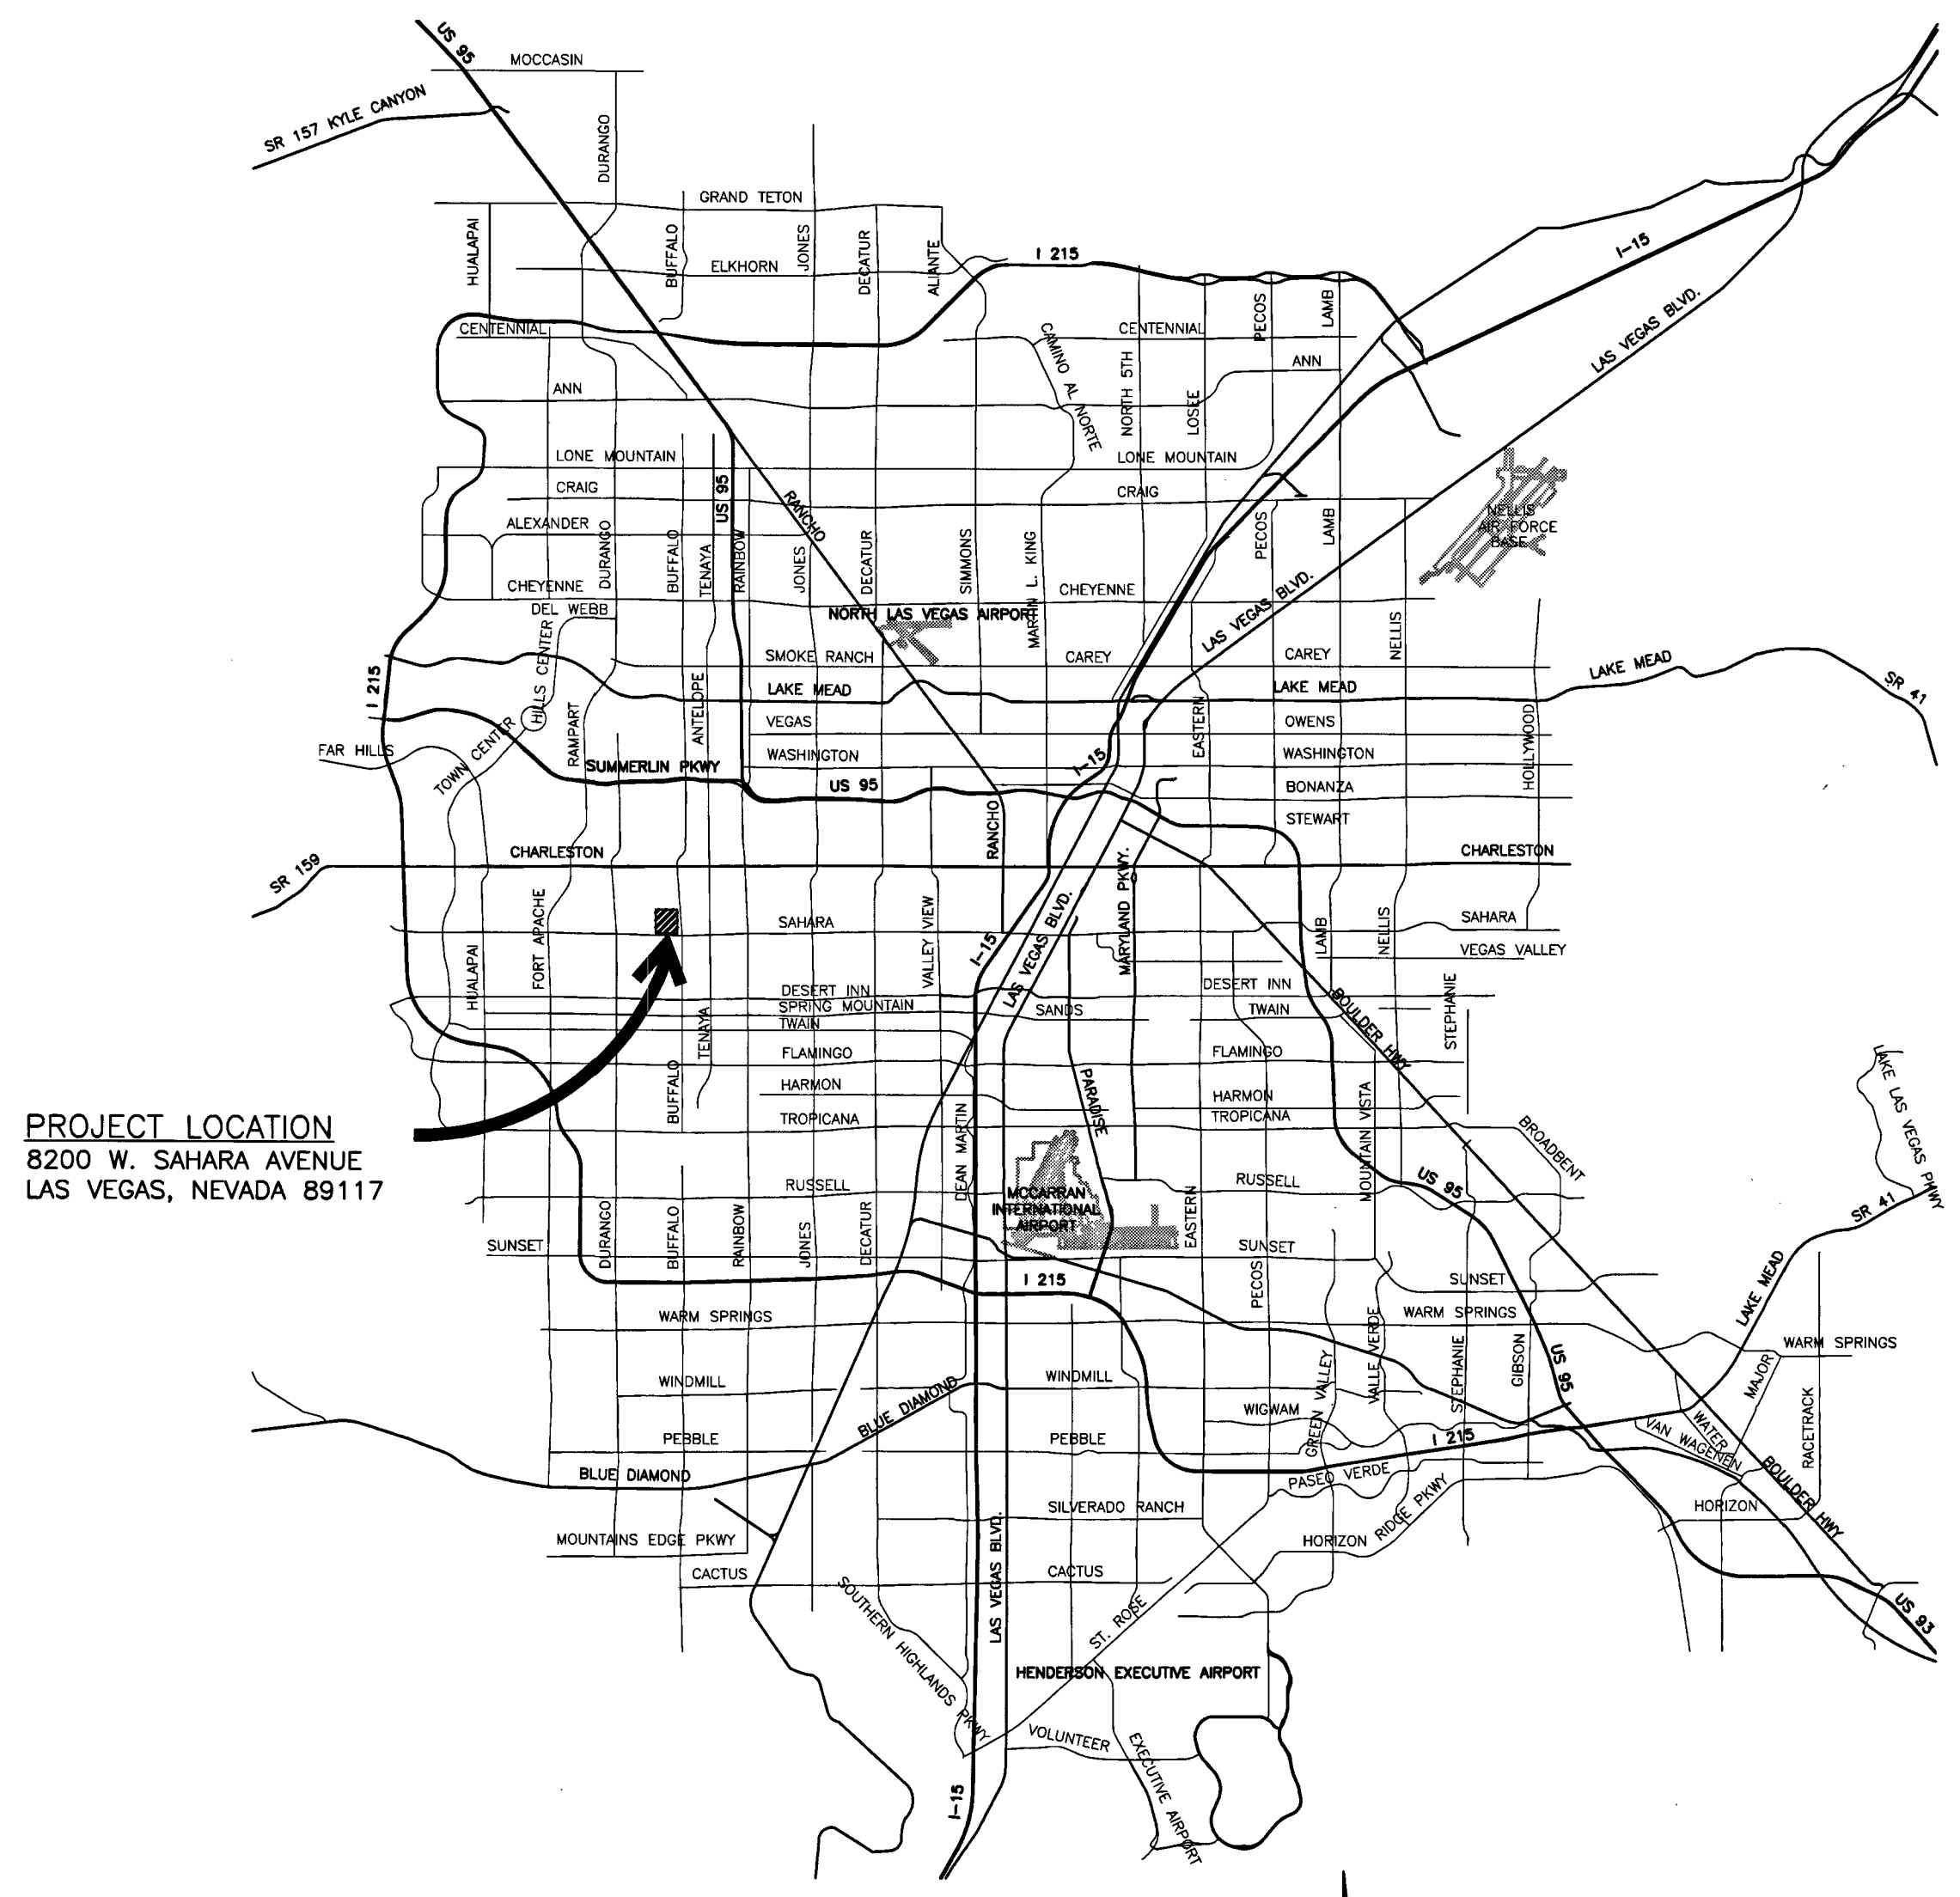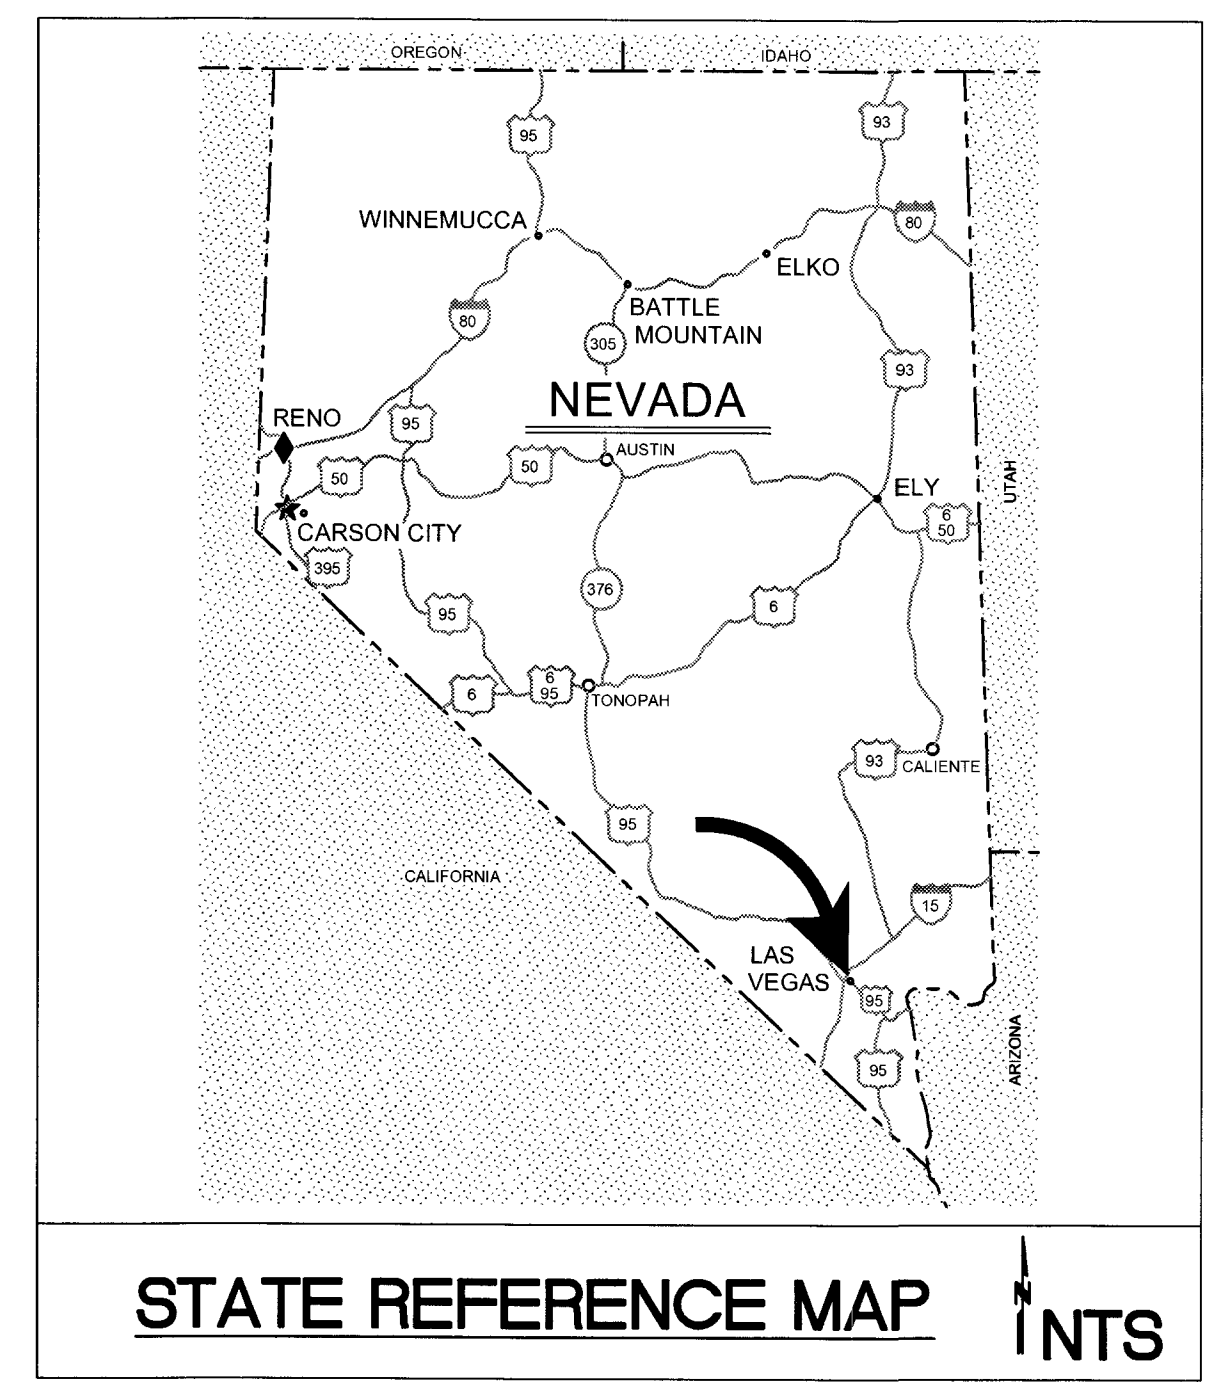

PROJECT LOCATION
8200 W. SAHARA AVENUE
LAS VEGAS, NEVADA 89117

VICINITY MAP
NOT TO SCALE

Pamela Kennedy
SOUTHWEST GAS CORPORATION
DATE 9-22-16

Cox Communications Las Vegas, Inc.
DATE 9/27/16

NV ENERGY - DISTRIBUTION
DATE 9-22-16

NEVADA POWER COMPANY ACKNOWLEDGES THAT WE HAVE RECEIVED YOUR PLANS AND WILL PROVIDE SERVICE TO ALL ELECTRICAL NEEDS ASSOCIATED WITH THIS PROJECT. NEVADA POWER COMPANY RESERVES THE RIGHT TO ADDRESS ANY EXISTING OR FUTURE CONFLICTS ONCE THE FINAL DESIGN IS COMPLETED. THE NEW SERVICE AND THE RESOLUTION OF ANY CONFLICTS WILL BE ACCOMPLISHED PURSUANT TO THE NEVADA PUBLIC UTILITY COMMISSION'S RULES AND REGULATIONS.

DIANE M. SCHORR
CENTRAL TELEPHONE COMPANY D/B/A CENTURYLINK
DATE 9-23-16

THE AFFIXED CENTURYLINK NEVADA APPROVAL DOES NOT ASSUME OR GUARANTEE LIABILITY FOR KNOWN OR UNKNOWN CONFLICTS WITH EXISTING OR PROPOSED IMPROVEMENTS. RESOLUTION OF ANY CONFLICT WILL BE ACCOMPLISHED PURSUANT TO LOCAL ORDINANCES, NEVADA REVISED STATUTES AND/OR PUBLIC UTILITY COMMISSION STANDARD REGULATIONS.

4. DISHAJI
LAS VEGAS VALLEY WATER DISTRICT ENGINEERING SERVICES MANAGER
PROJECT # 124537
SHEETS G1, G2, G4, G5, C3, C6
DATE 10/24/16


Chris Knight
CHRIS KNIGHT, DIRECTOR
BUILDING AND SAFETY DEPARTMENT
DATE 11-15-16

THIS PLANS MEETS THE APPLICABLE STANDARDS OF THE PLANNING DEPARTMENT

92 mik
CITY OF LAS VEGAS FIRE DEPARTMENT
DATE 10/10/16

Allen Pavelka
CITY ENGINEER - ALLEN PAVELKA PE, #9029
DATE 11/17/16

APPROVAL OF THESE PLANS BY THE CITY ENGINEER IS LIMITED TO THOSE IMPROVEMENTS CONSTRUCTED IN THE DEDICATED OF RIGHT-OF-WAY AND/OR DEDICATED EASEMENTS. THIS APPROVAL DOES NOT AUTHORIZE CONSTRUCTION OF ANY IMPROVEMENTS THAT DEVIATE FROM ADOPTED STANDARDS AND/OR SPECIFICATIONS, EXCEPT THOSE SPECIFICALLY LISTED UNDER DEVIATING FROM STANDARD. THE ENGINEER SHALL RESOLVE ANY DEVIATION OTHER THAN THOSE LISTED IN DEVIATIONS FROM STANDARDS IN FAVOR OF THE UNIFORM STANDARDS DRAWINGS AND SPECIFICATIONS CLARK COUNTY AREA, NEVADA.

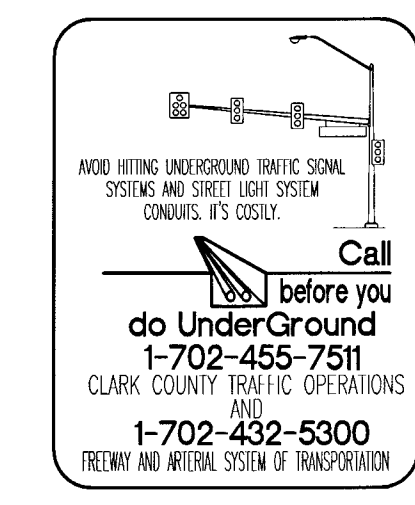

ALWAYS THINK
SAFETY