

1. ALL CONSTRUCTION AND MATERIALS SHALL BE IN ACCORDANCE WITH THE "UNIFORM STANDARD SPECIFICATIONS FOR PUBLIC WORKS CONSTRUCTION OFF-SITE IMPROVEMENTS, CONSTRUCTION (CITY OF LAS VEGAS, NEVADA)", LATEST EDITION, THE "UNIFORM STANDARD DRAWINGS FOR PUBLIC WORKS CONSTRUCTION, CITY OF LAS VEGAS, NEVADA", LATEST EDITION, REVISED EDITION, THE "SUMMERLIN AGREEMENT STANDARDS FOR WORK IN THE SUMMERLIN AREA", AND OTHER APPLICABLE APPROVED STANDARD SPECIFICATIONS ISSUED BY THE CONTROLLING AGENCY. THE USER SHALL BE RESPONSIBLE FOR VERIFYING THE APPLICABILITY OF ANY SPECIFICATION APPLICABLE, EXCEPT AS NOTED ON THIS SHEET AS "DEVIATIONS FROM STANDARDS".

2. THE EXISTENCE AND LOCATION OF ANY OVERHEAD OR UNDERGROUND UTILITY LINES, PIPES, OR STRUCTURES SHOWN ON THESE PLANS ARE OBTAINED BY A RESEARCH OF THE AVAILABLE RECORDS. EXISTING UTILITIES AS SHOWN FROM CLV PLANS LIBRARY ARE APPROXIMATE AND FOR RECORD PURPOSES. EXISTING UTILITIES ARE LOCATED ON PLANS BY THE CITY ENGINEER AND CONSTRUCTION OF THIS CONTRACT ARE EXTENSIVE. LATER, DETECTED UTILITIES MAY NOT BE SHOWN ON THE PLANS. THE CONTRACTOR SHALL, AT HIS OWN EXPENSE, LOCATE ALL UNDERGROUND AND OVERHEAD INTERFERENCES WHICH MAY AFFECT HIS CONSTRUCTION. THE CONTRACTOR SHALL BE RESPONSIBLE FOR TAKING THE NECESSARY PRECAUTIONS TO AVOID DAMAGE TO SAME. THE CONTRACTOR SHALL USE EXTREME CAUTION WHEN WORKING NEAR OVERHEAD UTILITIES SO AS TO SAFELY PROTECT ALL PERSONNEL AND EQUIPMENT, AND SHALL BE RESPONSIBLE FOR ALL COST AND LIABILITY IN CONNECTION THEREWITH.

3. THE CONTRACTOR SHALL TAKE ALL PRECAUTIONARY MEASURES NECESSARY TO PROTECT EXISTING UTILITY LINES, STRUCTURES AND STREET IMPROVEMENTS WHICH ARE TO REMAIN IN PLACE. FROM DAMAGE, AND ALL SUCH IMPROVEMENTS OR STRUCTURES DAMAGED BY THE CONTRACTOR'S OPERATIONS SHALL BE REPAIRED OR REPLACED SATISFACTORILY TO THE CITY ENGINEER AND SHALL BE SHOWN ON THESE PLANS AT THE EXPENSE OF THE CONTRACTOR.

4. ALL CONSTRUCTION SHALL BE IN ACCORDANCE WITH THESE PLANS, ANY REVISIONS SHALL HAVE THE CITY ENGINEER'S WRITTEN APPROVAL. CITY ENGINEER'S NO. _____

5. TYPE V CONCRENT SHALL BE USED IN ALL OFF-SITE CONCRETE WORK. CONCRETE TO BE 3000 P.S.I. MINIMUM @ 28 DAYS. MIX DESIGNS TO BE APPROVED BY THE CITY, PRIOR TO THE USE ON THE PROJECT.

6. PERMITS ARE REQUIRED FOR ANY WORK IN THE PUBLIC RIGHT-OF-WAY. THE CONTRACTOR SHALL OBTAIN ALL PERMITS AND INSPECTIONS REQUIRED FOR THIS CONSTRUCTION.

7. EXPANSION JOINTS REQUIRED, MAXIMUM EVERY 300' IN EXTRUDED-TYPE CURB.

8. AC PAVEMENT TO BE ONE-HALF INCH (1/2") ABOVE TOP OF ALL GUTTERS AFTER COMPACTION. EXCEPT AT SIDEWALK RAMPS AND CROSS UPGRADES.

9. CURB AND GUTTER FLOW TO BE UNACCEPTABLE TO THE CITY OF LAS VEGAS SHALL BE REMOVED AND REPLACED PER STANDARD DRAWING 216.

10. SIDEWALK RAMPS SHALL BE CONSTRUCTED IN EACH QUADRANT OF AN INTERSECTION PER STANDARD DRAWING 235. EXIST LOCATIONS OF RAMPS MAY BE ADJUSTED IN THE FIELD BY A CITY INSPECTOR.

11. CONTRACTOR SHALL PROVIDE ALL NECESSARY HORIZONTAL AND VERTICAL TRANSITIONS BETWEEN CONSTRUCTION AND EXISTING SURFACES TO PROVIDE FOR PROPER DRAINAGE AND FOR INGRESS AND EGRESS TO NEW CONSTRUCTION. THE EXTENT OF THE TRANSITIONS TO BE AS SHOWN ON PLANS.

12. ALL GRADING WORK SHALL CONFORM TO THE SOILS REPORT AS PREPARED BY WRIGHT ENGINEERS, REPORT #161102, 07/11/2016 APPROVED BY THE CITY ENGINEER, AND AS SHOWN ON THESE PLANS.

13. EXIST LOCATIONS OF ALL SAWCUT LINES MAY BE ADJUSTED OR DETERMINED IN THE FIELD BY THE CITY ENGINEER. EXISTING LOCATIONS OF SAWCUT LINES ARE NOT CLEARLY SHOWN, OR EXISTING PAVEMENT CONDITION REQUIRES RELOCATIONS.

14. THE CONTRACTOR SHALL TAKE ALL PRECAUTIONS NECESSARY TO PROTECT EXISTING PERMANENT SURVEY MONUMENTS. ANY MONUMENTS DISTURBED SHALL BE REPLACED AND ADJUSTED PER AVAILABLE RECORDS IN ACCORDANCE WITH N.E.S. STATUTE NO. 235.360 & CITY OF LAS VEGAS TITLE 16, APPENDIX D.

15. UTILITY COMPANY METER BOXES, MANHOLE LIDS, VALVE COVERS, ETC. SHALL BE LOCATED OUTSIDE OF DRIVEWAYS, DRIVEWAYS, DRIVEWAYS, AND CROSS GUTTERS. UNLESS WRITTEN APPROVAL IS GRANTED BY THE CITY ENGINEER AND THE CITY ENGINEER.

WALL NOTES.

16. ALL WALLS, NEW OR EXISTING, ARE ONLY SHOWN ON CIVIL PLANS FOR THE PURPOSE OF REVEALING GRADING RELATIONSHIPS; FLOOD CONTROL AND SIGHT DISTANCE AT INTERSECTIONS. NEW WALLS REQUIRE A SEPARATE PERMIT AND INSPECTION BY THE BUILDING DEPARTMENT.

17. ASPHALT MIX DESIGN MUST BE SUBMITTED AND APPROVED BY THE CITY ENGINEER PRIOR TO THE PLACEMENT OF ASPHALT WITHIN CITY RIGHT OF WAY.

18. CONTRACTOR SHALL ADJUST ALL NEW AND EXISTING INLETS, VALVE BOXES, MANHOLE RIMS, AND SEWER CLEAN OUTS, ETC. TO FINISH GRADE AS APPLICABLE WHETHER OR NOT THEY ARE SHOWN ON THE PLANS.

19. MATERIALS, HANDLING AND PLACEMENT OF PORTLAND CEMENT CONCRETE SHALL BE IN ACCORDANCE WITH APPLICABLE SECTIONS OF MDOT OR THE CLARK COUNTY AREA SPECIFICATIONS (AS APPLICABLE) AND THE PLANS AND DETAILS SHOWN HEREIN.

20. WHEN INSTALLING UNDERGROUND FACILITIES THAT REQUIRE UNDERGROUND LOCATING BEING DONE SUCH AS MAPPING, THE CONTRACTOR SHALL BE RESPONSIBLE FOR PROVIDING WRITTEN DOCUMENTATION TO OFFSITE INSPECTION AND TESTING CERTIFYING THAT ALL DEVICES HAVE BEEN PLACED AND VERIFIED TO BE IN GOOD WORKING CONDITION PRIOR TO THE CONSTRUCTION. ANY ROAD CLOSURES SHALL BE THE RESPONSIBILITY OF THE CONTRACTOR.

21. SANITARY SEWER AND STORM DRAIN FINAL LOCATION MAP(S) SHALL BE PROVIDED TO THE CITY ENGINEER PRIOR TO THE COMMENCEMENT OF FACILITY VIDEO INSPECTION. THE MAP(S) SHALL INCLUDE THE HORIZONTAL AND VERTICAL (INVERT) LOCATION OF PUBLIC SEWER MANHOLES, STORM DRAIN MANHOLES AND TRANSITION STRUCTURES, STORM DRAIN MANHOLES, AND THE CONNECTION TO THE STORM DRAIN MAIN AND, AT THE CONNECTION TO A DRAIN INLET, THE CONNECTION OF SEWER SERVICE LATERALS TO THE SEWER MAIN AND WHERE THE SEWER SERVICE LATERALS EXIT THE PUBLIC RIGHT-OF-WAY, AND STORM DRAIN MAIN ALIGNMENT, INCLUDING DEFLECTION POINTS. THE LOCATION SHALL BE DETERMINED BY COORDINATING WITH THE CITY ENGINEER. THE OFFICIAL HORIZONTAL AND VERTICAL CONTROL NETWORKS OF THE CITY OF LAS VEGAS. FINAL LOCATION MAPS MUST BE SEALED AND CERTIFIED BY A NEVADA PROFESSIONAL LAND SURVEYOR TO HAVE POSITIVE COORDINATES. THE COORDINATES SHALL BE PROVIDED TO THE CITY ENGINEER. A SEPARATE ELECTRONIC COMMA DELIMITED FILE FOR THE SANITARY SEWER AND STORM DRAIN COORDINATES SHALL ALSO ACCOMPANY THE SANITARY SEWER AND STORM DRAIN FINAL LOCATION MAP(S).

OR

22. SANITARY SEWER AND STORM DRAIN FACILITIES SHOWN ON THESE PLANS SHALL BE USED TO MEET THE REQUIREMENTS OF NRS 465 AND SHALL SHOW AT A MINIMUM THE HORIZONTAL AND VERTICAL LOCATION OF ALL SANITARY SEWER MANHOLES, STORM DRAIN MANHOLES, STORM DRAIN LATERALS, AND THE CONNECTION TO THE SEWER MAIN AND, AT THE CONNECTION TO A DRAIN INLET, THE CONNECTION OF SEWER SERVICE LATERALS EXIT THE PUBLIC RIGHT-OF-WAY, AND STORM DRAIN MAIN ALIGNMENT, INCLUDING DEFLECTION POINTS. THE LOCATION SHALL BE DETERMINED BY COORDINATING WITH THE CITY ENGINEER. THE OFFICIAL HORIZONTAL AND VERTICAL CONTROL NETWORKS OF THE CITY OF LAS VEGAS. FINAL LOCATION MAPS MUST BE SEALED AND CERTIFIED BY A NEVADA PROFESSIONAL LAND SURVEYOR TO HAVE POSITIVE COORDINATES. THE COORDINATES SHALL BE PROVIDED TO THE CITY ENGINEER. A SEPARATE ELECTRONIC COMMA DELIMITED FILE FOR THE SANITARY SEWER AND STORM DRAIN COORDINATES SHALL ALSO ACCOMPANY THE SANITARY SEWER AND STORM DRAIN FINAL LOCATION MAP(S).

23. FACILITY VIDEO INSPECTION IS REQUIRED FOR ALL SEWER AND STORM DRAINS. THE CCTV VIDEO INSPECTIONS NEED TO BE PERFORMED PER THE DESIGN AND CONSTRUCTION STANDARDS FOR WASTEWATER COLLECTION SYSTEMS LATEST ADDITION.

24. A SEPARATE BORING PERMIT IS REQUIRED FOR ALL BORING ACTIVITIES.

LVMDO PROJECT #124837 (REVISED 01/08/2017)

1. NO WORK SHALL BEGIN UNTIL THE WATER PLANS HAVE BEEN APPROVED FOR CONSTRUCTION BY THE LVMDO. FOLLOWING WATER PLAN APPROVAL, NOTICE SHALL BE GIVEN TO THE LVMDO COMMUNICATION SUPPORT CENTER (258-7171) TWO (2) WORKING DAYS PRIOR TO THE START OF CONSTRUCTION. FOR FUTURE INSPECTIONS, NOTICE MUST BE GIVEN BY 2:00 P.M. THE BUSINESS DAY PRIOR TO THE REQUESTED LVMDO INSPECTION. WHEN REQUESTING INSPECTIONS, PLEASE REFER TO THE PROJECT # IDENTIFIED ABOVE.
2. ALL WORK SHALL CONFORM TO LVMDO STANDARD PLATES, DRAWINGS, AND SPECIFICATIONS, AND TO THE 2010 EDITION OF THE UNIFORM DESIGN AND CONSTRUCTION STANDARDS FOR POTABLE WATER SYSTEMS (UDACS). THE LATEST EDITION OF UDACS SHALL SUPERSEDE ANY CONFLICTS CONTAINED IN THE APPROVED DRAWINGS AND/OR SPECIFICATIONS.
3. ALL WORK, EXCEPT AS MODIFIED BY THESE PLANS OR BY NOTE 2 ABOVE, SHALL BE DONE IN ACCORDANCE WITH THE MOST RECENT DRAFT OR EDITION OF THE UNIFORM STANDARD SPECIFICATIONS FOR PUBLIC WORKS CONSTRUCTION OFFSITE IMPROVEMENT, CLARK COUNTY AREA.
4. A SINGLE PIPE MATERIAL SHALL BE USED THROUGHOUT THE PROJECT UNLESS OTHERWISE APPROVED BY THE LVMDO.
5. A SINGLE WATER LATERALS TWO (2) INCHES IN DIAMETER AND SMALLER SHALL BE TYPE K COPPER TUBING WITH LVMDO APPROVED SEWER SADDLES.
6. ALL WATER METER BOXES SHALL BE LOCATED OUTSIDE OF DRIVEWAY AREAS.
7. ALL VALVES SHALL BE LOCATED OUTSIDE OF DRIVEWAYS, VALLEY AND CURB CUTTERS.
8. ALL WATER AND STORM DRAIN OR SANITARY SEWER CROSSINGS SHALL CONFORM TO SECTION 2.22 OF THE 2010 EDITION OF THE UDACS.
9. ALL WATER FACILITIES SHALL BE FILLED, DISINPECTED, PRESSURE TESTED, FLUSHED, FILLED, AND AN ACCEPTABLE WATER SAMPLE OBTAINED, PRIOR TO CONNECTION TO THE LVMDO DISTRIBUTION SYSTEM.
10. THE CONTRACTOR MUST OBTAIN ALL METERS TWO (2) INCHES AND SMALLER FROM LVMDO CENTRAL STORES. TELEPHONE 258-3152 OR 258-3802, TWO (2) WORKING DAYS PRIOR TO METER PICKUP.
11. ANY INTERRUPTION OF SERVICE MUST BE PERFORMED IN ACCORDANCE WITH UDACS SECTION 3.14.01, AND APPROVED BY THE LVMDO INSPECTION DIVISION PRIOR TO SHUTDOWN. PROPER WRITTEN NOTIFICATION MUST BE GIVEN TO ALL AFFECTED CUSTOMERS.
12. ALL WATER FACILITY CONSTRUCTION MATERIALS USED MUST BE AS LISTED ON THE LVMDO PRE-APPROVED MATERIALS AND MANUFACTURER'S LISTING FOR NEW FACILITIES. LATEST REVISION, OR SPECIFICALLY APPROVED ON THESE PLANS.
13. TELEPHONE "CALL BEFORE YOU DIG" AT "811" OR 1-800-227-2600.
14. THE INSTALLATION OF LAS VEGAS VALLEY WATER DISTRICT (LVMDO) MUNICIPAL WATER FACILITIES WITHIN ANY STREET IS ASSUMED TO BE IN COMPLIANCE WITH THE UNIFORM STANDARDS, INCLUDING THE PLACEMENT OF ASPHALT PATCH. IF ANY STREET IS DISTURBED BY THE LVMDO DURING THE LVMDO TO THE MUNICIPAL WATER FACILITIES WILL INCLUDE THE PLACEMENT OF AN APPROPRIATELY SIZED ASPHALT REPAIR PATCH ON THE STREET SURFACE.

ANY DECORATIVE PAVING SURFACE WITHIN THE STREET IS THE RESPONSIBILITY OF THE OWNER'S ASSOCIATION, OR THE INDIVIDUAL PROPERTY OWNERS IF NO OWNER'S ASSOCIATION IS IN EXISTENCE, OR THE AGENCY HAVING JURISDICTION. DECORATIVE SURFACE MATERIALS PLACED WITHIN THE TEN FOOT EASEMENT ADJUTING A PUBLIC RIGHT-OF-WAY STREET SHALL BE REPLACED BY THE LVMDO. ANY REPAIR WORK DONE BY THE LVMDO TO THE MUNICIPAL WATER FACILITIES WILL BE REPLACED BY LVMDO WITH AN APPROPRIATELY SIZED PLANK FINISH REPAIR PATCH. THE LVMDO WILL NOT RESTORE, AND WILL NOT BE RESPONSIBLE FOR THE RESTORATION OF, ANY DECORATIVE PAVING SURFACE WITHIN THE STREET. THE LVMDO WILL NOT ATTEMPT TO MATCH COLOR OR FINISH OF ANY ADJACENT MATERIALS.

15. NO LEAD COMPLIANCE NOTE:
TO BE IN ACCORD WITH THE FEDERAL SAFE DRINKING WATER ACT, ALL WATER WORK BRASS PRODUCTS PROPOSED TO BE RELOCATED, OR INSTALLED AS NEW MUST BE INSTALLED WITH THE LEAD FREE APPROVED PRODUCT. THE OLD LEADED PRODUCT MAY NOT BE USED.

1. ALL PERMANENT TRAFFIC CONTROL DEVICES CALLED FOR HEREON SHALL BE IN PLACE AND IN FINAL POSITION PRIOR TO ALLOWING ANY PUBLIC TRAFFIC ONTO THE PORTIONS OF THE ROAD(S) BEING IMPROVED HEREUNDER. REGARDLESS OF THE STATUS OF COMPLETION OF PAVING OR OTHER OFF-SITE IMPROVEMENTS CALLED FOR BY THESE PLANS.
2. BEFORE ANY WORK IS STARTED IN THE RIGHT-OF-WAY, THE CONTRACTOR SHALL INSTALL ALL ADVANCE WARNING SIGNS FOR THE CONSTRUCTION ZONE. THE CONTRACTOR SHALL INSTALL TEMPORARY GRADUATED STOP SIGNS AT ALL NEW STREET ENCROACHMENTS INTO EXISTING COUNTY STREETS IMMEDIATELY AFTER FIRST GRADING WORK IS ACCOMPLISHED AND SHALL MAINTAIN SAID SIGNS UNTIL PERMANENT SIGNS ARE INSTALLED.
3. ALL CONSTRUCTION SIGNING, BARRICADES AND PAVEMENT MARKINGS SHALL CONFORM TO THE NEVADA WORK ZONE TRAFFIC CONTROL HANDBOOK - 1986 AND TO THE MANUAL ON UNIFORM TRAFFIC CONTROL DEVICES CURRENT EDITION.
4. IF THE IMPROVEMENTS NECESSITATE THE OBLITERATION, TEMPORARY OBSTRUCTION, TEMPORARY REMOVAL, OR REPLACEMENT OF ANY EXISTING TRAFFIC PAVEMENT MARKING, SUCH PAVEMENT MARKING SHALL BE RESTORED OR REPLACED WITH THE SAME MATERIALS TO THE SATISFACTION OF THE COUNTY TRAFFIC MANAGER.
5. THE DEVELOPER SHALL BE RESPONSIBLE TO PROVIDE AND INSTALL ALL PERMANENT SIGNS SHOWN ON THE PLANS. STREET NAME SIGNS SHALL CONFORM IN THEIR ENTIRETY TO CLARK COUNTY AREA STANDARDS. ALL OTHER SIGNS SHALL BE STANDARD SIZE UNLESS OTHERWISE SPECIFIED ON THE PLANS. ALL SIGNPOSTS SHALL BE INSTALLED IN ACCORDANCE WITH CLARK COUNTY AREA STANDARDS. ALL SIGNS SHALL USE CLASS V SHEETING.
6. IF A PROPOSED STREET LIGHT STANDARD IS FIELD LOCATED TO WITHIN FIVE (5) FEET OF ANY SIGN SHOWN HEREON TO BE MOUNTED ON A SIGN POST, CHANGE SIGN MOUNTING TO ONE ON THE STREETLIGHT STANDARD.
7. PRIOR TO CONSTRUCTION, THE PLANNING DIVISION SHALL OBTAIN STREET NAMES AND BLOCK NUMBERING FROM THE CURRENT PLANNING DIVISION OF THE DEPARTMENT OF COMPREHENSIVE PLANNING.
8. ALL TRAFFIC SIGNAL POLE ASSEMBLIES, STEEL PEDESTAL FOR CABINETS AND STREET LIGHT POLES SHALL BE GALVANIZED PER ASTM A123.
9. ALL STREET LIGHTING INSTALLATIONS EXCEPT NOTED ON THE STREET LIGHTING PLANS SHALL CONFORM TO THE UNIFORM STANDARD DRAWINGS AND THE UNIFORM STANDARD SPECIFICATIONS FOR PUBLIC WORKS CONSTRUCTION OFF-SITE IMPROVEMENTS CLARK COUNTY AREA, NEVADA, LATEST EDITION OF EACH.
10. THE FOLLOWING CLARK COUNTY UNDERGROUND FACILITIES MAY BE LOCATED IN YOUR PROJECT AREA: STREET LIGHTS, TRAFFIC SIGNALS, AND FIBERCAST AND FIBER OPTIC SYSTEMS OF TRANSPORTATION (F.A.S.T.). IF INTERFERENCE TO ANY OF THESE FACILITIES IS ANTICIPATED, THE PROJECTOR SHALL ADVISE THE COUNTY TRAFFIC MANAGER. YOU MUST CONTACT CLARK COUNTY TRAFFIC MANAGEMENT DIVISION, OPERATIONS UNIT AT 455-6000 FOR LOCATIONS AT LEAST 48 HOURS PRIOR TO WORKING IN THE AREA. CLARK COUNTY IS NOT A MEMBER OF "CALL BEFORE YOU DIG" (UNDERGROUND SERVICE ALERT), AND A CALL TO THAT ORGANIZATION DOES NOT RELIEVE YOU OF LIABILITY FOR CLARK COUNTY FACILITIES.
11. F.A.S.T. INTERCONNECT CABLE POLICY IS IN EFFECT. INTERCONNECT CABLE MUST BE MAINTAINED AT ALL TIMES. DEVELOPER/CONTRACTOR SHALL PROVIDE TEMPORARY OVERHEAD INTERCONNECT CABLE WHILE PERMANENT INTERCONNECT CABLE IS BEING RELOCATED. TEMPORARY AERIAL INSTALLATION MUST BE ACCEPTABLE TO THE COUNTY TRAFFIC MANAGER AND TO F.A.S.T. ANY DAMAGE TO THIS CABLE IS DEEMED IN EMERGENCY BY F.A.S.T., CITY OF LAS VEGAS, CLARK COUNTY AND NOTGOT MUST BE REPAIRED IMMEDIATELY TO F.A.S.T. ADDITIONAL \$2,000.00 PER DAY DAMAGES MAY BE ASSESSED AFTER 24 HOURS HAS ELAPSED FROM TIME OF BREAK OR DAMAGE.
12. ALL NEW OR REPLACEMENT TRAFFIC SIGNAL LOOPS SHALL BE INSTALLED USING CABLE-IN-DUCT WIRING. EACH LEAD HAVING INDEPENDENT LEAD-IN WIRES FOR EACH LOOP FROM THE CONTROLLER TO THE PULL-BOX, AND EACH LEAD-IN SHALL BE INDIVIDUALLY TAGGED.
13. TRAFFIC SIGNAL PEDESTRIAN HEADS SHALL BE THE L.E.D. TYPE.
14. ELECTRICAL POWER SERVICE POINT LOCATION(S) FOR STREET LIGHTING AND TRAFFIC SIGNALS MUST BE INDICATED ON THE PLANS. IF CONNECTING TO AN EXISTING CIRCUIT, INDICATE LOCATION OF EXISTING SERVICE POINT FOR EACH CIRCUIT.
15. WHEN STREETLIGHTS ARE TO BE CONNECTED TO AN EXISTING CIRCUIT, THE ENGINEER MUST CERTIFY THAT THE EXISTING CIRCUIT IS CAPABLE OF HANDLING THE ADDITIONAL CIRCUIT LOAD.
16. CLARK COUNTY RESERVES THE RIGHT TO REJECT STREET LIGHT AND TRAFFIC SIGNAL POLES AND ASSEMBLIES WHICH HAVE A "STRIPPED" APPEARANCE.
17. TWO WEEKS PRIOR TO BEGINNING OF CONSTRUCTION, MODIFICATION OR RELOCATION OF ANY TRAFFIC SIGNAL SYSTEM SHALL BE SUBMITTED TO THE CLARK COUNTY TRAFFIC MANAGEMENT DIVISION OF THE DATE THAT WORK WILL BEGIN.
18. THREE (3) NORMAL WORKING DAYS PRIOR TO TURN-ON OR COMPLETION OF MODIFICATIONS) TO A TRAFFIC SIGNAL SYSTEM, WRITTEN NOTICE SHALL BE SUBMITTED TO THE CLARK COUNTY TRAFFIC MANAGEMENT DIVISION THAT WORK IS BEING COMPLETED AND THE PROPOSED DATE OF COMPLETION.

1. CONTRACTOR SHALL PROVIDE ALL NECESSARY HORIZONTAL AND VERTICAL TRANSITION BETWEEN NEW CONSTRUCTION AND EXISTING SURFACES TO PROVIDE FOR PROPER DRAINAGE AND OF INGRESS AND EGRESS TO SAID CONSTRUCTION. EXTENT OF TRANSITIONS TO BE DETERMINED BY THE COUNTY ENGINEER.
2. EXISTING UTILITIES ARE LOCATED ON PLANS FOR THE CONVENIENCE OF THE CONTRACTOR ONLY. THE CONTRACTOR SHALL BEAR FULL RESPONSIBILITY FOR THE PROTECTION OF UTILITIES AND THE ENGINEER BEARS NO RESPONSIBILITY FOR UTILITIES NOT SHOWN ON PLANS OR NOT IN THE LOCATION SHOWN ON THE PLANS. (CALL BEFORE YOU DIG 800-227-2660).
3. CONSTRUCTION SURVEY: GRADES ARE GIVEN FROM TOP OF STAKES OR NAILS. THE CONTRACTORS ARE CAUTIONED TO OBSERVE THE FOLLOWING RULE IN USING THE GRADE STAKES GIVEN BY THIS OFFICE. THREE CONSECUTIVE POINTS THAT ARE SHOWN TO BE ON THE SAME RATE OF SLOPE MUST BE USED IN COMMON IN ORDER THAT ANY VARIATION OUT OF A PERFECT STRAIGHT GRADE MAY BE DETECTED. IN CASE ANY SUCH DISCREPANCY IS FOUND, THE SAME MUST BE REPORTED OTHERWISE THIS OFFICE WILL NOT BE RESPONSIBLE FOR ANY ERROR IN THE GRADE OF THE FINISH WORK.
4. NEITHER THE OWNER NOR ENGINEER ASSUMES ANY RESPONSIBILITY FOR UTILITIES OR STRUCTURES NOT SHOWN ON THE DRAWINGS. CONTRACTOR TO VERIFY THE EXACT LOCATION OF UTILITIES PRIOR TO START OF CONSTRUCTION. THE CONTRACTOR'S RESPONSIBILITIES REGARDING UTILITIES SHALL BE AS REQUIRED UNDER SECTION 107.17 OF THE UNIFORM STANDARD SPECIFICATIONS FOR CLARK COUNTY AREA, NEVADA AND AS PROVIDED IN THE SPECIFICATIONS. THE CONTRACTOR SHALL USE EXTREME CARE WORKING OVER OR NEAR ANY EXISTING GAS MAINS.
5. THE CONTRACTOR SHALL TAKE ALL PRECAUTIONARY MEASURES NECESSARY TO PROTECT EXISTING IMPROVEMENTS, WHICH ARE TO REMAIN IN PLACE FROM DAMAGE. ALL SUCH IMPROVEMENTS OR STRUCTURES DAMAGED BY THE CONTRACTOR'S OPERATIONS SHALL BE REPAIRED OR RECONSTRUCTED TO THE SATISFACTION OF THE ENGINEER AT THE EXPENSE OF THE CONTRACTOR.
6. FENCES, SIGNS, STRUCTURES, LIGHTS AND OTHER EXISTING IMPROVEMENTS WITHIN STREET R/W SHALL BE REMOVED WHERE SHOWN ON THE CONTRACT DRAWINGS, AND AS REQUIRED BY THE ENGINEER.
7. REPLACEMENT, RELOCATION OR RECONSTRUCTION OF ALL EXISTING IMPROVEMENTS INCLUDING FENCES, WALL SIGNS, AND ALL OTHER ITEMS APPLICABLE TO THIS CONTRACT SHALL BE AS REQUIRED BY THE ENGINEER.
8. THE CONTRACTOR SHALL BACKFILL AND FINAL GRADE ALL CUT OR FILL SLOPES TO MATCH EXISTING CONDITIONS TO THE SATISFACTION OF THE ENGINEER.
9. THE CONTRACTOR SHALL BE RESPONSIBLE FOR THE VERTICAL ADJUSTMENT OF ALL EXISTING SANITARY, WATER AND STORM SEWER MANHOLES TO THE FINAL FINISH GRADES IN ACCORDANCE WITH THE DETAILS SHOWN ON THE CONTRACT DRAWINGS AND IN ACCORDANCE WITH SECTION 609 OF THE "STANDARD SPECIFICATIONS".
10. 48 HOURS PRIOR TO START OF CONSTRUCTION THE CONTRACTOR SHALL CONTACT: NV ENERGY PHONE - (702) 402-8400 CENTURYLINK TELEPHONE COMPANY PHONE - (702) 244-7055 SOUTHWEST GAS CORPORATION PHONE - (702) 601-2111 LAS VEGAS VALLEY WATER DISTRICT PHONE - (702) 670-2011
11. PRIVATE STREETS, CURB & GUTTER AND VALLEY GUTTERS REFLECTED ON THESE PLANS ARE TO BE INSPECTED BY A CLARK COUNTY INSPECTOR.
12. WHEELCHAIR RAMPS SHALL BE CONSTRUCTED AT ALL STREET INTERSECTIONS PER CLARK COUNTY STANDARD DRAWING 235 EXACT LOCATION OF RAMP TO BE DETERMINED IN FIELD BY A CLARK COUNTY INSPECTOR.
13. STANDARD STREET SECTIONS PER CLARK COUNTY STANDARD DRAWINGS UNLESS OTHERWISE NOTED.
14. CURB AND GUTTER WITH A GRADE OF LESS THAN FOUR TENTHS OF ONE PERCENT SHALL BE CONSTRUCTED BY FORMING. EACH JOINT SHALL BE CHECKED FOR GRADE PRIOR TO CONSTRUCTION AND WATER TESTED AS SOON AS POSSIBLE AFTER CONSTRUCTION.
15. VALLEY GUTTER WITH A GRADE OF FOUR TENTHS OF ONE PERCENT OR LESS SHALL BE CHECKED FOR GRADE PRIOR TO CONSTRUCTION AND WATER TESTED AS SOON AS POSSIBLE AFTER CONSTRUCTION. IT IS THE RESPONSIBILITY OF THE CONTRACTOR TO INSURE PROPER DRAINAGE ACROSS ALL VALLEY GUTTERS.
16. ALL BARRICADING AND TEMPORARY TRAFFIC CONTROL DEVICES OR METHODS USED DURING CONSTRUCTION SHALL BE IN ACCORDANCE WITH THE "NEVADA TRAFFIC CONTROL MANUAL, 1986 PUBLISHED BY THE STATE OF NEVADA, DEPARTMENT OF TRANSPORTATION, EXCEPT AS OTHERWISE PROVIDED IN THE CONTRACT DRAWINGS.
17. ALL GRADING SHALL BE IN ACCORDANCE WITH THE SPECIFICATION MANUAL AND THE SOILS REPORT AS PREPARED BY MIGHT ENGINEERS WHERE CONFLICTS OCCUR THE MOST RESTRICTIVE SHALL GOVERN.
18. THE CONTRACTOR SHALL, AT HIS OWN EXPENSE, LOCATE ALL OVERHEAD AND UNDERGROUND INTERFERENCES WHICH MAY AFFECT HIS OPERATION DURING CONSTRUCTION AND SHALL TAKE ALL NECESSARY PRECAUTIONS TO AVOID DAMAGE TO SAME. THE CONTRACTOR SHALL USE EXTREME CAUTION WHEN WORKING NEAR OVERHEAD AND UNDERGROUND FACILITIES SO AS TO SAFELY PROTECT ALL PERSONNEL AND EQUIPMENT, AND SHALL BE RESPONSIBLE FOR ALL COSTS AND LIABILITY IN CONNECTION THEREWITH.
19. ALL CONSTRUCTION SHALL BE AS SHOWN ON THESE PLANS, ANY ALTERATIONS SHALL HAVE THE PRIOR WRITTEN APPROVAL OF THE ENGINEER.
20. THE CONTRACTOR SHALL APPLY FOG SEAL ONLY AFTER ALL CORRECTIONS AND ADJUSTMENTS HAVE BEEN MADE.
21. THE CONTRACTOR SHALL NOT BACKFILL ANY TRENCHES IN WHICH WATERLINES HAVE BEEN UNCOVERED UNTIL TH WATERLINES HAVE BEEN INSPECTED BY THE LAS VEGAS VALLEY WATER DISTRICT.
22. UTILITY COMPANY METER BOXES, MANHOLE LIDS, VALVE COVERS, ETC. SHALL BE LOCATED OUT OF DRIVEWAYS, DRIVEWAY APPROX, FLOODES, AND VALLEY GUTTERS UNLESS WRITTEN APPROVAL IS GRANTED BY THE UTILITY COMPANY.
23. TYPE V CEMENT SHALL BE USED IN ALL CONCRETE WORK.
24. THE CONTRACTOR SHALL TAKE ALL PRECAUTIONS NECESSARY TO PROTECT EXISTING PERMANENT SURVEY MONUMENTS. ALL MONUMENTS DISTURBED SHALL BE REPLACED AND ADJUSTED PER AVAILABLE RECORDS IN

1. THE OWNER, SITE DEVELOPER, CONTRACTOR, AND/OR THEIR AUTHORIZED AGENTS SHALL EACH DAY REMOVE ALL SEDIMENT, MUD, CONSTRUCTION DEBRIS, AND OTHER POTENTIAL POLLUTANTS THAT MAY HAVE BEEN DISCHARGED TO, OR ACCUMULATED IN, THE PUBLIC RIGHTS OF WAY OF CLARK COUNTY, AS A RESULT OF CONSTRUCTION ACTIVITIES ASSOCIATED WITH THIS SITE DEVELOPMENT OR CONSTRUCTION PROJECT. SUCH MATERIALS SHALL BE PREVENTED FROM ENTERING THE STORM SEWER SYSTEM.
2. ADDITIONAL CONSTRUCTION SITE DISCHARGE BEST MANAGEMENT PRACTICES MAY BE REQUIRED OF THE OWNER AND HIS OR HER AGENTS DUE TO UNFORESEEN EROSION PROBLEMS OR IF THE SUBMITTER OF THIS PERMIT DOES NOT MEET THE REQUIREMENTS OF CLARK COUNTY TIE 24-40 AND THE LAS VEGAS VALLEY CONSTRUCTION SITE BMP GUIDANCE MANUAL.
3. TEMPORARY OR PERMANENT STABILIZATION PRACTICES WILL BE INSTALLED ON DISTURBED AREAS AS SOON AS PRACTICABLE AND NO LATER THAN 14 DAYS AFTER THE CONSTRUCTION ACTIVITY IN THAT PORTION OF THE SITE HAS TEMPORARILY OR PERMANENTLY CEASED. SOME EXCEPTIONS MAY APPLY; REFER TO LAS VEGAS STORMWATER GENERAL PERMIT FOR CONSTRUCTION ACTIVITY NW00000, SECTION II.A.5.
4. AT A MINIMUM, THE CONTRACTOR OR HIS AGENT SHALL INSPECT ALL DISTURBED AREAS, AREAS USED FOR STORAGE OF MATERIALS AND EQUIPMENT THAT ARE EXPOSED TO PRECIPITATION, VEHICLE ENTRANCE AND EXIT LOCATIONS, AND ALL BMPs WEEKLY, AND WITHIN 24 HOURS AFTER ANY RAIN EVENT. WHENEVER THERE ARE ANY RAIN EVENTS, THE CONTRACTOR SHALL INSPECT AND MAINTAIN THE STORMWATER POLLUTION PREVENTION PLAN AS NECESSARY. SOME EXCEPTIONS TO WEEKLY INSPECTIONS MAY APPLY, SUCH AS SUSPENSION OF LAND DISTURBANCE ACTIVITIES. REFER TO THE LAS VEGAS STORMWATER GENERAL PERMIT FOR CONSTRUCTION ACTIVITY NW00000, SECTION II.A.12.
5. ACCUMULATED SEDIMENT IN BMP'S SHALL BE REMOVED WITHIN SEVEN DAYS AFTER A STORMWATER RAINFALL EVENT. IF THE ACCUMULATED SEDIMENT IN ANY BMP EXCEEDS THE DESIGN CAPACITY, THE BMP MUST BE REMOVED WHEN BMP DESIGN CAPACITY HAS BEEN REDUCED BY 50 PERCENT OR MORE.

1. ALL CONSTRUCTION AND MATERIALS SHALL BE IN ACCORDANCE WITH THE LATEST EDITION OF THE DESIGN AND CONSTRUCTION STANDARDS FOR WASTEWATER COLLECTION SYSTEMS AND THE UNIFORM STANDARD SPECIFICATIONS FOR PUBLIC WORKS CONSTRUCTION OFF-SITE WASTEWATER, CLARK COUNTY AREA, NEVADA, AS AMENDED. IT WILL BE THE RESPONSIBILITY OF THE CONTRACTOR TO BE AWARE OF THE CONTENTS OF THE ABOVE SPECIFICATIONS.
2. IT SHALL BE THE CONTRACTOR'S RESPONSIBILITY TO PERFORM CONSTRUCTION AS PER PLAN. ANY ADDITIONS, DELETIONS, OR CHANGES SHALL FIRST MEET WITH THE APPROVAL OF THE CITY ENGINEER.
3. CHISEL "S" OR "G" IN CURBS WHERE SEWER OR GAS LATERALS PASS UNDER THE CURB.
4. POLYVNYL (PVC) SEWER PIPE SHALL MEET ASTM D-3034 SDR 35 SPECIFICATIONS, INSTALLED WITH SAND BEDDING AND BACKFILL OF TYPE II AGGREGATE BASE.
5. ALL MANHOLES PAVED IN STREETS EIGHTY (80') FOOT R/W AND LARGER SHALL HAVE CONCRETE CULVERTS. STREETS LESS THAN EIGHTY (80') FOOT R/W WILL REQUIRE RETROFIT IF PAVING DOES NOT CONFORM TO CITY STANDARDS AT THE MANHOLE.
6. TEE SADDLES SHALL BE USED TO CONNECT SEWER LATERALS TO EXISTING MAIN LINES UP TO 12" DIAMETER. SEWER LATERALS UP TO FIFTY FEET OR LARGER MAINS SHALL REQUIRE SPECIAL PROCEDURES. IN LINE "X" SHALL BE USED ON LINES TWELVE INCHES (12") OR ABOVE.
7. WATER MAINS SHALL BE PROTECTED IN ACCORDANCE WITH LVWD STANDARDS WHENEVER A SEWER MAIN CROSSES OVER A WATER MAIN OR THE SEWER IS LESS THAN EIGHTEEN INCH (18") UNDER A WATER MAIN.
8. ALL CONTRACTORS INSTALLING SEWER MAINS THAT WILL NOT UNDER THE JURISDICTION OF THE CITY OF LAS VEGAS, STATE OF NEVADA CLASS "A" CONTRACT.
9. THE CITY OF LAS VEGAS WILL NOT ACCEPT ANY SEWER MAINS WHICH HAVE A VERTICAL DEFLECTION MORE THAN ONE TENTH (0.1) OF THE DEPTH FROM THE APPROVED CONSTRUCTION PLANS AT ANY LOCATION. SEWER MAINS TOLERANCE WILL HAVE TO BE REPAIRED OR REMOVED OR REPLACED TO THE SATISFACTION OF THE CITY ENGINEER PRIOR TO ACCEPTANCE.
10. INSTALLATION OF CURVED SEWER REQUIRES THE USE OF C-900 PIPE WHICH ALLOWS FOR PIPE DEFLECTION AT THE JOINTS.

UNIFORM GUIDELINES - INSTALLATION AND SPECIFICATION OF FIRE HYDRANTS

1. ALL WORK SHALL BE DONE IN STRICT ACCORDANCE WITH THE CLARK COUNTY FIRE CODE AS AMENDED, AND THE 2007 EDITION OF NATIONAL FIRE PROTECTION ASSOCIATION PAMPHLET #24.
2. FIRE HYDRANTS AND WATER SUPPLIES FOR FIRE PROTECTION SHALL BE MADE AND SERVICEABLE PRIOR TO AND DURING THE TIME OF CONSTRUCTION IN ACCORDANCE WITH SECTION 1412 OF THE CLARK COUNTY FIRE CODE, AS AMENDED.
3. IF DURING CONSTRUCTION IT BECOMES NECESSARY TO CLOSE ANY CONTROL VALVE OR PLACE A HYDRANT OUT OF SERVICE, APPROVAL SHALL BE OBTAINED FROM THE FIRE DEPARTMENT PRIOR TO PLACING THE HYDRANT OUT OF SERVICE.
4. PAINTING OF CURBS AND/OR STRIPING OF ASPHALT AREAS AND PROTECTION OF HYDRANTS FROM PHYSICAL INJURY SHALL BE PER THE FIRE HYDRANT INSTALLATION SPECIFICATIONS OF THE FIRE PREVENTION DIVISION.
5. NO FIRE HYDRANT SHALL BE LOCATED WITHIN 25 FEET OF ANY STRUCTURE, OR 6 FEET OF A DRIVEWAY, POWER POLE, LIGHT STANDARD, OR ANY OTHER OBSTRUCTION. FOR WALL, FENCE AND PLANTER LOCATIONS, A PERIMETER AROUND THE HYDRANT MEASURING A MINIMUM OF 3 FEET FROM ITS EXTENSOR SHALL BE MAINTAINED CLEAR OF ALL OBSTRUCTION AT ALL TIMES.
6. FIRE APPARATUS ACCESS ROADS SHALL BE DESIGNED AND MAINTAINED TO SUPPORT THE IMPOSED LOADS OF FIRE APPARATUS, WITH A MINIMUM VEHICLE LOAD OF 33,000 POUNDS PER AXLE, AND SHALL BE SURFACED AND PAVED SO AS TO PROVIDE ALL-WEATHER DRIVING CAPABILITIES.

EXCEPTION: TEMPORARY ACCESS ROADS SERVING ONLY BUILDINGS UNDER CONSTRUCTION SHALL NOT BE REQUIRED TO BE PAVED, BUT SHALL COMPLY WITH ALL OTHER REQUIREMENTS OF SECTION 503.2.3 OF THE CLARK COUNTY FIRE CODE.

7. PRIOR TO ACCEPTANCE OF ANY FIRE SERVICE MAIN, A SATISFACTORY HYDROSTATIC TEST WITH PIPING JOINTS UNCOVERED MUST BE CONDUCTED. APPROVED PLANS, AN INSTALLATION PERMIT AND A CONTRACTOR'S MATERIALS AND TEST CERTIFICATE MUST BE PROVIDED AT TIME OF INSPECTION. SCHEDULE INSPECTION AT WWW.CLARKCOUNTY.GOV/FIRE/DEPARTMENT/SERVICE/PREVENTION/
8. FIRE HYDRANTS SHALL BE LOCATED 4' TO 7' FROM BACK OF CURB AND A MINIMUM OF 6 FEET AWAY FROM TURNS.
9. BLUE REFLECTIVE MARKERS MUST BE INSTALLED BEFORE FINAL HYDRANT ACCEPTANCE CAN BE ATTAINED (SECTION C107 OF THE CLARK COUNTY FIRE CODE, AS AMENDED)
10. HYDRANTS THAT ARE PROPOSED FOR INSTALLATION IN PUBLIC WATER SYSTEMS SHALL BE IN ACCORDANCE WITH APPROVED FIRE HYDRANTS AS ALLOWED BY THE WATER PURVEYOR. HYDRANTS PROPOSED FOR INSTALLATION ON PRIVATE WATER SYSTEMS SHALL BE IN ACCORDANCE WITH APPROVED FIRE HYDRANTS AS

1. INSPECTIONS ARE REQUIRED, CALL 24 HOURS IN ADVANCE, 455-4610. YOUR PERMIT, APPROVED PLANS, AND BARRICADE PLANS FOR THIS WORK MUST BE ON THE JOB SITE AT ALL TIMES.
2. EXACT LOCATION OF ALL SAW-CUT LINES SHALL BE DETERMINED IN THE FIELD BY A CLARK COUNTY INSPECTOR.
3. CURB AND GUTTER SHALL BE GRADED TO LESS THAN 4/10 OF ONE PERCENT SHALL BE CONSTRUCTED BY FLOODING. EACH JOINT SHALL BE CHECKED FOR ADEQUATE FLOW PRIOR TO CONSTRUCTION AND WATER TESTED AS SOON AS POSSIBLE AFTER CONSTRUCTION.
4. FINAL ASPHALTIC CONCRETE (AC) PAVEMENT SURFACES SHALL BE ONE-HALF (1/2) INCH ABOVE THE TOP OF THE CURB (NEAR OPEN GRADE).
5. ALL OFF-SITE IMPROVEMENT CONSTRUCTION SHALL CONFORM TO THE UNIFORM STANDARD SPECIFICATIONS AND STANDARD DRAWINGS, CLARK COUNTY, CLARK COUNTY, NEVADA, AND CLARK COUNTY SUPPLEMENT TO UNIFORM STANDARD DRAWINGS AND SPECIFICATIONS, LATEST REVISION.
6. PRIVATE STREETS, CURBS & GUTTER AND VALLEY GUTTERS REFLECTED ON THESE PLANS ARE TO BE INSPECTED BY A CLARK COUNTY INSPECTOR.
7. WHEEL CHAIR RAMPS SHALL BE CONSTRUCTED IN EACH QUADRANT OF AN INTERSECTION PER STANDARD DRAWING 235. EXACT LOCATION OF RAMPS SHALL BE DETERMINED IN THE FIELD BY A CLARK COUNTY INSPECTOR.
8. PROPER SIGNS, BARRIERS, BARRICADES AND LIGHTS SHALL BE PLACED AND MAINTAINED IN ACCORDANCE WITH THE 235. EXIST MANUAL, UNIFORM TRAFFIC CONTROL DEVICES FOR STREETS AND HIGHWAYS, TRAFFIC, SCHOOL, OR STREET SIGNS OF ANY KIND ARE NOT TO BE MOVED FOR ANY REASON WITHOUT FIRST COORDINATING WITH THE DEPARTMENT OF PUBLIC WORKS OFF-SITE INSPECTOR AT 702-455-4610.
9. THIS PLAN DOES NOT AUTHORIZE CLOSURE OF ANY ROAD OR STREET.
10. NO OPEN TRENCH SHALL BE ALLOWED ACROSS ANY STREET OR WITHIN TEN (10') OF ANY TRAVEL-WAY, EXCEPT WHEN WORK IS IN ACTUAL PROGRESS. AREAS COVERED BY ACCEPTABLE STEEL PLATE ARE NOT TO BE REFINISHED AS A TRENCH. NO OPEN TRENCH IS PERMITTED IN EXCESS OF 500 FEET OR LENGTH NECESSARY TO ACCOMMODATE PIPE INSTALLATION IN A SINGLE DAY, WHICH EVER IS GREATER. ALL TRENCH CROSSINGS TO BACKFILL SHALL MEET THE STANDARD SPECIFICATION UNLESS OTHERWISE STATED.
11. A TEMPORARY PATCH IS TO BE IN PLACE AT THE END OF EACH WORK DAY WHERE THE BACKFILL IN THE TRENCH HAS BEEN COMPLETED AND PRIOR TO OPENING THE WORK AREA BACK TO TRAFFIC; AND IS TO BE MAINTAINED UNTIL THE PERMANENT PATCH IS TO BE IN PLACE WITHIN THIRTY (30) DAYS AFTER THE INSTALLATION OF THE TEMPORARY PATCH.
12. COMPACTION TESTS ARE REQUIRED.

1. INDICATED GRADES OTHER THAN T.C., F.G. & GUTTER F.L. ARE ROUGH GRADES.
2. THE ROUGH GRADING PLANS SHALL BE ON THE JOB SITE AT ALL TIMES. THE ROUGH GRADING SHALL BE FINISHED IN CONFORMANCE WITH THE LINES AND GRADES SHOWN ON THE PLANS. THE GRADING QUANTITIES ARE BASED ON THE ELEVATION AND DETAILS SHOWN ON THE PLANS. ANY DEVIATIONS FROM THE PLANS WILL RESULT IN QUANTITY CHANGES.
3. CARE SHALL BE EXERCISED IN GRADING CORNER LOTS.
4. ROUGH PAD ELEVATIONS SHALL BE GRADED TO WITHIN 0.1" OF THE PAD ELEVATIONS SHOWN ON THE PLANS. WHEN GRADING IS COMPLETE FOR THE PLANS, THE CONTRACTOR SHALL NOTIFY THE ENGINEER SO THAT THE LOTS CAN BE INSPECTED. AT THAT TIME THE ENGINEER SHALL ALSO DECIDE IF ANY ADDITIONAL DITCHES OR BERMS ARE REQUIRED. THE CONTRACTOR IS REQUESTED NOT TO REMOVE ANY OF HIS ROUGH GRADING EQUIPMENT UNTIL HE RECEIVES GRADING APPROVAL FROM THE ENGINEER.
5. SOILS REPORT PREPARED BY WRIGHT ENGINEERS, PROJECT NO. 161102, DATED 07/11/2016.
6. EARTHWORK QUANTITIES (RAW):
 - CUT = 4,797 CUBIC YARDS.
 - FILL = 5,130 CUBIC YARDS.
 - NET = 333 CUBIC YARDS.
- A) THE ABOVE QUANTITIES DO NOT REFLECT LOSSES DUE TO SUBSIDENCE OR SHRINKAGE.
- B) THE ABOVE QUANTITIES DO REFLECT USING NATIVE MATERIAL IN LUMP OF TYPE I GRAVEL BASE MATERIAL FOR STREET CEMENTS.
- C) THE ABOVE QUANTITIES DO NOT REFLECT ANY EARTHWORK WHICH MAY BE REQUIRED BY THE ENGINEER TO CONSTRUCT ADDITIONAL PROTECTIVE DITCHES OR BERMS NOT SHOWN ON THESE DRAWINGS.

DATE 5/11/17 PROJECT No. 124637
LVVWD APPROVED FIRE FLOW 2,250 GPM AT 20 PSI RESIDUAL

AVOID HITTING OVERHEAD
POWER LINES. IT'S
COSTLY.

CALL BEFORE
YOU DO
OVERHEAD

1-702-227-2929

[illegible]

30 199 1 R 60E	EL
	DATE: 4/17/2017
	DRAFTER: KMB
	DESIGNER: KMB
	CHECKED: TJS
	PROJECT NO. PIN1602
C-2 SHEET 2 OF 15 HIT #16-46686 H#6R92	

AC ASPHALTIC CONCRETE OR ACRE
AG AGGREGATE BASE
APN ASSESSORS PARCEL NUMBER
APR APPROXIMATE
APPROX CR ~ AVENUE
Ø AT
B BEGIN CURVE OR BACK OF CURB
BCR BEGINNING OF CURB RETURN
BHW BOTTOM OF HEADWALL
BLDG BUILDING
BLVD BOULEVARD
BM BENCHMARK
BVC BEGIN VERTICAL CURVE
BW BACK WATER VALVE
CC CLARK COUNTY
CCAUSD CLARK COUNTY AREA UNIFORM STANDARD DRAWINGS
CDW CLARK COUNTY PUBLIC WORKS
CORFED CLARK COUNTY REGIONAL FLOOD DISTRICT
COWD CLARK COUNTY WATER DISTRICT DISTRICT
CØ COMMON ELEMENT
CØ CENTERLINE
CLØ CLEAR OR CLEARANCE
CLSM CONTROLLED LOW STRENGTH MATERIAL
CØMØ CEMENT MORTAR LINED AND COATED
CØMØ CONCRETE MASONRY UNIT
CØCØ CONCRETE
CØT CURB
CY OR CY ØD CURE YARD
DCWCS DESIGN AND CONSTRUCTION FOR WASTEWATER
COLLECTION SYSTEMS
DET DETAIL
DI DUCTILE IRON OR DRAIN INLET
DIA. Ø DIAMETER
DIP DUCTILE IRON PIPE
DRW DRIVING
DWG(S) DRAWING
DWY DRIVEWAY
EA EACH
EØR END CURB RETURN
EL EXISTING GROUND
EL ELEVATION
ESØNT EASEMENT
EP EDGE OF PAVEMENT
ERU EQUIVALENT RESIDENTIAL UNIT
EVC END VERTICAL CURVE
EX OR EXIST EXISTING
FC FACE OF CURB
FF FINISHED FLOOR
FGH FINISHED GRADE
FGH FINISHED GRADE, HIGH SIDE
FØL FINISHED GRADE, LOW SIDE
FH FIRE HYDRANT
FL FLOWLINE

FT	FEET OR FOOT
FUT	FUTURE
GR	GRADE OR ROAD
GB	GRADE BREAK OR GRADE CHANGE
GV	GRADE VALVE
HOPE	HIGH DENSITY POLYETHYLENE
HOA	HOME OWNERS ASSOCIATION
HORIZ	HORIZONTAL
HP	HIGH POINT
HWL	HIGH WATER LEVEL
HWM, OR HW	HEADWATER
HYD	HYDRAULIC OR HYDRANT
ID	INSIDE DIAMETER
IN	INCH
INT	INTERSECTION
INV	INVERT ELEVATION
IP	IRON PIPE
IRRG	IRRIGATION
LF	LINEAR FEET
LT OR L	LOW POINT
LVD	LEFT
LWVLD	LAS VEGAS VALLEY WATER DISTRICT
LWL	LOW WATER LEVEL
MAX	MAXIMUM
MCHL	MECHANICAL
MH	MANHOLE
MN	MINIMUM
MISC	MISCELLANEOUS
MUE	MUNICIPAL UTILITY EASEMENT
NDOT	NEVADA DEPARTMENT OF TRANSPORTATION
NPC	NEVADA POWER COMPANY
NTS	NOT TO SCALE
NUE	NONEXCLUSIVE UTILITY EASEMENT
ON	ON CENTER
OD	OUTSIDE DIAMETER OR OVERALL DIMENSION
OFF	OFFSET
ORG	ORIGINAL
PAE	PUBLIC OR PEDESTRIAN ACCESS EASEMENT
PB	PULL BOX
PC	POINT OF CURVE
PC	POINT OF COMPOUND CURVE
PDE	PUBLIC DRAINAGE EASEMENT
R, OR PL	PROPERTY LINE
PB	POINT OF BEGINNING
POC	POINT OF CURVATURE
POE	POINT OF ENDING
PRC	POINT OF REVERSE CURVATURE
PRELIM	PRELIMINARY
PROP	PROPOSED
PRV	PRESSURE REDUCING VALVE
PUE	PUBLIC UTILITY EASEMENT
PT	POINT OF TANGENT OR POINT
PVC	POLYVINYL CHLORIDE

PVA	POINT OF VERTICAL INTERSECTION
QTY	QUANTITY
R	RADIUS
RCA	REINFORCED CONCRETE ARCH
ROB	REINFORCED CONCRETE BOX
ROP	REINFORCED CONCRETE PIPE
ROADWAY	ROAD
ROWY ESMT	ROADWAY EASEMENT
REQD	REQUIRED
REV	REVISION
RO	ROUGH GRADE
RT OR R	RIGHT
R/W, ROW	RIGHT OF WAY
S	SLOPE
SD	SCHEDULE
SD	STORM DRAIN
SDD	STORM DRAIN DROP INLET
SDMH	STORM DRAIN MANHOLE
SEC	SECTION
SF	SQUARE FEET
SHT	SHEET
SHWA	SOUTHERN NEVADA WATER AUTHORITY
SPEC	SPECIFICATIONS
ST	STREET
SMH	SEWER MANHOLE
STA	STATION
STD	STANDARD
STC	STEEL OR STREET LIGHT
SW	SEWER
SW	SOUTHWEST GAS
SAN OR SS	SANITARY SEWER
SY	SQUARE YARD
TAN	TANGENT
TC	TOP OF CURB
IF	TOP OF FLOOR OR TOP OF FOOTING
THRU	THROUGH
THW	TOP OF HEADWALL
TP	TOP OF PILE
TR	TOP OF RAIL
TW	TOP OF WALL
TP	TOP OF RETAINING WALL
TSW	TOP SCREEN WALL
TY	TYPICAL
UDACS	UNIFORM DESIGN AND CONSTRUCTION STANDARDS
VC	VERTICAL CURVE
VERT	VERTICAL
VAL	VALLEY CUTTER
WG	WROUGHT IRON
WL	WATER LINE
WPZ	WATER PRESSURE ZONE
WT	WEIGHT
WTL	WATER LINE

IN THE EVENT THAT ANY TEMPORARY CONSTRUCTION ITEM IS REQUIRED WHICH IS NOT SHOWN ON THESE DRAWINGS, THE OWNER AGREES TO PROVIDE AND INSTALL SUCH ITEM AT HIS OWN EXPENSE AND AT THE DIRECTION OF THE CLARK COUNTY DEPT. OF PUBLIC WORKS. TEMPORARY CONSTRUCTION ITEMS INCLUDE: PAVEMENT TRANSITIONS, PROTECTIVE DITCHES AND BERMS, ROAD SIGNS AND BARRICADES, ETC.

-QUANTITIES SHOWN ARE ESTIMATES ONLY AND ARE INTENDED TO ILLUSTRATE SCOPE OF WORK. THE CONTRACTOR SHALL BE RESPONSIBLE FOR VERIFYING THE EXACT QUANTITIES INVOLVED.

-EXISTING UTILITY LOCATIONS SHOWN HEREIN ARE APPROXIMATE ONLY. IT SHALL BE THE CONTRACTOR'S RESPONSIBILITY TO DETERMINE THE EXACT VERTICAL AND HORIZONTAL LOCATION OF ALL EXISTING UNDERGROUND UTILITIES PRIOR TO COMMENCEMENT OF CONSTRUCTION. NO REPRESENTATION IS MADE THAT ALL EXISTING UTILITIES ARE SHOWN HEREON. THE ENGINEER ASSUMES NO RESPONSIBILITY FOR UTILITIES NOT SHOWN OR UTILITIES NOT SHOWN IN THEIR PROPER LOCATIONS. CALL BEFORE YOU DIG: (800) 227-2600

EXISTING	PROPOSED	DESCRIPTION
		5' CONTOUR
		1" CONTOUR
		STRIPING
		SEWER MANHOLE
		CURB AND GUTTER
		SANITARY SEWER PIPE AND FLOW ARROW
		WATER PIPE
		WATER GATE VALVE
		FIRE HYDRANT
		WATER BLOW-OFF
		WATER LATERAL 1/2 METER
		SANITARY SEWER LATERAL
		STREETLIGHT
		EDGE OF PAVEMENT
		TRAFFIC SIGN
		PAD ELEVATION
		FINISHED FLOOR ELEVATION
		ELEVATION
		RETAINING WALL
		STORM DRAIN W/ MANHOLE

	EXISTING GAS GATE VALVE		PROPOSED SCARP AREA
	EXISTING UNKNOWN MANHOLE		DRIVEWAY
	EXISTING GAS, SIZE PER PLAN		PROPOSED RIP RAP
	EXISTING POWER POLE		SIGHT VISIBILITY ZONE PER STD DWG NO. 201.2
	EXISTING TRAFFIC SIGNAL		HANDICAP RAMP
	EXISTING WALL		
	WATER PIPE FITTING		
	WATER POINT OF CONNECTION		
	SEWER POINT OF CONNECTION		
	DAYLIGHT LINE		
	STREET CENTERLINE		
	RIGHT-OF-WAY		
	MATCHLINE		
	BOUNDARY LINE		
	PHASE LINE		
	PROPERTY LINE		
	FLOWLINE		
	SAWCUT		
	CUT/FILL TRANSITION LINE		
	SIDEWALK		
	EX STRIPING TO BE OBLITERATED		
	GRADE BREAK LINE		
	REFLECTIVE RAISED PAVEMENT MARKERS		
	BACK WATER VALVE		
	WROUGHT IRON FENCE		
	PONY WALL		
	DECORATIVE PERIMETER WALL		
	DECORATIVE CURB		
	RETAINING WALL		
	PROPOSED SEWER AND GUTTER WITH RIGHT-OF-WAY AT BACK OF CURB		
	EXISTING CURB AND GUTTER WITH RIGHT-OF-WAY AT BACK OF CURB		
	FUTURE CURB AND GUTTER WITH RIGHT-OF-WAY AT BACK OF CURB		

DRAINAGE				
1.	CONCRETE DRAINAGE EASEMENT	SF	-	4,010
WATER SYSTEM				
1.	FIRE HYDRANT ASSEMBLY W/6" GATE VALVE PER UDACS PLATE NO. 40	EA	-	2
2.	8" PVC WATER PIPE (CLASS 150)	LF	-	1,350
3.	8" x 6" TEE PER UDACS PLATE NO. 31	EA	-	2
4.	8" x 8" TEE PER UDACS PLATE NO. 31	EA	-	2
5.	1" COPPER SERVICE W/ 3/4" METER PER UDACS PLATE NO. 3	EA	-	6
6.	1" COPPER SERVICE W/ 1" METER PER UDACS PLATE NO. 3	EA	-	2
7.	WATER LATERAL	LF	-	125
8.	CAP AND 2" BLOW-OFF ASSEMBLY W/CAP PER UDACS PLATE NO. 36	EA	-	5
9.	8" 45 DEGREE BEND PER UDACS PLATE NO. 31	EA	-	2
10.	8" CROSS PER UDACS PLATE NO. 31	EA	-	1
11.	8" 90 DEGREE BEND PER UDACS PLATE NO. 31	EA	-	1
SEWER SYSTEM (CITY OF LAS VEGAS ONLY)				
1.	8" PVC SEWER PIPE (PUBLIC)	LF	-	1680
2.	8" PVC C-900 SEWER PIPE (PUBLIC)	LF	-	220
3.	4" PVC SEWER LATERAL (PRIVATE)	LF	300	-
4.	STANDARD 48" SEWER MANHOLE (PUBLIC) PER DCSWCS SD-1A	EA	-	6
5.	8" SANITARY SEWER CAP PER DCSWCS 2.25	EA	-	1
6.	60" SEWER MANHOLE (PUBLIC) W/ CAST-IN-PLACE BASE PER DCSWCS SD-1A, SD-4, SD-7, AND SD-8, SINGLE 24" LID, AND CORROSION PROTECTION PER DCSWCS 3.16.8 A OR B	EA	-	1
STREET IMPROVEMENTS				
1.	3" A.C. PAVEMENT W/ 4" TYPE II OVER AGGREGATE BASE	SY	-	8,169
2.	2" A.C. PAVEMENT W/ 4" TYPE II OVER AGGREGATE BASE	SY	-	200
TRAFFIC SIGNALS				
1.	30" STOP SIGN WITH POST (R1-1) W/ (2) 9" STREET NAME SIGN (D-3)	EA	-	4
2.	BLUE COLORED REFLECTIVE RAISED PAVEMENT MARKER	EA	-	2
3.	6" WIDE WHITE PAINTED LINE	LF	-	4,010
4.	12" WIDE WHITE PAINTED LINE	LF	-	205
DRY UTILITIES				
1.	100W H.P.S. LUMINAIRE STREET LIGHT W/DECORATIVE POLE	EA	-	-
2.	1-1/4" PVC STREET LIGHT CONDUIT WITH (2) #4 AND (1) #8 CONDUCTORS	LF	-	-
3.	NO. 3-1/2 PULL BOX W/METAL COVER	EA	-	-
4.	150 AMP SERVICE PEDESTAL (IRR)	EA	-	-
5.	200 AMP SERVICE PEDESTAL (SILT)	EA	-	-

**SLATER
HANIFAN
S-I-G GROUP**
CONSULTING ENGINEERS & PLANNERS
5740 S. ARVILLE STREET #216, LAS VEGAS, NV 89118
PHONE (702) 284-5300
FAX (702) 284-5399

[illegible]

PINNACLE HOMES

ELK RIDGE ESTATES I

QUANTITIES AND ABBREVIATIONS

CLARK COUNTY, NV

300 97-195 R 60E		
DATE:		06/10/2017
DRAFTER:		KMB
DESIGNER:		KMB
CHECKED:		TJS
PROJECT NO.		
PIN1602		
C-3 SHEET 3 OF 15		
HTF #16-16686 11-668023		


APPROVED FOR CONSTRUCTION
















DISHAR: FR









LAS VEGAS VALLEY WATER DISTRICT ENGINEERING SERVICES ~~MANAGER~~

DATE *5/11/17* PROJECT No. 124637

LVMWD APPROVED FIRE FLOW 2,250 GPM AT 20 PSI RESIDUAL

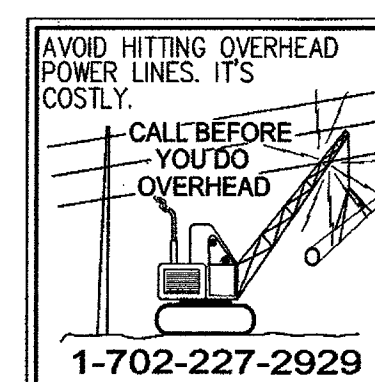

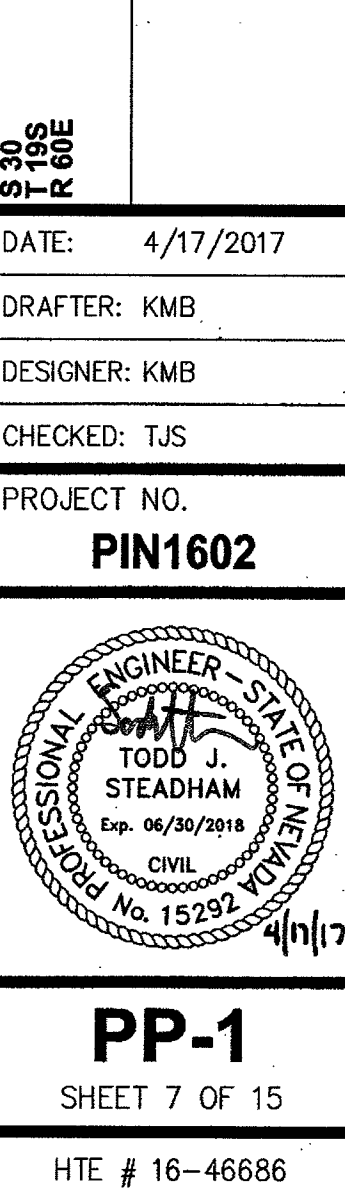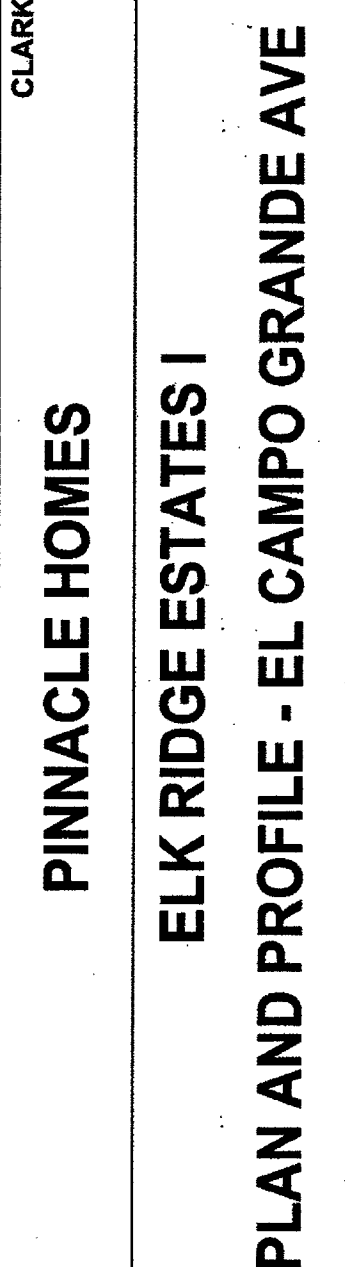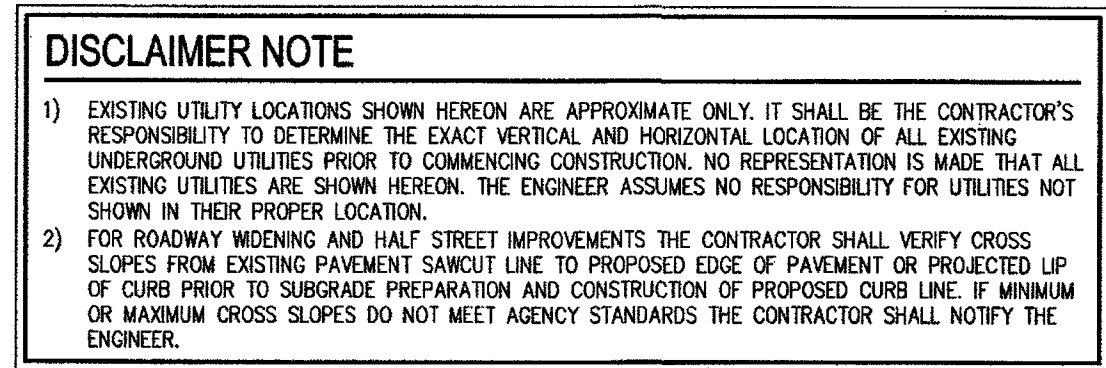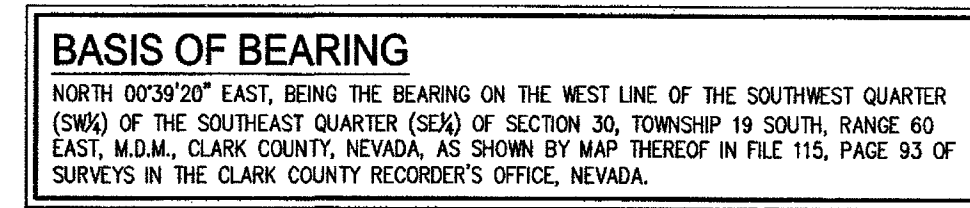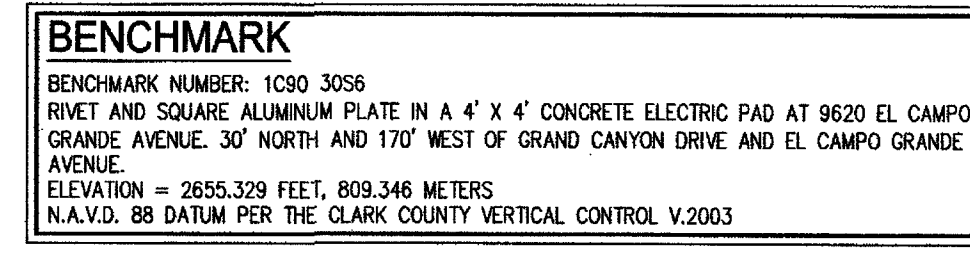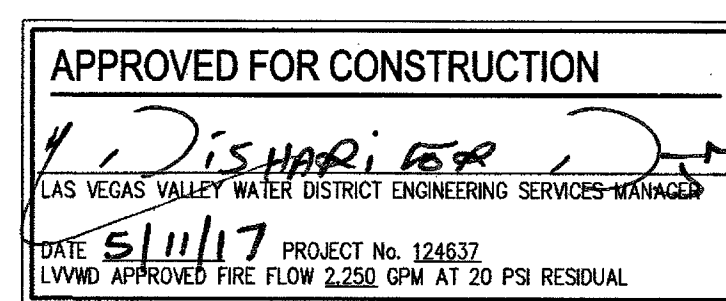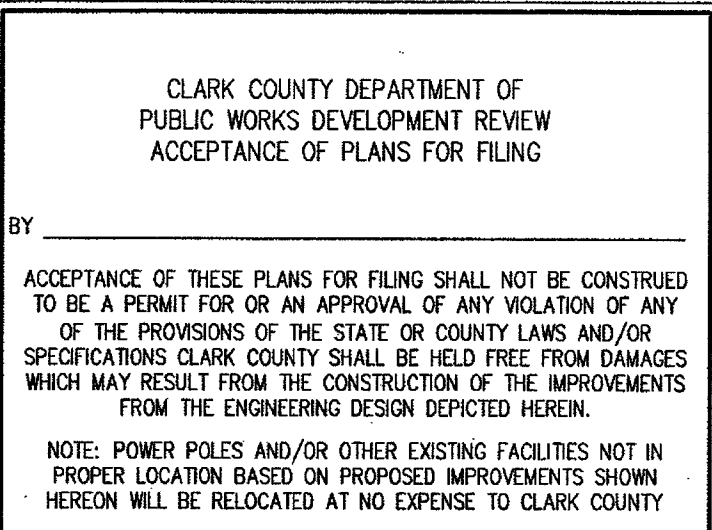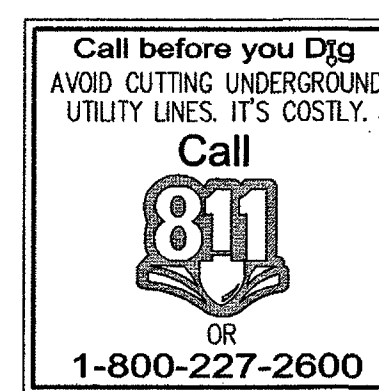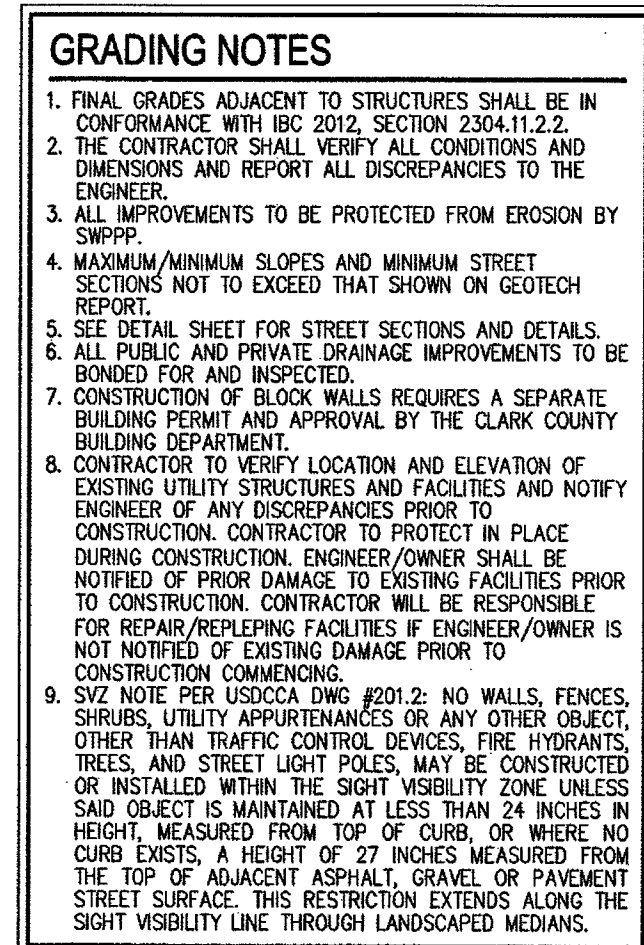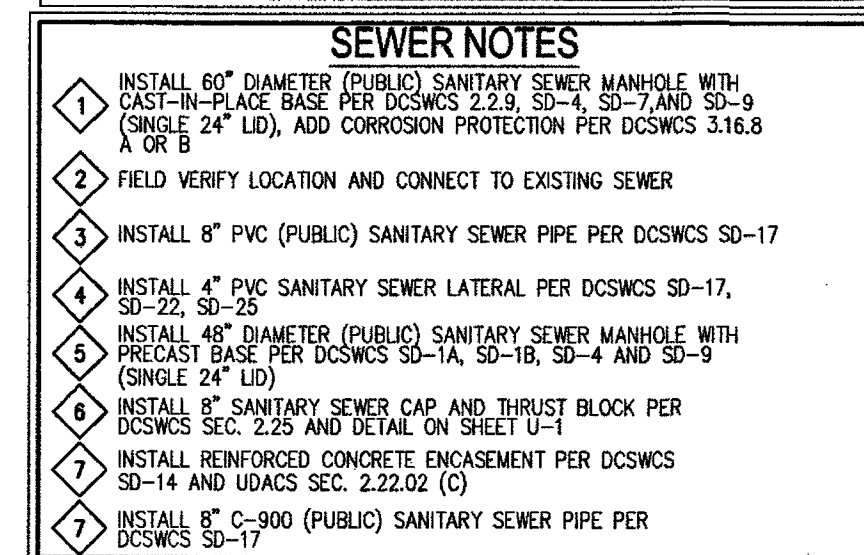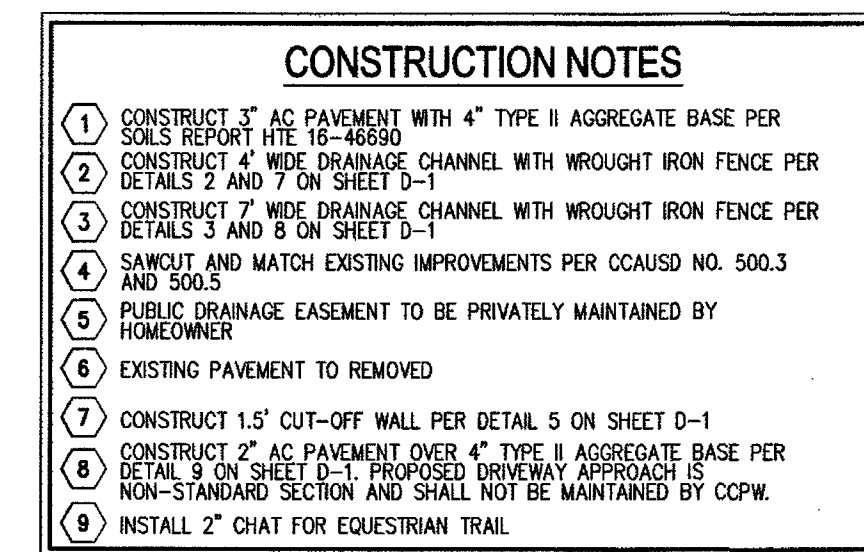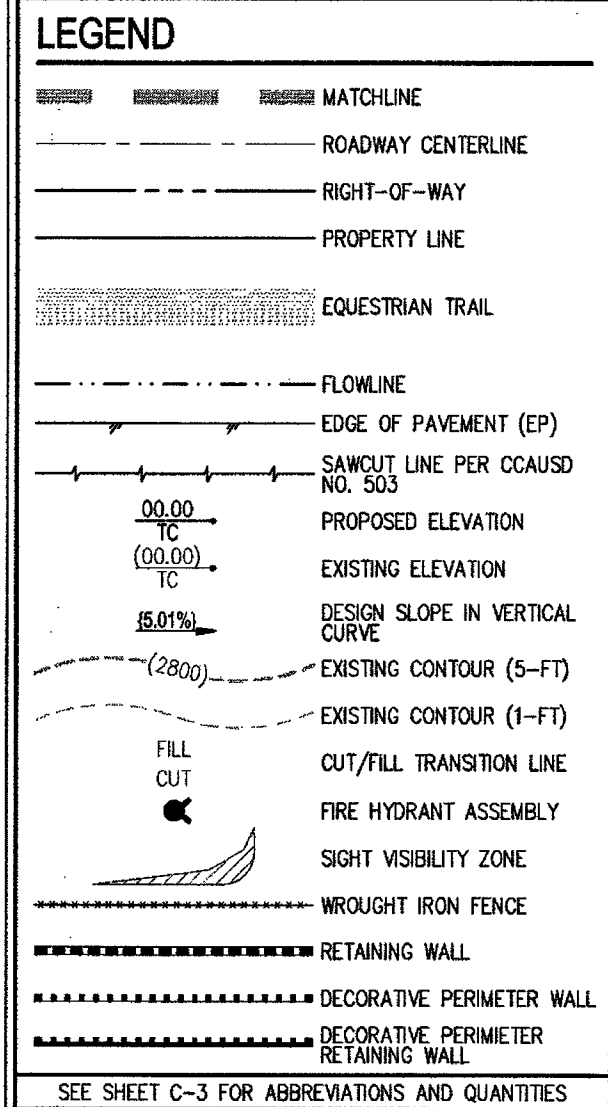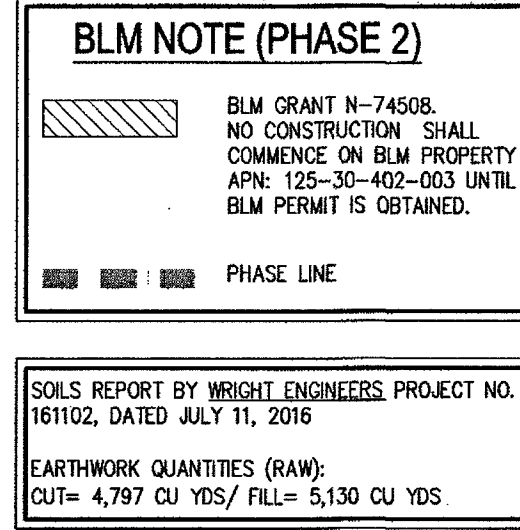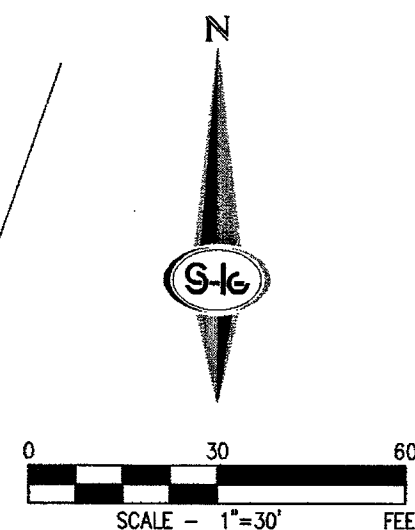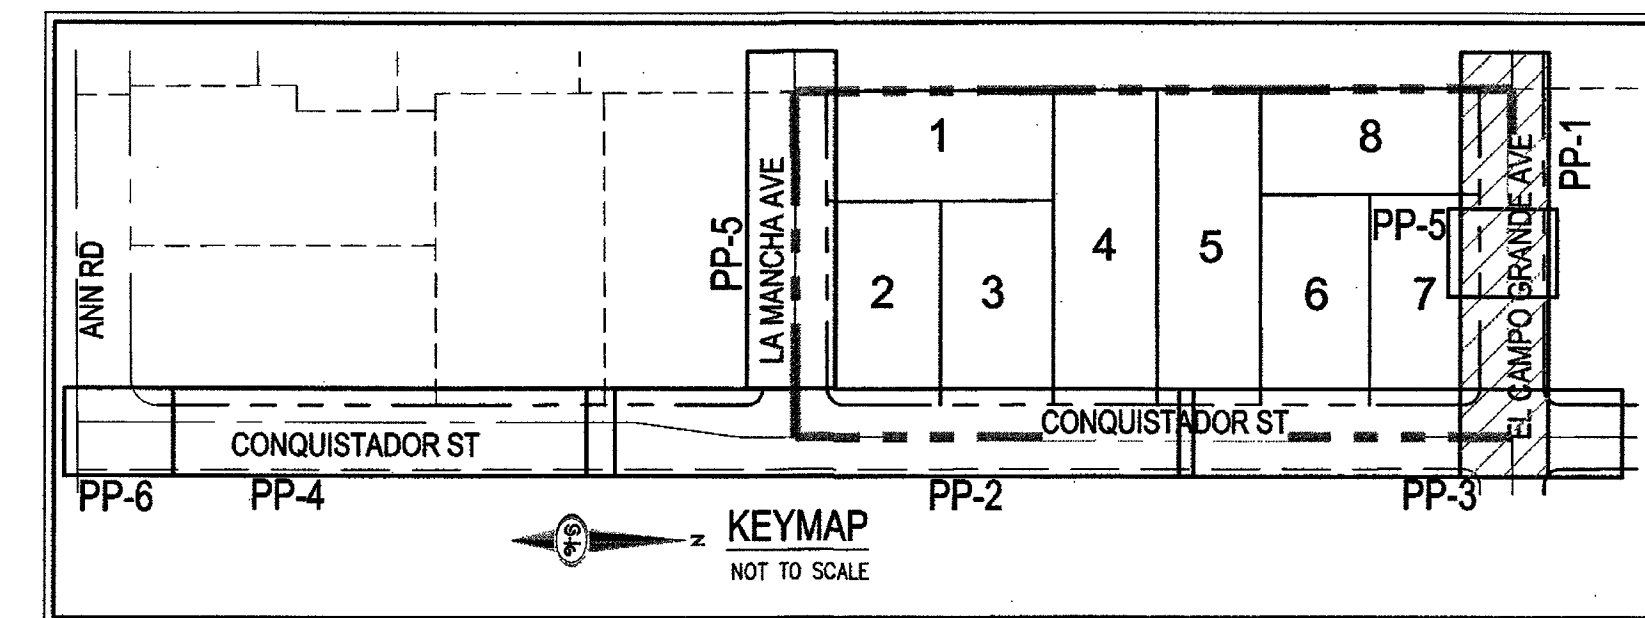

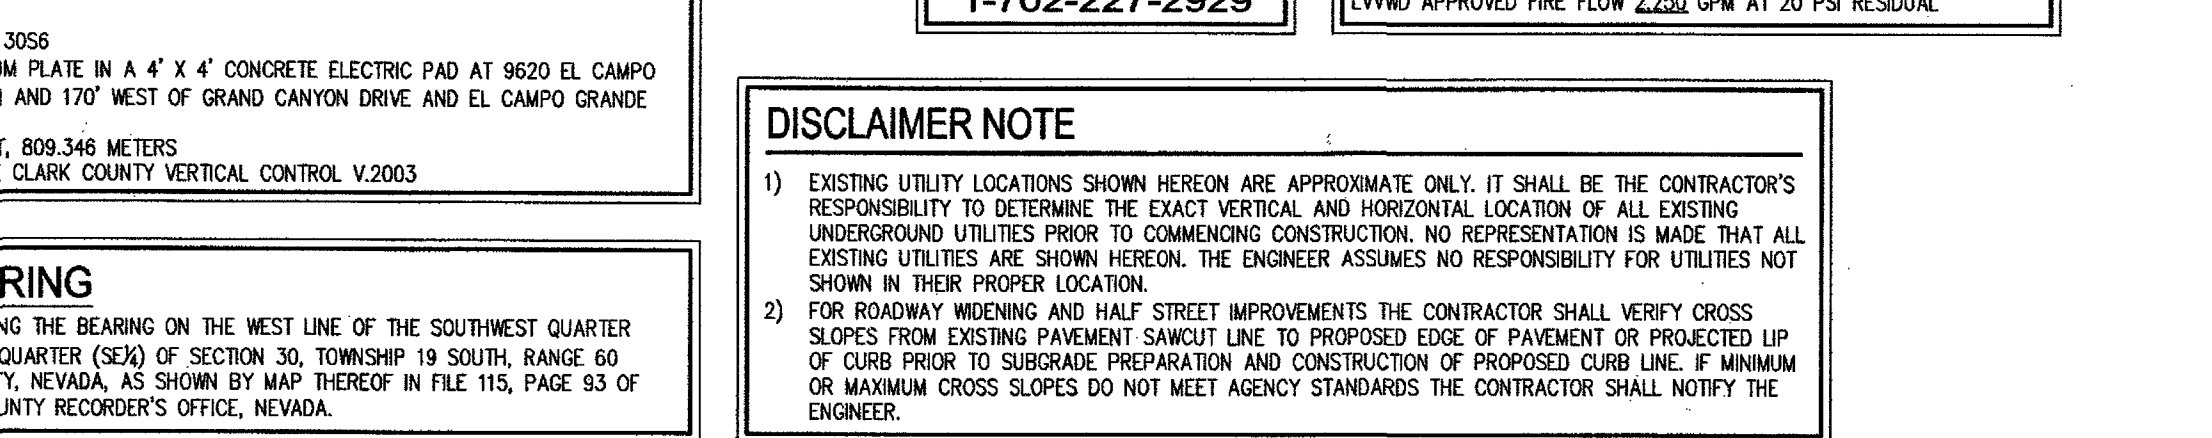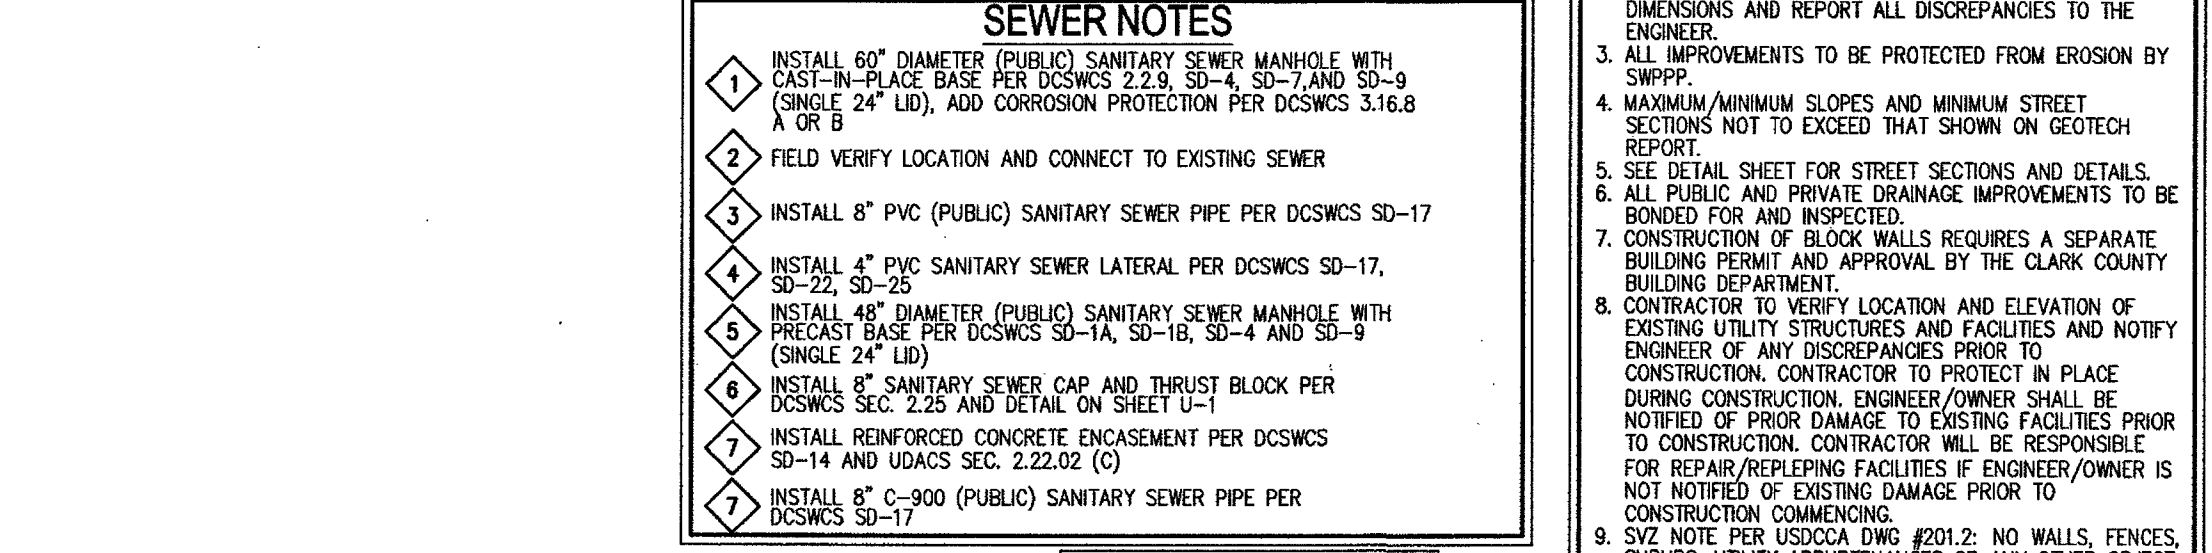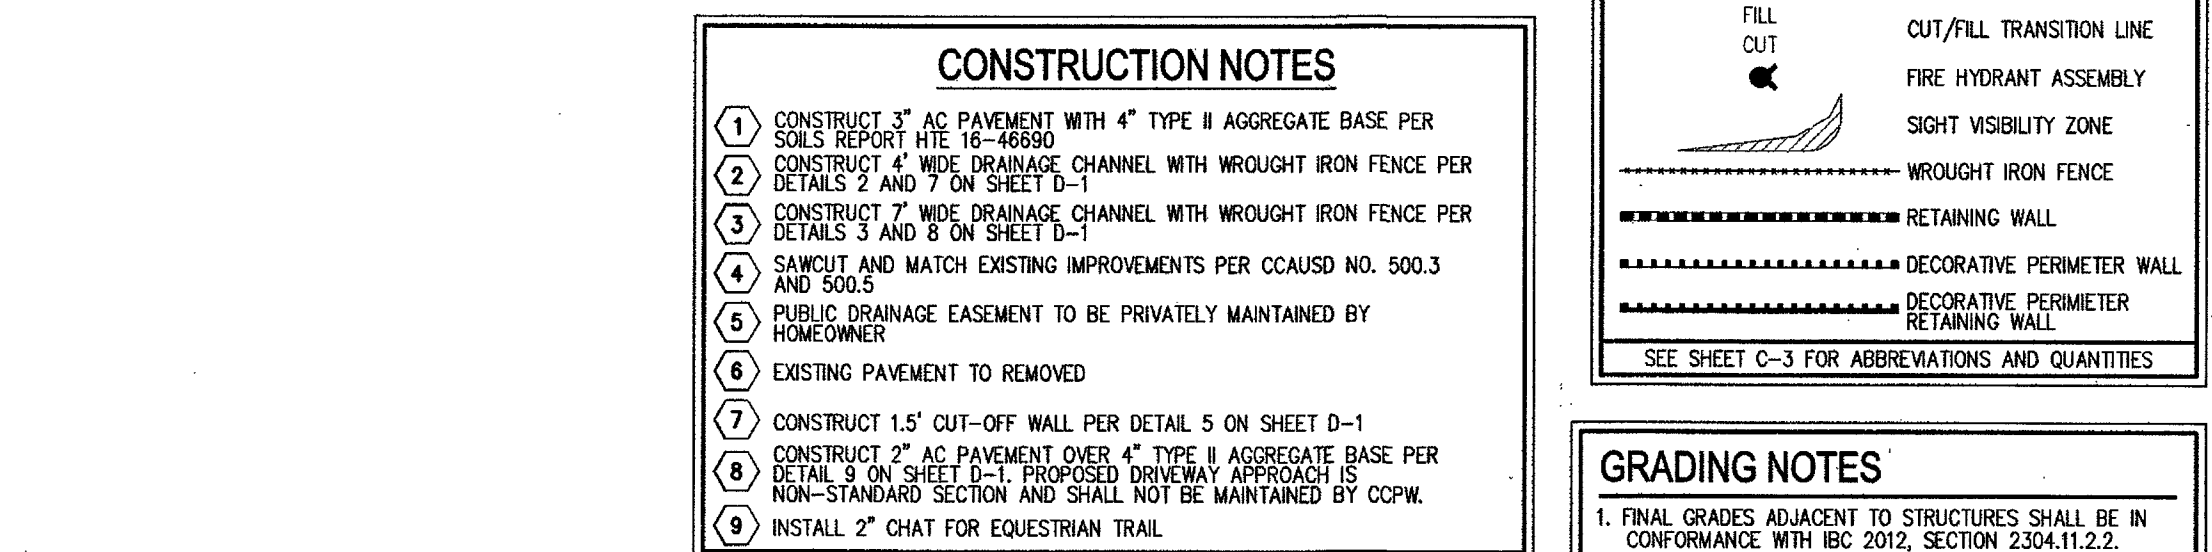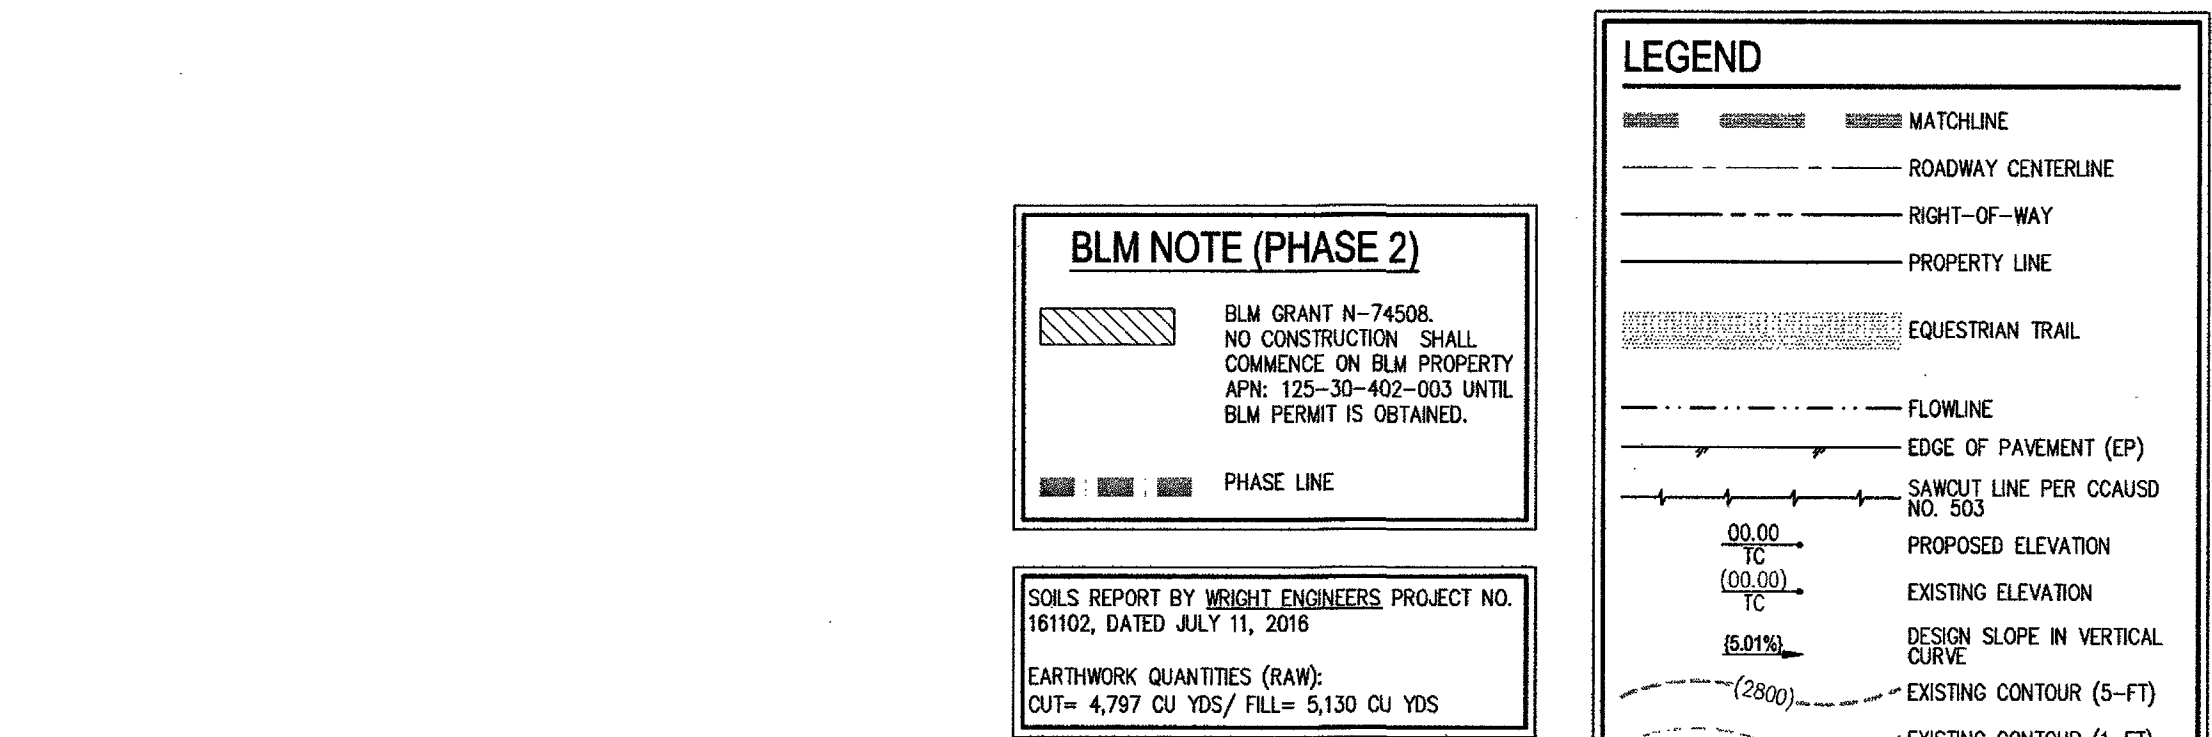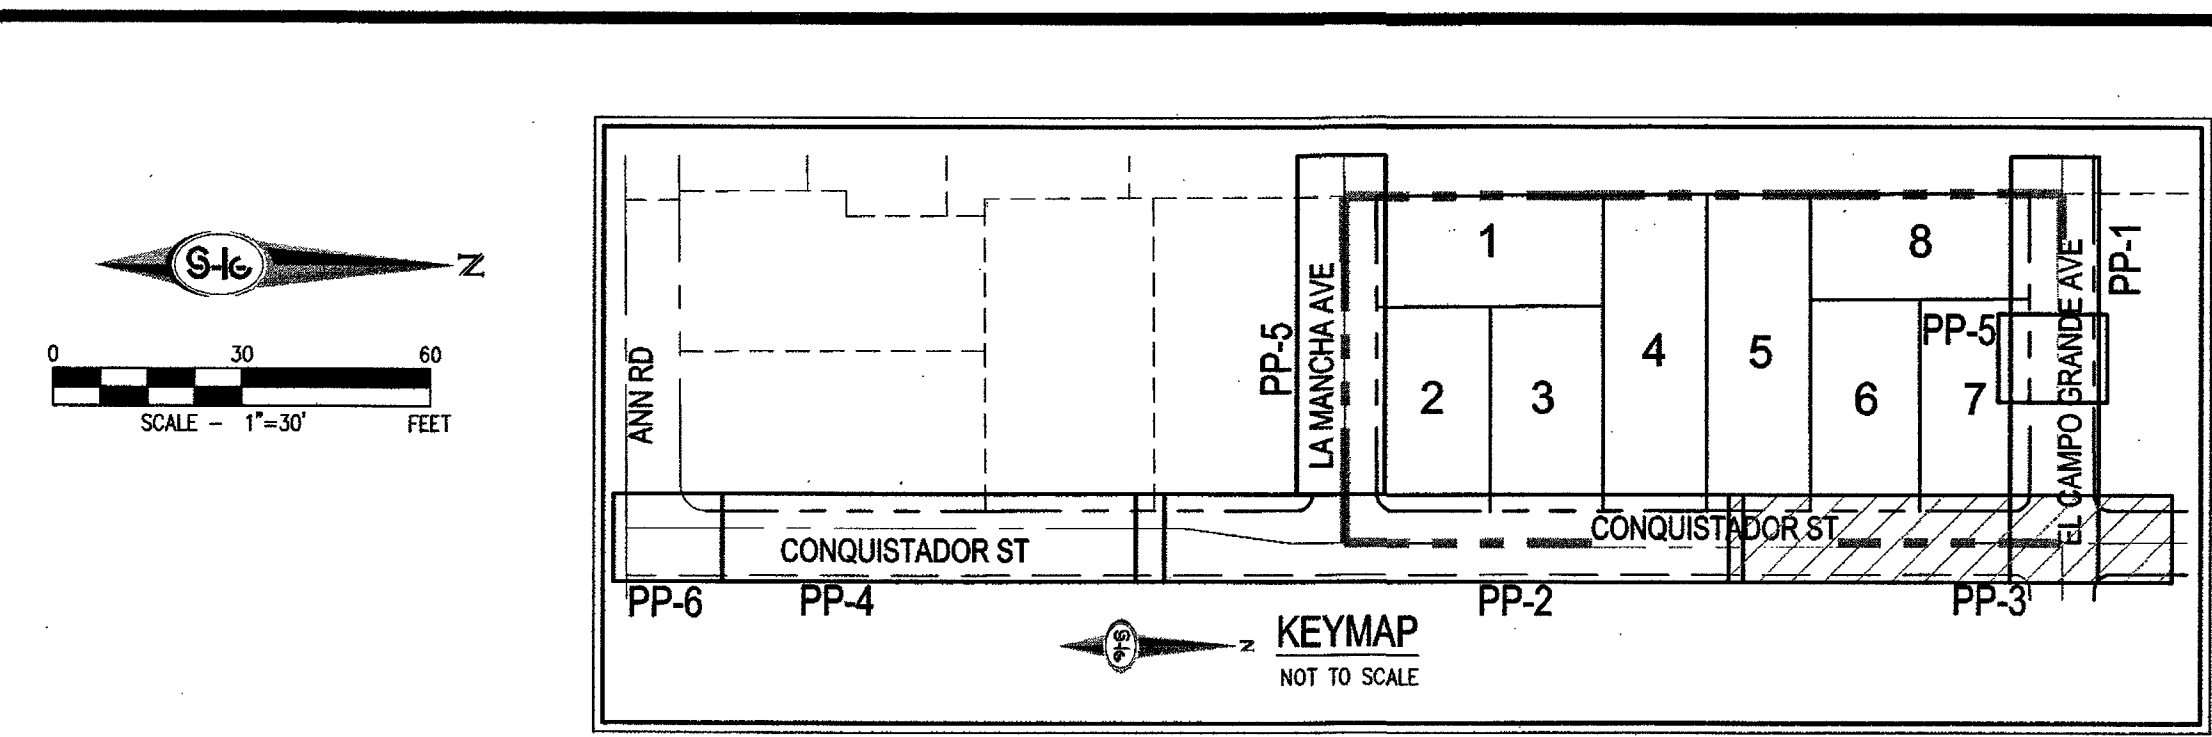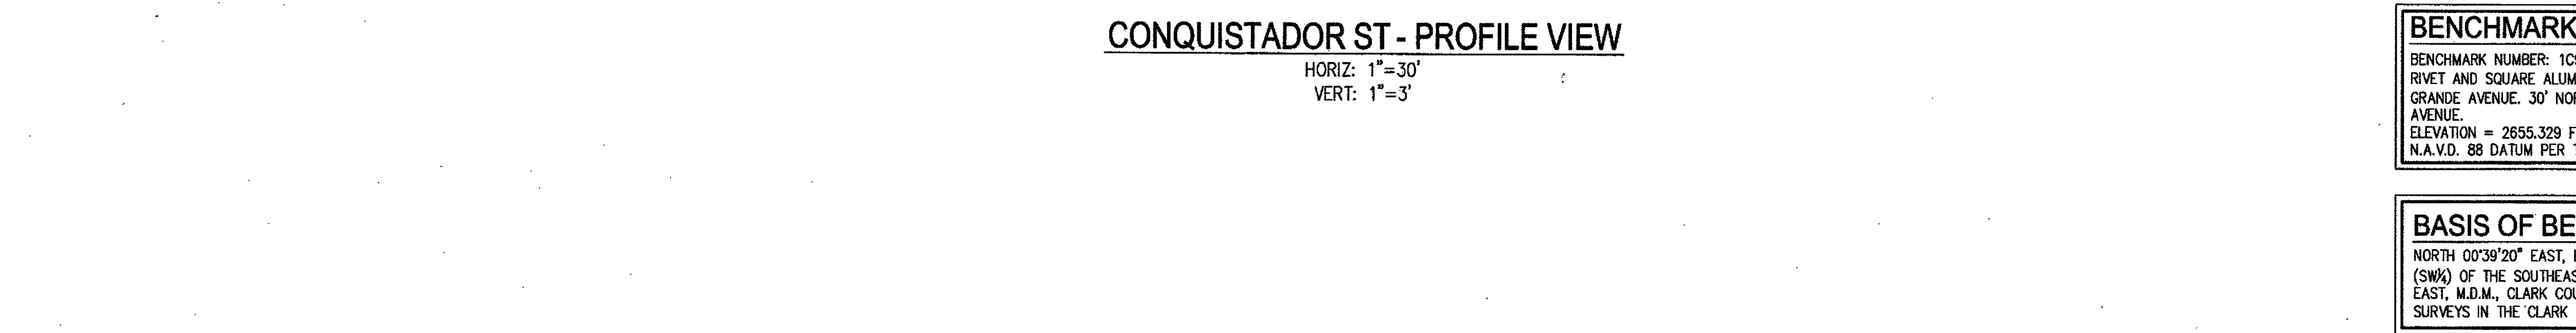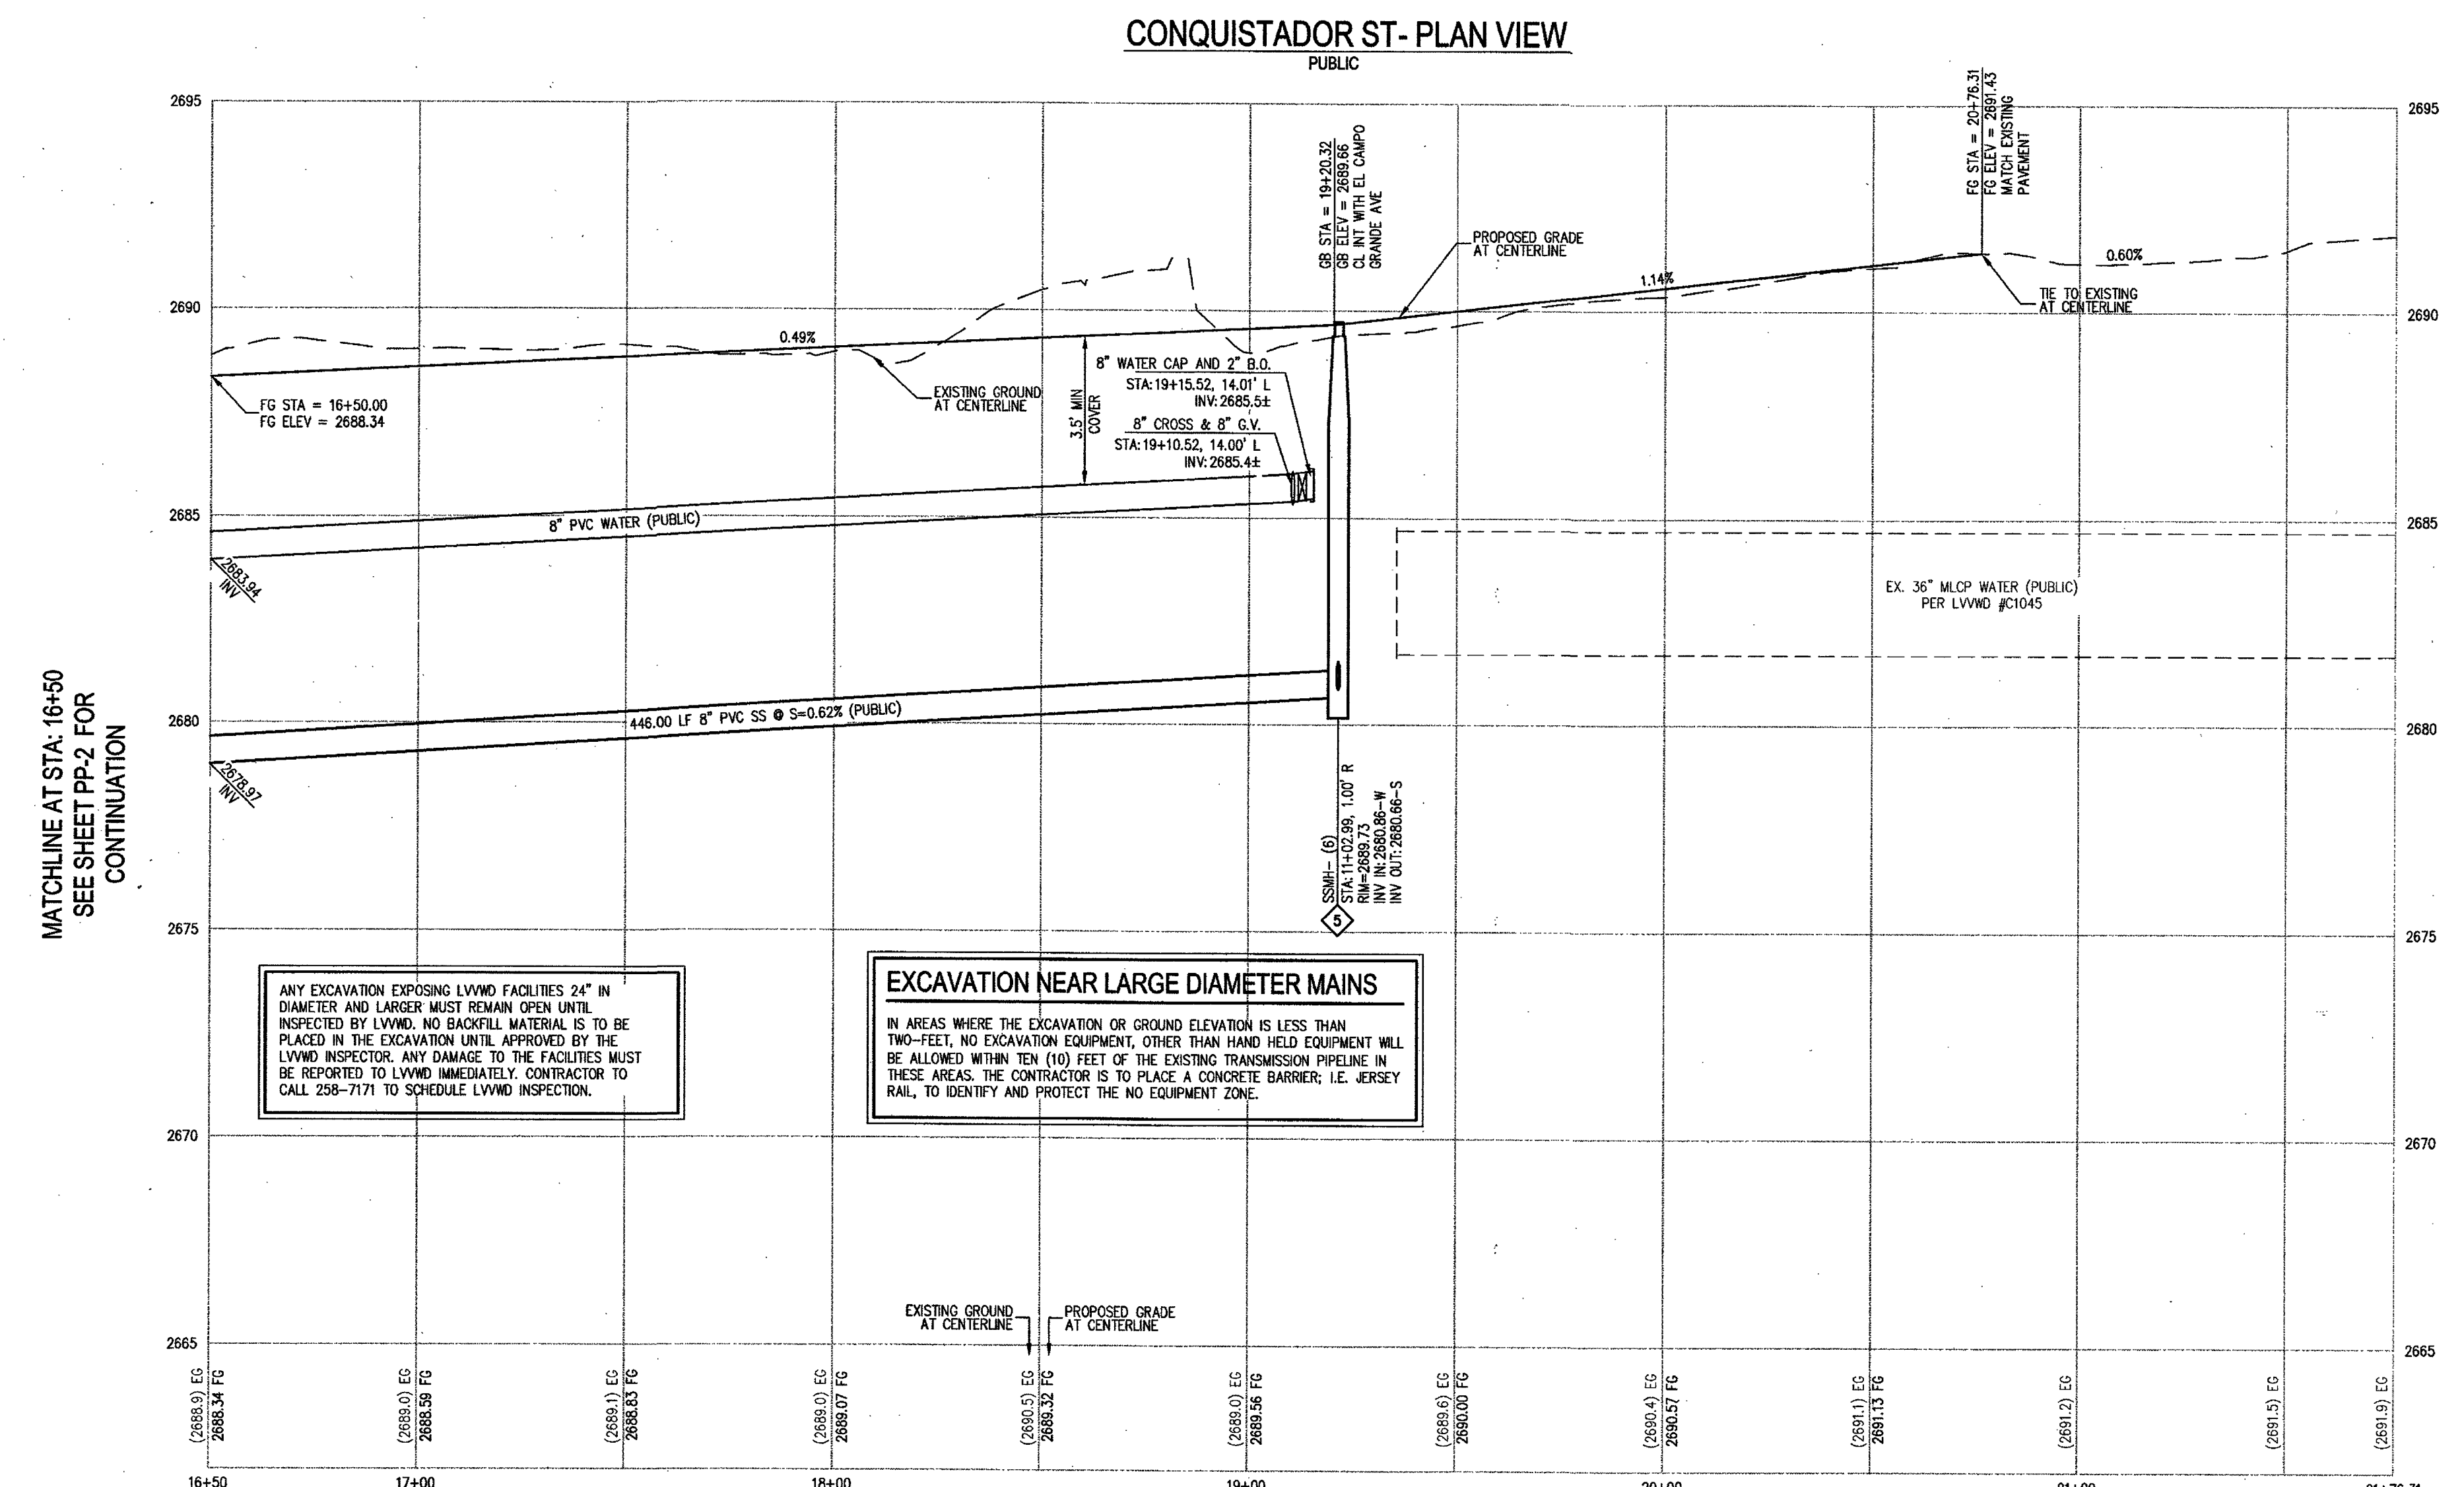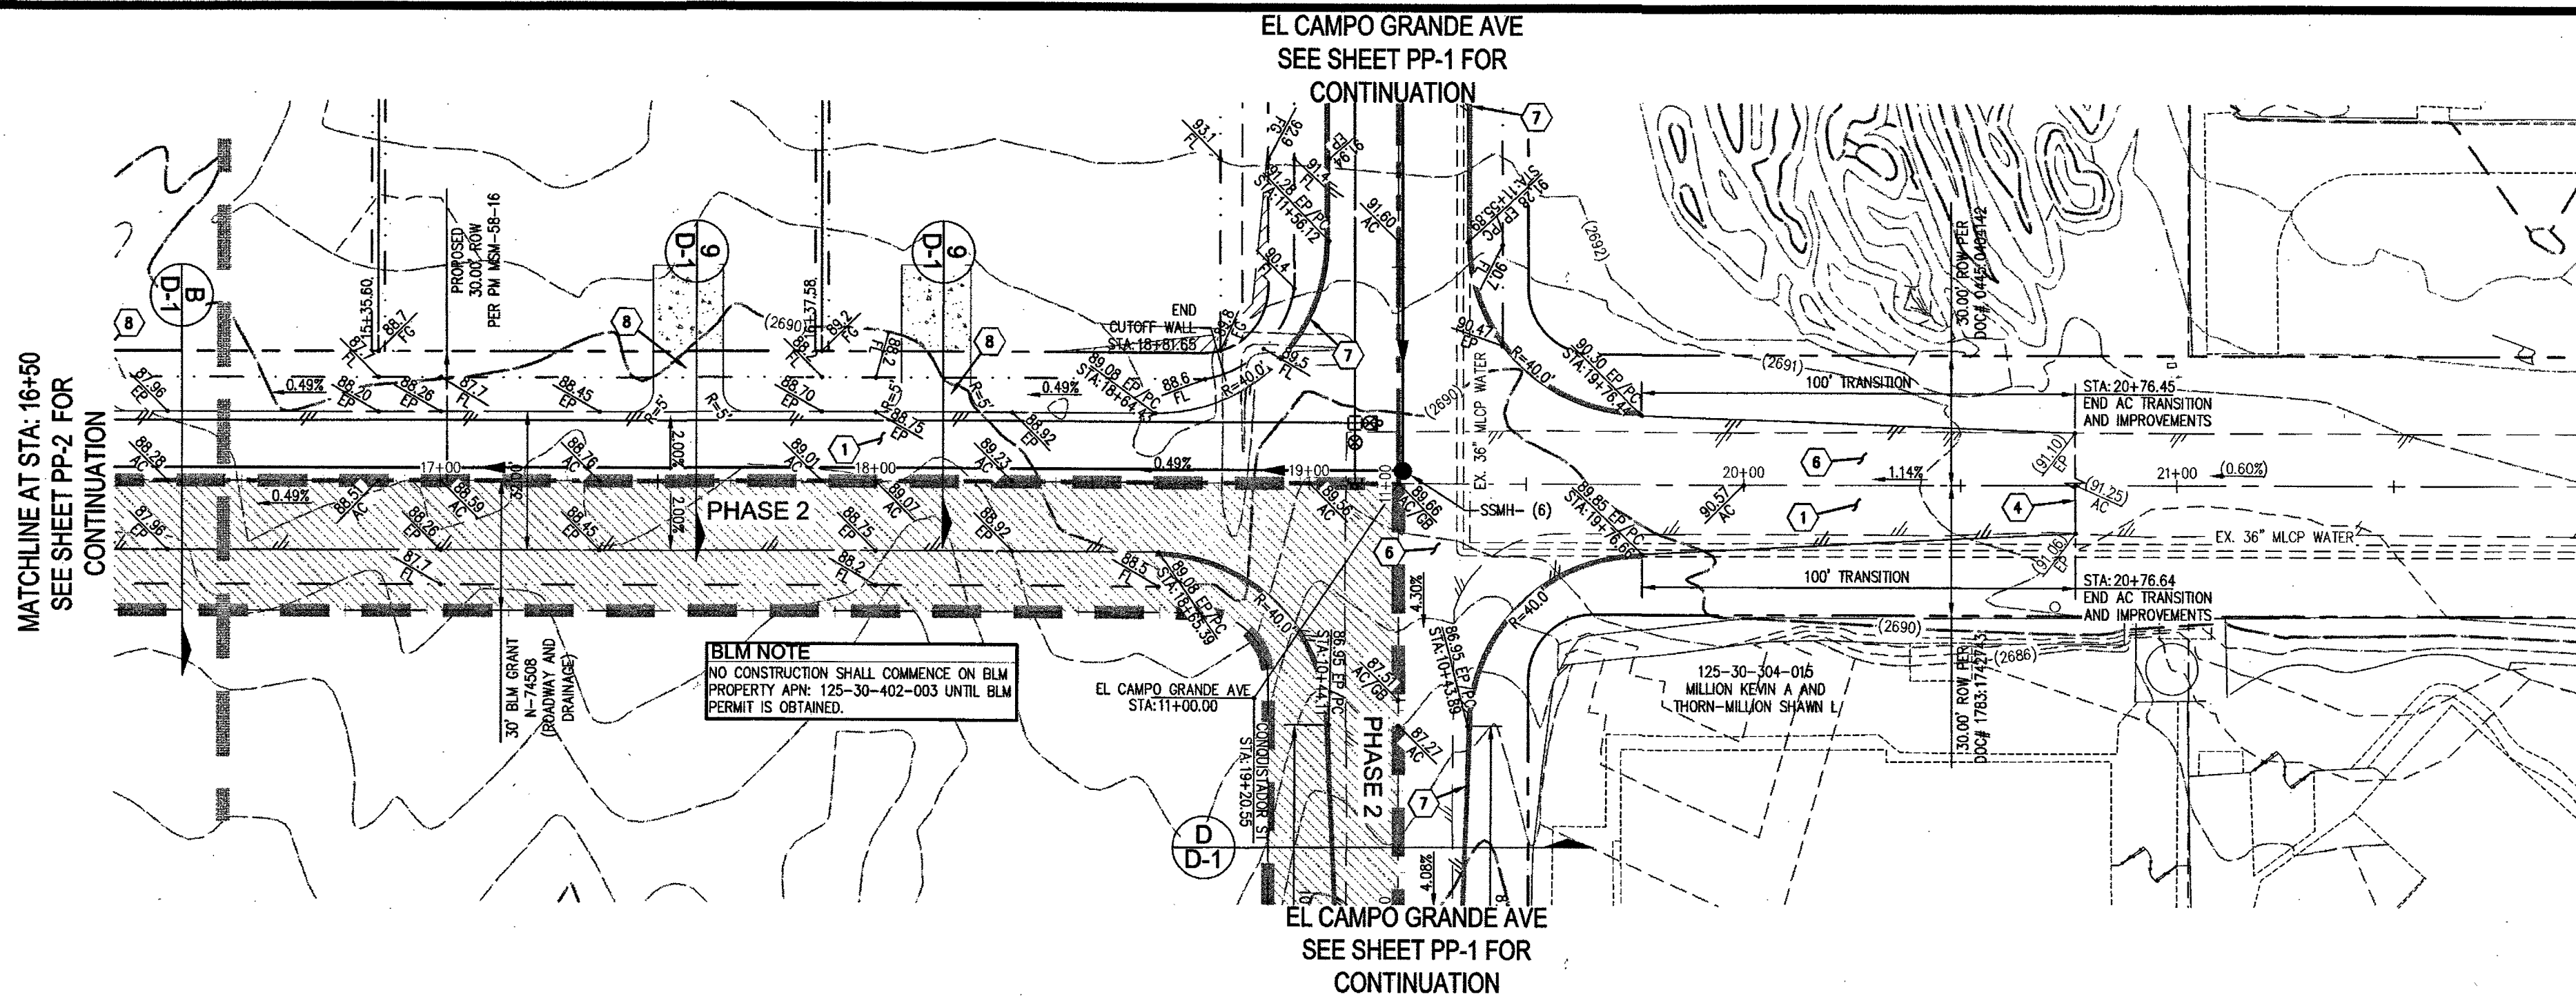

SLATER
HANIFAN
GROUP

CONSULTING ENGINEERS & PLANNERS

5740 S. ARVILLE STREET #216, LAS VEGAS, NV 89118

PHONE (702) 284-5300 FAX (702) 284-5399

CLARK COUNTY, NV

DATE: 4/17/2017

DRAFTER: KMB

DESIGNER: KMB

CHECKED: TJS

PROJECT NO. PIN1602

PROFESSIONAL ENGINEER - STATE OF NEVADA

TODD J. STEADHAM

Exp. 06/30/2018

CIVIL

PP-3

SHEET 9 OF 15

HTE #16-46686

PINNACLE HOMES





 




ELK RIDGE ESTATES I




PLAN AND PROFILE - CONQUISTADOR ST II

307u46

PP-3

307u46

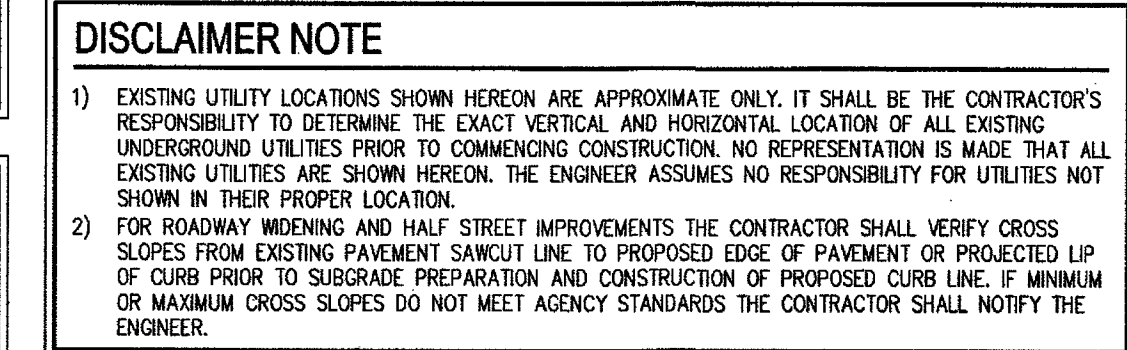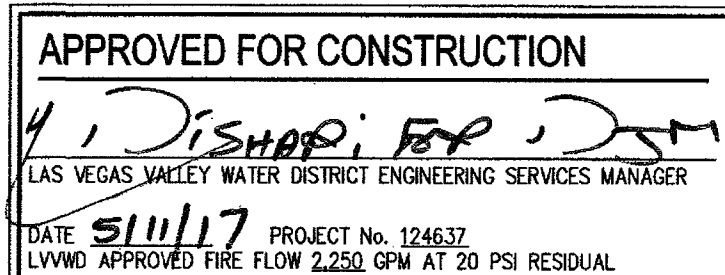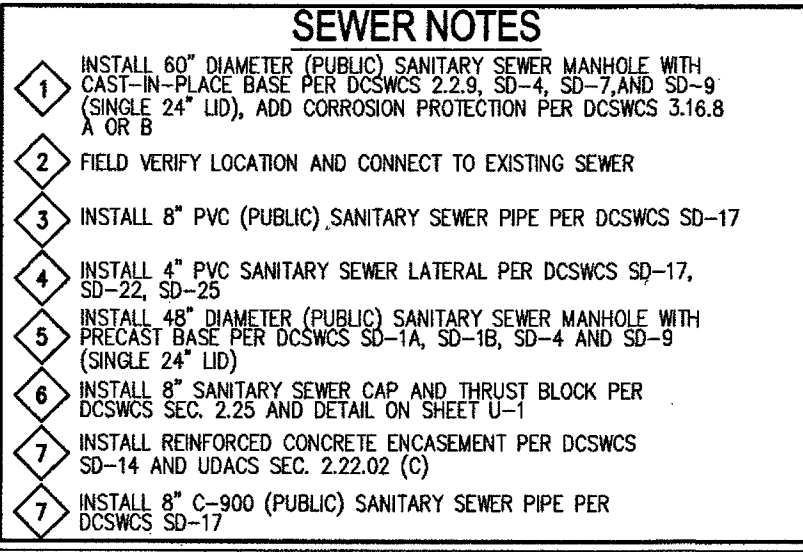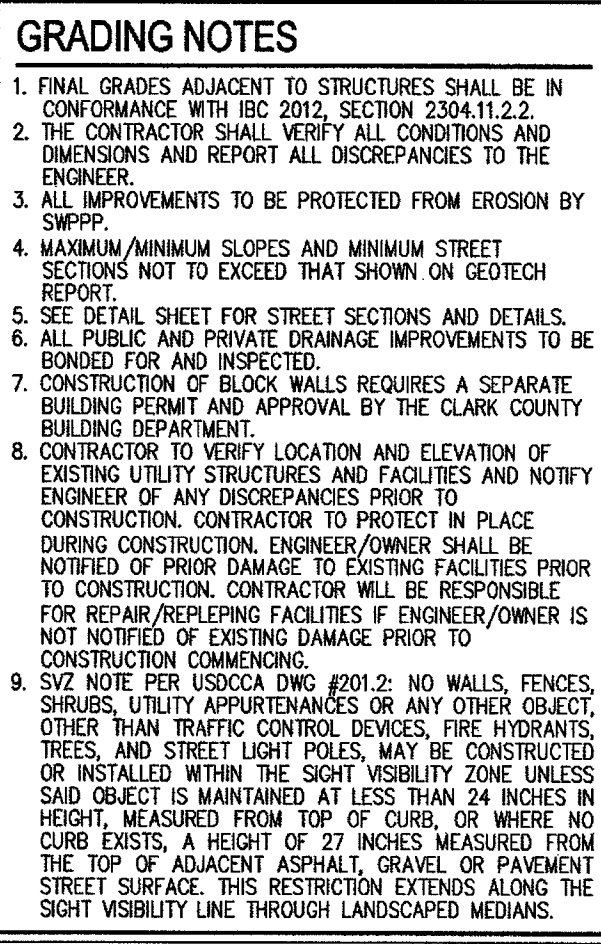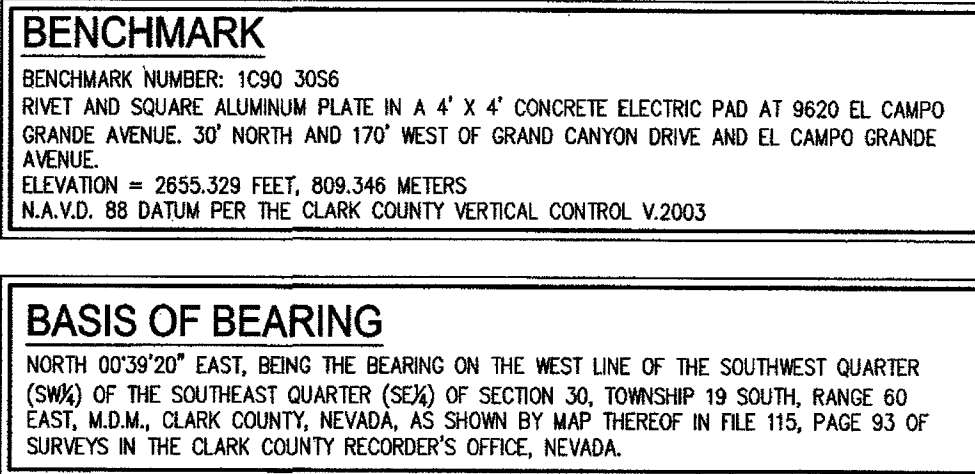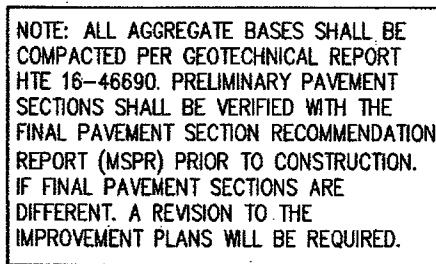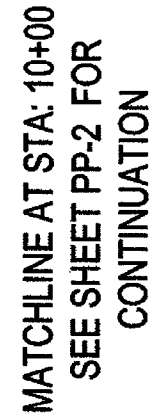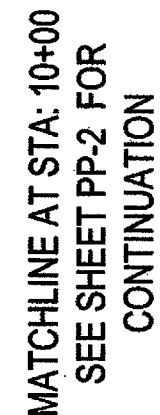

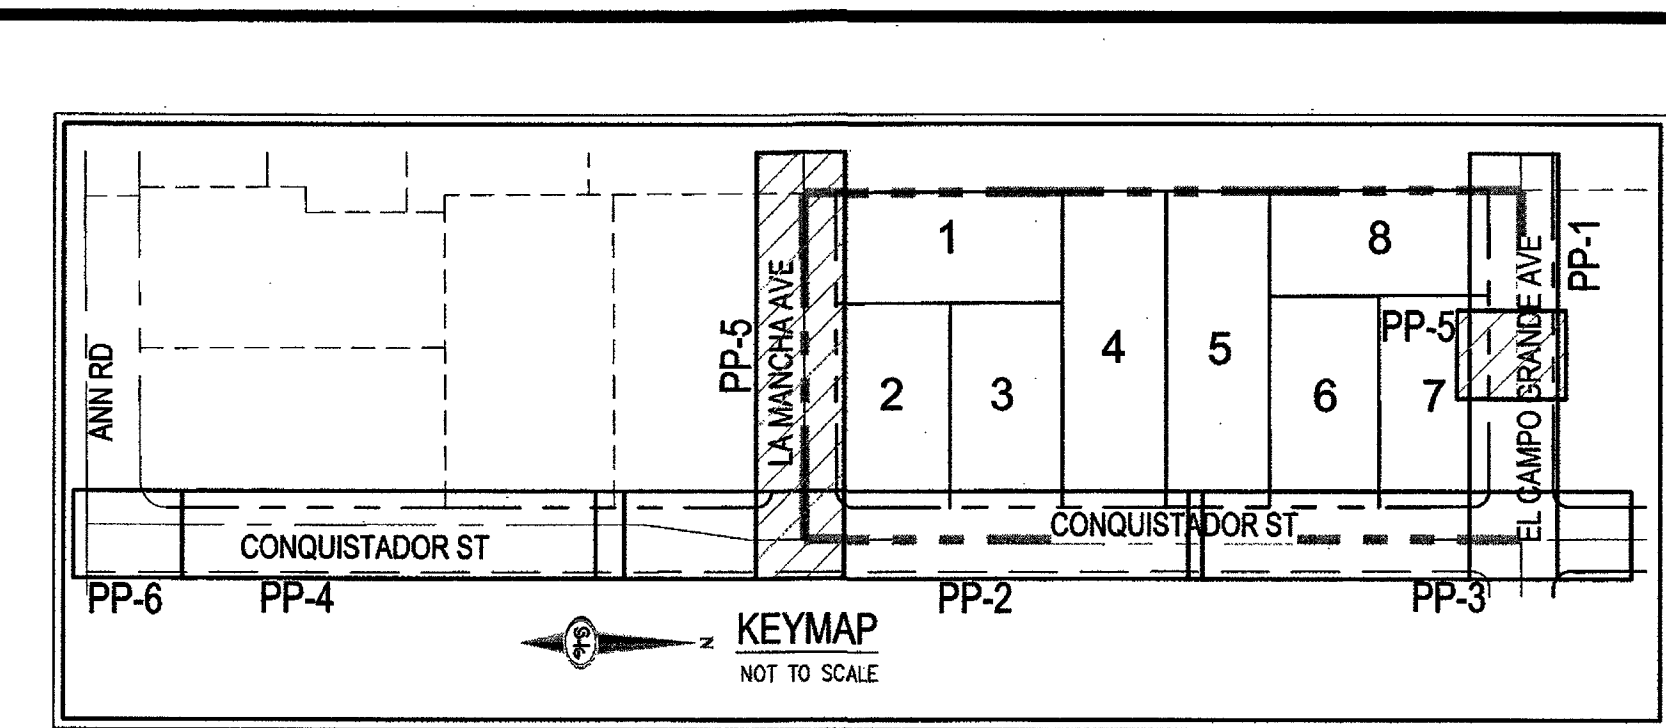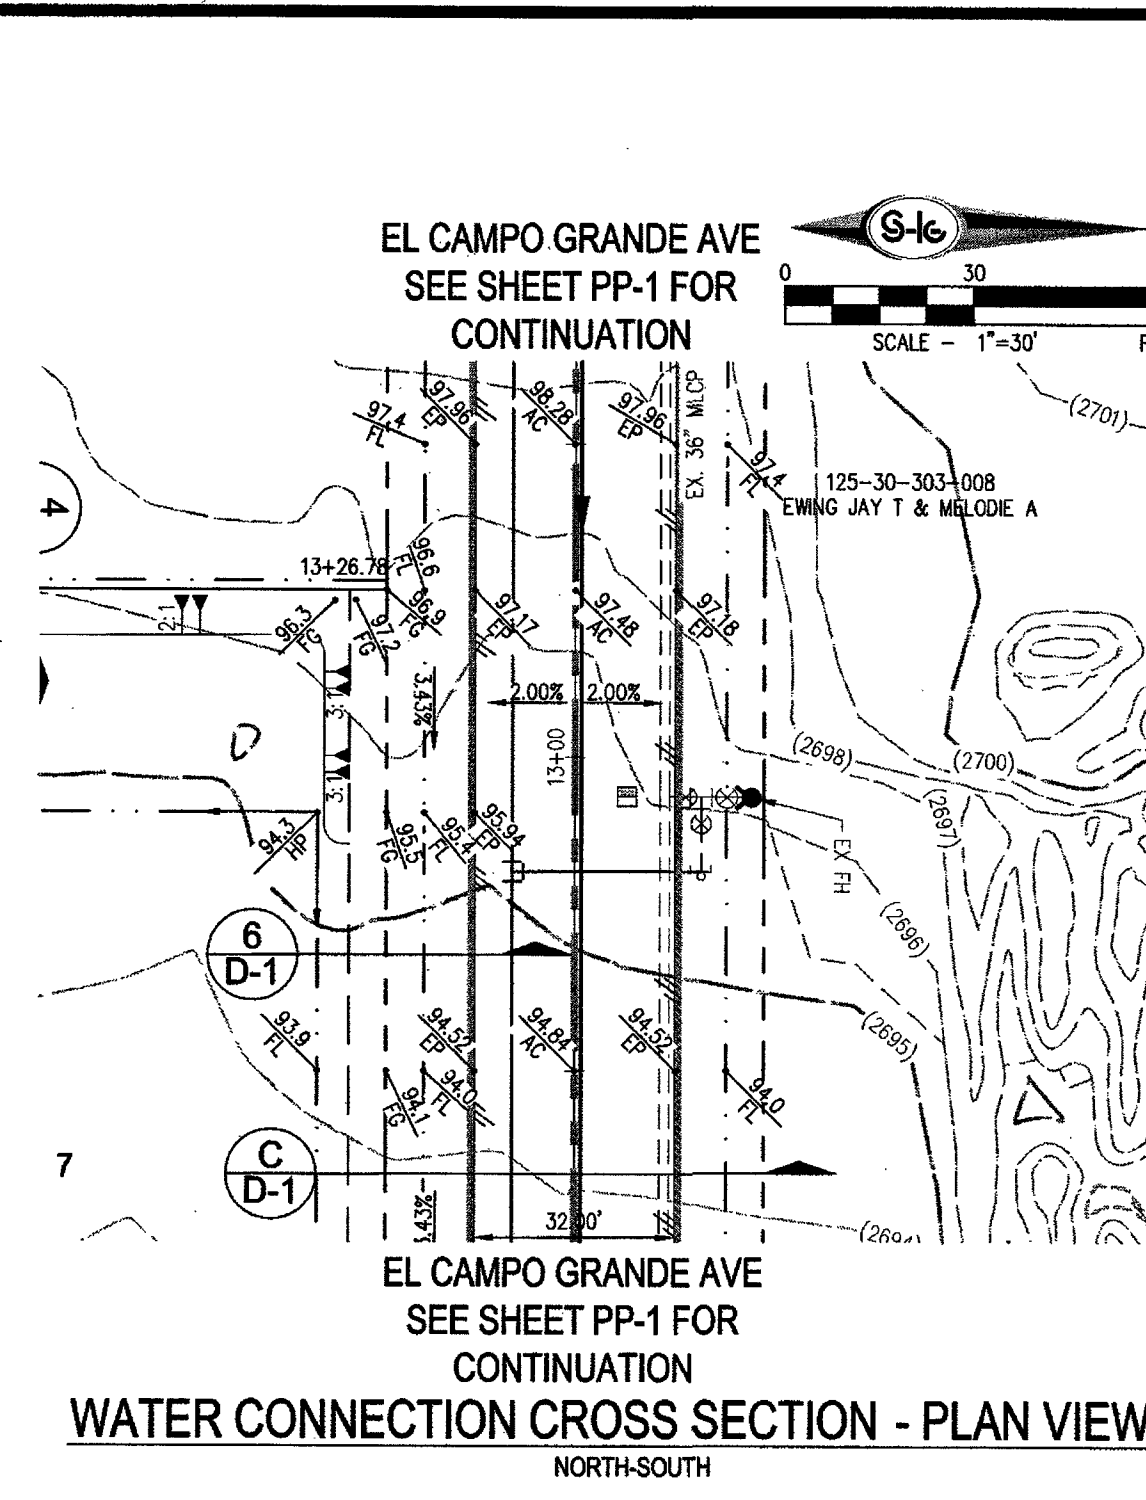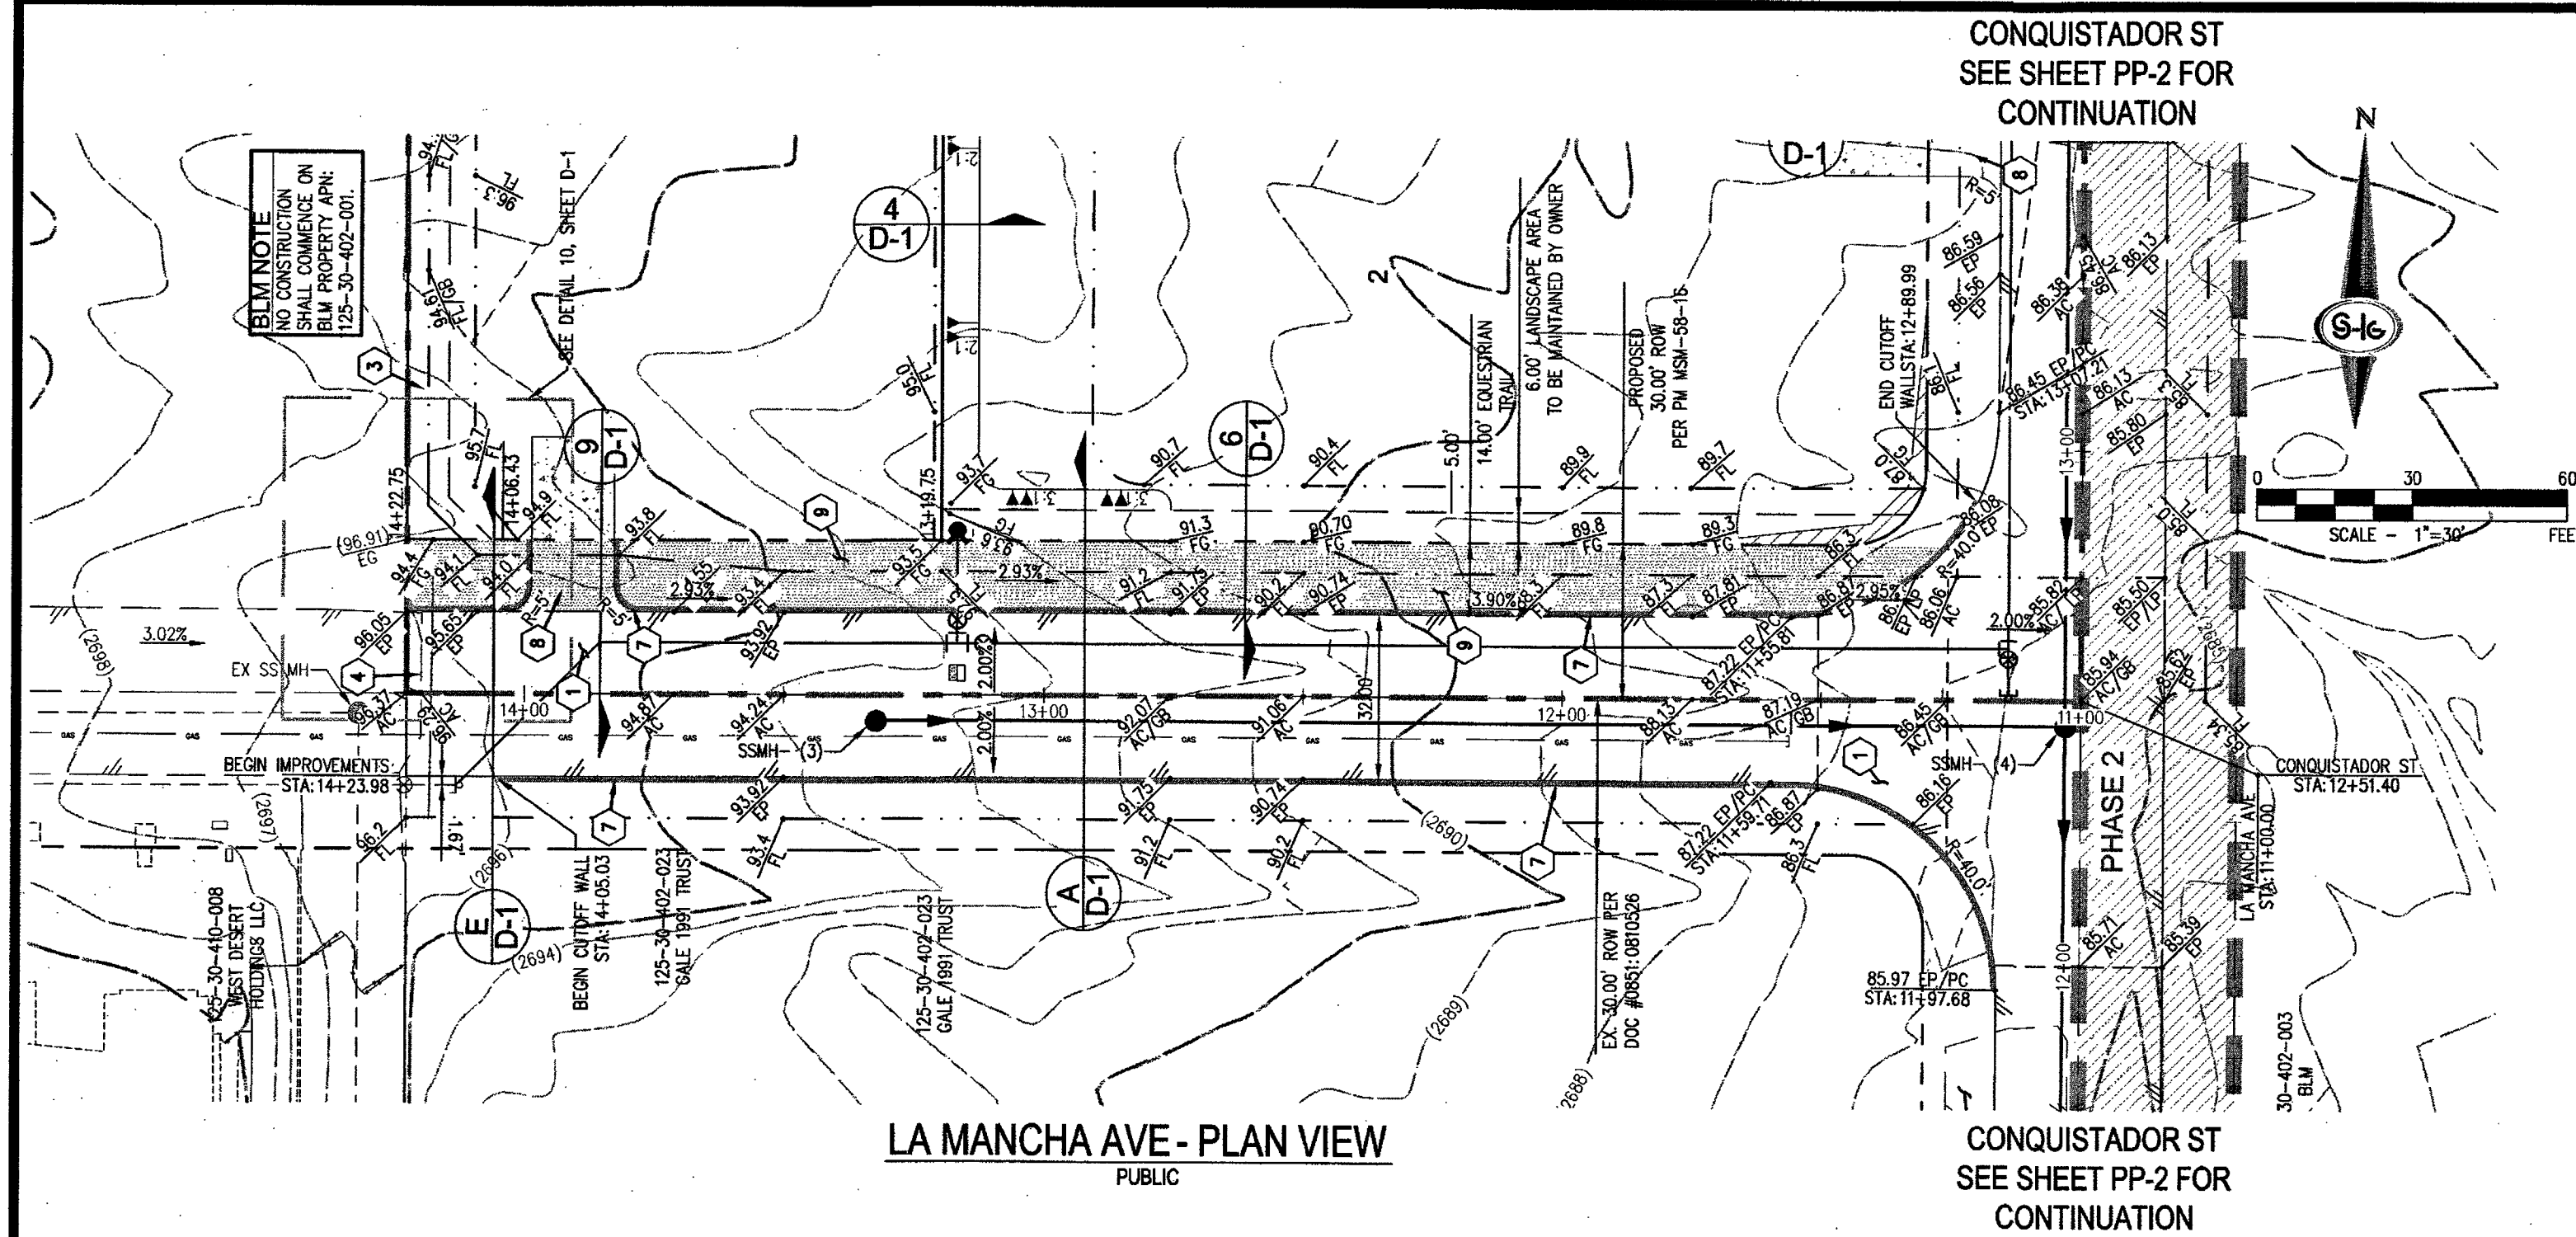

BLM NOTE (PHASE 2)

BLM GRANT N-74508.
NO CONSTRUCTION SHALL
COMMENCE ON BLM PROPERTY
UNTIL BLM PERMIT IS OBTAINED.

PHASE LINE

SOILS REPORT BY WRIGHT ENGINEERS PROJECT NO.
16102, DATED JULY 11, 2016

EARTHWORK QUANTITIES (RAW):
CUT= 4,797 CU YDS/ FILL= 5,130 CU YDS

LEGEND

ROADWAY CENTERLINE
RIGHT-OF-WAY
PROPERTY LINE
EQUESTRIAN TRAIL
FLOWLINE
EDGE OF PAVEMENT (EP)
SAWCUT LINE PER CCAUSD
NO. 503
PROPOSED ELEVATION
EXISTING ELEVATION
DESIGN SLOPE IN VERTICAL
CURVE
EXISTING CONTOUR (5-FT)
EXISTING CONTOUR (1-FT)
CUT/FILL TRANSITION LINE
FIRE HYDRANT ASSEMBLY
SIGHT VISIBILITY ZONE
WROUGHT IRON FENCE
RETAINING WALL
DECORATIVE PERIMETER WALL
RETAINING WALL

SEE SHEET C-3 FOR ABBREVIATIONS AND QUANTITIES

CONSTRUCTION NOTES

- CONSTRUCT 3" AC PAVEMENT WITH 4" TYPE II AGGREGATE BASE PER SOILS REPORT HTE 16-46660
- CONSTRUCT 4" WIDE DRAINAGE CHANNEL WITH WROUGHT IRON FENCE PER DETAILS 2 AND 7 ON SHEET D-1
- CONSTRUCT 7" WIDE DRAINAGE CHANNEL WITH WROUGHT IRON FENCE PER DETAILS 3 AND 8 ON SHEET D-1
- SAWCUT AND MATCH EXISTING IMPROVEMENTS PER CCAUSD NO. 500.3 AND 500.5
- PUBLIC DRAINAGE EASEMENT TO BE PRIVATELY MAINTAINED BY HOMEOWNER
- EXISTING PAVEMENT TO REMOVED
- CONSTRUCT 1.5' CUT-OFF WALL PER DETAIL 5 ON SHEET D-1
- CONSTRUCT 2" AC PAVEMENT OVER 4" TYPE II AGGREGATE BASE PER DETAILS 2 AND 7 ON SHEET D-1
- CONSTRUCT 2" AC PAVEMENT OVER 4" TYPE II AGGREGATE BASE PER DETAILS 2 AND 7 ON SHEET D-1
- CONSTRUCT 2" AC PAVEMENT OVER 4" TYPE II AGGREGATE BASE PER DETAILS 2 AND 7 ON SHEET D-1

SEWER NOTES

- INSTALL 60" DIAMETER (PUBLIC) SANITARY SEWER MANHOLE WITH (SINGLE 24" LID), ADD CORROSION PROTECTION PER DCSWCS 3.16.8 A OR B
- FIELD VERIFY LOCATION AND CONNECT TO EXISTING SEWER
- INSTALL 8" PVC (PUBLIC) SANITARY SEWER PIPE PER DCSWCS 50-17
- INSTALL 4" PVC SANITARY SEWER LATERAL PER DCSWCS 50-17, SD-22, SD-25
- INSTALL 48" DIAMETER (PUBLIC) SANITARY SEWER MANHOLE WITH PRECAST BASE PER DCSWCS 50-1A, SD-1R, SD-4 AND SD-9 (SINGLE 24" LID)
- INSTALL 8" SANITARY SEWER CAP AND THURST BLOCK PER DCSWCS SEC. 2.25 AND DETAIL ON SHEET U-1
- INSTALL REINFORCED CONCRETE ENCASUREMENT PER DCSWCS SD-14 AND UDACS SEC. 2.22.02 (C)
- INSTALL 8" C-900 (PUBLIC) SANITARY SEWER PIPE PER DCSWCS SD-17

FAST

Call before you Dig
Underground
1-702-432-5300
FREEWAY & ARTERIAL SYSTEM
OF TRANSPORTATION (F.A.S.T.)

Call before you Dig
AVOID CUTTING UNDERGROUND
UTILITY LINES. IT'S COSTLY.

Call
811
OR
1-800-227-2600

CLARK COUNTY DEPARTMENT OF
PUBLIC WORKS DEVELOPMENT REVIEW
ACCEPTANCE OF PLANS FOR FILING

BY _____

ACCEPTANCE OF THESE PLANS FOR FILING SHALL NOT BE CONSTRUED TO BE A PERMIT FOR OR AN APPROVAL OF ANY VIOLATION OF ANY OF THE PROVISIONS OF THE STATE OR COUNTY LAWS AND/OR SPECIFICATIONS CLARK COUNTY SHALL BE HELD FREE FROM DAMAGES WHICH MAY RESULT FROM THE CONSTRUCTION OF THE IMPROVEMENTS FROM THE ENGINEERING DESIGN DEPICTED HEREIN.

NOTE: POWER POLES AND/OR OTHER EXISTING FACILITIES NOT IN PROPER LOCATION BASED ON PROPOSED IMPROVEMENTS SHOWN HEREIN WILL BE RELOCATED AT NO EXPENSE TO CLARK COUNTY

AVOID HITTING OVERHEAD
POWER LINES. IT'S
COSTLY.

Call before you Dig
Underground
1-702-227-2929

APPROVED FOR CONSTRUCTION

DATE 5/11/17 PROJECT No. 124637
LVWD APPROVED FIRE FLOW 2,250 GPM AT 20 PSI RESIDUAL

DISCLAIMER NOTE



- EXISTING UTILITY LOCATIONS SHOWN HEREON ARE APPROXIMATE ONLY. IT SHALL BE THE CONTRACTOR'S RESPONSIBILITY TO DETERMINE THE EXACT VERTICAL AND HORIZONTAL LOCATION OF ALL EXISTING UNDERGROUND UTILITIES PRIOR TO COMMENCING CONSTRUCTION. NO REPRESENTATION IS MADE THAT ALL EXISTING UTILITIES ARE SHOWN HEREON. THE ENGINEER ASSUMES NO RESPONSIBILITY FOR UTILITIES NOT SHOWN IN THEIR PROPER LOCATION.
- FOR ROADWAY WIDENING AND HALF STREET IMPROVEMENTS THE CONTRACTOR SHALL VERIFY CROSS SLOPES FROM EXISTING PAVEMENT SAWCUT LINE TO PROPOSED EDGE OF PAVEMENT OR PROPOSED CURB PRIOR TO SUBGRADE PREPARATION AND CONSTRUCTION OF PROPOSED CURB LINE. IF MINIMUM OR MAXIMUM CROSS SLOPES DO NOT MEET AGENCY STANDARDS THE CONTRACTOR SHALL NOTIFY THE ENGINEER.

BENCHMARK

BENCHMARK NUMBER: 1030 3056
RIVET AND SQUARE ALUMINUM PLATE IN A 4' X 4' CONCRETE ELECTRIC PAD AT 9620 EL CAMPO GRANDE AVENUE, 30' NORTH AND 170' WEST OF GRAND CANYON DRIVE AND EL CAMPO GRANDE AVENUE.
ELEVATION = 2655.329 FEET, 809.346 METERS
N.A.V.D. 88 DATUM PER THE CLARK COUNTY VERTICAL CONTROL V.2003

BASIS OF BEARING

NORTH 00°39'20" EAST, BEING THE BEARING ON THE WEST LINE OF THE SOUTHWEST QUARTER (SW4) OF THE SOUTHEAST QUARTER (SE4) OF SECTION 30, TOWNSHIP 19 SOUTH, RANGE 60 EAST, M.D.M., CLARK COUNTY, NEVADA, AS SHOWN BY MAP THEREOF IN FILE 115, PAGE 93 OF SURVEYS IN THE CLARK COUNTY RECORDER'S OFFICE, NEVADA.

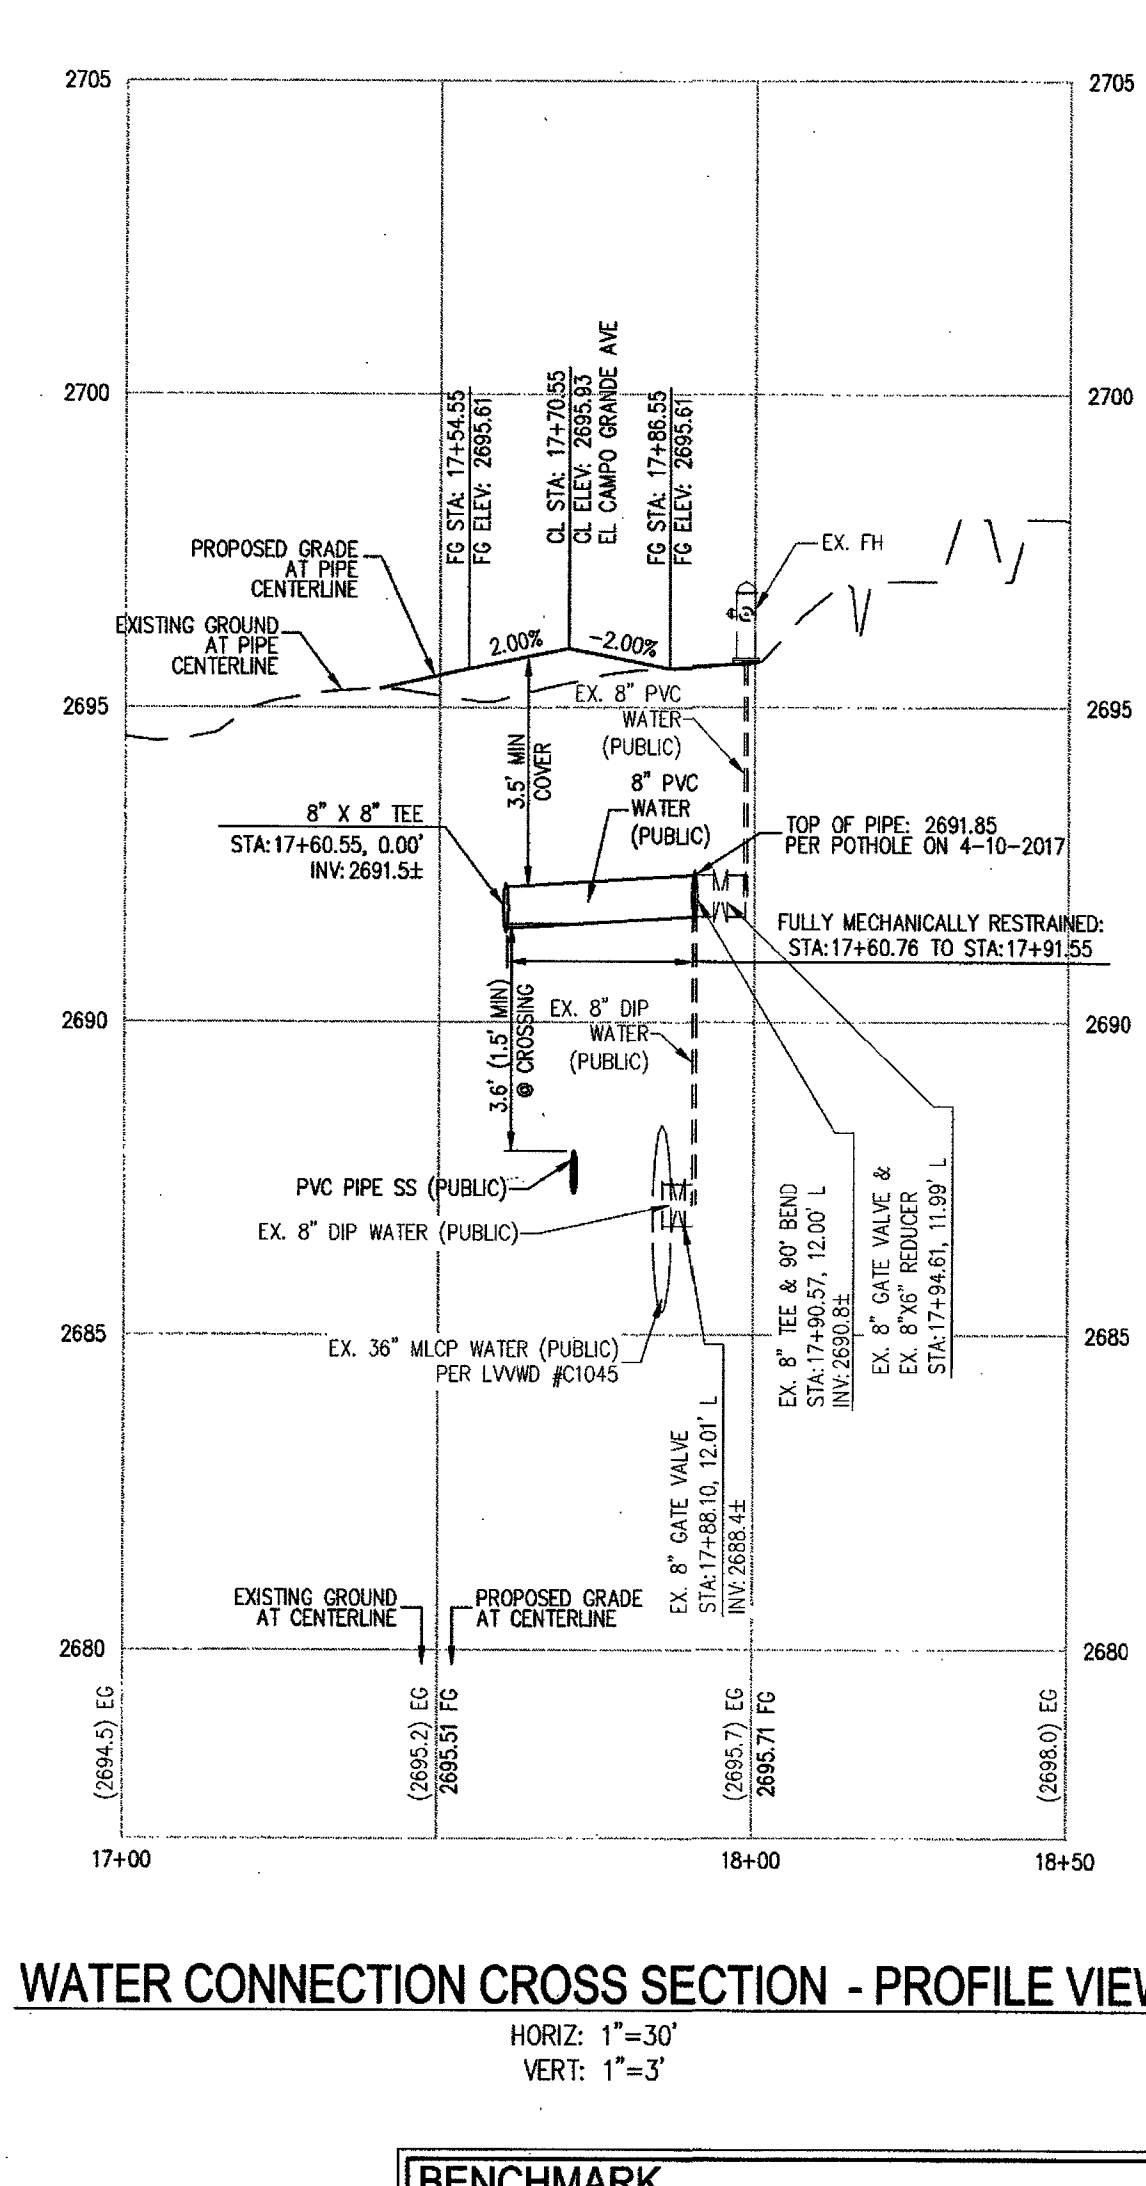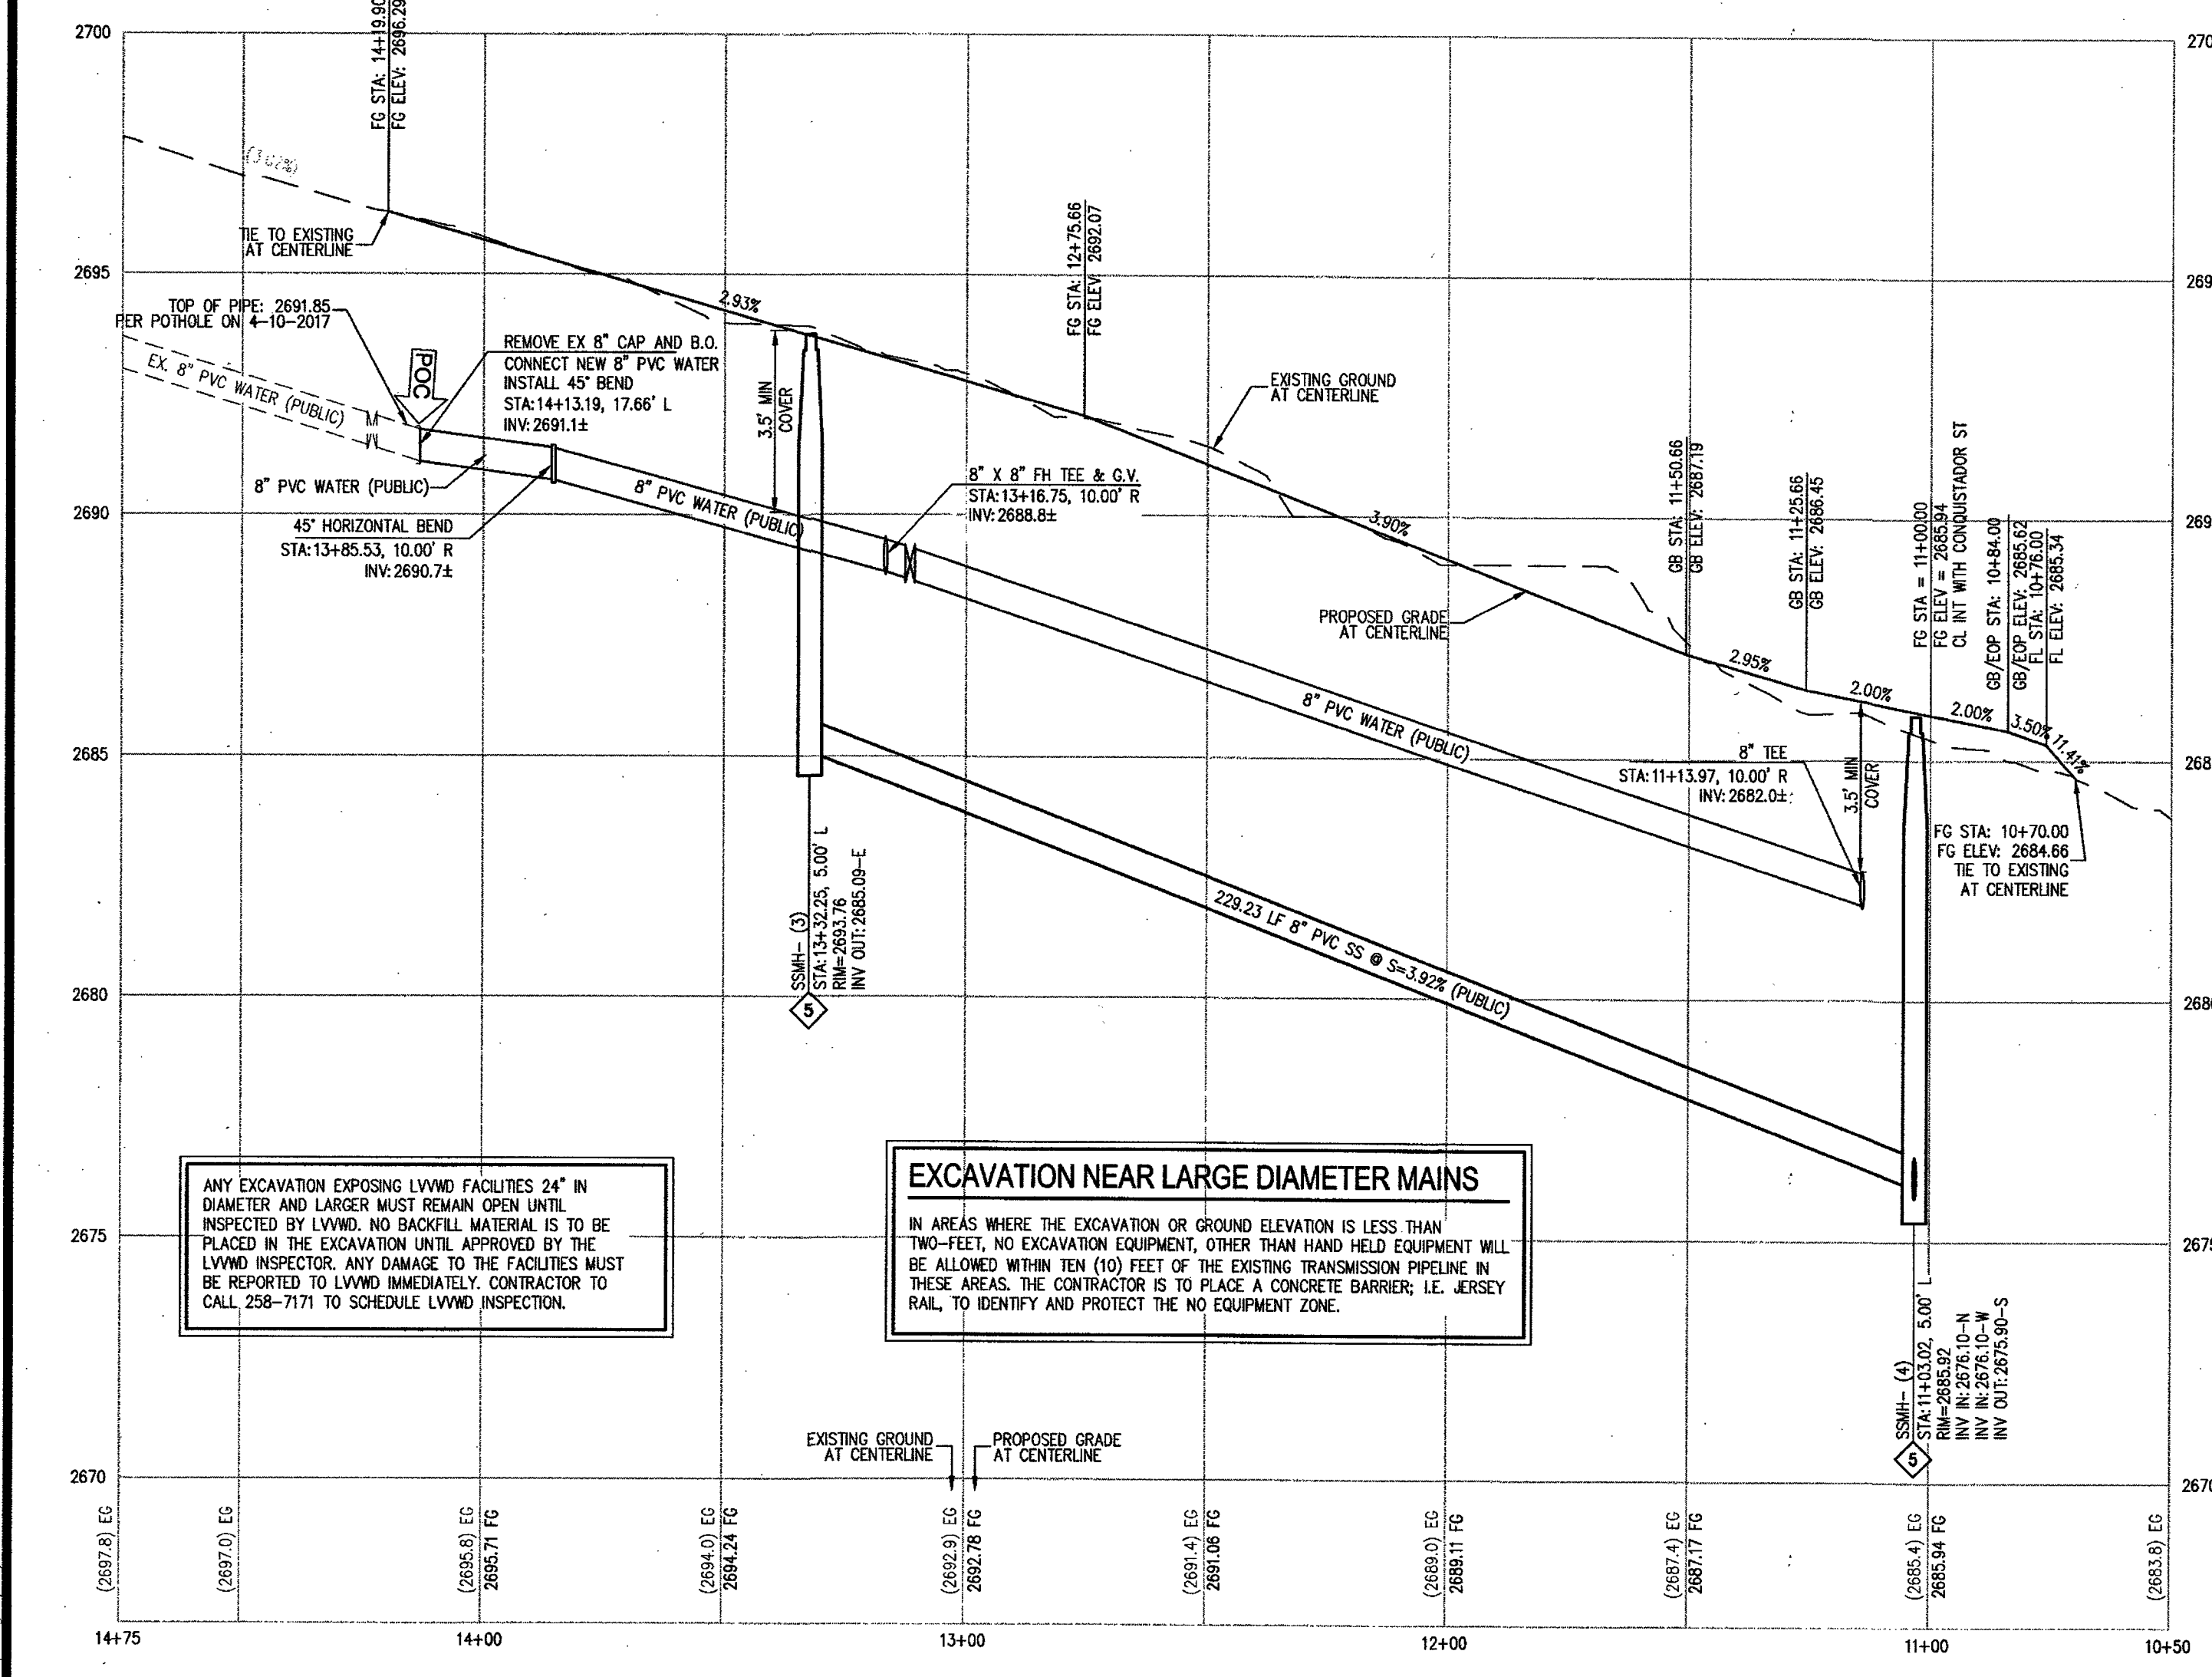

**SLATER
HANIFAN
GROUP**

CONSULTING ENGINEERS & PLANNERS

5740 S. ARVILLE STREET #216, LAS VEGAS, NV 89118
PHONE (702) 284-5300 FAX (702) 284-5399


PINNACLE HOMES

ELK RIDGE ESTATES I

PLAN AND PROFILE - LA MANCHA AVE

DATE: 4/17/2017
DRAFTER: KMB
DESIGNER: KMB
CHECKED: TJS
PROJECT NO.
PIN1602

PP-5
SHEET 11 OF 15
HTE # 16-46666

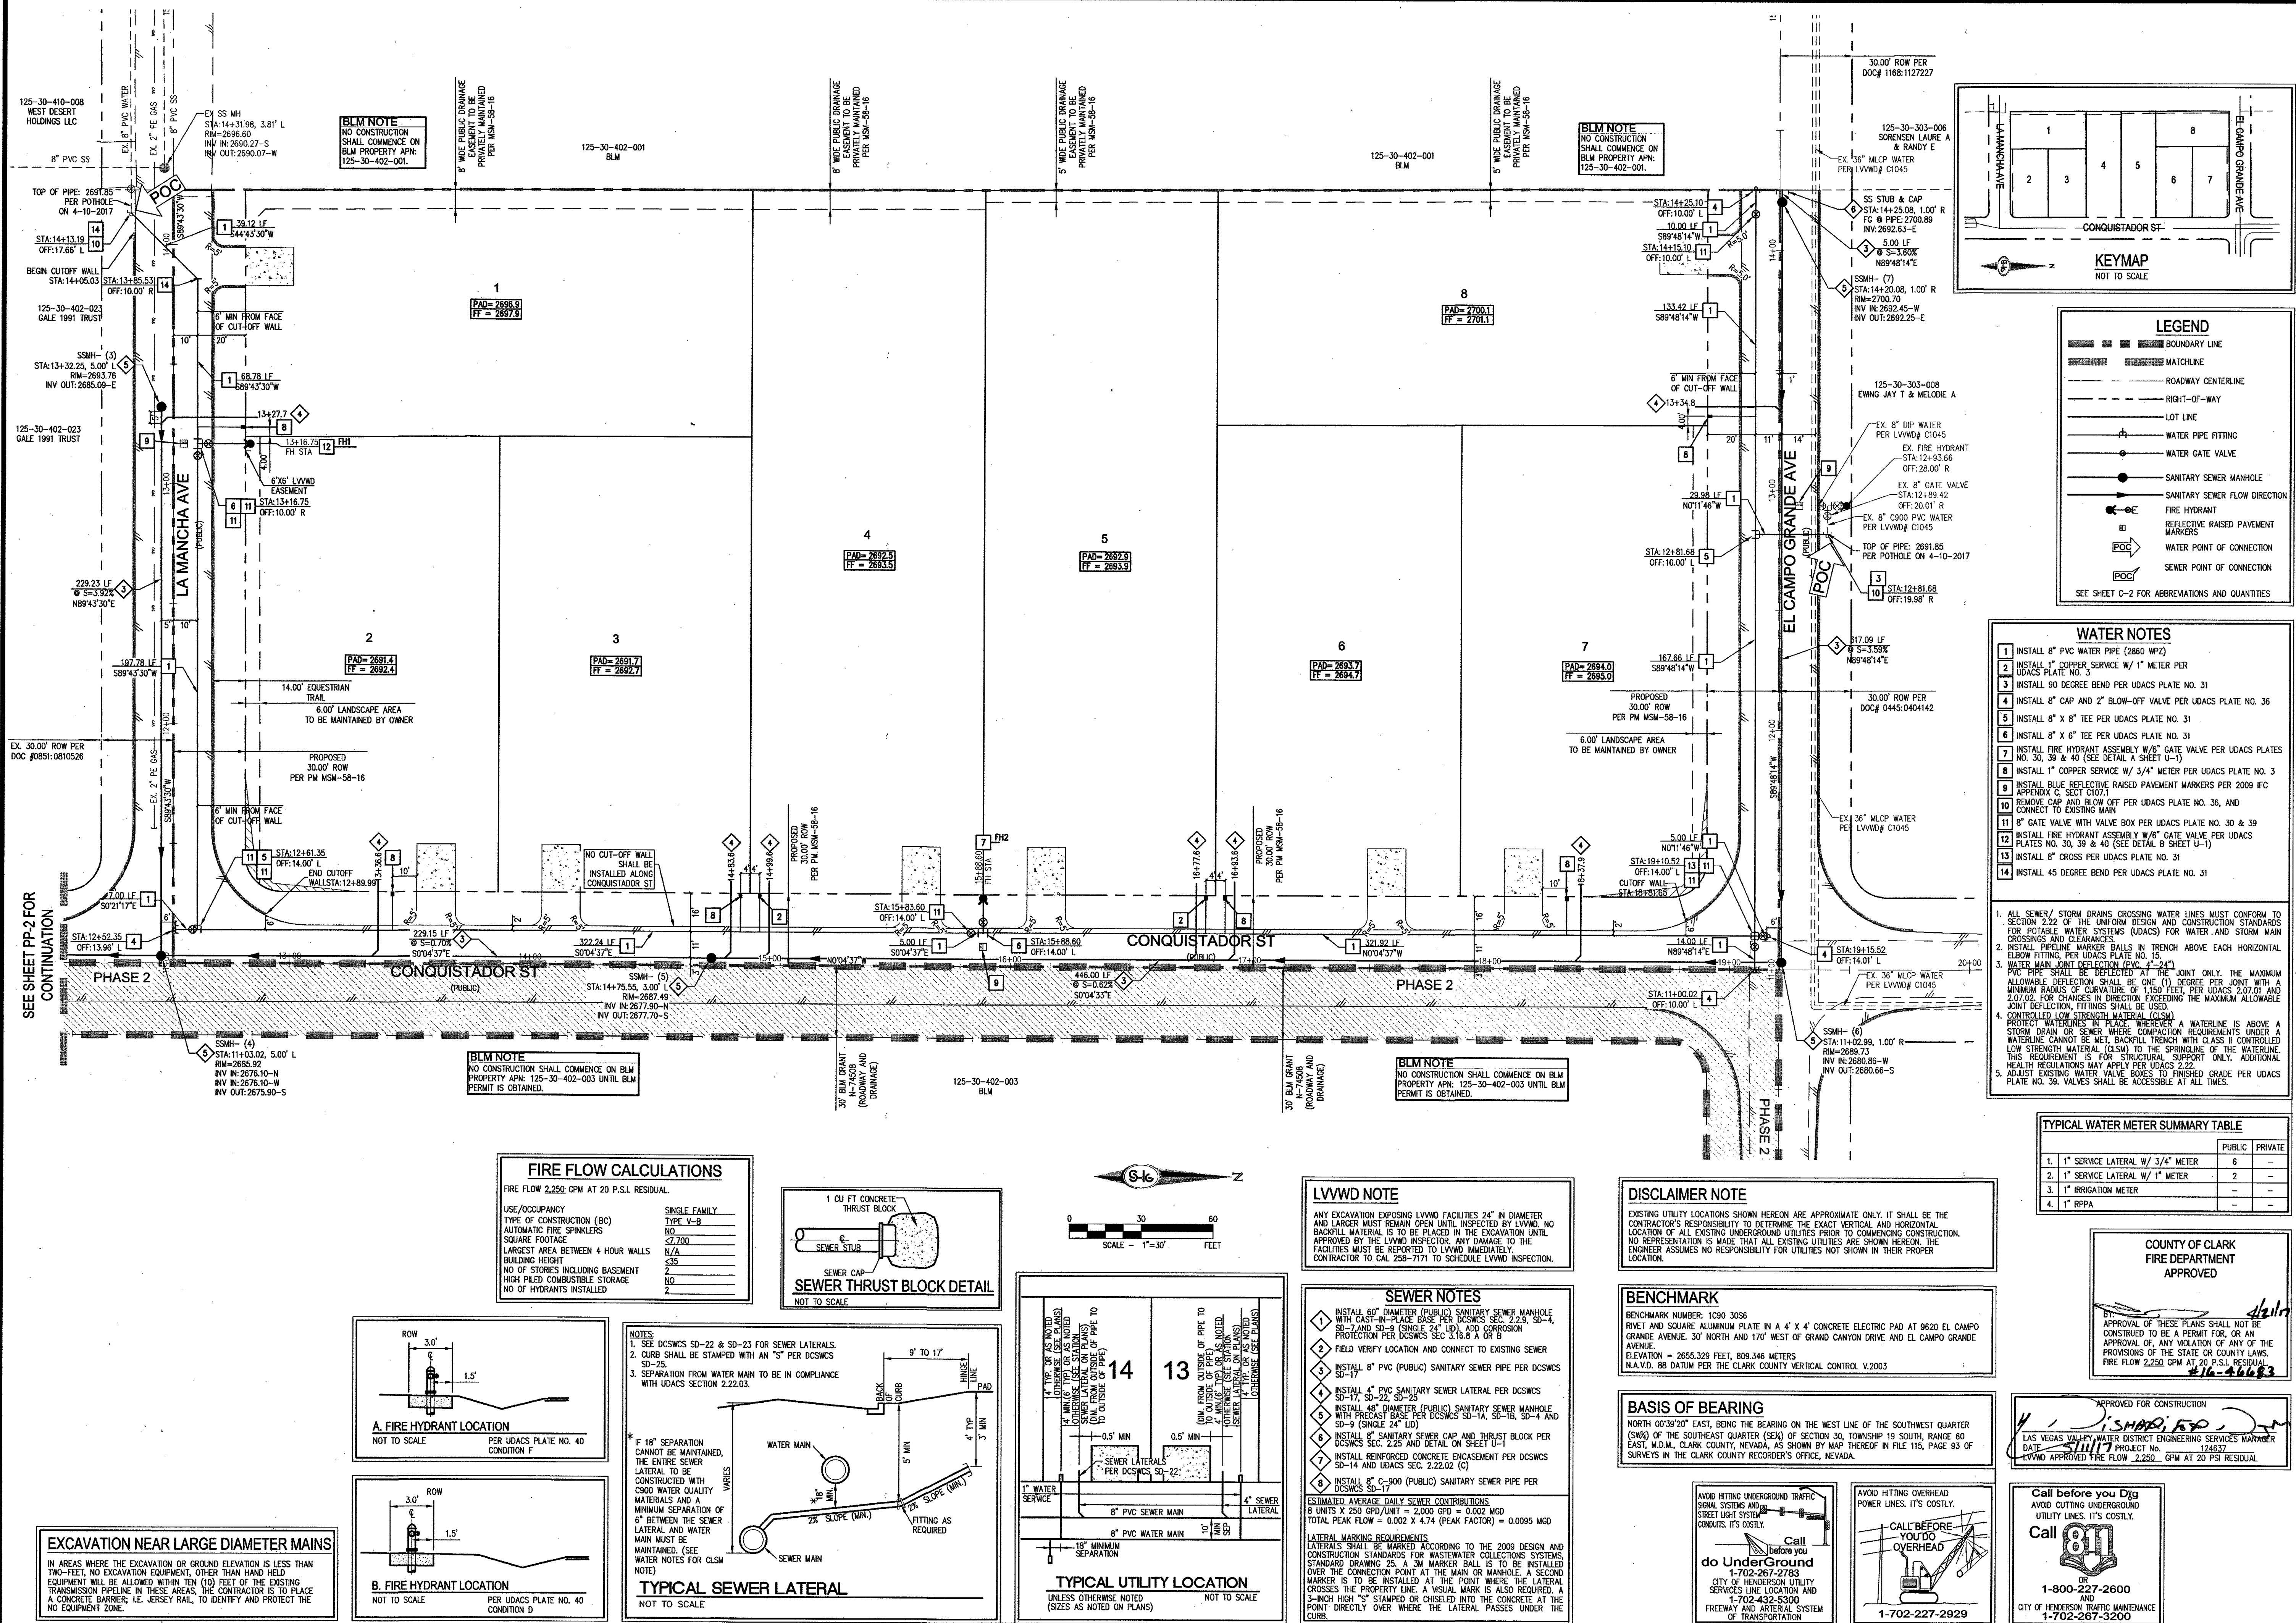[illegible]

PINNACLE HOMES
ELK RIDGE ESTATES I
UTILITY PLAN

		PUBLIC	PRIVATE
1.	1" SERVICE LATERAL W/ 3/4" METER	6	—
2.	1" SERVICE LATERAL W/ 1" METER	2	—
3.	1" IRRIGATION METER	—	—
4.	1" RPPA	—	—

COUNTY OF CLARK
FIRE DEPARTMENT
APPROVED

BY:  4/2/17
APPROVAL OF THESE PLANS SHALL NOT BE
CONSTRUED TO BE A PERMIT FOR, OR AN
APPROVAL OF, ANY VIOLATION OF ANY OF THE
PROVISIONS OF THE STATE OR COUNTY LAWS.
FIRE FLOW 2.250 GPM AT 20 P.S.I. RESIDUAL
#16-36683

APPROVED FOR CONSTRUCTION

LAS VEGAS VALLEY WATER DISTRICT ENGINEERING SERVICES MANAGER
DATE 5/11/17 PROJECT No. 124637
LVWD APPROVED FIRE FLOW 2,250 GPM AT 20 PSI RESIDUAL

Call before you Dig
AVOID CUTTING UNDERGROUND
UTILITY LINES. IT'S COSTLY.
Call 811
OR
1-800-227-2600
AND
CITY OF HENDERSON TRAFFIC MAINTENANCE
1-702-267-3200

U-1
SHEET 13 OF 15
HTF #16-46686 | H#68923

ROJ#:124637 AGR:116142 QS:125-30-SW XC 11294

