

CITY OF LAS VEGAS STREETLIGHT NOTES

1. ALL STREET LIGHTING INSTALLATIONS SHALL BE IN ACCORDANCE WITH THE STREET LIGHTING PLANS, THE UNIFORM STANDARD SPECIFICATIONS FOR PUBLIC WORKS CONSTRUCTION OFF-SITE IMPROVEMENTS, CLARK COUNTY AREA, NEVADA, LATEST REVISION, AND THE UNIFORM STANDARD DRAWINGS FOR PUBLIC WORKS CONSTRUCTION OFF-SITE IMPROVEMENTS, CLARK COUNTY AREA, NEVADA, LATEST REVISION, AND ANY ADOPTED SPECIAL AREA STANDARDS.
2. NO DEVIATION OF STREET LIGHT, PULL BOX, CONDUITS (ETC.) LOCATIONS SHALL BE PERMITTED WITHOUT WRITTEN APPROVAL OF TRAFFIC ENGINEERING AND THE CITY ENGINEER.
3. ALL EXISTING STREET LIGHTING SHALL REMAIN OPERATIONAL DURING CONSTRUCTION.
4. ALL STREET LIGHTING CONDUITS STUB SHALL HAVE AT LEAST ONE GREEN #8 THW FIRE INSTALLED, AS TRACER WIRE. WHEN EMPTY CONDUIT IS COMPLETELY INSTALLED FROM PB TO PB, IT SHALL HAVE MINIMUM OF 2 #4 AND 1 #8 THW WIRE WITH THE ENDS TAPPED OR "SAFE OFF" PRIOR TO FINAL INSPECTION.
5. ANY STRUCTURE SUCH AS BLOCK WALLS, CHAIN LINK FENCES, RETAINING WALLS, ETC., SHALL LEAVE A MINIMUM CLEARANCE IN ACCORDANCE WITH THE USD NO. 320A.
6. AS-BUILT DRAWINGS SHALL BE SUPPLIED TO THE TESTO PRIOR TO ANY PRE-FINAL INSPECTION. THE AS-BUILT DRAWING NEEDS TO BE STAMPED AS-BUILT AND SIGNED BY THE PREPARER.
7. SERVICE POINT SHALL BE COORDINATED WITH NV ENERGY COMPANY, AND WHEREVER POSSIBLE, BE LOCATED NEAR THE CENTER OF THE CIRCUIT. SERVICE POINTS SHALL BE SHOWN ON THE CIVIL PLANS.
8. IT SHALL BE ASSUMED THAT IN THE ABSENCE OF AN EXISTING, WORKABLE CIRCUIT TO ATTACH TO, ALL INSTALLATIONS SHALL REQUIRE A NEW SERVICE FOR OPERATION OF THE CIRCUIT.
9. WHEREVER THERE IS AN OVERHEAD UTILITY THAT MAY CONFLICT WITH THE INSTALLATION OF STREET LIGHTING CIRCUITS AND/OR POLES, THESE CONFLICTS MUST BE RESOLVED BETWEEN THE DEVELOPER AND THE UTILITIES INVOLVED, AT NO EXPENSE TO THE CITY OF LAS VEGAS, BEFORE STREETLIGHT BASES ARE INSTALLED.
10. THE CONTRACTOR SHALL FURNISH COMPLETE SERVICE TO TRANSFORMERS AND CONTROL SYSTEMS IF REQUIRED ON PLANS.
11. THE DEVELOPER/OWNER WILL BE REQUIRED TO SUPPLY POWER TO ALL NEW PUBLIC STREET LIGHTS INSTALLED UNDER THIS DESIGN PRIOR TO BOND RELEASE OR PROJECT COMPLETION. THE DEVELOPER/OWNER WILL BE RESPONSIBLE FOR ALL ITEMS ASSOCIATED WITH THE INSTALLATION, CONSTRUCTION, ENERGIZING, MAINTENANCE AND OPERATIONAL COST OF SAID STREET LIGHTS PRIOR TO PROJECT COMPLETION. REFER TO THE PLAN FOR ANY NEW SERVICE REQUIREMENTS. THE TRANSFER OF OWNERSHIP FROM THE DEVELOPER/OWNER TO THE CITY OF LAS VEGAS FOR ALL NEW PUBLIC STREET LIGHTS AND/OR SERVICE/S INSTALLED UNDER THIS PLAN DESIGN WILL BE IN CONJUNCTION WITH THIS PROJECT COMPLETION. COORDINATE ALL MAINTENANCE AND OPERATIONAL TRANSFERS WITH THE CITY OF LAS VEGAS TRAFFIC ENGINEERING DEPARTMENT (TED) AT (702) 229-6331.

REVISED 04/15/10

CITY OF LAS VEGAS GRADING NOTES

1. IN THE EVENT THAT ANY UNFORESEEN CONDITIONS NOT COVERED BY THESE NOTES ARE ENCOUNTERED DURING GRADING OPERATIONS, THE OWNER/ENGINEER SHALL BE IMMEDIATELY NOTIFIED FOR DIRECTION.
2. IT SHALL BE THE RESPONSIBILITY OF THE CONTRACTOR TO PERFORM ALL NECESSARY CUTS AND FILLS WITHIN THE LIMITS OF THIS PROJECT AND THE RELATED OFF-SITE WORK, SO AS TO GENERATE THE DESIRED SUBGRADE, FINISH GRADES AND SLOPES SHOWN.
3. CONTRACTOR SHALL TAKE FULL RESPONSIBILITY FOR ALL EXCAVATION. ADEQUATE SHORING SHALL BE DESIGNED AND PROVIDED BY THE CONTRACTOR TO PREVENT UNDERMINING OF ANY ADJACENT FEATURES OR FACILITIES AND/OR CAVING OF THE EXCAVATION.
4. THE CONTRACTOR IS WARNED THAT AN EARTHWORK BALANCE WAS NOT NECESSARILY THE INTENT OF THIS PROJECT. ANY ADDITIONAL MATERIAL REQUIRED OR LEFTOVER MATERIAL FOLLOWING EARTHWORK OPERATIONS BECOMES THE RESPONSIBILITY OF THE CONTRACTOR.
5. THE GRADING CONTRACTOR IS RESPONSIBLE TO COORDINATE WITH THE OWNER TO PROVIDE FOR THE REQUIREMENTS OF THE PROJECT STORM WATER POLLUTION PREVENTION PLAN (SWPPP) AND ASSOCIATED PERMIT.
6. CONTRACTOR SHALL GRADE TO THE LINES AND ELEVATIONS SHOWN ON THE PLANS WITHIN THE FOLLOWING HORIZONTAL AND VERTICAL TOLERANCES AND DEGREES OF COMPACTION, IN THE AREAS INDICATED:

	HORIZONTAL	VERTICAL	COMPACTION
A. PAVEMENT AREA SUBGRADE	0.1+/-	+0.0 TO -0.1"	SEE SOILS REPORT
B. ENGINEERED FILL	0.5+/-	+0.1 TO -0.1"	SEE SOILS REPORT

COMPACTION TESTING WILL BE PERFORMED BY THE OWNER OR HIS REPRESENTATIVE.
7. ALL CUT AND FILL SLOPES SHALL BE PROTECTED UNTIL EFFECTIVE EROSION CONTROL HAS BEEN ESTABLISHED.
8. THE USE OF POTABLE WATER WITHOUT A SPECIAL PERMIT FOR BUILDING OR CONSTRUCTION PURPOSES INCLUDING CONSOLIDATION OF BACKFILL OR DUST CONTROL IS PROHIBITED. THE CONTRACTOR SHALL OBTAIN ALL NECESSARY PERMITS FOR CONSTRUCTION WATER.
9. THE CONTRACTOR SHALL MAINTAIN THE STREETS, SIDEWALKS AND ALL OTHER PUBLIC RIGHT-OF-WAY IN A CLEAN, SAFE AND USABLE CONDITION. ALL SPILLS OF SOIL, ROCK OR CONSTRUCTION DEBRIS SHALL BE PROMPTLY REMOVED FROM THE PUBLICLY OWNED PROPERTY DURING CONSTRUCTION AND UPON COMPLETION OF THE PROJECT. ALL ADJACENT PROPERTY, PRIVATE OR PUBLIC SHALL BE MAINTAINED IN A CLEAN, SAFE AND USABLE CONDITION.
10. IN THE EVENT THAT ANY TEMPORARY CONSTRUCTION ITEM IS REQUIRED THAT IS NOT SHOWN ON THESE DRAWINGS, THE OWNER AGREES TO PROVIDE AND INSTALL SUCH ITEM AT HIS OWN EXPENSE AND AT THE DIRECTION OF THE CITY ENGINEER. TEMPORARY CONSTRUCTION INCLUDES DITCHES, BERM, ROAD SIGNS AND BARRICADES, ETC.

REVISED 04/15/10

CITY OF LAS VEGAS SEWER NOTES

1. ALL CONSTRUCTION AND MATERIALS SHALL BE IN ACCORDANCE WITH THE LATEST EDITION OF THE DESIGN AND CONSTRUCTION STANDARDS FOR WASTEWATER COLLECTION SYSTEMS AND THE UNIFORM STANDARD SPECIFICATIONS FOR PUBLIC WORKS CONSTRUCTION OFF-SITE IMPROVEMENTS, CLARK COUNTY AREA, NEVADA, AS AMENDED. IT WILL BE THE RESPONSIBILITY OF THE CONTRACTOR TO BE AWARE OF THE CONTENTS OF THE ABOVE SPECIFICATIONS.
2. IT SHALL BE THE CONTRACTOR'S RESPONSIBILITY TO PERFORM CONSTRUCTION AS PER PLANS. ANY ADDITIONS, DELETIONS, OR CHANGES SHALL FIRST MEET WITH THE APPROVAL OF THE CITY ENGINEER.
3. CHISEL S"OR G"IN CURBS WHERE SEWER OR GAS LATERALS PASS UNDER THE CURB.
4. POLYVNYL (PVC) SEWER PIPE SHALL MEET ASTM D-3034 SDR 35 SPECIFICATIONS, INSTALLED WITH SAND BEDDING AND BACKFILL OF TYPE II AGGREGATE.
5. ALL MANHOLES PAVED IN STREETS EIGHTY (80) FOOT R/W AND LARGER SHALL HAVE CONCRETE COLLARS. STREETS LESS THAN EIGHTY (80) FOOT R/W WILL REQUIRE RETROFIT IF PAVING DOES NOT CONFORM TO CITY STANDARDS AT THE MANHOLE.
6. TEE SADDLES SHALL BE USED TO CONNECT SEWER LATERALS TO EXISTING MAIN LINES UP TO TWELVE INCH (12) DIAMETER. CONNECTIONS TO FIFTEEN INCH (15) OR LARGER MAINS SHALL REQUIRE SPECIAL PROCEDURES. IN LINE "Y" SHALL BE USED ON LINES TWELVE INCHES (12) OR ABOVE.
7. WATER MAINS SHALL BE PROTECTED IN ACCORDANCE WITH LVVWD STANDARDS WHENEVER A SEWER MAIN CROSSES OVER A WATER MAIN OR THE SEWER IS LESS THAN EIGHTEEN INCH (18") UNDER A WATER MAIN.
8. ALL CONTRACTORS INSTALLING SEWER MAINS THAT WILL BE UNDER THE JURISDICTION OF THE CITY OF LAS VEGAS MUST BE STATE OF NEVADA CLASS "A" CONTRACTORS.
9. THE CITY OF LAS VEGAS WILL NOT ACCEPT ANY SEWER MAINS WHICH HAVE A VERTICAL DEFLECTION OF MORE THAN TEN TENTH (0.1) OF A FOOT FROM THE APPROVED CONSTRUCTION PLANS AT ANY LOCATION. SEWER MAINS FOUND TO EXCEED THIS TOLERANCE WILL HAVE TO BE REPAIRED OR REMOVED OR REPLACED TO THE SATISFACTION OF THE CITY ENGINEER PRIOR TO ACCEPTANCE BY THE CITY OF LAS VEGAS.
10. INSTALLATION OF CURVED SEWER REQUIRES THE USE OF C-900 PIPE WHICH ALLOWS FOR PIPE DEFLECTION AT THE JOINTS.

REVISED 04/15/10

CITY OF LAS VEGAS FIRE DEPARTMENT NOTES

1. ALL WORK SHALL BE DONE IN STRICT ACCORDANCE WITH THE LAS VEGAS FIRE & RESCUE ADOPTED FIRE CODE, ORDINANCE #6325 FOR HYDRANT SPECIFICATIONS AND HYDRANT INSTALLATION SPECIFICATIONS.
2. ONLY FIRE HYDRANTS THAT ARE ON THE LAS VEGAS VALLEY WATER DISTRICT'S - APPROVED PRODUCTS LIST ARE ALLOWED TO BE INSTALLED.
3. A PERMIT IS REQUIRED FROM LAS VEGAS FIRE & RESCUE FOR THE INSTALLATION OF ON-SITE WATER LINES AND FIRE HYDRANTS. THE PERMIT AND CONTRACTORS MATERIAL TEST CERTIFICATE FOR UNDERGROUND PIPING FORM SHALL BE OBTAINED FROM THE FIRE PROTECTION ENGINEER BEFORE COMMENCEMENT OF WORK. [IFC § 105.7.12]
4. ON ANY RESIDENTIAL OR COMMERCIAL INSTALLATIONS, FIRE HYDRANTS SHALL BE INSTALLED AND FIRE APPARATUS ACCESS ROADS SHALL BE MAINTAINED BEFORE COMMENCEMENT OF ANY COMBUSTIBLE CONSTRUCTION. ALL FIRE HYDRANTS SHALL BE IN GOOD WORKING ORDER AND SHALL BE CAPABLE OF DELIVERING THE REQUIRED FIRE FLOW. [IFC § 3310, § 3312]
5. TO IDENTIFY THE FIRE HYDRANT LOCATIONS, THE CONTRACTOR SHALL PLACE A BLUE REFLECTIVE MARKER AT THE CENTER LINE OF STREET ADJACENT TO THE FIRE HYDRANTS. [IFC § 507.5.7.3]
6. ALL UNDERGROUND INSPECTIONS, PRESSURE AND FLUSH VERIFICATIONS OF ALL FIRE HYDRANTS AND FIRE LINES, SHALL BE CONDUCTED BEFORE COVERING THE LINES. CENTER LOADING IS ACCEPTABLE FOR THE HYDRO TESTS WITH PRIOR FIRE PREVENTION APPROVAL. [IFC § 108.3]
7. ALL ON-SITE UNDERGROUND WATER MAINS AND MATERIALS SHALL BE U.L. LISTED A.W.W.A. APPROVED AND SHALL BE RATED FOR THE APPROPRIATE WORKING PRESSURE. [IFC § 507.2.1, NFPA 24]
8. PAINTING OF CURBS, FIRE HYDRANTS, PADS, PROTECTION OF FIRE HYDRANTS FROM PHYSICAL DAMAGE, AND ALL OTHER WORK NECESSARY PER PLANS SHALL BE COMPLETED BEFORE APPROVAL BY LAS VEGAS FIRE AND RESCUE, FIRE PREVENTION DIVISION. [IFC § 507]
9. PRIVATE HYDRANTS SHALL BE PAINTED RED. [IFC § 507.5.7.1]
10. PRIOR TO THE FINAL OCCUPANCY, A FIRE FLOW TEST SHALL BE WITNESSED BY LAS VEGAS FIRE AND RESCUE, FIRE PREVENTION DIVISION TO VERIFY AVAILABILITY OF THE REQUIRED FIRE FLOW. [IFC § 507]
11. FIRE HYDRANT SPACING SHALL BE AS FOLLOWS: [IFC § C102]

	RESIDENTIAL	COMMERCIAL
500 FEET UNSPRINKLERED	600 FEET UNSPRINKLERED	400 FEET UNSPRINKLERED
12. WHERE THE WATER MAINS ARE EXTENDED ALONG STREETS OR NEW STREETS ARE INSTALLED WHERE FIRE HYDRANTS ARE NOT NEEDED FOR PROTECTION OF STRUCTURES, FIRE HYDRANTS SHALL BE INSTALLED AT A MAXIMUM OF 1000 FT SPACING, TO PROVIDE FOR TRANSPORTATION HAZARDS. WHERE STREETS ARE PROVIDED WITH MEDIAN DIVIDERS OR HAVE FOUR (4) OR MORE TRAFFIC LANES AND HAVE A TRAFFIC COUNT OF MORE THAN 30,000 PER DAY, HYDRANTS ARE REQUIRED ON EACH SIDE OF THE STREET SPACED AT 500 FT ON AN ALTERNATING BASIS. [IFC § C102.8]
13. NO FIRE HYDRANTS SHALL BE LOCATED WITHIN THE RADIUS OF A CUL-DE-SAC OR WITHIN 20 FT OF THE PERIMETER OF THE RADIUS OF THE CUL-DE-SAC.
14. NO FIRE HYDRANTS SHALL BE LOCATED WITHIN 6 FT OF ANY CURB RETURN, DRIVEWAY, POWER POLE, STREETLIGHT OR ANY OTHER OBSTRUCTION. [IFC § C102.12]
15. A MAXIMUM DISTANCE FROM A FIRE HYDRANT TO A ONE-TWO FAMILY DWELLING SHALL NOT EXCEED 300 FT, AS MEASURED BY AN APPROVED ROUTE. [IFC § C102.4]
16. THE MAXIMUM DISTANCE FROM A FIRE HYDRANT TO A FIRE DEPARTMENT CONNECTION (FDC) SHALL NOT EXCEED 100 FT, AS MEASURED BY AN APPROVED ROUTE. [IFC § C102.7]
17. THE MAXIMUM DISTANCE FROM A HYDRANT TO THE END OF A DEAD-END STREET SHALL NOT EXCEED 200 FT. [IFC § C102.6]
18. TWO (2) SOURCES OF SUPPLY ARE REQUIRED WHENEVER THERE IS 4 OR MORE FIRE HYDRANTS. SPRINKLERS ARE INSTALLED ON A SINGLE SYSTEM. ADDITIONAL CONTROL VALVES SHALL BE INSTALLED SO THAT NO MORE THAN 2 FIRE HYDRANTS CAN BE OUT OF SERVICE DUE TO A BREAK IN A WATER MAIN. [IFC § C104]
19. ALL FIRE APPARATUS ACCESS ROADS SHALL BE PAVED TO PROVIDE ALL-WEATHER DRIVING CAPABILITIES, AND SHALL BE DESIGNED AND MAINTAINED TO SUPPORT THE IMPOSED LOADS OF THE FIRE APPARATUS. [IFC § 503.2.3]
20. THE GRADE/FOR THE FIRE APPARATUS ROADS SHALL NOT EXCEED 12% ANGLES OF APPROACH AND ANGLES OF DEPARTURE SHALL NOT EXCEED 6% FOR 25 FT PRIOR TO OR AFTER THE GRADE CHANGE. ADJACENT TO THE STRUCTURES GRADIENT SHALL NOT EXCEED 6%. [IFC § 503.2.7, § 503.2.8]
21. THE TURNING RADIUS OF THE FIRE APPARATUS ACCESS ROADS SHALL BE NO LESS THAN 52 FT OUTSIDE AND 28 FT INSIDE TURNING RADIUS. [IFC § 503.2.4]
22. VERTICAL CLEARANCE OF ALL FIRE APPARATUS ACCESS ROADS SHALL NOT BE LESS THAN 13 FT 6 IN. [IFC § 503.2.1]
23. FIRE DEPARTMENT ACCESS ROADS SHALL HAVE A MINIMUM UNOBSTRUCTED WIDTH OF NOT LESS THAN 40 FT FLOW LINE TO FLOW LINE WITH PARALLEL PARKING PERMITTED ON BOTH SIDES. NOT LESS THAN 32 FT WIDE, FLOW-LINE TO FLOW-LINE, WHERE PARKING IS PERMITTED ONLY ON ONE SIDE OF THE FIRE APPARATUS ACCESS ROAD, NOT LESS THAN 24 FT WIDE, FLOW-LINE TO FLOW-LINE, WHERE NO PARKING IS PERMITTED ON EITHER SIDE. FIRE LANES THROUGH PARKING LOTS SHALL NOT BE LESS THAN 24 FT. [IFC § 503.2.1.1]
24. FIRE APPARATUS ACCESS ROAD SHALL BE REQUIRED WHEN ANY PORTION OF AN EXTERIOR WALL OF THE FIRST STORY IS LOCATED MORE THAN 150 FT FROM FIRE DEPARTMENT VEHICLE ACCESS. THIS DISTANCE COULD BE INCREASED TO 250 FT IF THE BUILDING IS SPRINKLERED. [IFC § 503.1.1.1]
25. APPROVED SECONDARY FIRE APPARATUS ACCESS SHALL BE PROVIDED FOR 100 OR MORE DWELLING UNITS, ROAD(S) WITH DEAD-ENDS OR WITH A SINGLE POINT OF ACCESS IN EXCESS OF 600 FT. COMMERCIAL AND INDUSTRIAL DEVELOPMENTS WHERE BUILDINGS EXCEED 2 STORIES OR 30 FT IN HEIGHT, OR EXCEEDING 62,000 SQ FT IN AREA. [IFC § 503.1.2]
26. ALL DEAD-END FIRE APPARATUS ROADS AND/OR FIRE LANES, PUBLIC OR PRIVATE, IN EXCESS OF 150 FT IN LENGTH SHALL BE PROVIDED WITH AN APPROVED TURN AROUND HAVING A MINIMUM DIAMETER OF 81 FT. [IFC § 503.2.5]
27. ALL FIRE APPARATUS ACCESS ROADS SHALL BE MARKED BY PLACING APPROVED SIGNS AT THE START OF THE DESIGNATED FIRE LANE, ONE SIGN AT THE END OF THE FIRE LANE AND WITH SIGNS AT INTERVALS OF 100 FT ALONG THE DESIGNATED FIRE LANES. SIGNS TO BE PLACED ON BOTH SIDES OF AN ACCESS TO PREVENT PARKING OR OTHER OBSTRUCTION ON EITHER SIDE. SIGNS TO BE INSTALLED NO HIGHER THAN 10FT OR LESS THAN 6 FT FROM THE ROADWAY LEVEL. THE CURB ALONG OR ON THE PAVEMENT OR CEMENT (IF NO CURB IS PROVIDED) SHALL BE PAINTED WITH RED WEATHER RESISTANT PAINT IN ADDITION TO THE SIGNS. [IFC § 503.3]
28. ELECTRONICALLY CONTROLLED ACCESS GATES SHALL BE PROVIDED WITH AN APPROVED EMERGENCY VEHICLE DETECTOR/RECEIVER SYSTEM. SAID SYSTEM SHALL BE INSTALLED IN ACCORDANCE WITH THE IFC § 503.6 AND IFC APPENDIX M.

- EFFECTIVE DATE 03-01-2016
- 15' APPROVED
6/14/17
- APPROVED FOR CONSTRUCTION
- LAS VEGAS VALLEY WATER DISTRICT ENGINEERING SERVICES
- PROJECT No. 125376 FIRST APPROVED DATE: 5/14/18

DEVIATIONS FROM STANDARDS

NONE.

CL OR SURVEY LINE	EASEMENT LINE	DESCRIPTION:	CONTOUR LINES	EDGE OF PAVEMENT	"A" TYPE CURBS	"L" TYPE CURBS
PROPERTY LINE	SAWTOOTH LINE	EXISTING:	---(2210)---	---	---	---
ROW LINE	SCARP LINE	PROPOSED:	---(2122)---	---	---	---

CITY OF LAS VEGAS GENERAL NOTES

1. ALL CONSTRUCTION AND MATERIALS SHALL BE IN ACCORDANCE WITH THE UNIFORM STANDARD SPECIFICATIONS FOR PUBLIC WORKS CONSTRUCTION OFF-SITE IMPROVEMENTS, CLARK COUNTY AREA, NEVADA, LATEST ISSUE, THE UNIFORM STANDARD DRAWINGS FOR PUBLIC WORKS CONSTRUCTION, CLARK COUNTY AREA NEVADA, LATEST REVISED EDITION, THE SUMMERLIN IMPROVEMENT STANDARDS FOR WORK IN THE SUMMERLIN AREA, AND OTHER APPLICABLE APPROVED STANDARDS ISSUED BY THE CONTROLLING AGENCY, THE UNIFORM BUILDING CODE, AND ALL LOCAL CITY CODES AND ORDINANCES APPLICABLE, EXCEPT AS NOTED ON THIS SHEET AS "DEVIATIONS FROM STANDARDS".
2. THE EXISTENCE AND LOCATION OF ANY OVERHEAD OR UNDERGROUND UTILITY LINES, PIPES, OR STRUCTURES SHOWN ON THESE PLANS ARE OBTAINED BY A RESEARCH OF THE AVAILABLE RECORDS. EXISTING UTILITIES AS SHOWN FROM CIVIL PLANS LIBRARY ARE APPROXIMATE AND OF RECORD PURPOSES. EXISTING UTILITIES ARE LOCATED ON PLANS ONLY FOR THE CONVENIENCE OF THE CONTRACTOR. EXISTING UTILITY SERVICE LATERALS MAY NOT BE SHOWN ON THE PLANS. THE CONTRACTOR SHALL BE RESPONSIBLE FOR IDENTIFYING A NEED FOR STUDIES AND FOR THE SAFETY OF CROSSING THROUGH THAT WORK ZONE, THE CONTRACTOR SHALL BE REQUIRED TO PROVIDE A QUALIFIED "CROSSING GUARD", THE GUARD SHALL BE PRESENT FOR THE FULL DURATION OF THE TIME THAT CHILDREN ARE LIKELY TO BE PRESENT.
3. THE CONTRACTOR SHALL TAKE ALL PRECAUTIONARY MEASURES NECESSARY TO PROTECT EXISTING UTILITY LINES, STRUCTURES AND STREET IMPROVEMENTS WHICH ARE TO REMAIN IN PLACE, FROM DAMAGE, AND ALL SUCH IMPROVEMENTS OR STRUCTURES DAMAGED BY THE CONTRACTOR'S OPERATIONS SHALL BE REPAIRED OR REPLACED SATISFACTORY TO THE CITY ENGINEER AND OWNING UTILITY COMPANY AT THE EXPENSE OF THE CONTRACTOR.
4. ALL CONSTRUCTION SHALL BE AS SHOWN ON THESE PLANS, ANY REVISIONS SHALL HAVE THE PRIOR WRITTEN APPROVAL OF THE CITY ENGINEER.
5. TYPE V CEMENT SHALL BE USED IN ALL OFF-SITE CONCRETE WORK. CONCRETE TO BE 3000 P.S.I. MINIMUM @ 28 DAYS. MIX DESIGNS TO BE APPROVED BY THE CITY, PRIOR TO THE USE ON THE PROJECT.
6. PERMITS ARE REQUIRED FOR ANY WORK IN THE PUBLIC RIGHT-OF-WAY. THE CONTRACTOR SHALL SECURE ALL PERMITS AND INSPECTIONS REQUIRED FOR THIS CONSTRUCTION.
7. EXPANSION JOINTS REQUIRED, MAXIMUM EVERY 300' IN EXTRUDED-TYPE CURB.
8. AC PAVEMENT TO BE ONE-HALF INCH (1/2") ABOVE LIP OF ALL GUTTERS AFTER COMPACTION, EXCEPT AT SIDEWALK RAMPS AND CROSS GUTTERS.
9. CURB AND GUTTER FOUND TO BE UNACCEPTABLE TO THE CITY OF LAS VEGAS SHALL BE REMOVED AND REPLACED PER STANDARD DRAWING 218.
10. SIDEWALK RAMPS SHALL BE CONSTRUCTED IN EACH QUADRANT OF AN INTERSECTION PER STANDARD DRAWING 235. EXACT LOCATION OF RAMPS MAY BE ADJUSTED IN THE FIELD BY A CITY INSPECTOR.
11. CONTRACTOR SHALL PROVIDE ALL NECESSARY HORIZONTAL AND VERTICAL TRANSITIONS BETWEEN NEW CONSTRUCTION AND EXISTING SURFACES TO PROVIDE FOR PROPER DRAINAGE AND FOR INGRESS AND EGRESS TO NEW CONSTRUCTION. THE EXTENT OF THE TRANSITIONS TO BE AS SHOWN ON PLANS.
12. ALL GRADING WORK SHALL CONFORM TO THE SOILS REPORT AS PREPARED BY THE (COMPANY, - REPORT #, DATE) APPROVED BY THE CITY ENGINEER, AND AS SHOWN ON THESE PLANS.
13. EXACT LOCATION OF ALL SAWCUT LINES MAY BE ADJUSTED OR DETERMINED IN THE FIELD BY A CITY OF LAS VEGAS ENGINEER IF LOCATION ON PLANS IS NOT CLEARLY SHOWN, OR EXISTING PAVEMENT CONDITION REQUIRES RELOCATION.
14. THE CONTRACTOR SHALL TAKE ALL PRECAUTIONS NECESSARY TO PROTECT EXISTING PERMANENT SURVEY MONUMENTS. ANY MONUMENTS DISTURBED SHALL BE REPLACED AND ADJUSTED PER AVAILABLE RECORDS IN ACCORDANCE WITH N.R.S. STATUTE NO. 625.380 & CITY OF LAS VEGAS TITLE 18, APPENDIX D.
15. UTILITY COMPANY METER BOXES, MANHOLE LIDS, VALVE COVERS, ETC., SHALL BE LOCATED OUT OF DRIVEWAYS, DRIVEWAY APRONS, FLOWLINES, AND CROSS GUTTERS UNLESS WRITTEN APPROVAL IS GRANTED BY THE UTILITY COMPANY AND THE CITY ENGINEER.
16. WALLS, NEW OR EXISTING, ARE ONLY SHOWN ON CIVIL PLANS FOR THE PURPOSE OF REVIEWING GRADING RELATIONSHIPS; FLOOD CONTROL AND SIGHT DISTANCE AT INTERSECTIONS, NEW WALLS REQUIRE A SEPARATE PERMIT AND INSPECTION BY THE BUILDING DEPARTMENT.
17. ASPHALT MIX DESIGN MUST BE SUBMITTED AND APPROVED BY THE CITY ENGINEER PRIOR TO THE PLACEMENT OF ASPHALT WITHIN CITY RIGHT OF WAY.
18. CONTRACTOR SHALL ADJUST ALL NEW AND EXISTING INLETS, VALVE BOXES, MANHOLE RIMS, AND SEWER CLEAN OUTS, ETC. TO FINISH GRADE AS APPLICABLE WHETHER OR NOT THEY ARE SHOWN ON THE PLANS.
19. MATERIALS, HANDLING AND PLACEMENT OF PORTLAND CEMENT CONCRETE SHALL BE IN ACCORDANCE WITH APPLICABLE SECTIONS OF MDT OR THE CLARK COUNTY AREA SPECIFICATIONS (AS APPLICABLE) AND THE PLANS AND DETAILS SHOWN HEREON.
20. WHEN INSTALLING UNDERGROUND FACILITIES THAT REQUIRE UNDERGROUND LOCATING DEVICES SUCH AS MARKER BALLS, LOCATING RIBBON, ETC., THE CONTRACTOR SHALL PROVIDE WRITTEN DOCUMENTATION TO OFFSITE INSPECTION AND TESTING CERTIFYING THAT ALL DEVICES HAVE BEEN PLACED/VERIFIED TO BE IN GOOD WORKING CONDITION PRIOR TO THE CONSTRUCTION OF ANY ROAD BASE.
21. SANITARY SEWER AND STORM DRAIN FINAL LOCATION MAP(S) SHALL BE PROVIDED TO THE CITY AND APPROVED PRIOR TO ADEQUATE FINAL FIELD INSPECTION. THE MAP(S) SHALL INCLUDE THE HORIZONTAL AND VERTICAL (INVERT) LOCATION OF PUBLIC SEWER MANHOLES, STORM DRAIN MANHOLES AND TRANSITION STRUCTURES, STORM DRAIN LATERALS AT THE CONNECTION TO THE STORM DRAIN MAIN AND AT THE CONNECTION TO A DROP INLET, THE CONNECTION OF SEWER SERVICE LATERALS TO THE SEWER MAIN AND WHERE THE SEWER SERVICE LATERALS EXIT THE PUBLIC RIGHT-OF-WAY, AND STORM DRAIN MAIN ALIGNMENT, INCLUDING DEFLECTION POINTS. THE LOCATION SHALL BE DESCRIBED BY COORDINATES WHICH SHALL BE BASED ON THE OFFICIAL HORIZONTAL AND VERTICAL CONTROL NETWORKS OF THE CITY OF LAS VEGAS. FINAL LOCATION MAPS MUST BE SEALED AND CERTIFIED BY A NEVADA PROFESSIONAL LAND SURVEYOR TO HAVE POSITIVE CERTAINTIES OF +0.09 METERS (+ 0.3 FEET) HORIZONTAL AND VERTICAL. A SEPARATE ELECTRONIC COMMA DELIMITED FILE FOR THE SANITARY SEWER AND STORM DRAIN COORDINATES SHALL ALSO ACCOMPANY THE SANITARY SEWER AND STORM DRAIN FINAL LOCATION MAP(S).
22. CCTV VIDEO INSPECTION IS REQUIRED FOR ALL SEWER AND STORM DRAINS. THE CCTV VIDEO INSPECTIONS NEED TO BE PERFORMED PER THE DESIGN AND CONSTRUCTION STANDARDS FOR WASTEWATER COLLECTION SYSTEMS LATEST EDITION.
23. A SEPARATE BORING PERMIT IS REQUIRED FOR ALL BORING ACTIVITIES.

- REVISED 02/03/15
22. CCTV VIDEO INSPECTION IS REQUIRED FOR ALL SEWER AND STORM DRAINS. THE CCTV VIDEO INSPECTIONS NEED TO BE PERFORMED PER THE DESIGN AND CONSTRUCTION STANDARDS FOR WASTEWATER COLLECTION SYSTEMS LATEST EDITION.
23. A SEPARATE BORING PERMIT IS REQUIRED FOR ALL BORING ACTIVITIES.

QUANTITIES

DESCRIPTION	PUBLIC QUANTITIES
5-INCH ASPHALTIC CONCRETE PAVING	2,287 SF
6-INCH ASPHALTIC CONCRETE PAVING	5,394 SF
TYPE II GRAVEL	3,454 CY
CURB & GUTTER "L" CURB	374 LF
CONCRETE CROSS GUTTER	1,792 SF
4-INCH CONCRETE SIDEWALK	2,976 SF
60-INCH SEWER MANHOLES	1 EA
6-INCH DIP WATER MAIN	38 LF
8-INCH WATER MAIN	150 LF
3/4" WATER METER	1 EA
1" WATER METER	2 EA
1-1/2" WATER METER	2 EA
10" COMPACT RPDA	2 EA
10" X 8" TEE	2 EA
10" GATE VALVE	1 EA
8" GATE VALVE	2 EA
POWER SERVICE TO LOTS	4 EA
SIDEWALK UNDERDRAIN	2 EA
PAVEMENT STRIPING ARTERIAL	6,072 LF
TRAFFIC SIGNAL AND/OR BASE	1 EA
TRAFFIC SIGNAL UNDERGROUND	914 LF
TRAFFIC CONTROL DEVICES	8 EA
SURVEY MONUMENTS	1 EA

NOTE: THIS QUANTITY ESTIMATE IS FOR BONDING PURPOSES ONLY. CONTRACTOR TO DETERMINE INDEPENDENT ESTIMATIONS.

THE QUANTITY ESTIMATE SHOWN HERE IS FOR EXAMPLE ONLY. ALL DRAFTERS NEED TO CHECK WITH THEIR PROJECT MANAGER BEFORE USING THIS QUANTITY ESTIMATE. SOME PROJECT MANAGERS MAY LIKE IT AND SOME MAY NOT. IT IS NOT REQUIRED IN CLARK COUNTY TO SHOW A QUANTITY ESTIMATE ON THE NOTE SHEET. IT IS MANDATORY, HOWEVER, TO SHOW A QUANTITY ESTIMATE ON THE NOTE SHEET IN CITY OF LAS VEGAS JURISDICTION, IF AND ONLY IF YOUR PROJECT ENGINEER WANTS THE QUANTITY ESTIMATE TO SHOW, THEN CHANGE IT TO THE APPROPRIATE LAYERS ALREADY DEFINED IN THIS DRAWING.

CITY OF LAS VEGAS TRAFFIC NOTES

1. ALL CONSTRUCTION SIGNING, BARRICADING, AND TRAFFIC DELINEATION SHALL CONFORM TO THE "MANUAL ON UNIFORM TRAFFIC CONTROL DEVICES", LATEST EDITION.
2. THE STREET SIGN CONTRACTOR SHALL OBTAIN STREET NAMES AND BLOCK NUMBERING FROM THE PLANNING DEPARTMENT PRIOR TO CONSTRUCTION.
3. BEFORE ANY WORK IS STARTED IN THE RIGHT-OF-WAY, THE CONTRACTOR SHALL INSTALL ALL ADVANCE WARNING SIGNS FOR THE CONSTRUCTION ZONE. THE CONTRACTOR SHALL INSTALL TEMPORARY STOP SIGNS AT ALL NEW STREET ENCRoACHMENTS INTO EXISTING CITY STREETS WHERE WARRANTED IMMEDIATELY AFTER FIRST GRADING WORK IS ACCOMPLISHED, AND SHALL MAINTAIN SAID SIGNS UNTIL PERMANENT SIGNS ARE INSTALLED.
4. WHEN A DESIGNATED "SAFE ROUTE TO SCHOOL" IS ENCRoACHED UPON BY A CONSTRUCTION WORK ZONE AND PUBLIC WORKS, THE CONTRACTOR SHALL BE REQUIRED TO PROVIDE A "SAFE CROSSING THROUGH THAT WORK ZONE". THE CONTRACTOR SHALL BE REQUIRED TO PROVIDE A QUALIFIED "CROSSING GUARD", THE GUARD SHALL BE PRESENT FOR THE FULL DURATION OF THE TIME THAT CHILDREN ARE LIKELY TO BE PRESENT.
5. IF THE IMPROVEMENTS NECESSITATE THE OBLITERATION, TEMPORARY OBSTRUCTION, TEMPORARY REMOVAL OR RELOCATION OF ANY EXISTING TRAFFIC PAVEMENT MARKING, SUCH PAVEMENT MARKING SHALL BE RESTORED OR REPLACED WITH LIKE MATERIALS TO THE SATISFACTION OF THE CITY TRAFFIC ENGINEER.
6. THE CONTRACTOR SHALL BE RESPONSIBLE FOR PROVIDING AND INSTALLING ALL PERMANENT SIGNS SHOWN ON THE PLANS. ALL NEW TRAFFIC SIGNS SHALL BE FABRICATED WITH DIAMOND GRADE WP CLASS 6 REFLECTIVE SHEETING OR APPROVED EQUAL. ALL NEW TRAFFIC SIGNS, EXCEPT STREETNAME AND SCHOOL SPEED LIMIT SIGNS, SHALL HAVE 3M SERIES 1180 OR APPROVED EQUIVALENT ANTI-GRAFFITI PROTECTIVE OVERLAY FILM. SCHOOL ZONE SIGNS SHALL HAVE 3M SERIES 1150 ANTI-GRAFFITI PROTECTIVE OVERLAY FILM. STREET NAME SIGNS SHALL CONFORM IN THEIR ENTIRETY TO CURRENT CITY STANDARDS. ALL OTHER SIGNS SHALL BE STANDARD SIZE UNLESS OTHERWISE SPECIFIED ON THE PLANS. ALL SIGN POSTS SHALL BE INSTALLED IN ACCORDANCE WITH THE CURRENT CITY STANDARDS.
7. WHEN A PROPOSED STREET LIGHT STANDARD IS LOCATED WITHIN FIVE (5) FEET OF ANY PROPOSED SIGN SHOWN ON THE PLANS TO BE MOUNTED ON A SIGNPOST, THE SIGN SHALL BE MOUNTED ON THE STREET LIGHT STANDARD AND THE SIGNPOST SHALL BE ELIMINATED.
8. ALL PERMANENT TRAFFIC CONTROL DEVICES CALLED FOR HEREON SHALL BE IN PLACE AND IN FINAL POSITION PRIOR TO ALLOWING ANY PUBLIC TRAFFIC ONTO THE PORTIONS OF THE ROAD(S) BEING IMPROVED HEREON, REGARDLESS OF THE STATUS OF COMPLETION OF PAVING OR OTHER OFF-SITE IMPROVEMENTS CALLED FOR BY THESE PLANS.
9. STREET SIGNS AND STOPS SIGNS SHALL BE INSTALLED PER CITY STANDARD SPECIFICATIONS FOR PLACEMENT OF STREET NAME SIGNS.
10. THE CONTRACTOR SHALL PROVIDE ALL NECESSARY TRAFFIC CONTROL DEVICES AND FLAGGERS TO INSURE THE SAFETY OF THE PUBLIC IN OR AROUND THE WORK AREA. THE CONTRACTOR SHALL HAVE A CERTIFIED ATSSA TRAFFIC CONTROL TECHNICIAN OR ISEA WORK ZONE SAFETY SPECIALIST SET UP, MAINTAIN AND/OR REMOVE ALL TRAFFIC CONTROL DEVICES IN THE CITY OF LAS VEGAS RIGHT OF WAY.
11. WORK IN PUBLIC STREETS, ONCE BEGUN, SHALL BE EXPEDITED TO COMPLETION SO AS TO PROVIDE MINIMUM INCONVENIENCE TO ADJACENT PROPERTY OWNERS AND TO THE TRAVELING PUBLIC.
12. THE CONTRACTOR SHALL BE RESPONSIBLE FOR NOTIFYING CITIZENS AREA TRANSIT (C.A.T.) IF THE CONSTRUCTION INTERRUPTS OR RELOCATES A BUS STOP OR HAS AN ADVERSE EFFECT ON BUS SERVICE ON THAT STREET TO ARRANGE FOR TEMPORARY RELOCATION OF STOP.
13. GUARDS SHALL BE OBTAINED BY CONTACTING THE METROPOLITAN POLICE DEPARTMENT SPECIAL EVENTS UNIT (PHONE # 828-3442) WHO WILL PROVIDE OFFICERS PROPERLY TRAINED IN TRAFFIC CONTROL. FEES FOR THE USE OF THESE OFFICERS SHALL BE SET BY METRO AND WILL BE PAID BY THE CONTRACTOR. THE CONTRACTOR IS RESPONSIBLE FOR ALL ARRANGEMENTS WITH METRO.
14. ANY WORK WITHIN 300' OF A SIGNALIZED INTERSECTION WILL BE NIGHT WORK, UNLESS OTHERWISE DIRECTED BY THE CITY OF LAS VEGAS TRAFFIC ENGINEER.
15. THE CONTRACTOR SHALL CONTACT THE TRAFFIC ENGINEERING DIVISION (TRANSPORTATION SECTION) THROUGH THE PROJECT OFFSITE INSPECTOR PRIOR TO INITIATING PAVING TO RECOVER PROTECTION FOR ANY PERMANENT OR TEMPORARY MODIFICATIONS TO THE APPROVED DRAWINGS REGARDING FINAL PAVEMENT TRANSITIONS, MARKINGS AND SIGNING THAT ARE REQUIRED TO MATCH ADJACENT ROADWAY SEGMENTS. THE CONTRACTOR SHALL PROVIDE A DRAWING FOR APPROVAL BY THE TRAFFIC ENGINEERING DIVISION. THIS DRAWING SHALL BE THE FINAL PAVEMENT MARKINGS AND SIGNAGE, WHICH MAY INCLUDE OMITTING, ADDING OR MODIFYING PAVEMENT MARKINGS AND TRAFFIC CONTROL SIGNS SUCH THAT ADEQUATE TRANSITIONS AND LANE TERMINATIONS BETWEEN ADJACENT ROADWAY SEGMENTS ARE CONSTRUCTED.

REVISED 04/15/10

LAS VEGAS VALLEY WATER DISTRICT NOTES

LVVWD PROJECT # 125376

1. NO WORK SHALL BEGIN UNTIL THE WATER PLANS HAVE BEEN APPROVED FOR CONSTRUCTION BY THE LVVWD. FOLLOWING WATER PLAN APPROVAL, NOTICE SHALL BE GIVEN TO THE LVVWD COMMUNICATION SUPPORT CENTER (258-7171) TWO (2) WORKING DAYS PRIOR TO THE START OF CONSTRUCTION. FOR FUTURE INSPECTIONS, NOTICE MUST BE GIVEN BY 2:00 P.M. THE BUSINESS DAY PRIOR TO THE REQUESTED LVVWD INSPECTION. WHEN REQUESTING INSPECTIONS, PLEASE REFER TO THE PROJECT # IDENTIFIED ABOVE.
2. ALL WORK SHALL CONFORM TO LVVWD STANDARD PLATES, DRAWINGS, AND SPECIFICATIONS, AND TO THE 2010 EDITION OF THE UNIFORM DESIGN AND CONSTRUCTION STANDARDS FOR POTABLE WATER SYSTEMS (UDACS). THE LATEST EDITION OF UDACS SHALL SUPERSEDE ANY CONFLICTS CONTAINED IN THE APPROVED DRAWINGS AND/OR SPECIFICATIONS.
3. ALL WORK, EXCEPT AS MODIFIED BY THESE PLANS OR BY NOTE 2 ABOVE, SHALL BE DONE IN ACCORDANCE WITH THE 2010 EDITION OF THE UNIFORM DESIGN AND CONSTRUCTION STANDARDS FOR POTABLE WATER SYSTEMS (UDACS). THE LATEST EDITION OF UDACS SHALL SUPERSEDE ANY CONFLICTS CONTAINED IN THE APPROVED DRAWINGS AND/OR SPECIFICATIONS.
4. A SINGLE PIPE MATERIAL SHALL BE USED THROUGHOUT THE PROJECT UNLESS OTHERWISE APPROVED BY THE LVVWD.
5. ALL SERVICE LATERALS TWO (2) INCHES IN DIAMETER AND SMALLER SHALL BE TYPE K COPPER TUBING WITH LVVWD APPROVED SERVICE SADDLES.
6. ALL WATER METER BOXES SHALL BE LOCATED OUTSIDE OF DRIVEWAY AREAS.
7. ALL VALVES SHALL BE LOCATED OUTSIDE OF DRIVEWAYS, VALLEY AND CURB GUTTERS.
8. ALL WATER AND STORM DRAIN OR SANITARY SEWER CROSSINGS SHALL CONFORM TO SECTION 2.22 OF THE 2010 EDITION OF THE UDACS.
9. ALL WATER FACILITIES SHALL BE FILLED, DISINFECTED, PRESSURE TESTED, FLUSHED, FILLED, AND AN ACCEPTABLE WATER SAMPLE OBTAINED, PRIOR TO CONNECTION TO THE LVVWD DISTRIBUTION SYSTEM.
10. THE CONTRACTOR MUST OBTAIN ALL METERS TWO (2) INCHES AND SMALLER FROM LVVWD CENTRAL STORAGE. TELEPHONE 258-3152 OR 258-3802, TWO (2) WORKING DAYS PRIOR TO METER PICKUP.
11. ANY INTERRUPTION OF SERVICE MUST BE PERFORMED IN ACCORDANCE WITH UDACS SECTION 3.14.01, AND APPROVED BY THE LVVWD INSPECTION DIVISION PRIOR TO SHUTDOWN. PROPER WRITTEN NOTIFICATION MUST BE GIVEN TO ALL AFFECTED CUSTOMERS.
12. ALL WATER FACILITY CONSTRUCTION MATERIALS USED MUST BE AS LISTED ON THE LVVWD PRE-APPROVED MATERIALS AND MANUFACTURER'S LISTING FOR NEW FACILITIES, LATEST REVISION, OR SPECIFICALLY APPROVED ON THESE PLANS.
13. TELEPHONE "CALL BEFORE YOU DIG" AT "811" OR 1-800-227-2600.
14. THE INSTALLATION OF LAS VEGAS VALLEY WATER DISTRICT (LVVWD) MUNICIPAL WATER FACILITIES WITHIN ALL STREETS IS ASSUMED TO BE IN COMPLIANCE WITH THE UNIFORM STANDARDS, INSTEAD OF THE PLACEMENT OF ASPHALT PAVING STREET SURFACES. ANY REPAIR WORK DONE BY THE LVVWD TO THE MUNICIPAL WATER FACILITIES WILL INCLUDE THE PLACEMENT OF AN APPROPRIATELY SIZED ASPHALT REPAIR PATCH ON THE STREET SURFACE.
15. NO LEAD COMPLIANCE NOTE: TO COMPLY WITH THE FEDERAL SAFE DRINKING WATER ACT, ALL WATER WORKS BRASS PRODUCTS PROPOSED TO BE RELOCATED, OR INSTALLED AS NEW MUST BE INSTALLED WITH THE LEAD FREE APPROVED PRODUCT. THE OLD LEADED PRODUCT MAY NOT BE REUSED.

CLARK COUNTY TRAFFIC NOTES

1. ALL PERMANENT TRAFFIC CONTROL DEVICES CALLED FOR HEREON SHALL BE IN PLACE AND IN FINAL POSITION PRIOR TO ALLOWING ANY PUBLIC TRAFFIC ONTO THE PORTIONS OF THE ROAD(S) BEING IMPROVED HEREUNDER, REGARDLESS OF THE STATUS OF COMPLETION OF PAVING OR OTHER OFF-SITE IMPROVEMENTS CALLED FOR BY THESE PLANS.
2. BEFORE ANY WORK IS STARTED IN THE RIGHT-OF-WAY, THE CONTRACTOR SHALL INSTALL ALL ADVANCE WARNING SIGNS FOR THE CONSTRUCTION ZONE. THE CONTRACTOR SHALL INSTALL TEMPORARY GROUND MOUNTED STOP SIGNS AT ALL NEW STREET ENCRoACHMENTS INTO EXISTING COUNTY STREETS IMMEDIATELY AFTER FIRST GRADING WORK IS ACCOMPLISHED AND SHALL MAINTAIN SAID SIGNS UNTIL PERMANENT SIGNS ARE INSTALLED.
3. ALL CONSTRUCTION SIGNING, BARRICADING AND PAVEMENT MARKINGS SHALL CONFORM TO THE NEVADA WORK ZONE TRAFFIC CONTROL HANDBOOK - 1986 AND TO THE MANUAL ON UNIFORM TRAFFIC CONTROL DEVICES, CURRENT EDITION.
4. IF THE IMPROVEMENTS NECESSITATE THE OBLITERATION, TEMPORARY OBSTRUCTION, TEMPORARY REMOVAL, OR RELOCATION OF ANY EXISTING TRAFFIC PAVEMENT MARKING, SUCH PAVEMENT MARKING SHALL BE RESTORED OR REPLACED WITH LIKE MATERIALS TO THE SATISFACTION OF THE COUNTY TRAFFIC MANAGER.
5. THE DEVELOPER SHALL BE RESPONSIBLE TO PROVIDE AND INSTALL ALL PERMANENT SIGNS SHOWN ON THE PLANS. STREET NAME SIGNS SHALL CONFORM IN THEIR ENTIRETY TO CLARK COUNTY AREA STANDARDS. ALL OTHER SIGNS SHALL BE STANDARD SIZE UNLESS OTHERWISE SPECIFIED ON THE PLANS. ALL SIGNPOSTS SHALL BE INSTALLED IN ACCORDANCE WITH CLARK COUNTY AREA STANDARDS. ALL SIGNS SHALL USE CLASS V SHEETING.
6. IF A PROPOSED STREET LIGHT STANDARD IS FIELD LOCATED TO WITHIN FIVE (5) FEET OF ANY SIGN SHOWN HEREON TO BE MOUNTED ON A SIGN POST, CHANGE SIGN MOUNTING TO ONE ON THE STREETLIGHT STANDARD.
7. PRIOR TO CONSTRUCTION, THE STREET SIGN CONTRACTOR SHALL OBTAIN STREET NAMES AND BLOCK NUMBERING FROM THE CURRENT PLANNING DIVISION OF THE DEPARTMENT OF COMPREHENSIVE PLANNING.
8. ALL TRAFFIC SIGNAL POLE ASSEMBLIES, STEEL PEDESTAL FOR CABINETS AND STREET LIGHT POLES SHALL BE GALVANIZED PER ASTM A123.
9. ALL STREET LIGHTING INSTALLATIONS EXCEPT NOTED ON THE STREET LIGHTING PLANS SHALL CONFORM TO THE UNIFORM STANDARD DRAWINGS AND THE UNIFORM STANDARD SPECIFICATIONS FOR PUBLIC WORKS CONSTRUCTION OFF-SITE IMPROVEMENTS, CLARK COUNTY AREA, NEVADA, LATEST EDITION OF EACH.
10. THE FOLLOWING CLARK COUNTY UNDERGROUND FACILITIES MAY BE LOCATED IN YOUR PROJECT AREA: STREET LIGHTING, TRAFFIC SIGNALS, AND AN ELECTRIC SYSTEM OF TRANSPORTATION (E.A.S.T.) INTERCONNECT CABLE. YOU MUST CONTACT CLARK COUNTY TRAFFIC MANAGEMENT DIVISION, OPERATIONS UNIT AT 455-6000 FOR LOCATIONS AT LEAST 48 HOURS PRIOR TO WORKING IN THE AREA. CLARK COUNTY IS NOT A MEMBER OF "CALL BEFORE YOU DIG" AND (USEFUL SERVICE ALERT) AND (USEFUL SERVICE ALERT) THAT ORGANIZATION DOES NOT RELIEVE YOU OF LIABILITY FOR CLARK COUNTY FACILITIES.
11. F.A.S.T. INTERCONNECT CABLE POLICY IS IN EFFECT. INTERCONNECT CABLE MUST BE MAINTAINED AT ALL TIMES. DEVELOPER/CONTRACTOR SHALL PROVIDE TEMPORARY OVERHEAD INTERCONNECT CABLE WHILE PERMANENT CABLE IS BEING RELOCATED. TEMPORARY AERIAL INSTALLATION MUST BE ACCEPTABLE TO THE COUNTY TRAFFIC MANAGER AND TO F.A.S.T. ANY DAMAGE TO THIS CABLE IS DEEMED AN EMERGENCY BY F.A.S.T., CITY OF LAS VEGAS, CLARK COUNTY AND MDT AND MUST BE REPAIRED IMMEDIATELY TO F.A.S.T. ACCEPTANCE. \$2,500 PER DAY DAMAGES MAY BE ASSESSED AFTER 24 HOURS HAS ELAPSED FROM TIME OF BREAK OR DAMAGE.
12. ALL NEW OR REPLACEMENT TRAFFIC SIGNAL LOOPS SHALL BE INSTALLED USING CABLE-IN-DUCT WIRING, SHALL HAVE INDEPENDENT LEAD-IN WIRES FOR EACH LOOP FROM THE CONTROLLER TO THE PULL-BOX, AND EACH LEAD-IN SHALL BE INDIVIDUALLY TAGGED.
13. TRAFFIC SIGNAL PEDESTRIAN HEADS SHALL BE THE L.E.D. TYPE.
14. ELECTRICAL POWER SERVICE POINT LOCATION(S) FOR STREET LIGHTING AND TRAFFIC SIGNALS MUST BE LOCATED ON THE PLANS. IF CONNECTING TO AN EXISTING CIRCUIT, INDICATE LOCATION OF EXISTING SERVICE POINT FOR EACH CIRCUIT.
15. WHEN STREETLIGHTS ARE TO BE CONNECTED TO AN EXISTING CIRCUIT, THE ENGINEER MUST CERTIFY THAT THE EXISTING CIRCUIT IS CAPABLE OF HANDLING THE ADDITIONAL CIRCUIT LOAD.
16. CLARK COUNTY RESERVES THE RIGHT TO REJECT STREET LIGHT AND TRAFFIC SIGNAL POLES AND ASSEMBLIES WHICH HAVE A "STRIPED" APPEARANCE.
17. TWO WEEKS PRIOR TO BEGINNING OF CONSTRUCTION, MODIFICATION OR RELOCATION OF ANY TRAFFIC SIGNAL SYSTEM, WRITTEN NOTICE SHALL BE SUBMITTED TO THE CLARK COUNTY TRAFFIC MANAGEMENT DIVISION OF THE DATE THAT WORK WILL BEGIN.
18. THREE (3) NORMAL WORKING DAYS PRIOR TO TURN-ON OR COMPLETION OF MODIFICATION(S) TO A TRAFFIC SIGNAL SYSTEM, WRITTEN NOTICE SHALL BE SUBMITTED TO THE CLARK COUNTY TRAFFIC MANAGEMENT DIVISION THAT WORK IS BEING COMPLETED AND THE PROPOSED DATE OF COMPLETION.

CLARK COUNTY DEPARTMENT OF PUBLIC WORKS DEVELOPMENT REVIEW NOTES

1. INSPECTIONS ARE REQUIRED. CALL 24 HOURS IN ADVANCE TO SCHEDULE AT (702)455-4610. PERMIT, APPROVED PLANS, AND BARRICADE PLANS FOR THIS WORK MUST BE ON THE JOB SITE AT ALL TIMES.
2. EXACT LOCATION OF ALL SAW-CUT LINES SHALL BE DETERMINED IN THE FIELD BY THE CLARK COUNTY INSPECTOR.
3. CURB AND GUTTER WITH A GRADE OF LESS THAN 1/8" OF ONE PERCENT SHALL BE CONSTRUCTED BY FORMING. EACH JOINT SHALL BE CHECKED FOR GRADE PRIOR TO CONSTRUCTION AND WATER TESTED AS SOON AS POSSIBLE AFTER CONSTRUCTION.
4. FINAL

FOR CONTINUATION SEE SHEET C2.02

CITY OF LAS VEGAS
JURISDICTION

CLARK COUNTY NEVADA
JURISDICTION

A.P.N.:125-19-202-007
GOVERNMENT LOT 18
NOT A PART


SEWER CONSTRUCTION NOTES:

- NOT ALL NOTES USED ON THIS SHEET -
- STUB & CAP SANITARY SEWER SERVICE. REFER TO PLUMBING PLANS FOR CONTINUATION.
 - INSTALL 48" SANITARY SEWER MANHOLE & BASE PER DCSWCS DWG. NO. SD-1A & SD-1B, CONCRETE COLLAR PER SD-4, SINGLE COVER 24"
 - INSTALL WYE LATERAL CONNECTION PER DCSWCS DWG. NO. SD-22.
 - INSTALL SEWER CLEAN-OUT PER DCSWCS DWG. NO. SD-26.
 - INSTALL 1500 GALLON SAND/OIL INTERCEPTOR BY OTHERS
 - INSTALL 1500 GALLON GREASE INTERCEPTOR BY OTHERS
 - NOT USED
 - SAMPLE MANHOLE FOR INTERCEPTOR(S) BY OTHERS
 - INSTALL SEWER BACK WATER VALVE.

WATER CONSTRUCTION NOTES:

- ALL WATER CONSTRUCTION TO BE DONE IN ACCORDANCE WITH "UNIFORM DESIGN AND CONSTRUCTION STANDARDS FOR WATER DISTRIBUTION SYSTEMS (UDACS)" LATEST EDITION.
- NOT ALL NOTES USED ON THIS SHEET -
- INSTALL 10" RPPA PER UDACS PLATE NO. 59.
 - NOT USED.
 - INSTALL 3/4" METER PER DETAIL ON SHEET C2.03
 - INSTALL 1-1/2" RPPA PER DETAIL ON SHEET C2.03
 - INSTALL 1-1/2" METER PER DETAIL ON SHEET C2.03
 - INSTALL REDUCER (SAME SIZE AS PIPES)
 - INSTALL FIRE HYDRANT W/ GATE VALVE PER UDACS PLATE NO. 40.
 - INSTALL SERVICE SADDLE (SAME SIZE AS PIPE) PER UDACS PLATE NO. 30 AND 39.
 - INSTALL GATE VALVE (SAME SIZE AS PIPE) PER UDACS PLATE NO. 31.
 - INSTALL 90° BEND W/THRUST BLOCK (SAME SIZE AS PIPE) PER UDACS PLATE NO. 31
 - INSTALL 45° BEND W/THRUST BLOCK (SAME SIZE AS PIPE) PER UDACS PLATE NO. 31
 - INSTALL 22.5° BEND W/THRUST BLOCK (SAME SIZE AS PIPE) PER UDACS PLATE NO. 31
 - INSTALL 11.25° BEND W/THRUST BLOCK (SAME SIZE AS PIPE) PER UDACS PLATE NO. 31
 - INSTALL TEE (SAME SIZE AS PIPES) PER UDACS PLATE NO. 31.
 - STUB & CAP WATER SERVICE. REFER TO PLUMBING PLANS FOR CONTINUATION.
 - STUB & CAP WATER SERVICE. REFER TO LANDSCAPE PLANS FOR CONTINUATION.
 - STUB & CAP WATER SERVICE.
 - INSTALL 90° BEND (SAME SIZE AS PIPE) PER UDACS PLATE NO. 31.
 - INSTALL 45° BEND (SAME SIZE AS PIPE) PER UDACS PLATE NO. 31
 - INSTALL 22.5° BEND (SAME SIZE AS PIPE) PER UDACS PLATE NO. 31
 - INSTALL 11.25° BEND (SAME SIZE AS PIPE) PER UDACS PLATE NO. 31
 - INSTALL 1" RPPA PER DETAIL ON SHEET C2.03
 - INSTALL 1" METER PER DETAIL ON SHEET C2.03
 - INSTALL RETAINING WALL WITH HANDRAIL PER STRUCTURAL DRAWINGS.
 - INSTALL 2" RPPA PER DETAIL ON SHEET C2.03
 - INSTALL 2" METER PER DETAIL ON SHEET C2.03

GRAPHIC SCALE

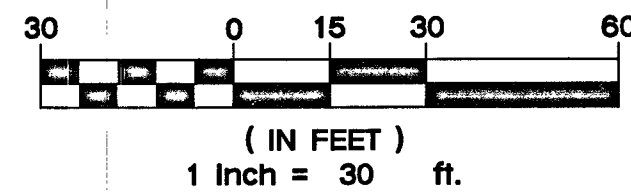

FIRE WATER AT DOMESTIC WATER CROSSINGS

ALL NON-POTABLE FIRE WATER LINES CROSSING POTABLE DOMESTIC WATER LINES ARE TO BE INSTALLED WITH "A" VERTICAL SEPARATION OF NO LESS THAN SIX INCHES. AND IN ACCORDANCE WITH UDACS 2.23.01, 2.04.03, 2.22.02.B1, AND 2.22.02.B2.

WARNING:

WARNING FIRE LINE (NON-POTABLE WATER)
ALL EXISTING, RELOCATED OR PROPOSED DCD/RPDA INSTALLATIONS:

"TO COMPLY WITH THE FEDERAL SAFE DRINKING WATER ACT, THE FIRE LINE OR ANY OF ITS COMPONENTS, SHALL NOT BE USED FOR POTABLE DRINKING WATER AT ANY TIME."

NOTE:

ALL SEWER/STORM DRAINS CROSSING WATER LINES MUST CONFORM TO SECTION 2.22 OF UNIFORM DESIGN AND CONSTRUCTION STANDARD FOR WATER DISTRIBUTION SYSTEMS (UDACS) FOR WATER AND STORM DRAIN CROSSING AND CLEARANCES.

NOTE:

ALL ABOVE GROUND UTILITY SHALL COMPLY WITH TITLE 19.08.010 UTILITY SCREENING REQUIREMENTS. ALL ABOVE GROUND UTILITIES GREATER THAN 27" CUBIC FEET SHALL BE SETBACK A MINIMUM OF 3' FROM THE BACK OF SIDEWALK AND INCLUDE VEGETATION THAT UPON MATURITY WILL ADEQUATELY SCREEN SUCH EQUIPMENT FROM PUBLIC VIEW.

NOTE:

THE DISTRICT CANNOT GUARANTEE A WATERTIGHT SHUTDOWN WHERE CONNECTIONS OR REPAIRS TO EXISTING FACILITIES ARE REQUIRED. THE CONTRACTOR SHALL ENSURE ALL LABOR AND EQUIPMENT IS AVAILABLE TO REMOVE FUGITIVE WATER THAT MAY IMPEDE CONSTRUCTION AT ALL TIMES. COORDINATION WITH INSPECTION DIVISION MUST TAKE PLACE PRIOR TO ANY TRIAL SHUTDOWN. CONTRACTOR TO INSTALL TEMPORARY SERVICE TO ENSURE PROPER SHUTDOWN IN THE EVENT NO OTHER APURTANANCES ARE AVAILABLE.

NOTE:

CONTRACTOR TO INCLUDE COST OF UNDERGROUND UTILITY DETECTION COMPANY TO LOCATE AND MARK ALL EXISTING UTILITIES PRIOR TO ANY REMEDIATION OR EXCAVATION. ENGINEER TO BE PROVIDED WITH AS-BUILT SKETCH OF EXISTING UTILITIES, AND IS TO BE NOTIFIED IMMEDIATELY OF ANY POTENTIAL CONFLICTS WITH PROPOSED UTILITIES AND/OR FINISHED GRADES.

REDUCED PRESSURE DETECTOR ASSEMBLY (RPDA): (2) 10"

THE REDUCED PRESSURE DETECTOR ASSEMBLYS SHALL BE INSTALLED IN ACCORDANCE WITH THE UDACS PLATE NO. 59. NO WATER SHALL BE TAKEN FROM A SERVICE REQUIRING BACKFLOW PREVENTION UNTIL THE ASSEMBLY HAS BEEN SUCCESSFULLY TESTED BY LVWD. ANY BLOCK WALL OR OTHER FENCE MATERIAL SHALL BE DESIGNED AND CONSTRUCTED AROUND THE OUTSIDE OF THE EASEMENT(S) SO AS TO ALLOW LVWD DIRECT ACCESS FROM THE ADJACENT RIGHT-OF-WAY. EASEMENTS SHALL BE CLEARLY MARKED OR STAKED PRIOR TO THE START OF CONSTRUCTION.

REDUCED PRESSURE PRINCIPLE ASSEMBLY (RPPA): (4) 1", (2) 1-1/2", (1) 2"

APPROVED REDUCED PRESSURE PRINCIPLE ASSEMBLY(S) SHALL BE INSTALLED PER U.D.A.C.S. PLATE NO. 8. NO WATER SHALL BE TAKEN FROM A SERVICE REQUIRING BACKFLOW PREVENTION UNTIL THE REDUCED PRESSURE PRINCIPLE ASSEMBLY HAS BEEN SUCCESSFULLY TESTED BY THE LVWD.

ANY BLOCK WALL OR OTHER FENCE MATERIAL SHALL BE DESIGNED AND CONSTRUCTED AROUND THE OUTSIDE OF THE EASEMENT(S) TO ALLOW THE DISTRICT DIRECT ACCESS FROM THE ADJACENT RIGHT-OF-WAY.

EASEMENTS SHALL BE CLEARLY MARKED OR STAKED PRIOR TO THE START OF CONSTRUCTION.

FIRE FLOW CALCULATIONS

BASED ON:	BLDG 1	BLDG 2	C-STORE	CARWASH	STORAGE
SQUARE FOOTAGE:	2,061 SF	4,499 SF	3,868	2,154	94,055
LARGEST AREA BETWEEN SEPARATION WALL:	N/A	N/A	N/A	N/A	N/A
BUILDING HEIGHT:	24'-0"	23'-6"	19'-2"	22'-6"	21'-10 3/8"
NUMBER OF STORIES:	1 STORY	1 STORY	1 STORY	1 STORY	3 STORY
TYPE OF CONSTRUCTION:	V-B	V-B	V-B	V-B	II-B
EXPOSURES:	N/A	N/A	N/A	N/A	N/A
SPRINKLER SYSTEM:	NO	NO	NO	NO	YES
OCCUPANCY:	A-2	A-2/M	W	B	B/R-3/5-1
ROOF CONSTRUCTION:	WOOD TRUSSES W/ PLYWOOD SHEATHING	CLASS C	WOOD TRUSSES	WOOD TRUSSES	CLASS A
FLOW REQUIRED @ 20 PSI RESIDUAL:	1,500 GPM	1,750 GPM	1,750 GPM	1,500 GPM	3,250 GPM

EX. STATIC WATER PRESSURE IS 67.4 psi IN STREET.

FIRE ACCESS NOTES/ LEGEND:

- INSTALL FIRE LANE SIGN AT A MAXIMUM DISTANCE OF EVERY 100' ALONG THE FIRE LANE PER FIRE LANE DETAIL, SHEET C2.01
 - INSTALL FIRE LANE ENTRANCE WARNING SIGN PER DETAIL ON SHEET C2.01.
- NOTE: CURB SHALL BE PAINTED RED ADJACENT TO DESIGNATED FIRE TRUCK ROUTE
- 24' WIDE FIRE TRUCK ACCESSIBLE ROUTE TURNING RADIUS OF 28' & 52' MIN.

NOTE:

REMOVAL OF EXISTING ACTIVE UTILITIES TO BE PHASED AS DIRECTED BY OWNER.

157 Approved 5/11/17
APPROVED FOR CONSTRUCTION

LAS VEGAS VALLEY WATER DISTRICT ENGINEERING SERVICES
PROJECT NO. 125376 FIRST APPROVED DATE: 5/11/18
LVWD APPROVED FIRE FLOW: TOTAL 3,200 GPM/ONSITE 3,200 GPM


NOTE: ALL LOCATIONS OF UTILITIES SHOWN ARE APPROXIMATE

CITY OF LAS VEGAS FIRE DEPARTMENT APPROVAL

BY: *R. M. ...* DATE: 4/18/18


APPROVAL OF THESE PLANS SHALL NOT BE CONSTRUED TO BE A PERMIT FOR, OR AN APPROVAL OF, ANY VIOLATION OF ANY OF THE PROVISIONS OF THE STATE OR COUNTY LAWS. TOTAL FIRE FLOW=3,250 GPM AT 20 P.S.I. RESIDUAL.

PROJECT SITE

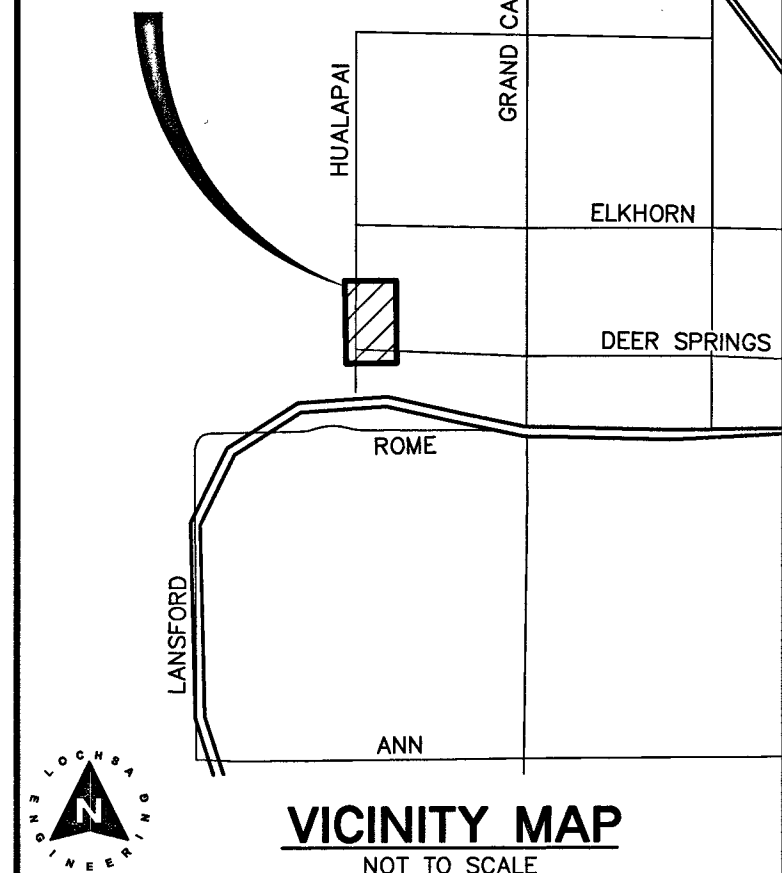

VICINITY MAP

NOT TO SCALE

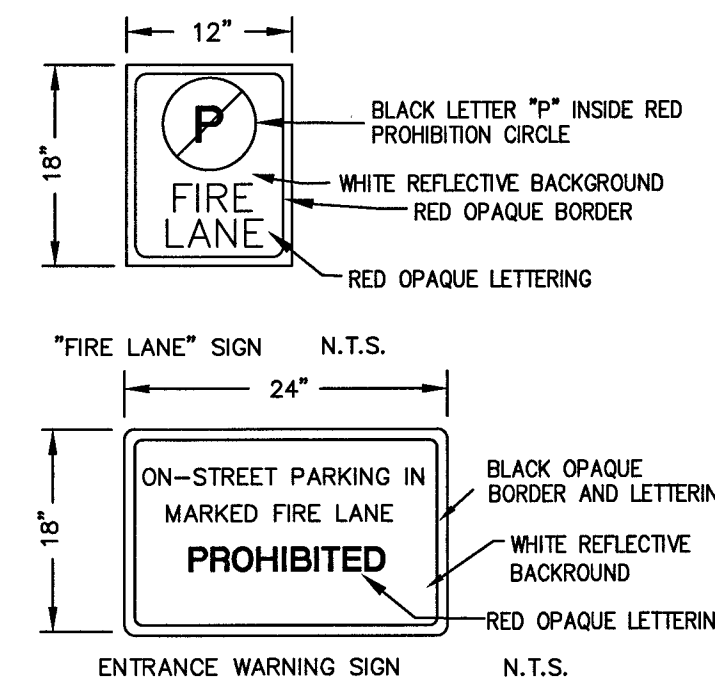

GENERAL UTILITY NOTES:

- STATIC WATER PRESSURE IN ZONE 2975 = 67 PSI.
- THE FIRE SAFETY CONTRACTOR IS RESPONSIBLE FOR ESTABLISHING THE SIZE OF PIPING REQUIRED TO CONNECT FROM THE FIRE WATER LOOP TO THE FIRE SPRINKLER RISER. LINE SIZE SHOWN FOR INFORMATION PURPOSES ONLY.
- TRENCH BACKFILL FOR WATER LINES TO BE CONSTRUCTED PER UDACS PLATE NO. 17, EXCEPT WITHIN RIGHT OF WAY. TRENCH BACKFILL TO BE CONSTRUCTED PER UDACS PLATE NO. 18.
- ONLY SEWER LINES AND LATERALS MAY BE INSTALLED IN TRENCHES EXCAVATED FOR SEWER LINES. SEE DCSWCS SECTION 2.2.18 (TYPICAL).
- WATER AND SEWER TO BE INSTALLED IN SEPARATE TRENCHES WITH AT LEAST 10' MINIMUM SEPARATION FROM EXTERIOR PIPE WALLS (TYPICAL). SEE UDACS SECTION 2.22.
- CONTRACTOR TO SAWCUT AND REMOVE EXISTING ASPHALT AND CONCRETE AS NECESSARY FOR UTILITY TRENCHES, BACKFILL AND PATCH ALL TRENCHES AS INDICATED ON DETAILS AND/OR ACCORDING TO THE GOVERNING ENTITY.
- THESE DRAWINGS MAY NOT INDICATE ALL EXISTING BURIED UTILITY LINES. CONTRACTOR IS TO EXERCISE GREAT CARE DURING EXCAVATION IN ORDER TO AVOID MAKING CONTACT WITH ANY EXISTING UTILITY LINES. IF UTILITY LINES ARE DAMAGED BY THE CONTRACTOR, SUCH DAMAGE SHALL BE REPLACED TO THE SATISFACTION OF THE OWNER AT THE CONTRACTOR'S EXPENSE.
- CONTRACTOR TO LOCATE AND VERIFY SIZE, LINE, TYPE, CONDITION, DEPTH, PRESSURE, AND LOCATION OF ALL EXISTING UTILITY LINES WITHIN THE CONSTRUCTION AREA PRIOR TO CONSTRUCTION. THE CIVIL ENGINEER SHALL BE CONTACTED ONCE THE UTILITY LINE IS LOCATED.
- CONTRACTOR/OWNER TO OBTAIN CITY OF LAS VEGAS OFF-SITE IMPROVEMENT PERMIT FOR ALL WORK WITHIN PUBLIC RIGHT-OF-WAY.
- CONTRACTOR TO VERIFY UTILITY STUB LOCATIONS AND SIZE WITH PLUMBING PLANS PRIOR TO INSTALLATION OF NEW UTILITIES.
- ALL EXISTING STREET LIGHTS INDICATED ON THESE PLANS ARE SHOWN FOR INFORMATION PURPOSES ONLY. LOCATION IS APPROXIMATE UNLESS NOTED WITH STATION AND OFFSET.
- ALL EXISTING GAS LINE LOCATIONS SHOWN ON THESE PLANS ARE APPROXIMATIONS ONLY. PROPOSED GAS LINES SHOWN ON THESE PLANS ARE FOR INFORMATION PURPOSES ONLY. SEE SOUTHWEST GAS PLANS FOR CONSTRUCTION.
- ALL DIMENSIONS TO UTILITIES LINES ARE TO CENTERLINE OF PIPE UNLESS INDICATED OTHERWISE.
- ALL LINEAR FEET OF STORM DRAIN AND SANITARY SEWER PIPE NOTED ON PLANS IS MEASURED FROM CENTER OF MANHOLE TO CENTER OF MANHOLE.

NOTE:

LOCHSA ENGINEERING ASSUMES NO RESPONSIBILITY FOR EXISTING UTILITY LOCATIONS AND ELEVATIONS. THE UTILITIES SHOWN ON THIS PLAN ARE FROM THE BEST AVAILABLE INFORMATION. IT IS THE CONTRACTOR'S RESPONSIBILITY TO FIELD VERIFY THE LOCATION AND ELEVATION OF ALL UTILITIES, INCLUDING BUT NOT LIMITED TO, THE WATER, FIRE, SANITARY SEWER, STORM SEWER, TELEPHONE, POWER, GAS, AND IRRIGATION LINES PRIOR TO THE COMMENCEMENT OF CONSTRUCTION. IF CONFLICT EXISTS IN THE FIELD, THE CONTRACTOR IS TO NOTIFY THE PROJECT ARCHITECT, OWNER'S REPRESENTATIVE AND THE PROJECT ENGINEER IMMEDIATELY.



1-800-227-2800 1-702-432-5300 1-702-227-2929

UTILITY PLANS
SHEET 1 OF 3

DEER SPRINGS AND HUALAPAI
CITY OF LAS VEGAS,
NEVADA

PROJECT NO.: 161109

DATE: APRIL 3, 2018


SCALE: 1"=30'

DRAWN BY: MGZ

DESIGNED BY: MGZ

CHECKED BY: JLI

SEAL

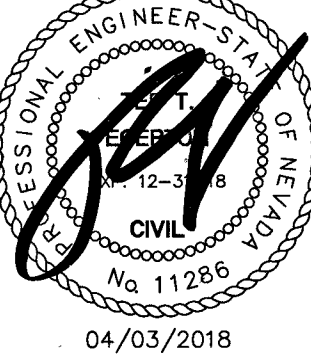

DATE: 04/03/2018

SHEET NO. C2.01

CLV NO. 69418 HTE NO. 17-19758

PROJ #125376 AGR #116293 CS 125-19-NW

NOTE:

CONTRACTOR SHALL EMPLOY A NEVADA LICENSED PROFESSIONAL LAND SURVEYOR (PLS) TO FIELD STAKE THE EXTENT OF THE PROPOSED EXISTING LVWD EASEMENT WITHIN THE PROJECT SITE. THESE STAKES SHALL BE CONTINUOUSLY MAINTAINED DURING THE CONSTRUCTION OF THE PROJECT. THE PLS SHALL ALSO FIELD STAKE THE PROPOSED EXTENT OF ADJACENT PROJECT BUILDING IMPROVEMENTS IMMEDIATELY ADJACENT TO THE EASEMENT. CONTRACTOR SHALL NOTIFY THE LVWD INSPECTOR AT LEAST FORTY-EIGHT (48) HOURS PRIOR TO THE INITIAL BUILDING EXCAVATION AND FOUNDATION CONSTRUCTION ACTIVITY. LVWD WILL INSPECT THE FIELD STAKING FOR COMPLIANCE WITH SEPARATION REQUIREMENTS. THE CONTRACTOR SHALL NOTIFY THE LVWD PRIOR TO UTILITY TRENCHING OR ANY OTHER SUBGRADE EFFORTS WITHIN THE PROPOSED/EXISTING LVWD EASEMENT.

A WATER CONNECTION


SEWER CONSTRUCTION NOTES:

- NOT ALL NOTES USED ON THIS SHEET
- STUB & CAP SANITARY SEWER SERVICE. REFER TO PLUMBING PLANS FOR CONTINUATION.
- INSTALL 48" SANITARY SEWER MANHOLE & BASE PER DCSWCS DWG. NO. SD-1A & SD-1B, CONCRETE COLLAR PER SD-4, SINGLE COVER 24"
- INSTALL WYE LATERAL CONNECTION PER DCSWCS DWG. NO. SD-22.
- INSTALL SEWER CLEAN-OUT PER DCSWCS DWG. NO. SD-26.
- INSTALL 1500 GALLON SAND/OIL INTERCEPTOR BY OTHERS
- NOT USED
- SAMPLE MANHOLE FOR INTERCEPTOR(S) BY OTHERS
- INSTALL SEWER BACK WATER VALVE.

WATER CONSTRUCTION NOTES:

- ALL WATER CONSTRUCTION TO BE DONE IN ACCORDANCE WITH "UNIFORM DESIGN AND CONSTRUCTION STANDARDS FOR WATER DISTRIBUTION SYSTEMS (UDACS)" LATEST EDITION.
- NOT ALL NOTES USED ON THIS SHEET
- INSTALL 10" RPDA PER UDACS PLATE NO. 59.
- NOT USED.
- INSTALL 3/4" METER PER DETAIL ON SHEET C2.03
- INSTALL 1-1/2" RPDA PER DETAIL ON SHEET C2.03
- INSTALL 1-1/2" METER PER DETAIL ON SHEET C2.03
- INSTALL REDUCER (SAME SIZE AS PIPES)
- INSTALL FIRE HYDRANT W/ GATE VALVE PER UDACS PLATE NO. 40.
- INSTALL SERVICE SADDLE (SAME SIZE AS PIPE) PER DETAIL ON SHEET C2.03
- INSTALL GATE VALVE (SAME SIZE AS PIPE) PER UDACS PLATE NO. 31.
- INSTALL 90° BEND W/THRUST BLOCK (SAME SIZE AS PIPE) PER UDACS PLATE NO. 31.
- INSTALL 45° BEND W/THRUST BLOCK (SAME SIZE AS PIPE) PER UDACS PLATE NO. 31
- INSTALL 22.5° BEND W/THRUST BLOCK (SAME SIZE AS PIPE) PER UDACS PLATE NO. 31
- INSTALL 11.25° BEND W/THRUST BLOCK (SAME SIZE AS PIPE) PER UDACS PLATE NO. 31
- INSTALL TEE (SAME SIZE AS PIPES) PER UDACS PLATE NO. 31.
- STUB & CAP WATER SERVICE. REFER TO PLUMBING PLANS FOR CONTINUATION.
- STUB & CAP WATER SERVICE. REFER TO LANDSCAPE PLANS FOR CONTINUATION.
- STUB & CAP WATER SERVICE.
- INSTALL 90° BEND (SAME SIZE AS PIPE) PER UDACS PLATE NO. 31.
- INSTALL 45° BEND (SAME SIZE AS PIPE) PER UDACS PLATE NO. 31
- INSTALL 22.5° BEND (SAME SIZE AS PIPE) PER UDACS PLATE NO. 31
- INSTALL 11.25° BEND (SAME SIZE AS PIPE) PER UDACS PLATE NO. 31
- INSTALL 1" RPDA PER DETAIL ON SHEET C2.03
- INSTALL 1" METER PER DETAIL ON SHEET C2.03
- INSTALL RETAINING WALL WITH HANDRAIL PER STRUCTURAL DRAWINGS.
- INSTALL 2" RPDA PER DETAIL ON SHEET C2.03
- INSTALL 2" METER PER DETAIL ON SHEET C2.03

GRAPHIC SCALE

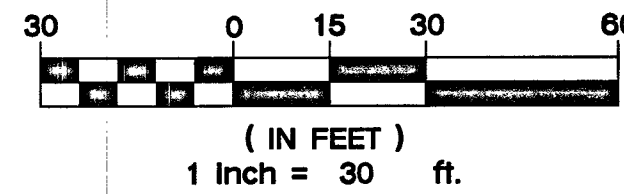

FIRE WATER AT DOMESTIC WATER CROSSINGS

ALL NON-POTABLE FIRE WATER LINES CROSSING POTABLE DOMESTIC WATER LINES ARE TO BE INSTALLED WITH "A" VERTICAL SEPARATION OF NO LESS THAN 12 INCHES. AND IN ACCORDANCE WITH UDACS 2.23.01, 2.04.03, 2.22.02.B1, AND 2.22.02.B2.

WARNING:

WARNING FIRE LINE (NON-POTABLE WATER)
ALL EXISTING, RELOCATED OR PROPOSED DCD/RPDA INSTALLATIONS:

"TO COMPLY WITH THE FEDERAL SAFE DRINKING WATER ACT, THE FIRE LINE OR ANY OF ITS COMPONENTS, SHALL NOT BE USED FOR POTABLE DRINKING WATER AT ANY TIME."

NOTE:

ALL SEWER/STORM DRAINS CROSSING WATER LINES MUST CONFORM TO SECTION 2.22 OF UNIFORM DESIGN AND CONSTRUCTION STANDARD FOR WATER DISTRIBUTION SYSTEMS (UDACS) FOR WATER AND STORM DRAIN CROSSING AND CLEARANCES.

NOTE:

ALL ABOVE GROUND UTILITY SHALL COMPLY WITH TITLE 19.08.010 UTILITY SCREENING REQUIREMENTS. ALL ABOVE GROUND UTILITIES GREATER THAN 27 CUBIC FEET SHALL BE SETBACK A MINIMUM OF 3' FROM THE BACK OF SIDEWALK AND SHALL INCLUDE VEGETATION THAT UPON MATURITY WILL ADEQUATELY SCREEN SUCH EQUIPMENT FROM PUBLIC VIEW.

NOTE:

THE DISTRICT CANNOT GUARANTEE A WATERTIGHT SHUTDOWN WHERE CONNECTIONS OR REPAIRS TO EXISTING FACILITIES ARE REQUIRED. THE CONTRACTOR SHALL ENSURE ALL LABOR AND EQUIPMENT IS AVAILABLE TO REMOVE FUGITIVE WATER THAT MAY IMPEDE CONSTRUCTION AT ALL TIMES. COORDINATION WITH INSPECTION DIVISION MUST TAKE PLACE PRIOR TO ANY TRIAL SHUTDOWN. CONTRACTOR TO INSTALL TEMPORARY SERVICE TO ENSURE PROPER SHUTDOWN IN THE EVENT NO OTHER AFFURTANCES ARE AVAILABLE.

NOTE:

CONTRACTOR TO INCLUDE COST OF UNDERGROUND UTILITY DETECTION COMPANY TO LOCATE AND MARK ALL EXISTING UTILITIES PRIOR TO ANY DEMOLITION OR EXCAVATION. ENGINEER TO BE PROVIDED WITH AS-BUILT SKETCH OF EXISTING UTILITIES, AND IS TO BE NOTIFIED IMMEDIATELY OF ANY POTENTIAL CONFLICTS WITH PROPOSED UTILITIES AND/OR FINISHED GRADES.

REDUCED PRESSURE DETECTOR ASSEMBLY (RPDA): (2) 10"

THE REDUCED PRESSURE DETECTOR ASSEMBLY(S) SHALL BE INSTALLED IN ACCORDANCE WITH THE UDACS PLATE NO. 59. NO WATER SHALL BE TAKEN FROM A SERVICE REQUIRING BACKFLOW PREVENTION UNTIL THE ASSEMBLY HAS BEEN SUCCESSFULLY TESTED BY LVWD. ANY BLOCK WALL OR OTHER FENCE MATERIAL SHALL BE DESIGNED AND CONSTRUCTED AROUND THE OUTSIDE OF THE EASEMENT(S) SO AS TO ALLOW LVWD DIRECT ACCESS FROM THE ADJACENT RIGHT-OF-WAY. EASEMENTS SHALL BE CLEARLY MARKED OR STAKED PRIOR TO THE START OF CONSTRUCTION.

REDUCED PRESSURE PRINCIPLE ASSEMBLY (RPDA): (4) 1", (2) 1-1/2", (1) 2"

APPROVED REDUCED PRESSURE PRINCIPLE ASSEMBLY(S) SHALL BE INSTALLED PER THE U.D.A.C.S. PLATE NO. 8. NO WATER SHALL BE TAKEN FROM A SERVICE REQUIRING BACK FLOW PREVENTION UNTIL THE REDUCED PRESSURE PRINCIPLE ASSEMBLY HAS BEEN SUCCESSFULLY TESTED BY THE LVWD.

ANY BLOCK WALL OR OTHER FENCE MATERIAL SHALL BE DESIGNED AND CONSTRUCTED AROUND THE OUTSIDE OF THE EASEMENT(S) TO ALLOW THE DISTRICT DIRECT ACCESS FROM THE ADJACENT RIGHT-OF-WAY.

EASEMENTS SHALL BE CLEARLY MARKED OR STAKED PRIOR TO THE START OF CONSTRUCTION.

FIRE FLOW CALCULATIONS

BASED ON:	BLDG 1	BLDG 2	C-STORE	CARWASH	STORAGE
SQUARE FOOTAGE:	2,061 SF	4,499 SF	3,868	2,154	94,055
LARGEST AREA BETWEEN SEPARATION WALL:	N/A	N/A	N/A	N/A	N/A
BUILDING HEIGHT:	24'-0"	23'-6"	19'-2"	22'-6"	21'-10 3/8"
NUMBER OF STORIES:	1 STORY	1 STORY	1 STORY	1 STORY	3 STORY
TYPE OF CONSTRUCTION:	V-B	V-B	V-B	V-B	II-B
EXPOSURES:	N/A	N/A	N/A	N/A	N/A
SPRINKLER SYSTEM:	NO	NO	NO	NO	YES
OCCUPANCY:	A-2	A-2/M	W	B	B/R-3/5-1
ROOF CONSTRUCTION:	WOOD TRUSSES W/ FLYWOOD SHEATHING	CLASS C	WOOD TRUSSES	WOOD TRUSSES	CLASS A
FLOW REQUIRED @ 20 PSI RESIDUAL:	1,500 GPM	1,750 GPM	1,750 GPM	1,500 GPM	3,250 GPM

EX. STATIC WATER PRESSURE IS 67.4 psi IN STREET.

FIRE ACCESS NOTES/ LEGEND:

- INSTALL FIRE LANE SIGN AT A MAXIMUM DISTANCE OF EVERY 100' ALONG THE FIRE LANE PER FIRE LANE DETAIL SHEET C2.01
- INSTALL FIRE LANE ENTRANCE WARNING SIGN PER DETAIL ON SHEET C2.01.

NOTE:

REMOVAL OF EXISTING ACTIVE UTILITIES TO BE PHASED AS DIRECTED BY OWNER.

APPROVED FOR CONSTRUCTION

LAS VEGAS VALLEY WATER DISTRICT ENGINEERING SERVICES
PROJECT No. 125376 FIRST APPROVED DATE: 5/14/18
LVWD APPROVED FIRE FLOW: TOTAL 3,200 GPM/ONSITE 3,200 GPM
NOTE: ALL LOCATIONS OF UTILITIES SHOWN ARE APPROXIMATE



CITY OF LAS VEGAS

FIRE DEPARTMENT APPROVAL

BY: *[Signature]* DATE: 4/10/18

APPROVAL OF THESE PLANS SHALL NOT BE CONSTRUED TO BE A PERMIT FOR, OR AN APPROVAL OF, ANY VIOLATION OF ANY OF THE PROVISIONS OF THE STATE OR COUNTY LAWS. TOTAL FIRE FLOW=3,250 GPM AT 20 P.S.I. RESIDUAL.

PROJECT SITE

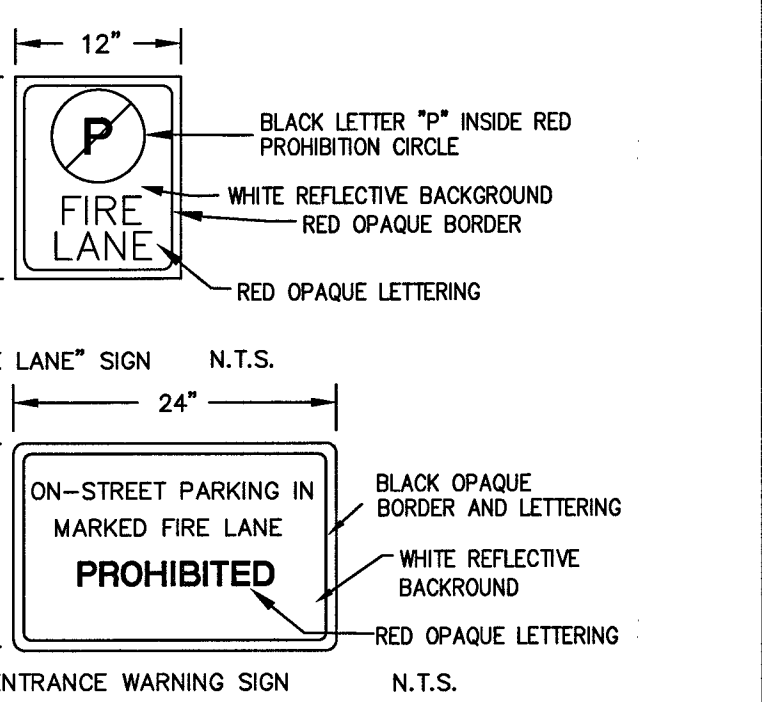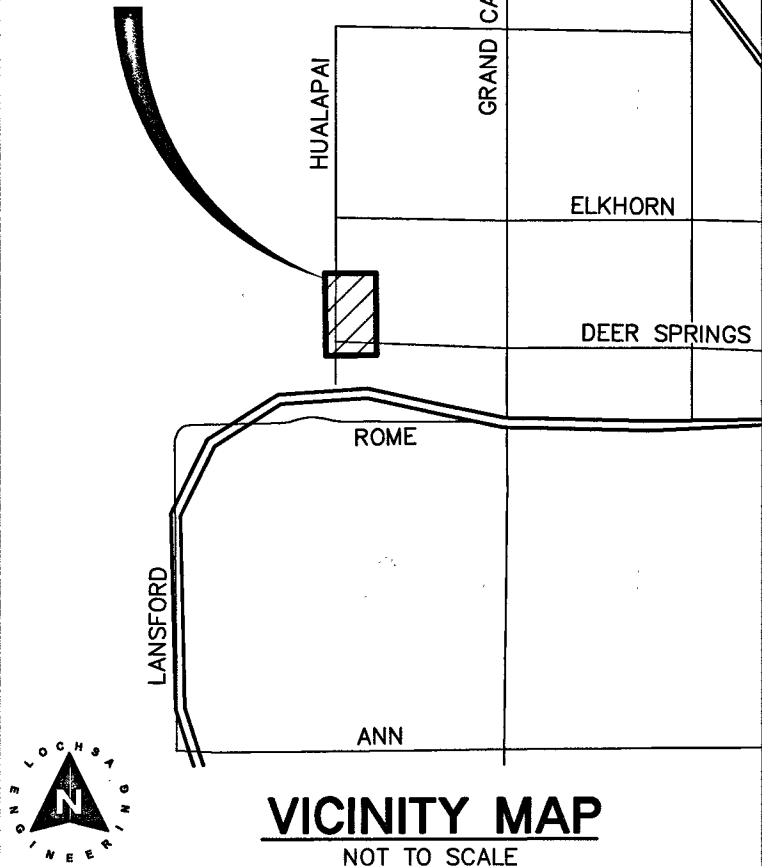

GENERAL UTILITY NOTES:

- STATIC WATER PRESSURE IN ZONE 2975 = 67 PSI.
- THE FIRE SAFETY CONTRACTOR IS RESPONSIBLE FOR ESTABLISHING THE SIZE OF PIPING REQUIRED TO CONNECT FROM THE FIRE WATER LOOP TO THE FIRE SPRINKLER RISER. LINE SIZE SHOWN FOR INFORMATION PURPOSES ONLY.
- TRENCH BACKFILL FOR WATER LINES TO BE CONSTRUCTED PER UDACS PLATE NO. 17, EXCEPT WITHIN RIGHT OF WAY. TRENCH BACKFILL TO BE CONSTRUCTED PER UDACS SECTION 2.2.18 (TYPICAL).
- ONLY SEWER LINES AND LATERALS MAY BE INSTALLED IN TRENCHES EXCAVATED FOR SEWER LINES. SEE DCSWCS SECTION 2.2.18 (TYPICAL).
- WATER AND SEWER TO BE INSTALLED IN SEPARATE TRENCHES WITH AT LEAST 10' MINIMUM SEPARATION FROM EXTERIOR PIPE WALLS (TYPICAL). SEE UDACS SECTION 2.22.
- CONTRACTOR TO SAWCUT AND REMOVE EXISTING ASPHALT AND CONCRETE AS NECESSARY FOR UTILITY TRENCHES. BACKFILL AND PATCH ALL TRENCHES AS INDICATED ON DETAILS AND/OR ACCORDING TO THE GOVERNING ENTITY.
- THESE DRAWINGS DO NOT INDICATE ALL EXISTING BURIED UTILITY LINES. CONTRACTOR IS TO EXERCISE GREAT CARE DURING EXCAVATION IN ORDER TO AVOID MAKING CONTACT WITH ANY EXISTING UTILITY LINES. IF UTILITY LINES ARE DAMAGED BY THE CONTRACTOR, SUCH DAMAGE SHALL BE REPLACED TO THE SATISFACTION OF THE OWNER AT THE CONTRACTOR'S EXPENSE.
- CONTRACTOR TO LOCATE AND VERIFY SIZE, LINE TYPE, CONDITION, DEPTH, PRESSURE, AND LOCATION OF ALL EXISTING UTILITY LINES WITHIN THE CONSTRUCTION AREA PRIOR TO CONSTRUCTION. THE CIVIL ENGINEER SHALL BE CONTACTED ONCE THE UTILITY LINE IS LOCATED.
- CONTRACTOR/OWNER TO OBTAIN CITY OF LAS VEGAS OFF-SITE IMPROVEMENT PERMIT FOR ALL WORK WITHIN PUBLIC RIGHT-OF-WAY.
- CONTRACTOR TO VERIFY UTILITY STUB LOCATIONS AND SIZE WITH PLUMBING PLANS PRIOR TO INSTALLATION OF NEW UTILITIES.
- ALL EXISTING STREET LIGHTS INDICATED ON THESE PLANS ARE SHOWN FOR INFORMATION PURPOSES ONLY. LOCATION IS APPROXIMATE UNLESS NOTED WITH STATION AND OFFSET.
- ALL EXISTING GAS LINE LOCATIONS SHOWN ON THESE PLANS ARE APPROXIMATIONS ONLY. PROPOSED GAS LINES SHOWN ON THESE PLANS ARE FOR COORDINATION ONLY. SEE SOUTHWEST GAS PLANS FOR CONSTRUCTION.
- ALL DIMENSIONS TO UTILITIES LINES ARE TO CENTERLINE OF PIPE UNLESS INDICATED OTHERWISE.
- ALL LINEAR FEET OF STORM DRAIN AND SANITARY SEWER PIPE NOTED ON PLANS IS MEASURED FROM CENTER OF MANHOLE TO CENTER OF MANHOLE.

NOTE:

LOCHSA ENGINEERING ASSUMES NO RESPONSIBILITY FOR EXISTING UTILITY LOCATIONS AND ELEVATIONS. THE UTILITIES SHOWN ON THIS PLAN ARE FROM THE BEST AVAILABLE INFORMATION. IT IS THE CONTRACTOR'S RESPONSIBILITY TO FIELD VERIFY THE LOCATION AND ELEVATION OF ALL UTILITIES, INCLUDING BUT NOT LIMITED TO, THE WATER, FIRE, SANITARY SEWER, STORM SEWER, TELEPHONE, POWER, GAS, AND IRRIGATION LINES PRIOR TO THE COMMENCEMENT OF CONSTRUCTION. IF CONFLICT EXISTS IN THE FIELD, THE CONTRACTOR IS TO NOTIFY THE PROJECT ARCHITECT, OWNER'S REPRESENTATIVE AND THE PROJECT ENGINEER IMMEDIATELY.



1-800-227-2800 1-702-432-5300 1-702-227-2929

UTILITY PLANS
SHEET 2 OF 3

DEER SPRINGS AND HUALAPAI
CITY OF LAS VEGAS,
NEVADA

PROJECT No.: 161109


DATE: APRIL 3, 2018

SCALE: 1"=30'

DRAWN BY: MGZ

DESIGNED BY: MGZ

CHECKED BY: JLI

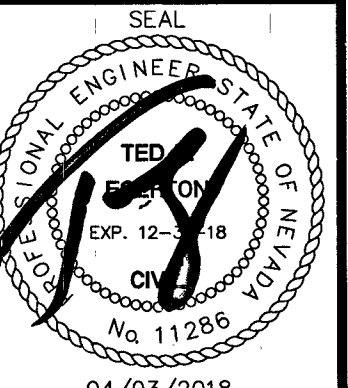

1715 800 SHEET No.



C2.02

CLV No. HTE No.

69418 17-19758

FOR CONTINUATION SEE SHEET C3.02

CITY OF LAS VEGAS JURISDICTION CLARK COUNTY NEVADA JURISDICTION

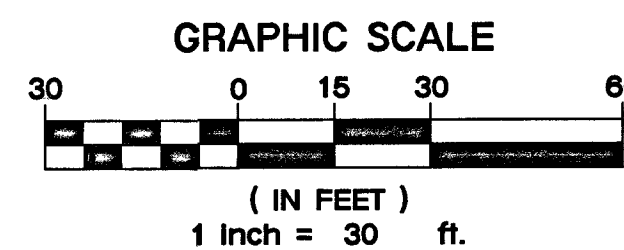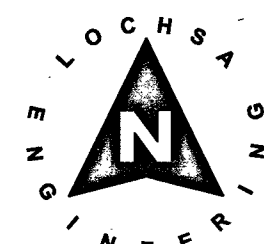


CLARK COUNTY DEPARTMENT OF PUBLIC WORKS DEVELOPMENT REVIEW
ACCEPTANCE OF PLANS FOR FILING:

BY: _____ DATE: _____

ACCEPTANCE OF THESE PLANS FOR FILING SHALL NOT BE CONSTRUED TO BE A PERMIT FOR, OR AN APPROVAL OF, ANY VIOLATION OF ANY OF THE PROVISIONS OF THE STATE OR COUNTY LAWS AND/OR SPECIFICATIONS. CLARK COUNTY SHALL BE HELD FREE FROM DAMAGES WHICH MAY RESULT FROM THE CONSTRUCTION OF THE IMPROVEMENTS FROM THE ENGINEERING DESIGN DEPICTED HEREIN. NOTE: POWER POLES AND/OR OTHER EXISTING FACILITIES NOT IN PROPER LOCATION, BASED ON PROPOSED IMPROVEMENTS SHOWN HEREON WILL BE RELOCATED AT NO EXPENSE TO CLARK COUNTY.

PROFILE OF NORTH ENTRANCE

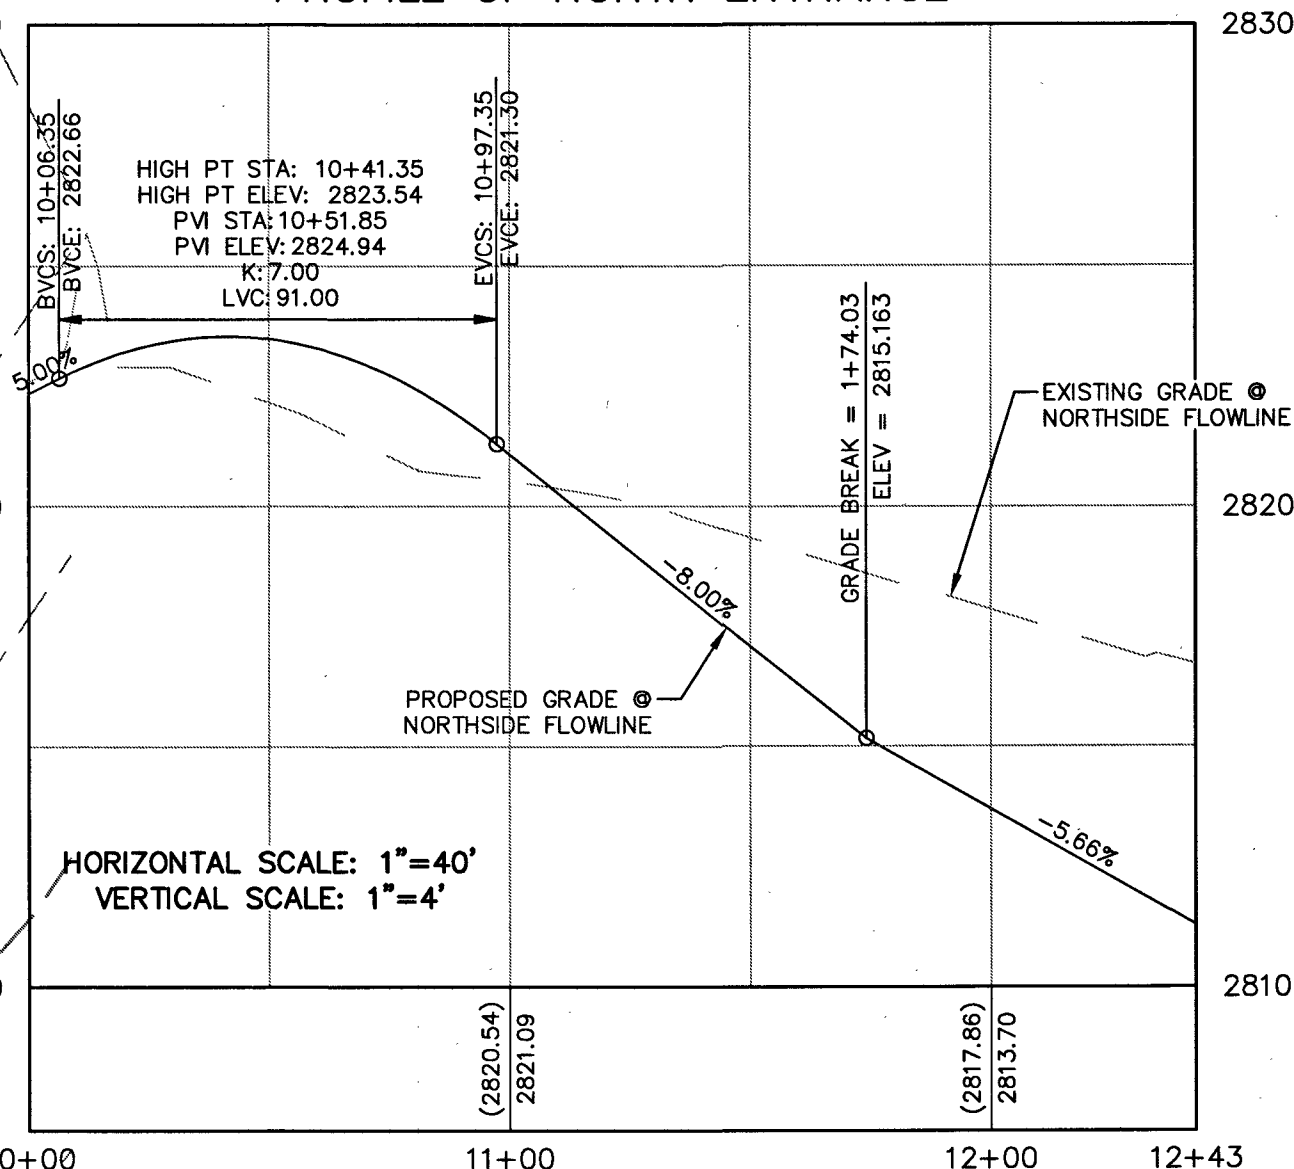

FLOOD ZONE NOTE:

THE PROJECT SITE IS COVERED BY THE FLOOD INSURANCE RATE MAP (FIRM) FOR THE CLARK COUNTY, NEVADA, AND INCORPORATED AREAS, COMMUNITY PANEL NUMBER: 32003C1750E, EFFECTIVE DATE: SEPTEMBER 27, 2002. THE PROJECT SITE FALLS WITHIN ZONE X (UNSHADDED), DESCRIBED BY FEMA AS: AREAS DETERMINED TO BE OUTSIDE THE 0.2% ANNUAL CHANCE FLOODPLAIN.

CUT	FILL	NET
19,474.46 CY	3,290.62 CY	16,183.83 CY

NOTE: CUT/FILL QUANTITIES ARE TO FINISHED GRADE & DO NOT INCLUDE MATERIAL THICKNESS, FOOTINGS, ETC.

A.P.N.: 125-19-202-006

BASIS OF BEARINGS:

SOUTH 89°47'00" EAST, BEING THE BEARING OF THE SOUTH LINE OF THE SOUTHWEST QUARTER (SW 1/4) OF THE SOUTHWEST QUARTER (SW 1/4) OF SECTION 19, TOWNSHIP 19 SOUTH, RANGE 60 EAST, M.D.M., ALSO BEING THE CENTERLINE OF CENTENNIAL PARKWAY AS MEASURED BETWEEN HUALAPAI WAY AND CONQUISTADOR STREET AS SHOWN ON FILE 107, PAGE 31 OF SURVEYS IN THE RECORDER'S OFFICE, CLARK COUNTY, NEVADA.

BENCHMARK:

RIVET & PLATE IN TOP OF CURB AT THE SOUTHEAST CORNER OF THE BRIDGE OVER CLARK COUNTY HIGHWAY 215 ON HUALAPAI ELEVATION = 853.317 METERS) 2799.59 (U.S. SURVEY FEET) NORTH AMERICAN VERTICAL DATUM OF 1988

STORM DRAIN

CONSTRUCTION NOTES:

- NOT ALL NOTES USED ON THIS SHEET -
- INSTALL 48" TYPE 1 STORM DRAIN MANHOLE PER C.C.A.U.S.D. No. 403
- CONSTRUCT 2.5" TYPE "CM2" DROP INLET PER C.C.A.U.S.D. Nos. 412.1 AND 421
- RCP STORM DRAIN TO BE INSTALLED WITH JOINT GASKETS PER UDACS SECTION 2, PARAGRAPH 2.22.02-D

CONSTRUCTION NOTES:

- ALL CONSTRUCTION TO BE DONE IN ACCORDANCE WITH "CLARK COUNTY AREA UNIFORM STANDARD DRAWINGS C.C.A.U.S.D." 1" EDITION AND/OR REGULATING ENTITY HAVING JURISDICTION.
- NOT ALL NOTES USED ON THIS SHEET -
- CONSTRUCT AC PAVEMENT PER DETAIL 3 ON C6.01.
- CONSTRUCT TYPICAL BUS STOP PER CCAUSD #234.1
- CONSTRUCT "A" TYPE CURB PER DETAIL 4 SHEET C6.01
- CONSTRUCT "L" TYPE CURB PER CCAUSD No. 216.
- CONSTRUCT CONC. SIDEWALK PER CCAUSD No. 234.
- CONSTRUCT VALLEY GUTTER PER CCAUSD No. 228
- CONSTRUCT SIDEWALK RAMP CCAUSD No. 235 CASE I.
- LANDSCAPING - REFER TO LANDSCAPE PLANS FOR SPECIFICATIONS.
- CONSTRUCT 2" VALLEY GUTTER PER DETAIL 8 ON C6.01
- CONSTRUCT SIDEWALK DRAIN PER C.C.A.U.S.D. No. 236
- CONSTRUCT MODIFIED CURB RAMP PER DETAIL 1 ON SHEET C6.01
- INSTALL RIP RAP SWALES PER DETAIL 5 ON C6.01 WITH CURB CUTS PER DETAIL 6 ON C6.01
- SAWOUT AND MATCH EXISTING PAVEMENT
- CONSTRUCT SIDEWALK RAMP PER DETAIL 13 ON C6.02
- CONSTRUCT CONC. "U" CHANNEL PER DETAIL 2 ON C6.01
- PROPOSED WALL BY OTHERS
- PROPOSED GATE BY OTHERS
- CONSTRUCT BUS STOP PASSENGER SHELTER PAD PER CCAUSD #234.2
- RETAINING WALL BY OTHERS
- CONSTRUCT 2' WIDE CURB OPENING
- CONSTRUCT PARKING BUMPER PER DETAIL 14 ON C6.02
- CONSTRUCT CONC. PAVEMENT PER DETAIL 7 ON C6.01
- PROPOSED TRASH ENCLOSURE PER ARCH. PLANS
- CONSTRUCT SIDEWALK RAMP PER DETAIL 15 ON C6.02
- CONSTRUCT "A" TYPE ISLAND CURB PER CCAUSD #219
- RETAINING WALL WITH HANDRAIL BY OTHERS
- CONSTRUCT MODIFIED CURB RAMP PER DETAIL 16 ON SHEET C6.02
- INSTALL DETECTABLE WARNING (TRUNCATED DOMES) PER CCAUSD No. 235, SHEET 4.
- INSTALL ENHANCED PAVEMENT PER ARCHITECTURAL DRAWINGS.
- CONSTRUCT 1' WIDE CURB OPENING


GENERAL GRADING NOTES:

- PRIOR TO INSTALLATION OF STORM OR SANITARY SEWER, WATER MAIN OR ANY OTHER UTILITIES, THE CONTRACTOR SHALL EXCAVATE, VERIFY, AND CALCULATE ALL POINTS OF CONNECTION AND UTILITIES CROSSINGS AND INFORM THE OWNER AND THE ENGINEER OF ANY CONFLICTS OR REQUIRED DEVIATIONS FROM THE PLAN PRIOR TO CONSTRUCTION. NOTIFICATION SHALL BE MADE A MINIMUM OF 72 HOURS PRIOR TO CONSTRUCTION. THE ENGINEER AND ITS CLIENTS SHALL BE HELD HARMLESS IN THE EVENT THAT THE CONTRACTOR FAILS TO MAKE SUCH NOTIFICATION.
- ALL SLOPES AND AREAS DISTURBED BY CONSTRUCTION SHALL BE GRADED SMOOTH AND FOUR INCHES OF TOPSOIL APPLIED IF ADJACENT TOPSOIL IS NOT AVAILABLE ON SITE. THE CONTRACTOR SHALL PROVIDE TOPSOIL, APPROVED BY THE OWNER, AS NEEDED. THE AREA SHALL THEN BE SEED/COVERED. FERTILIZER, MULCH, AND MAINTAINED UNTIL HARDY GRASS GROWTH IS ESTABLISHED IN ALL AREAS. ANY RELOCATED TREES SHALL BE MAINTAINED UNTIL SUCH POINT AS TREE IS RE-ESTABLISHED. ANY AREAS DISTURBED FOR ANY REASON PRIOR TO FINAL ACCEPTANCE OF THE PROJECT SHALL BE CORRECTED BY THE CONTRACTOR AT NO ADDITIONAL COST TO THE OWNER.
- THE CONTRACTOR IS SPECIFICALLY CAUTIONED THAT THE LOCATION AND/OR ELEVATION OF EXISTING UTILITIES AS SHOWN ON THESE PLANS IS BASED ON RECORDS OF THE VARIOUS UTILITY COMPANIES, AND WHERE POSSIBLE, MEASUREMENTS TAKEN IN THE FIELD. THE INFORMATION IS NOT TO BE RELIED ON AS BEING EXACTLY COMPLETE. THE CONTRACTOR MUST CALL THE APPROPRIATE UTILITY COMPANY AT LEAST 72 HOURS BEFORE ANY EXCAVATION TO REQUEST EXACT FIELD LOCATION OF UTILITIES.
- REFER TO GEOTECHNICAL REPORT FOR SPECIFIC SITE SOIL CONDITIONS AND CONSIDERATIONS.
- CONTRACTOR SHALL COMPLY COMPLETELY WITH THE LATEST STANDARDS OF OSHA DIRECTIVES OR ANY OTHER AGENCY HAVING JURISDICTION FOR EXCAVATION AND TRENCHING PROCEDURES. THE CONTRACTOR SHALL USE SUPPORT SYSTEMS, SLOPING, BENCHING AND OTHER MEANS OF PROTECTION. THIS IS TO INCLUDE, BUT NOT LIMITED TO ACCESS AND EGRESS FROM ALL EXCAVATION AND TRENCH. CONTRACTOR IS RESPONSIBLE FOR COMPLYING WITH PERFORMANCE CRITERIA AS REQUIRED BY OSHA.

GRADING PLAN CERTIFICATION

CERTIFY THAT THIS GRADING PLAN IS IN CONFORMANCE WITH APPROVED DRAINAGE STUDY FOR THIS SITE ON FILE AT THE CITY OF LAS VEGAS AND CLARK COUNTY FOR THIS PROJECT.
DS#4857/DS#17-10295

PROJECT SITE

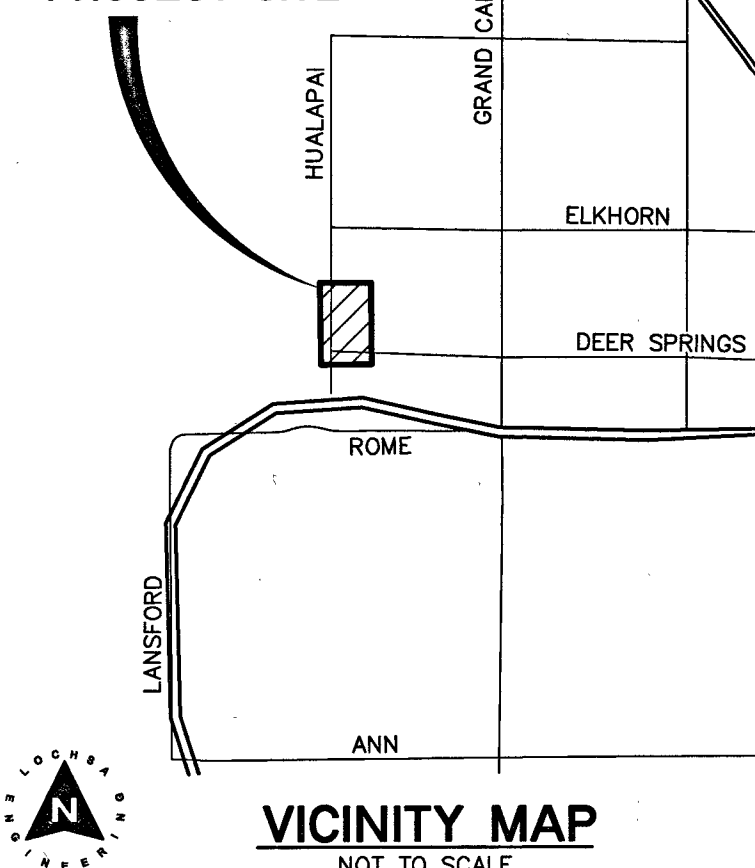

GRADING NOTES:

- SLOPES 4:1 OR STEEPER AND FINE-GRAINED MATERIALS THAT HAVE BEEN DISTURBED (SANDY AND SILTY MATERIALS) SHOULD BE PROTECTED WITH BURLAP OR OTHER EROSION CONTROL FABRIC/MATERIAL, UNLESS OTHERWISE SPECIFIED BY LANDSCAPE DRAWINGS AND SPECIFICATIONS OR THE SOILS REPORT.
- CONTRACTOR SHALL DETERMINE HIS OWN FOOTING OR BASEMENT EXCAVATION QUANTITIES, EVEN THOUGH SHOWN ON ROUGH GRADING PLANS. ADDITIONALLY, STRUCTURE BACKFILL COSTS SHOULD BE INCLUDED IN THE COST OF THE STRUCTURE, UNLESS OTHERWISE SPECIFIED IN THE CONTRACT DOCUMENTS.
- CONTRACTOR SHALL NOTIFY LOCHSA ENGINEERING WITHIN 24 HOURS OF OMISSIONS AND ERRORS DISCOVERED ON PLANS. LOCHSA ENGINEERING WILL NOT BE RESPONSIBLE FOR ANY "CORRECTIVE" WORK DONE BY OTHERS.
- CONTRACTOR TO ENSURE POSITIVE DRAINAGE. NO PONDING ALLOWED. CONTRACTOR TO FOLLOW RECOMMENDATIONS AS OUTLINED IN THE PROJECT GEOTECHNICAL REPORT, INCLUDING BUT NOT LIMITED TO EXCAVATION, GRADING AND COMPACTION. REFER TO THE REPORT PREPARED BY: GEOTEK, INC., PROJECT No. 13092-LV, DATED: AUGUST 31, 2016.

LAS VEGAS VALLEY CONSTRUCTION SITE BEST MANAGEMENT PRACTICES GUIDANCE MANUAL SECTION 3.5.1 STANDARD NOTES 1-5

- THE OWNER, SITE DEVELOPER, CONTRACTOR, AND/OR THEIR AUTHORIZED AGENTS SHALL EACH DAY REMOVE ALL SEDIMENT, MUD, CONSTRUCTION DEBRIS, OR OTHER POTENTIAL POLLUTANTS THAT MAY HAVE BEEN DISCHARGED TO, OR ACCUMULATED IN, THE PUBLIC RIGHT-OF-WAY OF THE (INSERT JURISDICTION). AS A RESULT OF CONSTRUCTION ACTIVITIES ASSOCIATED WITH THIS SITE DEVELOPMENT OR CONSTRUCTION PROJECT, SUCH MATERIAL SHALL BE PREVENTED FROM ENTERING THE STORM SEWER SYSTEM.
- ADDITIONAL CONSTRUCTION SITE DISCHARGE BEST MANAGEMENT PRACTICES MAY BE REQUIRED OF THE OWNER AND HIS OR HER AGENTS DUE TO UNFORESEEN EROSION PROBLEMS OR IF THE SUBMITTED PLAN DOES NOT MEET THE PERFORMANCE STANDARDS SPECIFIED IN THE (INSERT JURISDICTION). AND THE LAS VEGAS VALLEY CONSTRUCTION SITE BMP GUIDANCE MANUAL.
- TEMPORARY OR PERMANENT STABILIZATION PRACTICES WILL BE INSTALLED ON DISTURBED AREAS AS SOON AS PRACTICABLE AND NO LATER THAN 14 DAYS AFTER THE CONSTRUCTION ACTIVITY IN THAT PORTION OF THE SITE HAS TEMPORARILY OR PERMANENTLY CEASED. SOME EXCEPTIONS MAY APPLY; REFER TO THE NEVADA STORMWATER GENERAL PERMIT FOR CONSTRUCTION ACTIVITY NVR100000, SECTION III.A.5.
- AT A MINIMUM, THE CONTRACTOR OR HIS AGENT SHALL INSPECT ALL DISTURBED AREAS, AREAS USED FOR STORAGE OF MATERIALS AND EQUIPMENT THAT ARE EXPOSED TO PRECIPITATION, VEHICLE ENTRANCE AND EXIT LOCATIONS, AND ALL BMPs WEEKLY, AND WITHIN 24 HOURS AFTER ANY RAIN EVENT OR 0.5 INCHES OR MORE OF RAIN. THE CONTRACTOR OR HIS AGENT SHALL UPDATE OR MODIFY THE STORMWATER POLLUTION PREVENTION PLAN AS NECESSARY. SOME EXCEPTIONS TO WEEKLY INSPECTIONS MAY APPLY, SUCH AS SUSPENSION OF LAND DISTURBANCE ACTIVITIES. REFER TO THE NEVADA STORMWATER GENERAL PERMIT FOR CONSTRUCTION ACTIVITY NVR100000, SECTION III.A.12.
- ACCUMULATED SEDIMENT IN BMPs SHALL BE REMOVED WITHIN SEVEN DAYS AFTER A STORMWATER RUNOFF EVENT OR PRIOR TO THE NEXT ANTICIPATED STORM EVENT, WHICHEVER IS EARLIER. SEDIMENT MUST BE REMOVED WHEN BMP DESIGN CAPACITY HAS BEEN REDUCED BY 50 PERCENT OR MORE.

EXISTING UTILITY NOTE:

CONTRACTOR TO ADJUST ALL EXISTING UTILITIES TO MATCH PROPOSED FINISH GRADE ELEVATIONS.

NOTE:


LOCHSA ENGINEERING ASSUMES NO RESPONSIBILITY FOR EXISTING UTILITY LOCATIONS AND ELEVATIONS. THE UTILITIES SHOWN ON THIS PLAN ARE FROM THE BEST AVAILABLE INFORMATION. IT IS THE CONTRACTOR'S RESPONSIBILITY TO FIELD VERIFY THE LOCATION AND ELEVATION OF ALL UTILITIES, INCLUDING BUT NOT LIMITED TO, THE WATER, FIRE, SANITARY SEWER, STORM SEWER, TELEPHONE, POWER, GAS, AND IRRIGATION LINES PRIOR TO THE COMMENCEMENT OF CONSTRUCTION. IF CONFLICTS EXIST IN THE FIELD, THE CONTRACTOR IS TO NOTIFY THE PROJECT ARCHITECT, OWNER'S REPRESENTATIVE AND THE PROJECT ENGINEER IMMEDIATELY.

Call before you Dig



1-800-227-2800

Call before you Dig

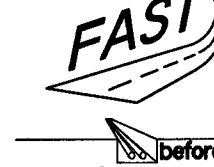

1-702-432-5300

Call before you Dig



1-702-227-2929

6445 South Jones Blvd
Las Vegas, NV 89118
Phone (702) 885-9312
www.lochsa.com

Lochsa
engineering


DEER SPRINGS AND HUALAPAI
CITY OF LAS VEGAS,
NEVADA

GRADING PLANS
SHEET 1 OF 2

TITLE
PROJECT No.: 161109
DATE: APRIL 3, 2018
SCALE: 1"=30'
DRAWN BY: MGZ
DESIGNED BY: MGZ
CHECKED BY: JLI

SEAL
Professional Engineer
No. 1296
04/03/2018

SHEET No. 6 of 15
CLV No. 69418
RTE No. 17-19758

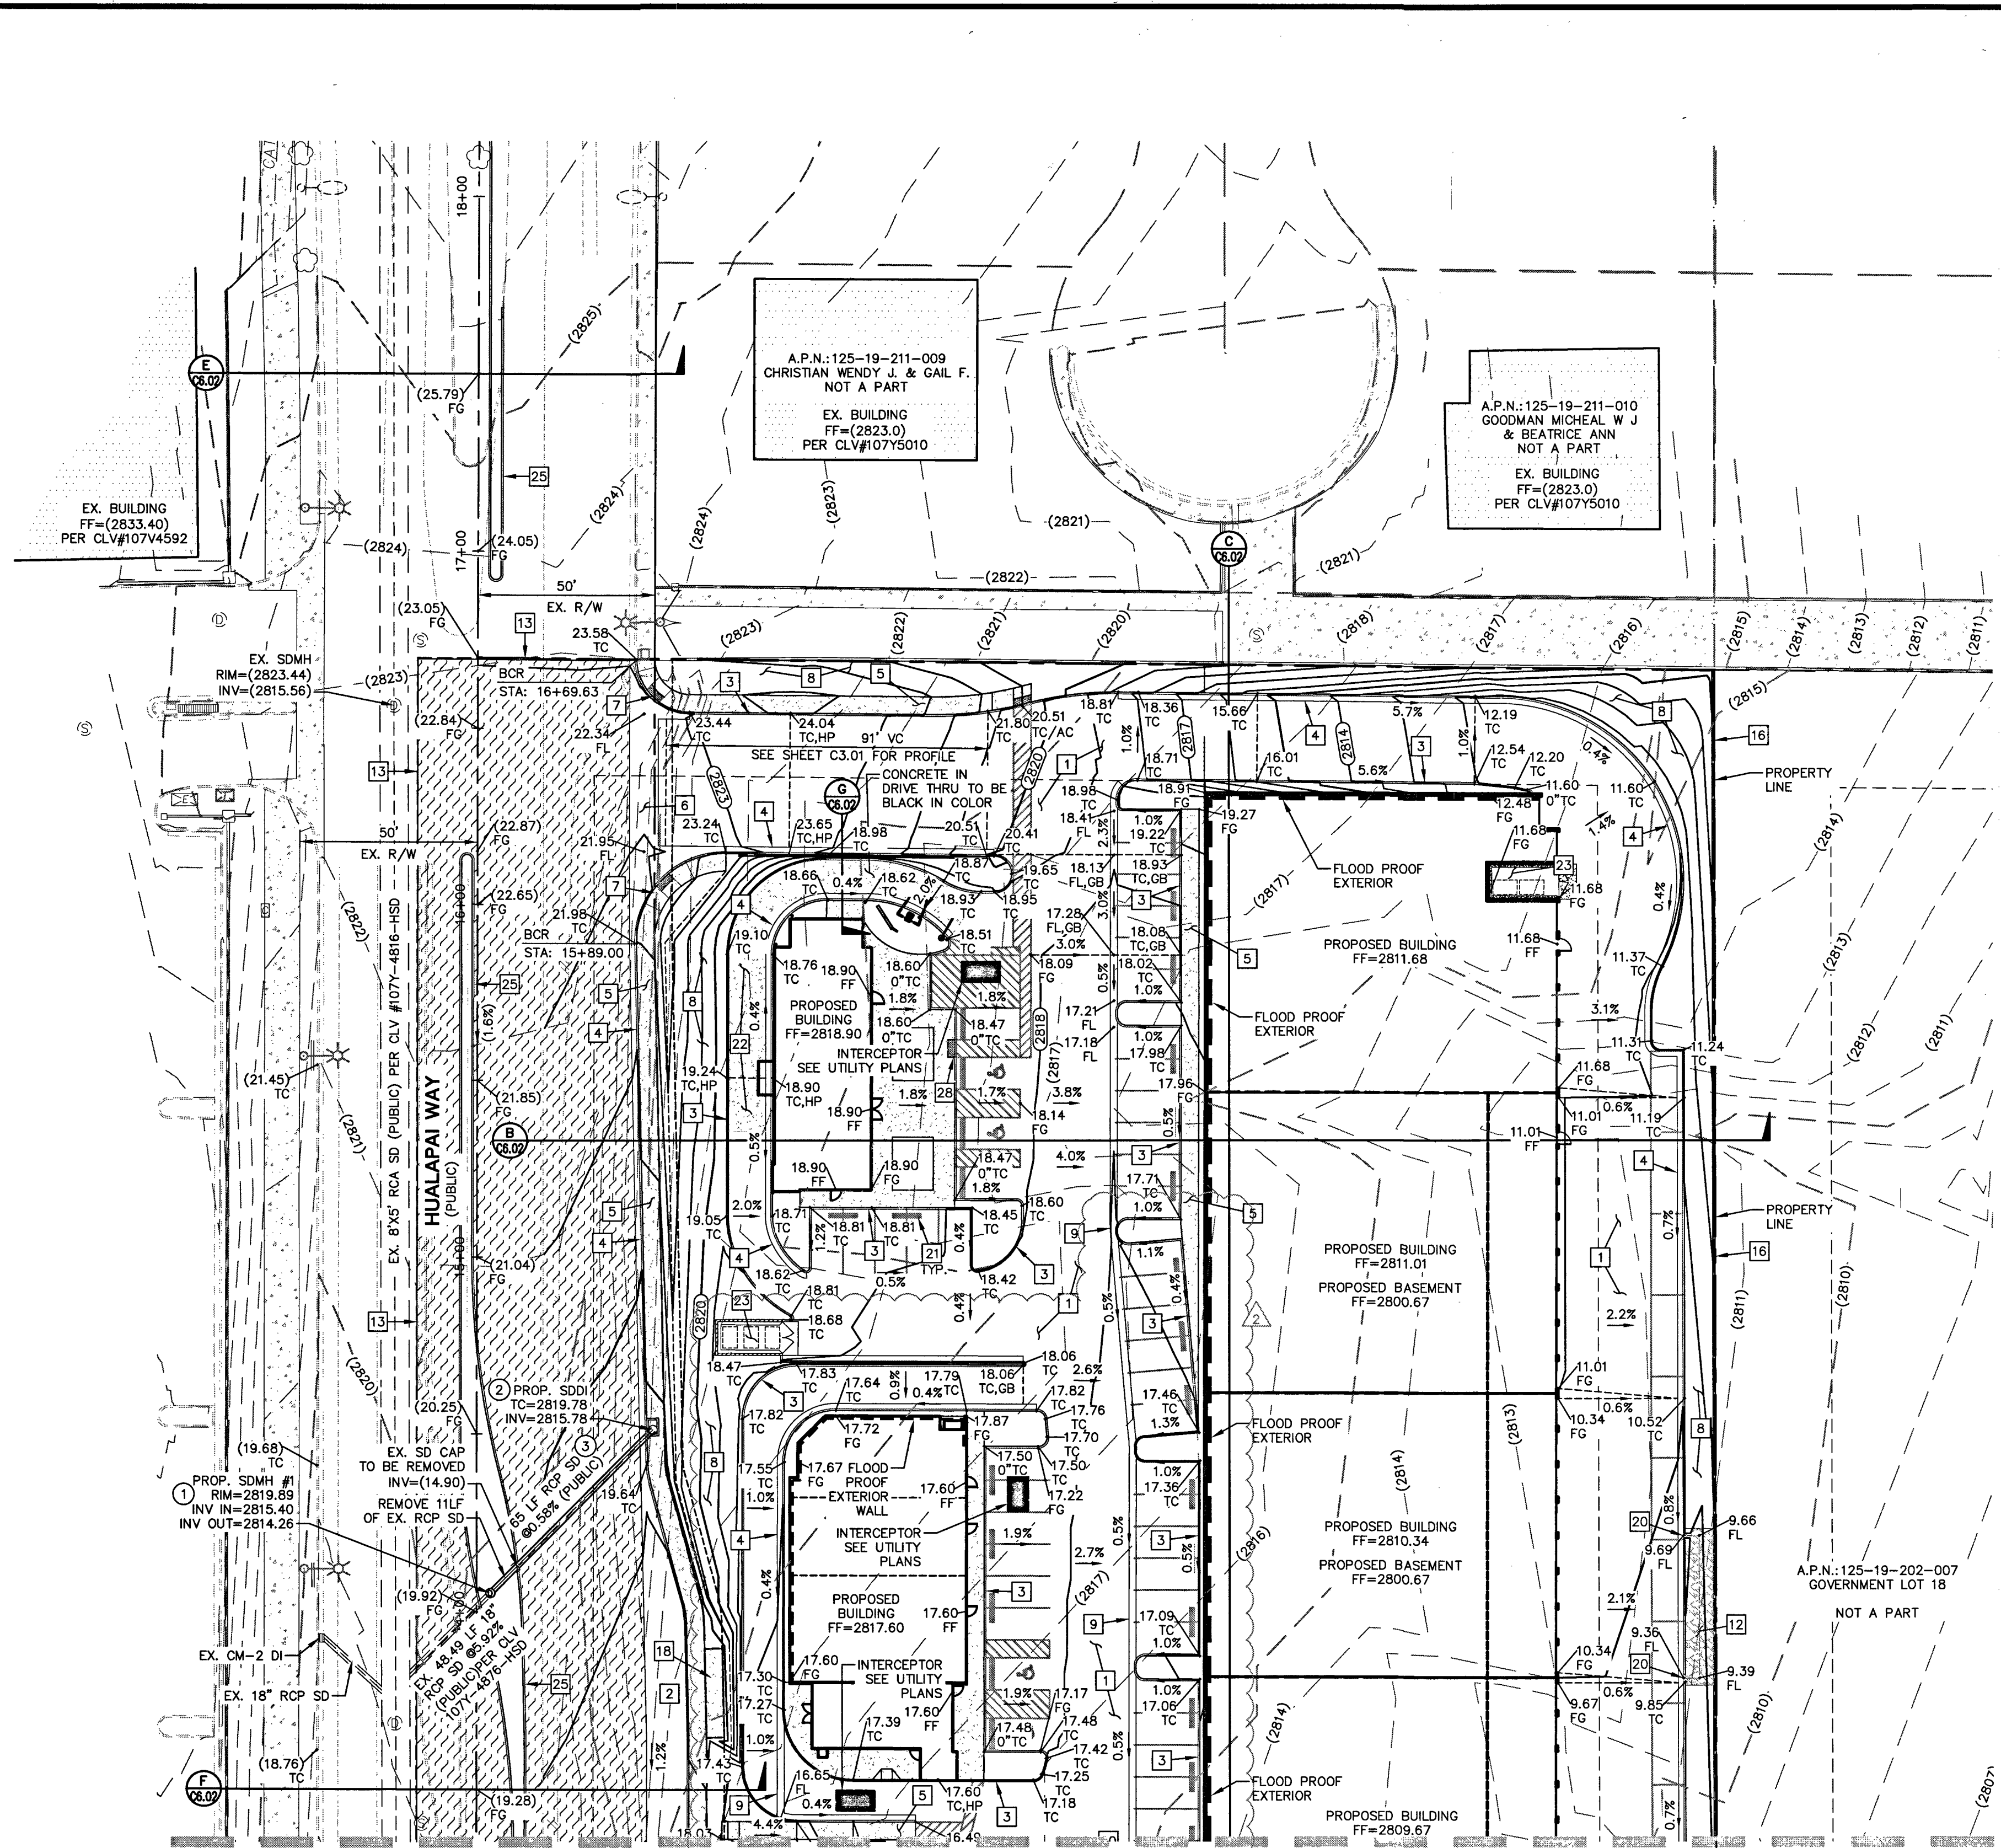

FOR CONTINUATION SEE SHEET C3.01

A.P.N.: 125-19-202-006

BASIS OF BEARINGS:

SOUTH 89°47'00" EAST, BEING THE BEARING OF THE SOUTH LINE OF THE SOUTHWEST QUARTER (SW 1/4) OF THE SOUTHWEST QUARTER (SW 1/4) OF SECTION 19, TOWNSHIP 19 SOUTH, RANGE 60 EAST, M.D.M., ALSO BEING THE CENTERLINE OF CENTENNIAL PARKWAY AS MEASURED BETWEEN HUALAPAI WAY AND CONQUISTADOR STREET AS SHOWN ON FILE 107, PAGE 31 OF SURVEYS IN THE RECORDER'S OFFICE, CLARK COUNTY, NEVADA.

BENCHMARK:


IRON & PLATE IN TOP OF CURB AT THE SOUTHEAST CORNER OF THE BRIDGE OVER CLARK COUNTY HIGHWAY 215 ON HUALAPAI. ELEVATION = 853.317 (METERS) / 2799.59 (U.S. SURVEY FEET) NORTH AMERICAN VERTICAL DATUM OF 1985

FLOOD ZONE NOTE:


THE PROJECT SITE IS COVERED BY THE FLOOD INSURANCE RATE MAP (FIRM) FOR THE CLARK COUNTY, NEVADA, AND INCORPORATED AREAS. COMMUNITY PANEL NUMBER: 32003C1750E, EFFECTIVE DATE: SEPTEMBER 27, 2002. THE PROJECT SITE FALLS WITHIN ZONE "X" (UNSHADED), DESCRIBED BY FEMA AS: "AREAS DETERMINED TO BE OUTSIDE THE 0.2% ANNUAL CHANCE FLOODPLAIN."

CUT	FILL	NET
19,474.45 CY	3,290.62 CY	16,183.83 CY

NOTE: CUT/FILL QUANTITIES ARE TO FINISHED GRADE & DO NOT INCLUDE MATERIAL THICKNESS'S, FOOTINGS, ETC.

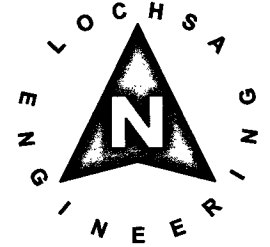

GRAPHIC SCALE

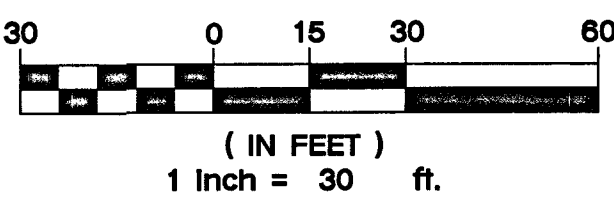

STORM DRAIN

CONSTRUCTION NOTES:

- NOT ALL NOTES USED ON THIS SHEET -
- INSTALL 48" TYPE 1 STORM DRAIN MANHOLE PER C.C.A.U.S.D. No. 403
- CONSTRUCT 2.5' TYPE "CM2" DROP INLET PER C.C.A.U.S.D. Nos. 412.1 AND 421
- RCP STORM DRAIN TO BE INSTALLED WITH JOINT GASKETS PER UDACS SECTION 2, PARAGRAPH 2.22.02-D

CONSTRUCTION NOTES:

- ALL CONSTRUCTION TO BE DONE IN ACCORDANCE WITH "CLARK COUNTY AREA UNIFORM STANDARD DRAWINGS (C.C.A.U.S.D.)" LATEST EDITION AND/OR REGULATING ENTITY HAVING JURISDICTION
- NOT ALL NOTES USED ON THIS SHEET -
- CONSTRUCT AC PAVEMENT PER DETAIL 3 ON C6.01.
- CONSTRUCT TYPICAL BUS STOP PER CCAUSD #234.1
- CONSTRUCT "A" TYPE CURB PER DETAIL 4 SHEET C6.01
- CONSTRUCT "L" TYPE CURB PER CCAUSD No. 216.
- CONSTRUCT CONC. SIDEWALK PER CCAUSD No. 234.
- CONSTRUCT VALLEY GUTTER PER CCAUSD No. 228
- CONSTRUCT SIDEWALK RAMP PER CCAUSD No. 235 CASE I.
- LANDSCAPING - REFER TO LANDSCAPE PLANS FOR SPECIFICATIONS.
- CONSTRUCT 2" VALLEY GUTTER PER DETAIL 8 ON C6.01
- CONSTRUCT SIDEWALK DRAIN PER C.C.A.U.S.D. No. 236
- CONSTRUCT MODIFIED CURB RAMP PER DETAIL 1 ON SHEET C6.01
- INSTALL RIP RAP SWALES PER DETAIL 5 ON C6.01 WITH CURB CUTS PER DETAIL 6 ON C6.01
- SAW CUT AND MATCH EXISTING PAVEMENT
- CONSTRUCT SIDEWALK RAMP PER DETAIL 13 ON C6.02
- CONSTRUCT CONC. "U" CHANNEL PER DETAIL 2 ON C6.01
- PROPOSED WALL BY OTHERS
- CONSTRUCT BUS STOP PASSENGER SHELTER PAD PER CCAUSD #234.2
- RETAINING WALL BY OTHERS
- CONSTRUCT 2' WIDE CURB OPENING
- CONSTRUCT PARKING BUMPER PER DETAIL 14 ON C6.02
- CONSTRUCT CONC. PAVEMENT PER DETAIL 7 ON C6.01
- PROPOSED TRASH ENCLOSURE PER ARCH. PLANS
- CONSTRUCT SIDEWALK RAMP PER DETAIL 15 ON C6.02
- CONSTRUCT "A" TYPE ISLAND CURB PER CCAUSD #219
- RETAINING WALL WITH HANDRAIL BY OTHERS.
- CONSTRUCT MODIFIED CURB RAMP PER DETAIL 16 ON SHEET C6.02
- INSTALL DETECTABLE WARNING (TRUNCATED DOMES) PER CCAUSD No. 235, SHEET 4.
- INSTALL ENHANCED PAVEMENT PER ARCHITECTURAL DRAWINGS.
- CONSTRUCT 1' WIDE CURB OPENING

GENERAL GRADING NOTES:


- PRIOR TO INSTALLATION OF STORM OR SANITARY SEWER, WATER MAIN OR ANY OTHER UTILITIES, THE CONTRACTOR SHALL EXCAVATE, VERIFY, AND CALCULATE ALL POINTS OF CONNECTION AND ALL UTILITIES CROSSINGS AND INFORM THE OWNER AND THE ENGINEER OF ANY CONFLICTS OR REQUIRED DEVIATIONS FROM THE PLAN PRIOR TO CONSTRUCTION. NOTIFICATION SHALL BE MADE A MINIMUM OF 72 HOURS PRIOR TO CONSTRUCTION. THE ENGINEER AND ITS CLIENTS SHALL BE HELD HARMLESS IN THE EVENT THAT THE CONTRACTOR FAILS TO MAKE SUCH NOTIFICATION.
- ALL SLOPES AND AREAS DISTURBED BY CONSTRUCTION SHALL BE GRADED SMOOTH AND FOUR INCHES OF TOPSOIL APPLIED. IF ADEQUATE TOPSOIL IS NOT AVAILABLE ON SITE, THE CONTRACTOR SHALL PROVIDE TOPSOIL, APPROVED BY THE OWNER, AS NEEDED. THE AREA SHALL THEN BE SEED/ED, SOILED, FERTILIZED, MULCHED, WATERED AND MAINTAINED UNTIL HARDY GRASS GROWTH IS ESTABLISHED IN ALL AREAS. ANY RELOCATED TREES SHALL BE MAINTAINED UNTIL SUCH POINT AS TREE IS RE-ESTABLISHED. ANY AREAS DISTURBED FOR ANY REASON PRIOR TO FINAL ACCEPTANCE OF THE PROJECT SHALL BE CORRECTED BY THE CONTRACTOR AT NO ADDITIONAL COST TO THE OWNER.
- THE CONTRACTOR IS SPECIFICALLY CAUTIONED THAT THE LOCATION AND/OR ELEVATION OF EXISTING UTILITIES AS SHOWN ON THESE PLANS IS BASED ON RECORDS OF THE VARIOUS UTILITY COMPANIES, AND WHERE POSSIBLE, MEASUREMENTS TAKEN IN THE FIELD. THE INFORMATION IS NOT TO BE RELIED ON AS BEING EXACT OR COMPLETE. THE CONTRACTOR MUST CALL THE APPROPRIATE UTILITY COMPANY AT LEAST 72 HOURS BEFORE ANY EXCAVATION TO REQUEST EXACT FIELD LOCATION OF UTILITIES.
- REFER TO GEOTECHNICAL REPORT FOR SPECIFIC SITE SOIL CONDITIONS AND CONSIDERATIONS.
- CONTRACTOR SHALL COMPLY COMPLETELY WITH THE LATEST STANDARDS OF OSHA DIRECTIVES OR ANY OTHER AGENCY HAVING JURISDICTION FOR EXCAVATION AND TRENCHING PROCEDURES. THE CONTRACTOR SHALL USE SUPPORT SYSTEMS, SLOPING, BENCHING AND OTHER MEANS OF PROTECTION. THIS IS TO INCLUDE, BUT NOT LIMITED TO, ACCESS AND EGRESS FROM EXCAVATION AND TRENCHING. CONTRACTOR IS RESPONSIBLE FOR COMPLYING WITH PERFORMANCE CRITERIA AS REQUIRED BY OSHA.

GRADING PLAN CERTIFICATION

NAME: 11200 4610 PE # 11200 4610 DA 04/03/2018

CERTIFY THAT THIS GRADING PLAN IS IN CONFORMANCE WITH APPROVED DRAINAGE STUDY FOR THIS SITE ON FILE AT THE CITY OF LAS VEGAS FOR THIS PROJECT. DS#4857

PROJECT SITE

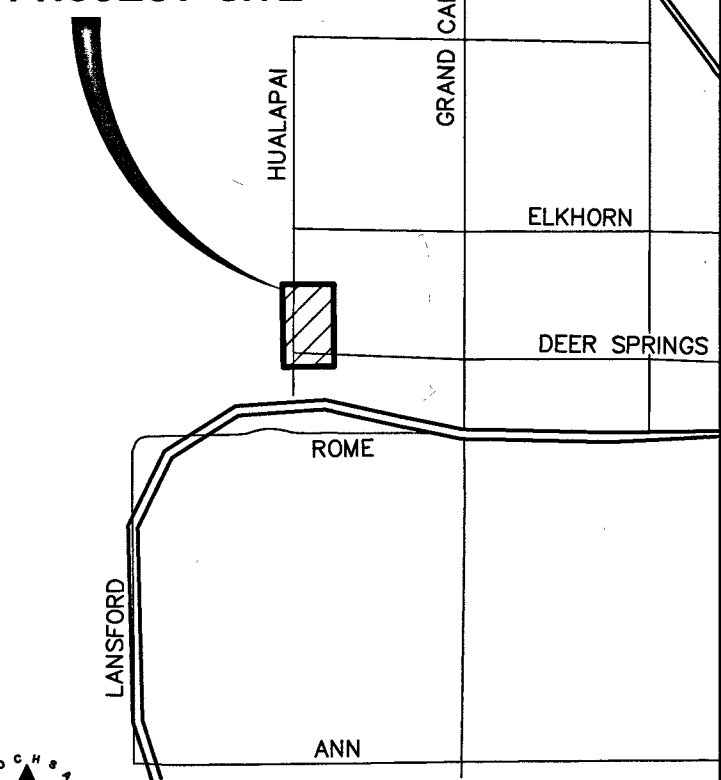

VICINITY MAP

NOT TO SCALE

GRADING NOTES:

- SLOPES 4:1 OR STEEPER AND FINE-GRAINED MATERIALS THAT HAVE BEEN DISTURBED (SANDY AND SILTY MATERIALS) SHOULD BE PROTECTED WITH BURLAP OR OTHER EROSION CONTROL FABRIC/MATERIAL, UNLESS OTHERWISE SPECIFIED BY LANDSCAPE DRAWINGS AND SPECIFICATIONS OR THE SOIL REPORT.
- CONTRACTOR SHALL DETERMINE HIS OWN FOOTING OR BASEMENT EXCAVATION QUANTITIES, EVEN THOUGH SHOWN ON ROUGH GRADING PLANS. ADDITIONALLY, STRUCTURE BACKFILL COSTS SHOULD BE INCLUDED IN THE COST OF THE STRUCTURE, UNLESS OTHERWISE SPECIFIED IN THE CONTRACT DOCUMENTS.
- CONTRACTOR SHALL NOTIFY LOCHSA ENGINEERING WITHIN 24 HOURS OF OMISSIONS AND ERRORS DISCOVERED ON PLANS. LOCHSA ENGINEERING WILL NOT BE RESPONSIBLE FOR ANY "CORRECTIVE" WORK DONE BY OTHERS.
- CONTRACTOR TO ENSURE POSITIVE DRAINAGE. NO PONDING ALLOWED. CONTRACTOR TO FOLLOW RECOMMENDATIONS AS OUTLINED IN THE PROJECT GEOTECHNICAL REPORT, INCLUDING BUT NOT LIMITED TO EXCAVATION, GRADING AND COMPACTION. REFER TO THE REPORT PREPARED BY: GEOTEK, INC., PROJECT No. 13092-LV, DATED: AUGUST 31, 2016.

LAS VEGAS VALLEY

CONSTRUCTION SITE BEST

MANAGEMENT PRACTICES

GUIDANCE MANUAL SECTION

3.5.1 STANDARD NOTES 1-5

- THE OWNER, SITE DEVELOPER, CONTRACTOR, AND/OR THEIR AUTHORIZED AGENTS SHALL EACH DAY REMOVE ALL SEDIMENT, MUD, CONSTRUCTION DEBRIS, OR OTHER POTENTIAL POLLUTANTS THAT MAY HAVE BEEN DISCHARGED TO, OR ACCUMULATED IN, THE PUBLIC RIGHT-OF-WAY OF THE (INSERT JURISDICTION) AS A RESULT OF CONSTRUCTION ACTIVITIES ASSOCIATED WITH THIS SITE DEVELOPMENT OR CONSTRUCTION PROJECT. SUCH MATERIAL SHALL BE PREVENTED FROM ENTERING THE STORM SEWER SYSTEM.
- ADDITIONAL CONSTRUCTION SITE DISCHARGE BEST MANAGEMENT PRACTICES MAY BE REQUIRED OF THE OWNER AND HIS OR HER AGENTS DUE TO UNFORESEEN EROSION PROBLEMS OR IF THE SUBMITTED PLAN DOES NOT MEET THE PERFORMANCE STANDARDS SPECIFIED IN THE (INSERT JURISDICTION) AND THE LAS VEGAS VALLEY CONSTRUCTION SITE BMP GUIDANCE MANUAL.
- TEMPORARY OR PERMANENT STABILIZATION PRACTICES WILL BE INSTALLED ON DISTURBED AREAS AS SOON AS PRACTICABLE AND NO LATER THAN 14 DAYS AFTER THE CONSTRUCTION ACTIVITY IN THAT PORTION OF THE SITE HAS TEMPORARILY OR PERMANENTLY CEASED. SOME EXCEPTIONS MAY APPLY; REFER TO THE NEVADA STORMWATER GENERAL PERMIT FOR CONSTRUCTION ACTIVITY NV10000, SECTION III.A.5.
- AT A MINIMUM, THE CONTRACTOR OR HIS AGENT SHALL INSPECT ALL DISTURBED AREAS, AREAS USED FOR STORAGE OF MATERIALS AND EQUIPMENT THAT ARE EXPOSED TO PRECIPITATION, VEHICLE ENTRANCE AND EXIT LOCATIONS, AND ALL BMPs WEEKLY, AND WITHIN 24 HOURS AFTER ANY RAIN EVENT OR 0.5 INCHES OR MORE. THE CONTRACTOR OR HIS AGENT SHALL UPDATE OR MODIFY THE STORMWATER POLLUTION PREVENTION PLAN AS NECESSARY. SOME EXCEPTIONS TO WEEKLY INSPECTIONS MAY APPLY, SUCH AS SUSPENSION OF LAND DISTURBANCE ACTIVITIES. REFER TO THE NEVADA STORMWATER GENERAL PERMIT FOR CONSTRUCTION ACTIVITY NV10000, SECTION III.A.12.
- ACCUMULATED SEDIMENT IN BMPs SHALL BE REMOVED WITHIN SEVEN DAYS AFTER A STORMWATER RUNOFF EVENT OR PRIOR TO THE NEXT ANTICIPATED STORM EVENT, WHICHEVER IS EARLIER. SEDIMENT MUST BE REMOVED WHEN BMP DESIGN CAPACITY HAS BEEN REDUCED BY 50 PERCENT OR MORE.

EXISTING UTILITY NOTE:

CONTRACTOR TO ADJUST ALL EXISTING UTILITIES TO MATCH PROPOSED FINISH GRADE ELEVATIONS.

NOTE:

LOCHSA ENGINEERING ASSUMES NO RESPONSIBILITY FOR EXISTING UTILITY LOCATIONS AND ELEVATIONS. THE UTILITIES SHOWN ON THIS PLAN ARE FROM THE BEST AVAILABLE INFORMATION. IT IS THE CONTRACTOR'S RESPONSIBILITY TO FIELD VERIFY THE LOCATION AND ELEVATION OF ALL UTILITIES, INCLUDING BUT NOT LIMITED TO, THE WATER, FIRE, SANITARY SEWER, STORM SEWER, TELEPHONE, POWER, GAS, AND IRRIGATION LINES PRIOR TO THE COMMENCEMENT OF CONSTRUCTION. IF CONFLICT EXISTS IN THE FIELD, THE CONTRACTOR IS TO NOTIFY THE PROJECT ARCHITECT, OWNER'S REPRESENTATIVE AND THE PROJECT ENGINEER IMMEDIATELY.

Call before you Dig
Avoid hitting overhead power lines. It's costly.

FAST
Call before you Dig
Underground

1-800-227-2600
1-702-432-6300
1-702-227-2929

Lochsa Engineering

GRADING PLANS
SHEET 2 OF 2

DEER SPRINGS AND HUALAPAI
CITY OF LAS VEGAS,
NEVADA

PROJECT No.: 161109

DATE: APRIL 3, 2018

SCALE: 1"=30'



DRAWN BY: MGZ

DESIGNED BY: MGZ

CHECKED BY: JLI

SEAL
PROFESSIONAL ENGINEER
CLARK COUNTY, NEVADA
No. 11286
04/03/2018

SHEET No. C3.02
L-11111
CLV No. 69418
HTE No. 17-19758

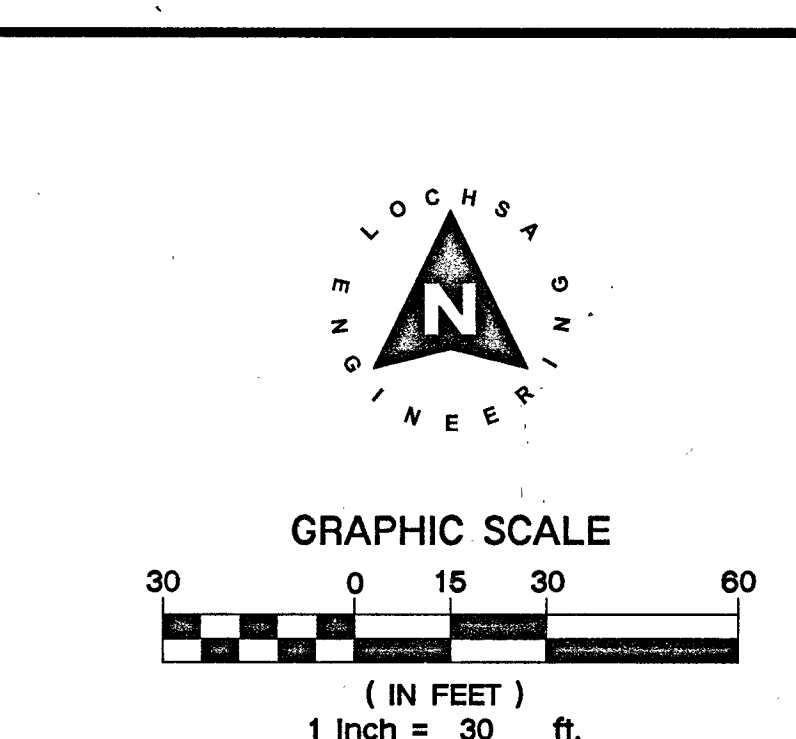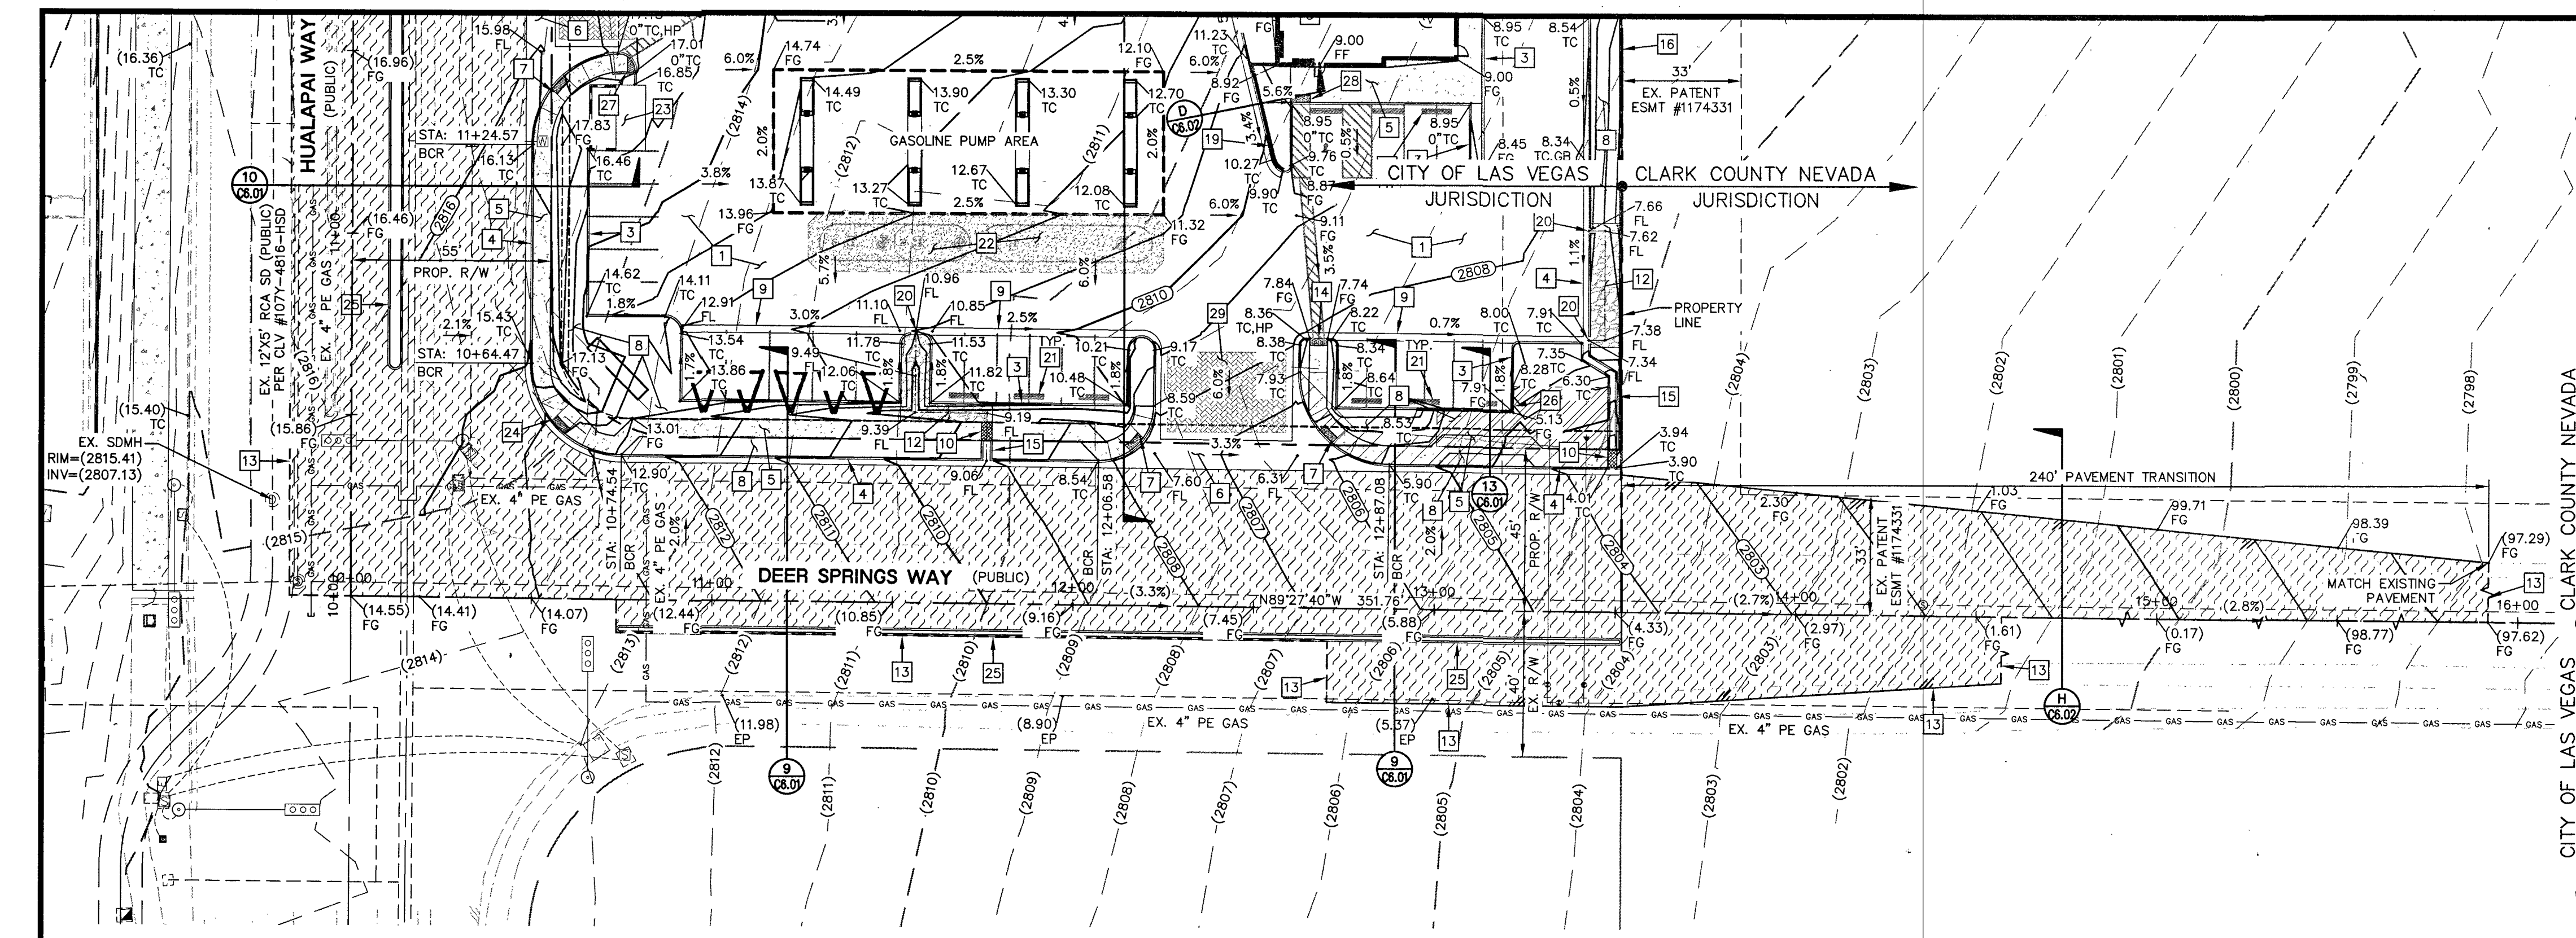

STORM DRAIN CONSTRUCTION NOTES:

- 1. NOT ALL NOTES USED ON THIS SHEET
- 2. INSTALL 48" TYPE 1 STORM DRAIN MANHOLE PER C.C.A.U.S.D. No. 403
- 3. CONSTRUCT 2.5' TYPE "OM2" DROP INLET PER C.C.A.U.S.D. Nos. 412.1 AND 421
- 4. RCP STORM DRAIN TO BE INSTALLED WITH JOINT GASKETS PER UDCS SECTION 2, PARAGRAPH 2.22.02-D

CONSTRUCTION NOTES:

- 1. ALL CONSTRUCTION TO BE DONE IN ACCORDANCE WITH "CLARK COUNTY AREA UNIFORM STANDARD DRAWINGS (C.C.A.U.S.D.)" LATEST EDITION AND/OR REGULATING ENTITY HAVING JURISDICTION
- 2. NOT ALL NOTES USED ON THIS SHEET
- 3. CONSTRUCT AC PAVEMENT PER DETAIL 3 ON C6.01
- 4. CONSTRUCT TYPICAL BUS STOP PER CCAUSD #234.1
- 5. CONSTRUCT "A" TYPE CURB PER DETAIL 4 SHEET C6.01
- 6. CONSTRUCT "L" TYPE CURB PER CCAUSD No. 216
- 7. CONSTRUCT CONC. SIDEWALK PER CCAUSD No. 234
- 8. CONSTRUCT VALLEY GUTTER PER CCAUSD No. 228
- 9. CONSTRUCT SIDEWALK RAMP PER CCAUSD No. 235 CASE 1
- 10. LANDSCAPING - REFER TO LANDSCAPE PLANS FOR SPECIFICATIONS
- 11. CONSTRUCT 2' VALLEY GUTTER PER DETAIL 8 ON C6.01
- 12. CONSTRUCT SIDEWALK DRAIN PER C.C.A.U.S.D. No. 236
- 13. CONSTRUCT MODIFIED CURB RAMP PER DETAIL 1 ON SHEET C6.01
- 14. INSTALL RIP RAP SWALES PER DETAIL 5 ON C6.01 WITH CURB CUTS PER DETAIL 6 ON C6.01
- 15. SAWCUT AND MATCH EXISTING PAVEMENT
- 16. CONSTRUCT SIDEWALK RAMP PER DETAIL 13 ON C6.02
- 17. CONSTRUCT CONC. "U" CHANNEL PER DETAIL 2 ON C6.01
- 18. PROPOSED WALL BY OTHERS
- 19. PROPOSED GATE BY OTHERS
- 20. CONSTRUCT BUS STOP PASSENGER SHELTER PAD PER CCAUSD #234.2
- 21. RETAINING WALL BY OTHERS
- 22. CONSTRUCT 2' WIDE CURB OPENING
- 23. CONSTRUCT PARKING BUMPER PER DETAIL 14 ON C6.02
- 24. CONSTRUCT CONC. PAVEMENT PER DETAIL 7 ON C6.01
- 25. PROPOSED TRASH ENCLOSURE PER ARCH. PLANS
- 26. CONSTRUCT SIDEWALK RAMP PER DETAIL 15 ON C6.02
- 27. CONSTRUCT "A" TYPE ISLAND CURB PER CCAUSD #219
- 28. RETAINING WALL WITH HANDRAIL BY OTHERS
- 29. CONSTRUCT MODIFIED CURB RAMP PER DETAIL 16 ON SHEET C6.01
- 30. INSTALL DEFLECTABLE WARNING (TRUNCATED DOMES) PER CCAUSD No. 235, SHEET 4
- 31. INSTALL ENHANCED PAVEMENT PER ARCHITECTURAL DRAWINGS

GENERAL GRADING NOTES:

A. PRIOR TO INSTALLATION OF STORM OR SANITARY SEWER, WATER MAIN OR ANY OTHER UTILITIES, THE CONTRACTOR SHALL EXCAVATE, VERIFY, AND CALCULATE ALL POINTS OF CONNECTION AND ALL UTILITY CROSSINGS AND INFORM THE OWNER AND THE ENGINEER OF ANY CONFLICTS OR REQUIRED DEVIATIONS FROM THE PLAN PRIOR TO CONSTRUCTION. NOTIFICATION SHALL BE MADE A MINIMUM OF 72 HOURS PRIOR TO CONSTRUCTION, THE ENGINEER AND ITS CLIENTS SHALL BE HELD HARMLESS IN THE EVENT THAT THE CONTRACTOR FAILS TO MAKE SUCH NOTIFICATION.

B. ALL SLOPES AND AREAS DISTURBED BY CONSTRUCTION SHALL BE GRADED SMOOTH AND FOUR INCHES OF TOPSOIL APPLIED. IF ADEQUATE TOPSOIL IS NOT AVAILABLE ON SITE, THE CONTRACTOR SHALL PROVIDE TOPSOIL, APPROVED BY THE OWNER, AS NEEDED. THE AREA SHALL THEN BE SEED/SODDED, FERTILIZED, MULCHED, WATERED AND MAINTAINED UNTIL HARDY GRASS GROWTH IS ESTABLISHED IN ALL AREAS. ANY RELOCATED TREES SHALL BE MAINTAINED UNTIL SUCH POINT AS TREE IS RE-ESTABLISHED. ANY AREAS DISTURBED FOR ANY REASON PRIOR TO FINAL ACCEPTANCE OF THE PROJECT SHALL BE CORRECTED BY THE CONTRACTOR AT NO ADDITIONAL COST TO THE OWNER.

C. THE CONTRACTOR IS SPECIFICALLY CAUTIONED THAT THE LOCATION AND/OR ELEVATION OF EXISTING UTILITIES AS SHOWN ON THESE PLANS IS BASED ON RECORDS OF THE VARIOUS UTILITY COMPANIES, AND WHERE POSSIBLE, MEASUREMENTS TAKEN IN THE FIELD. THE INFORMATION IS NOT TO BE RELIED ON AS BEING EXACT OR COMPLETE. THE CONTRACTOR MUST CALL THE APPROPRIATE UTILITY COMPANY AT LEAST 72 HOURS BEFORE ANY EXCAVATION TO REQUEST EXACT FIELD LOCATION OF UTILITIES.

D. REFER TO GEOTECHNICAL REPORT FOR SPECIFIC SITE SOIL CONDITIONS AND CONSIDERATIONS.

E. CONTRACTOR SHALL COMPLY COMPLETELY WITH THE LATEST STANDARDS OF OSHA DIRECTIVES OR ANY OTHER AGENCY HAVING JURISDICTION FOR EXCAVATION AND TRENCHING PROCEDURES. THE CONTRACTOR SHALL USE SUPPORT SYSTEMS, SLOPING, BENCHING AND OTHER MEANS OF PROTECTION. THIS IS TO INCLUDE, BUT NOT LIMITED TO ACCESS AND EGRESS FROM ALL EXCAVATION AND TRENCHING. CONTRACTOR IS RESPONSIBLE FOR COMPLYING WITH PERFORMANCE CRITERIA AS REQUIRED BY OSHA.

FLOOD ZONE NOTE:

THE PROJECT SITE IS COVERED BY THE FLOOD INSURANCE RATE MAP (FIRM) FOR THE CLARK COUNTY, NEVADA, AND INCORPORATED AREAS, COMMUNITY PANEL NUMBER, 32003C1750E, EFFECTIVE DATE: SEPTEMBER 27, 2002. THE PROJECT SITE FALLS WITHIN ZONE "X" (UNSHADED), DESCRIBED BY FEMA AS: "AREAS DETERMINED TO BE OUTSIDE THE 0.2% ANNUAL CHANCE FLOODPLAIN."

GRADING PLAN CERTIFICATION


NAME: PE # DATE: 11/26/2017

CERTIFY THAT THIS GRADING PLAN IS IN CONFORMANCE WITH APPROVED DRAINAGE STUDY FOR THIS SITE ON FILE AT THE CITY OF LAS VEGAS FOR THIS PROJECT.

DS#4857

CUT	FILL	NET
19,474.45 CY	3,290.62 CY	16,183.83 CY

NOTE: CUT/FILL QUANTITIES ARE TO FINISHED GRADE & DO NOT INCLUDE MATERIAL THICKNESS, FOOTINGS, ETC.

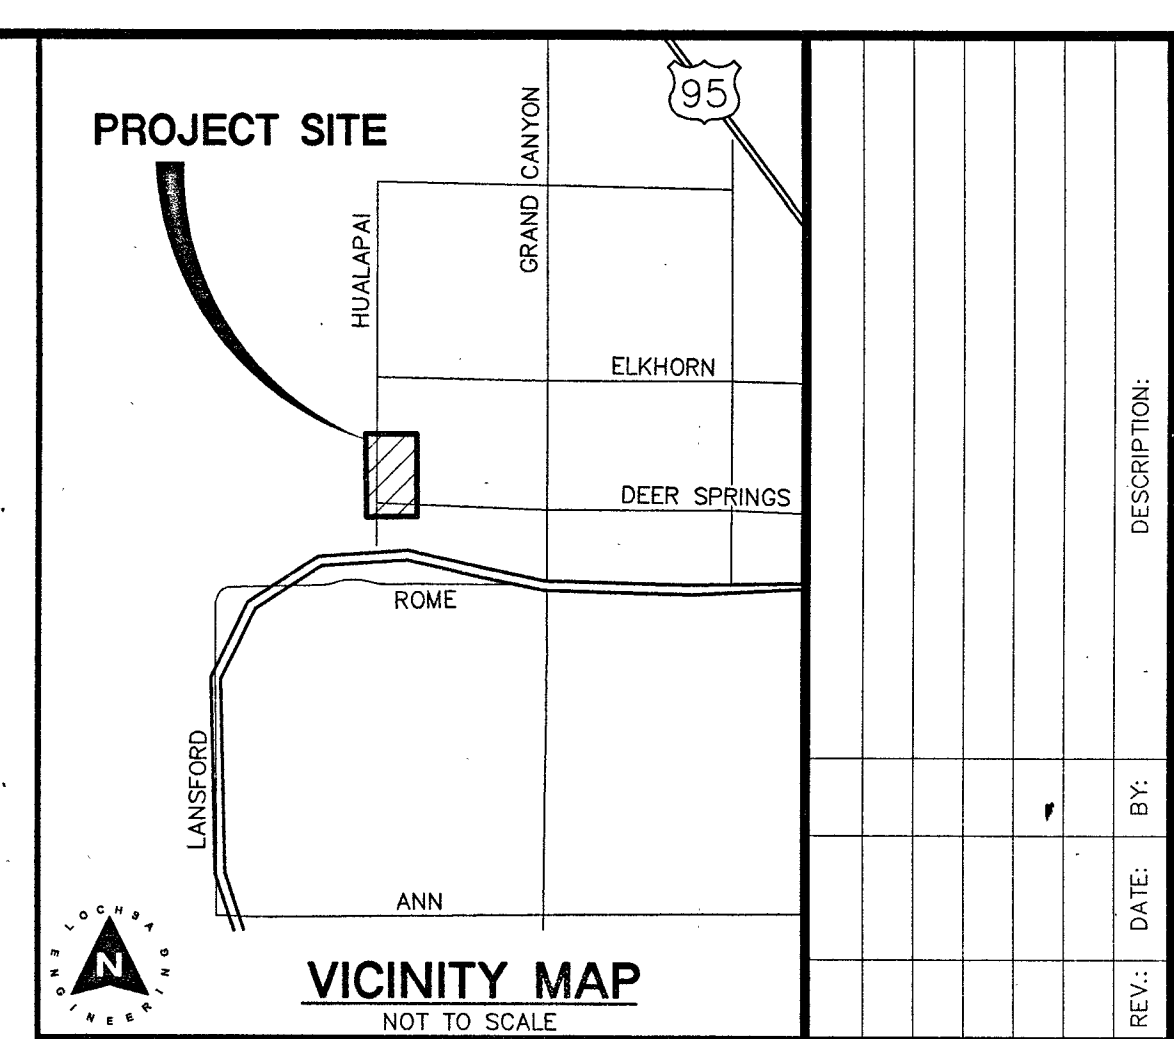

GRADING NOTES:

- 1. SLOPES 4:1 OR STEEPER AND FINE-GRAINED MATERIALS THAT HAVE BEEN DISTURBED (SANDY AND SILTY MATERIALS) SHOULD BE PROTECTED WITH BURLAP OR OTHER EROSION CONTROL FABRIC/MATERIAL, UNLESS OTHERWISE SPECIFIED BY LANDSCAPE DRAWINGS AND SPECIFICATIONS OR THE SOILS REPORT.
- 2. CONTRACTOR SHALL DETERMINE HIS OWN FOOTING OR BASEMENT EXCAVATION QUANTITIES, EVEN THOUGH SHOWN ON ROUGH GRADING PLANS. ADDITIONALLY, STRUCTURE BACKFILL COSTS SHOULD BE INCLUDED IN THE COST OF THE STRUCTURE, UNLESS OTHERWISE SPECIFIED IN THE CONTRACT DOCUMENTS.
- 3. CONTRACTOR SHALL NOTIFY LOCHSA ENGINEERING WITHIN 24 HOURS OF OMISSIONS AND ERRORS DISCOVERED ON PLANS. LOCHSA ENGINEERING WILL NOT BE RESPONSIBLE FOR ANY "CORRECTIVE" WORK DONE BY OTHERS.
- 4. CONTRACTOR TO ENSURE POSITIVE DRAINAGE. NO PONDING ALLOWED. CONTRACTOR TO FOLLOW RECOMMENDATIONS AS OUTLINED IN THE PROJECT GEOTECHNICAL REPORT, INCLUDING BUT NOT LIMITED TO EXCAVATION, GRADING AND COMPACTION. REFER TO THE REPORT PREPARED BY: GEOTEK, INC., PROJECT No. 13092-LV, DATED: AUGUST 31, 2016.

LAS VEGAS VALLEY CONSTRUCTION SITE BEST MANAGEMENT PRACTICES GUIDANCE MANUAL SECTION 3.5.1 STANDARD NOTES 1-5

1. THE OWNER, SITE DEVELOPER, CONTRACTOR, AND/OR THEIR AUTHORIZED AGENTS SHALL EACH DAY REMOVE ALL SEDIMENT, MUD, CONSTRUCTION DEBRIS, OR OTHER POTENTIAL POLLUTANTS THAT MAY HAVE BEEN DISCHARGED TO, OR ACCUMULATED IN, THE PUBLIC RIGHT-OF-WAY OF THE (INSERT JURISDICTION) AS A RESULT OF CONSTRUCTION ACTIVITIES ASSOCIATED WITH THIS SITE DEVELOPMENT OR CONSTRUCTION PROJECT. SUCH MATERIAL SHALL BE PREVENTED FROM ENTERING THE STORM SEWER SYSTEM.
2. ADDITIONAL CONSTRUCTION SITE DISCHARGE BEST MANAGEMENT PRACTICES MAY BE REQUIRED OF THE OWNER AND HIS OR HER AGENTS DUE TO UNFORESEEN EROSION PROBLEMS OR IF THE SUBMITTED PLAN DOES NOT MEET THE PERFORMANCE STANDARDS SPECIFIED IN THE (INSERT JURISDICTION) AND THE LAS VEGAS VALLEY CONSTRUCTION SITE BMP GUIDANCE MANUAL.
3. TEMPORARY OR PERMANENT STABILIZATION PRACTICES WILL BE INSTALLED ON DISTURBED AREAS AS SOON AS PRACTICABLE AND NO LATER THAN 14 DAYS AFTER THE CONSTRUCTION ACTIVITY IN THAT PORTION OF THE SITE HAS TEMPORARILY OR PERMANENTLY CEASED. SOME EXCEPTIONS MAY APPLY. REFER TO THE NEVADA STORMWATER GENERAL PERMIT FOR CONSTRUCTION ACTIVITY NVR100000, SECTION III.A.5.
4. AT A MINIMUM, THE CONTRACTOR OR HIS AGENT SHALL INSPECT ALL DISTURBED AREAS, AREAS USED FOR STORAGE OF MATERIALS AND EQUIPMENT THAT ARE EXPOSED TO PRECIPITATION, VEHICLE ENTRANCE AND EXIT LOCATIONS, AND ALL BMPs WEEKLY, AND WITHIN 24 HOURS AFTER ANY RAIN EVENT OR 0.5 INCHES OR MORE. THE CONTRACTOR OR HIS AGENT SHALL UPDATE OR MODIFY THE STORMWATER POLLUTION PREVENTION PLAN AS NECESSARY. SOME EXCEPTIONS TO WEEKLY INSPECTIONS MAY APPLY, SUCH AS SUSPENSION OF LAND DISTURBANCE ACTIVITIES. REFER TO THE NEVADA STORMWATER GENERAL PERMIT FOR CONSTRUCTION ACTIVITY NVR100000, SECTION III.A.12.
5. ACCUMULATED SEDIMENT IN BMPs SHALL BE REMOVED WITHIN SEVEN DAYS AFTER A STORMWATER RUNOFF EVENT OR PRIOR TO THE NEXT ANTICIPATED STORM EVENT, WHICHEVER IS EARLIER. SEDIMENT MUST BE REMOVED WHEN BMP DESIGN CAPACITY HAS BEEN REDUCED BY 50 PERCENT OR MORE.

EXISTING UTILITY NOTE:

CONTRACTOR TO ADJUST ALL EXISTING UTILITIES TO MATCH PROPOSED FINISH GRADE ELEVATIONS.

NOTE:

LOCHSA ENGINEERING ASSUMES NO RESPONSIBILITY FOR EXISTING UTILITY LOCATIONS AND ELEVATIONS. THE UTILITIES SHOWN ON THIS PLAN ARE FROM THE BEST AVAILABLE INFORMATION. IT IS THE CONTRACTOR'S RESPONSIBILITY TO VERIFY THE LOCATION AND ELEVATION OF ALL UTILITIES, INCLUDING BUT NOT LIMITED TO, THE WATER, FIRE, SANITARY, SEWER, STORM SEWER, TELEPHONE, POWER, GAS, AND IRRIGATION LINES PRIOR TO THE COMMENCEMENT OF CONSTRUCTION. IF CONFLICT EXISTS IN THE FIELD, THE CONTRACTOR IS TO NOTIFY THE PROJECT ARCHITECT, OWNER'S REPRESENTATIVE AND THE PROJECT ENGINEER IMMEDIATELY.

CLARK COUNTY DEPARTMENT OF PUBLIC WORKS DEVELOPMENT REVIEW

125-19-202-006

BASIS OF BEARINGS:

SOUTH 89°47'00" EAST, BEING THE BEARING OF THE SOUTH LINE OF THE SOUTHWEST QUARTER (SW 1/4) OF THE SOUTHWEST QUARTER (SW 1/4) OF SECTION 19, TOWNSHIP 19 SOUTH, RANGE 60 EAST, M.D.M., ALSO BEING THE CENTERLINE OF CENTENNIAL PARKWAY AS MEASURED BETWEEN HUALAPAI WAY AND CONQUISTADOR STREET AS SHOWN ON FILE 107, PAGE 31 OF SURVEYS IN THE RECORDER'S OFFICE, CLARK COUNTY, NEVADA.

BENCHMARK:

RIEDEL & PLATE IN TOP OF CURB AT THE SOUTHEAST CORNER OF THE BRIDGE OVER CLARK COUNTY HIGHWAY 215 ON HUALAPAI. ELEVATION = 653.317 (METERS) / 2799.59 (U.S. SURVEY FEET) NORTH AMERICAN VERTICAL DATUM OF 1988

CLARK COUNTY DEPARTMENT OF PUBLIC WORKS DEVELOPMENT REVIEW

125-19-202-006

BASIS OF BEARINGS:

SOUTH 89°47'00" EAST, BEING THE BEARING OF THE SOUTH LINE OF THE SOUTHWEST QUARTER (SW 1/4) OF THE SOUTHWEST QUARTER (SW 1/4) OF SECTION 19, TOWNSHIP 19 SOUTH, RANGE 60 EAST, M.D.M., ALSO BEING THE CENTERLINE OF CENTENNIAL PARKWAY AS MEASURED BETWEEN HUALAPAI WAY AND CONQUISTADOR STREET AS SHOWN ON FILE 107, PAGE 31 OF SURVEYS IN THE RECORDER'S OFFICE, CLARK COUNTY, NEVADA.

BENCHMARK:

RIEDEL & PLATE IN TOP OF CURB AT THE SOUTHEAST CORNER OF THE BRIDGE OVER CLARK COUNTY HIGHWAY 215 ON HUALAPAI. ELEVATION = 653.317 (METERS) / 2799.59 (U.S. SURVEY FEET) NORTH AMERICAN VERTICAL DATUM OF 1988

CL OR SURVEY LINE	EASEMENT LINE	DESCRIPTION:	CONTOUR LINES	EDGE OF PAVEMENT	"A" TYPE CURBS	"L" TYPE CURBS	WALLS	FENCES	AC PAVEMENT	CONCRETE	SPOT ELEVATIONS	SIGNS	MANHOLE W/ DESCRIPTION	MANHOLE DESCRIPTIONS	FIRE HYDRANTS	GATE VALVES	REDUCERS	CLEAN OUTS	UTILITY BOX OR VAULT	BACKWATER VALVES	100W HPS STREETLIGHTS	150W HPS STREETLIGHTS	200W HPS STREETLIGHTS	250W HPS STREETLIGHTS
---	---	EXISTING: --- (2210) ---	---	---	---	---	---	---	---	---	---	---	---	---	---	---	---	---	---	---	---	---	---	---
---	---	PROPOSED: --- (2122) ---	---	---	---	---	---	---	---	---	---	---	---	---	---	---	---	---	---	---	---	---	---	---

9/14/2017 2:08 PM
C:\Users\jwheeler\OneDrive\Documents\125-19-202-006.dwg
Drawing: 125-19-202-006.dwg

Lochsa Engineering

6345 South Jones Blvd.
Suite 100
Las Vegas, NV 89131
Phone: (702) 365-9312
Fax: (702) 365-9317
www.lochsa.com

PLAN AND PROFILES

DEER SPRINGS WAY

DEER SPRINGS AND HUALAPAI

CITY OF LAS VEGAS, NEVADA

PROJECT No.: 161109

DATE: 4/25/2017

SCALE: 1"=30'



DRAWN BY: MGZ

DESIGNED BY: MGZ

CHECKED BY: JLI

SHEET No.: 4 of 15

CLV No.: 69418 17-19756

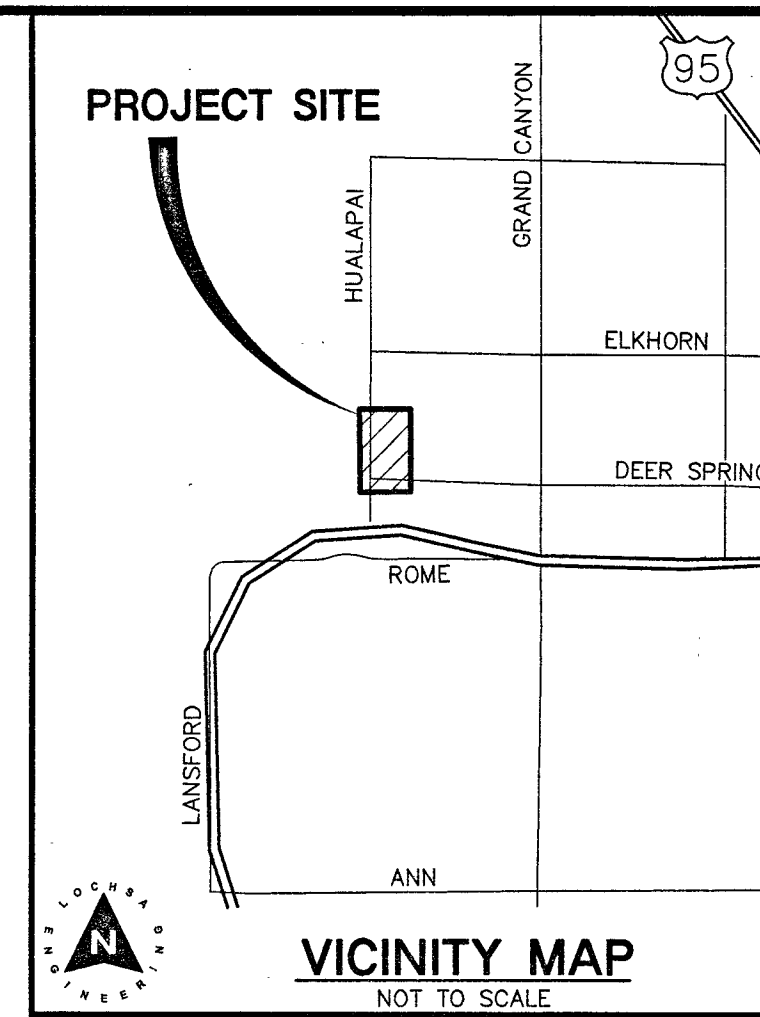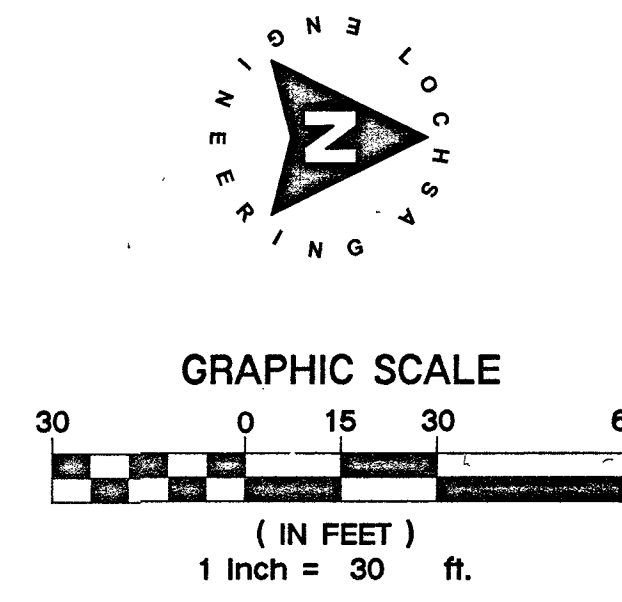

- NOT ALL NOTES USED ON THIS SHEET -

- ① INSTALL 48" TYPE I STORM DRAIN MANHOLE PER C.C.A.U.S.D. No. 403
- ② CONSTRUCT 2.5' TYPE "CM2" DROP INLET PER C.C.A.U.S.D. Nos. 412.1 AND 421
- ③ RCP STORM DRAIN TO BE INSTALLED WITH JOINT GASKETS PER UDACS SECTION 2, PARAGRAPH 2.22.02-D

- ALL CONSTRUCTION TO BE DONE IN ACCORDANCE WITH "CLARK COUNTY AREA UNIFORM STANDARD DRAWINGS (C.C.A.U.S.D.)" LATEST EDITION AND/OR REGULATING ENTITY HAVING JURISDICTION.
- NOT ALL NOTES USED ON THIS SHEET -

- 3 CONSTRUCT "A" TYPE CURB PER DETAIL 4 SHEET C8.01
- 4 CONSTRUCT "L" TYPE CURB PER CCAUSD No. 216.
- 5 CONSTRUCT CONC. SIDEWALK PER CCAUSD No. 234.
- 6 CONSTRUCT VALLEY GUTTER PER CCAUSD No. 228
- 7 CONSTRUCT SIDEWALK RAMP CCAUSD No. 235 CASE I.
- 8 LANDSCAPING -- REFER TO LANDSCAPE PLANS FOR SPECIFICATIONS.
- 9 CONSTRUCT 2' VALLEY GUTTER PER DETAIL 8 ON C6.01
- 10 CONSTRUCT SIDEWALK CURB PER C.C.A.U.S.D. No. 236
- 11 CONSTRUCT MODIFIED DRAIN RAMP PER DETAIL 1 ON

1. SLOPES 4:1 OR STEEPER AND FINE-GRAINED MATERIALS THAT HAVE BEEN DISTURBED (SANDY AND SILTY MATERIALS) SHALL BE PROTECTED BY EROSION OR OTHER EROSION CONTROL FABRIC/MATERIAL, UNLESS OTHERWISE SPECIFIED BY LANDSCAPE DRAWINGS AND SPECIFICATIONS OR THE SOILS REPORT.
2. CONTRACTOR SHALL DETERMINE HIS OWN FOOTING OR BASEMENT EXCAVATION QUANTITIES, EVEN THOUGH SHOWN ON ROUGH EXCAVATION PLANS. ADDITIONALLY, STRUCTURE BASEMENT COSTS SHALL BE INCLUDED IN THE COST OF THE STRUCTURE, UNLESS OTHERWISE SPECIFIED IN THE CONTRACT DOCUMENTS.

3. CONTRACTOR SHALL NOTIFY LOCHSA ENGINEERING WITHIN 24 HOURS OF OMISSIONS AND ERRORS DISCOVERED ON PLANS. LOCHSA ENGINEERING WILL NOT BE RESPONSIBLE FOR ANY "CORRECTIVE" WORK DONE BY OTHERS.
4. CONTRACTOR TO ENSURE POSITIVE DRAINAGE, NO PONDING ALLOWED. CONTRACTOR TO FOLLOW RECOMMENDATIONS AS OUTLINED IN THE PROJECT GEOTECHNICAL REPORT, INCLUDING BUT NOT LIMITED TO EXCAVATION, GRADING AND COMPACTION. REFER TO THE REPORT PREPARED BY: GRIFFIN, INC., PROJECT NO. 13092-LV, DATED: AUGUST 31, 2016.

1. THE OWNER, SITE DEVELOPER, CONTRACTOR, AND/OR THEIR AUTHORIZED REPRESENTATIVES SHALL BE RESPONSIBLE FOR THE REMOVAL OF ALL EXISTING AND REMAINING SEDIMENT, MUD, CONSTRUCTION DEBRIS, OR OTHER POTENTIAL POLLUTANTS THAT MAY HAVE BEEN DISCHARGED TO OR ACCUMULATED IN ANY PUBLIC RIGHT-OF-WAY OR WATERWAY (INSERT JURISDICTION) AS A RESULT OF CONSTRUCTION ACTIVITIES ASSOCIATED WITH THIS SITE DEVELOPMENT OR CONSTRUCTION. THE OWNER SHALL BE RESPONSIBLE FOR PREVENTING THE MATERIAL FROM BEING PREVENTED FROM ENTERING THE STORM SEWER SYSTEM.
2. ADDITIONAL CONSTRUCTION SITE DISCHARGE BEST MANAGEMENT PRACTICES MAY BE REQUIRED OF THE OWNER AND/OR HIS OR HER AGENTS IF DISCREPANCIES BETWEEN EROSION PROBLEMS OR IF THE SITUATED PLAN DOES NOT MEET THE PERFORMANCE STANDARDS SPECIFIED IN THE (INSERT JURISDICTION) (INSERT JURISDICTION) VEGAS VALLEY CONSTRUCTION SITE BMP GUIDANCE MANUAL.

3. TEMPORARY OR PERMANENT STABILIZATION PRACTICES WILL BE INSTALLED ON DISTURBED AREAS AS SOON AS PRACTICABLE AND NO LATER THAN 14 DAYS AFTER THE CONSTRUCTION ACTIVITY IN THAT PORTION OF THE SITE HAS COMPLETED. TEMPORARILY PERMANENT STABILIZATION EXCEPTIONS MAY APPLY; REFER TO THE NEVADA STORMWATER GENERAL PERMIT FOR CONSTRUCTION ACTIVITY NVRI00000, SECTION III.A.5.
4. AT A MINIMUM, THE CONTRACTOR OR HIS AGENT SHALL INSTALL AND MAINTAIN DISTURBED AREAS USED FOR STORAGE OF MATERIALS AND EQUIPMENT. AREAS ARE EXPOSED TO PRECIPITATION, VEHICLE ENTRANCE AND EXIT LOCATIONS, AND ALL BMP'S WEEKLY, AND WITHIN 24 HOURS AFTER A RAIN EVENT. INSPECTIONS MAY APPLY. THE CONTRACTOR OR HIS AGENT SHALL UPDATE OR MODIFY THE STORMWATER POLLUTION PREVENTION PLAN AS NECESSARY. CONSTRUCTION ACTIVATIONS TO EXCEED INSPECTIONS MAY APPLY, SUCH AS SUSPENSION OF LAND DISTURBANCE ACTIVITIES. REFER TO THE NEVADA STORMWATER GENERAL PERMIT FOR CONSTRUCTION ACTIVITY NVRI00000, SECTION III.A.12.
5. ACCUMULATED SEDIMENT IN BMP'S SHALL BE REMOVED WITHIN SEVEN DAYS AFTER THE STORMWATER RUNOFF EVENT OR IMMEDIATELY TO THE NEXT TREATMENT FACILITY, WHICHEVER IS EARLIER. SEDIMENT MUST BE REMOVED WHEN BMP DESIGN CAPACITY HAS BEEN REDUCED BY 50% OR MORE.

LOCHSA ENGINEERING ASSUMES NO RESPONSIBILITY FOR EXISTING UTILITY LOCATIONS AND ELEVATIONS. THE UTILITIES SHOWN ON THIS PLAN ARE FROM THE BEST AVAILABLE INFORMATION. IT IS THE CONTRACTOR'S RESPONSIBILITY TO FIELD VERIFY THE LOCATION AND ELEVATION OF ALL UTILITIES, INCLUDING BUT NOT LIMITED TO, THE WATER, SANITARY SEWER, STORM SEWER, TELEPHONE, POWER, GAS, AND IRRIGATION LINES PRIOR TO THE COMMENCEMENT OF CONSTRUCTION. IF CONFLICT EXISTS IN THE FIELD, THE CONTRACTOR IS TO NOTIFY THE PROJECT ARCHITECT, OWNER'S REPRESENTATIVE AND THE PROJECT ENGINEER IMMEDIATELY.

Call before you Dig
 Avoid cutting underground
 utility lines. It's costly.

**CALL
 811**

OR

1-800-227-2800

FAST



 
**Call
 before you
 Underground**

1-702-432-5300


FREWAY & AERIAL SYSTEM
 OF THE PAPER INDUSTRIES


Avoid hitting overhead
 power lines. It's costly.

**CALL BEFORE
 YOU DO
 OVERHEAD**



1-702-227-2929

 PROJECT No.: 161109 DATE: 4/25/2017 SCALE: 1" = 30' DRAWN BY: MGZ DESIGNED BY: MGZ CHECKED BY: JLI		PLAN AND PROFILES HUALAPAI WAY (SHEET 1 OF 2)	
TITLE: DEER SPRINGS AND HUALAPAI CITY OF LAS VEGAS, NEVADA 6345 South Jones Blvd Suite 100, NV 89119 Phone (702) 365-9312 Fax (702) 365-9317 www.lochsa.com			
SEAL 		SHEET No. 1075067 C4.02 SHEET 9 OF 15 CLV No. 69418	

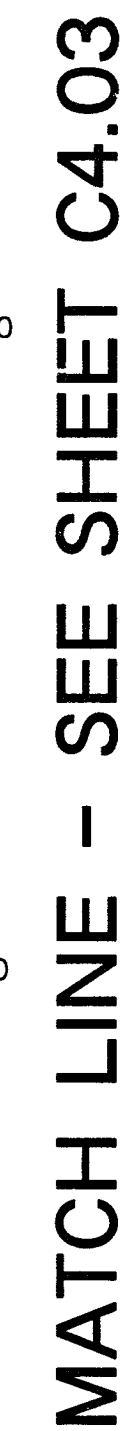

SOUTH 89°47'00" EAST, BEING THE BEARING OF THE SOUTH LINE OF THE SOUTHWEST QUARTER (SW 1/4) OF THE SOUTHWEST QUARTER (SW 1/4) OF SECTION 19, TOWNSHIP 19 SOUTH, RANGE 60 EAST, M.D.M., ALSO BEING THE CENTERLINE OF CENTENNIAL PARKWAY AS MEASURED BETWEEN HAULPAI WAY AND CONQUISTADOR STREET AS SHOWN ON FILE 107, PAGE 31 OF SURVEYS IN THE RECORDER'S OFFICE, CLARK COUNTY, NEVADA.

OF THE BRIDGE OVER CLARK COUNTY HIGHWAY 215 ON
HUALAPAI. ELEVATION - 853.317 (METERS) / 2799.59 (U.S.
SURVEY FEET) NORTH AMERICAN VERTICAL DATUM OF 1988

THE PROJECT SITE IS COVERED BY THE FLOOD INSURANCE RATE MAP (FIRM) FOR THE CLARK COUNTY, NEVADA, AND INCORPORATED AREAS, COMMUNITY PANEL NUMBER: 32003C1750E, EFFECTIVE DATE: SEPTEMBER 27, 2002. THE PROJECT SITE FALLS WITHIN ZONE "X"(UNSHADED), DESCRIBED BY FEMA AS: 'AREAS DETERMINED TO BE OUTSIDE THE 0.2% ANNUAL CHANCE FLOODPLAIN.

NOTE: CUT/FILL QUANTITIES ARE TO FINISHED GRADE &
DO NOT INCLUDE MATERIAL THICKNESS'S, FOOTINGS, ETC.




NAME: Ty PE # 11286 DATE 5/24/11

CERTIFY THAT THIS GRADING PLAN IS IN CONFORMANCE
WITH APPROVED DRAINAGE STUDY FOR THIS SITE ON FILE
AT THE CITY OF LAS VEGAS FOR THIS PROJECT.

US#4837

S	GATE VALVES	REDUCERS	CLEAN OUTS	UTILITY BOX OR VAULT	BACKWATER VALVES	100w HPS STREETLIGHTS	150w HPS STREETLIGHTS	200w HPS STREETLIGHTS	250w HPS STREETLIGHTS


CL OR SURVEY LINE	EASEMENT LINE	DESCRIPTION:	CONTOUR LINES	EDGE OF PAVEMENT	"A" TYPE CURBS	"L" TYPE CURBS	WALLS	FENCES	AC PAVEMENT	CONCRETE	SPOT ELEVATIONS
PROPERTY LINE	SAWTOOTH LINE	EXISTING:	---(2210)---		=====	=====	=====	—○—○—○—		=====	(12.34)
ROW LINE	SCARP LINE	PROPOSED:	---(2122)---		=====	=====	=====	—○—○—○—		=====	12.34

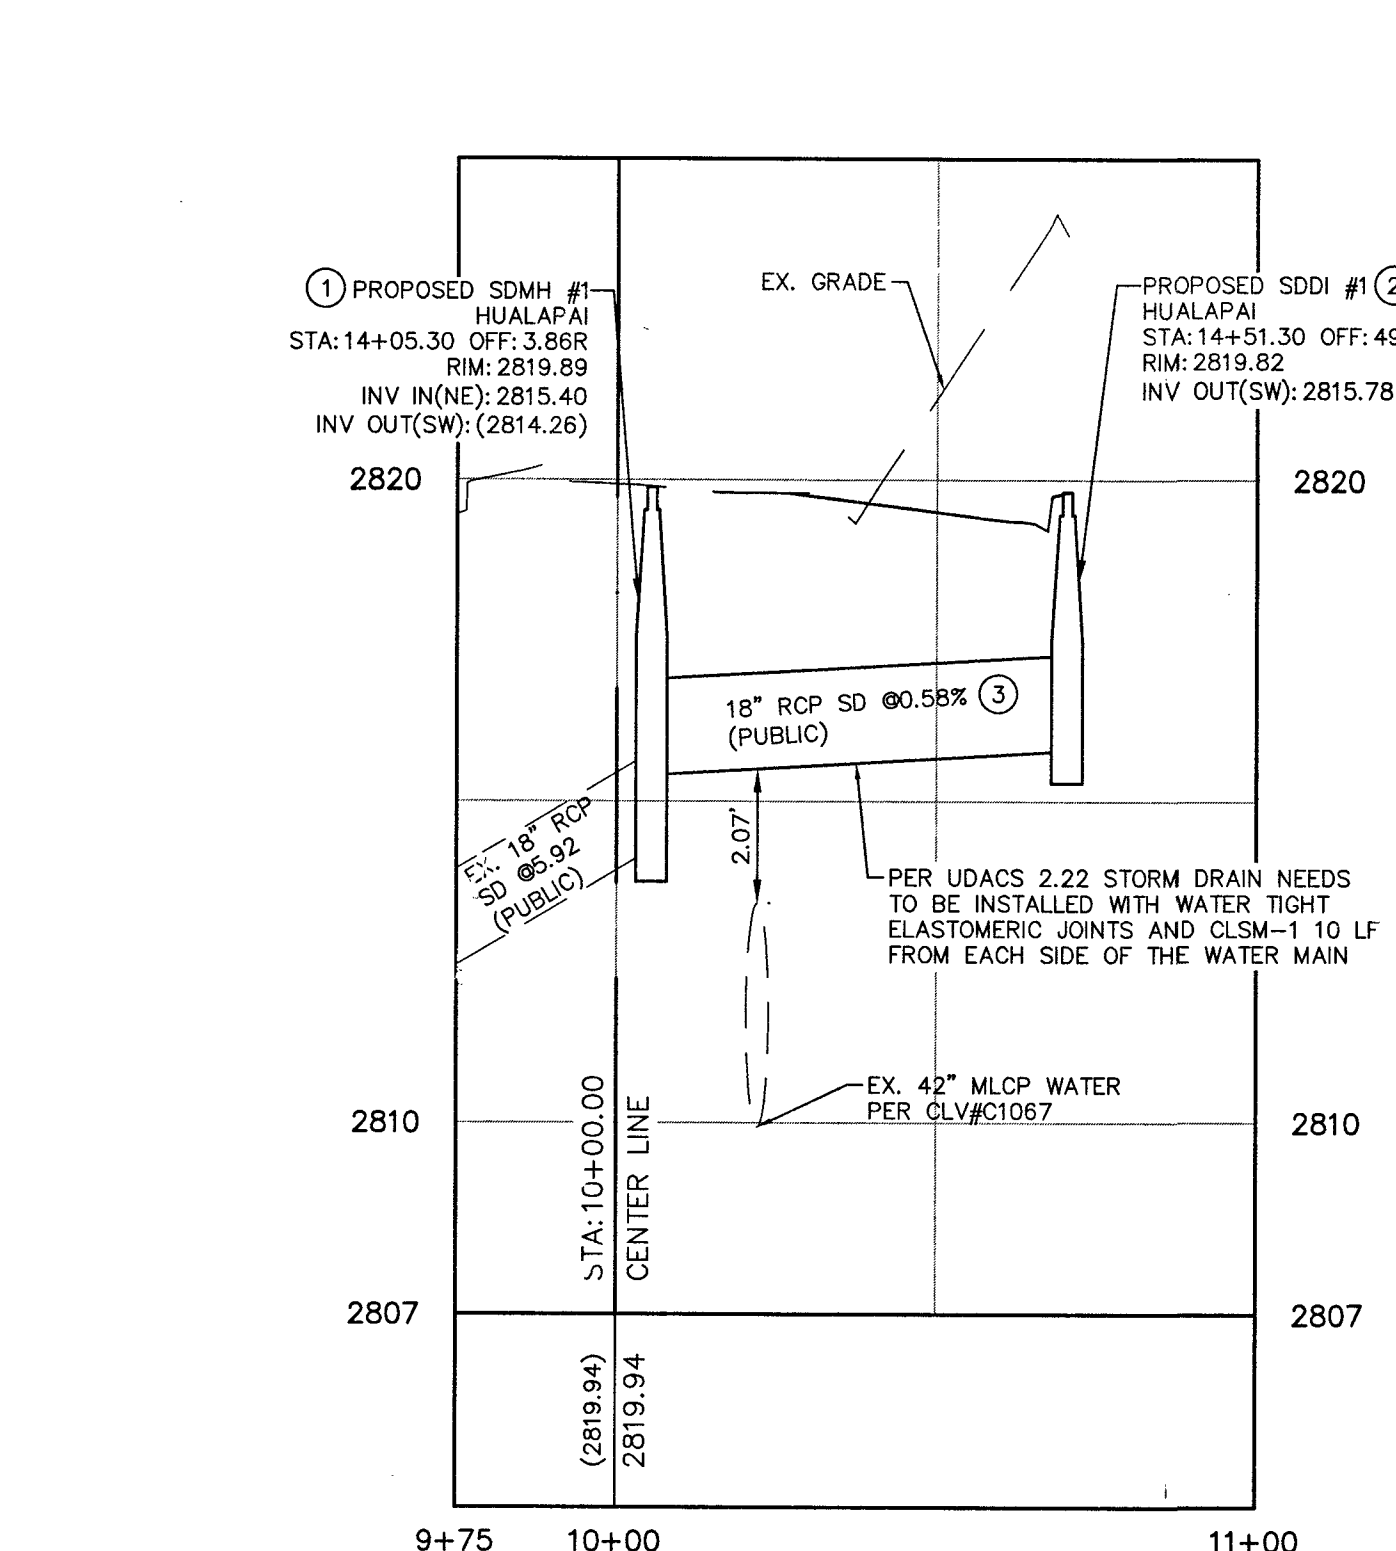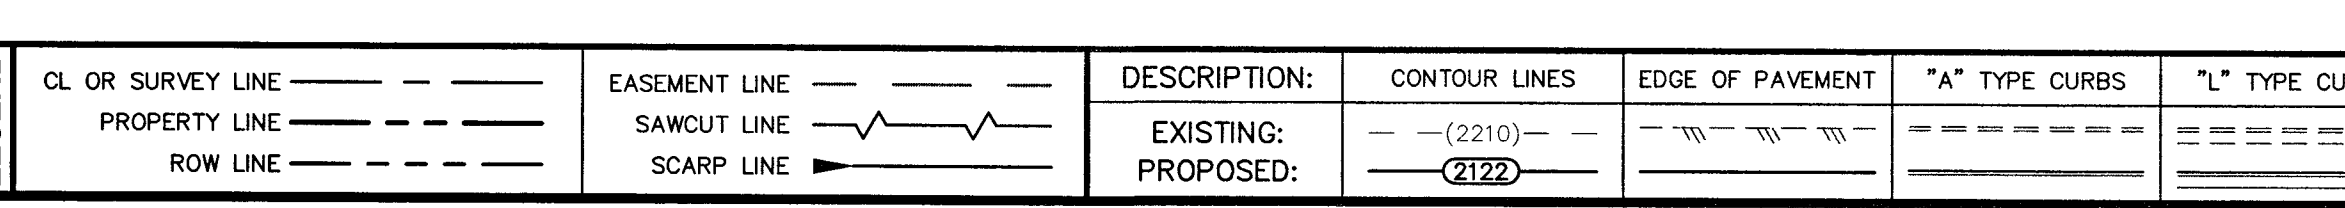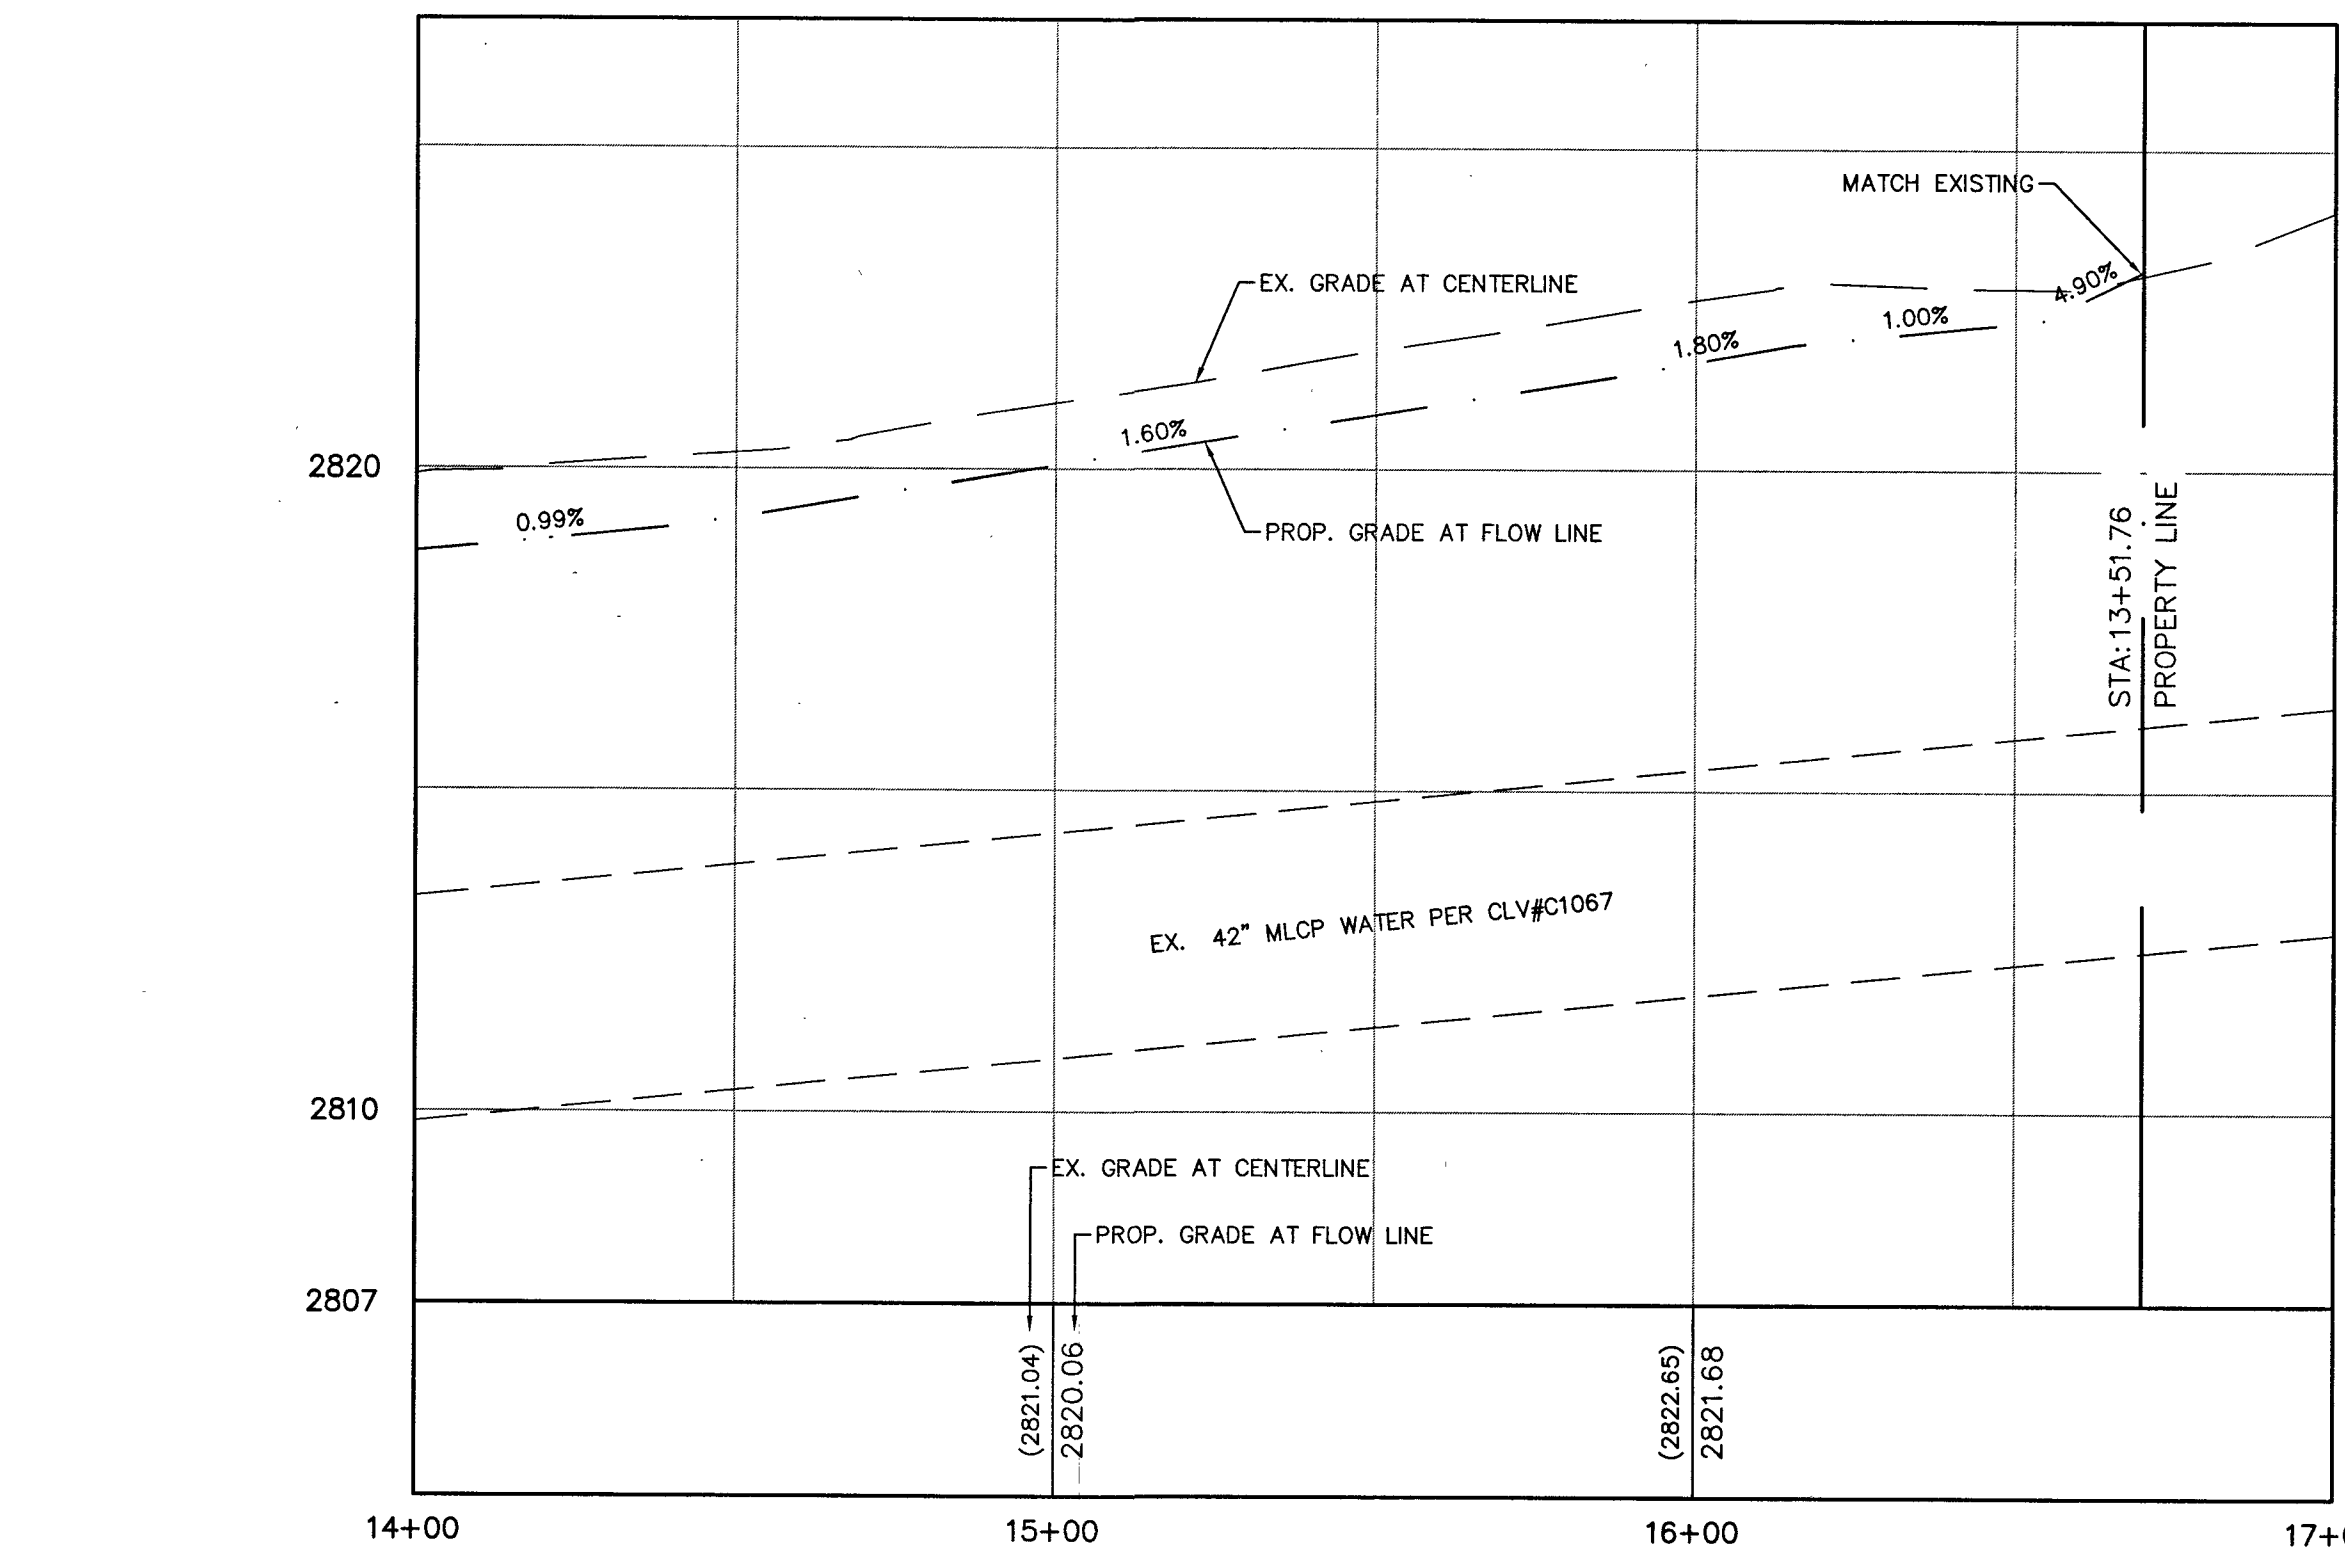

ANCES	AC PAVEMENT	CONCRETE	SPI ELEVATION
 	 	 	 

SIGNS	MANHOLE W/ DESCRIPTION	MANHOLE DESCRIPTIONS	H'
	Ⓢ	Ⓢ = SANITARY SEWER	
	Ⓓ	Ⓓ = STORM DRAIN	
	Ⓔ	Ⓔ = ELECTRICAL	
	Ⓣ	Ⓣ = TELEPHONE	

DS#4857					
ITS	GATE VALVES	REDUCERS	CLEAN OUTS	UTILITY BOX OR VAULT	B
	⊗	▷	○	□	
	⊙	▶	●	▢	

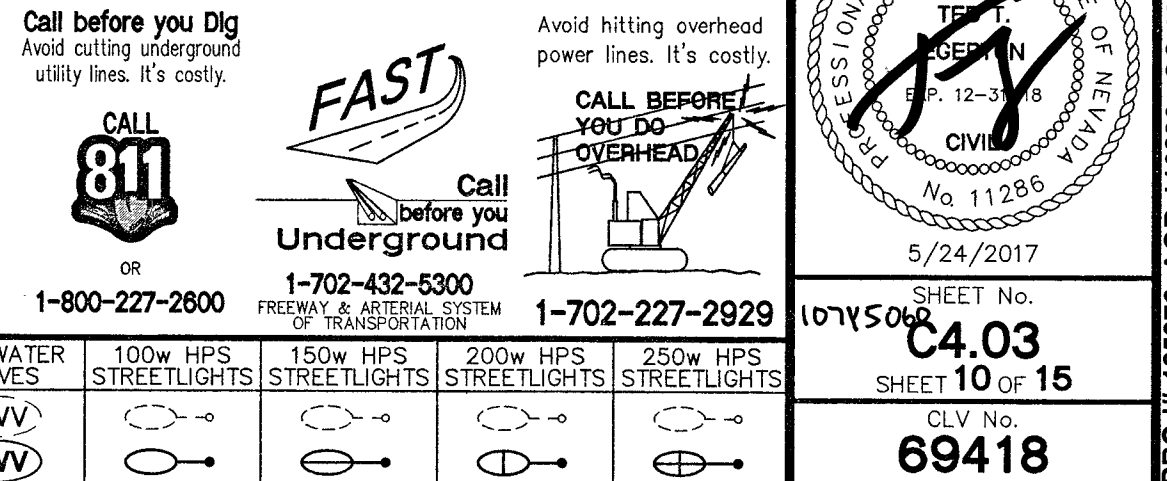


LINE TABLE		
LINE #	LENGTH	DIRECTION
L1	69.12'	N89°25'32"W
L2	107.91'	N89°25'32"W
L3	8.42'	N00°08'02"E
L4	6.63'	N89°56'46"E
L5	136.41'	S00°03'14"E
L6	38.00'	S00°03'14"E
L7	112.52'	S00°03'14"E
L8	28.00'	S00°03'14"E
L9	46.07'	S00°03'14"E
L10	7.50'	S89°56'46"W
L11	9.39'	N31°51'09"W
L12	63.25'	S00°03'14"E
L13	28.00'	S00°03'14"E
L14	3.07'	S00°03'14"E
L15	11.86'	N89°25'32"W
L16	1.25'	N89°27'40"W
L17	3.57'	S89°51'58"E
L18	4.48'	S89°27'40"E
L19	17.25'	S89°27'14"E
L20	15.92'	S00°08'02"W

LINE TABLE		
LINE #	LENGTH	DIRECTION
L21	22.55'	N89°27'40"W
L22	17.50'	S00°32'20"W
L23	7.50'	S00°32'20"W
L24	60.51'	N89°27'40"W
L25	1.00'	S89°27'40"E
L26	1.00'	S89°27'40"E
L27	41.53'	N00°08'02"E
L28	17.50'	N00°08'02"E
L29	50.00'	S89°51'58"E
L30	17.28'	N00°08'02"E
L31	77.71'	S13°34'50"E
L32	82.69'	N00°08'02"E
L33	15.86'	S89°51'58"E
L35	7.00'	S89°51'58"E
L37	8.62'	N00°08'02"E
L39	29.57'	N00°08'02"E
L40	18.75'	N89°51'58"W
L41	55.00'	N00°08'02"E
L42	15.50'	N89°51'58"W
L43	23.16'	S00°08'02"W

LINE TABLE		
LINE #	LENGTH	DIRECTION
L44	15.50'	N89°51'56"W
L45	55.00'	N00°08'02"E
L46	15.50'	N89°51'58"W
L47	15.32'	S89°51'58"E
L52	14.91'	N89°51'58"W
L53	55.00'	N00°08'02"E
L54	15.50'	N89°51'58"W
L55	1.50'	N00°08'02"E
L56	15.50'	N89°51'58"W
L57	55.00'	N00°08'02"E
L58	16.50'	N89°51'58"W
L59	1.10'	N00°08'02"E
L60	95.23'	N29°23'32"W
L61	86.20'	S89°51'58"E
L62	45.99'	N00°08'02"E
L63	21.60'	N89°51'58"W
L64	18.63'	S00°32'20"W
L65	61.00'	N89°27'40"W
L66	16.50'	S00°32'20"W
L67	16.50'	S00°32'20"W

LINE TABLE		
LINE #	LENGTH	DIRECTION
L68	55.00'	N89°27'40"W
L69	15.50'	S00°32'20"W
L70	15.50'	S00°32'20"W
L71	29.50'	N89°27'40"W
L72	5.00'	S00°32'20"W
L73	5.00'	S00°32'20"W
L74	99.54'	N89°27'40"W
L75	60.10'	N00°08'02"E
L76	4.00'	S00°08'02"E
L77	13.75'	N00°08'02"E
L78	17.50'	S89°51'58"E
L79	68.00'	N00°08'02"E
L81	12.00'	S89°51'58"E
L82	74.83'	S89°51'58"E
L83	69.75'	N00°08'02"E
L84	16.50'	N00°08'02"E
L85	100.00'	S89°51'58"E
L86	17.49'	N00°08'02"E
L87	12.00'	S89°51'58"E
L88	57.38'	N00°08'02"E

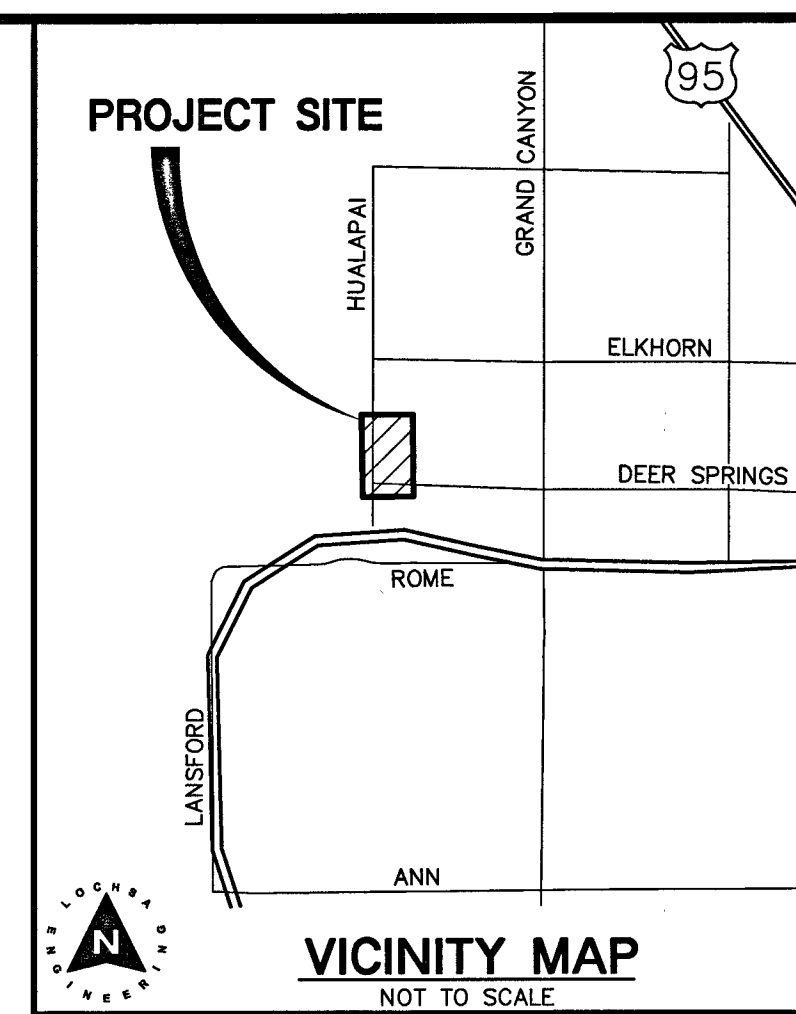

- ALL CONSTRUCTION TO BE DONE IN ACCORDANCE WITH "CLARK COUNTY AREA UNIFORM STANDARD DRAWINGS (CCAUSD)" LATEST EDITION.

LINE TABLE		
LINE #	LENGTH	DIRECTION
L89	56.69'	S09°35'46"W
L90	42.55'	N00°08'02"E
L91	35.01'	N15°11'39"W
L92	146.67'	N01°08'21"W
L93	75.81'	N89°25'00"W
L94	31.92'	N01°08'21"E
L95	25.00'	S00°03'14"E
L96	17.50'	S89°51'58"E
L106	74.18'	N00°08'02"E
L108	6.50'	S89°51'58"E
L109	16.50'	S89°51'58"E
L110	82.00'	N00°08'02"E
L111	12.00'	S89°51'58"E
L112	46.00'	S89°51'58"E
L113	26.41'	S00°03'14"E
L114	10.90'	N89°25'32"W
L116	17.12'	N00°08'02"E
L118	16.35'	N00°08'02"E
L121	54.00'	S00°08'02"E
L133	108.00'	S89°51'58"E

LINE TABLE		
LINE #	LENGTH	DIRECTION
L134	39.00'	N00°08'02"E
L135	108.00'	S89°51'58"W
L136	39.00'	N00°08'02"E
L137	10.50'	S00°32'20"W
L138	8.72'	S58°12'30"E
L139	8.72'	S58°12'30"E
L140	74.18'	N00°08'02"E
L142	276.21'	S89°27'40"E
L143	276.21'	S89°27'40"E
L156	68.60'	N89°51'58"W
L157	64.00'	S89°51'58"E
L158	56.76'	N89°51'58"E
L159	97.83'	S00°08'02"E
L160	69.83'	N00°08'02"E
L161	50.90'	N89°51'58"E
L162	33.64'	S89°51'58"W
L163	49.14'	S89°51'58"E
L164	13.84'	S00°08'02"E
L165	15.42'	N89°51'58"E
L166	82.00'	S00°08'02"E

LINE TABLE		
LINE #	LENGTH	DIRECTION
L167	15.20'	S89°51'58"E
L168	5.02'	S04°58'35"E
L169	15.52'	S89°51'58"E



NOTE:
FOR CURVE TABLES SEE SHEET C5.0

HORIZONTAL CONTROL NOTE
ALL DIMENSIONS SHOWN ARE TO BACK OF CURB
UNLESS NOTED OTHERWISE ON PLANS

CLARK COUNTY
DEPARTMENT OF PUBLIC WORKS
ACCEPTED

BY: _____ DATE: _____

ACCEPTANCE OF THESE PLANS SHALL NOT BE CONSTRUED TO BE A PERMIT FOR OR AN APPROVAL OF ANY VIOLATION OF STATE, COUNTY OR FEDERAL LAW SPECIFICATIONS, OR THE MANUAL ON UNIFORM TRAFFIC CONTROL DEVICES.

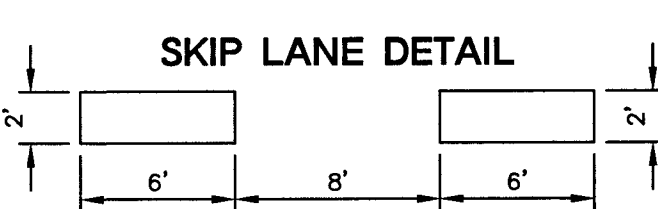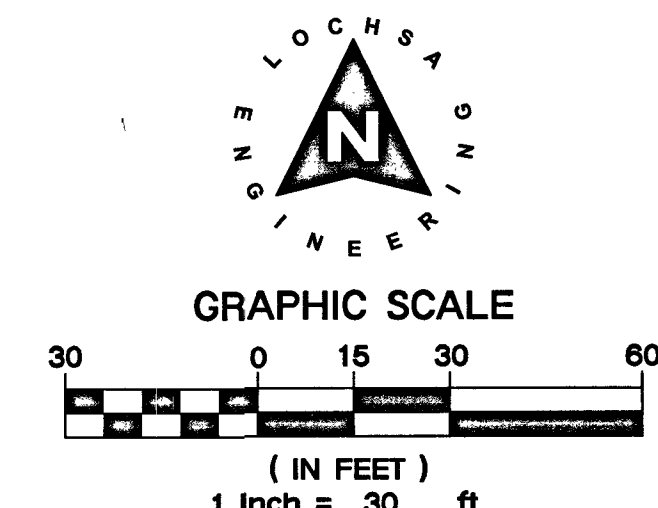

A.P.N.:
125-19-202-008

BASIS OF BEARINGS:
SOUTH 89°47'00" EAST, BEING THE BEARING OF THE SOUTH
BOUNDARY OF THE SECTION 10 OF THE 36TH TOWNSHIP OF
SOUTHWEST QUARTER (SW 1/4) OF SECTION 19, TOWNSHIP
19 SOUTH, RANGE 60 EAST, W.D.M., ALSO BEING THE
BEARING OF CENTENNIAL PARKWAY AS MEASURED
BETWEEN HUALAPAI WAY AND CONQUISTADOR STREET AS
SHOWN ON FILE 107, PAGE 31 OF SURVEYS IN THE
ENGINEERS OFFICE, CLARK COUNTY, NEVADA.

BENCHMARK:
THE BENCHMARK IS THE TOP OF CURB AT THE SOUTHEAST
CORNER OF THE BRIDGE OVER CLARK COUNTY HIGHWAY
215 ON HUALAPAI. ELEVATION = 853.317 (METERS) /
2799.53 (U.S. SURVEY FEET) NORTH AMERICAN VERTICAL
DATUM 1988

NOTE:
LOCHISA ENGINEERING ASSUMES NO RESPONSIBILITY FOR EXISTING UTILITY LOCATIONS AND ELEVATIONS. THE UTILITIES SHOWN ON THIS PLAN ARE FROM THE BEST AVAILABLE INFORMATION. IT IS THE CONTRACTOR'S RESPONSIBILITY TO FIELD VERIFY THE LOCATION AND ELEVATION OF ALL UTILITIES, INCLUDING BUT NOT LIMITED TO, THE WATER, FIRE, SANITARY SEWER, STORM SEWER, TELEPHONE, POWER, GAS, AND IRRIGATION LINES PRIOR TO THE COMMENCEMENT OF CONSTRUCTION. IF CONFLICTS EXIST IN THE FIELD, THE CONTRACTOR IS TO NOTIFY THE PROJECT ARCHITECT, OWNER'S REPRESENTATIVE, AND THE PROJECT ENGINEER IMMEDIATELY.

Call before you Dig
Avoid cutting underground utility lines. It's costly.

CALL 811

FAST

Call before you Underground

Avoid hitting overhead power lines. It's costly.

Call BEFORE YOU DO OVERHEAD

TRAFFIC AND HORIZONTAL CONTROL PLANS
SHEET 1 OF 2

DEER SPRINGS AND HUALAPAI
CITY OF LAS VEGAS,
NEVADA


PROJECT No.:	161109
DATE:	APRIL 3, 2018
SCALE:	---
DRAWN BY:	MGZ
DESIGNED BY:	MGZ
CHECKED BY:	JLJ

SEAL
PROFESSIONAL ENGINEER—STATE OF MISSISSIPPI
ED. T. EIGHTON
EXP. 12-31-18
CIVIL
No. 11286
04/03/2018
SHEET No.
C5.01
SHEET 11 of 15
CLY No. HTE No.
69418 17-19756

Lochsa
engineering
6345 South Jones Blvd.
Suite 100
Las Vegas, NV 89118
Phone (702) 365-9312
Fax (702) 365-9317
www.lochsa.com

FOR CONTINUATION
SEE SHEET C5.02

CL OR SURVEY LINE		EASEMENT LINE	DESCRIPTION:	CONTOUR LINES	EDGE OF PAVEMENT	"A" TYPE CURBS	"L" TYPE CURBS	WALLS	FENCES	AC PAVEMENT	CONCRETE	SPOT ELEVATIONS	SIGNS	MANHOLE W/ DESCRIPTION	MANHOLE DESCRIPTIONS	FIRE HYDRANTS	GATE VALVES	REDUCERS	CLEAN OUTS	UTILITY BOX OR VAULT	BACKWATER VALVES	100W HPS STREETLIGHTS	150W HPS STREETLIGHTS	200W HPS STREETLIGHTS	250W HPS STREETLIGHTS	C5.01 SHEET 11 of 15	
PROPERTY LINE		SAWTOOTH LINE	EXISTING:	--(2210)--								12.34 BC		Ⓢ	Ⓢ = SANITARY SEWER											CLV No.	HTE No.
ROW LINE		SCARP LINE	PROPOSED:	Ⓢ(2122)								12.34 BC		Ⓢ	Ⓢ = STORM DRAIN Ⓢ = ELECTRICAL Ⓢ = TELEPHONE											69418	17-19756

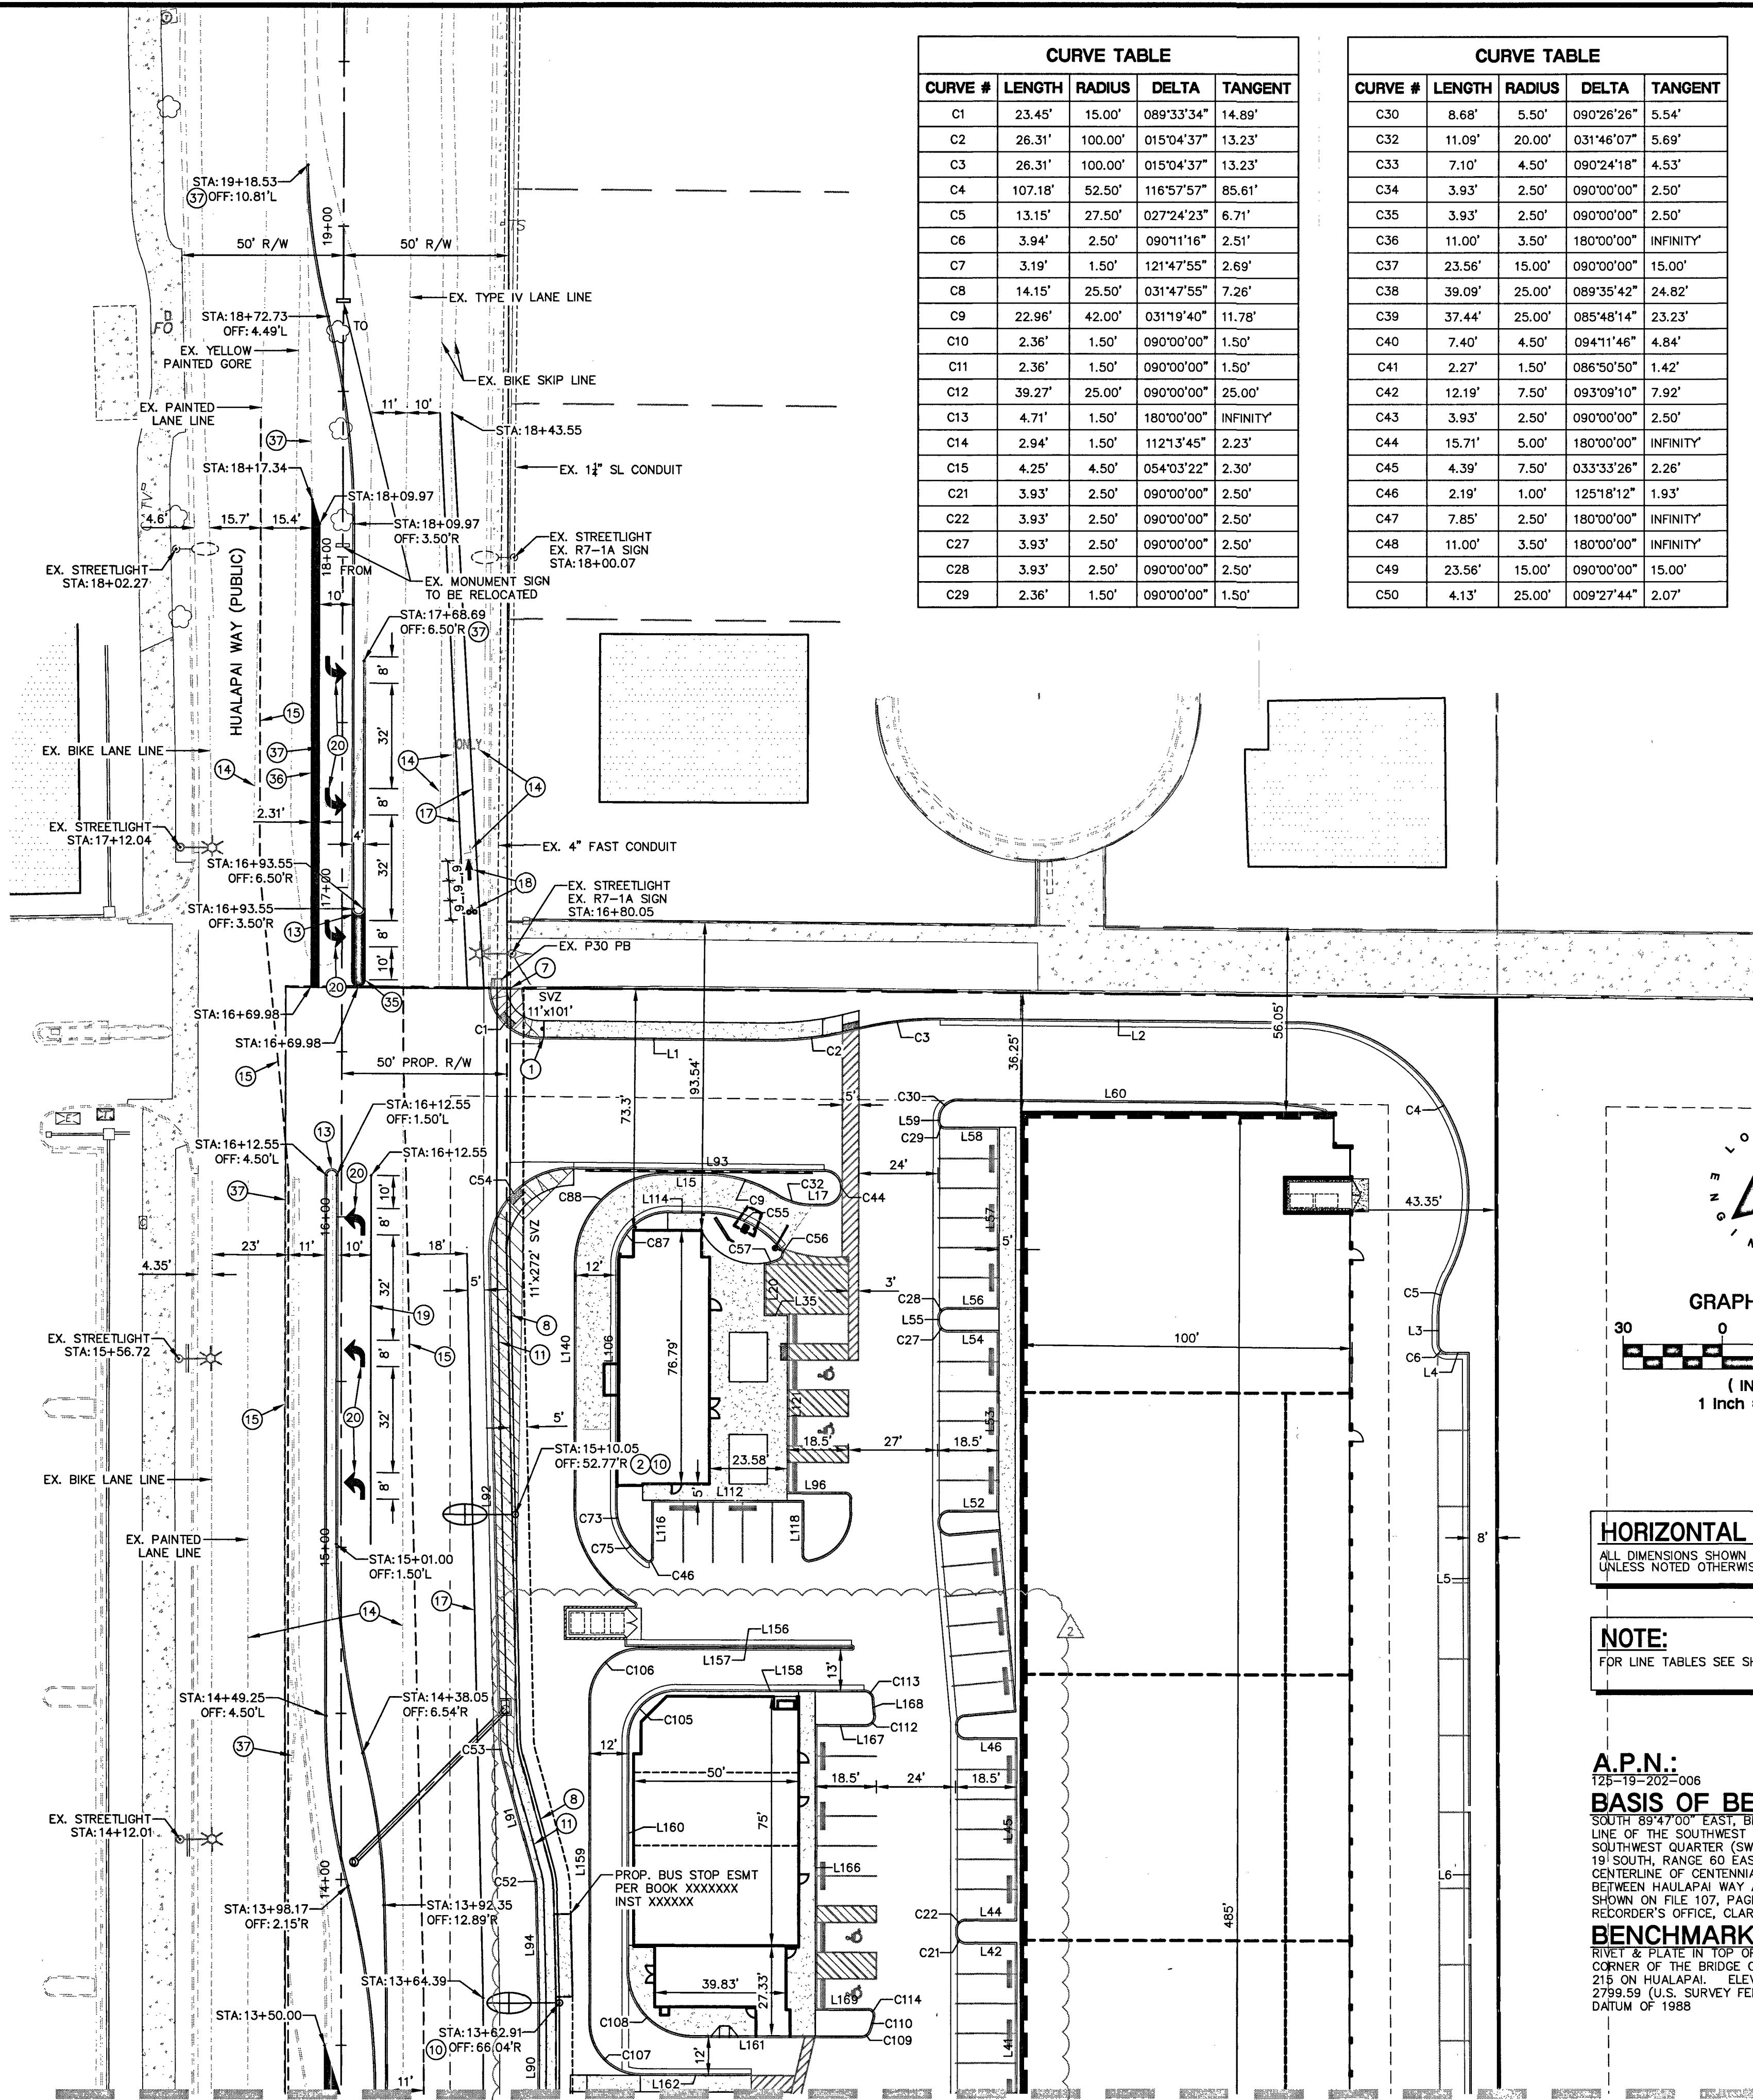


CURVE TABLE				
CURVE #	LENGTH	RADIUS	DELTA	TANGENT
C1	23.45'	15.00'	089°33'34"	14.89'
C2	26.31'	100.00'	015°04'37"	13.23'
C3	26.31'	100.00'	015°04'37"	13.23'
C4	107.18'	52.50'	116°57'57"	85.61'
C5	13.15'	27.50'	027°24'23"	6.71'
C6	3.94'	2.50'	090°11'16"	2.51'
C7	3.19'	1.50'	121°47'55"	2.69'
C8	14.15'	25.50'	031°47'55"	7.26'
C9	22.96'	42.00'	031°19'40"	11.78'
C10	2.36'	1.50'	090°00'00"	1.50'
C11	2.36'	1.50'	090°00'00"	1.50'
C12	39.27'	25.00'	090°00'00"	25.00'
C13	4.71'	1.50'	180°00'00"	INFINITY
C14	2.94'	1.50'	112°13'45"	2.23'
C15	4.25'	4.50'	054°03'22"	2.30'
C21	3.93'	2.50'	090°00'00"	2.50'
C22	3.93'	2.50'	090°00'00"	2.50'
C27	3.93'	2.50'	090°00'00"	2.50'
C28	3.93'	2.50'	090°00'00"	2.50'
C29	2.36'	1.50'	090°00'00"	1.50'

CURVE TABLE				
CURVE #	LENGTH	RADIUS	DELTA	TANGENT
C30	8.68'	5.50'	090°26'26"	5.54'
C32	11.09'	20.00'	031°46'07"	5.69'
C33	7.10'	4.50'	090°24'18"	4.53'
C34	3.93'	2.50'	090°00'00"	2.50'
C35	3.93'	2.50'	090°00'00"	2.50'
C36	11.00'	3.50'	180°00'00"	INFINITY
C37	23.56'	15.00'	090°00'00"	15.00'
C38	39.09'	25.00'	089°35'42"	24.82'
C39	37.44'	25.00'	085°48'14"	23.23'
C40	7.40'	4.50'	094°11'46"	4.84'
C41	2.27'	1.50'	086°50'50"	1.42'
C42	12.19'	7.50'	093°09'10"	7.92'
C43	3.93'	2.50'	090°00'00"	2.50'
C44	15.71'	5.00'	180°00'00"	INFINITY
C45	4.39'	7.50'	033°33'26"	2.26'
C46	2.19'	1.00'	125°18'12"	1.93'
C47	7.85'	2.50'	180°00'00"	INFINITY
C48	11.00'	3.50'	180°00'00"	INFINITY
C49	23.56'	15.00'	090°00'00"	15.00'
C50	4.13'	25.00'	009°27'44"	2.07'

CURVE TABLE				
CURVE #	LENGTH	RADIUS	DELTA	TANGENT
C51	4.13'	25.00'	009°27'44"	2.07'
C52	6.13'	25.00'	014°03'18"	3.08'
C53	6.13'	25.00'	014°03'18"	3.08'
C54	40.02'	25.00'	091°42'49"	25.76'
C55	25.97'	30.00'	049°36'20"	13.86'
C56	3.75'	2.00'	107°23'08"	2.72'
C57	4.19'	18.00'	013°19'57"	2.10'
C67	3.83'	1.50'	146°26'34"	4.97'
C68	7.85'	2.50'	180°00'00"	INFINITY
C69	30.63'	19.50'	090°00'00"	19.50'
C70	8.64'	5.50'	090°00'00"	5.50'
C73	5.53'	14.50'	021°51'25"	2.80'
C75	12.90'	22.50'	032°50'23"	6.63'
C86	2.36'	1.50'	090°00'00"	1.50'
C87	24.47'	15.50'	090°26'26"	15.62'
C88	43.45'	27.50'	090°31'29"	27.75'
C89	1.57'	0.50'	180°00'00"	INFINITY
C90	1.57'	0.50'	180°00'00"	INFINITY
C105	22.78'	14.50'	090°00'00"	14.50'
C106	24.35'	15.50'	090°00'01"	15.50'

CURVE TABLE				
CURVE #	LENGTH	RADIUS	DELTA	TANGENT
C107	24.35'	15.50'	090°00'00"	15.50'
C108	30.63'	19.50'	090°00'00"	19.50'
C109	3.03'	2.50'	089°24'47"	1.73'
C110	4.60'	27.50'	009°35'16"	2.31'
C112	4.15'	2.50'	095°06'38"	2.73'
C113	3.70'	2.50'	084°53'22"	2.29'
C114	3.53'	2.00'	100°59'57"	2.43'


FOR CONTINUATION
SEE SHEET C5.01

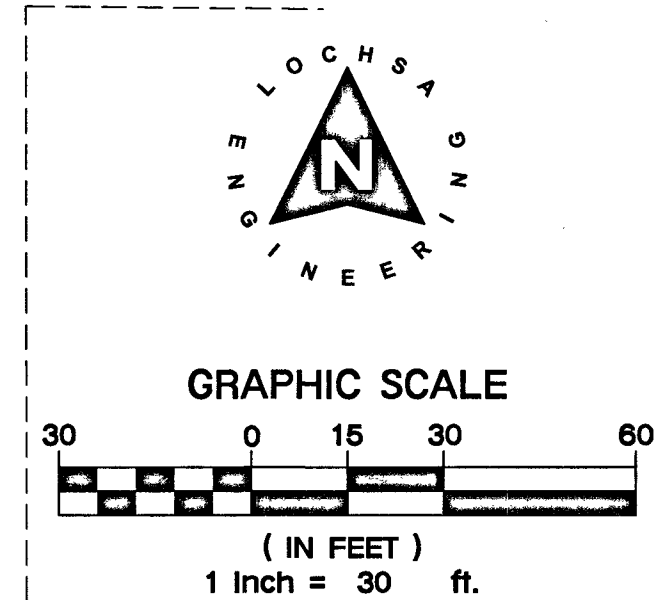

HORIZONTAL CONTROL NOTE:
ALL DIMENSIONS SHOWN ARE TO BACK OF CURB
UNLESS NOTED OTHERWISE ON PLANS.

NOTE:
FOR LINE TABLES SEE SHEET C5.01

A.P.N.:
12B-19-202-006
BASIS OF BEARINGS:
SOUTH 89°47'00" EAST, BEING THE BEARING OF THE SOUTH
LINE OF THE SOUTHWEST QUARTER (SW 1/4) OF THE
SOUTHWEST QUARTER (SW 1/4) OF SECTION 19, TOWNSHIP
19 SOUTH, RANGE 60 EAST, M.D.M., ALSO BEING THE
CENTERLINE OF CENTENNIAL PARKWAY AS MEASURED
BEHIND HUALAPAI WAY AND CONQUISTADOR STREET AS
SHOWN ON FILE 107, PAGE 31 OF SURVEYS IN THE
RECORDER'S OFFICE, CLARK COUNTY, NEVADA.
BENCHMARK:
RIVET & PLATE IN TOP OF CURB AT THE SOUTHEAST
CORNER OF THE BRIDGE OVER CLARK COUNTY HIGHWAY
215 ON HUALAPAI. ELEVATION = 853.317 (METERS) /
2799.59 (U.S. SURVEY FEET) NORTH AMERICAN VERTICAL
DATUM OF 1988

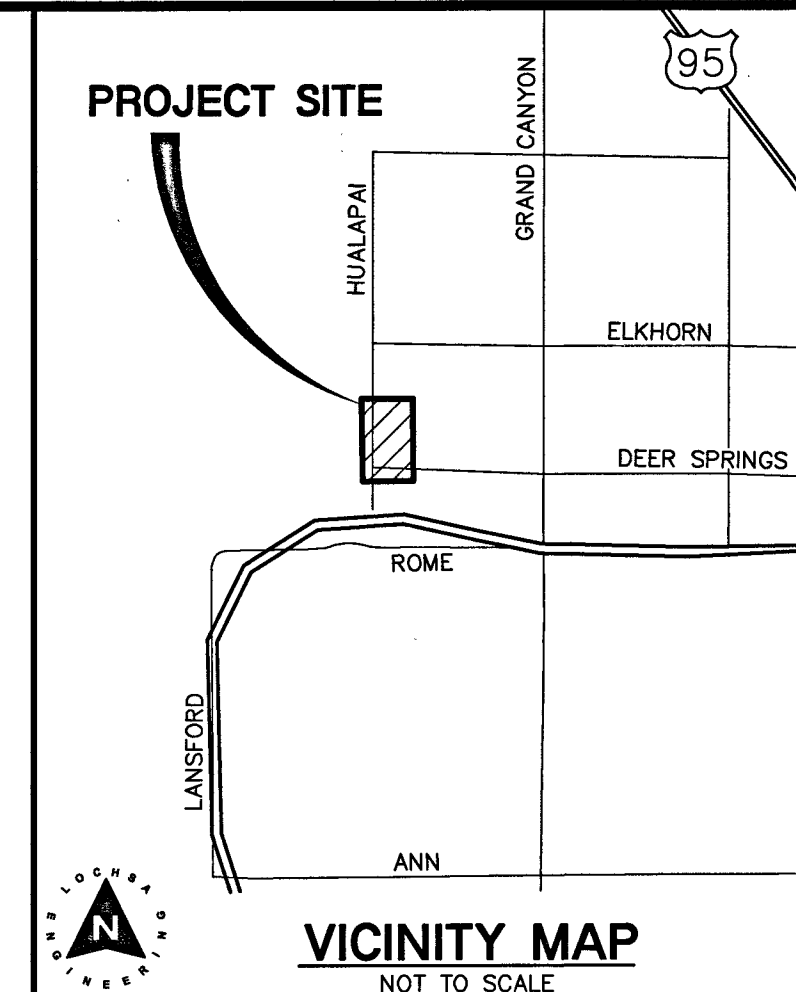

- TRAFFIC CONSTRUCTION NOTES:**
- ALL CONSTRUCTION TO BE DONE IN ACCORDANCE WITH "CLARK COUNTY AREA UNIFORM STANDARD DRAWINGS (CCAUDS)" LATEST EDITION.
 - INSTALL 36" R1-1 SIGN
 - INSTALL R7-1A SIGN (18"x24")
 - INSTALL R6-1R SIGN (36"x12")
 - RELOCATE EX. R2-1 SIGN
 - REMOVE EXISTING SIGNS
 - INSTALL R3-17 SIGN (24"x18") W/ R3-17B SIGN (24"x18")
 - INTERCEPT EX. CONDUIT AND REPUCC CONDUCTORS
 - INSTALL 1 1/2" PVC CONDUIT W/ (2) #4 CONDUCTORS AND (1) #8 CONDUCTORS
 - INSTALL NO. 3 PULLBOX PER CCAUSD 326
 - INSTALL LED FIXTURE C422-1E-160 LA-AW-UMIV-BLP PER TOWN CENTER STANDARDS
 - INSTALL 4" FAST INTERCONNECT CONDUIT W/ (1) #8 BARE WIRE
 - P30 PULLBOX (REFER TO TRAFFIC SIGNAL PLAN)
 - INSTALL YELLOW PAINTED MEDIAN NOSE MARKINGS PER CCAUSD 248
 - OBSTITUTE EX. STRIPING
 - INSTALL TYPE IV LANE LINE (RPM) PER CCAUSD 244.1
 - INSTALL TYPE II FILM WHITE 24" WIDE STOP BAR
 - INSTALL WHITE TYPE II FILM 6" WIDE BIKE LANE LINE
 - INSTALL WHITE TYPE I FILM BIKE PAVEMENT MARKINGS
 - INSTALL LEFT TURN LANE LINE PER CCAUSD 246
 - INSTALL WHITE TYPE II FILM PAVEMENT MARKING
 - INSTALL YELLOW PAINTED GORE AREA PER CCAUSD 245
 - INSTALL TYPE I CENTERLINE (RPM) PER CCAUSD 244
 - INSTALL WHITE PAINTED GORE AREA PER CCAUSD 245
 - INSTALL R3-7R SIGN (36"x36")
 - INSTALL OM-3R SIGN (12"x48")
 - INSTALL R3-4 SIGN (24"x24")
 - INSTALL P30 PULLBOX PER CCAUSD 761
 - INSTALL 200 AMP SERVICE PEDESTAL PER CCAUSD 330,331 & 332
 - INSTALL 4" WHITE PAINTED EDGELINE
 - INSTALL 8" WHITE PAINTED EDGELINE
 - INSTALL R3-17 SIGN (24"x18")
 - INSTALL TYPE II FILM SINGLE SKIP LANE LINE PER DETAIL
 - INSTALL 6" WIDE PAINTED GORE LINE
 - INSTALL WHITE CAT TRACKS (RPM)
 - INSTALL YELLOW TYPE II FILM AREA
 - INSTALL WHITE TYPE II FILM AREA
 - EXISTING ISLAND MEDIAN TO BE REMOVED
 - INSTALL NDOT SIGN RNV3-18

NOTE:
LOCHSA ENGINEERING ASSUMES NO RESPONSIBILITY FOR
EXISTING UTILITY LOCATIONS AND ELEVATIONS. THE UTILITIES
SHOWN ON THIS PLAN ARE FROM THE BEST AVAILABLE
INFORMATION. IT IS THE CONTRACTOR'S RESPONSIBILITY TO
FIELD VERIFY THE LOCATION AND ELEVATION OF ALL UTILITIES,
INCLUDING BUT NOT LIMITED TO, THE WATER, FIRE, SANITARY
SEWER, STORM SEWER, TELEPHONE, POWER, GAS, AND
IRRIGATION LINES PRIOR TO THE COMMENCEMENT OF
CONSTRUCTION. IF CONFLICT EXISTS IN THE FIELD, THE
CONTRACTOR IS TO NOTIFY THE PROJECT ARCHITECT, OWNER'S
REPRESENTATIVE AND THE PROJECT ENGINEER IMMEDIATELY.

Call before you Dig
Avoid cutting underground
utility lines. It's costly.

FAST
Call before you Dig
Underground

1-800-227-2800
1-702-432-5300
1-702-227-2929

6345 South Jones Blvd
Suite 100
Las Vegas, NV 89118
Phone (702) 365-9312
Fax (702) 365-9317
www.lochsa.com

Lochsa
engineering

TRAFFIC AND HORIZONTAL CONTROL PLANS
SHEET 2 OF 2















DEER SPRINGS AND HUALAPAI
CITY OF LAS VEGAS,
NEVADA

PROJECT No.: 161109
DATE: APRIL 3, 2018
SCALE:
DRAWN BY: MGZ
DESIGNED BY: MGZ
CHECKED BY: JLI

SEAL
REGISTERED PROFESSIONAL ENGINEER-STATE OF NEVADA
J. T. FOSTON
No. 11286
04/03/2018

10/11/2018
L-1418
SHEET 12 OF 15
C5.02
CLY No. 69418
ITE No. 17-19758

4/2/2018 3:38 PM
7:00 AM (161109) Drawings\Plot Drawings\161109-10.dwg

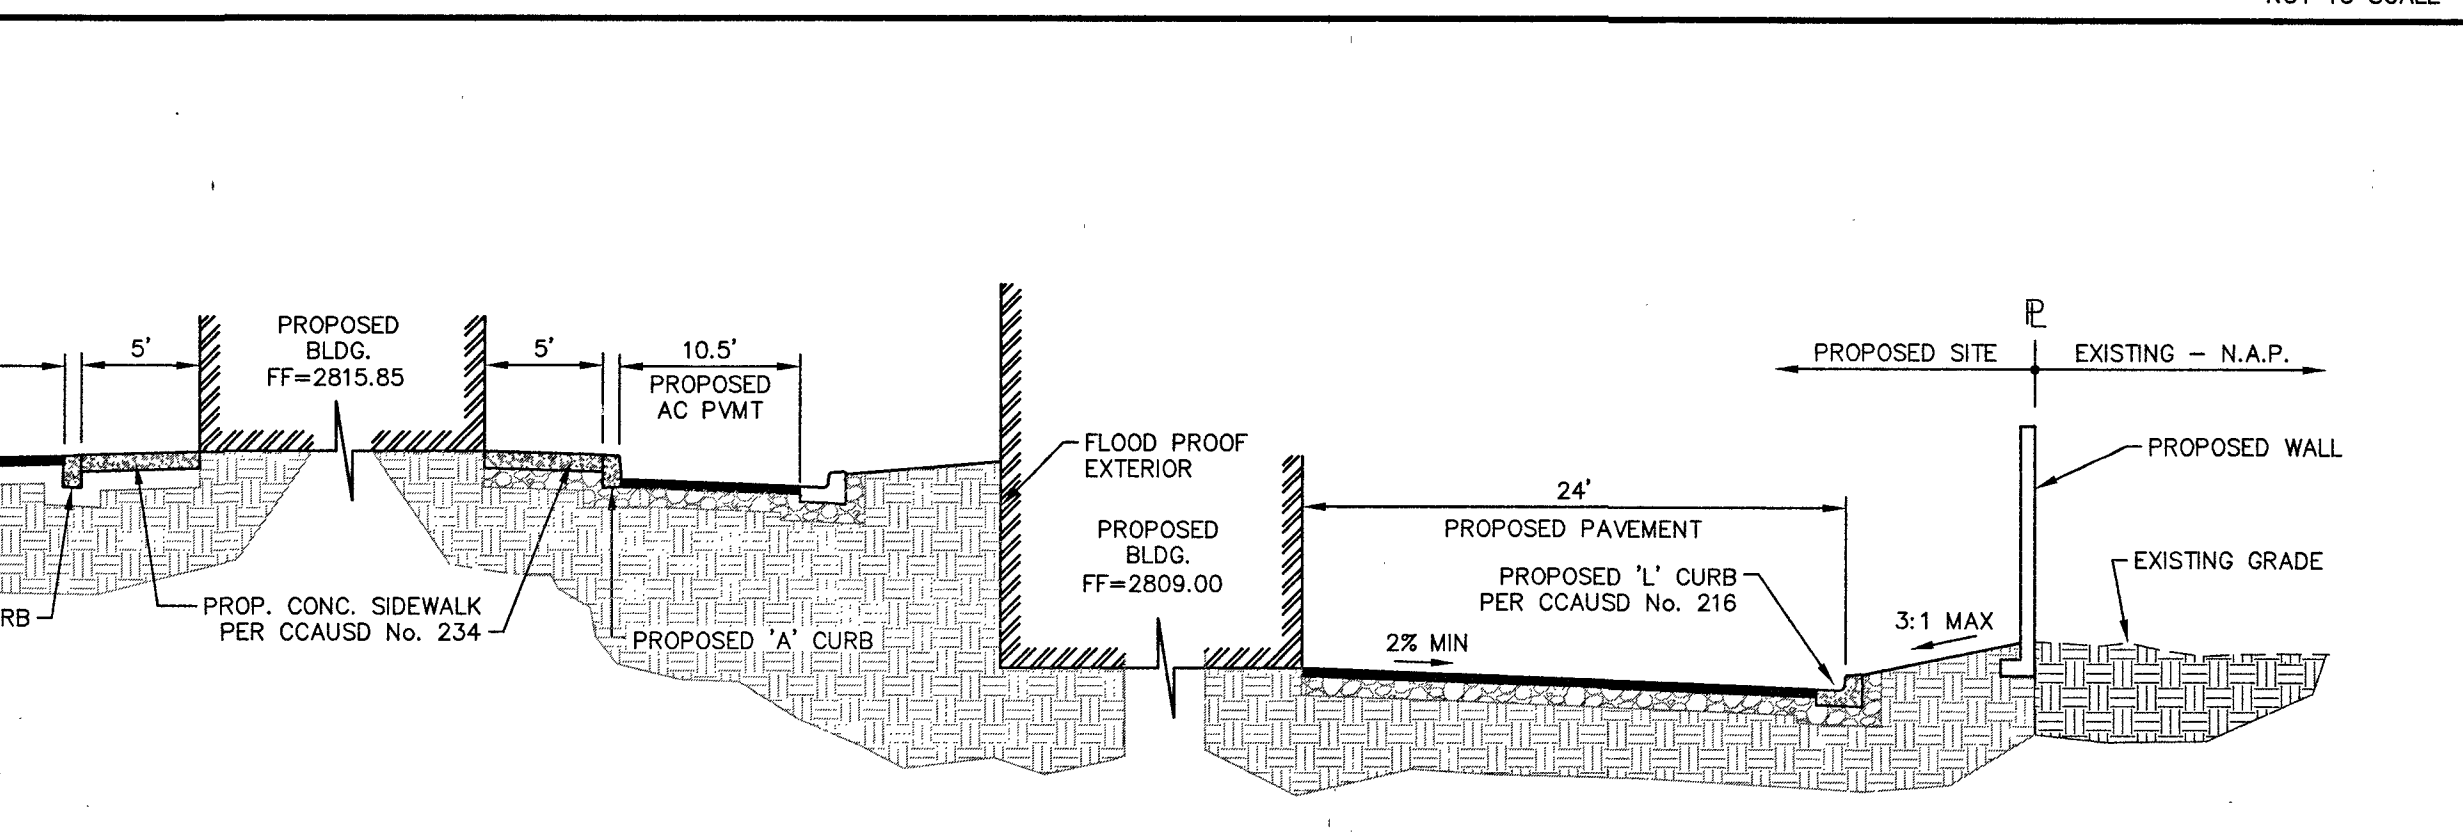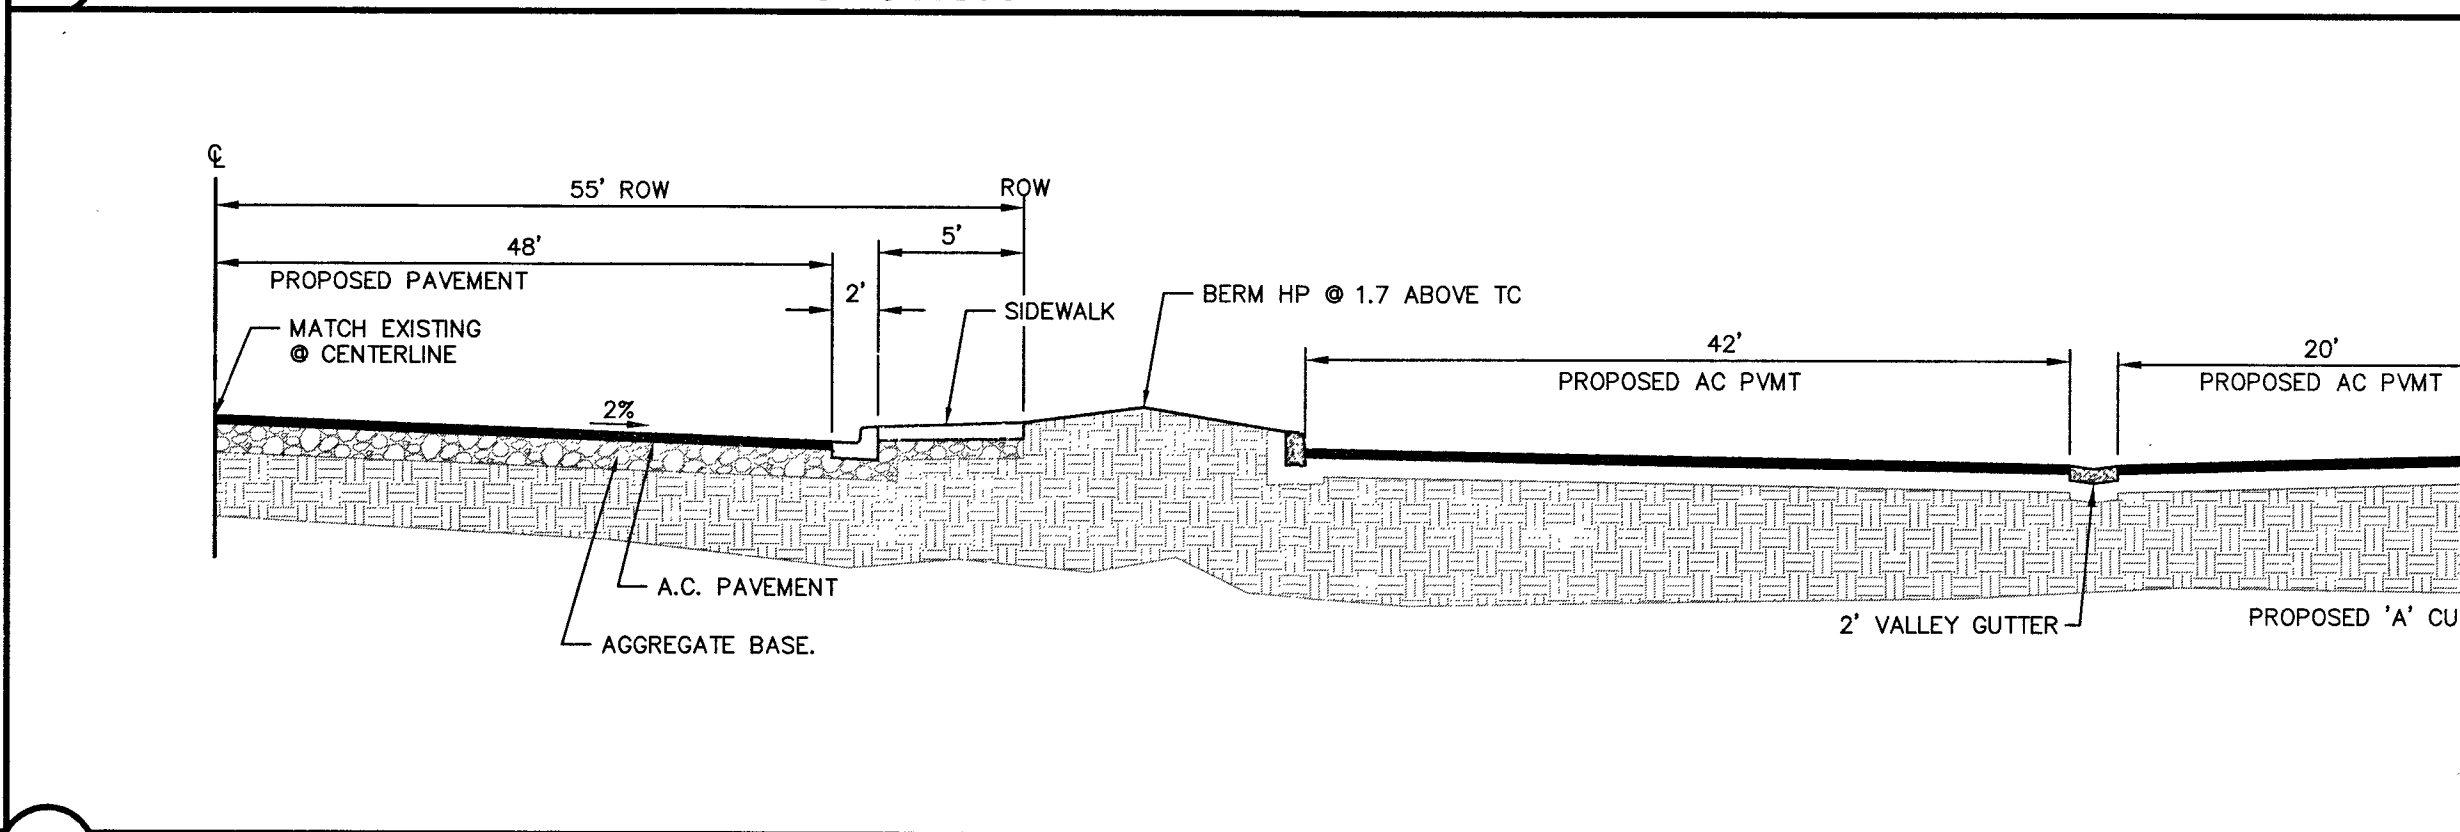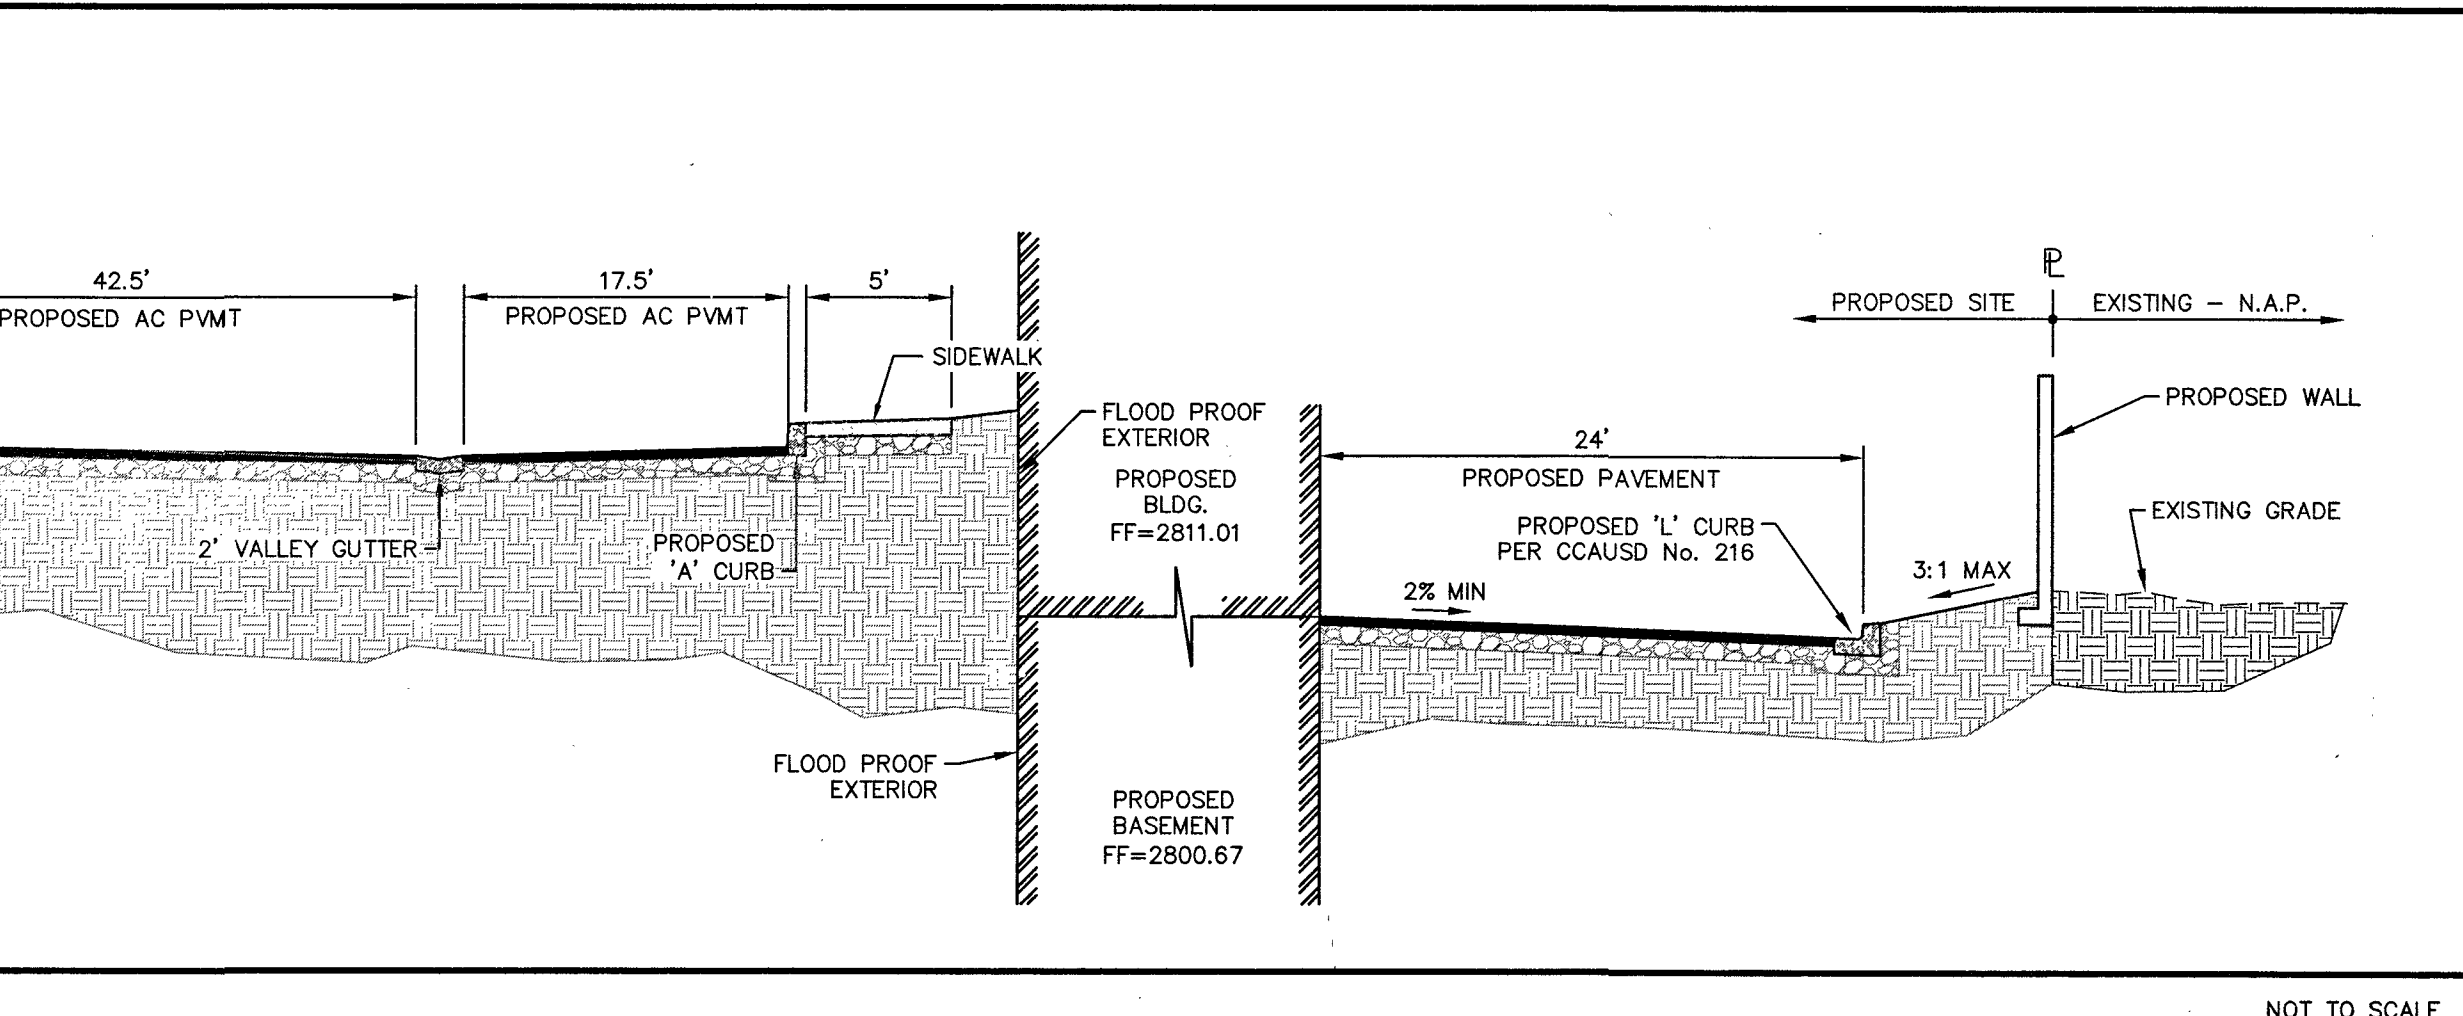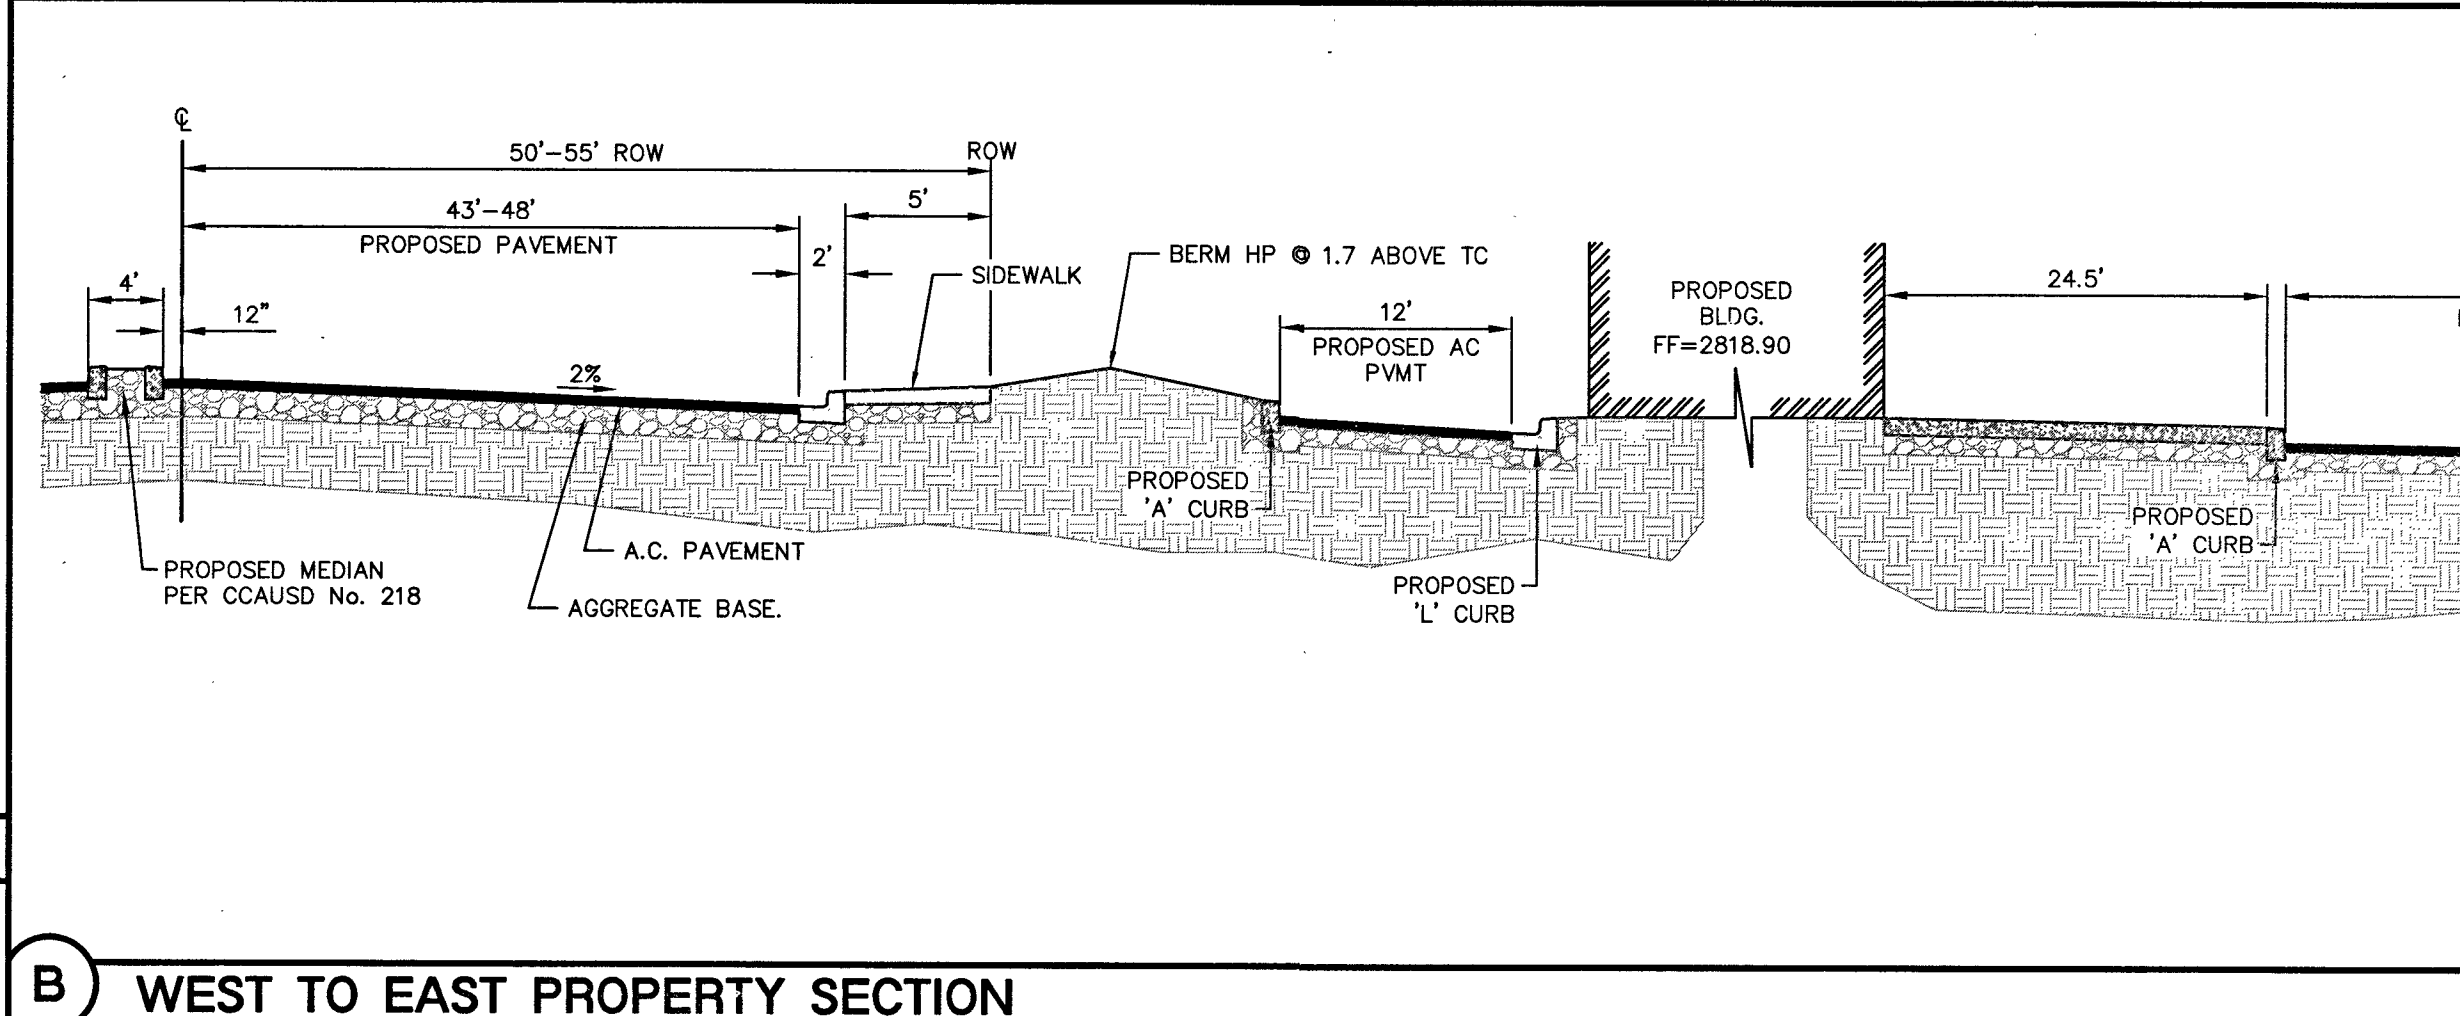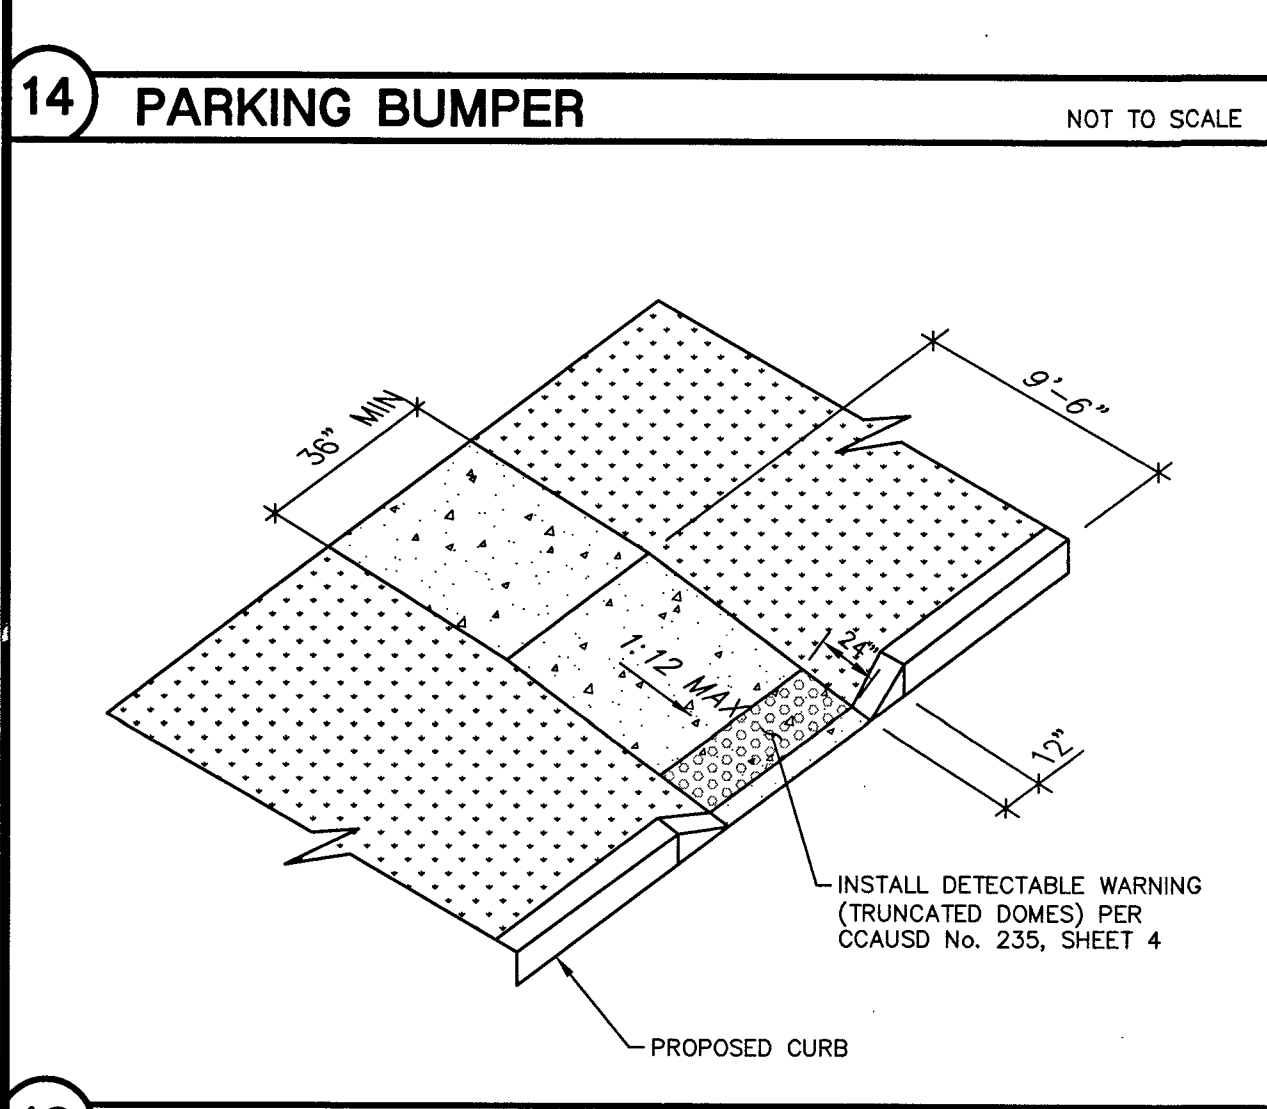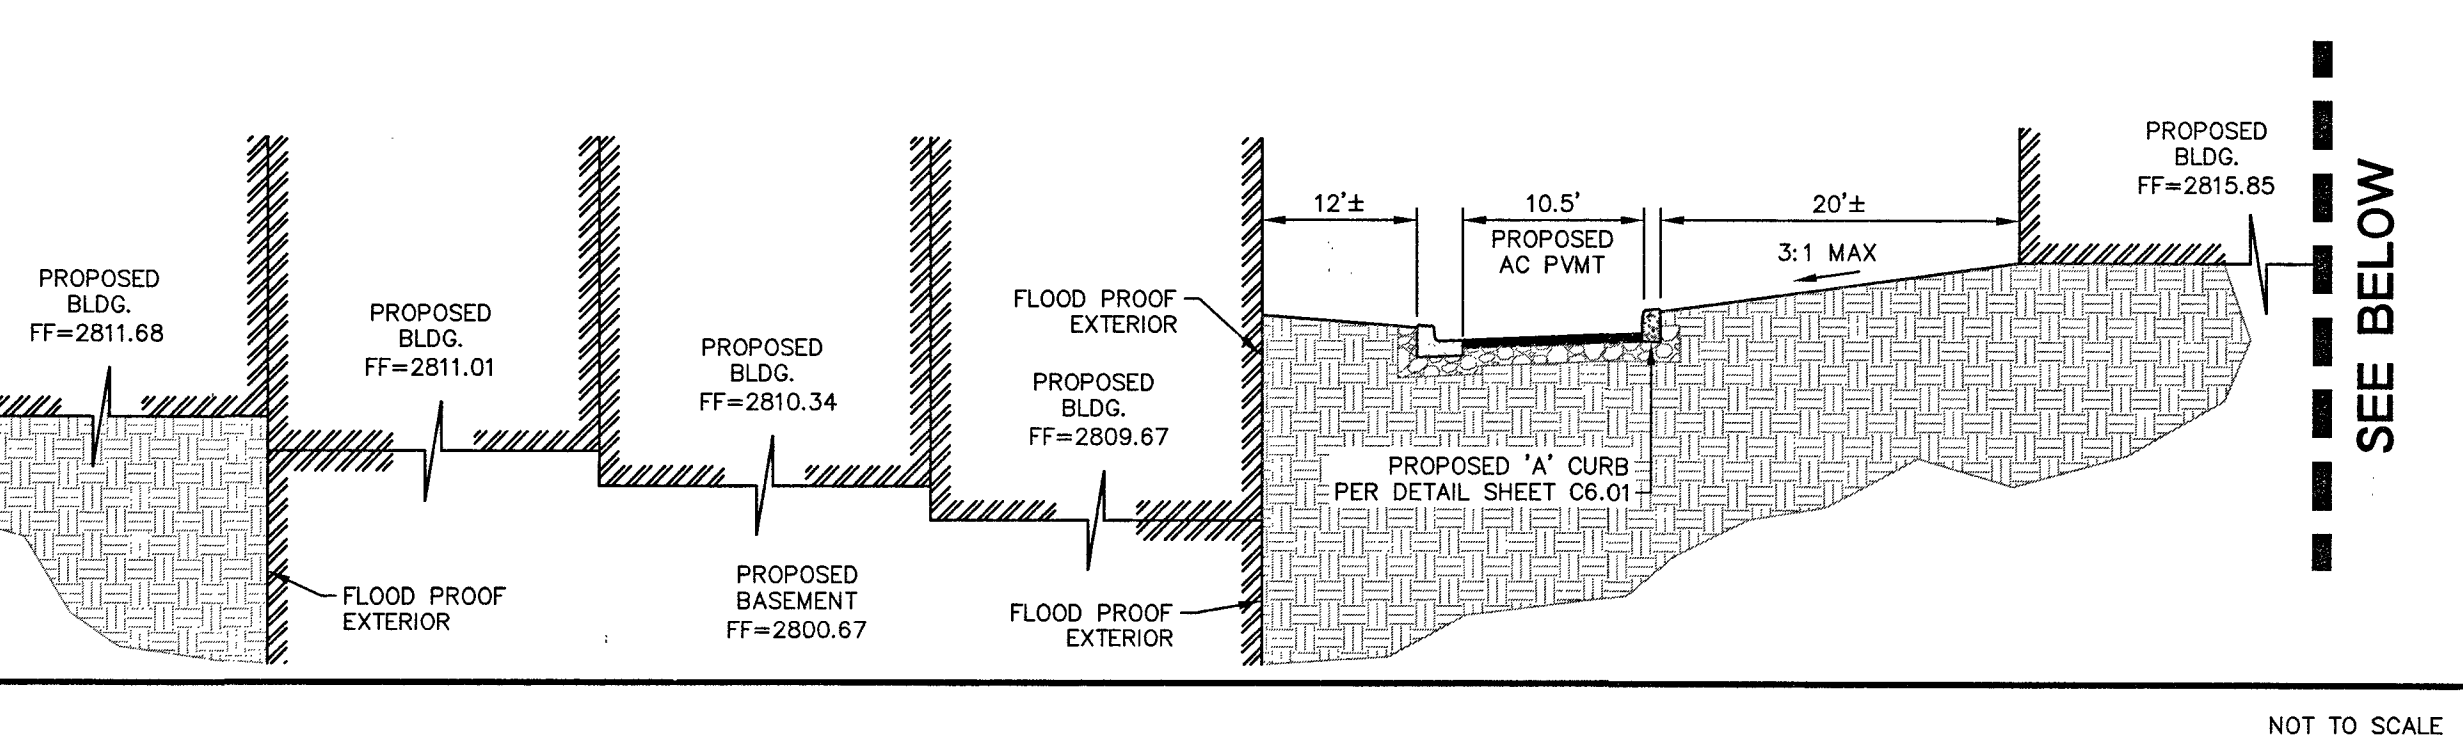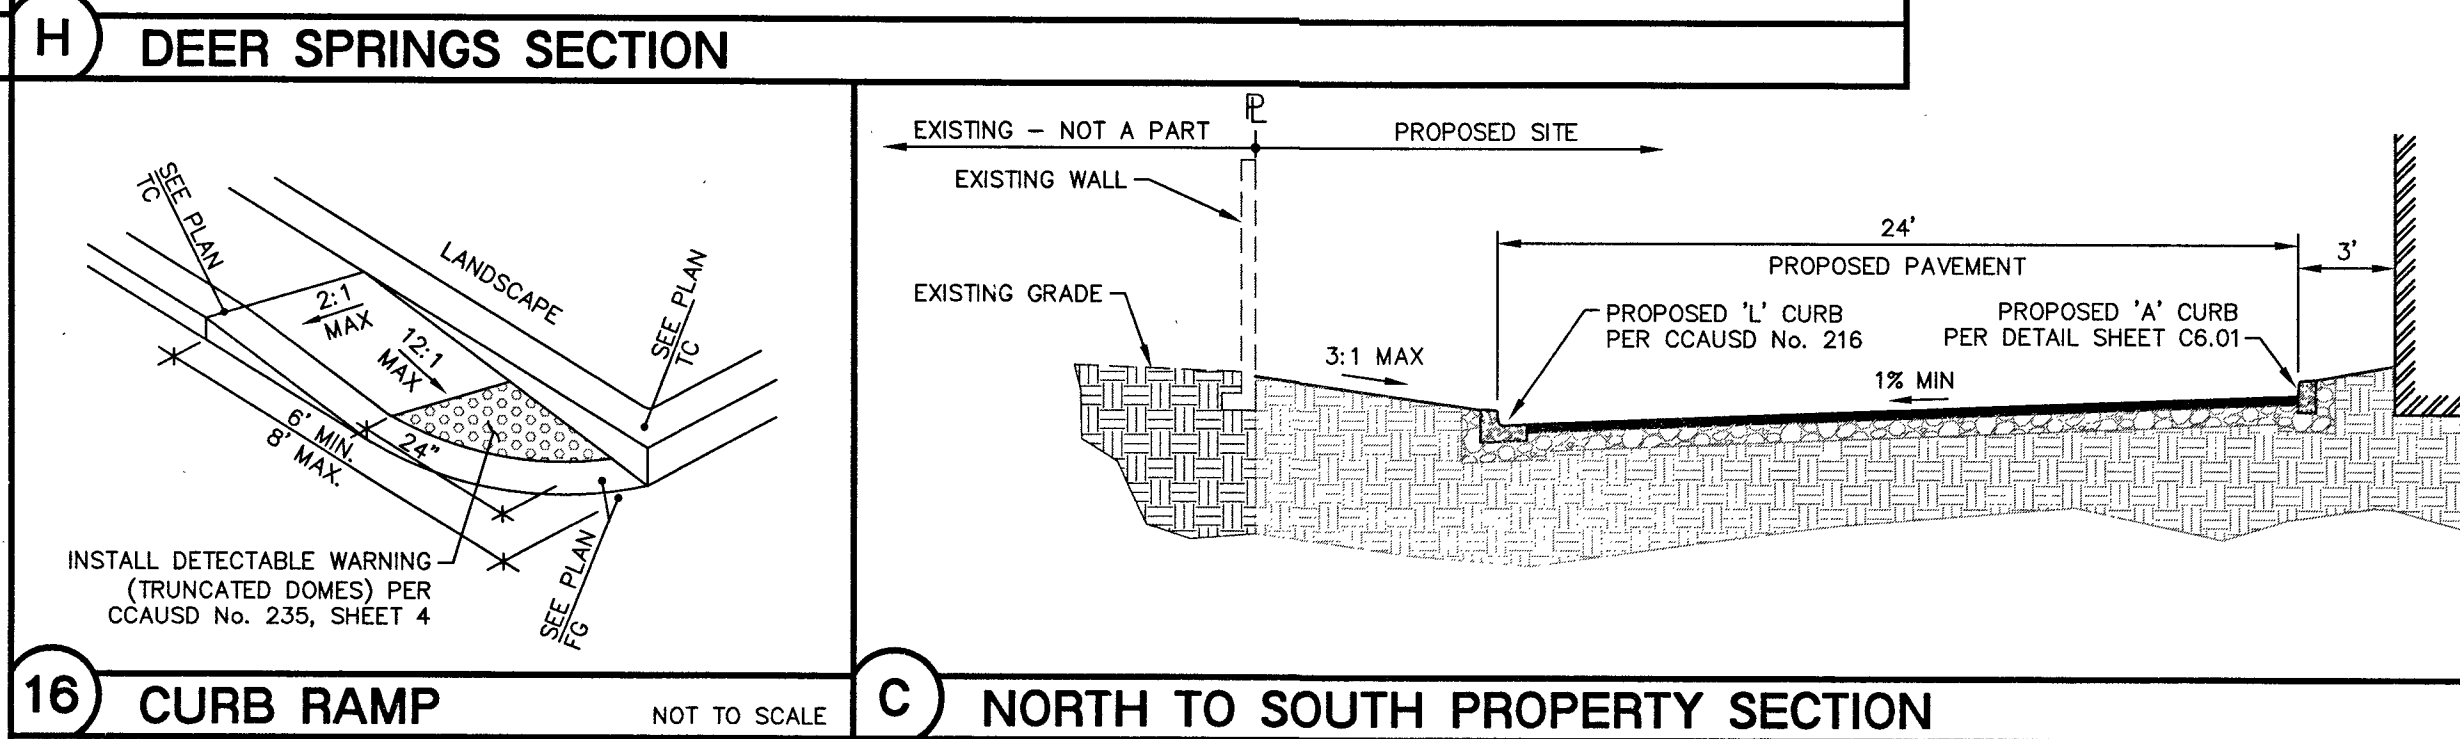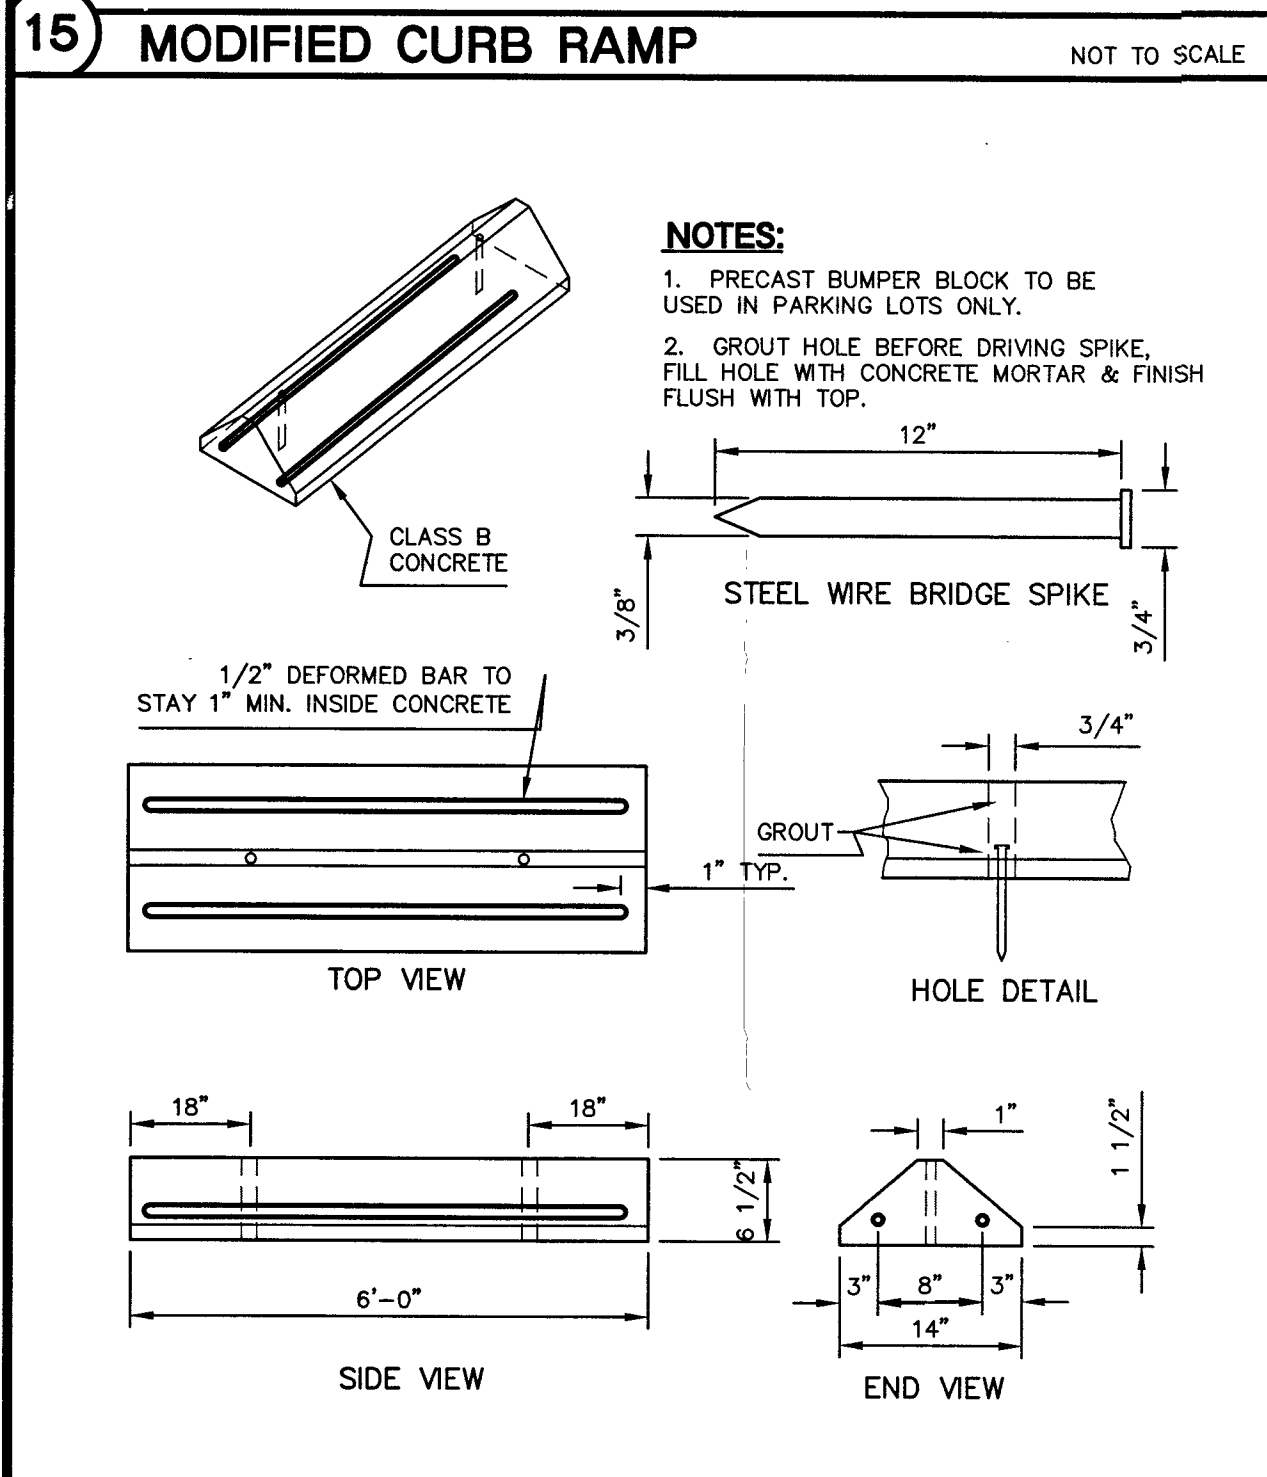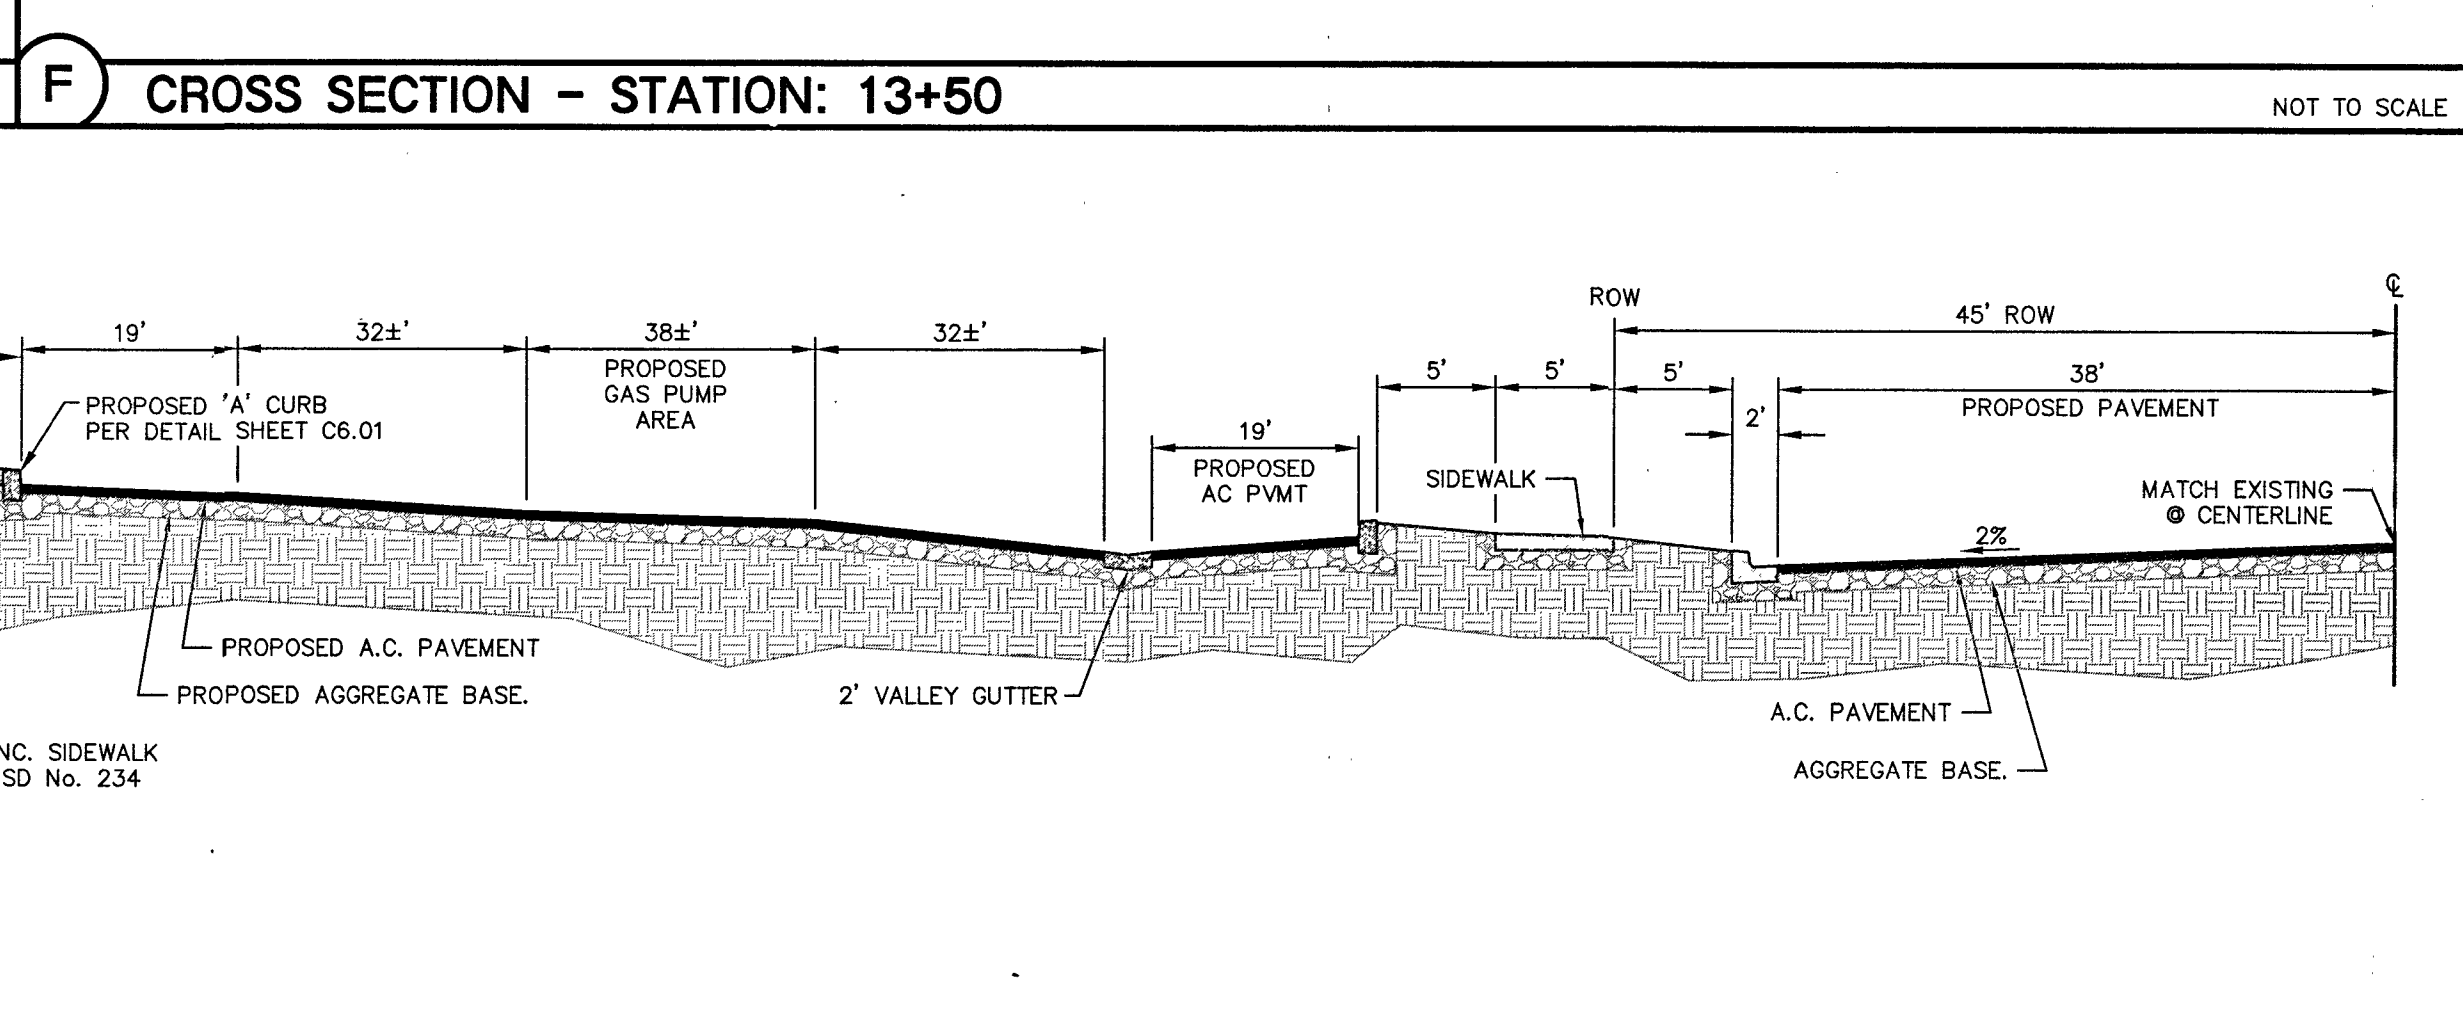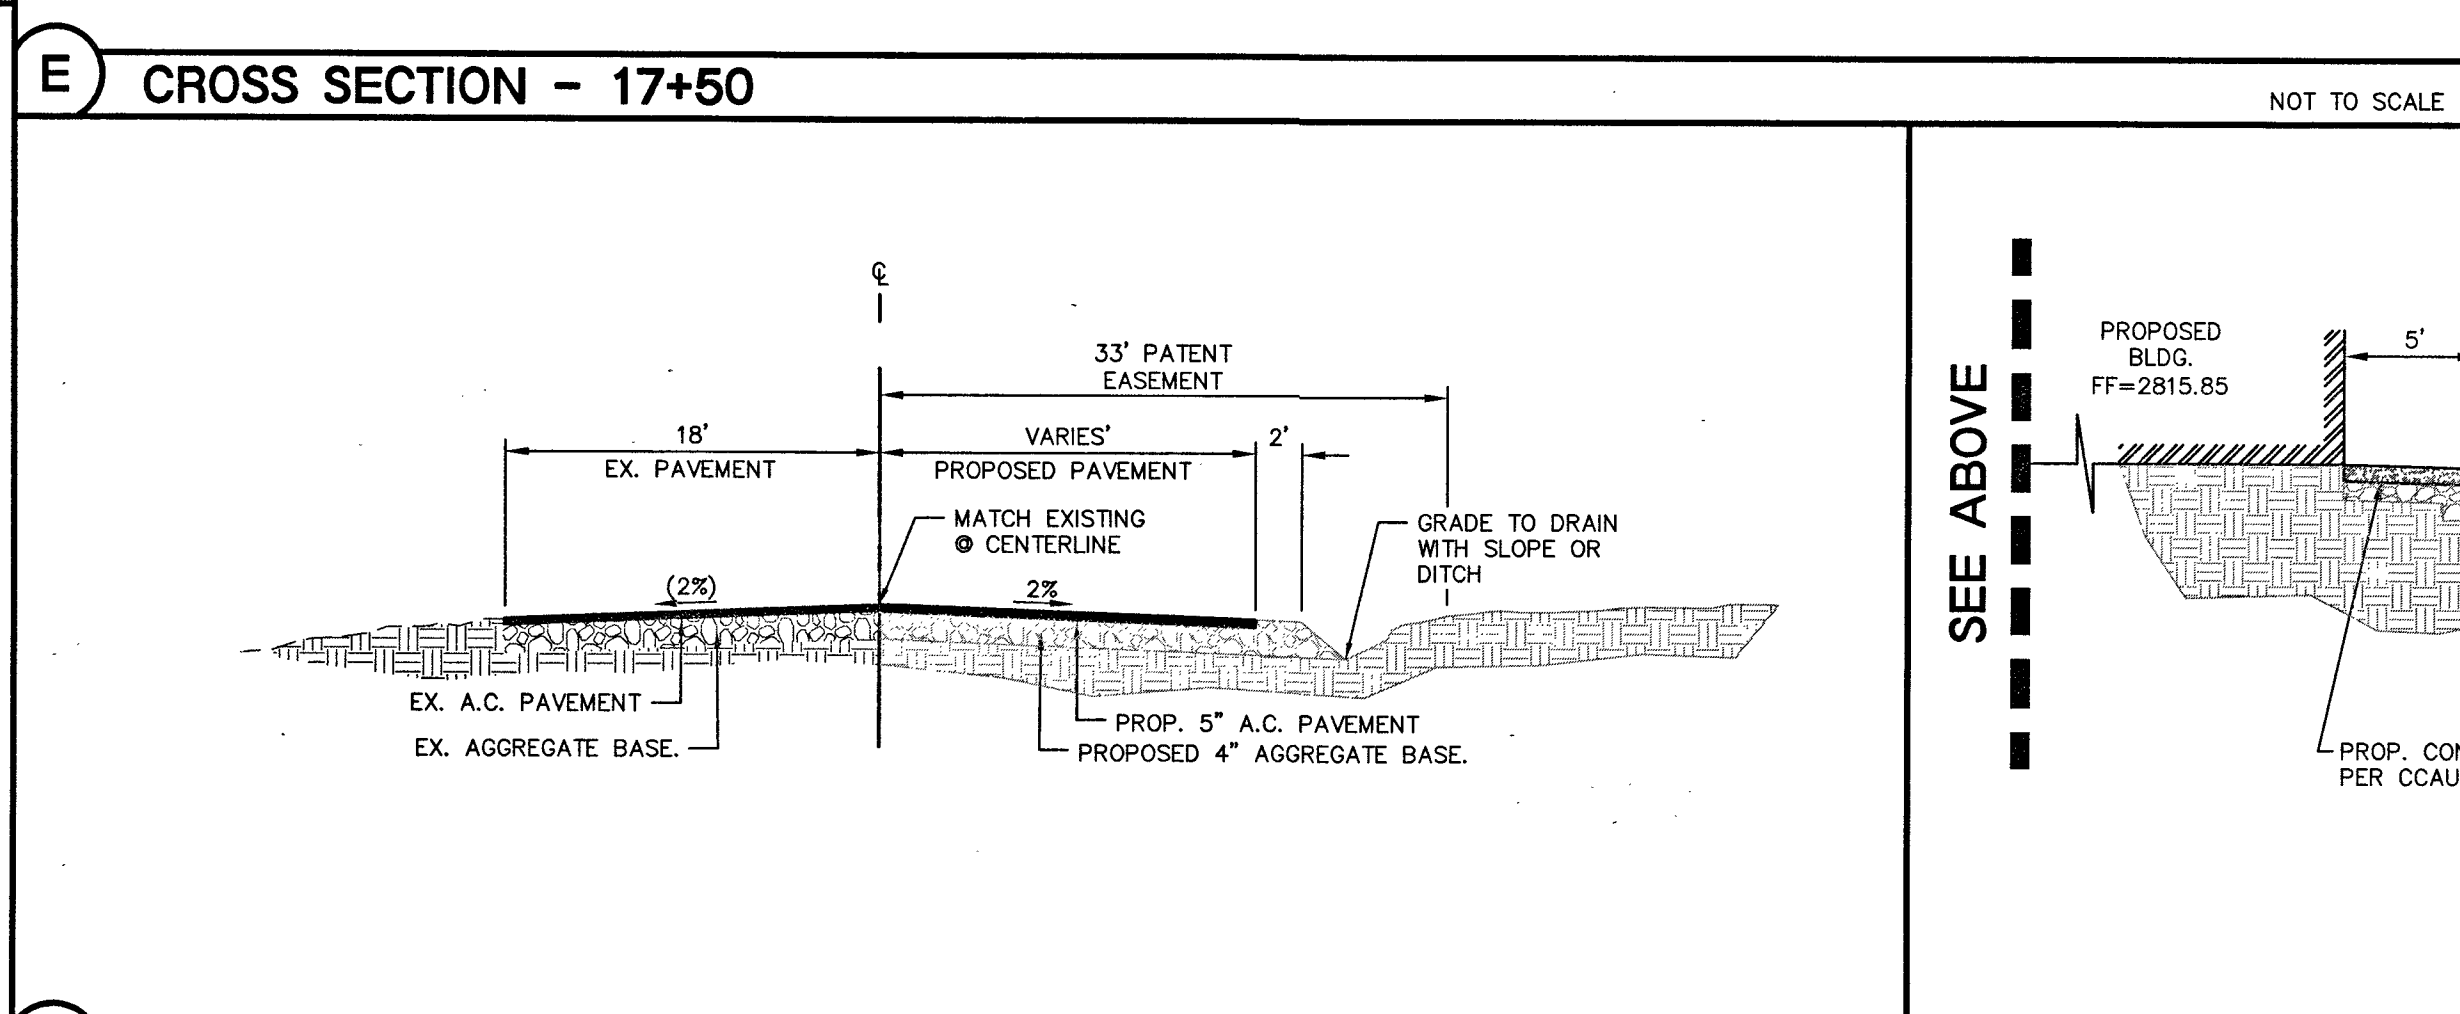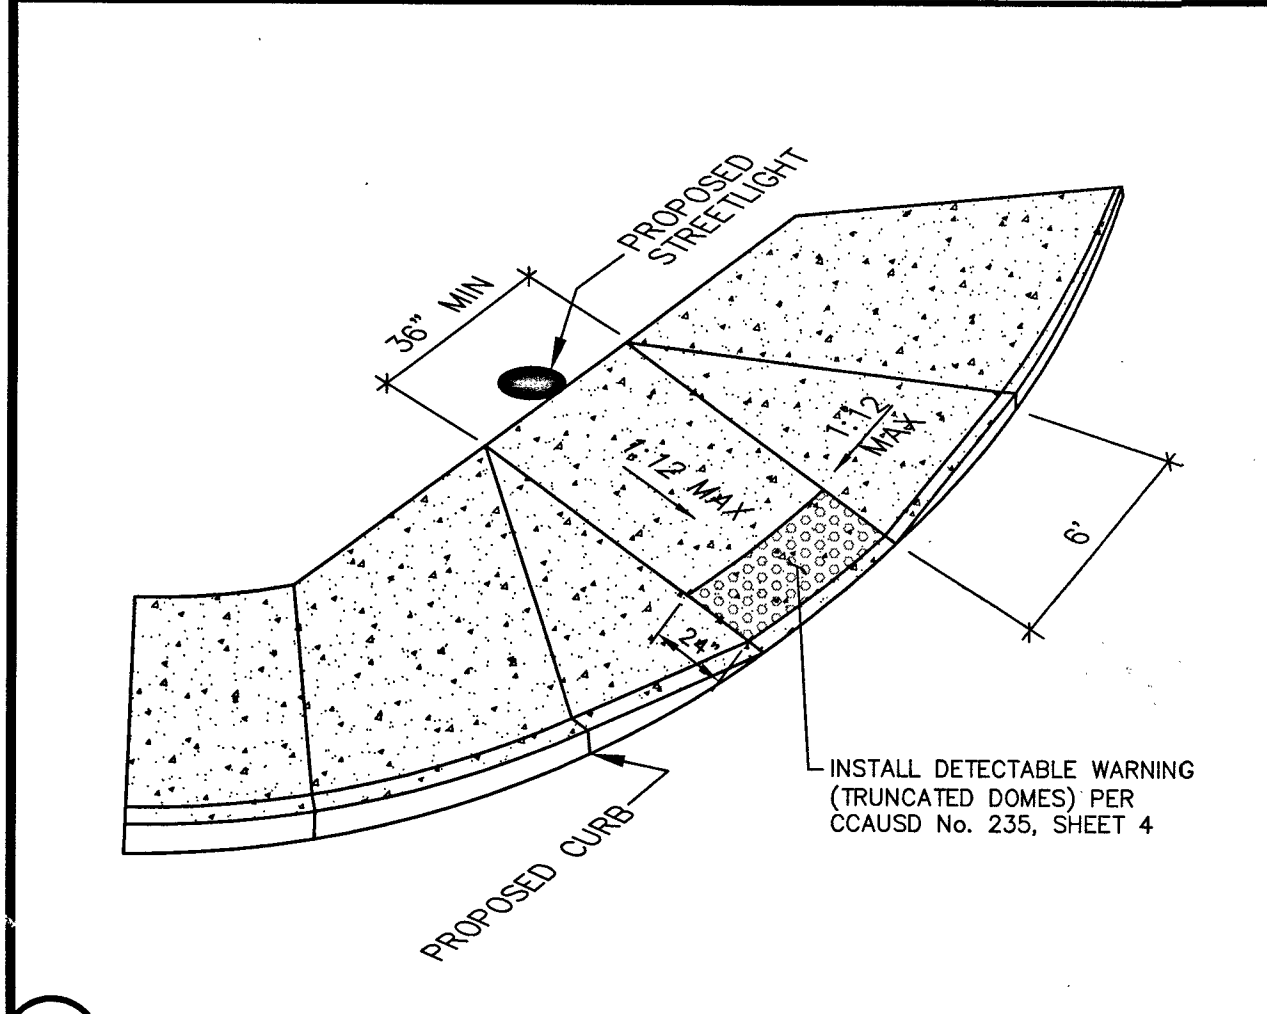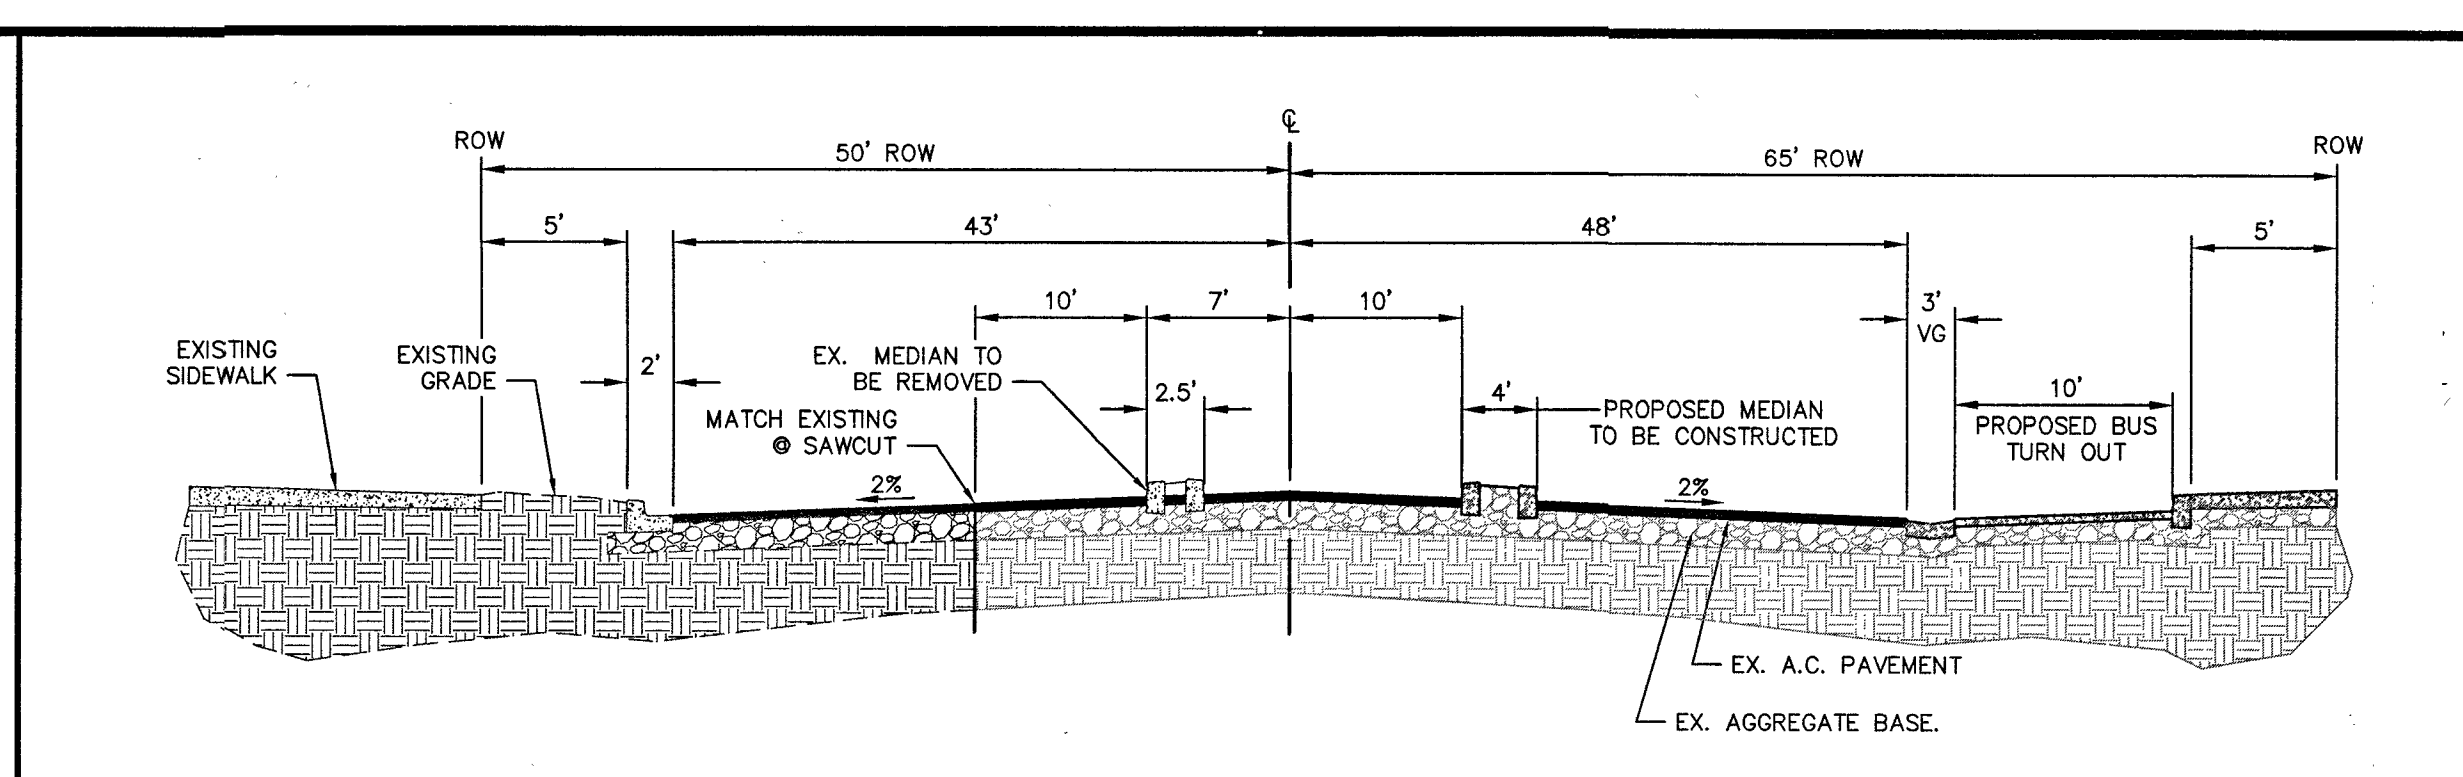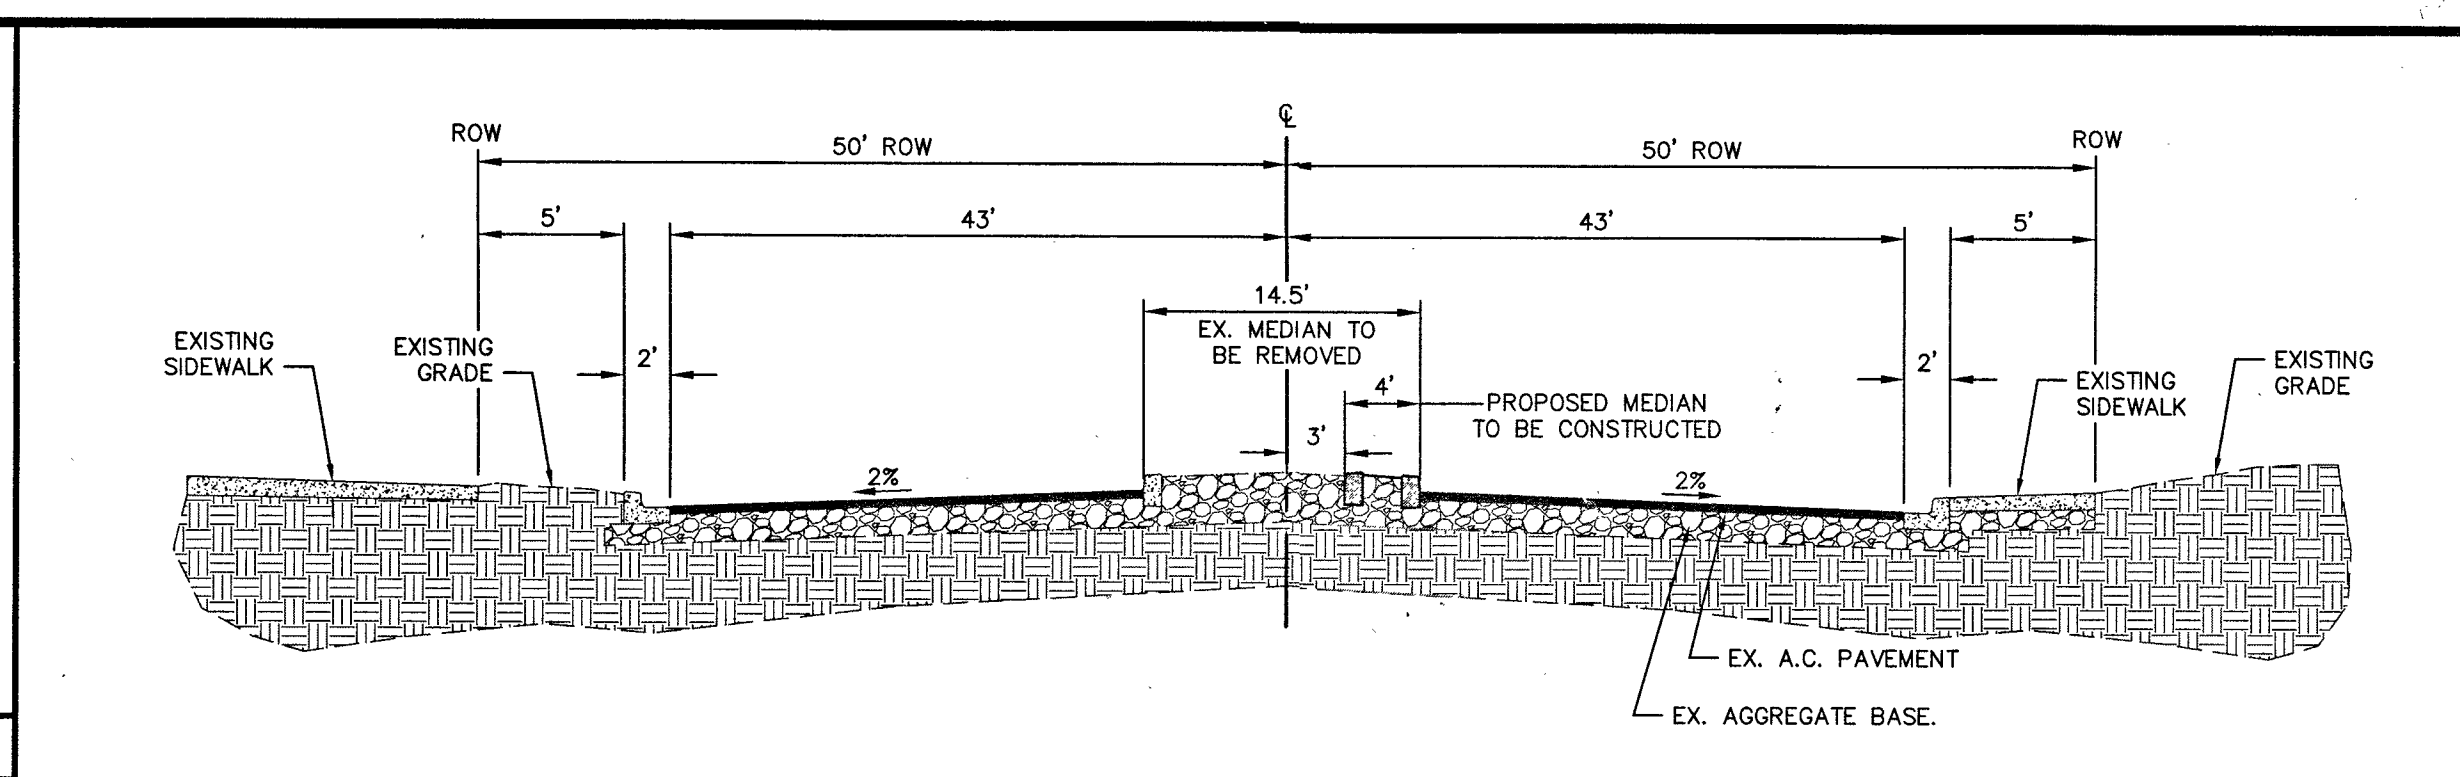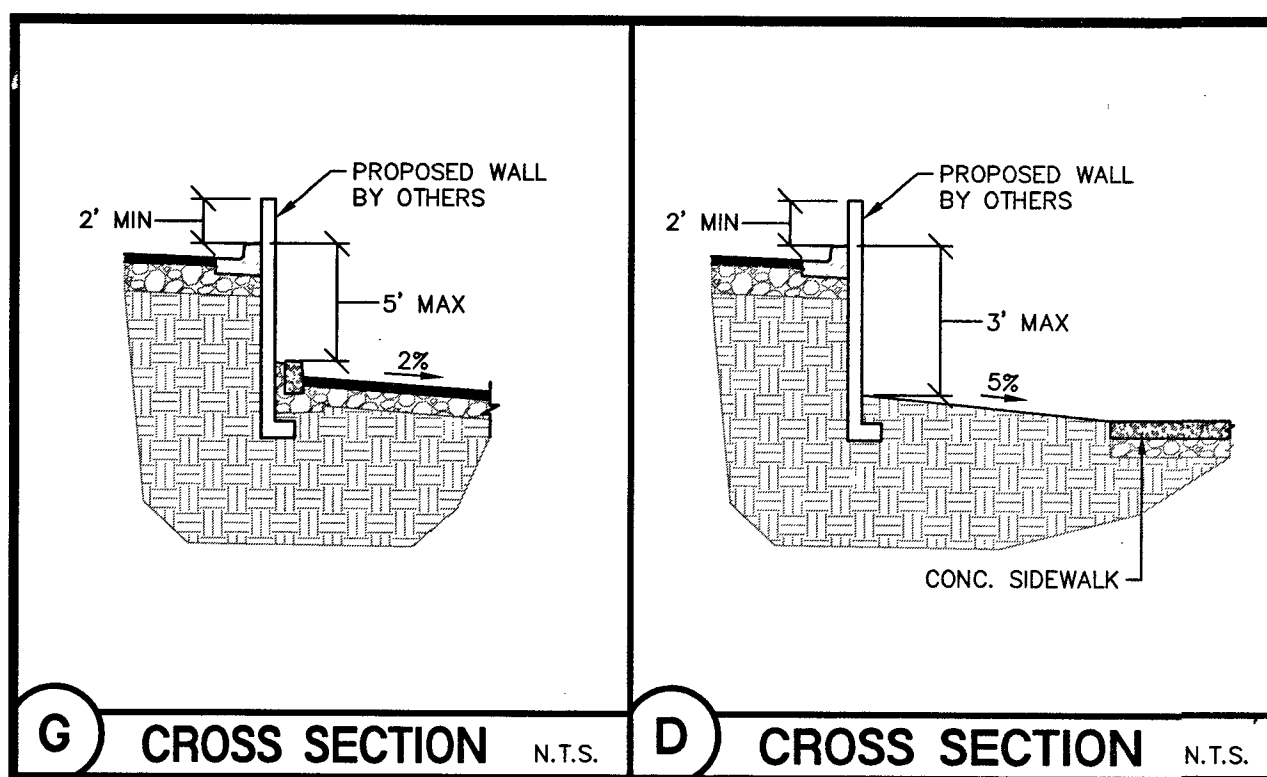

Lochsa Engineering

6945 South Jones Blvd.
Suite 100
Las Vegas, NV 89118
Phone (702) 365-5312
Fax (702) 365-5317
www.lochsa.com

DEER SPRINGS AND HUALAPAI CITY OF LAS VEGAS, NEVADA



DETAIL SHEETS SHEET 2 OF 2

PROJECT No.: 161109
DATE: 4/25/2017
SCALE: ---
DRAWN BY: MGZ
DESIGNED BY: MGZ
CHECKED BY: JLI

CLV No.: 10745060 **HTE No.:** 69418 **17-19758**

SHEET No.: C6.02 **14 OF 15**

5/24/2017

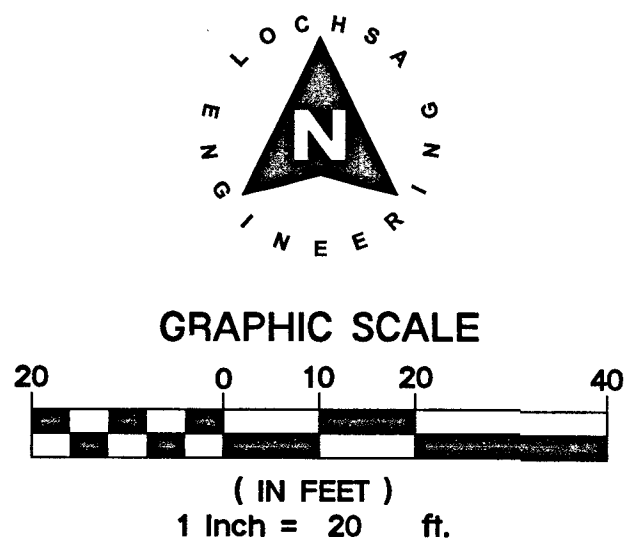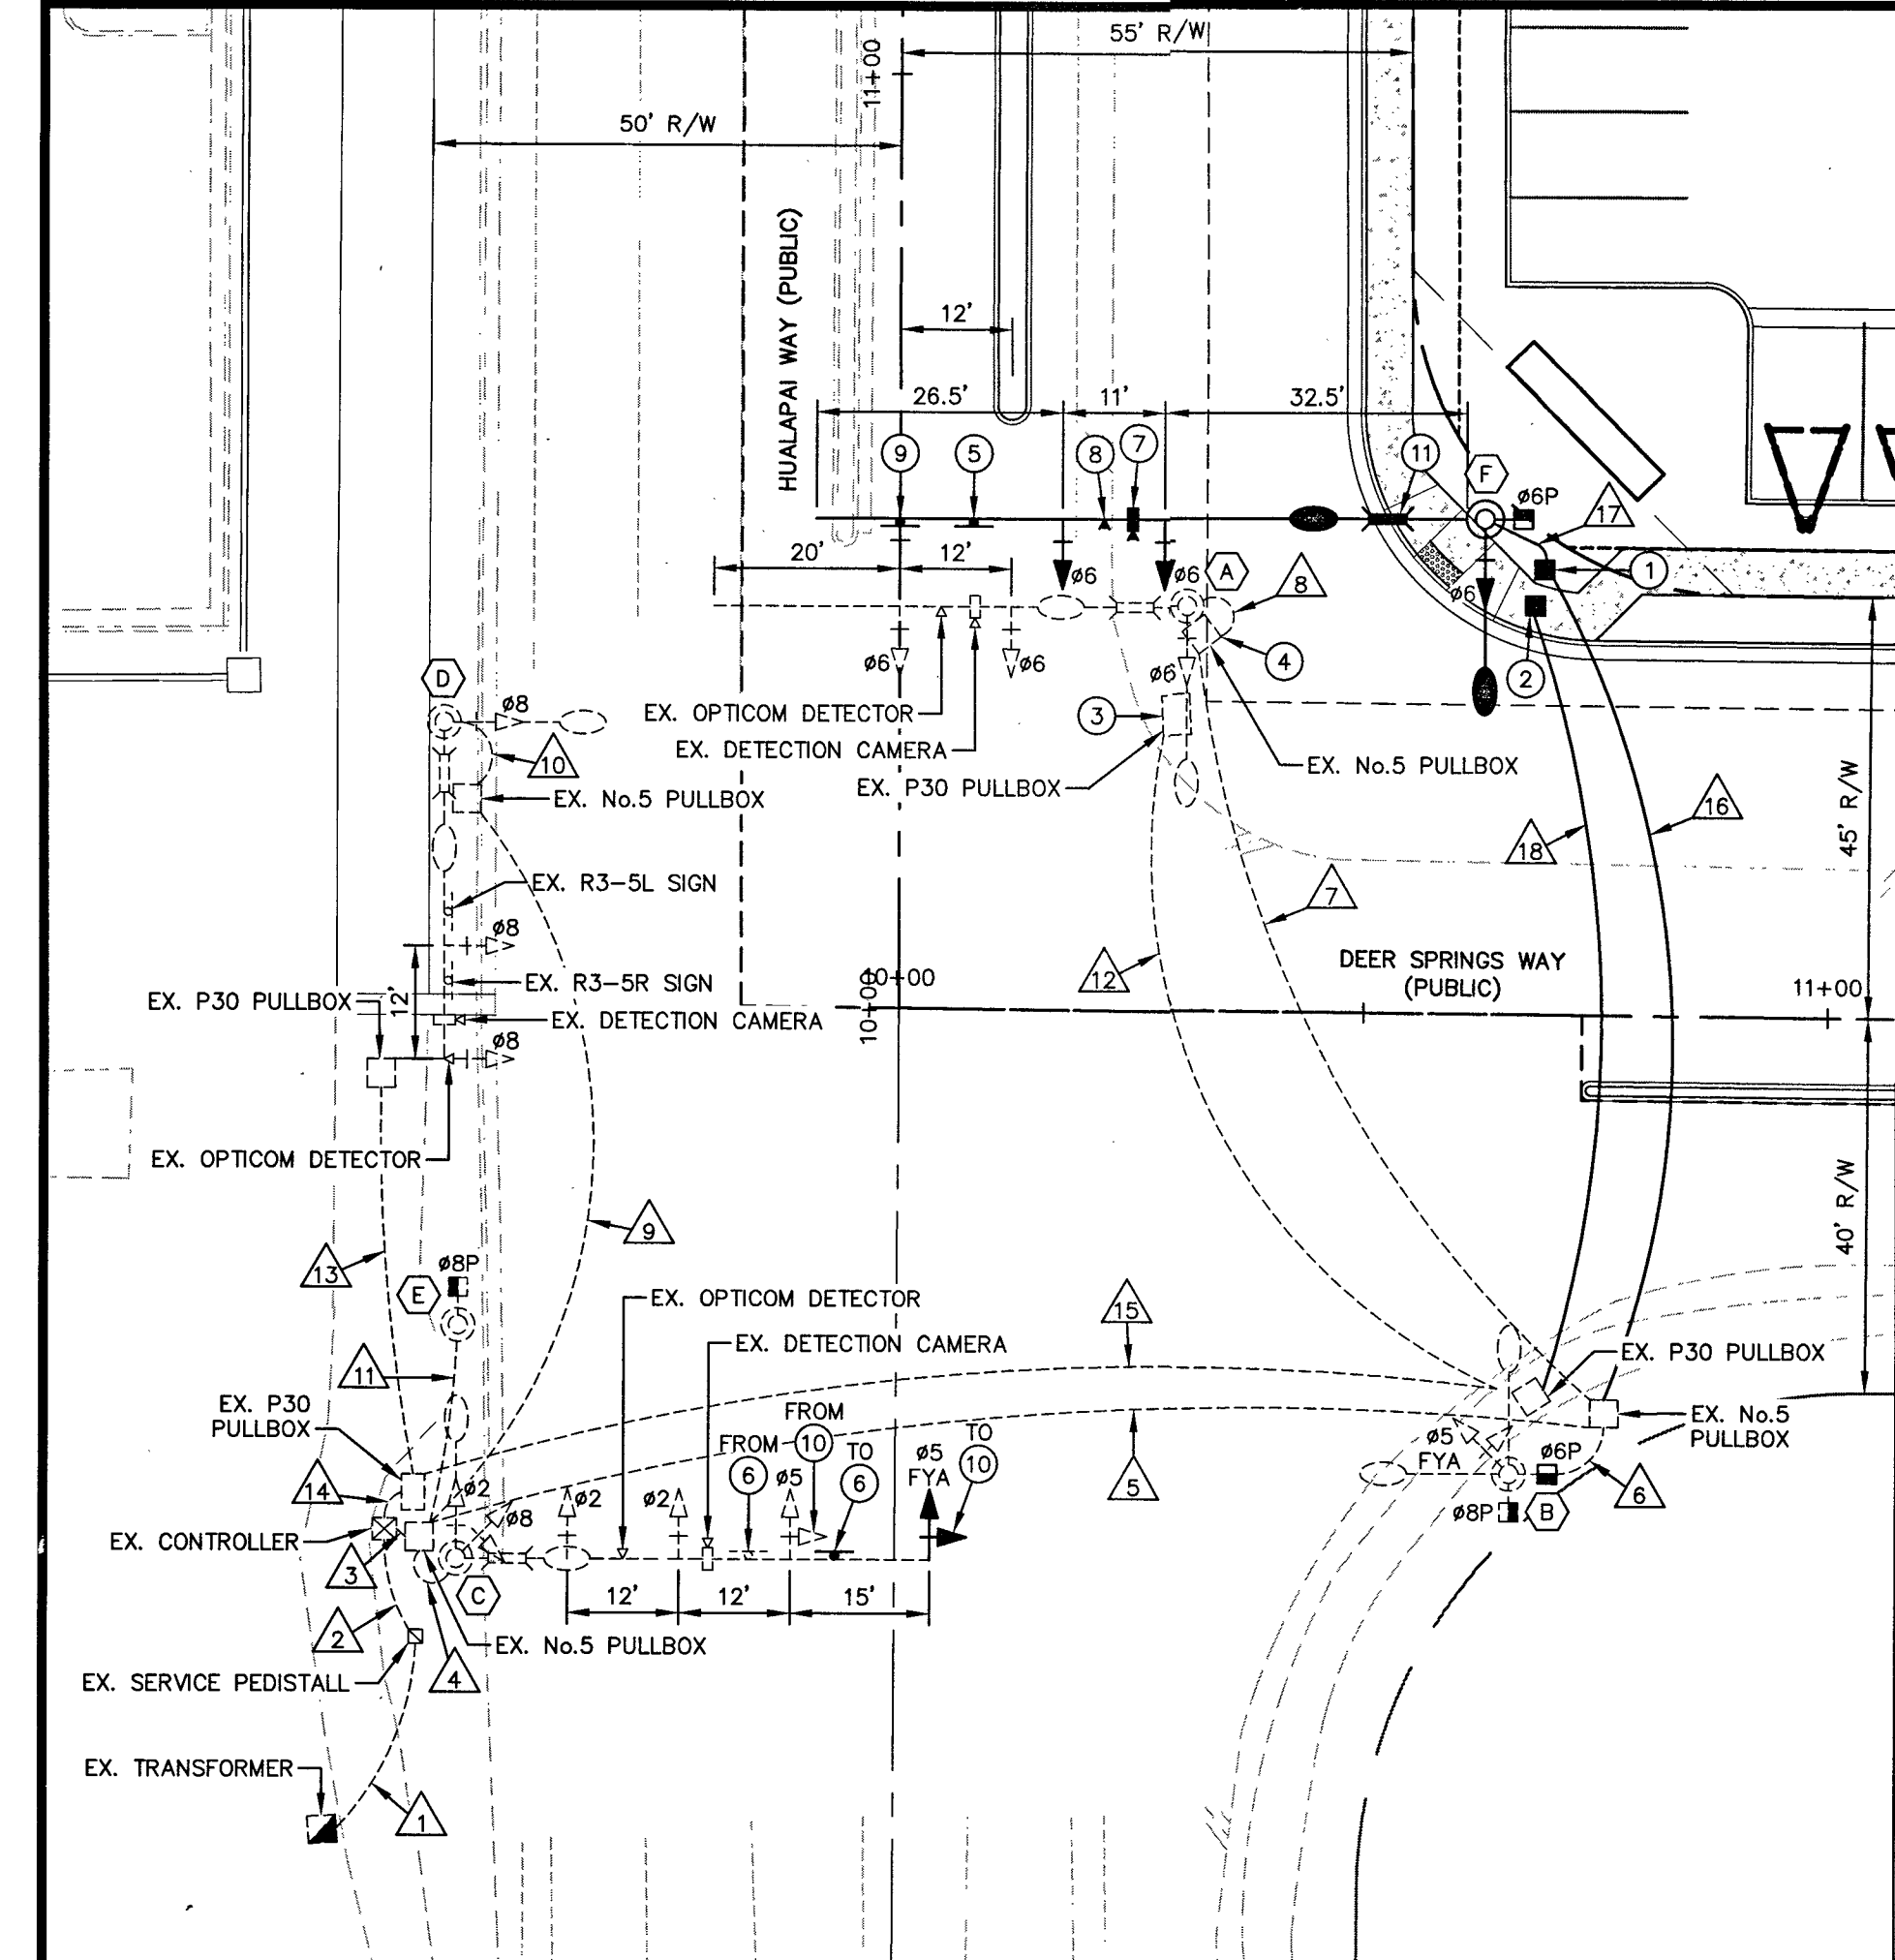

A.P.N.:
125-19-202-006

BASIS OF BEARINGS:
SOUTH 89°47'00" EAST, BEING THE BEARING OF THE SOUTH LINE OF THE SOUTHWEST QUARTER (SW 1/4) OF THE SOUTHWEST QUARTER (SW 1/4) OF SECTION 19, TOWNSHIP 19 SOUTH, RANGE 60 EAST, M.D.M. ALSO BEING THE CENTERLINE OF CENTENNIAL PARKWAY AS MEASURED BETWEEN HUALAPAI WAY AND CONQUISTADOR STREET AS SHOWN ON FILE 107, PAGE 31 OF SURVEYS IN THE RECORDER'S OFFICE, CLARK COUNTY, NEVADA.


BENCHMARK:
RIVET & PLATE IN TOP OF CURB AT THE SOUTHEAST CORNER OF THE BRIDGE OVER CLARK COUNTY HIGHWAY 215 ON HUALAPAI. ELEVATION = 853.317 (METERS) / 2799.59 (U.S. SURVEY FEET) NORTH AMERICAN VERTICAL DATUM OF 1988

PROPOSED POLE SCHEDULE

POLE	LOCATION STATION	POLE				SIGNALS (VEH.)		SIGNALS (PEDESTRIAN)		PED. PUSH BUTTON		REMARKS
		TYPE	QUAD	ARM	QUAD	TYPE	QUAD	TYPE	QUAD	QUAD	QUAD	
(A)	EXISTING	XX-A	EX	50'	EX	15'	(2)M-2	EX	-	-	-	EX. POLE TO BE REMOVED UPON ACTIVATION OF POLE F. RELOCATE ISNS TO POLE F.
(B)	EXISTING	XX	EX	-	EX	15'	(1)B1-4	EX	W-OT	EX	3	EX. POLE. REMOVE EX. W-OT PEDESTRIAN SIGNAL HEAD. REPLACE W/ W-3T PEDESTRIAN SIGNAL HEAD. INSTALL PEDESTRIAN PUSH BUTTON.
(C)	EXISTING	XX-A	EX	50'	EX	15'	(1)M-4	EX	-	-	-	EX. POLE. RELOCATE EXISTING M-4 SIGNAL HEAD.
(D)	EXISTING	XX-30	EX	35'	EX	15'	(2)M-2	EX	-	-	-	EX. POLE.
(E)	EXISTING	1-B	EX	-	-	-	-	-	W-OT	EX	EX	EX. POLE.
(F)	(HUALAPAI) 104+52.49 62.94 R	XX-B	EX	70'	3	15'	(2)M-2	MA	W-OT	1	4	NEW POLE. RELOCATED ISNS FROM POLE A.



CONDUIT AND WIRE SCHEDULE

WIRE & CONDUCTOR	FROM	TO	VIA CONDUIT	REMARKS
EXISTING WIRE	RS-19	SERVICE PEDESTAL	X	
EX(1)-#4 AWG THW	SERVICE PEDESTAL	CONTROLLER	X	
EX(1) 25 COND #14	CONTROLLER	POLE A	X	REMOVE EXISTING WIRE UPON ACTIVATION OF POLE F.
EX(4) #10 AWG THW	CONTROLLER	POLE B	X	
EX(1) #8 AWG THW	CONTROLLER	POLE C	X	
EX(1) #8 AWG THW	CONTROLLER	POLE D	X	
EX(1) 25 COND #14	CONTROLLER	POLE E	X	
EX(4) #10 AWG THW	CONTROLLER	EXISTING PULLBOX	X	
EX(1) #8 AWG THW	CONTROLLER	POLE LUMINAIRES	X	
EX(1) #8 AWG THW	CONTROLLER	POLE F	X	
EX(1) #8 AWG THW	CONTROLLER	FAST PULLBOX (NEC)	X	
EX(2) #4 AWG THW	CONTROLLER	POLE A LUMINAIRE	X	REMOVE EXISTING WIRE UPON ACTIVATION OF POLE F.
EX(1) #8 AWG THW	CONTROLLER	EXISTING PULLBOX	X	REMOVE EXISTING WIRE.

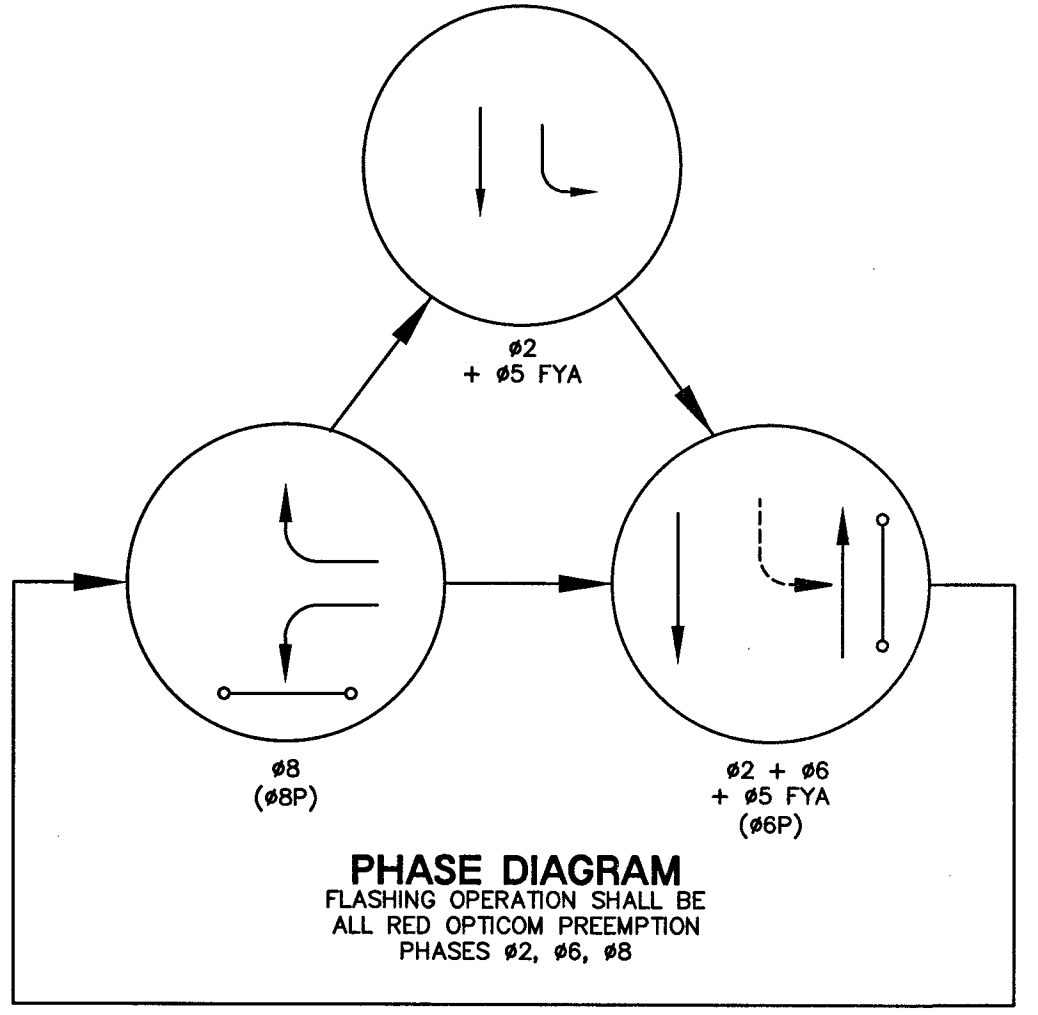

CITY OF LAS VEGAS
TRAFFIC SIGNAL NOTES (CIP):


- ALL WORK PERFORMED ON ANY TRAFFIC SIGNAL COMPONENT MUST BE UNDER THE DIRECT ON-SITE SUPERVISION OF AN IMSA CERTIFIED TECHNICIAN. THE LEVEL OF CERTIFICATION REQUIRED SHALL BE LEVEL II.
- THE CONTRACTOR SHALL BE RESPONSIBLE FOR DAMAGE TO ALL EXISTING UTILITIES. THE LOCATIONS OF UNDERGROUND UTILITIES AS SHOWN ON THE PLANS ARE APPROXIMATE ONLY. THE CONTRACTOR SHALL NOTIFY ALL UTILITY COMPANIES TO VERIFY IN THE FIELD THE LOCATIONS OF THEIR INSTALLATIONS 72 HOURS PRIOR TO CONSTRUCTION.
CALL-BEFORE-YOU-OVERHEAD 1-702-227-2929
CALL-BEFORE-YOU-DIG 1-800-227-2600
1-702-229-3331
1-702-432-5300 F.A.S.T.
- ALL TRAFFIC SIGNAL INSTALLATIONS SHALL CONFORM TO THE UNIFORM STANDARD DRAWINGS SPECIFICATIONS AND SPECIAL PROVISIONS FOR PUBLIC WORKS' CONSTRUCTION OFF-SITE IMPROVEMENTS, CLARK COUNTY AREA, NEVADA, VOLUMES I AND II, ADOPTED BY THE REGIONAL TRANSPORTATION COMMISSION APRIL 8, 1992 WITH ALL SUBSEQUENT REVISIONS. BRACKET MOUNTED (SIDE-MOUNTED) VEHICLE SIGNAL ASSEMBLIES WITH 2 OR MORE SIGNAL HEADS SHALL HAVE AN ADDITIONAL ELBOW AS SHOWN IN UNIFORM STANDARD DRAWING NUMBER 863 AND SHOWN AS OPTION B IN UNIFORM STANDARD DRAWING NUMBER 844, AND SHALL HAVE A WENERALLA-C SUPPORT AS SHOWN IN UNIFORM STANDARD DRAWING NUMBER 863 IF ONE OF THE SIGNAL HEADS CONTAINS 4 OR MORE SIGNAL MODULES.
- SERVICE SHALL HAVE 1-60 AMP SINGLE POLE BREAKER FOR SIGNAL AND ONE 40 AMP SINGLE POLE BREAKERS FOR STREET LIGHTS. SERVICE SHALL BE 200 AMP PADMOUNT.
- LINE SIDE OF METER TO BE WIRED WITH THREE #3/0 AWG THW. LOAD SIDE SHALL BE WIRED WITH FOUR #4 AWG THW (2 BLACK, 2 WHITE) AND ONE #6 AWG THW (GREEN).
- LUMINAIRES ON ALL SIGNAL POLES SHALL BE AN APPROVED LED EQUAL TO A 400 WATT HIGH PRESSURE SODIUM CUTOFF (G.E. M400A) WITH MC-111 DISTRIBUTION PER SECTION 623.1.02.19 OF THE SPECIAL PROVISIONS. EACH LUMINAIRE SHALL HAVE AN INDIVIDUAL 1000 WATT P.E. FOR LUMINAIRES. FOR SIGNALS WITH THE #4 AWG THW CONDUCTORS FROM THE SERVICE TO THE CABINET, IN THE CABINET, THE #4 AWG THW CONDUCTORS SHALL BRANCH OFF INTO #10 AWG THW CONDUCTORS INDIVIDUALLY FUSED WITH 10 AMP FUSES. THERE SHALL BE NO SPLICES BETWEEN THE CABINET AND LUMINAIRE FIXTURES.
- THE INTERNALLY ILLUMINATED STREET NAME SIGNS SHALL BE WIRED TO THE LUMINAIRES PHOTO CELL FOR CONTROL WITH #10 AWG THW COPPER STRANDED WIRE (TYPICAL). THE SIGN SHALL BE WIRED TO THE LUMINAIRE DIRECTLY ABOVE IT. IN THE EVENT THERE IS NO LUMINAIRE ON THE TRAFFIC SIGNAL POLE, THE 1000 WATT P.E. CONTROL SHALL BE MOUNTED ON THE POLE CAP. ALL NEW ILLUMINATED STREET NAME SIGNS SHALL HAVE LIGHT EMITTING DIODE (LED) LAMPS PER SECTION 623.1.02.16 OF THE SPECIAL PROVISIONS.
- CHECK CONDUIT AND CABLE SCHEDULE FOR CONDUIT, CABLE, AND WIRE SIZE. VERIFY ALL EXISTING CONDUIT RUNS.
- ALL PULLBOXES SHALL BE IN ACCORDANCE WITH UNIFORM STANDARD DRAWINGS NO. 705, NO. 706, AND NO. 707.
- TRAFFIC SIGNAL CABLE SHALL BE 15 OR 25 CONDUCTOR #14 AWG SOLID (TYPICAL) CABLE AND SHALL CONFORM TO IMSA SPEC. NO. 20-1.
- PEDESTRIAN PUSH BUTTONS SHALL BE AUDIBLE TACTILE "POLARA NAVIGATOR" TYPE (2 WIRE SYSTEM) OR CAMPBELL COMPANY ADVANCED ACCESSIBLE PEDESTRIAN SYSTEM BUTTONS WITH AAPS APC (CONTROLLER) IN ACCORDANCE WITH CITY OF LAS VEGAS SPECIAL PROVISIONS SECTION 623 OF THE CCA USS. PUSH BUTTON SIGNS SHALL BE R10-3E PER MUTCD, 2009 EDITION, WITH FULL MOUNTING BRACKETS, AS MODIFIED BY THE MANUFACTURER TO FIT ON A 9'X12' SIGN, AND SHALL BE PORCELAIN-ENAMELED METAL ALL PUSH BUTTONS TO BE MOUNTED 42" ABOVE SIDEWALK. THE MAXIMUM HORIZONTAL REACH DISTANCE IS TO BE 10". SIDEWALK RAMPS WILL BE ACCORDING TO U.S. NO. 235 (1-4) LATEST EDITION. WHEN AN EXISTING SIGNAL WITH EXISTING AUDIBLE-TACTILE PUSH BUTTONS IS MODIFIED, THE CONTRACTOR SHALL VERIFY NEW PEDESTRIAN PUSH BUTTONS OR CABINET EQUIPMENT MATCHES THE MANUFACTURE AND MODEL OF ANY EXISTING EQUIPMENT SCHEDULED TO REMAIN, TO PROVIDE A FULLY FUNCTIONING SYSTEM. THE CONTRACTOR SHALL PROVIDE AND INSTALL ALL CABINET EQUIPMENT, INCLUDING THE PEDESTRIAN PUSH BUTTON CONTROL UNIT, INTERFACE PANEL AND ANY REQUIRED HARNESSES, TO PROVIDE A FULLY FUNCTIONING SYSTEM.
- THE ROUTING AND TERMINATION OF CONDUITS AND THE PLACING OF POLES AND CABINETS SHALL BE AS INDICATED ON THE PLANS. ALL CHANGES SHALL BE APPROVED BY THE ENGINEER.
- MAST ARM R10-12 SIGNS TO BE ADJACENT (NO GAP) TO THE M-5 SIGNAL HEAD. WHERE FLASHING YELLOW ARROW LEFT TURN SIGNALS ARE USED, A MAST ARM R10-12F LEFT TURN YIELD ON FLASHING YELLOW ARROW SIGN SHALL BE MOUNTED ADJACENT TO THE M-4 SIGNAL HEAD.
- TRAFFIC SIGNAL CABINET SHALL BE A TYPE VII CABINET UNLESS OTHERWISE SPECIFIED IN THE PLANS. THIS IS COMMONLY REFERRED TO AS AN "R" CABINET. THE CABINET SHALL CONFORM TO THE CLARK COUNTY AREA UNIFORM STANDARD DRAWINGS AND SPECIFICATIONS AND THE CITY OF LAS VEGAS SPECIAL PROVISIONS. INSTALL CABINET NEAR THE R.O.W. LINE OR AS SHOWN ON THE DRAWINGS. THE TRAFFIC SIGNAL CONTROLLER CABINET SHALL BE EQUIPPED WITH 16 LOAD BAY POSITIONS. SHALL BE A 48 DETECTOR CHANNEL R CABINET AND SHALL INCLUDE TWO (2) RACK-MOUNTED, 12 SLOT, LOOP DETECTION RACKS, WITH 2 DETECTOR LOOP CHANNELS PER SLOT FULLY WIRED SO THAT ALL CHANNELS ARE USABLE AND 4 CHANNEL SLOTS THAT CAN ACCOMMODATE VIDEO DETECTION CARDS. THE CABINET SHALL CONTAIN A 764 OPTICOM PHASE SELECTOR IN A 760 RACK, WITH A 768 AUXILIARY INTERFACE PANEL MOUNTED IN THE CABINET AND FULLY WIRED FOR GREEN SEEN CAPABILITIES.
- THE CONTRACTOR SHALL SUPPLY A MALFUNCTION MANAGEMENT UNIT (MMU) AND TRAFFIC SIGNAL CONTROLLER TO THE CITY OF LAS VEGAS TRAFFIC SIGNAL REPAIR SHOP A MINIMUM OF FOURTEEN DAYS PRIOR TO SIGNAL TURN-ON OR PRIOR TO CONVERTING TO A NEW PHASING SCHEME, FOR TESTING AND PROGRAMMING PURPOSES. THE CONTROLLER SHALL BE A NAZTEC 980 ATC T52 TYPE 2 NTOP COMPLIANT SIGNAL CONTROLLER WITH INSTALLED AND LICENSED APOGEE CONTROLLER SOFTWARE, LATEST VERSION, AND THE MMU SHALL BE A MODEL MMU-1600GSE AS MANUFACTURED BY RENO A&E, OR APPROVED EQUAL, THE CONTRACTOR SHALL DELIVER THE CONTROLLER AND MMU TO, AND PICKUP THE CONTROLLER AT 2824 E. CHARLESTON BOULEVARD. CONTRACTOR SHALL NOTIFY THE TRAFFIC SIGNAL REPAIR SHOP (229-6078) SEVEN DAYS PRIOR TO PICKUP THE CITY AT ITS DISCRETION. MAY PROVIDE A DIFFERENT MODEL OF MMU OR CONTROLLER FOR INITIAL TURN-ON, IN WHICH CASE CITY PERSONNEL WILL SWAP THE CONTROLLER OR MMU AFTER THE PROJECT IS ACCEPTED.
- CONTRACTOR SHALL POTHOLE SIGNAL POLE LOCATIONS PRIOR TO ORDERING OF POLES.
- ALL MAST ARMS TO BE HOT-DIP GALVANIZED BY THE MANUFACTURER THE MAST ARM IS TO BE FABRICATED WITH END TENON ONLY. THE END TENON SHALL BE FACTORY INSTALLED AND THE REMAINING TENONS SHALL BE FABRICATED IN THE FIELD AT THE LOCATION SHOWN ON THE PLANS OR AS DIRECTED BY THE TRAFFIC ENGINEER AND/OR HIS AUTHORIZED REPRESENTATIVE. FOR TENON FABRICATION DETAILS SEE CLARK COUNTY AREA U.S.D. NO. 808 SHEET 2. ALL WELDING SHALL CONFORM TO AWS D 2.0. "SPECIFICATION FOR WELDED HIGHWAYS AND RAILWAY BRIDGES," AND TO ANY ADDITIONAL REQUIREMENTS OF SECTION 623 OF THE SPECIFICATIONS. ALL EXPOSED WELDS, SHALL BE PAINTED AS PROVIDED FOR REPAIRING DAMAGED GALVANIZED SURFACES.
- ALL VEHICLE AND PEDESTRIAN SIGNAL INDICATIONS SHALL HAVE LIGHT EMITTING DIODE (LED) TYPE INDICATIONS, IN CONFORMANCE TO CITY OF LAS VEGAS SPECIAL PROVISIONS AND TO SECTION 623 OF THE CCA USS. ALL PEDESTRIAN SIGNAL PHASES SHALL PROVIDE "WALKING PERSON," "HAND," AND "COUNTDOWN" MESSAGES AS PROVIDED BY DURALIGHT MODEL #JXM-400-VEIL OR DIALIGHT MODEL #430-6479-001X, OR APPROVED EQUAL, THE "COUNTDOWN" MESSAGE SHALL NOT FLASH. WHERE EXISTING SIGNALS ARE MODIFIED, THE CONTRACTOR SHALL VERIFY THAT LED PEDESTRIAN INDICATIONS FOR A SPECIFIC PHASE ARE OF THE SAME MANUFACTURE SO THAT THEY FUNCTION CORRECTLY, OR SHALL REPLACE ALL COUNTDOWN PEDESTRIAN INDICATIONS FOR THAT PHASE.
- VIDEO DETECTION SYSTEMS WILL BE EITHER ITERS EDGE 2 WITH EDGECONNECT PAK, (IP ADDRESSABLE); PEEK VIDEOTRAK IQ (WITH ETHERNET PORT); OR TRAFICON VIP WITH VEWCOM (IP ADDRESSABLE). WHEN VIDEO DETECTION IS SPECIFIED ON THE SIGNAL PLANS, ALL VIDEO DETECTION SYSTEMS WILL BE STAND ALONE SYSTEMS TO INCLUDE ALL NECESSARY EQUIPMENT TO PROGRAM THE VIDEO DETECTION SYSTEM. A PROGRAMMING "MOUSE", KEYPAD OR LAPTOP COMPUTER (IF REQUIRED FOR PROGRAMMING THE VIDEO DETECTION SYSTEM) AND APPROPRIATE SOFTWARE WILL BE SUPPLIED WITH EACH VIDEO SYSTEM. PERSONAL COMPUTERS (PCS) MAY NOT BE SUBSTITUTED FOR LAPTOPS. A VIDEO MONITOR (COLOR FLAT SCREEN) 9" TO 13" WILL BE SUPPLIED WITH EACH VIDEO DETECTION SYSTEM. EACH VIDEO CAMERA WILL HAVE POWER AND VIDEO CABLE DIRECTLY FROM THE CABINET. COAXIAL CABLE WILL BE TYPE 8281 (SOLID CENTER CONDUCTOR). CAMERAS THAT USE A PRE-ABRICATED CABLE INTEGRATING POWER AND COAXIAL CABLE INTO A SINGLE WEATHERPROOF CONNECTOR ARE ACCEPTABLE. "BNC" ARE THE ONLY ACCEPTABLE TERMINATION OF COAXIAL CABLES. CAMERAS WILL BE MOUNTED PER MANUFACTURER'S RECOMMENDATIONS AND PER CLV TRAFFIC ENGINEER APPROVAL. VIDEO CAMERAS SHALL BE TYPE 8281 AND SHALL BE MOUNTED ON A MINIMUM 4 FOOT REBAR IN THE SIGNAL MAST ARM WITH EXTENSION BRACKETS (COLOR AS-BUILT-6-62 OR EQUIVALENT), THE LOCATION OF THE CAMERA ON THE MAST ARM SHALL BE APPROVED BY THE TRAFFIC SIGNAL SUPERVISOR. A VIDEO FILTER (CX06-BNYC OR EQUIVALENT) WILL BE INSTALLED IN THE SIGNAL CABINET FOR EACH CAMERA VIDEO INPUT. VIDEO DETECTION PROCESSORS AND COMMUNICATIONS CARDS SHALL BE PROVIDED WITH THE LATEST VERSIONS OF THE MANUFACTURER'S SOFTWARE. THE CONTRACTOR SHALL AM CAMERAS AND PROGRAM AND CONFIGURE THE VIDEO DETECTION PROCESSORS TO PROVIDE A FULLY FUNCTIONING SYSTEM.
- WHERE NEW LOOPS WILL BE OVERLAPED WITH NEW PAVEMENT, LOOP DETECTORS SHALL BE PREFORMED LOOPS AS MANUFACTURED BY RENO A & E OR NEVER-FAIL LOOP SYSTEMS, AND ALL LOOPS SHALL BE INSTALLED IN THE ROADWAY PRIOR TO PLACEMENT OF THE FINAL PAVEMENT LIFT. WHERE NEW LOOPS ARE INSTALLED THAT ARE NOT OVERLAPED WITH NEW PAVEMENT, LOOPS SHALL BE CABLE-IN-DUCT PER SECTION 623.1.02.04.C OF THE CITY OF LAS VEGAS SPECIAL PROVISIONS. LOOP LEAD-IN CABLE SHALL BE 6-PAIR 16 AWG MULTIPLE CONDUCTOR CABLE AS SPECIFIED IN SECTION 623T.02.04 OF THE CLV SPECIAL PROVISIONS. ALL WIRING HARNESSES, RACK POSITIONS, AND LOOP LEAD-IN CABLE SHALL BE CLEARLY MARKED AS TO THE APPROPRIATE PHASE AND LETTER DESIGNATION TO WHICH IT BELONGS AS SHOWN ON THE TRAFFIC SIGNAL PLANS. LOOPS SHALL BE LOCATED AS SHOWN ON THE TRAFFIC SIGNAL PLANS AND APPROVED BY THE CLV TRAFFIC ENGINEERING DIVISION PRIOR TO INSTALLATION. REFER TO SECTION 623T.02.04 OF THE CLV SPECIAL PROVISIONS FOR ADDITIONAL REQUIREMENTS.
- OPTICAL PREEMPTION UNITS WILL BE GLOBAL TRAFFIC TECHNOLOGIES (ENCODING CAPABLE), MODEL 764 OPTICOM PHASE SELECTOR INSTALLED IN A MODEL 760 RACK WITH A MODEL 768 AUXILIARY INTERFACE PANEL (AIP) MOUNTED IN THE CABINET AND FULLY WIRED FOR GREEN SEEN CAP-BLITES. OPTICAL SENSORS WILL BE MODEL 721 WITH ONE DETECTOR PER DIRECTION UNLESS SHOWN OTHERWISE IN THE PLANS, AND WILL BE INTERFACED TO THE TRAFFIC SIGNAL CONTROLLER CABINET WITH M-138 CABLE. THE SOUTH-SOUND OPTICOM DETECTOR SHALL BE WIRED TO INPUT PREEMPTIONS ON CHANNEL 1 IN THE PHASE SELECTOR EASTBOUND ON CHANNEL 2, NORTHBOUND ON CHANNEL 3, AND WESTBOUND ON CHANNEL 4, UNLESS VARIATIONS ARE APPROVED BY THE TRAFFIC SIGNAL SUPERVISOR. WHEN 764 PHASE SELECTORS ARE ADDED TO A CABINET WITHOUT A 768 AIP, THE CONTRACTOR SHALL INSTALL AND WIRE A NEW 766 AIP.
- IF THE IMPROVEMENTS NECESSITATE THE OBLITERATION, TEMPORARY CONSTRUCTION, TEMPORARY REMOVAL, OR RELOCATION OF ANY EXISTING TRAFFIC PAVEMENT MARKING, SUCH PAVEMENT MARKING SHALL BE RESTORED OR REPLACED AT THE CONTRACTORS EXPENSE TO THE SATISFACTION OF THE CITY.
- INTERCONNECT CABLE SHALL BE AS SHOWN IN THE WIRE SCHEDULE.
- THE CONTRACTOR SHALL INSTALL CROSSWALKS, STOP BARS, STRIPING AND SIGNS AS IDENTIFIED ON THE PLANS.
- WHERE THE PLANS CALL FOR REMOVAL AND SALVAGE OF EXISTING TRAFFIC SIGNAL EQUIPMENT, THE CONTRACTOR SHALL CONTACT KARL KELLEY, THE TRAFFIC SIGNAL SUPERVISOR, AT 702-229-4086 TO ARRANGE FOR DELIVERY TIMES AND LOCATIONS.
- THE CONTRACTOR SHALL MAINTAIN EXISTING SIGNALS THROUGH THE LIFE OF THE PROJECT PER SECTION 623 G.03.01N OF THE CLV SPECIAL PROVISIONS.

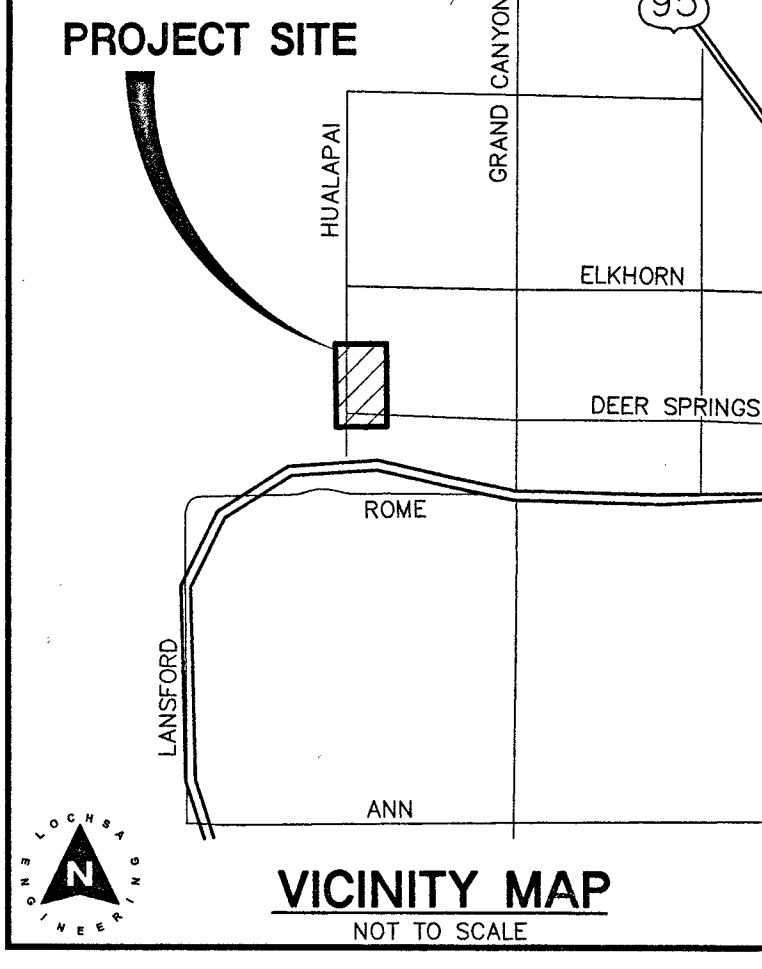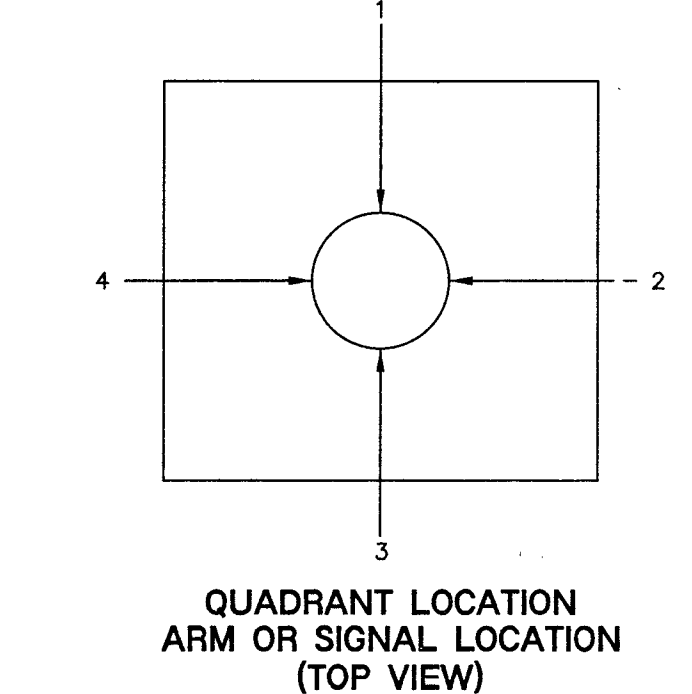

NOTE:
REFER TO SHEET C5.01 FOR SIGNAGE/STRIPING PLAN

TRAFFIC CONSTRUCTION NOTES:

- ALL CONSTRUCTION TO BE DONE IN ACCORDANCE WITH "CLARK COUNTY AREA UNIFORM STANDARD DRAWINGS (CAUSD)" LATEST EDITION.
- 1. INSTALL NO. 5 PULLBOX PER CAUSD NO. 706.
- 2. INSTALL P30 PULLBOX PER CAUSD NO. 761.
- 3. REMOVE EXISTING P30 PULLBOX.
- 4. REMOVE EXISTING NO. 5 PULLBOX UPON POLE F ACTIVATION.
- 5. INSTALL R3-4 SIGN (36"x36").
- 6. RELOCATE R10-12F SIGN PER CAUSD 857 (30"x36").
- 7. INSTALL DETECTION CAMERA.
- 8. INSTALL OPTICOM DETECTOR
- 9. INSTALL R3-2 SIGN (36"x36")
- 10. INSTALL TENON ON MASTER ARM. RELOCATE M-4 SIGNAL
- 11. RELOCATE EXISTING ILLUMINATED STREET NAME SIGN FROM POLE A TO POLE F.

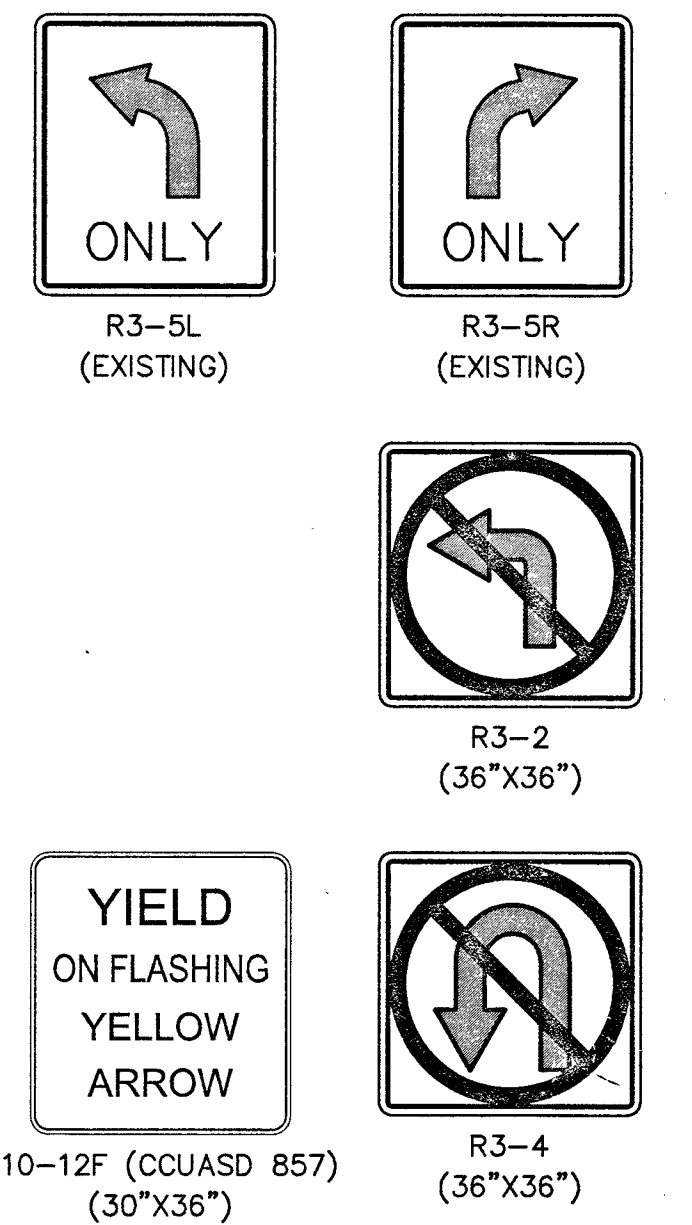

NOTE:
LOCHSA ENGINEERING ASSUMES NO RESPONSIBILITY FOR EXISTING UTILITY LOCATIONS AND ELEVATIONS. THE UTILITIES SHOWN ON THIS PLAN ARE FROM THE BEST AVAILABLE INFORMATION. IT IS THE CONTRACTOR'S RESPONSIBILITY TO FIELD VERIFY THE LOCATION AND ELEVATION OF ALL UTILITIES, INCLUDING BUT NOT LIMITED TO, THE WATER, FIRE, SANITARY, SEWER, STORM SEWER, TELEPHONE, POWER, GAS, AND IRRIGATION LINES PRIOR TO THE COMMENCEMENT OF CONSTRUCTION. IF CONFLICT EXISTS IN THE FIELD, THE CONTRACTOR IS TO NOTIFY THE PROJECT ARCHITECT, OWNER'S REPRESENTATIVE AND THE PROJECT ENGINEER IMMEDIATELY.



CL OR SURVEY LINE	EASEMENT LINE	DESCRIPTION:	CONTOUR LINES	EDGE OF PAVEMENT	"A" TYPE CURBS	"L" TYPE CURBS	WALLS	FENCES	AC PAVEMENT	CONCRETE	SPOT ELEVATIONS	SIGNS	MANHOLE DESCRIPTION	MANHOLE DESCRIPTIONS	FIRE HYDRANTS	GATE VALVES	REDUCERS	CLEAN OUTS	UTILITY BOX OR VAULT	BACKWATER VALVES	100W HPS STREETLIGHTS	150W HPS STREETLIGHTS	200W HPS STREETLIGHTS	250W HPS STREETLIGHTS
CL OR SURVEY LINE	EASEMENT LINE	EXISTING:	CONTOUR LINES	EDGE OF PAVEMENT	"A" TYPE CURBS	"L" TYPE CURBS	WALLS	FENCES	AC PAVEMENT	CONCRETE	SPOT ELEVATIONS	SIGNS	MANHOLE DESCRIPTION	MANHOLE DESCRIPTIONS	FIRE HYDRANTS	GATE VALVES	REDUCERS	CLEAN OUTS	UTILITY BOX OR VAULT	BACKWATER VALVES	100W HPS STREETLIGHTS	150W HPS STREETLIGHTS	200W HPS STREETLIGHTS	250W HPS STREETLIGHTS
PROPERTY LINE	SAWCUT LINE	PROPOSED:	CONTOUR LINES	EDGE OF PAVEMENT	"A" TYPE CURBS	"L" TYPE CURBS	WALLS	FENCES	AC PAVEMENT	CONCRETE	SPOT ELEVATIONS	SIGNS	MANHOLE DESCRIPTION	MANHOLE DESCRIPTIONS	FIRE HYDRANTS	GATE VALVES	REDUCERS	CLEAN OUTS	UTILITY BOX OR VAULT	BACKWATER VALVES	100W HPS STREETLIGHTS	150W HPS STREETLIGHTS	200W HPS STREETLIGHTS	250W HPS STREETLIGHTS
ROW LINE	SCARP LINE		CONTOUR LINES	EDGE OF PAVEMENT	"A" TYPE CURBS	"L" TYPE CURBS	WALLS	FENCES	AC PAVEMENT	CONCRETE	SPOT ELEVATIONS	SIGNS	MANHOLE DESCRIPTION	MANHOLE DESCRIPTIONS	FIRE HYDRANTS	GATE VALVES	REDUCERS	CLEAN OUTS	UTILITY BOX OR VAULT	BACKWATER VALVES	100W HPS STREETLIGHTS	150W HPS STREETLIGHTS	200W HPS STREETLIGHTS	250W HPS STREETLIGHTS

Lochsa Engineering

6345 South Jones Blvd.
Suite 100
Las Vegas, NV 89118
Tel: (702) 365-9817
Fax: (702) 365-9817
www.lochsa.com

TRAFFIC PLANS
SHEET 1 OF 1

DEER SPRINGS AND HUALAPAI
CITY OF LAS VEGAS,
NEVADA


PROJECT NO.: 161109
DATE: 4/25/2017
SCALE: 1"=20'
DRAWN BY: MGZ
DESIGNED BY: MGZ
CHECKED BY: JLI

SHEET No. 1075000
C7.01
SHEET 15 of 15
69418
HTE 18
17-19756


LANDSCAPE LEGEND (BOULDERS)

SYMBOL	SIZE	COMMON NAME	BOTANICAL NAME	QUANTITY
	1500-2500 LB	GRANITE LANDSCAPE BOULDER	N/A	21

 LANDSCAPE LEGEND (TREES)

SYMBOL	SIZE	COMMON NAME	BOTANICAL NAME	QUANTITY
	36 INCH BOX	SHOESTRING ACACIA	ACACIA STENOPHYLLA	47
	36 INCH BOX	RAYWOOD ASH	FRAXINUS OXYCARPA 'RAYWOOD'	45
	24 INCH BOX	BLUE PALO VERDE	PARKINSONIA FLORIDA	35
	36 INCH BOX	BLUE PALO VERDE	PARKINSONIA FLORIDA	6
	24 INCH BOX	CAROLINA LAUREL CHERRY	PRUNUS CAROLINIANA	7
	24 INCH BOX (10'-0" BROWN TRUNK HEIGHT)	MEXICAN FAN PALM	WASHINGTONIA ROBUSTA	26
	24 INCH BOX	SHOESTRING ACACIA	ACACIA STENOPHYLLA	7

 
LANDSCAPE LEGEND (SHRUBS)

SYMBOL	SIZE	COMMON NAME	BOTANICAL NAME	QUANTITY
	5 GALLON	TRAILING LANTANA - ORANGE	LANTANA MONTEVIDENSIS - ORANGE	86
	5 GALLON	TRAILING LANTANA - YELLOW	LANTANA MONTEVIDENSIS - YELLOW	98
	5 GALLON	AUTUMN SAGE	SALVIA GREGGII	54
	5 GALLON	GREEN DESERT SPOON	DASYLIRON ACROTRICHE	127
	5 GALLON	PURPLE FOUNTAIN GRASS	PENNISETUM SETACEUM 'RUBRUM' 'CUPREUM'	85
	5 GALLON	VELVET-LEAF SENNA	SENNA LINDHEIMERIANA (=CASSIA)	13

LANDSCAPE GENERAL NOTES:

1. INSTALLATION AND MAINTENANCE REQUIREMENTS OF NEW LANDSCAPING TO BE PROVIDED BY THE OWNER IN ACCORDANCE WITH TOWN CENTER DEVELOPMENT STANDARDS AND TITLE 19.
2. THE OWNER, DEVELOPER AND OCCUPANT OF THE PROPERTY ARE JOINTLY AND SEVERALLY RESPONSIBLE FOR MAINTAINING OR ASSURING THE ONGOING MAINTENANCE OF INSTALLED LANDSCAPING SO THAT THE LANDSCAPING CONTINUES TO THRIVE. PRIOR TO THE ISSUANCE OF A BUILDING PERMIT, THE OWNER, DEVELOPER OR CONTRACTOR SHALL POST A PERFORMANCE BOND OR EQUIVALENT SECURITY TO ASSURE THE PERFORMANCE OF THE MAINTENANCE OBLIGATION FOR A MINIMUM OF TWO YEARS.
3. LANDSCAPE CONTRACTOR TO PROVIDE (4) FIVE GALLON SHRUBS PER REQUIRED TREE.
4. ALL LANDSCAPE TO BE INSTALLED PER TITLE 19 REQUIREMENTS.
5. THE OWNER, DEVELOPER AND OCCUPANT OF THE PROPERTY ARE JOINTLY AND SEVERALLY RESPONSIBLE FOR MAINTAINING OR ASSURING THE ONGOING MAINTENANCE OF INSTALLED LANDSCAPING SO THAT THE LANDSCAPING CONTINUES TO THRIVE. PRIOR TO THE ISSUANCE OF A BUILDING PERMIT, THE OWNER, DEVELOPER OR CONTRACTOR SHALL POST A PERFORMANCE BOND OR EQUIVALENT SECURITY TO ASSURE THE PERFORMANCE OF THE MAINTENANCE OBLIGATION FOR A MINIMUM OF TWO YEARS.
6. ALL PLANTERS AREAS NOT OTHERWISE NOTED TO HAVE 3" DEEP, 3/4" GRAVEL, OR BLACK POLYETHYLENE GROUND COVER, AROUND & BETWEEN PLANTS & SHRUBS. GRAVEL COLOR TO BE SELECTED BY ARCHITECT.
7. ALL TREES SHALL HAVE A GROWTH HEIGHT OF 4' OR HIGHER W/ 20 FOOT SPREAD MIN. ALL TREES TO BE STAKED FOR SUPPORT.
8. CONTRACTOR SHALL REMOVE ALL ROCKS, WEEDS, DEBRIS & ALL EXTRANEOUS MATERIAL FROM JOB SITE PRIOR TO PROCEEDING WITH ANY LANDSCAPE WORK AND DISPOSE OF IN A SUITABLE AND LAWFUL MANNER.
9. ANY REQUIRED PLANT MATERIAL THAT DOES NOT SURVIVE, OR SUSTAINS SEVERE DAMAGE, SHALL BE REPLACED WITHIN 90 DAYS.
10. ALL PLANTING AREAS TO BE PROPERLY PREPARED AND FERTILIZED TO SUSTAIN LIFE AND GROWTH FOR SIX (6) MONTHS AFTER INSTALLATION.
11. SUPPLY AND INSTALL ALL PIPING, FITTINGS, VALVES, HEADS, TIMER, WIRING, ETC. NECESSARY TO PROVIDE A PROPER AUTOMATIC IRRIGATION SYSTEM TO ALL PLANTING AREAS ADEQUATE TO ALLOW VIGOROUS PLANT LIFE, HEALTH, AND GROWTH.
12. IRRIGATION CONTROLLER TO BE: RAINMASTER EAGLE4 (12) W/ CENTRAL COMMUNICATION KIT.
13. ROOT BARRIER TO BE INSTALLED BY ANY CURB, WALL OR SIDEWALK.
14. ALL PIPES AND CONTROLLER WIRES ARE TO BE PLACED IN SLEEVINGS UNDER ALL HARDSCAPE AREAS.

ARCHITECT OF RECORD

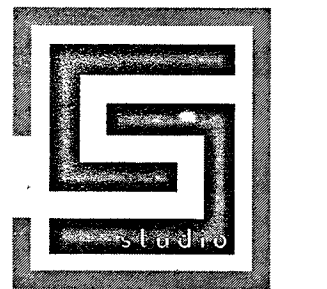


SHURLEY
design studio
architecture • interior design
2000 SHARPE BLVD. SUITE 100
LAS VEGAS, NV 89102
PHONE 702.491.0022

CLIENT

100 % CONSTRUCTION DOCUMENTS - PERMIT SET

These drawings and specifications are instruments of service and remain the property of Shurley Design Studio, LLC. Copies of drawings and specifications made by the client may be utilized only for the project for which they are prepared, and not for construction of any other project. These plans are not to be reproduced, changed or copied in any form or manner without the written consent of the design professional. Written dimensions on these drawings shall have precedence over verbal dimensions.

©copyright 2017, Shurley Design Studio, LLC

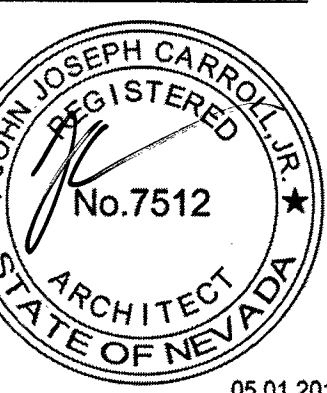

STORAGEONE
W DEER SPRINGS WAY & N HUALAPAI WAY
LAS VEGAS, NEVADA


Delta #	Issue Date	Description
1	04/13/17	PinChk Comments

Project No.	2017001
Date:	April 6, 2017
Drawn:	J. Carroll
Reviewed:	J. Carroll & Shurley
Drawing Title:	

LANDSCAPE PLAN

Sheet No.:

AS2.1
10725000 L-69418

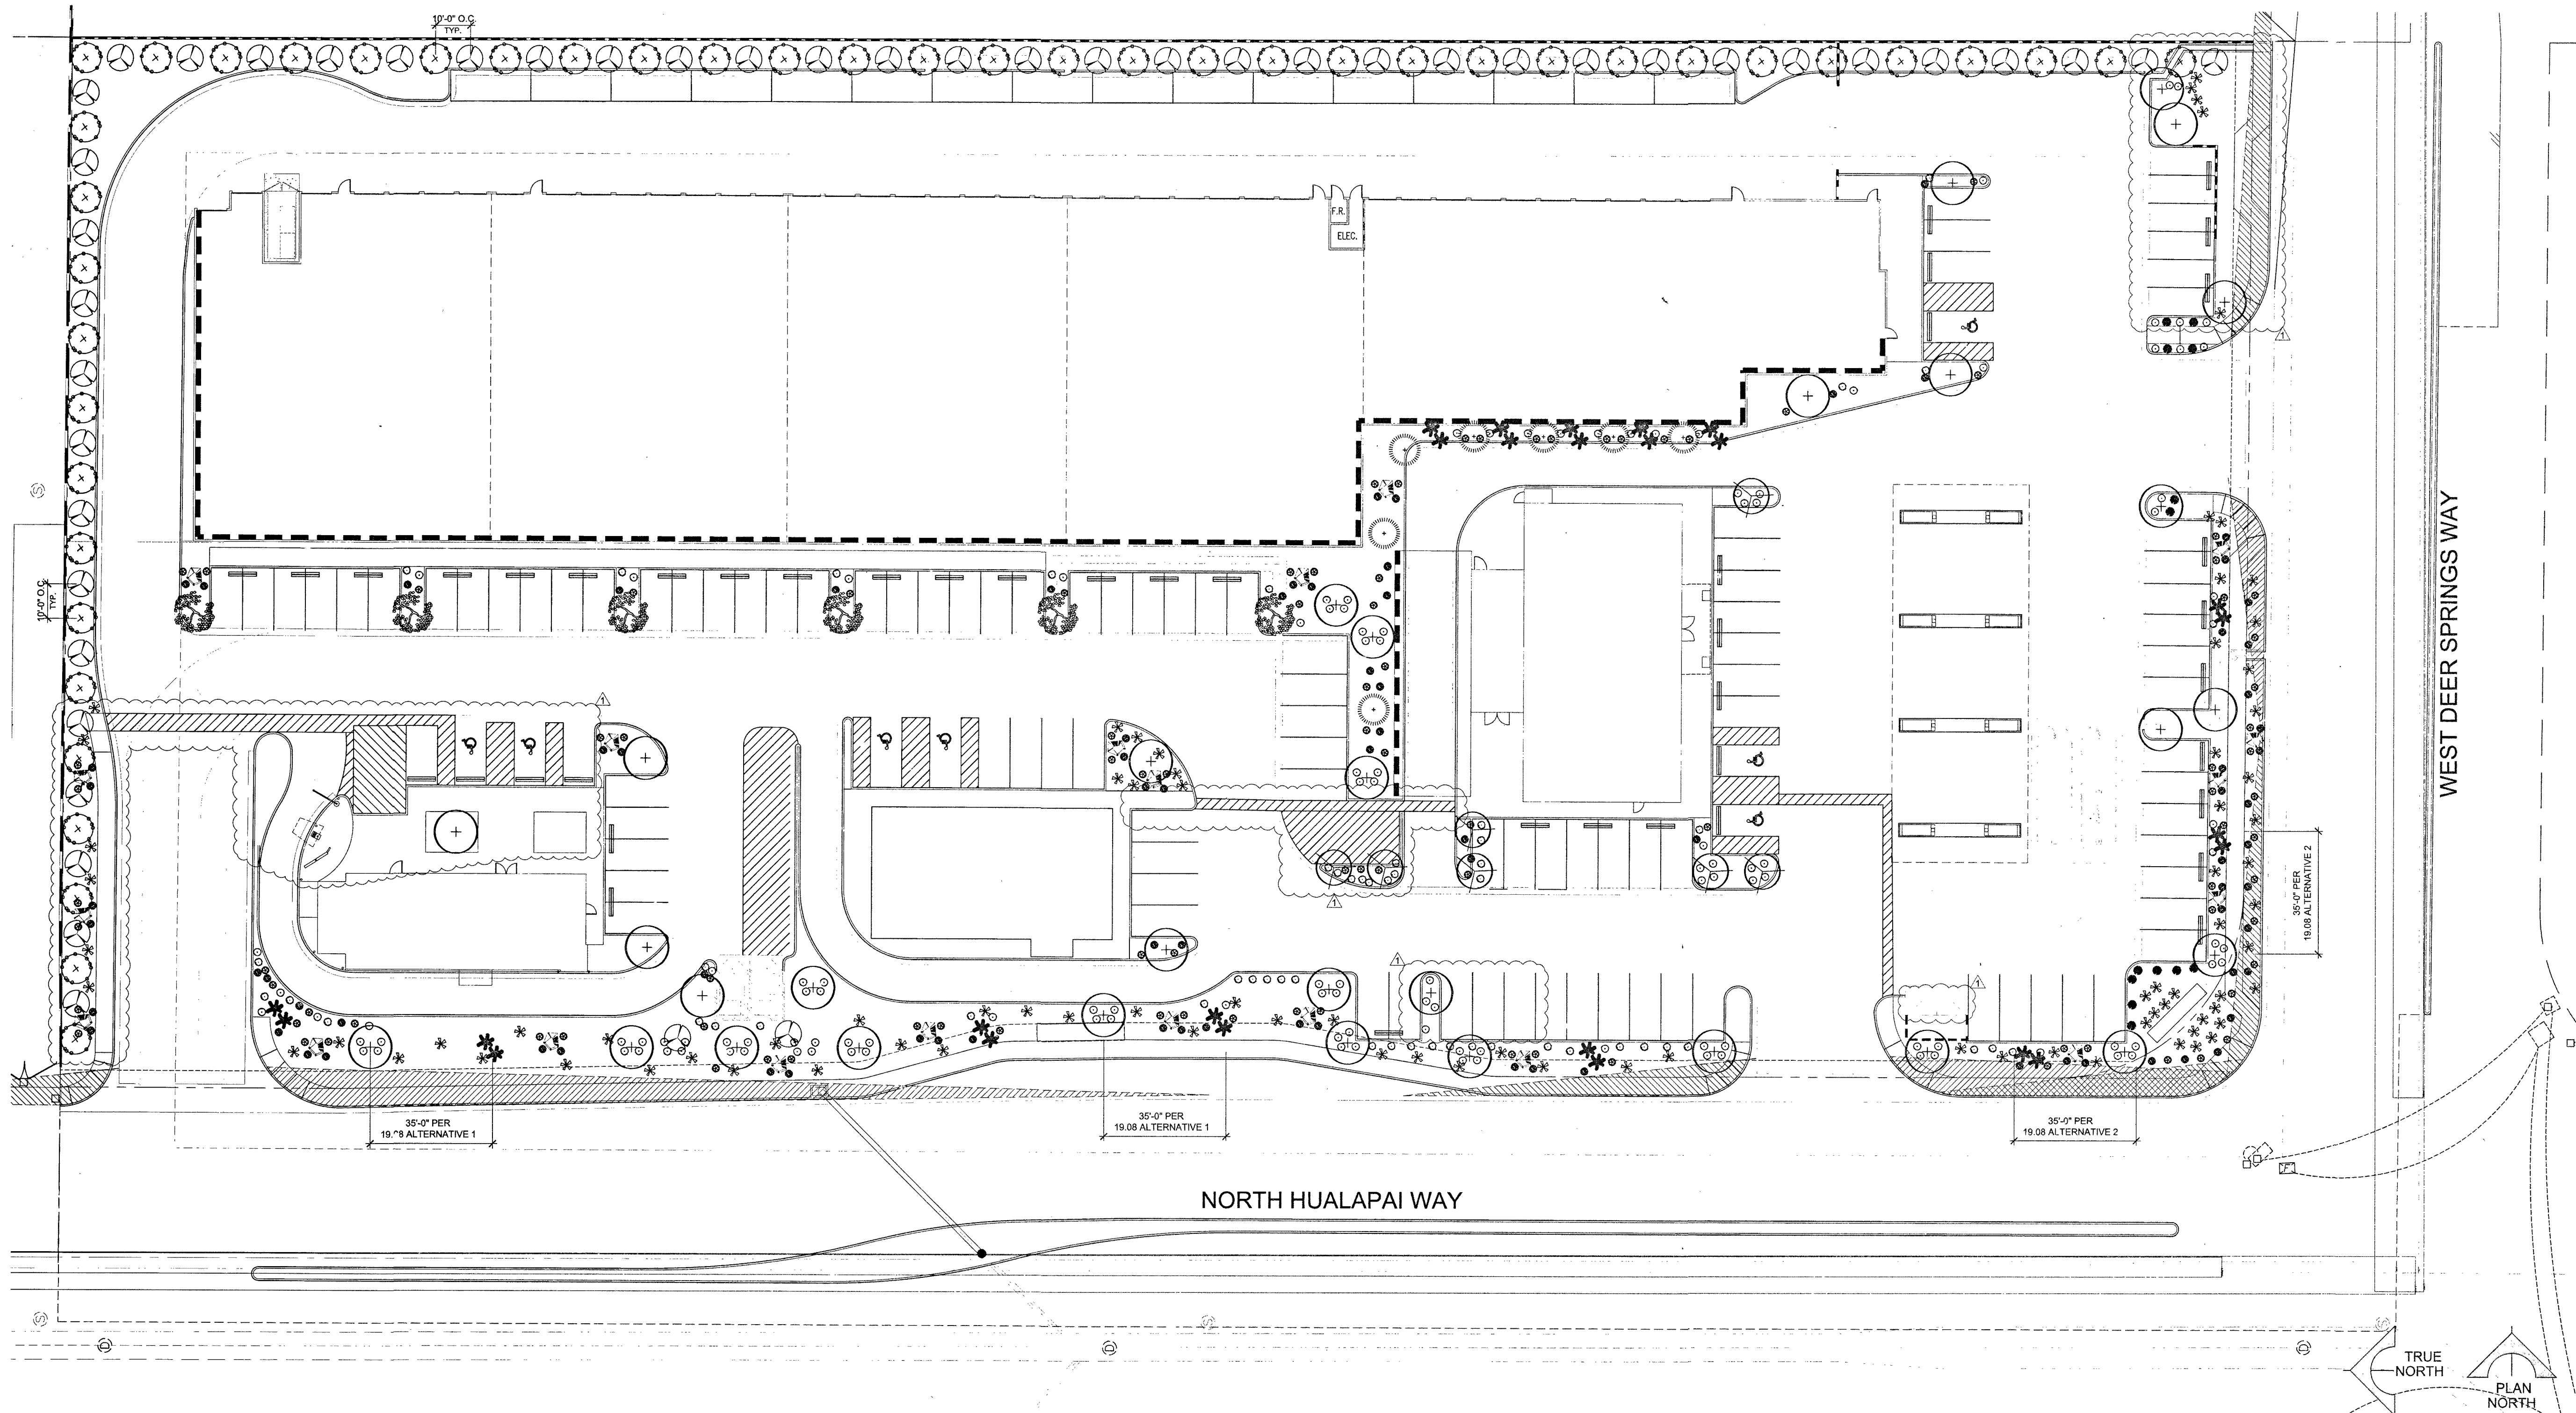

LANDSCAPE PLAN

SCALE: 1" = 20'

SCALE 1" = 20'
0 10 20 40

[illegible]

SCALE: NOT TO SCALE

STORAGEONE
1100 W DEER SPRINGS WAY & N HUALAPAI WAY
LAS VEGAS, NEVADA

Delta #	Issue Date	Description
Project No.	201700	
Date:	April 6, 2018	J. Carroll
Drawn:		
Reviewed:		J.Carroll/G.Shurley

LANDSCAPE -
PLANTING
DETAILS


17
Sheet No.:
AS2.2
10745060 L-69418

SYMBOL	MANUFACTURER	MODEL NUMBER / DESCRIPTION
	SEE CIVIL PLANS	WATER METER
	HUNTER	ICV 1" REMOTE CONTROL VALVE W/ FILTER & PRESSURE REGULATOR - TREE, SHRUB & PALM VALVE
	AGRIFIM	DRIP FLUSH END CAP
	FIBRO	825W W/ STRAINER BACKFLOW PREVENTION ASSEMBLY
-----	AS APPROVED	PVC PIPE SCHEDULE 40 - SIZE ACCORDINGLY 18" BELOW GRADE. ALL MAINLINE ON PROJECT SEE SIZE ON PLAN
	TORO	DRIP IRRIGATION WITH 3/4" BLUE STRIPE POLY PIPE TUBING AND 1/4" EMITTER TUBING - REFER TO SHRUB EMITTER CHART
	AS APPROVED	PROVIDE (2) PVC PIPE SCHEDULE 40 SLEEVES, MINIMUM 2" DIAMETER: (1) TO BE USED FOR THIS SCOPE OF WORK AND (1) 2" DIAMETER FOR FUTURE USE. PIPE USED FOR THIS SCOPE OF WORK SHALL BE THE DIAMETER OF PIPE OR WIRE BUNDLE CARRIED. NO SYMBOL SHOWN ON PLANS - ALL PIPES AND WIRES UNDER PAVING
	TORO	PVC PIPE CLASS 200, AS LATERAL LINES 12" BELOW GRADE, SIZE PER PLAN
	HUNTER	IRRIGATION SYSTEM CONTROLLER - PEDESTAL MOUNT

DIAMETER	CL 200	CL 315	SCH 40
1/2"	-	-	-
3/4"	8-11 GPM	-	5-8 GPM
1"	12-16 GPM	-	9-13 GPM
1-1/4"	17-26 GPM	-	14-24 GPM
1-1/2"	27-36 GPM	-	25-34 GPM
2"	37-57 GPM	26-39 GPM	35-50 GPM

SIZE	GPH	NUMBER OF EMITTERS
1 GALLON	2 GPH	1 EACH
5 GALLON	2 GPH	2 EACH
15 GALLON	2 GPH	3 EACH
24" BOX	2 GPH	4 EACH
36" BOX	2 GPH	6 EACH

1. THE IRRIGATION SYSTEM IS DRAWN DIAGRAMMATICALLY. WHERE POSSIBLE, LOCATE ALL IRRIGATION LINES AND APPURTENANCES.
2. INSTALL REMOVE CONTROL VALVES ADJACENT TO PAVING WHERE POSSIBLE.
3. ALL IRRIGATION LINES UNDER PAVING SHALL BE SLEEVED WITH SCHEDULE 40 PIPE MIN. X DIA. METER OF PIPE BEING SLEEVED TYPE, 1" BELOW GRADE. PROVIDE GROUND MARKER TO SHOW LOCATION OF SLEEVE ENDS.
4. ALL IRRIGATION SLEEVES TO BE INSTALLED AT MINIMUM OF 6" EAST ANY KNOWN OBSTRUCTIONS BEING SLEEVED UNDER AND 6" WEST ANY KNOWN OBSTRUCTIONS BEING SLEEVED UNDER.
5. ACTUAL DROP TO EACH PIPING TO BE AS DESIGNATED BY WATER DISTRICT AND OWNER'S AUTHORIZED REPRESENTATIVE.
6. SCHEDULE 40P LATERALS/MAINFOLDS ARE DIAGRAMMATIC ONLY AND DEMOTE GENERALIZATION. LIMITS: SUBLATERALS, FLEX PIPE, EMITTERS, AND OTHER DROP EQUIPMENT ARE NOT SHOWN FOR CLARITY.
7. MAIN LINE AND LATERAL LINES SHOWN WITH PAVING FOR CLARITY ONLY. ACTUAL MAIN LINE TO BE A MINIMUM OF 18" ABOVE ADJACENT HARDSURFACES AND OTHER EXISTING SURFACES.
8. CONTRACTOR TO COORDINATE QUANTITY AND LOCATIONS OF IRRIGATION SYSTEM CONTROLLERS WITH OWNER/ ARCHITECT PRIOR TO CONSTRUCTION.

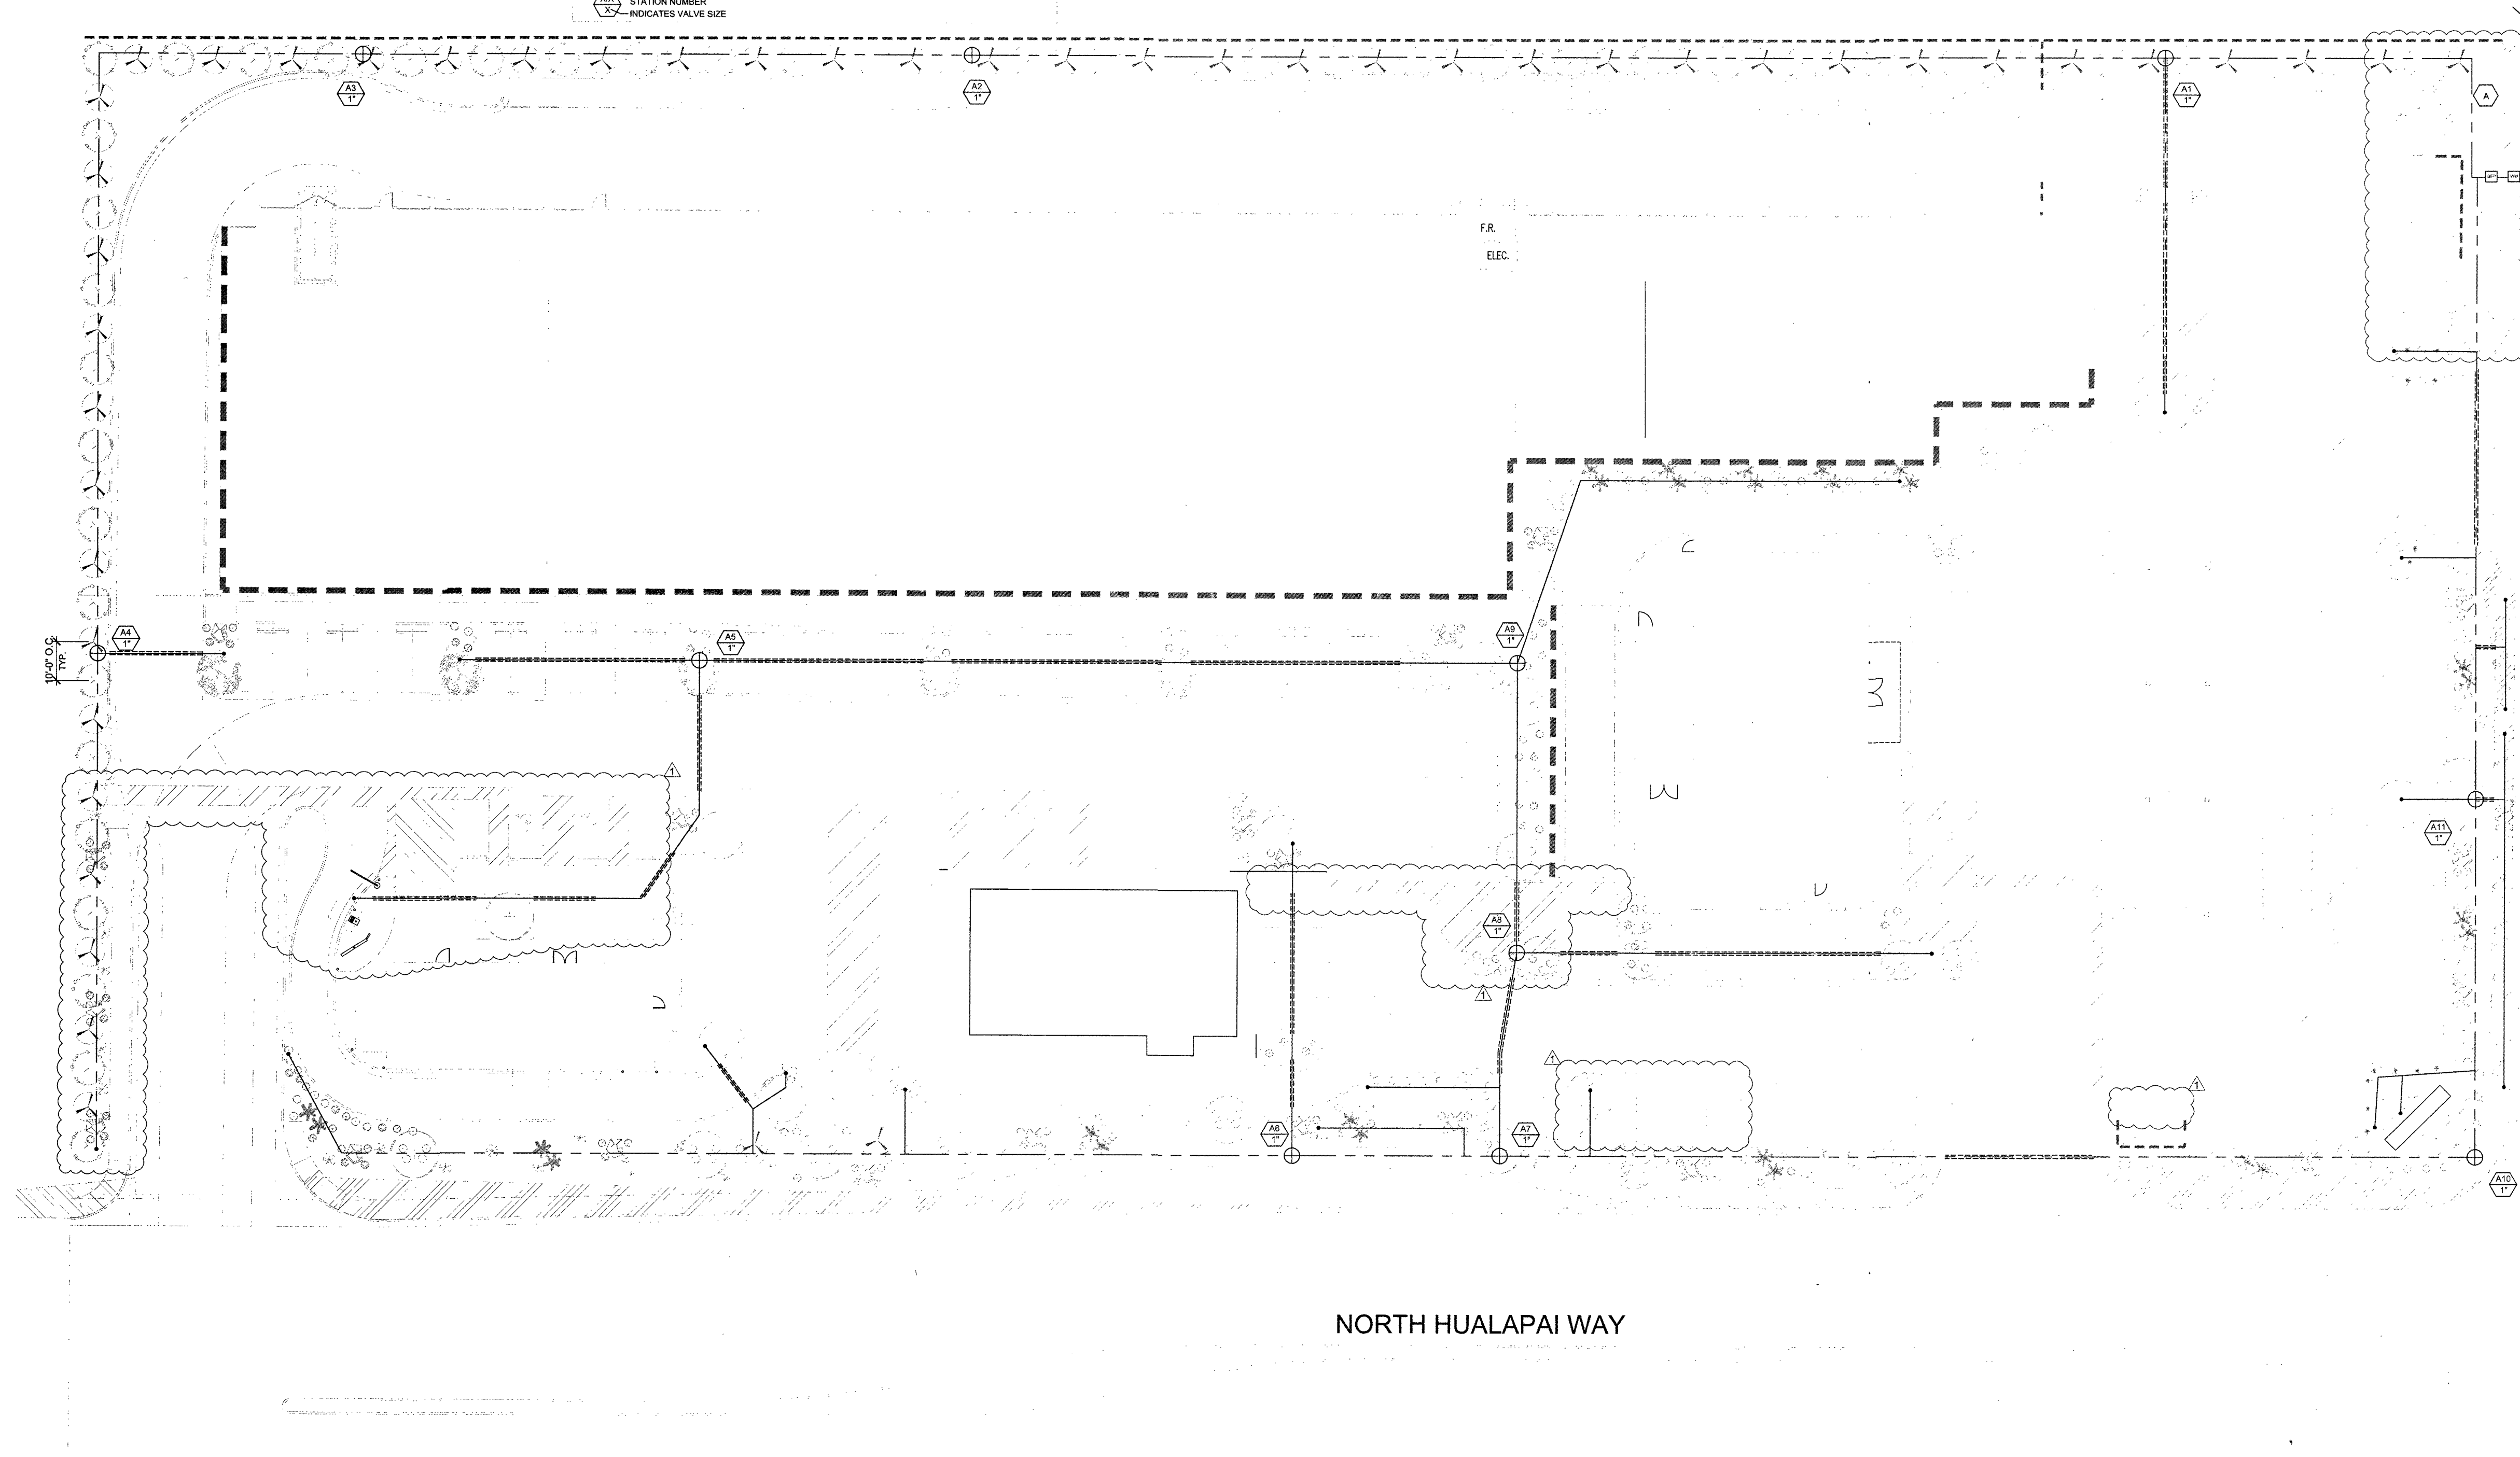

WEST DEER SPRINGS WAY

NORTH HUALAPAI WAY

TRUE
NORTH




A LANDSCAPE - IRRIGATION PLAN

SCALE: 1" = 20'

100 % CONSTRUCTION DOCUMENTS - PERMIT SET

ARCHITECT OF RECORD

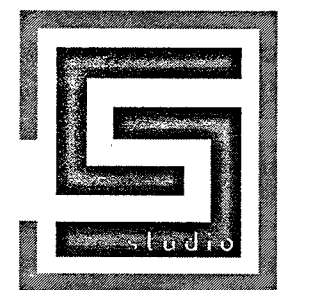


SHURLEY
design studio
architecture + interior design
3020 WEST AVENUE LAS VEGAS, NV 89104
EMAIL: GEOFF@SHURLEYDESIGN.COM
PHONE: 702.624.0022

CLIENT

These drawings and specifications are instruments of service and remain the property of Sharley Design Studio, LLC. Copies of these drawings and specifications retained by the client may be utilized only for the project for which they are prepared, and not for construction of any other project. These plans are not to be reproduced, changed or copied in any form or manner whatsoever, nor are they to be assigned to any third party, without first obtaining the expressed written permission and consent of the design professional. Written dimensions on these drawings shall have precedence over scaled dimensions.

©copyright 2017, Sharley Design Studio, LLC

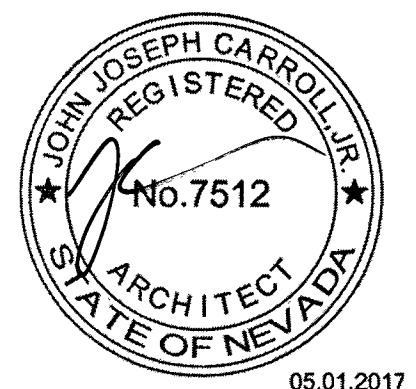

05.01.2017

STORAGEONE
 1000 W DEER SPRINGS WAY & N HUALAPAI WAY
 LAS VEGAS, NEVADA


Delta #	Issue Date	Description
1	04/13/17	PlnChk Comments

Project No.	2017001
Date:	April 6, 2017
Drawn:	J.Carroll
Reviewed:	J.Carroll/G.Shurley


Drawing Title:
**LANDSCAPE -
IRRIGATION PLAN**

Sheet No.: 18


AS2.3
0745060 L-69418

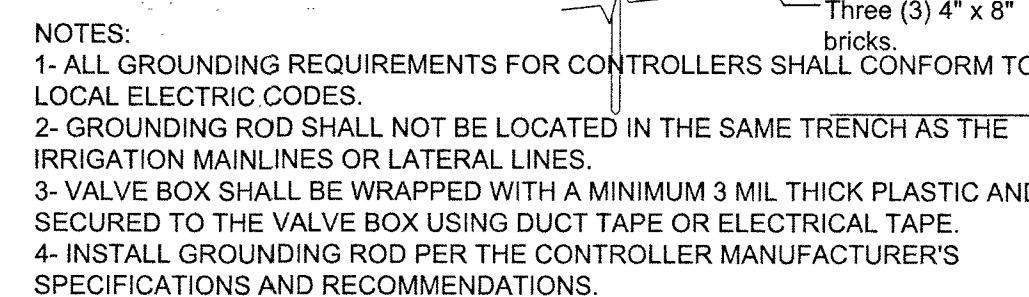


SCALE: NONE

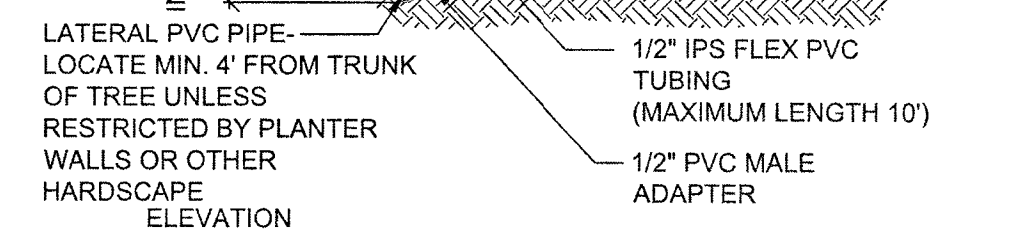


4 SCALE: NONE

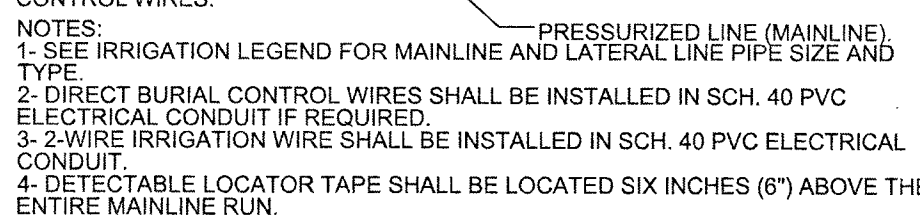


SCALE: NONE

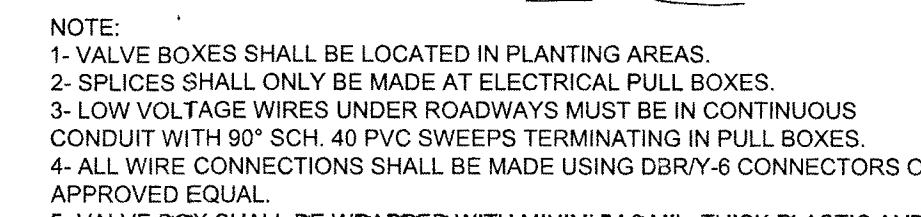


SCALE: NONE

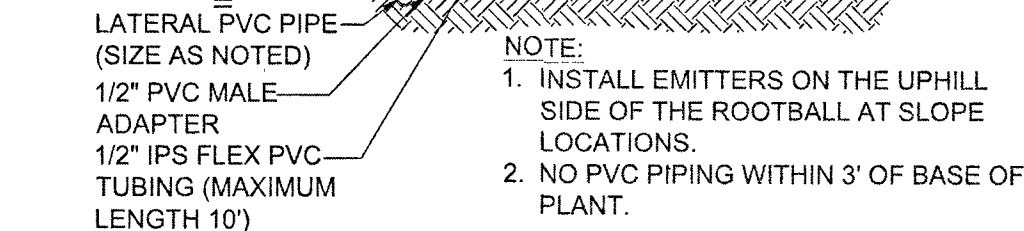


SCALE: NONE

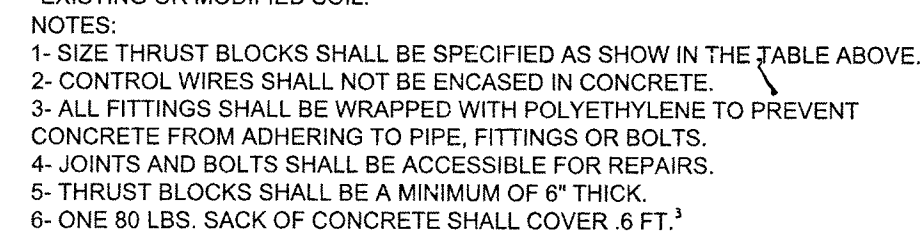


SCALE: NONE

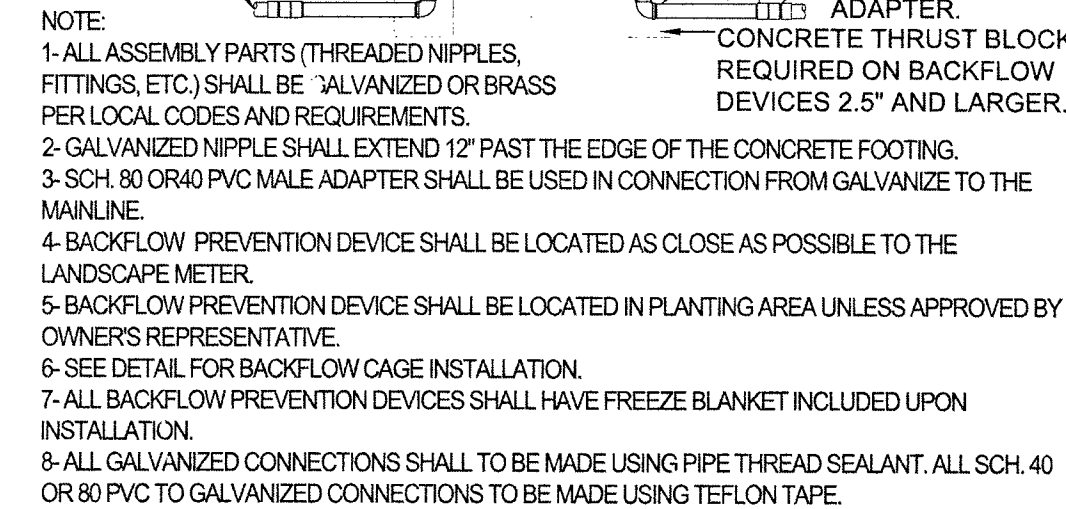


SCALE: NONE

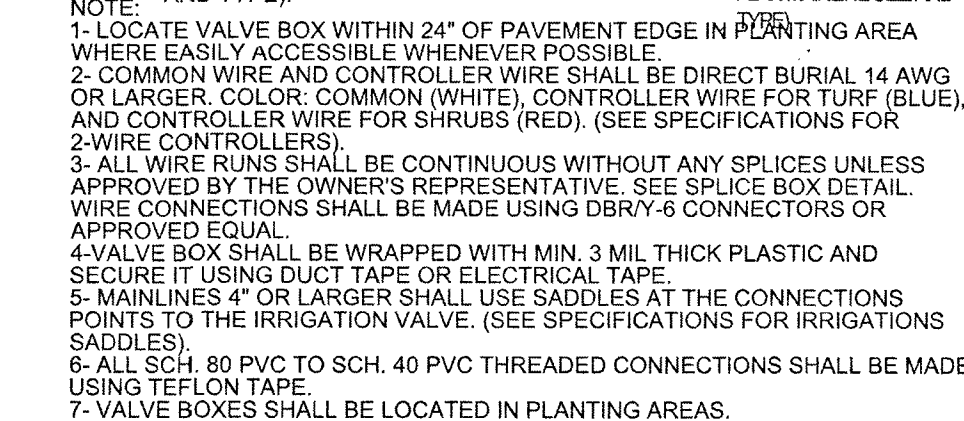

6	SCALE: NONE
---	-------------

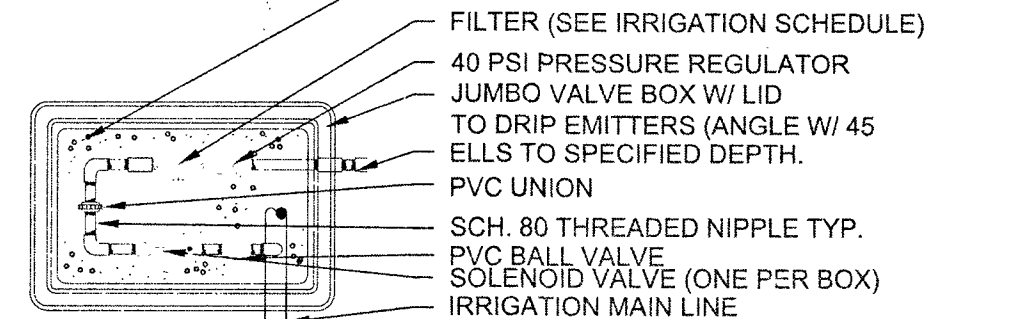


2	SCALE: NONE
---	-------------

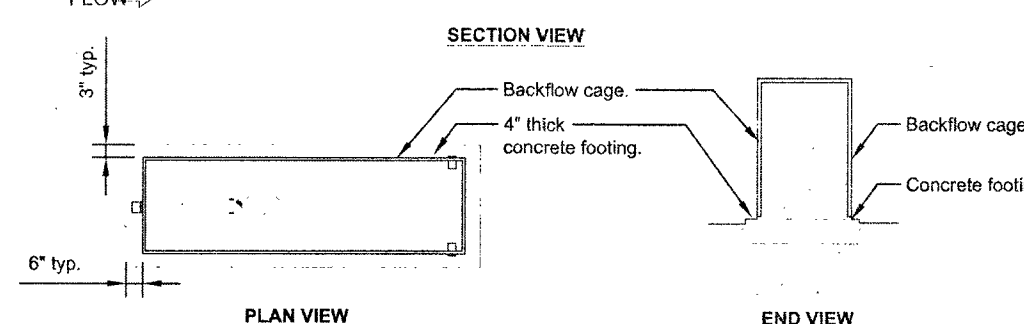

SCALE: NONE




5	SCALE: NONE
---	-------------

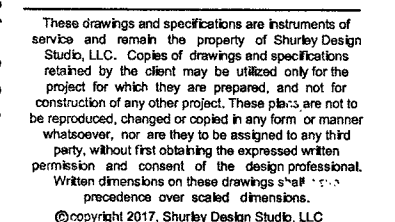


STORAGEONE
1100 W DEER SPRINGS WAY & N HUALAPAI WAY
LAS VEGAS, NEVADA


Project No.	2017001
Date:	April 6, 2017
Drawn:	J. Carroll
Reviewed:	J. Carroll/G. Shurley
Drawing Title:	
IRRIGATION DETAILS	
19	
Sheet No.:	
AS2.4	
107Y5060 L-69418	

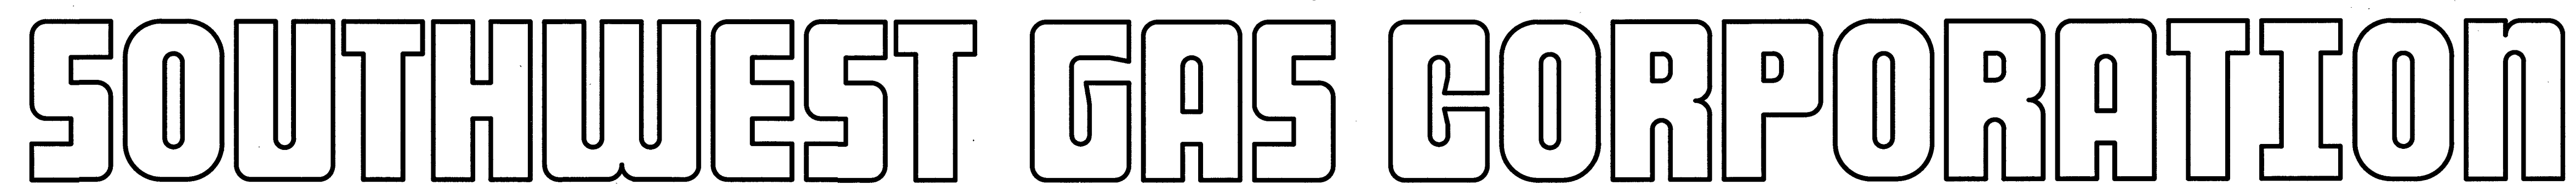

C DEER SPRINGS HUALAPAI
CITY OF LAS VEGAS, NV
WR #3376796

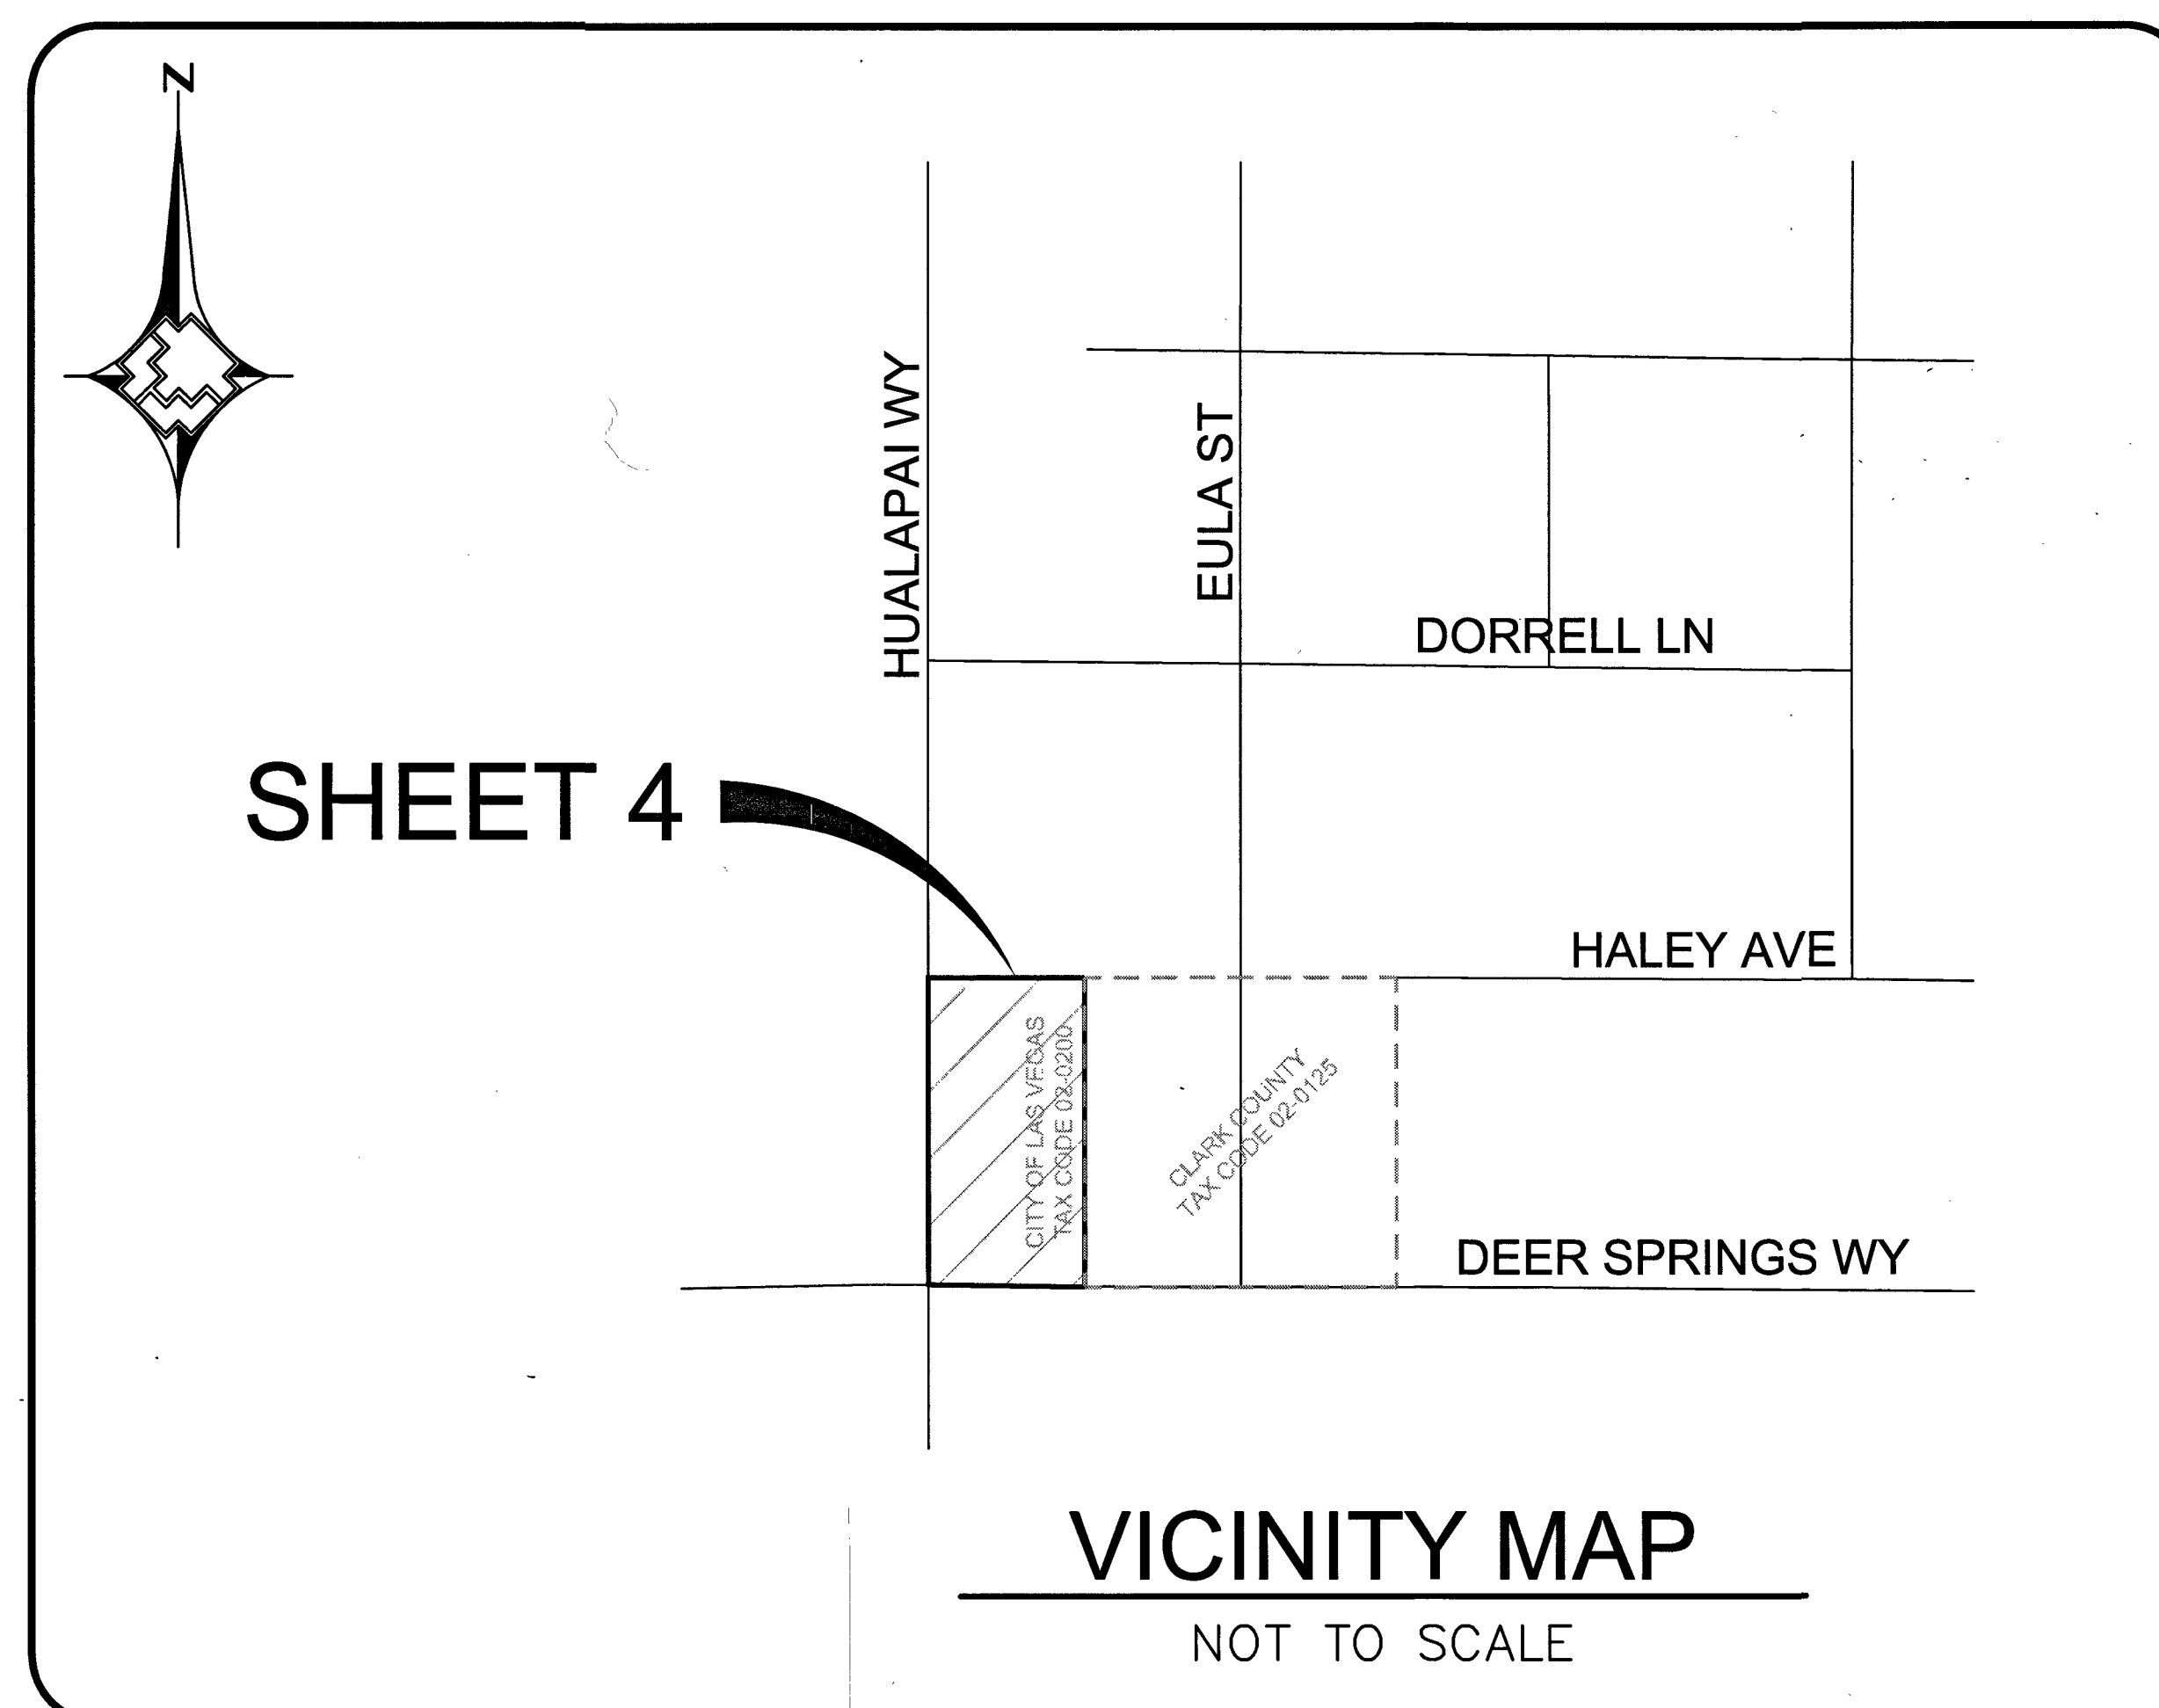


LEGEND

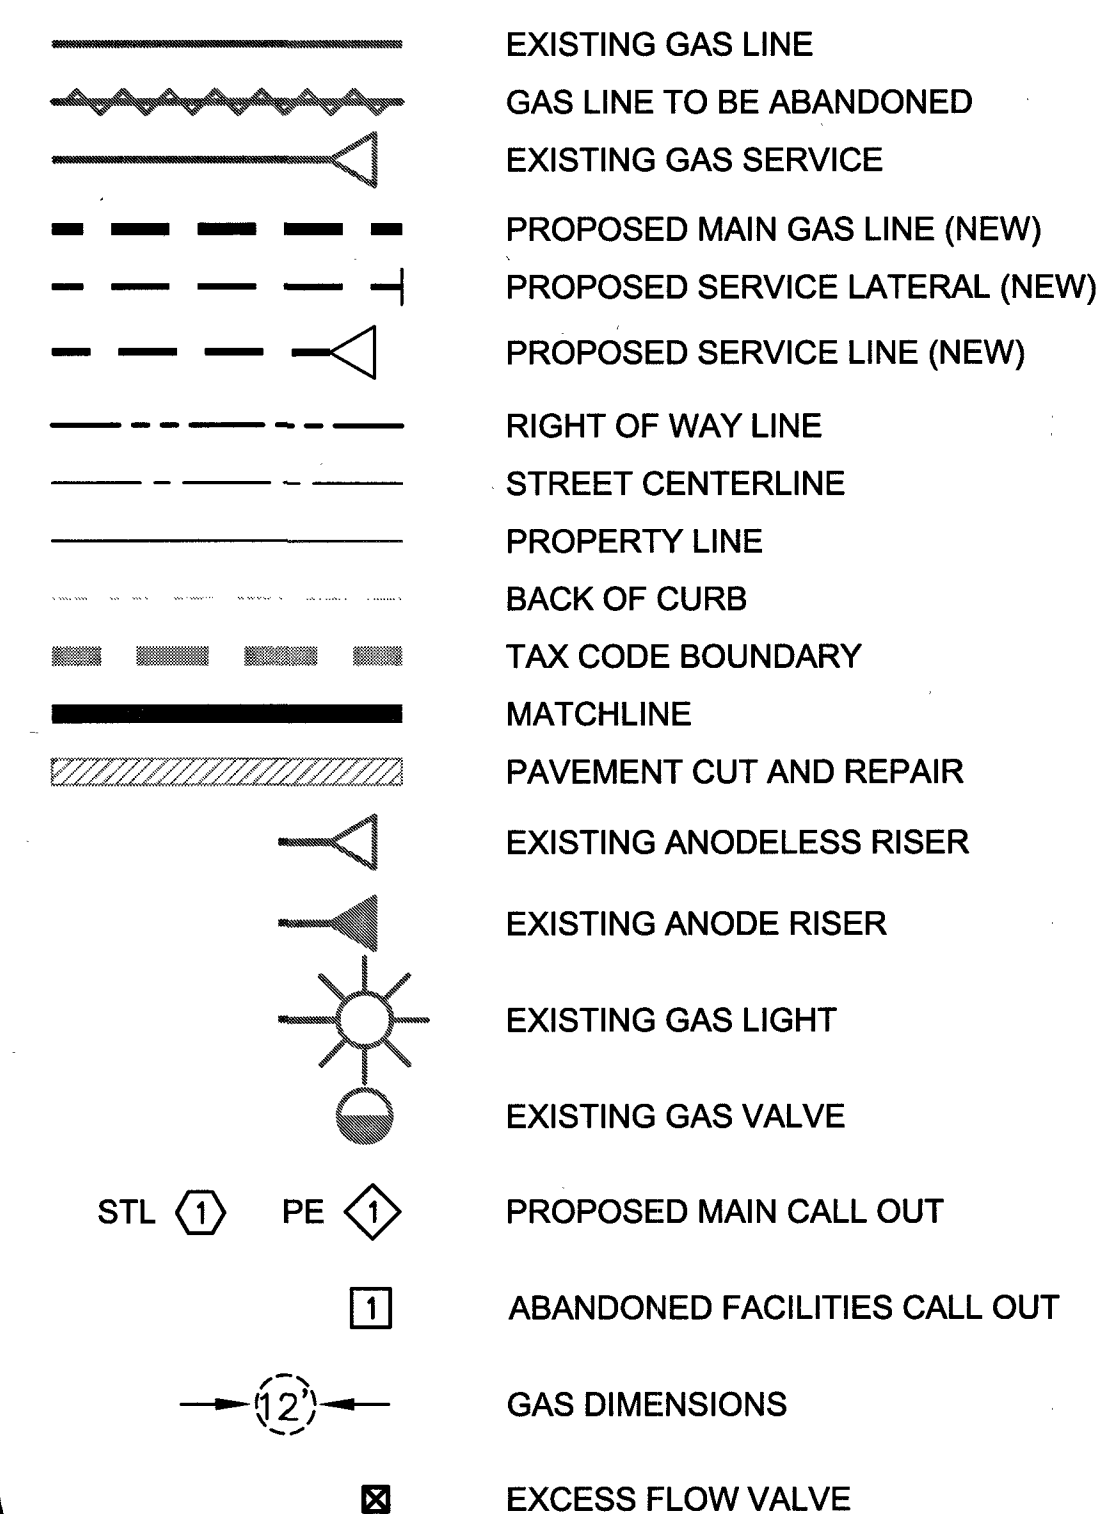

SHEET INDEX

1. COVER SHEET
2. ABBREVIATIONS & NOTES
3. MATERIALS & SIGNATURES - PE
4. DESIGN PLAN
5. TYPICAL SWPPP BMPs DETAILS

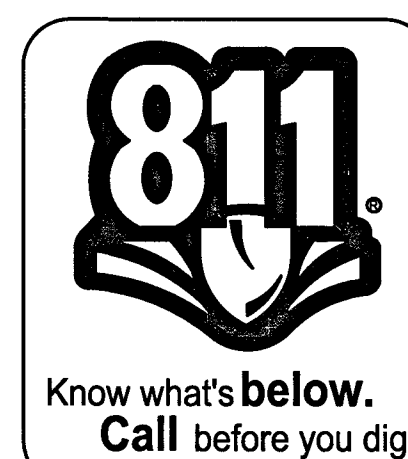[illegible]

MATERIAL LIST FOR DISTRIBUTION FACILITIES				
ITEM#	QTY. (DESIGN)	QTY. (AS-BUILT)	STOCK ID#	DESCRIPTION
1	1		160-8174	4" X 2" HVTT
2	449'		100-5101	2" PE MAIN
3	364'		100-5101	2" PE SVC
4	5		140-3067	2" PE 90° ELBOW
5	3		140-3074	2" PE TEE
6	4		160-9271	2" EFV (5,500)
7	2		161-7661	2" PE RISER, 600 CFH, 7" WC, 2' SPREAD
8	1		161-7661	2" PE RISER, 1,000 CFH, 7" WC, 2' SPREAD
9	1		161-7661	2" PE RISER, 500 CFH, 7" WC, 2' SPREAD

CATHODIC PROTECTION NOTES:

1. NO STEEL WITHIN PROJECT LIMITS.
NO CP ACTION REQUIRED.

VISUAL INSPECTION (OQ/PJQ)


SIGNATURE _____

DATE _____


PURGE PLAN WAS COMPLETED IN ACCORDANCE
WITH THE OPERATIONS MANUAL GUIDELINES BY:

PRINT: _____ DATE: _____

SIGNATURE: _____

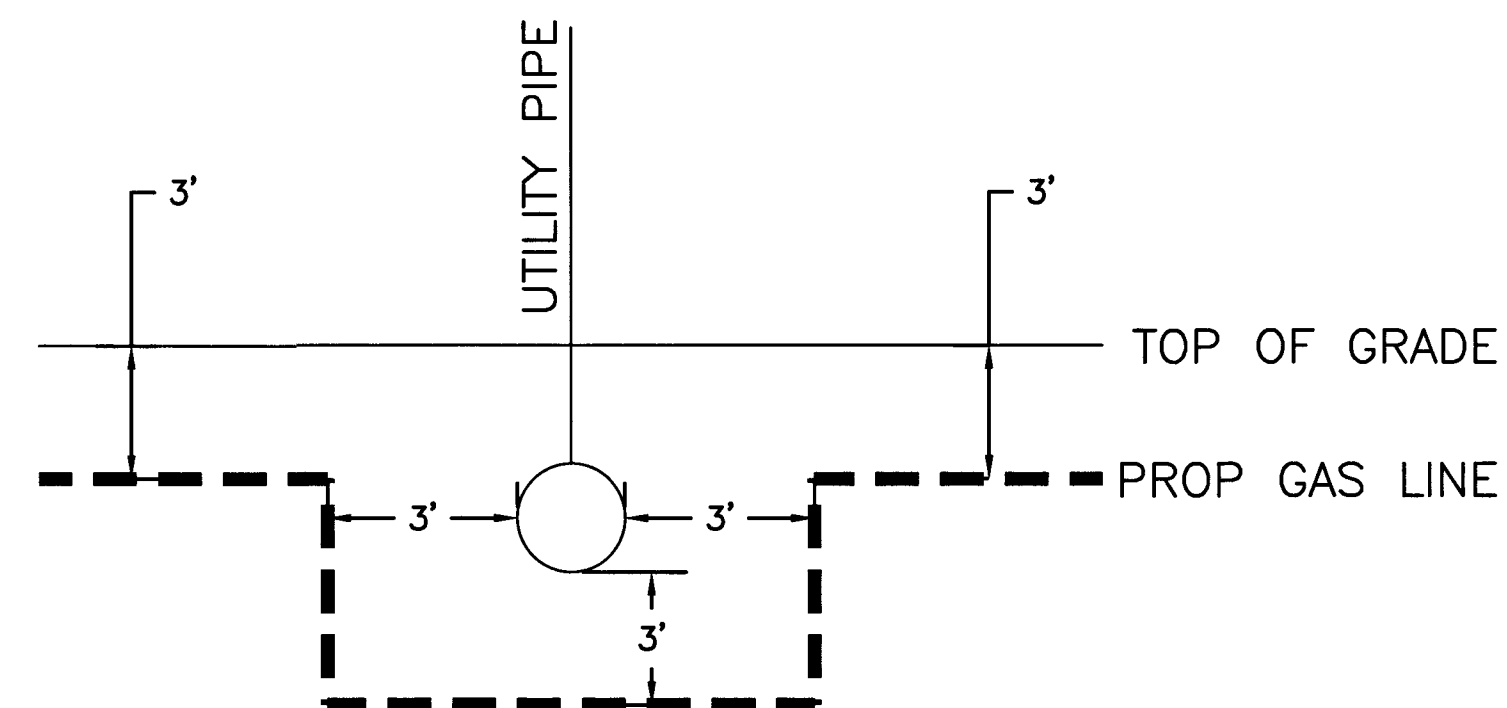



TYPICAL UTILITY CROSSING DETAIL
NOT TO SCALE

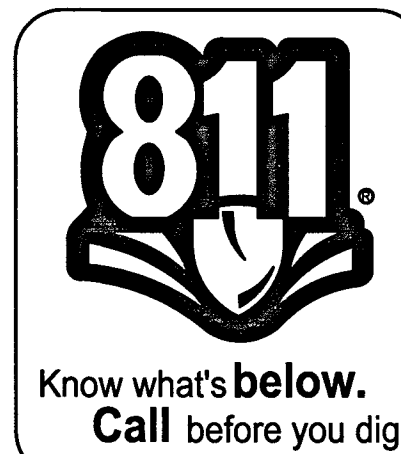

SYSTEM	D_N_VALLEY_W
DR. NO.	21DS10009738
SEGMENT M.A.O.P.	N/A
SYSTEM M.A.O.P.	60 psig
SYSTEM M.O.P.	55 psig

AS-BUILT DRAWING-PRESSURE TEST DATA		
PIPE DIA. _____ PIPE LENGTH _____ PIPE TYPE _____ MIN. DURATION _____	TEST MEDIUM TEST METHOD ☐ AIR ☐ GAUGE ☐ NITROGEN ☐ CHART ☐ WATER ☐ GAUGE/ ☐ SOAP ☐ PRESS REC SN#	
TEST PRES. (PSIG) _____	START _____	END _____
TIME _____		
DATE _____		
PERFORMED BY _____		

[illegible]

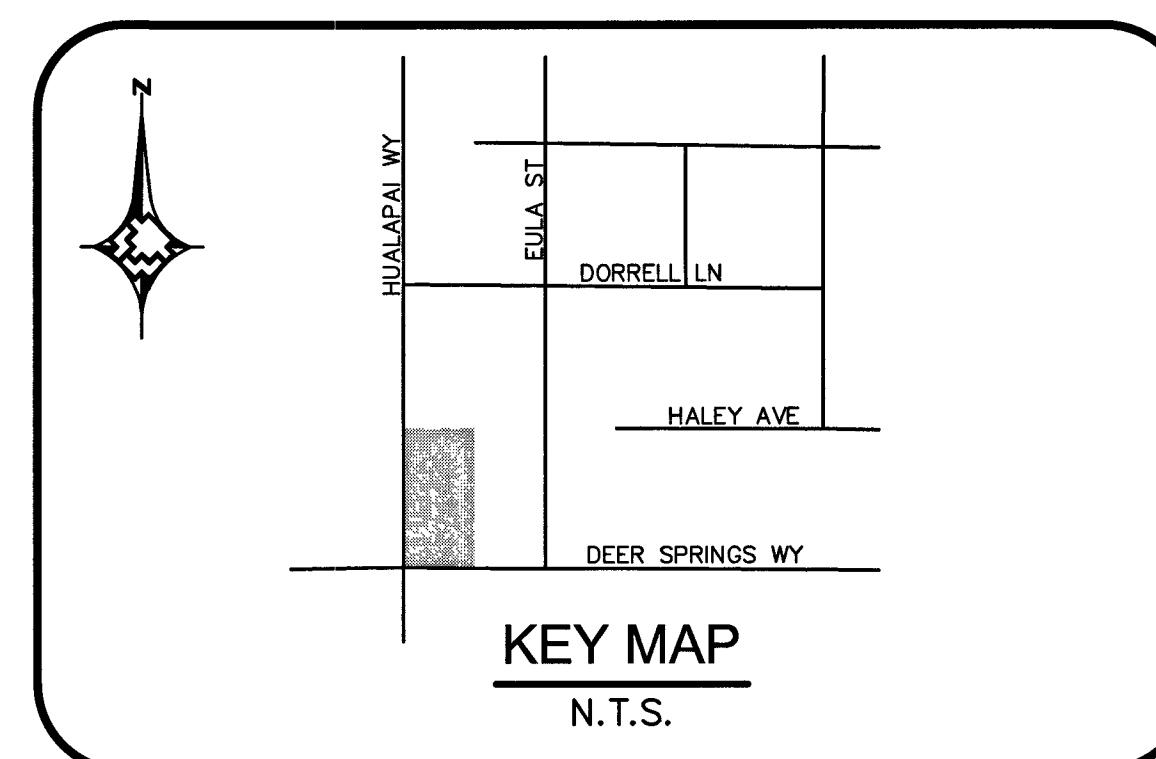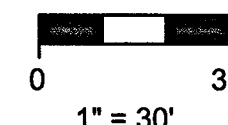


MATERIAL LIST FOR DISTRIBUTION FACILITIES			
ITEM#	QTY. (AS-BUILT)	STOCK ID#	DESCRIPTION
1		160-8174	4" X 2" HVTT
2		100-5101	2" PE MAIN
3		100-5101	2" PE SVC
4		140-3067	2" PE 90° ELBOW
5		140-3074	2" PE TEE
6		160-9271	2" EFV (5,500)
7		161-7661	2" PE RISER, 600 CFH, 7" WC, 2' SPREAD
8		161-7661	2" PE RISER, 1,000 CFH, 7" WC, 2' SPREAD
9		161-7661	2" PE RISER, 500 CFH, 7" WC, 2' SPREAD

RTC NOTES:


PAVEMENT REPAIR SHALL CONFORM TO RTC:

- | | |
|----|-------|
| A1 | 500.5 |
| A2 | 503 |

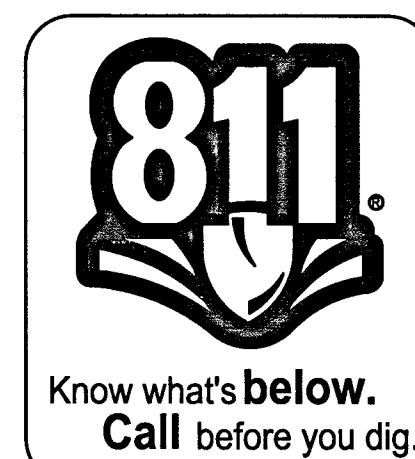
[illegible]

10745060 L-69418


TYPICAL SWPPP BMPs DETAILS

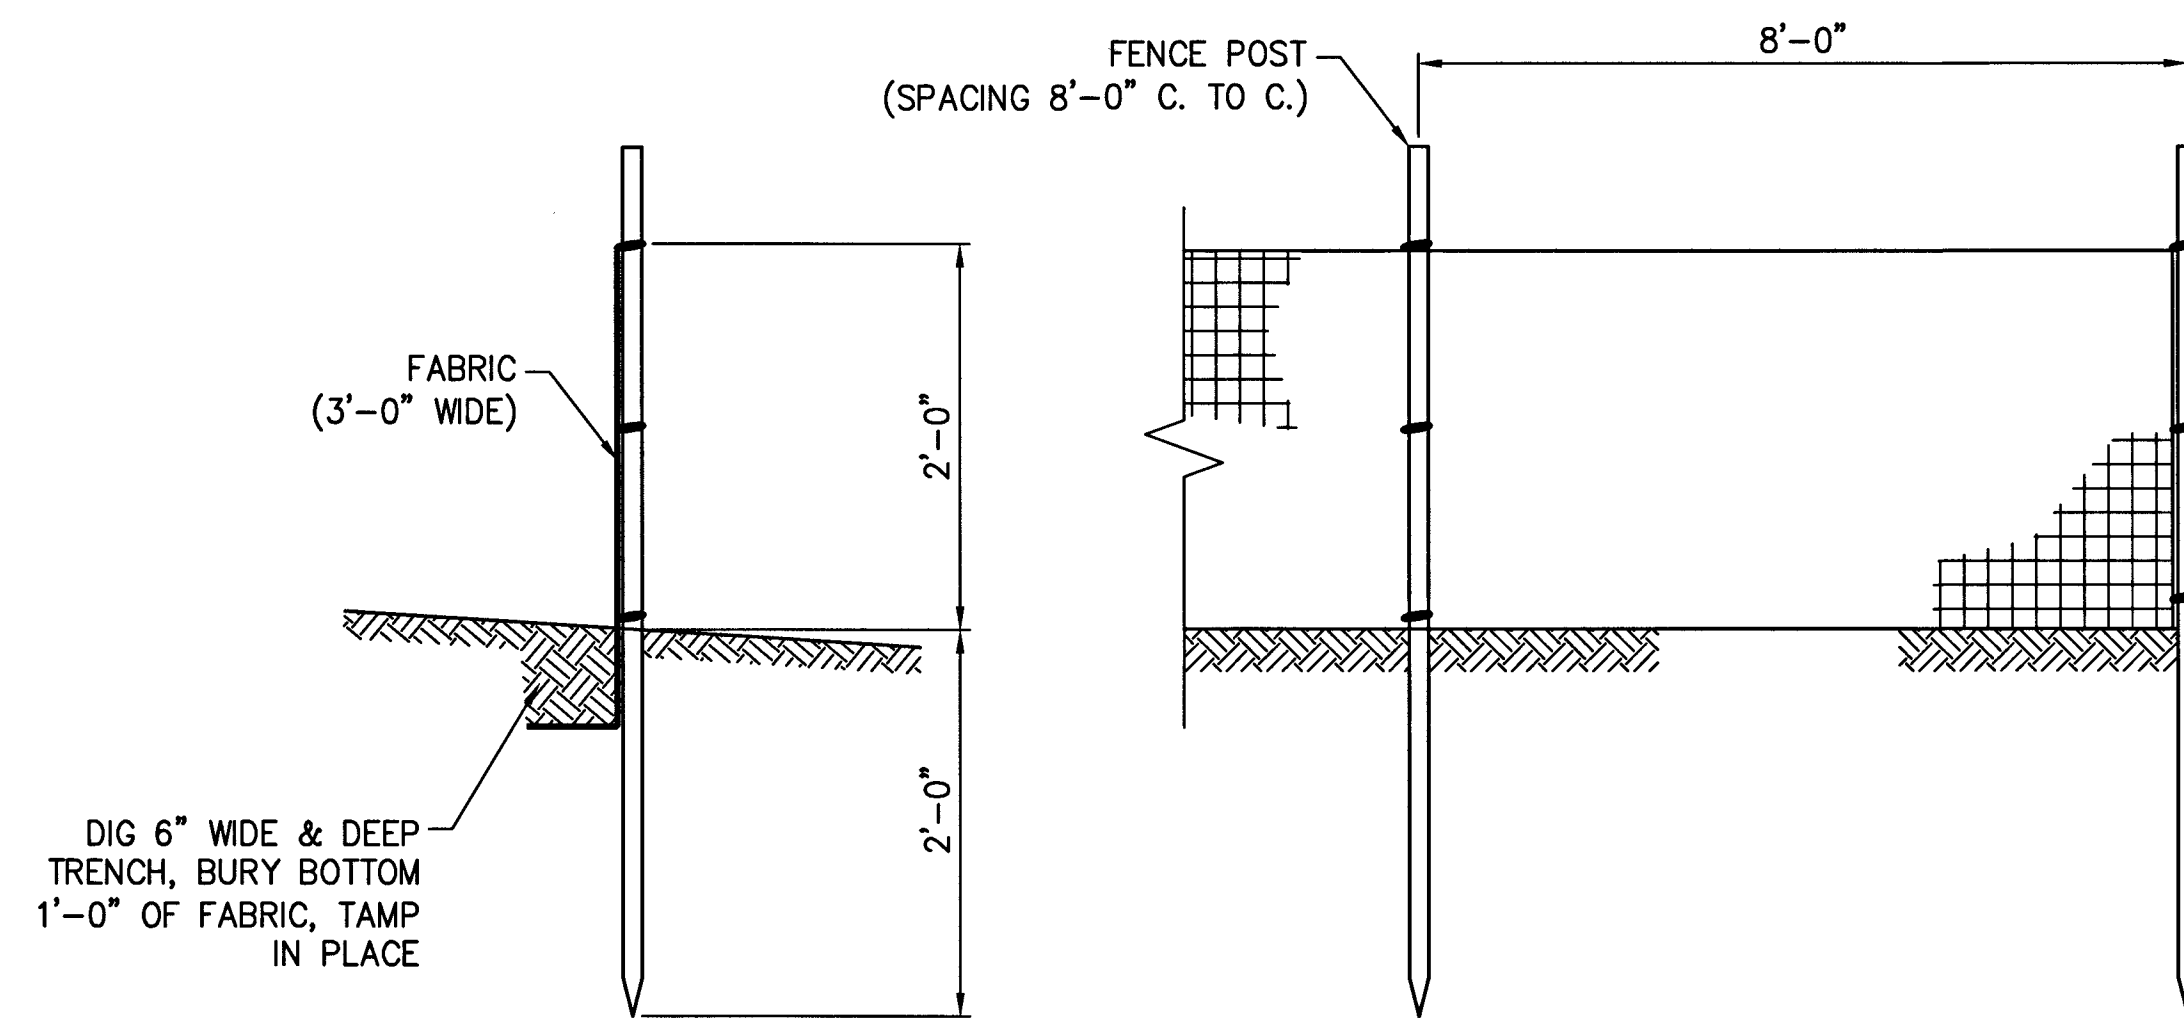


1
5 **SILT FENCE**
NOT TO SCALE

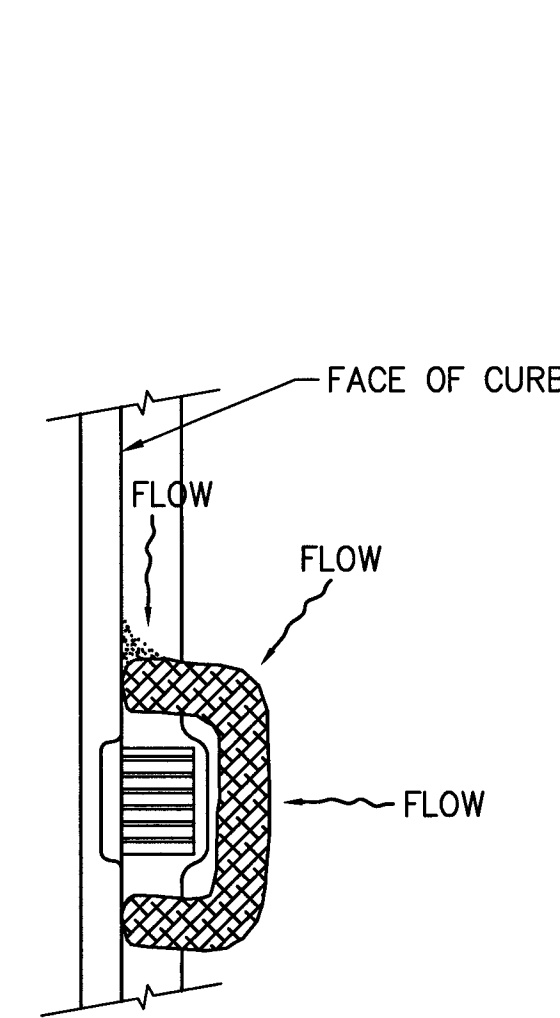


2
5 **FIBER ROLL**
NOT TO SCALE

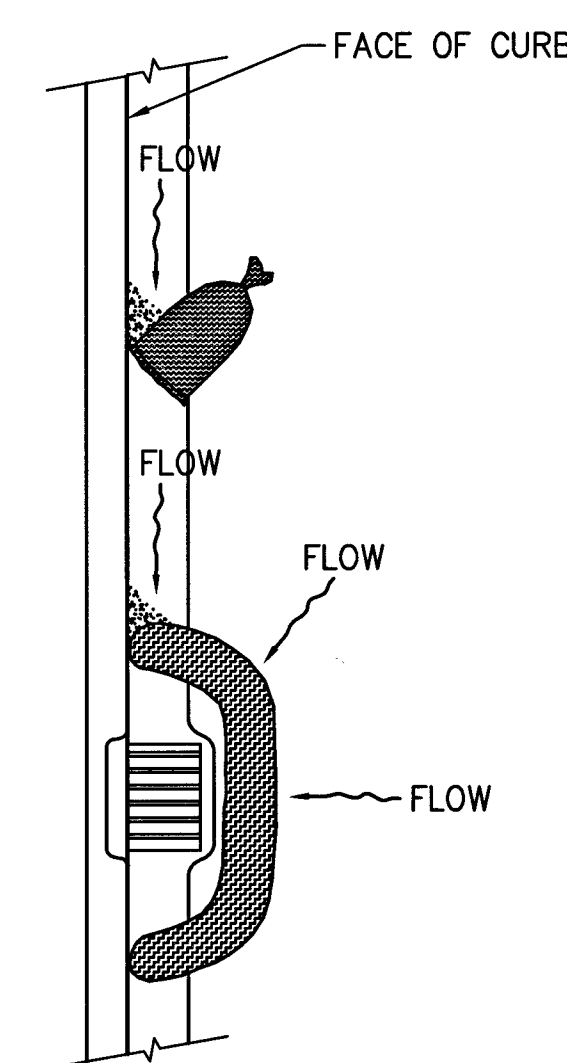



3
5 **SAND BAG / ROLL**
NOT TO SCALE

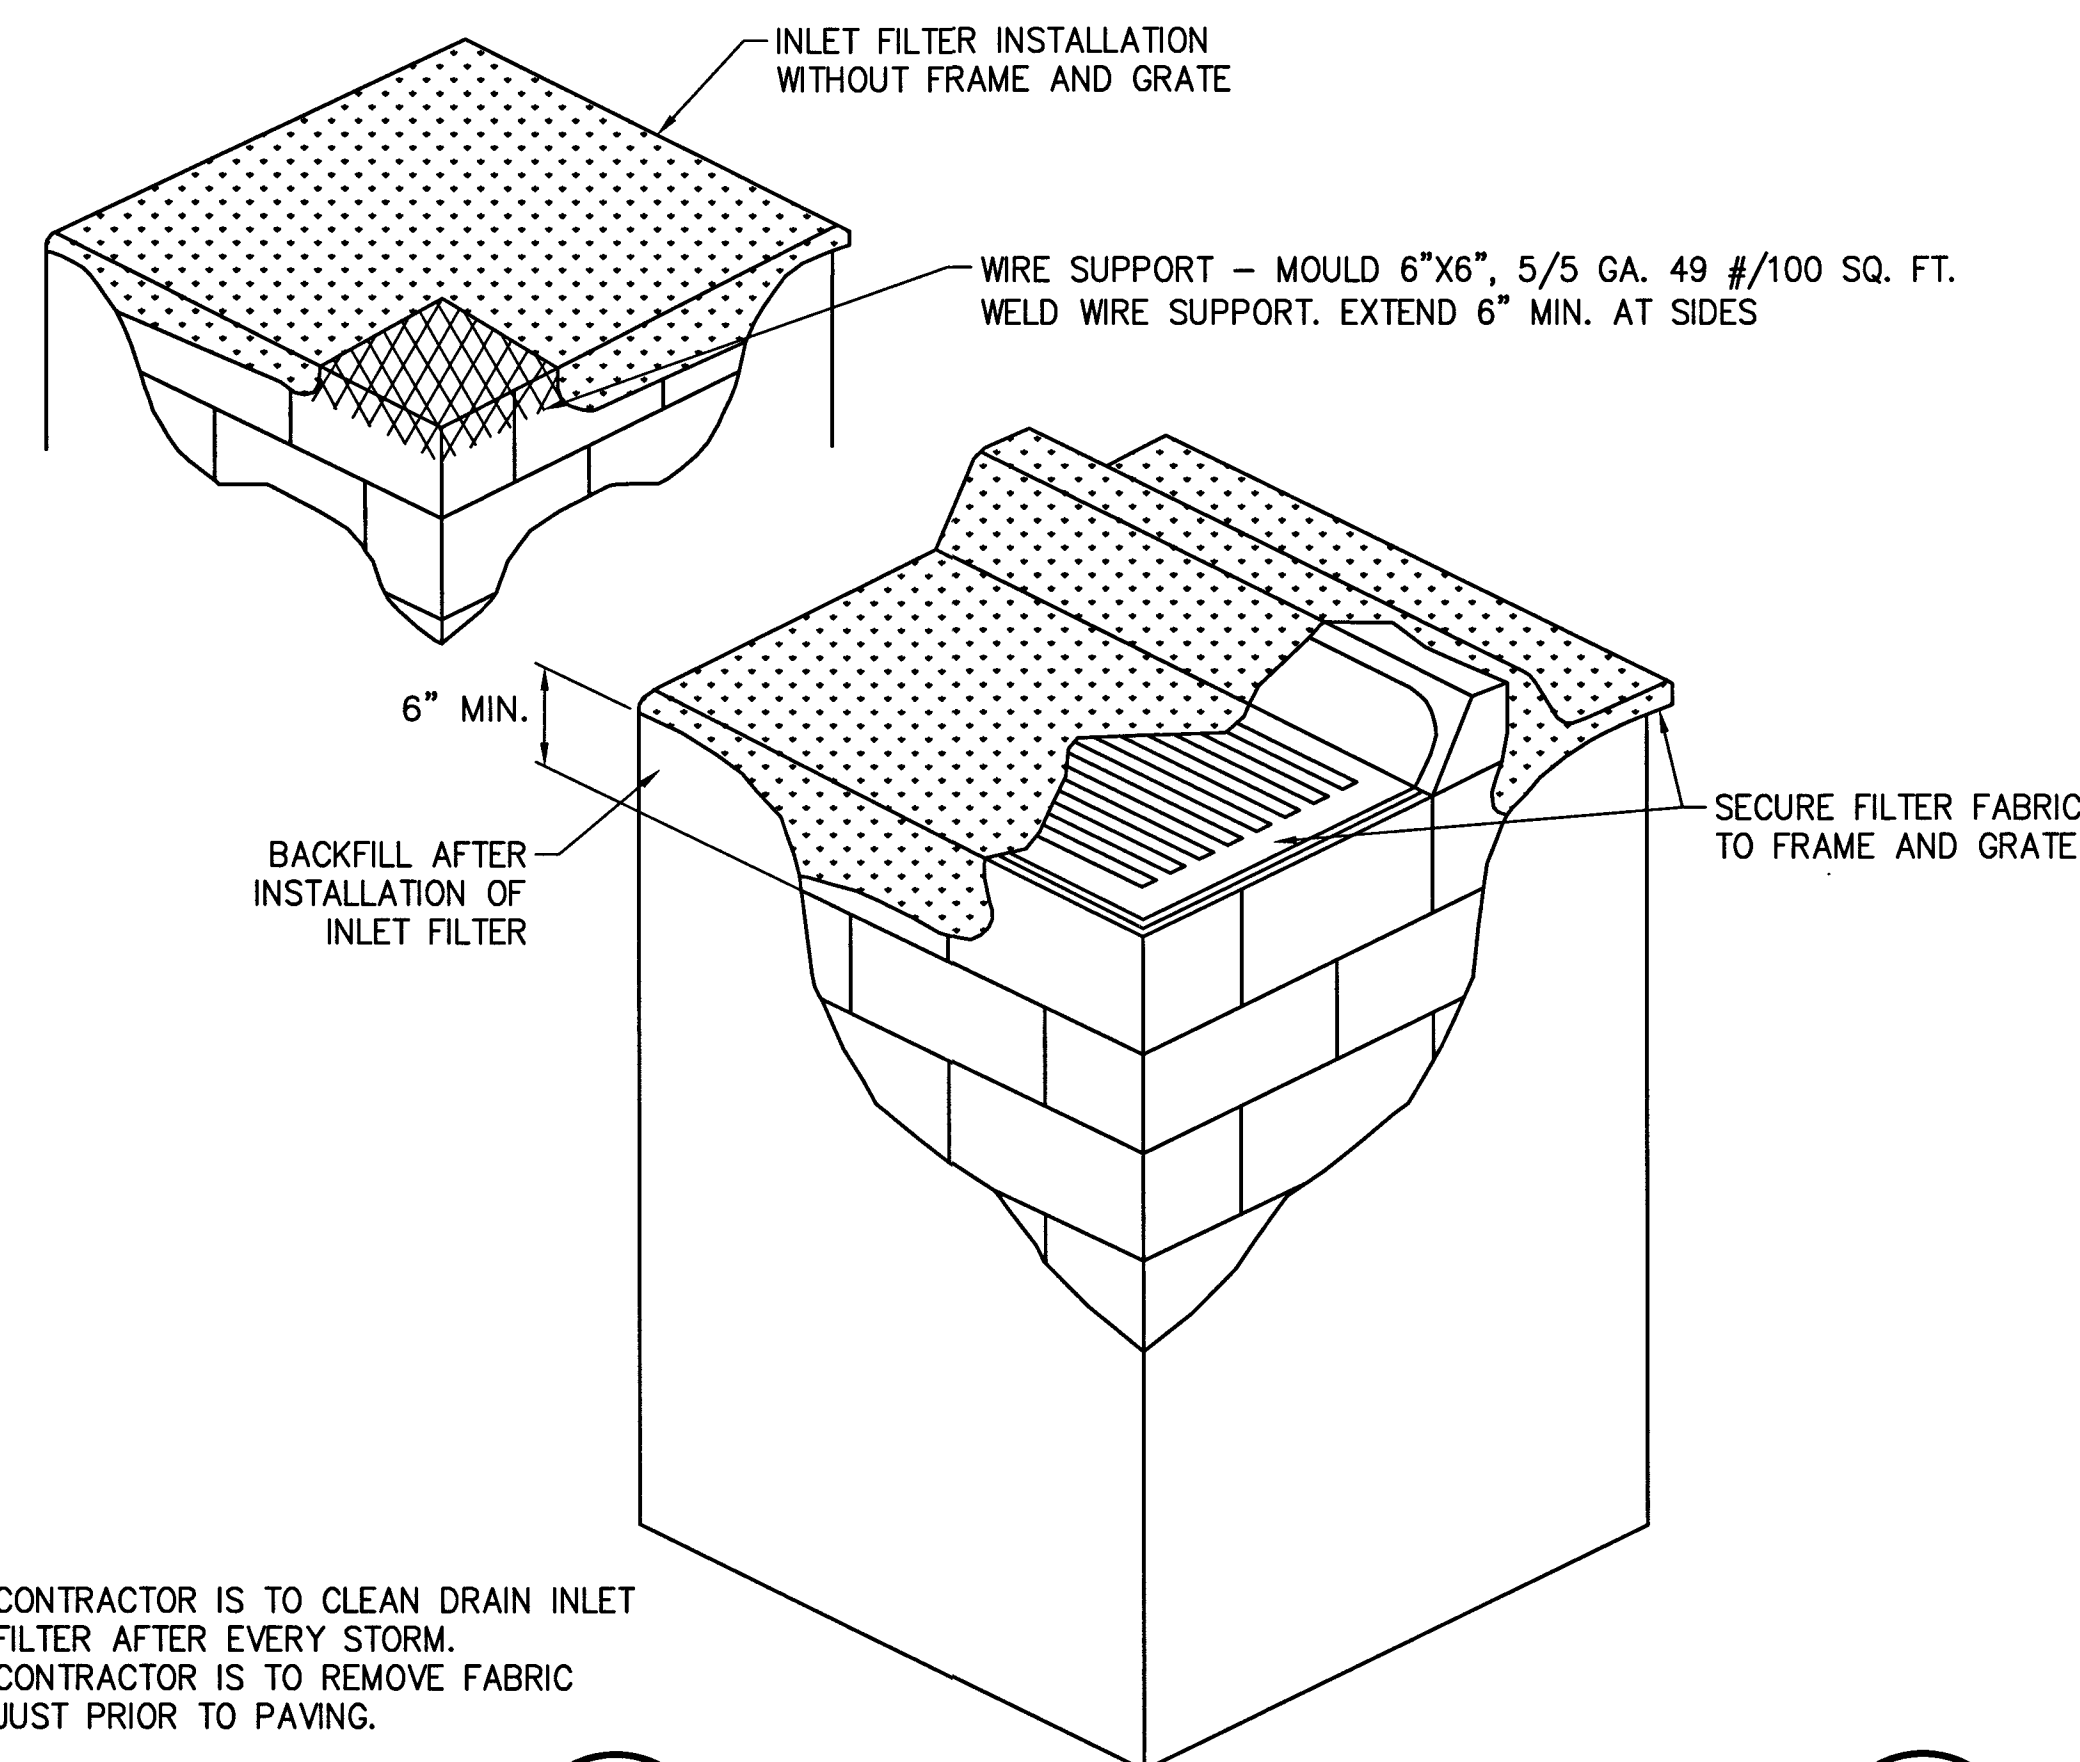

4
5 **DRAIN INLET FILTER**
NOT TO SCALE

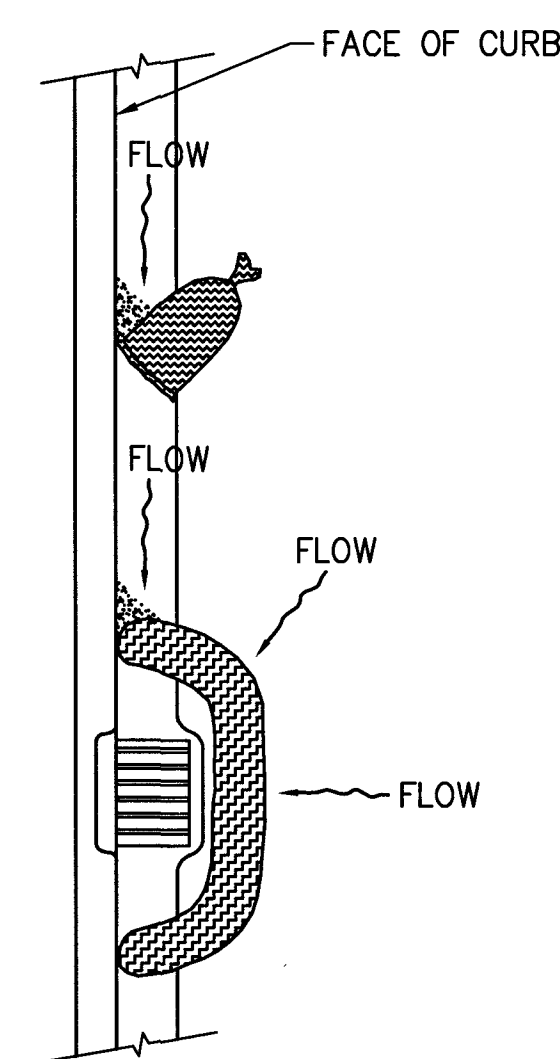

5
5 **GRAVEL BAG / ROLL**
NOT TO SCALE

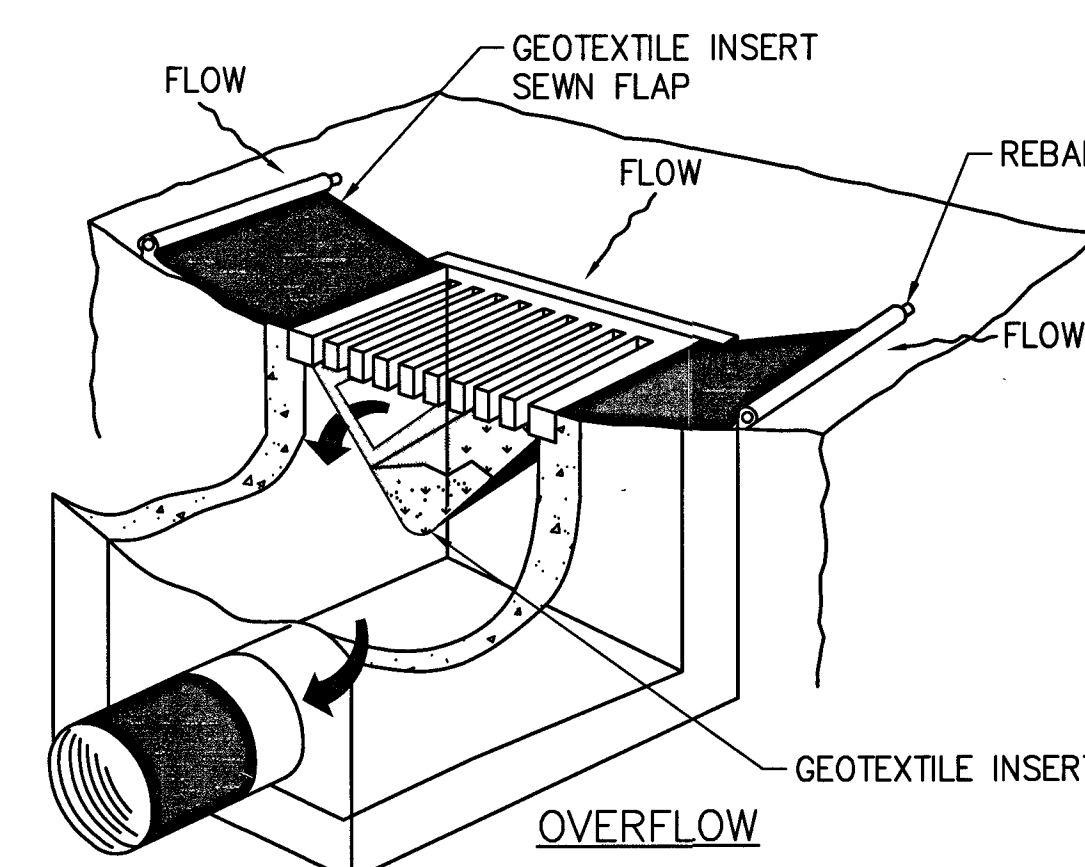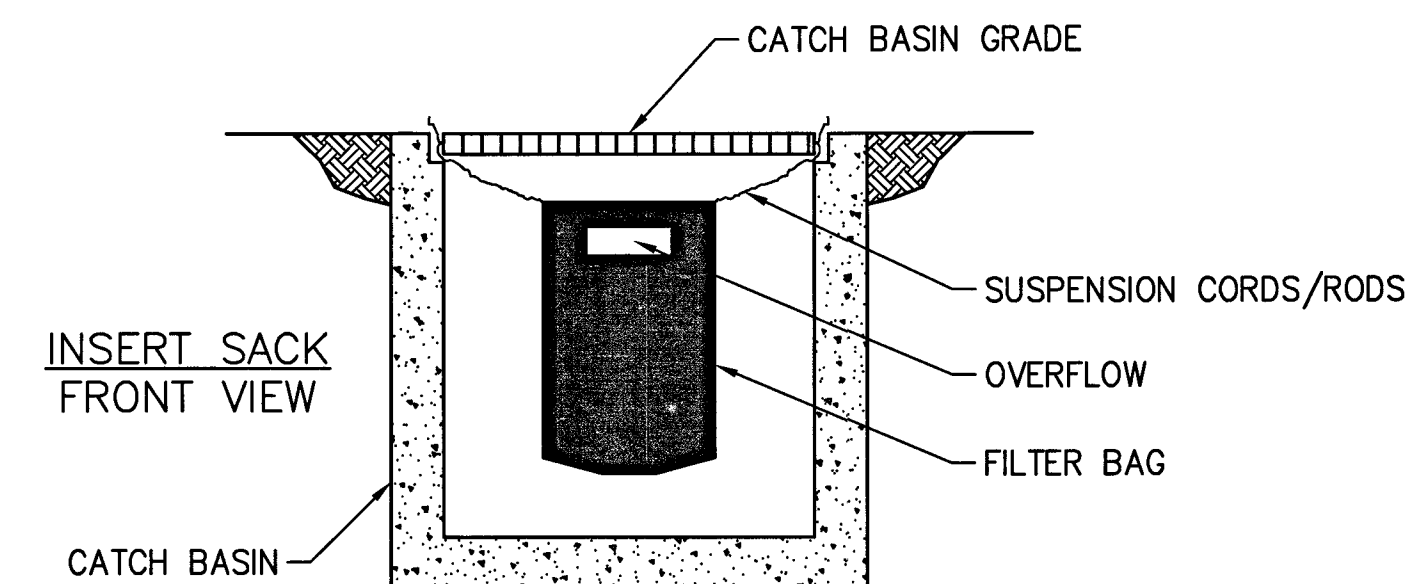


NOTE: RECESSED CURB INLET MUST BE BLOCKED WHEN USING FILTER FABRIC INLET SACKS. SIZE OF FILTER FABRIC INLET SACK TO BE DETERMINED BY MANUFACTURER.

6
5 **SEDIMENT FILTER BAG**
NOT TO SCALE

STORMWATER NOTES

1. SOUTHWEST GAS CORPORATION, IT'S CONTRACTOR, AND/OR THEIR AUTHORIZED AGENTS SHALL INSTALL ONE OF THE APPROPRIATE BMPs FOR THE PROTECTION OF EXISTING STORM DRAIN INLETS, WITHIN OR SIGNIFICANTLY NEAR ANY IMPROVED RIGHT-OF-WAY, FROM DEBRIS AND SEDIMENT RESULTING FROM CONSTRUCTION OF NATURAL GAS FACILITIES.
2. SOUTHWEST GAS CORPORATION, IT'S CONTRACTOR, AND/OR THEIR AUTHORIZED AGENTS SHALL EACH DAY REMOVE ALL SEDIMENT, MUD, CONSTRUCTION DEBRIS, OR OTHER POTENTIAL POLLUTANTS THAT MAY HAVE BEEN DISCHARGED TO, OR ACCUMULATED IN, THE PUBLIC RIGHTS OF WAY OF CLARK COUNTY AS A RESULT OF CONSTRUCTION ACTIVITIES ASSOCIATED WITH THIS SITE DEVELOPMENT OR CONSTRUCTION PROJECT. SUCH MATERIALS SHALL BE PREVENTED FROM ENTERING THE STORM SEWER SYSTEM, USING BEST MANAGEMENT PRACTICES DETAILED ON THIS SHEET.
3. ADDITIONAL CONSTRUCTION SITE DISCHARGE BEST MANAGEMENT PRACTICES MAY BE REQUIRED OF SOUTHWEST GAS CORPORATION, IT'S CONTRACTOR, AND/OR THEIR AUTHORIZED AGENTS DUE TO UNFORESEEN EROSION PROBLEMS OR IF THE LISTED BMPs ON THIS SHEET DO NOT MEET THE PERFORMANCE STANDARDS SPECIFIED IN THE CLARK COUNTY CODE - CHAPTER 24.40/STORM SEWER SYSTEM DISCHARGE AND THE LAS VEGAS VALLEY CONSTRUCTION SITE BMP GUIDANCE MANUAL.
4. ACCUMULATED SEDIMENT IN BMPs SHALL BE REMOVED WITHIN SEVEN DAYS AFTER A STORMWATER RUNOFF EVENT OR PRIOR TO THE NEXT ANTICIPATED STORM EVENT, WHICHEVER IS EARLIER. SEDIMENT MUST BE REMOVED WHEN BMP DESIGN CAPACITY HAS BEEN REDUCED BY 50 PERCENT OR MORE.

- NOTE:
1. CONTRACTOR IS TO CLEAN DRAIN INLET FILTER AFTER EVERY STORM.
 2. CONTRACTOR IS TO REMOVE FABRIC JUST PRIOR TO PAVING.

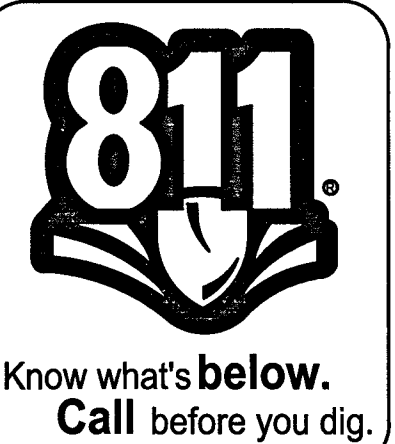

REVISIONS NO. DESCRIPTION BY DATE APPVD				PROPERTY UNITS TAX CODES UNIT NO. UNIT TYPE INSTL. RETIRED PROPOSED COMPLETED				AS-BUILT DRAWING-PRESSURE TEST DATA PIPE DIA. _____ TEST MEDIUM _____ TEST METHOD _____ PIPE LENGTH _____ ☐ AIR ☐ GAUGE PIPE TYPE _____ ☐ NITROGEN ☐ CHART MIN. DURATION _____ ☐ WATER GAUGE/ ☐ SOAP PRESS REC SN# TEST PRES. (PSIG) (MAX) _____ (MIN) _____ TIME (START) _____ (STOP) _____ DATE (START) _____ (STOP) _____ PERFORMED BY: _____ SWGS VERIFIED BY: _____				INDIVIDUAL PERFORMING VISUAL INSPECTION VISUAL INSPECTION CERTIFICATION I HAVE VISUALLY INSPECTED ALL HEATED FUSIONS, SOLVENT CEMENT, MECHANICAL JOINTS, AND WELDS THAT HAVE PERFORMED NAME _____ DATE _____ SEE SHEET 3				CONSTRUCTION INSPECTOR _____ FOREMAN _____ REVIEWED BY _____ SEE SHEET 3				PERMIT INFORMATION CITY OF LAS VEGAS TAX CODE: 02-0200				ISOLATION AREA DIST_328 W.R. NO. 3376796				ENGINEER/TECH: KAELAN TANIGAWA ACCOUNT REP: GARTH BRETON PROJECT CONTACT: DAVE WAGNER SHEET NO: 5 OF 5 DWN. BY: BC&F SCALE: NTS CHKD. BY: _____ DATE: 01/24/2018 APPVD. BY: _____				LOCATION SEC 19 T19S R60E M.D.M. ATLAS #/TILE # x579y558				C DEER SPRINGS HUALAPAI TYPICAL SWPPP BMPs DETAILS 107x5000 L-69418			
---	--	--	--	---	--	--	--	--	--	--	--	---	--	--	--	---	--	--	--	---	--	--	--	---	--	--	--	--	--	--	--	---	--	--	--	---	--	--	--

