

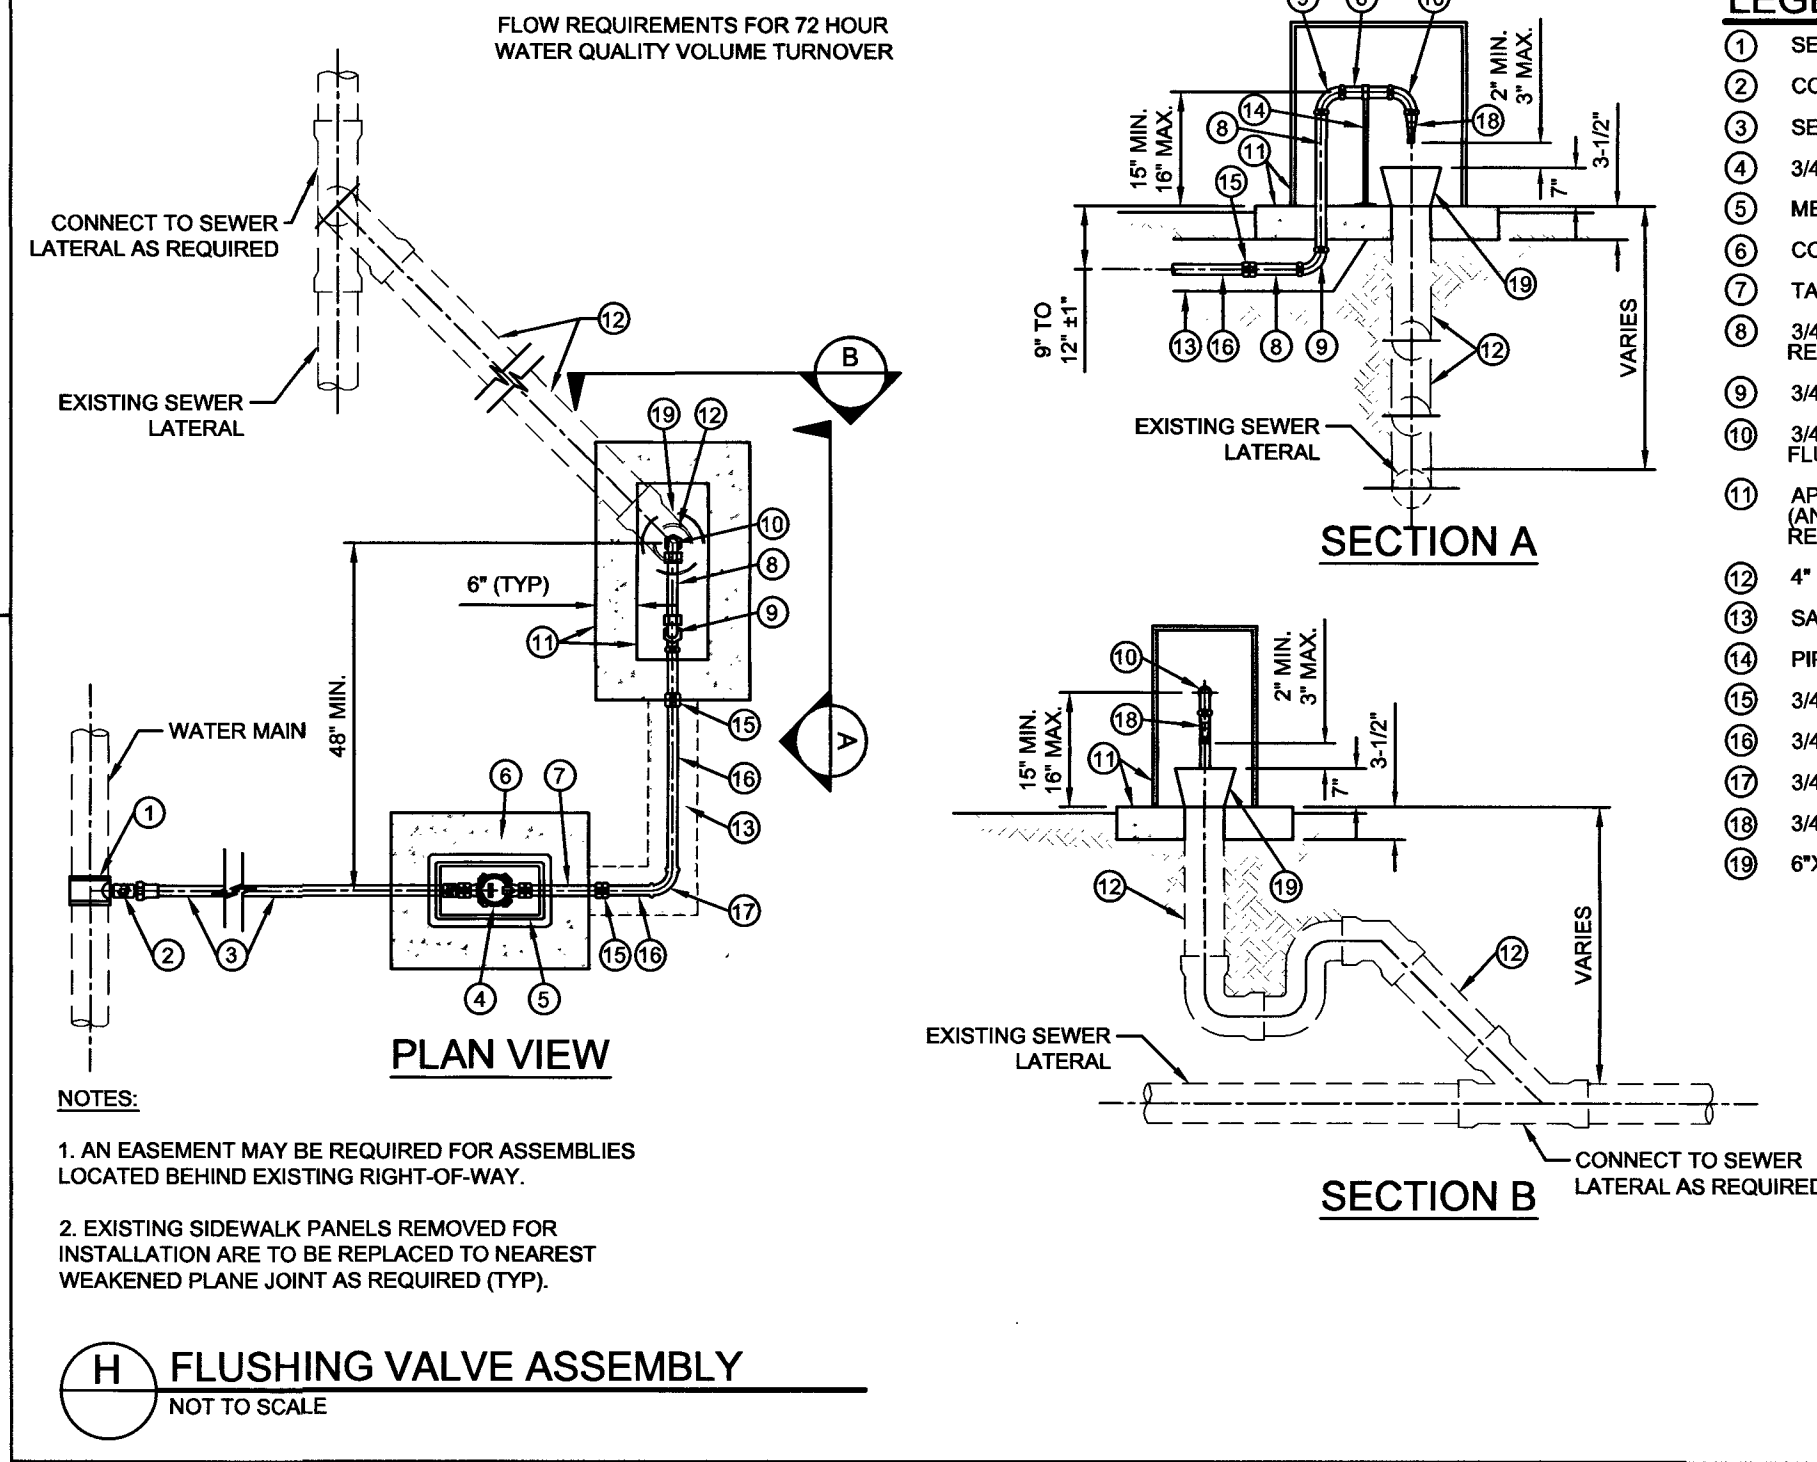
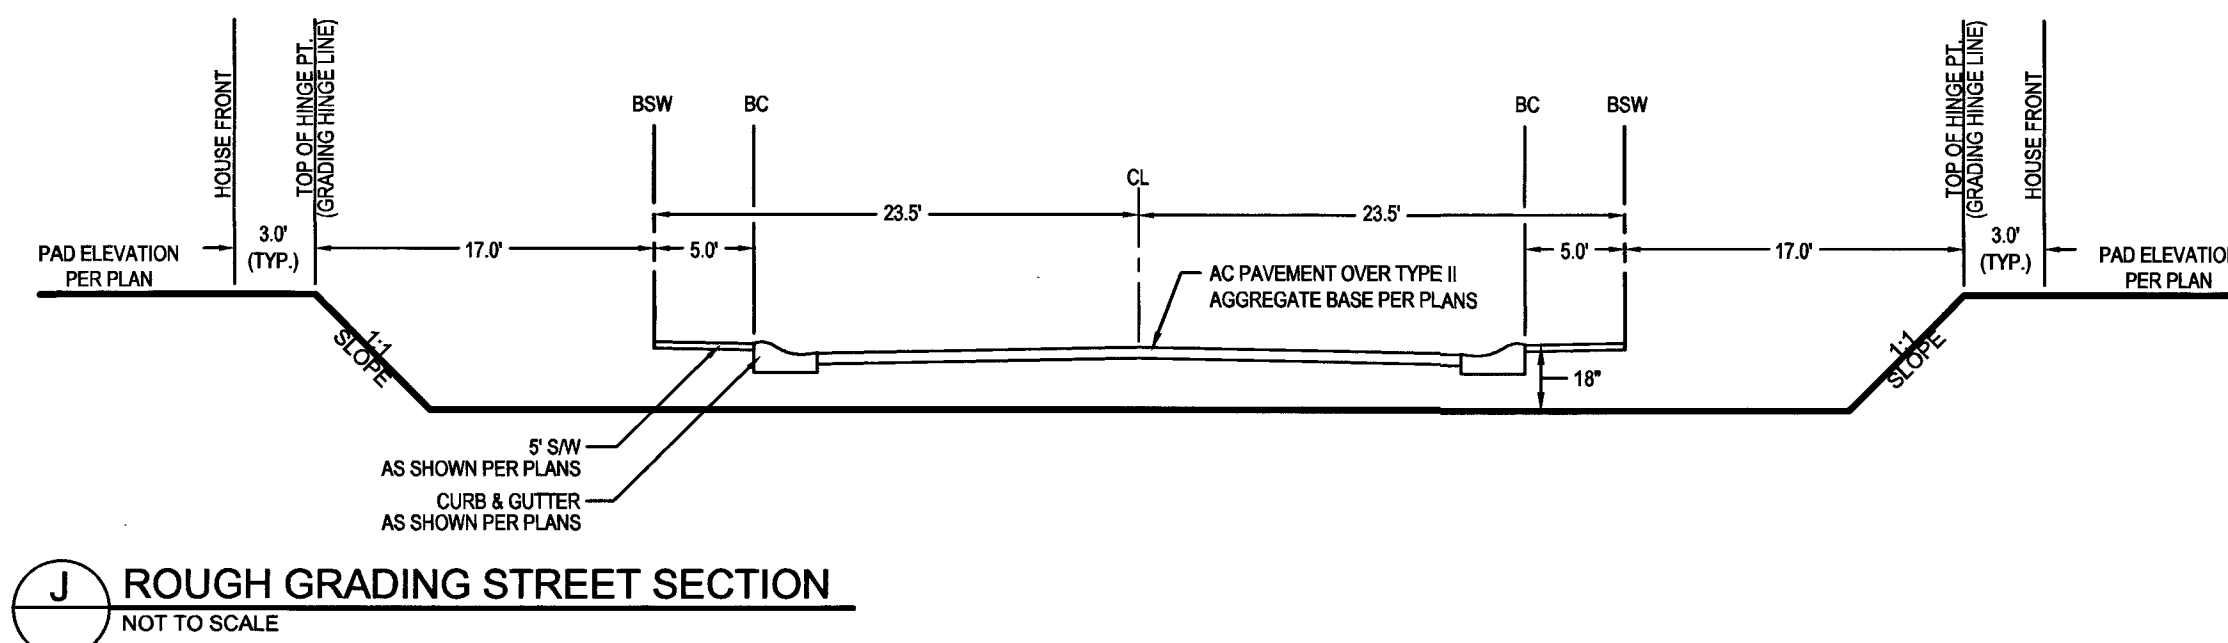
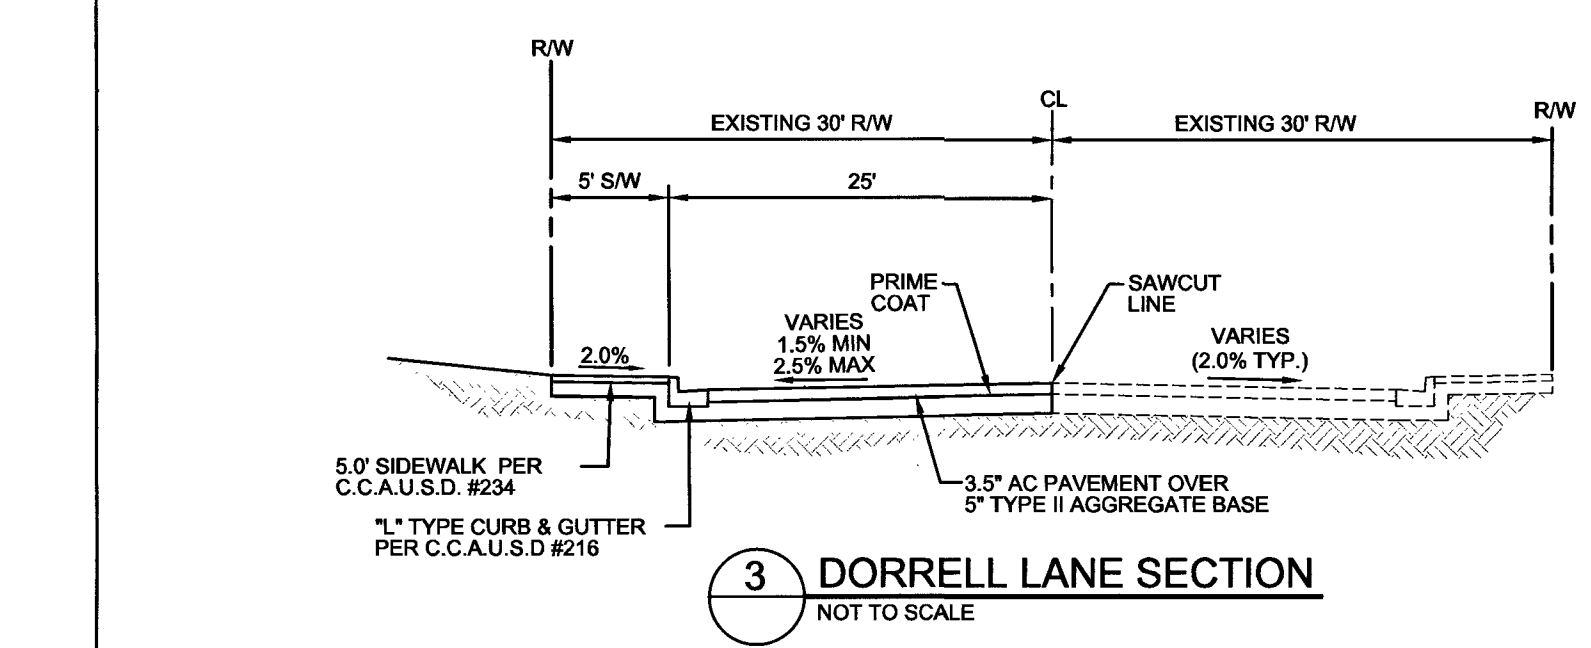
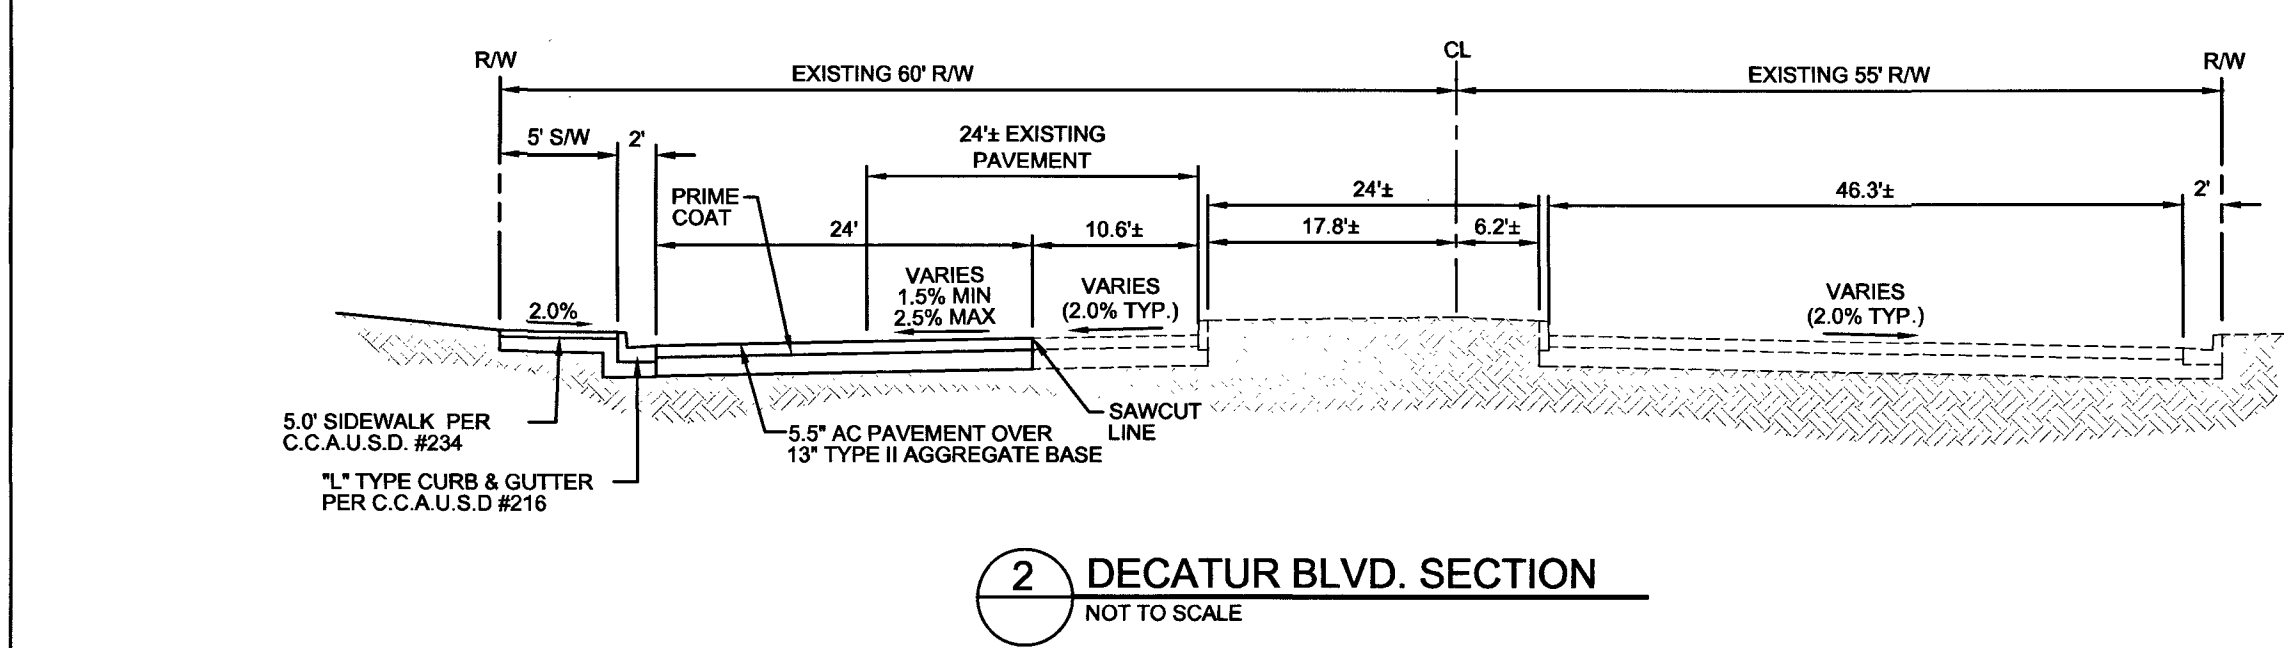
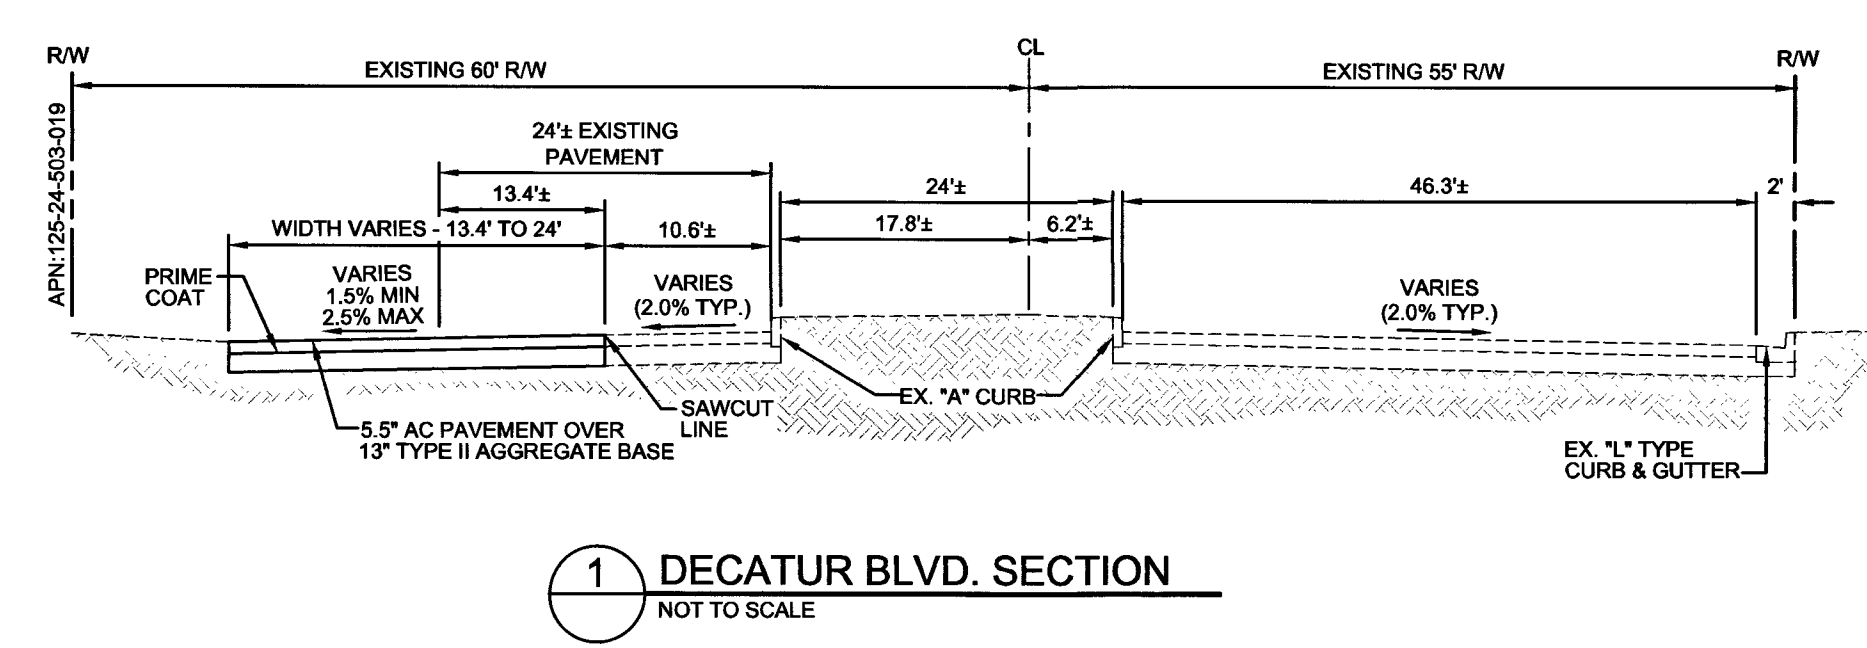
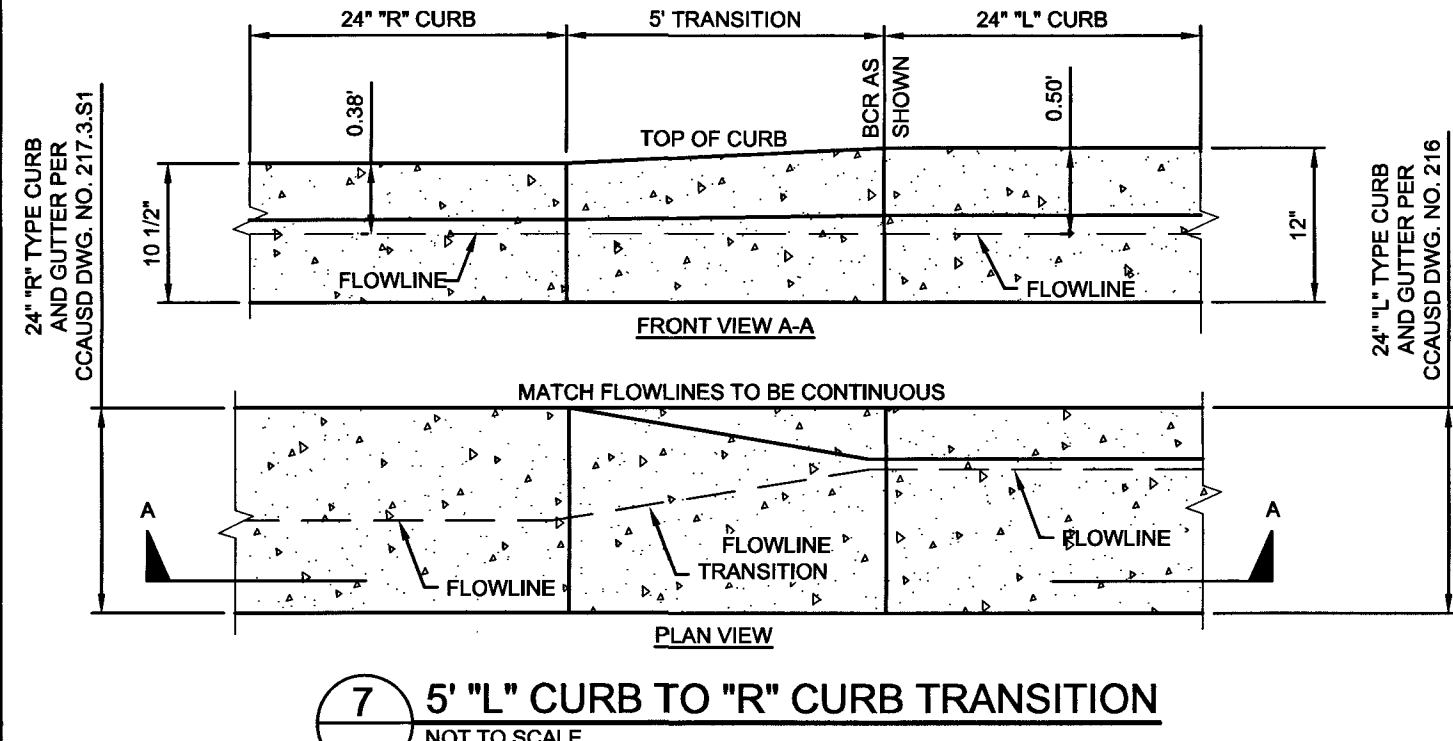
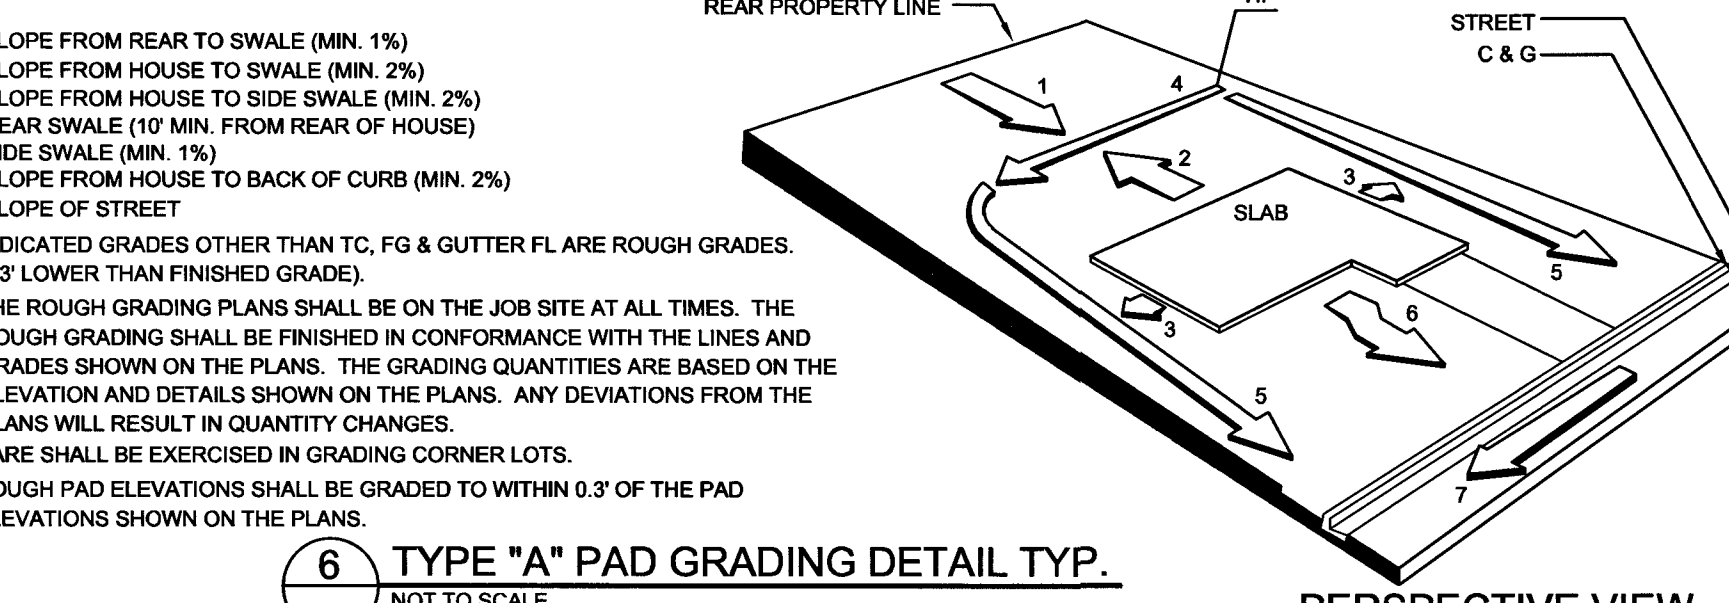
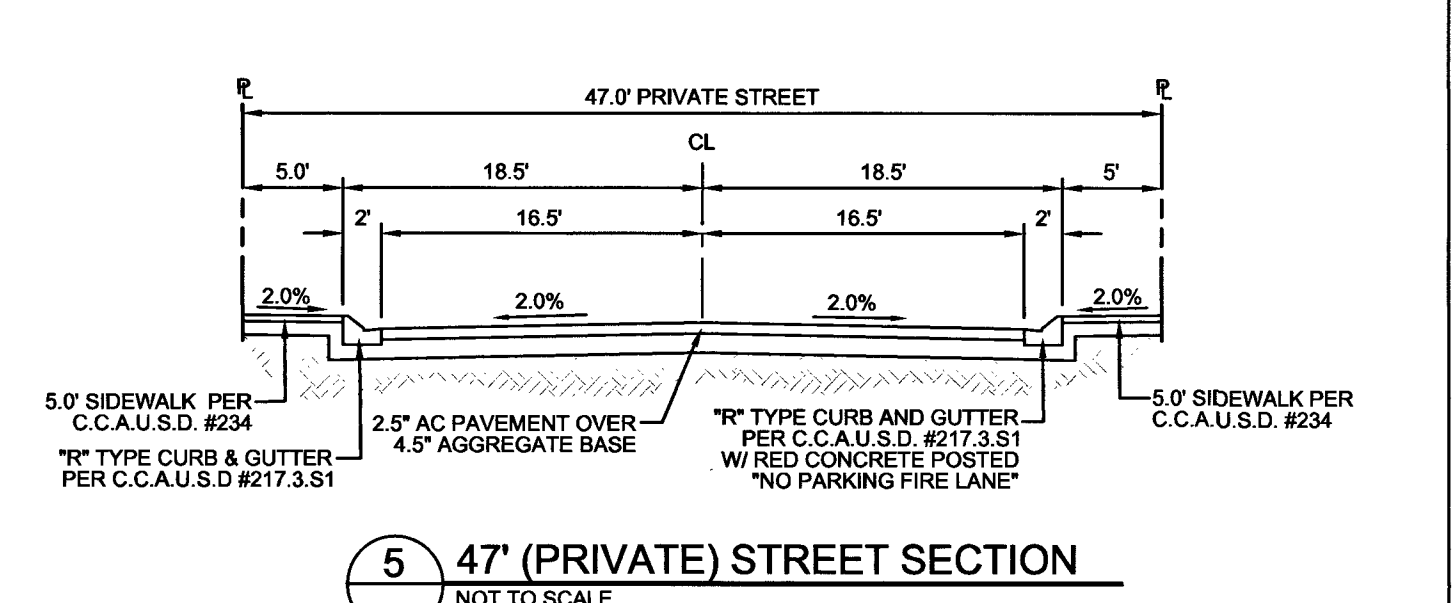
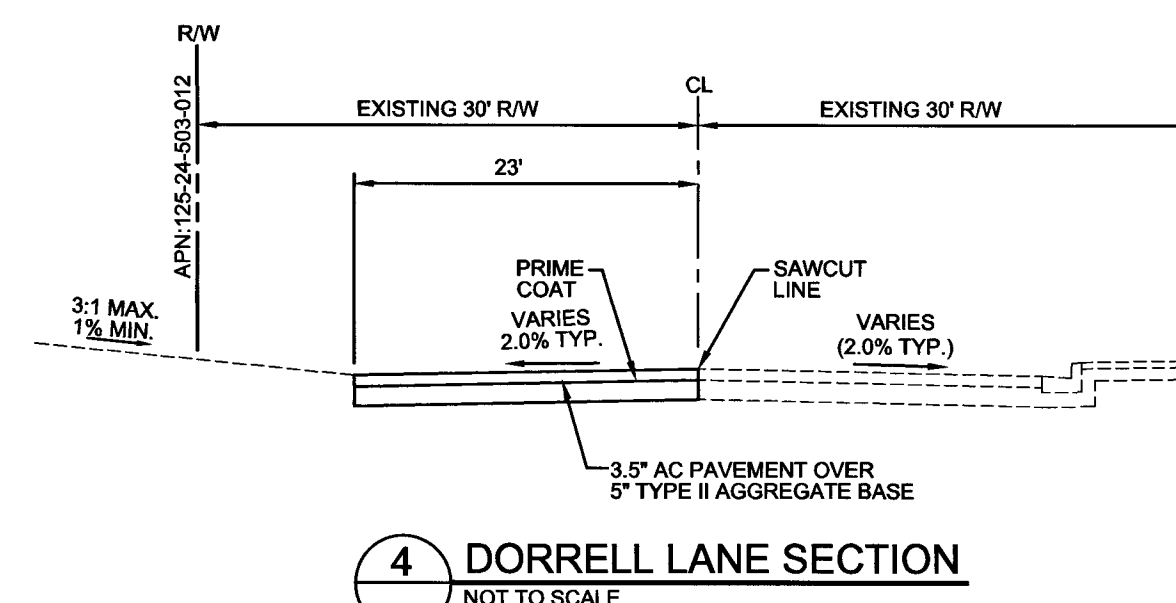
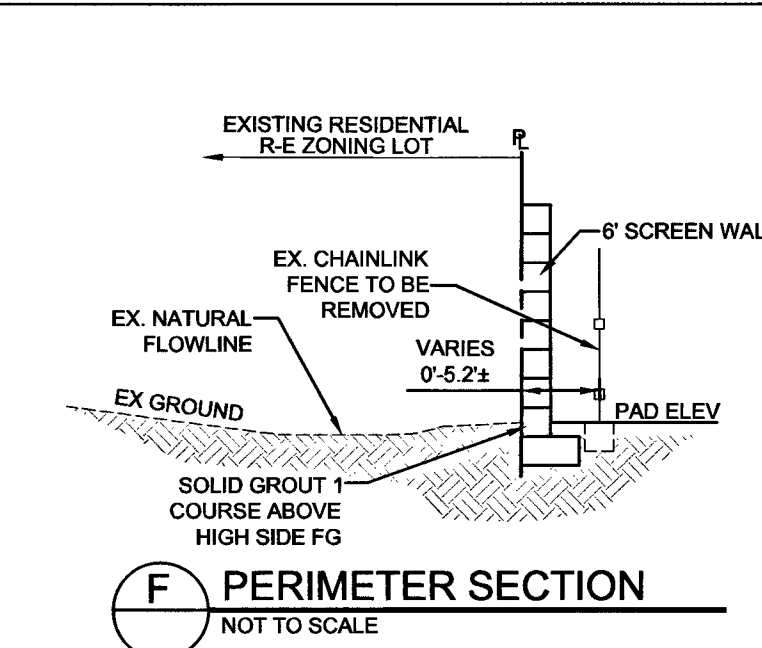
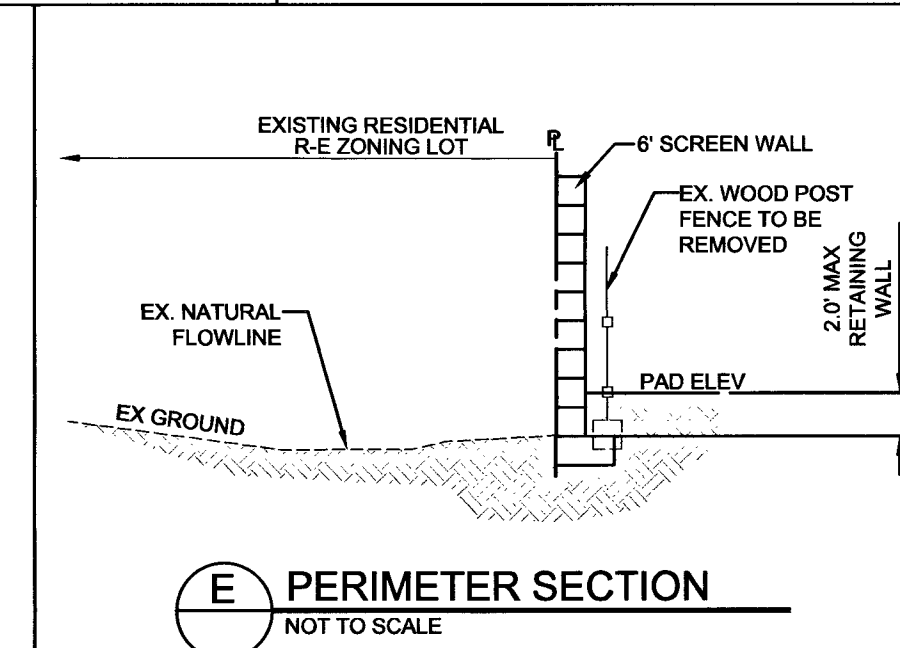
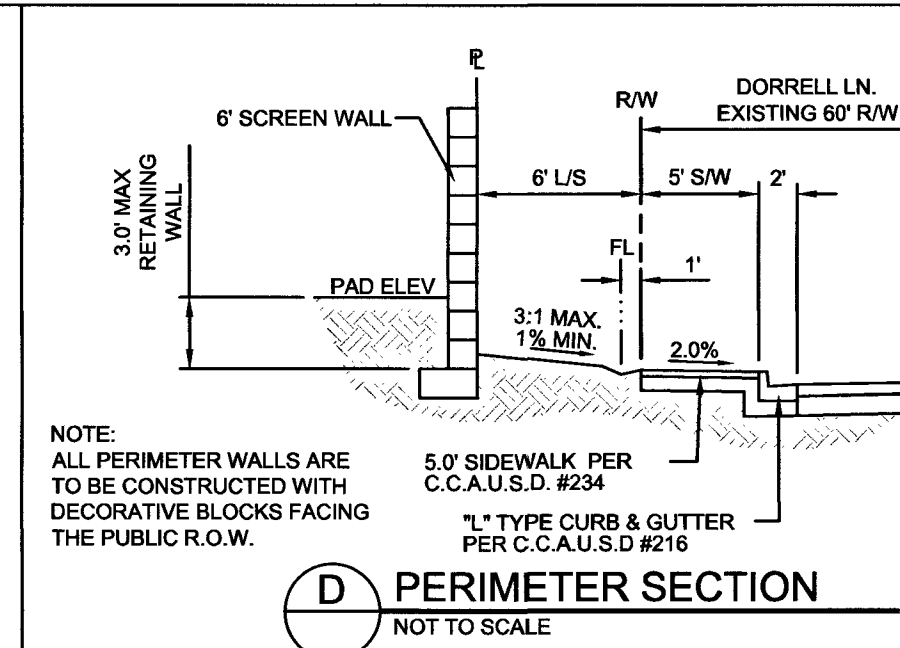
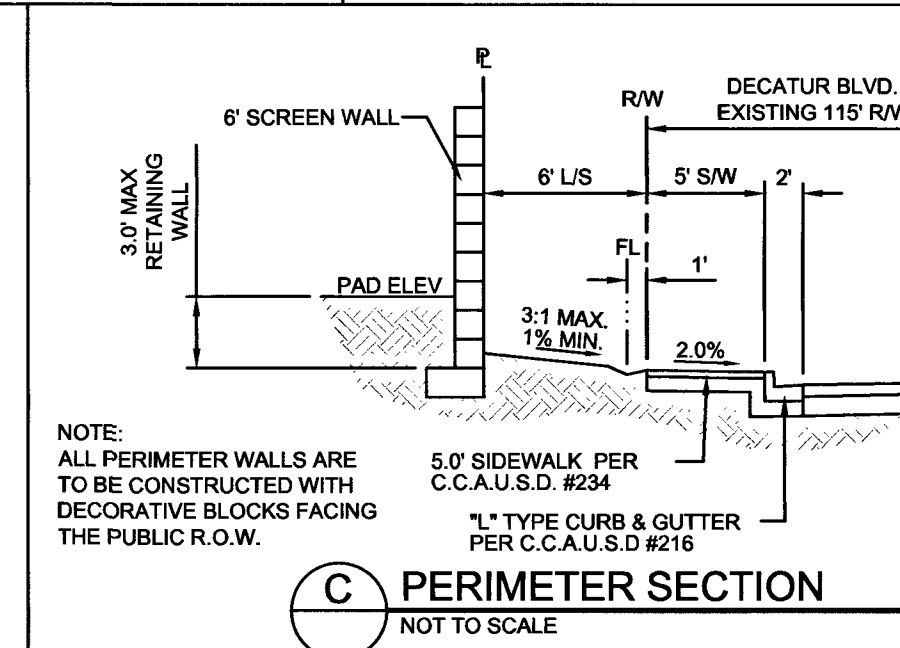
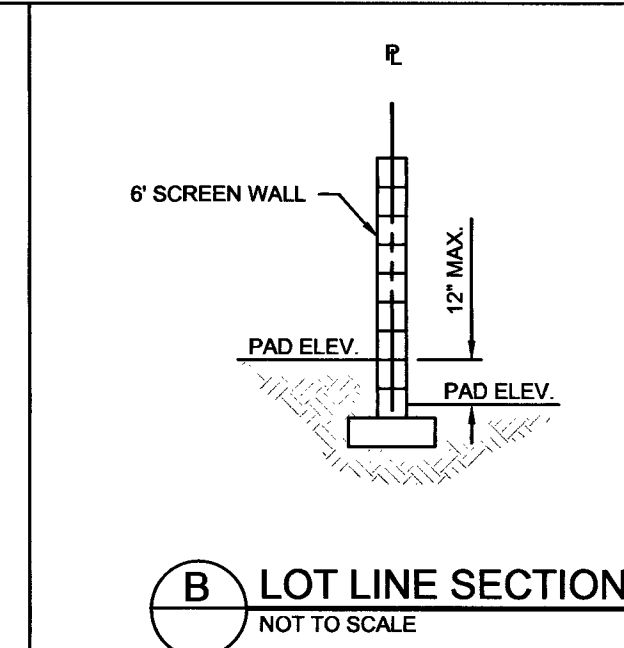


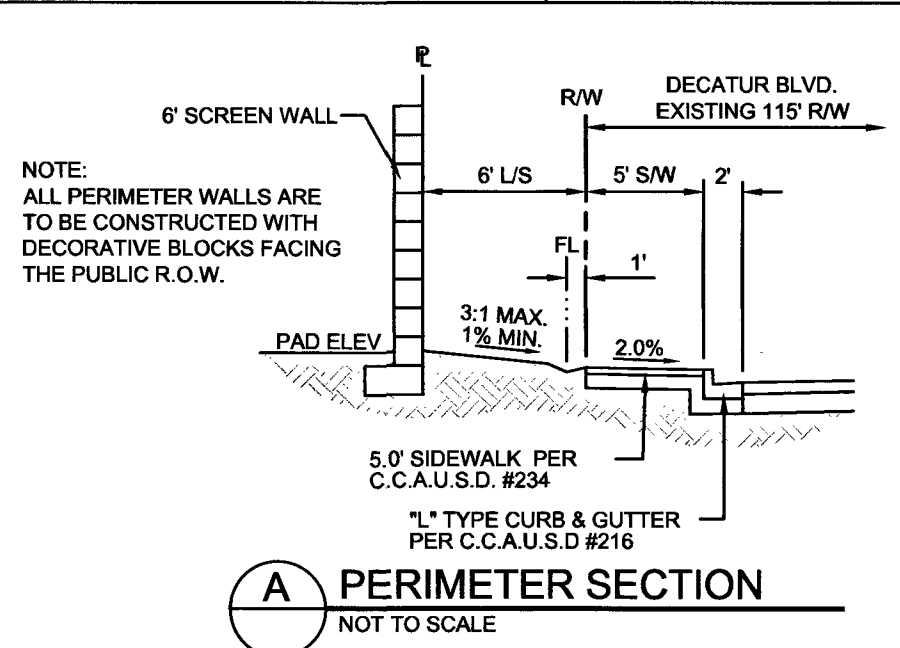

- LEGEND**
- 1 SERVICE SADDLE
 - 2 CORPORATION STOP
 - 3 SERVICE LATERAL
 - 4 3/4" WATER METER
 - 5 METER BOX
 - 6 CONCRETE COLLAR OR SIDEWALK PANEL
 - 7 TAILPIECE
 - 8 3/4" BRASS PIPE THREADED ON BOTH ENDS (LENGTH AS REQUIRED)
 - 9 3/4" BRASS 90° BEND (FEMALE THREAD X FEMALE THREAD)
 - 10 3/4" BRASS 90° BEND (FEMALE THREAD X MALE THREAD), FOR FLUSHING VALVE CONNECTION
 - 11 APPROVED FIBERGLASS ENCLOSURE AND CONCRETE PAD (ANCHOR TO CONCRETE PAD PER MANUFACTURER'S REQUIREMENTS)
 - 12 4" PVC SEWER LATERAL
 - 13 SAND BACKFILL FULL WIDTH OF TRENCH
 - 14 PIPE SUPPORT AS REQUIRED
 - 15 3/4" COUPLING
 - 16 3/4" PVC PIPE (SCH 40), LENGTH AS REQUIRED
 - 17 3/4" PVC (SCH 40) 90° BEND
 - 18 3/4" BALL VALVE (APOLLO MODEL 77CLF-100)
 - 19 6"X4" PVC REDUCER

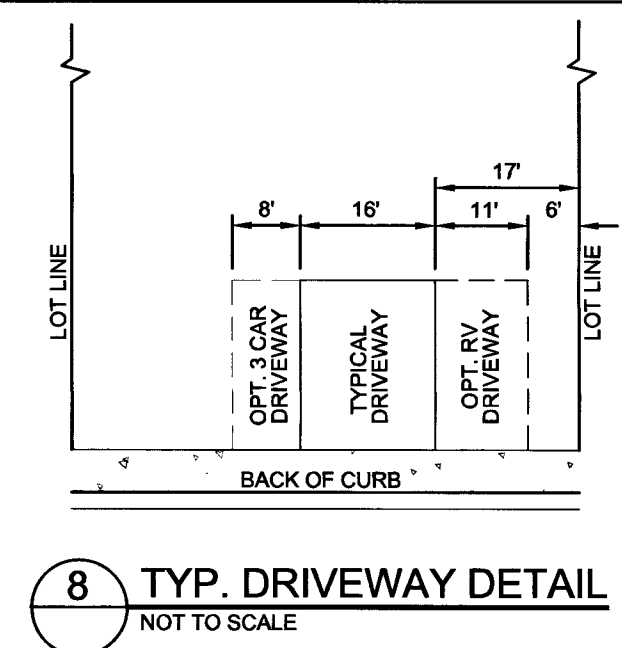

- WALL NOTES**
1. WALL DETAILS ARE FOR REFERENCE ONLY AND DO NOT CONSTITUTE A STRUCTURAL DESIGN.
 2. CONSTRUCTION OF BLOCK WALLS REQUIRE A SEPARATE BUILDING PERMIT AND APPROVAL BY THE BUILDING DEPARTMENT.
 3. ALL PERIMETER WALLS TO BE CONSTRUCTED WITH DECORATIVE BLOCK FACING THE PUBLIC R.O.W.

APPROVED FOR CONSTRUCTION

LAS VEGAS VALLEY WATER DISTRICT ENGINEERING SERVICES

PROJECT NO. 135002 FIRST APPROVED DATE: 10/10/18

L/VVWD APPROVED FIRE FLOW 1750 GPM AT 20 PSI RESIDUAL MAXIMUM AVAILABLE FIRE SPRINKLER FLOW 0 GPM

SHEETS: C1, C2, C4 THRU C9

L18-00903 107Y5067-2

DETAIL SHEET

DECATUR DONALD II

BEAZER HOMES

CITY OF LAS VEGAS, NEVADA

DATE	DESCRIPTION
07/19/2018	RWF
07/19/2018	RWF
07/19/2018	ALW/DCL
07/19/2018	BZ011803

ENGINEER - STATE

DARRY L. LATTIMORE

EXP. 12/31/19

CIVIL

PROJ. # 135002-A, QS-125-24-NE


SHEET #

DETAILS

SHEET NUMBER

C4

SHT. 4 OF 10

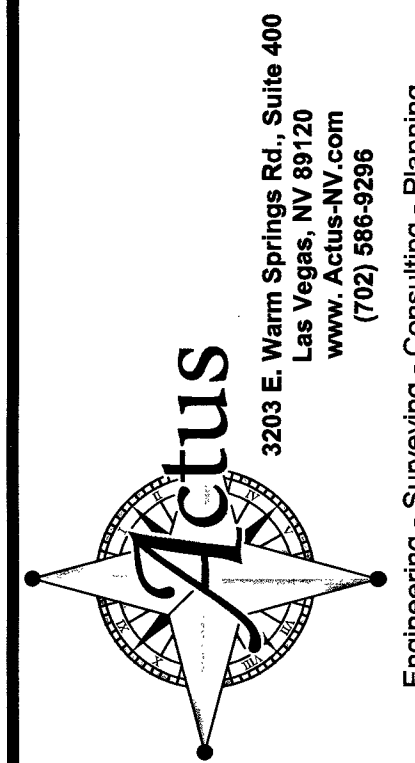

SHI.7 OF 10

AVOID HITTING OVERHEAD POWER LINES. IT'S COSTLY

CALL BEFORE YOU DO OVERHEAD

1-702-227-2929

 
APPROVED FOR CONSTRUCTION


LAS VEGAS VALLEY WATER DISTRICT ENGINEERING SERVICES




PROJECT NO. 135002 FIRST APPROVED DATE: 10/10/18

LYVWD APPROVED FIRE FLOW 1750 GPM AT 20 PSI RESIDUAL
MAXIMUM AVAILABLE FIRE SPRINKLER FLOW 0 GPM

SHEETS:
C1, C2, C4 THRU C9



   I CERTIFY THAT THIS GRADING PLAN IS IN CONFORMANCE WITH THE APPROVED UPDATED DRAINAGE STUDY CLV# DS4975 ON FILE WITH THE CITY OF LAS VEGAS.



CURVE #	LENGTH	RADIUS	DELTA	TANGENT
C1	45.89'	30.00'	87.64°	28.79
C2	17.62'	20.00'	50.48°	9.43
C3	198.60'	40.50'	280.96°	33.41
C4	17.62'	20.00'	50.48°	9.43
C5	48.36'	30.00'	92.36°	31.26
C6	45.89'	30.00'	87.64°	28.79


CLINT H.
SOUTHWEST GAS CORPORATION

Las Vegas Valley Water District Engineering Services

PROJECT NO. 130002 FIRST APPROVED DATE: 10/10/18

LVWWD APPROVED FIRE FLOW 1750 GPM AT 20 PSI RESIDUAL
MAXIMUM AVAILABLE FIRE SPRINKLER FLOW 0 GPM

SHEETS:
C1, C2, C4 THRU C9

SOUTHWEST GAS CORPORATION

7/20/16
DATE

DATE 7/25/18 L18-00903

C8

SHT. 8 OF 10

CITY OF LAS VEGAS, NEVADA

SHEET TITLE
PLAN & PROFILES
 SHEET NUMBER

C8



