


CITY OF LAS VEGAS DETENTION CENTER

3300 STEWART AVE. - BUILDING 1 & 2

LAS VEGAS, NEVADA 89101

EDS ELECTRONICS INC.
 2675 WEST CHEYENNE AVENUE
 NORTH LAS VEGAS, NV. 89032
 PHONE: (702) 871-3733
 FAX: (702) 871-3199
 CONTRACTORS LICENSE: 35144A
 LICENSE LIMIT \$950,000.00

NO.	DATE	REVISION	BY

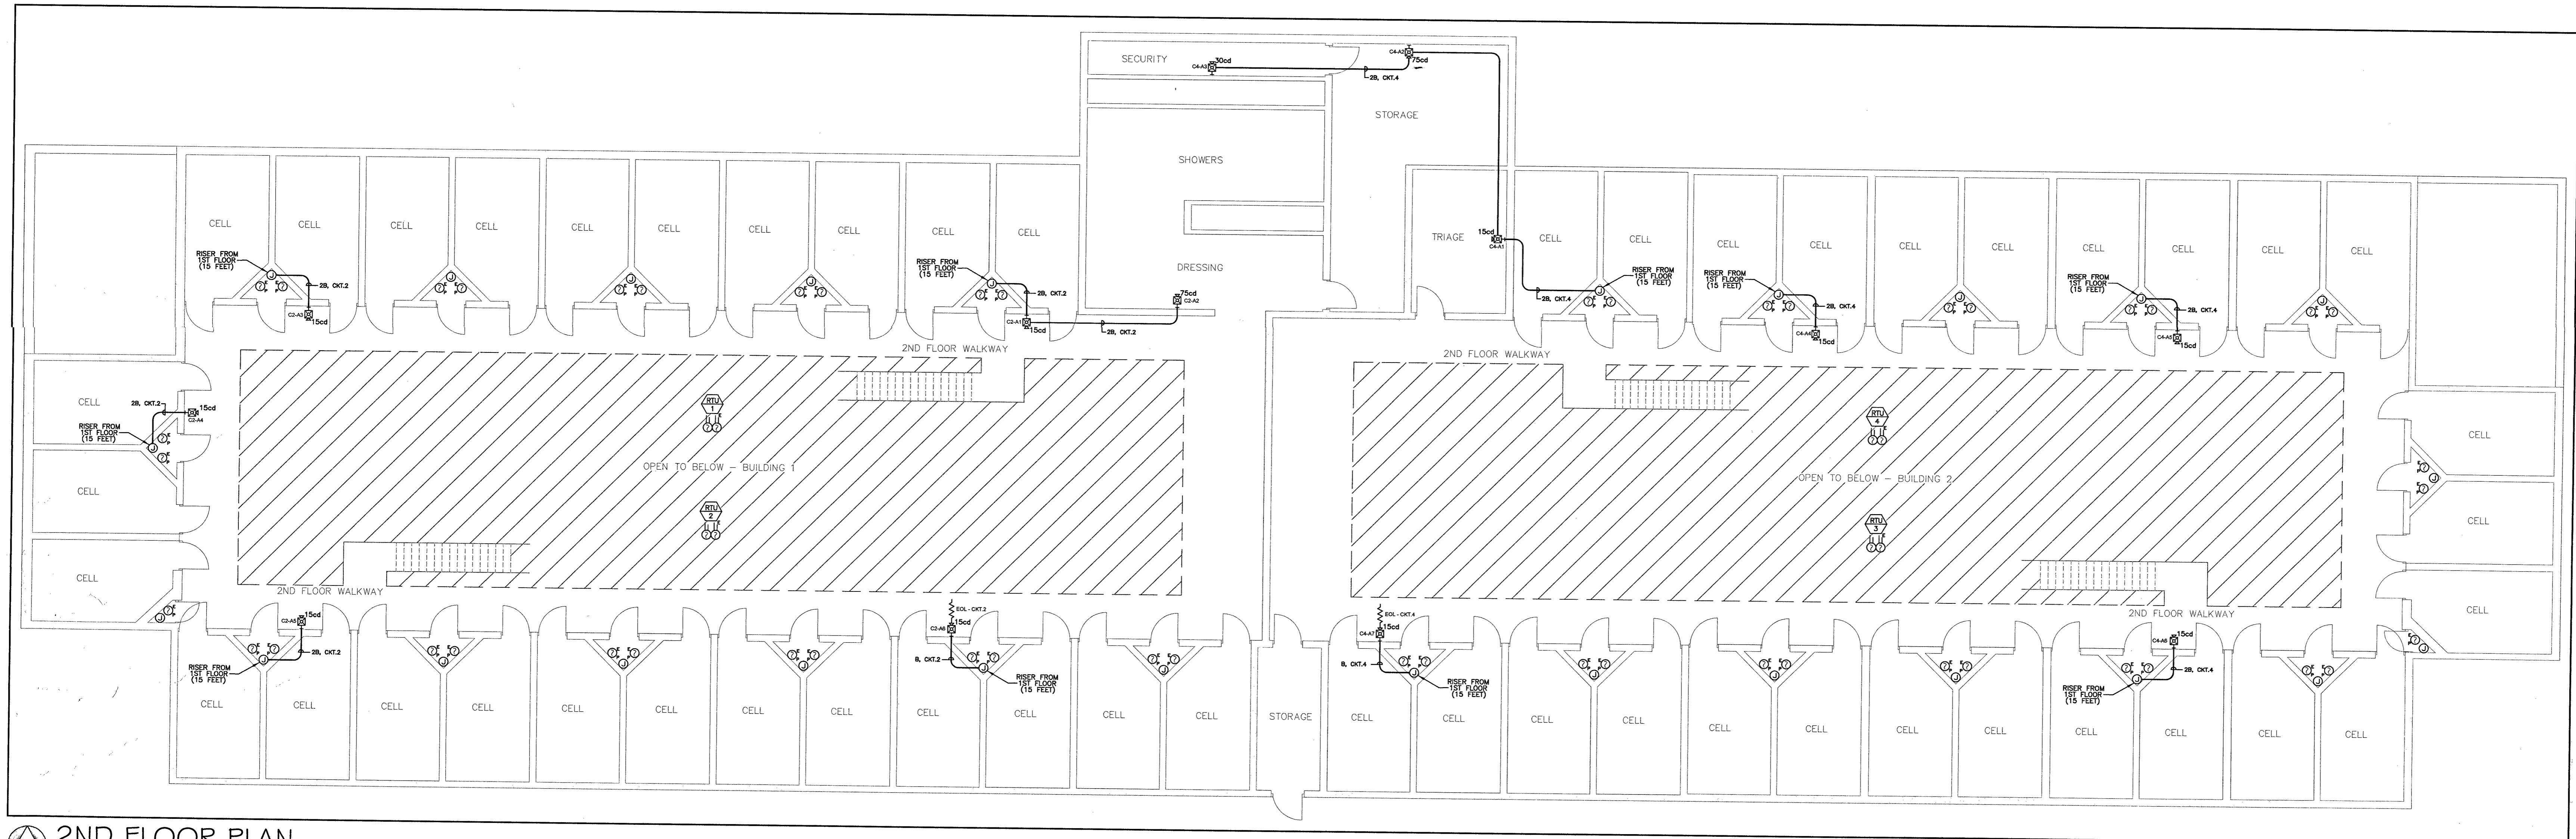

2ND FLOOR PLAN
 SCALE: 1/8" = 1'-0"

For the mechanical & electrical rooms, audible alarm signals shall either have a sound level at least 15 dB above the average ambient sound level per NFPA 72 '02 § 7.4.2.1, or 80 dB as required by CLV Ordinance #5667, whichever is higher. If this sound level is not achieved, then add strobe device(s) as allowed by NFPA 72 '02 § 7.4.2.2.

The visible notification appliances must be of a type, size, intensity, and number so that the operating effect of the appliance is seen by the intended viewers regardless of the viewer's orientation (including the areas behind curtains) per [NFPA 72 § 7.4.2.1].


CITY OF LAS VEGAS DETENTION CENTER
3300 STEWART AVE. BUILDING 1 & 2
LAS VEGAS, NEVADA 89101

F.C.P.S. N.A.C. KEY:

CF-A# NOTIFICATION APPLIANCE NUMBER
 NOTIFICATION CIRCUIT NUMBER

WIRE LEGEND:

B = 2 #14 THHN SOLID COPPER (N.A.C.) CLASS B / STYLE Y

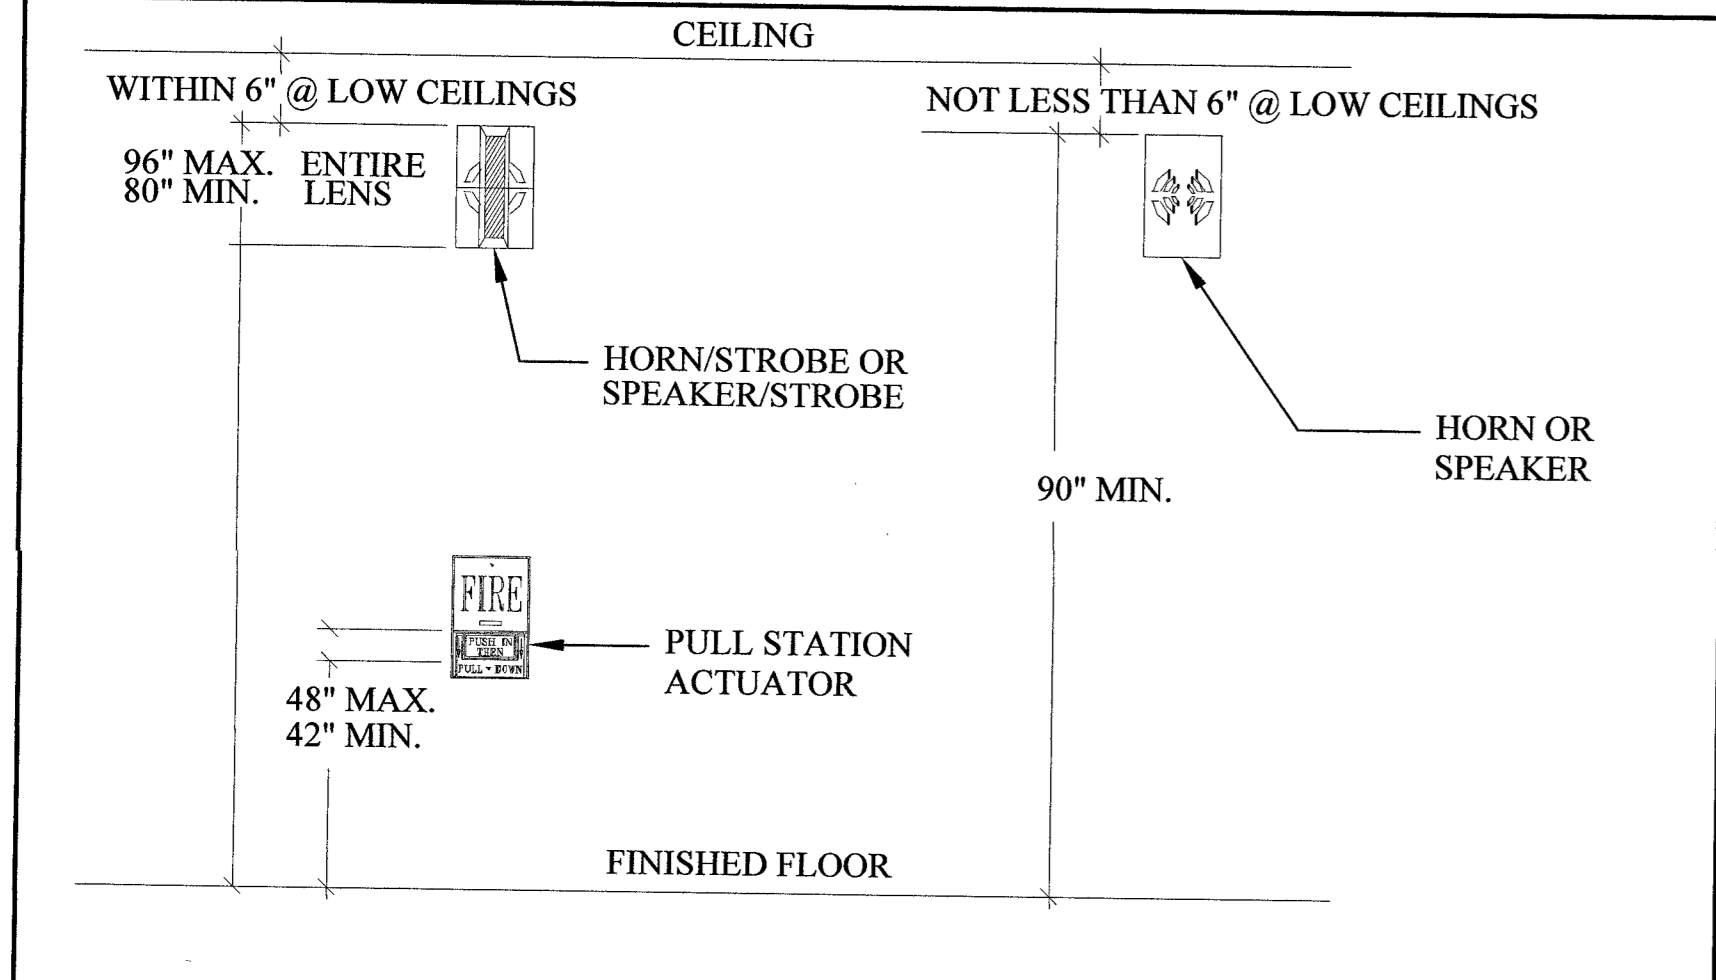

WALL MOUNTING HEIGHT DETAIL

ACTION:	REACTION:				
	ACTIVATION OF ALL NOTIFICATION APPLIANCES	WILL NOT ACTIVATE ANY NOTIFICATION APPLIANCES	WATER FLOW SIGNAL TO ON-SITE DISPATCH CENTER	SUPERVISORY SIGNAL TO ON-SITE DISPATCH CENTER	FIRE ALARM SIGNAL TO ON-SITE DISPATCH CENTER
ACTIVATION OF ANY WATER FLOW SWITCH	X	X	X	X	X
ACTIVATION OF ANY TAMPER VALVE	X	X	X	X	X
ACTIVATION OF ANY SMOKE DETECTOR	X	X	X	X	X
ACTIVATION OF MANUAL PULL STATION	X	X	X	X	X
ACTIVATION OF ANY DUCT DETECTOR	X	X	X	X	X
TROUBLE AT FIRE ALARM PANEL	X	X	X	X	X

REVIEWED BY: LAS VEGAS FIRE DEPARTMENT
 CHECKED FOR INSTALLATION AS SUBMITTED
 RELEASE FOR INSTALLATION AS NOTED
 REVISE AND RESUBMIT

THIS REVIEW DOES NOT CONSTITUTE PERMISSION TO VIOLATE ANY CITY, STATE OR FEDERAL LAWS, ORDINANCES, ULTIMATE RESPONSIBILITY FOR COMPLIANCE RESTS WITH THE OWNER.

FINAL ACCEPTANCE OF INSTALLATION IS BASED UPON FIELD INSPECTION AND ACCEPTANCE TESTING.

REVIEWED BY: *[Signature]*
 DATE: 7/20/09

THESE PLANS WERE PREPARED BY, AND ARE THE PROPERTY OF, EDS ELECTRONICS INC. A NEVADA LICENSED FIRE ALARM CONTRACTOR. NEVADA STATE FIRE ALARM LICENSE #: F162 CONTRACTOR LICENSE #: 35144A MASTER CARD #: 1450 LICENSE CLASSIFICATION C2, c, d LICENSE LIMIT \$950,000.00

SIGNATURE: *[Signature]*
 MASTER/Q.I.: EDWIN B. RAUGUST DATE: 7/20/09

Fire Protection Engineering Technology
FIRE ALARM SYSTEMS
 NICET CERTIFIED LEVEL II

SIGNATURE: *[Signature]*
 STEVEN W. WARFIELD
 CERTIFICATION #122376
 DATE: 7/20/09

NOTE: THESE DRAWINGS, SPECIFICATIONS, AND CALCULATIONS ARE THE PROPERTY OF EDS ELECTRONICS INC. THEY ARE NOT TO BE USED BY ANY OTHER ENTITY, OR FOR ANY OTHER PROJECT, WITHOUT THE EXPRESS WRITTEN CONSENT OF EDS ELECTRONICS INC. REPRODUCTION OF THESE PLANS IN WHOLE, OR IN PART, BY ANY MEANS WHATSOEVER IS STRICTLY PROHIBITED EXCEPT WITH THE WRITTEN CONSENT OF EDS ELECTRONICS INC.

COPYRIGHT 2008

PROJECT: CLV DETENTION CENTER BUILDING 1 & 2 2ND FLOOR
TYPE OF SYSTEM: FIRE ALARM
DRAWN BY: S.W.W.
CHECKED BY:
DATE: 07/13/2009
SCALE: 1/8"=1'-0"
JOB #: 2866
SHEET FA-02

