

- ☐ BRICK PAVERS PER ARCHITECT'S PLANS
- ☐ STAMPED CONCRETE PER ARCHITECT'S PLANS

NORTH
CornerStone Engineering
SCALE: 1"=20'



A graphic scale bar is located at the bottom of the page. It is a horizontal bar divided into segments of 10 feet each, with major tick marks at 0, 10, 20, 30, 40, 50, and 60 feet. The segments are alternating black and white. Above the bar, the text "NORTH" is written in a large, bold, serif font. Below "NORTH", the text "CornerStone Engineering" is written in a smaller, sans-serif font. Below that, the text "SCALE: 1\"=20'" is written in a large, bold, serif font.

CITY OF LAS VEGAS BENCHMARK NO 7C10255W6
RIVET AND PLATE AT THE SE CORNER
OF SAHARA AVE AND REDWOOD STREET
ELEVATION = 236132 NAVD 88

THE SOUTH LINE OF THE SW 1/4 OF
SECTION 2, T25, R 60 E MDM
AS SHOWN ON RECORD OF SURVEY IN
FILE 84 AT PAGE 44 CLARK COUNTY RECORDS
1E S 89°08'00"E

EXISTING UTILITIES ARE SHOWN ON PLANS FOR THE CONVENIENCE OF THE CONTRACTOR ONLY. THE CONTRACTOR IS RESPONSIBLE FOR THE PROTECTION OF ALL UTILITIES. THE ENGINEER BEARS NO RESPONSIBILITY FOR UTILITIES NOT SHOWN OR SHOWN INCORRECTLY.

**Call
BEFORE YOU
Dig**


1-800-227-2600
UNDERGROUND SERVICE

ASSUMES NO RESPONSIBILITY FOR EXISTING UTILITY LOCATIONS, SHOWN OR NOT SHOWN. THE UTILITIES SHOWN ON THIS DRAWING HAVE BEEN PLOTTED FROM RECORD INFORMATION AND ARE FOR THE CONVENIENCE OF THE CONTRACTOR ONLY. THE CONTRACTOR IS RESPONSIBLE TO FIELD VERIFY THE LOCATIONS AND DEPTHS OF ALL RELEVANT UTILITIES PRIOR TO COMMENCING WITH CONSTRUCTION. THE CONTRACTOR IS RESPONSIBLE TO NOTIFY THE ENGINEER OF WORK, IN WRITING, OF ANY CONFLICTS OR DISCREPANCIES.

ALL EXISTING UTILITY STRUCTURES WITHIN CONSTRUCTION
AREA SHALL BE ADJUSTED TO MATCH FINISH GRADE
(I.E., WV, BOX, WMH, ANNODE BOX, FH, TEL BOX, ETC)

ALL DIMENSIONS TO UTILITIES ARE TO CENTERLINE OF PIPE
UNLESS INDICATED OTHERWISE

CONTRACTOR SHALL VERIFY HORIZONTAL AND VERTICAL
ALIGNMENT OF EXISTING UTILITIES AND TO NOTIFY THE
DESIGN ENGINEER IMMEDIATELY ON ANY DISCREPANCIES
PRIOR TO CONSTRUCTION

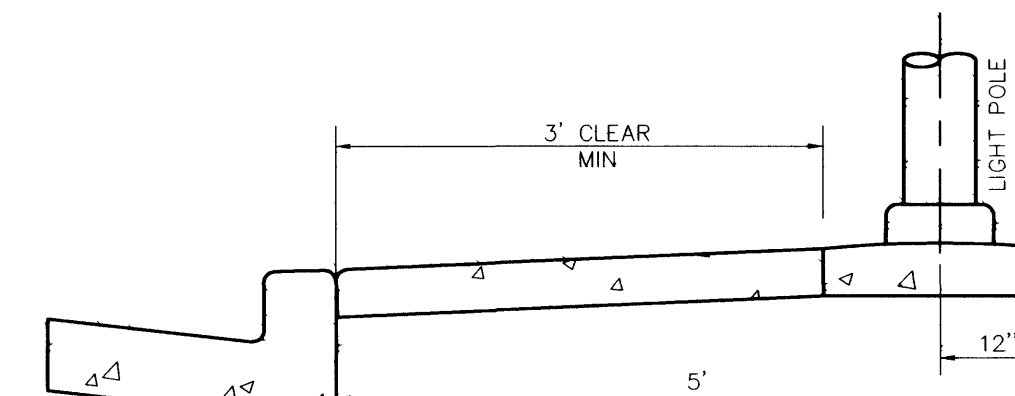

PER CLARK COUNTY DWG 318
STREET LIGHT LOCATION
NO SCALE



FIRE HYDRANT LOCATION DETAIL
NO SCALE

SEE SHEET C3 FOR CURB DATA TABLES, SIDEWALK
RAMP DATA TABLE, SURE DATA TABLES, BOUNDARY
DATA TABLE AND QUANTITIES

SEE SHEET C2 FOR UTILITY NOTES, LEGENDS AND
FIRE FLOW DATA

405+10 MATCHLINE SEE SHEET 5

BY: 

APPROVAL OF THESE PLANS SHALL NOT BE CONSTRUED TO BE A PERMIT FOR, OR AN APPROVAL OF, ANY VIOLATION OF ANY THE PROVISION OF THE STATE OR COUNTY LAWS FIRE FLOW _____ GPM AT 20 PSI RESIDUAL

LAS VEGAS VALLEY WATER DISTRICT

**HORIZONTAL CONTROL/UTILITY/
STREET LIGHTING PLAN EAST**

**FLETCHER JONES LEXUS
CITY OF LAS VEGAS**

FLETCHER JONES SR. TRUST
175 E. RENO AVENUE, SUITE C-6
LAS VEGAS, NEVADA 89119
(702) 739-1420

CornerStone Engineering Inc.
22285-C RENAISSANCE DR
LAS VEGAS, NV 89119
702-731-4711 FAX 702-731-4788

FILENAME: 143-IJUE	DATE: SEPT 12, 2001	SHEET:
XREF FILES: 143-1MSTDWG		
CHECKED BY: DWS	DRAWN BY: CC	TITLE:
PROJECT NO: 143-10	SCALE: 1"=20' 1"=2'	

SEAL



9/12/6

SHEET
C6
6 OF 8 SHEETS

DRAWING NO.
107-V-3489